
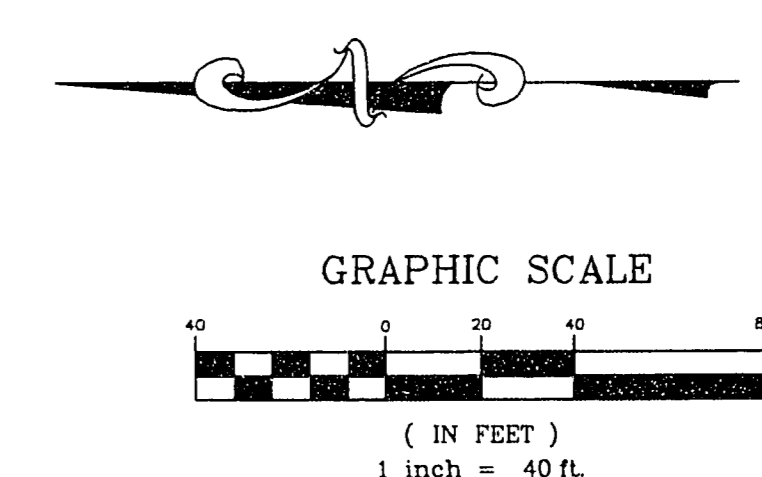
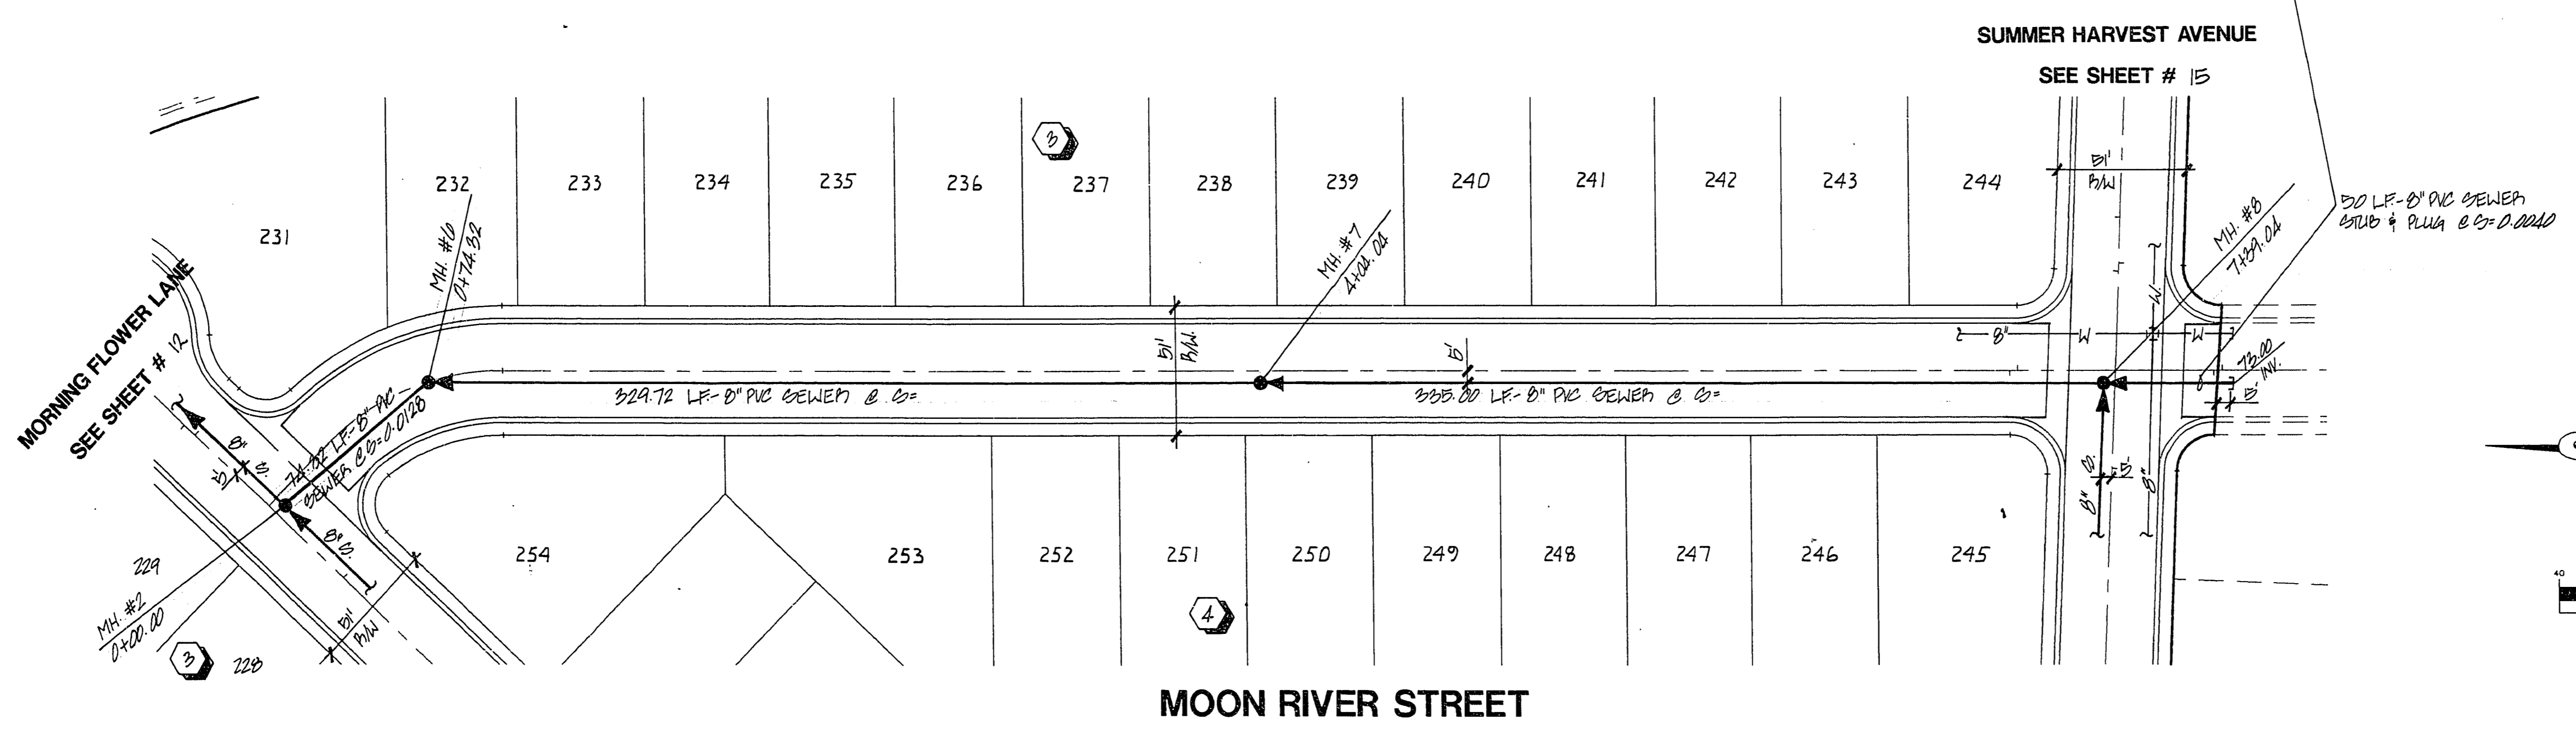


H:\CAD\LAND\4663\4663LAND.dwg 6 09:32:07 1995 PLOTTED BY: M.G.B.

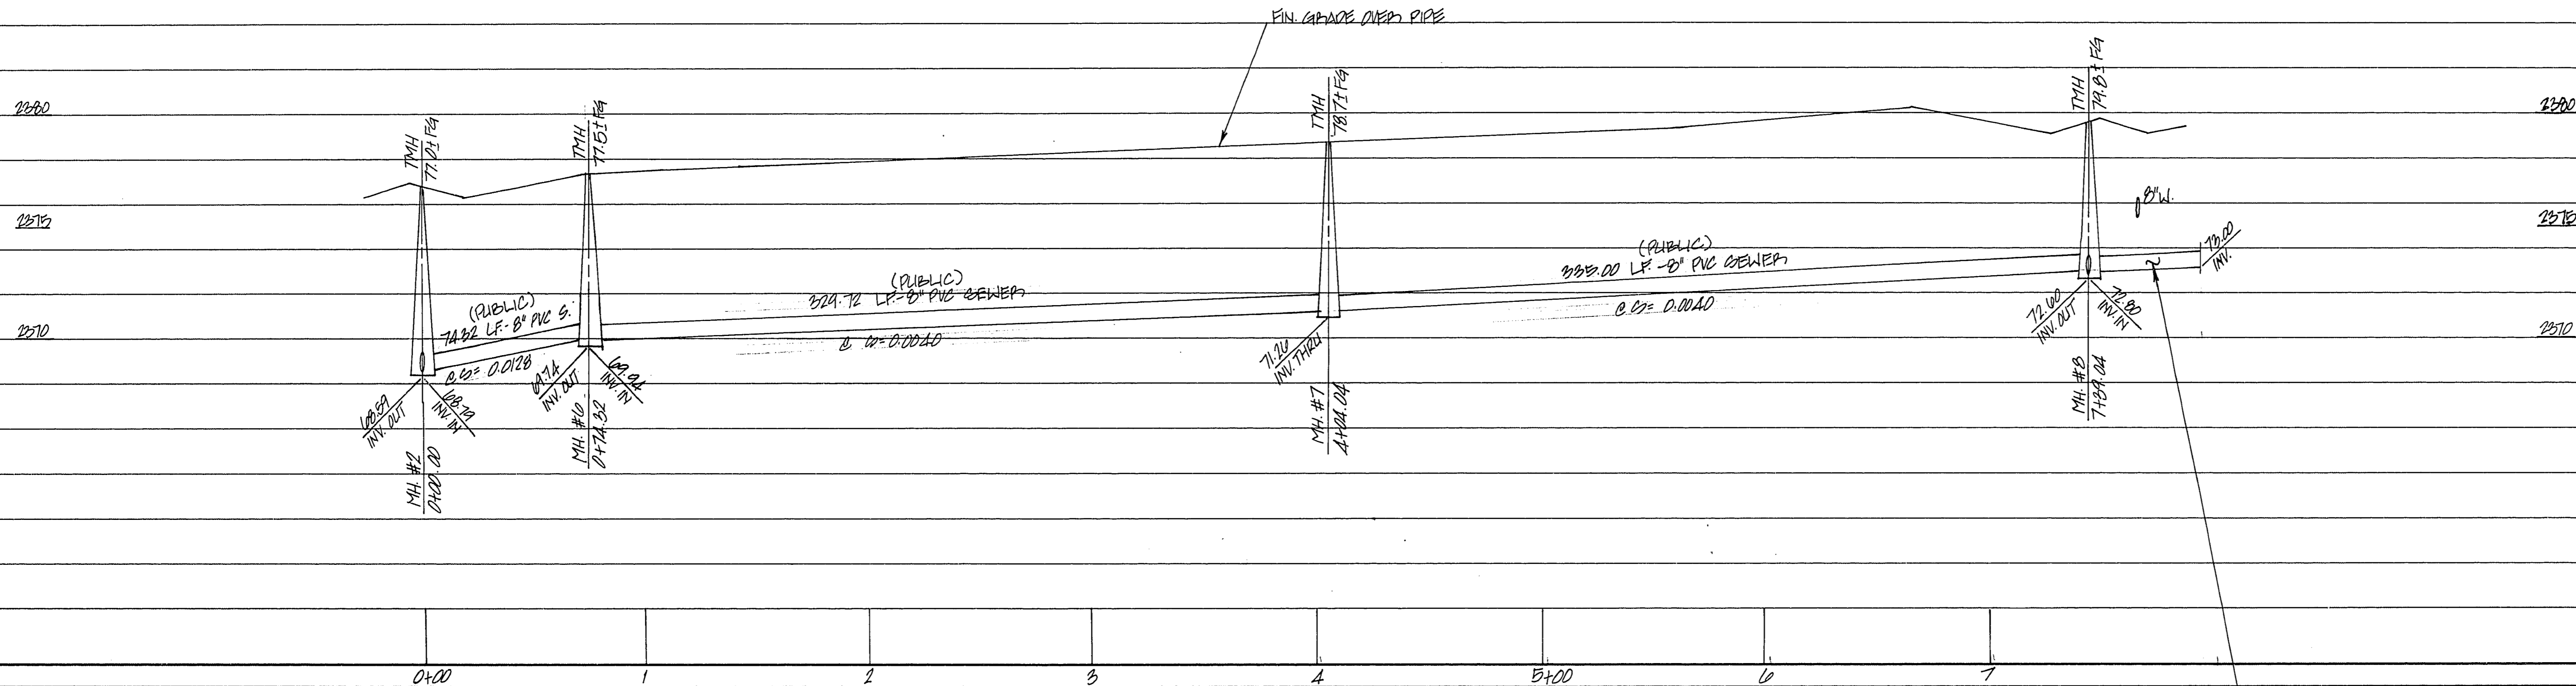

Avoid cutting underground utility lines. It's costly.

**Call before you Dig**

1-800-227-2600

**BENCHMARK**

CITY OF LAS VEGAS BENCHMARK

RIVET AND PLATE IN TOP OF CURB, SOUTHWEST RETURN OF CHEYENNE AVENUE AND RAMPART BOULEVARD, CLV BM# 030017NES.

ELEVATION = 746.096 METERS (NAVD 88)  
= 2450.78 FEET (NAVD 88)

ROYAL CONSTRUCTION	DATE	BY	REVISION
CITY OF LAS VEGAS, NEVADA			
CONSULTING ENGINEERS • PLANNERS • LAND SURVEYORS 2727 SOUTH RAINBOW BOULEVARD LAS VEGAS, NEVADA 89102-5148 PHONE (702) 873-7550 FAX (702) 362-2597			

**SEWER PLAN AND PROFILE**

MOON RIVER STREET

**NORTHSHORE - LOT "D"**

UNIT 1

PROJECT

NO. 4663

BY DH, WJR

DATE 9/95

SCALE: HORIZ. 1"=40'  
VERT. 1"=4'

SHEET 13 OF 15 SHEETS

16 JAN. 96

SEAL  
 W. C. PETERSEN  
 CIVIL ENGINEER  
 STATE OF NEVADA  
 LICENSE NO. 10000

11-12-108. 3074-4318-1-D1