


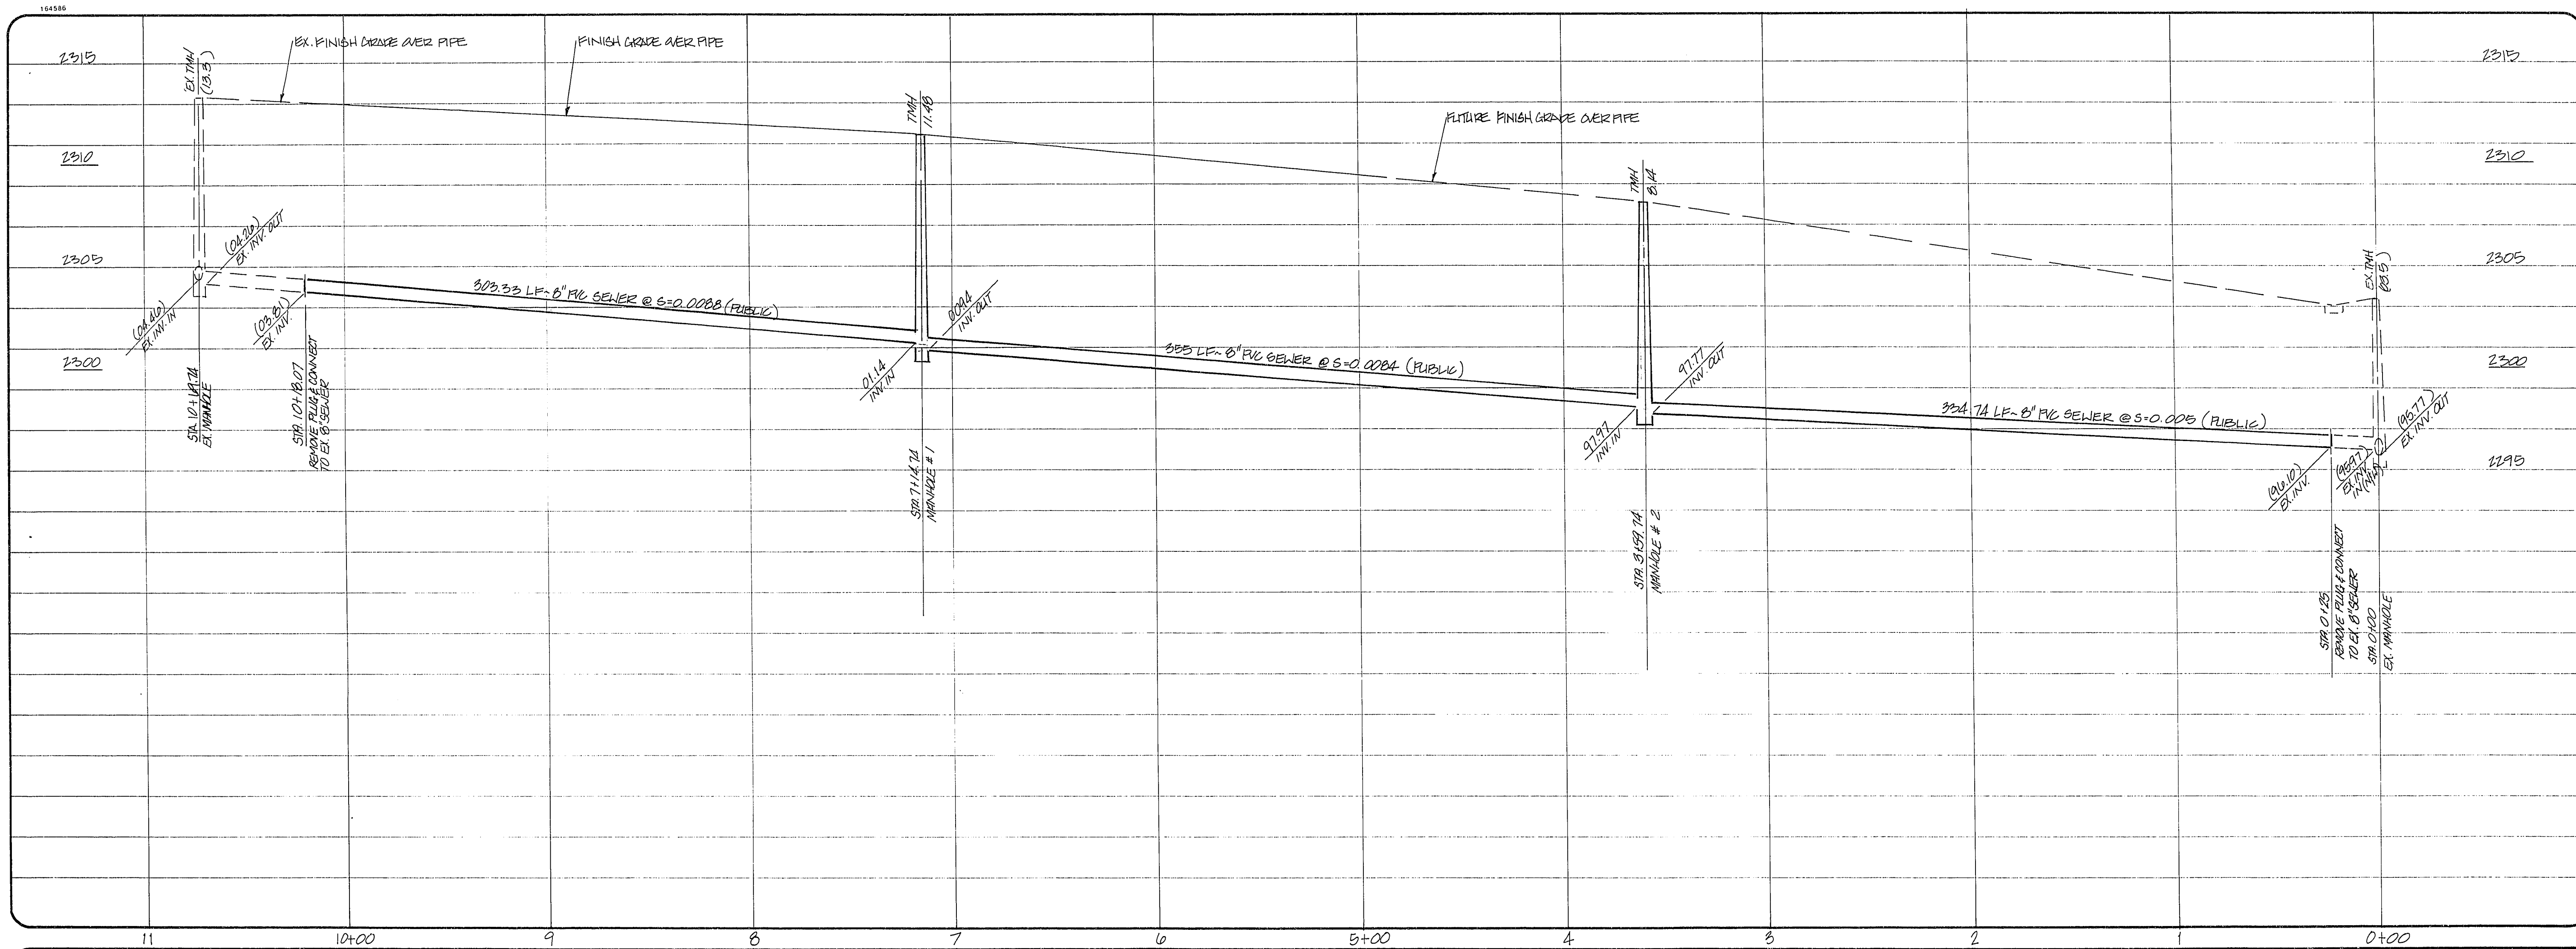


REV	DATE	BY	REVISION

AMLAND DEVELOPMENT, INC.
CITY OF LAS VEGAS, NEVADA

CONSULTING ENGINEERS • PLANNERS • LAND SURVEYORS
2727 SOUTH RAINBOW BOULEVARD
LAS VEGAS, NEVADA 89102-5148 PHONE (702) 873-7550 FAX (702) 362-2597

vtm nevada

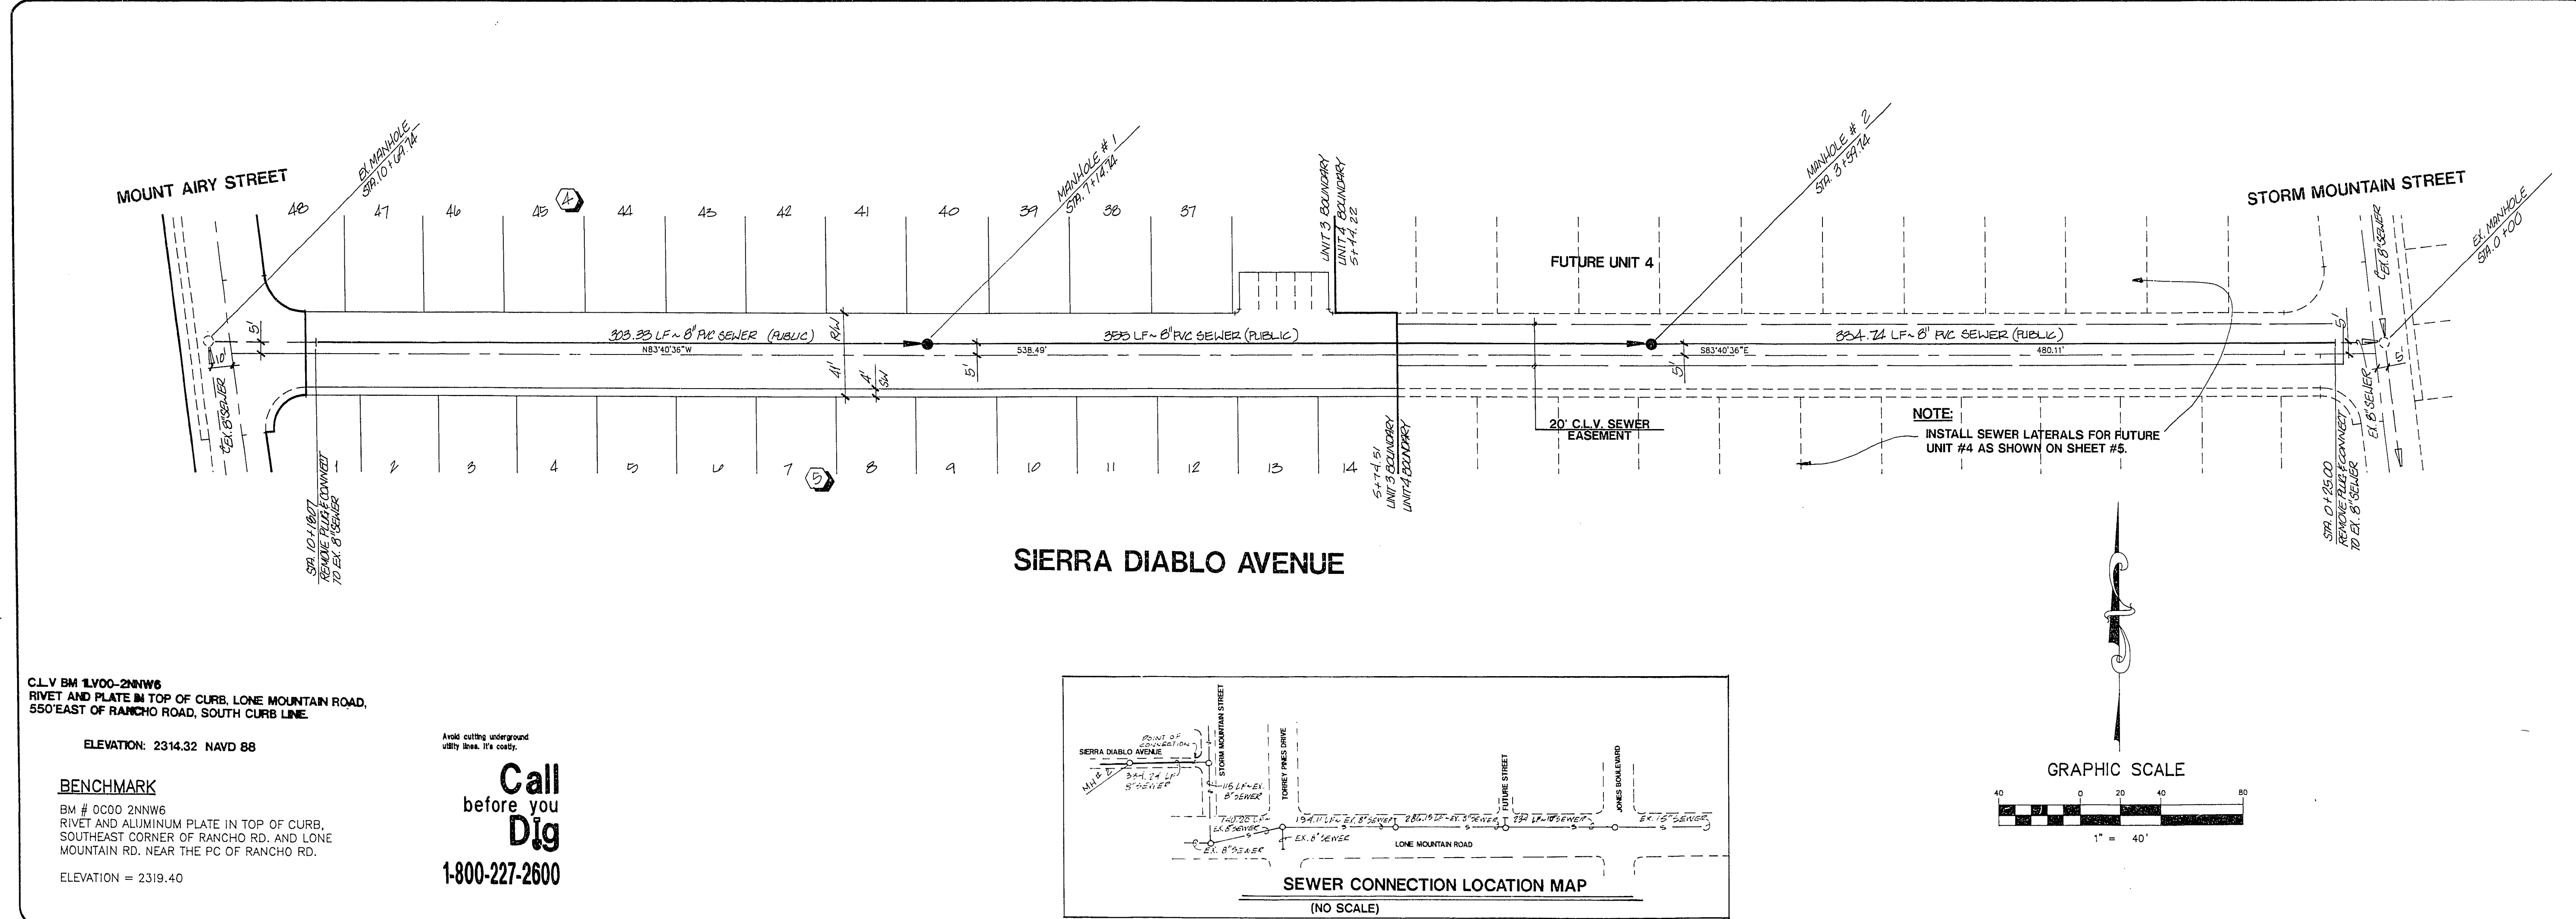

SEWER PLAN AND PROFILE

SIERRA DIABLO AVENUE

MOUNTAIN GATE TOWNHOMES

UNIT 3

TITLE

PROJECT

SEAL

REGISTERED PROFESSIONAL ENGINEER
KENT
ANDERSON
CIVIL
NO. 5012
8-25-97

WD NO. **4824-3**

BY **JS**

DATE **AUG 1995**

SCALE HORIZ. 1" = 40'
VERT. 1" = 4'

SHEET **6** OF 7 SHEETS

C.L.V. BM 1V00-2NNW6
RIVET AND PLATE IN TOP OF CURB, LONE MOUNTAIN ROAD,
550' EAST OF RANCHO ROAD, SOUTH CURB LINE.

ELEVATION: 2314.32 NAVD 88

BENCHMARK



BM # 0C00 2NNW6
RIVET AND ALUMINUM PLATE IN TOP OF CURB,
SOUTHEAST CORNER OF RANCHO RD. AND LONE
MOUNTAIN RD. NEAR THE PC OF RANCHO RD.

ELEVATION = 2319.40

Avoid cutting underground
utility lines. It's costly.

**Call
before you
Dig**

1-800-227-2600

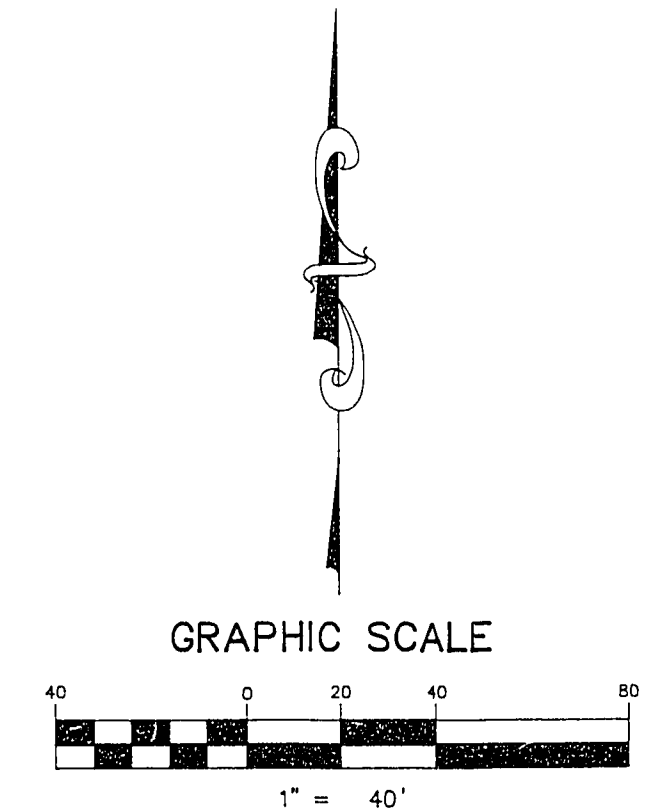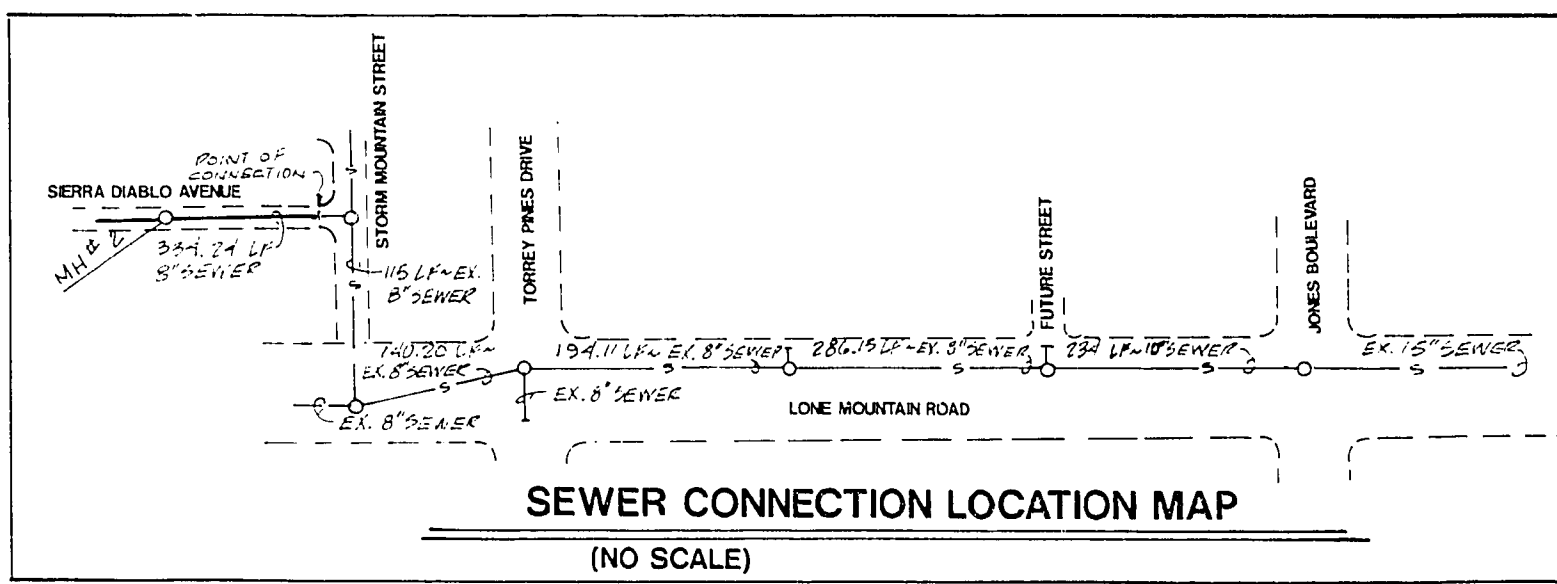

11-17-158
307Y-4352-3