

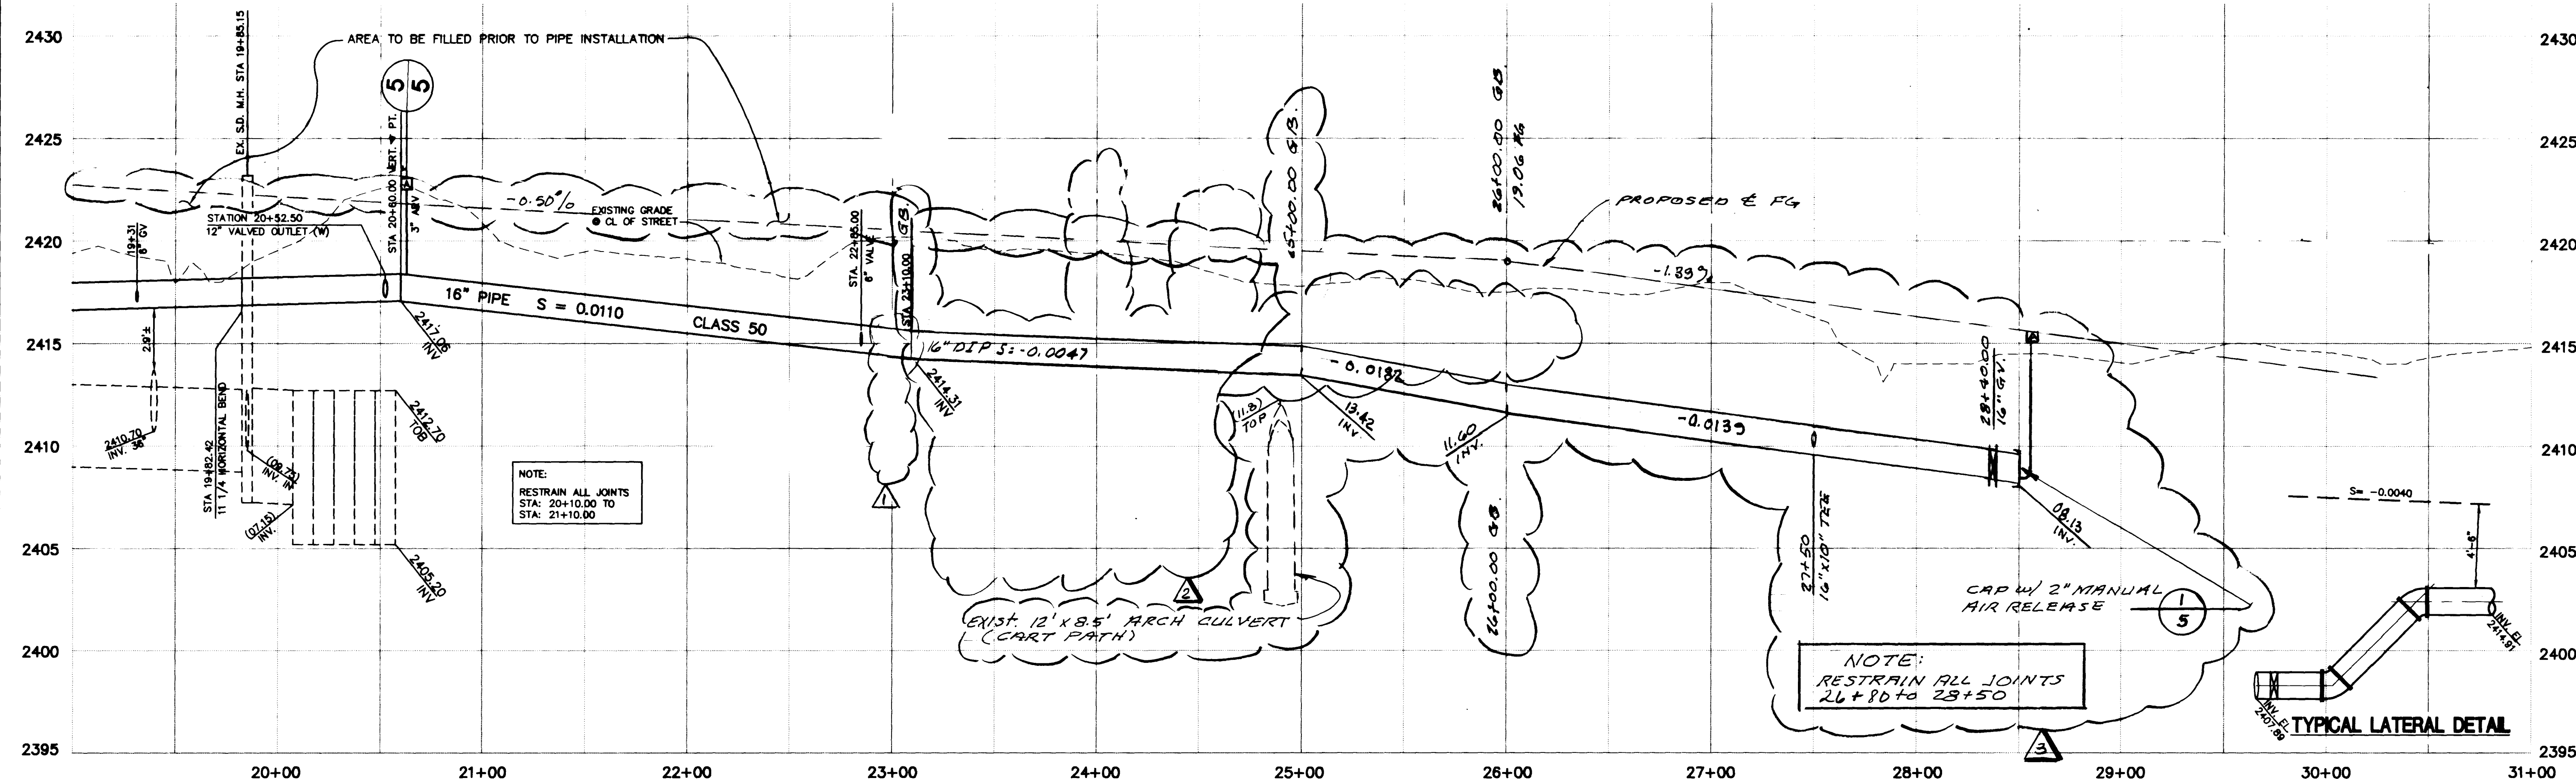



MATCH LINE 19+00 - SEE SHEET 3

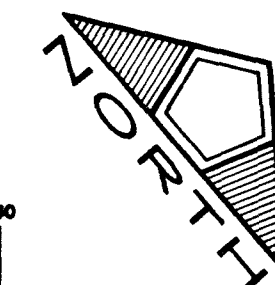

PROFILE
SCALE: HORIZ. 1" = 40'
VERT. 1" = 4'

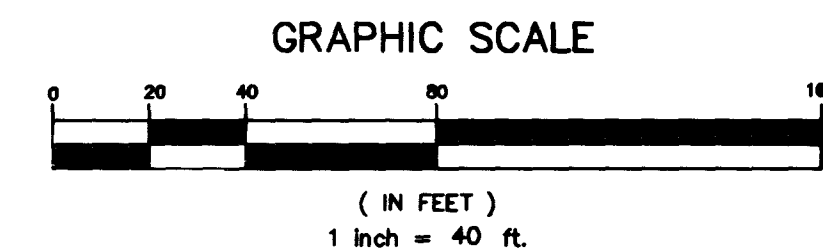

Curve Data =
PC STA. 22+18.28
PT STA. 34+03.58
Δ = 39°56'52"
R = 1700'
L = 1185.27'

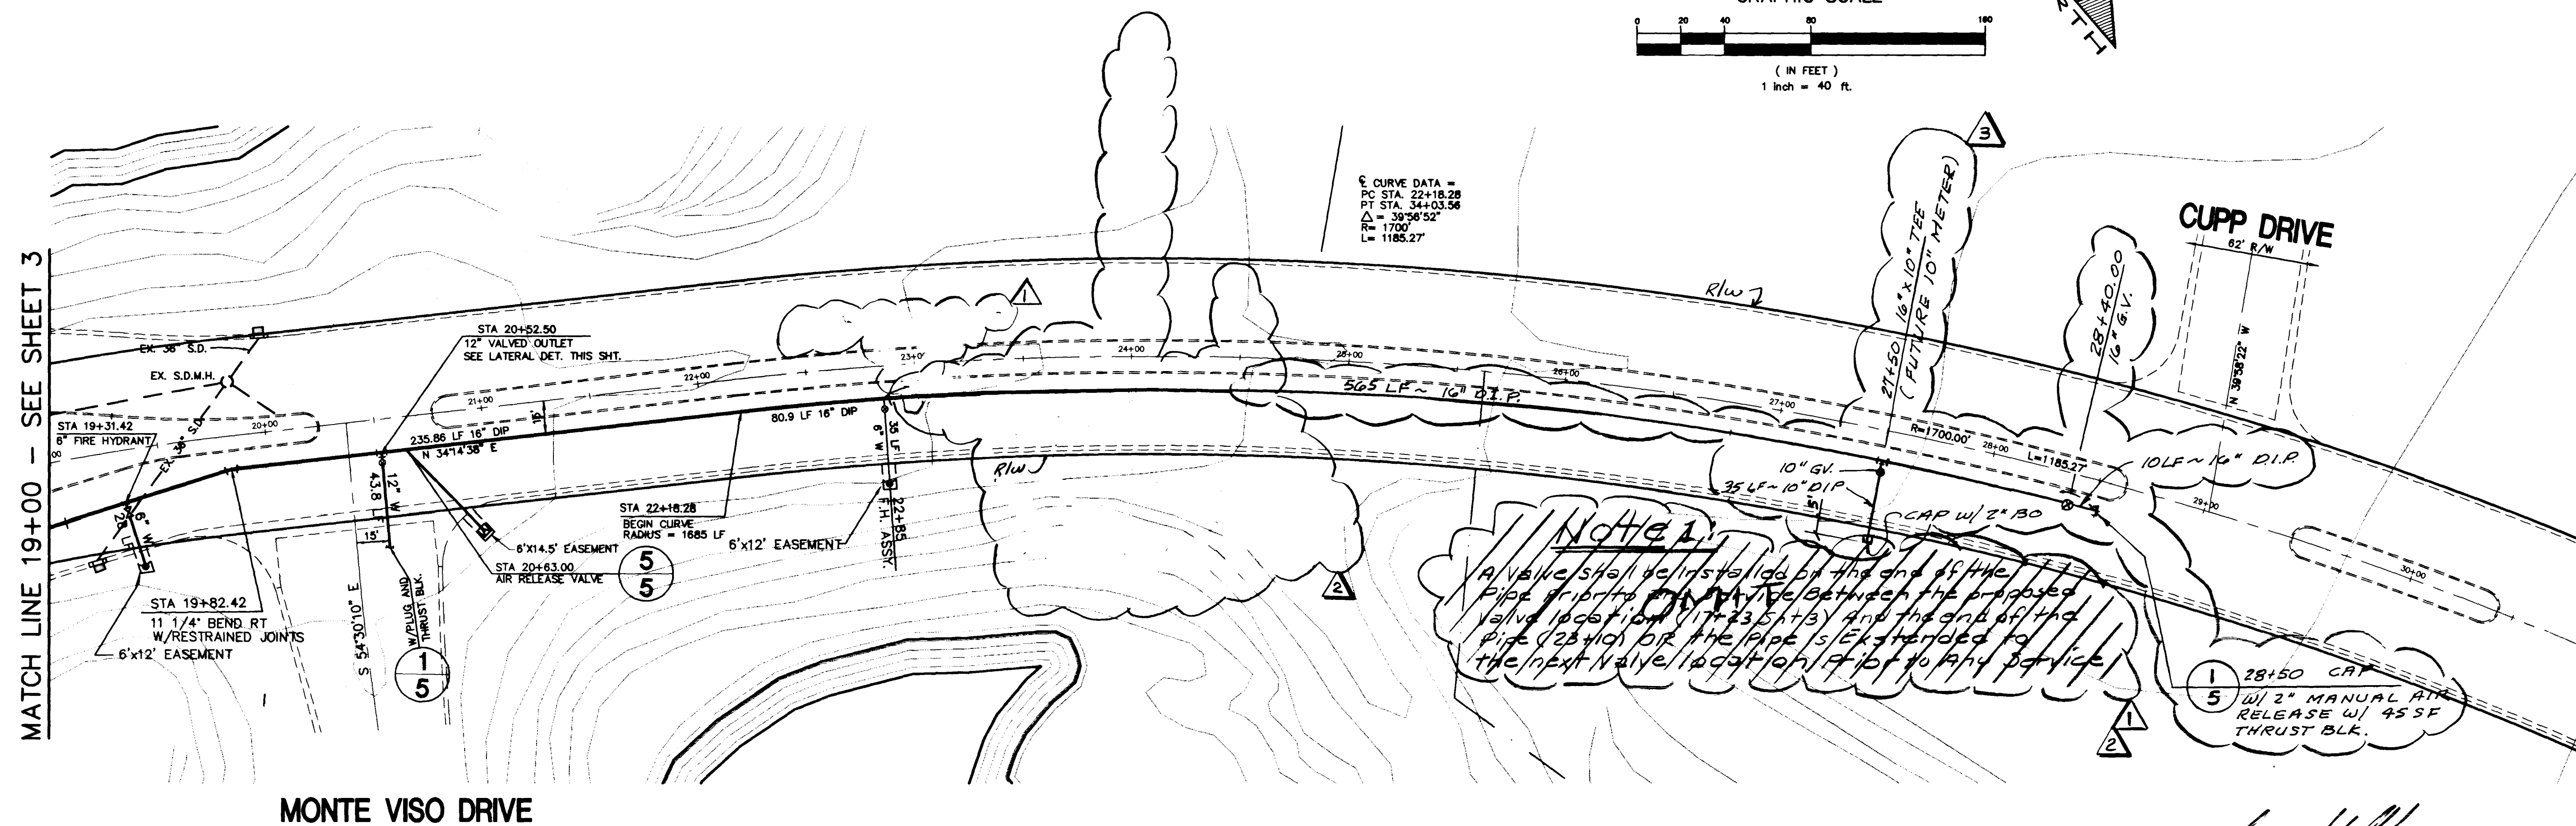


MOUNTAIN SPA DRIVE

CUPP DRIVE


NOTE:
A valve shall be installed at the end of the
pipe prior to the next valve. Between the proposed
valve location (17+23.51+3) and the end of the
pipe (28+10) the pipe is extended to
the next valve location (17+23.51+3) or to any service.

1 28+50 CAP
5 W/ 2" MANUAL AIR
RELEASE W/ 45 SF
THRUST BLK.

CITY OF LAS VEGAS FIRE DEPARTMENT
LAS VEGAS VALLEY WATER DISTRICT
DATE 4-16-98
DATE 9/14/98

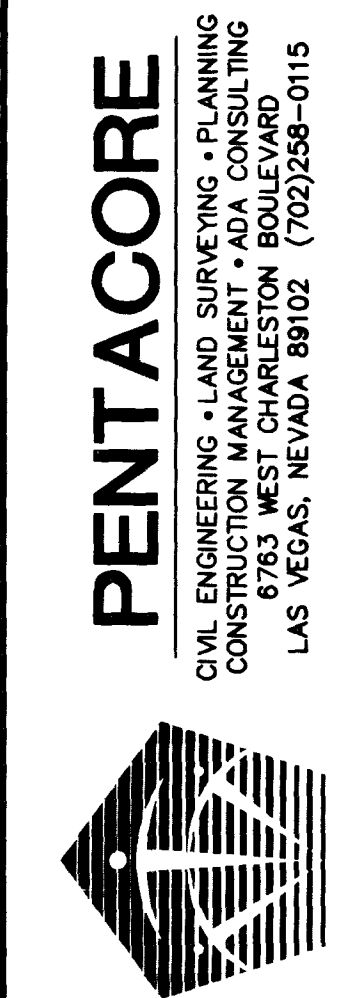

MOUNTAIN SPA DEVELOPMENT, INC.
MOUNTAIN SPA DRIVE PIPELINE
STA 19+00 TO STA 28+50
PLAN AND PROFILE

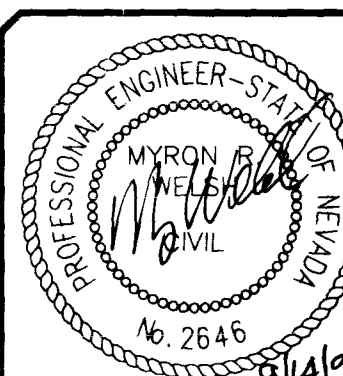

SHEET
4
OF 7

5674-4344-0W

