


12-81


PLAN	DATE
BY	
NO.	
NOTE: BOOK NO. 12-81	
NOTE: CHECKED BY	
NOTE: DATE	

PROFILE	DATE
BY	
NO.	
NOTE: BOOK NO. 12-81	
NOTE: CHECKED BY	
NOTE: DATE	

SCALE
1" = 30' HORIZ.
1" = 3' VERT.

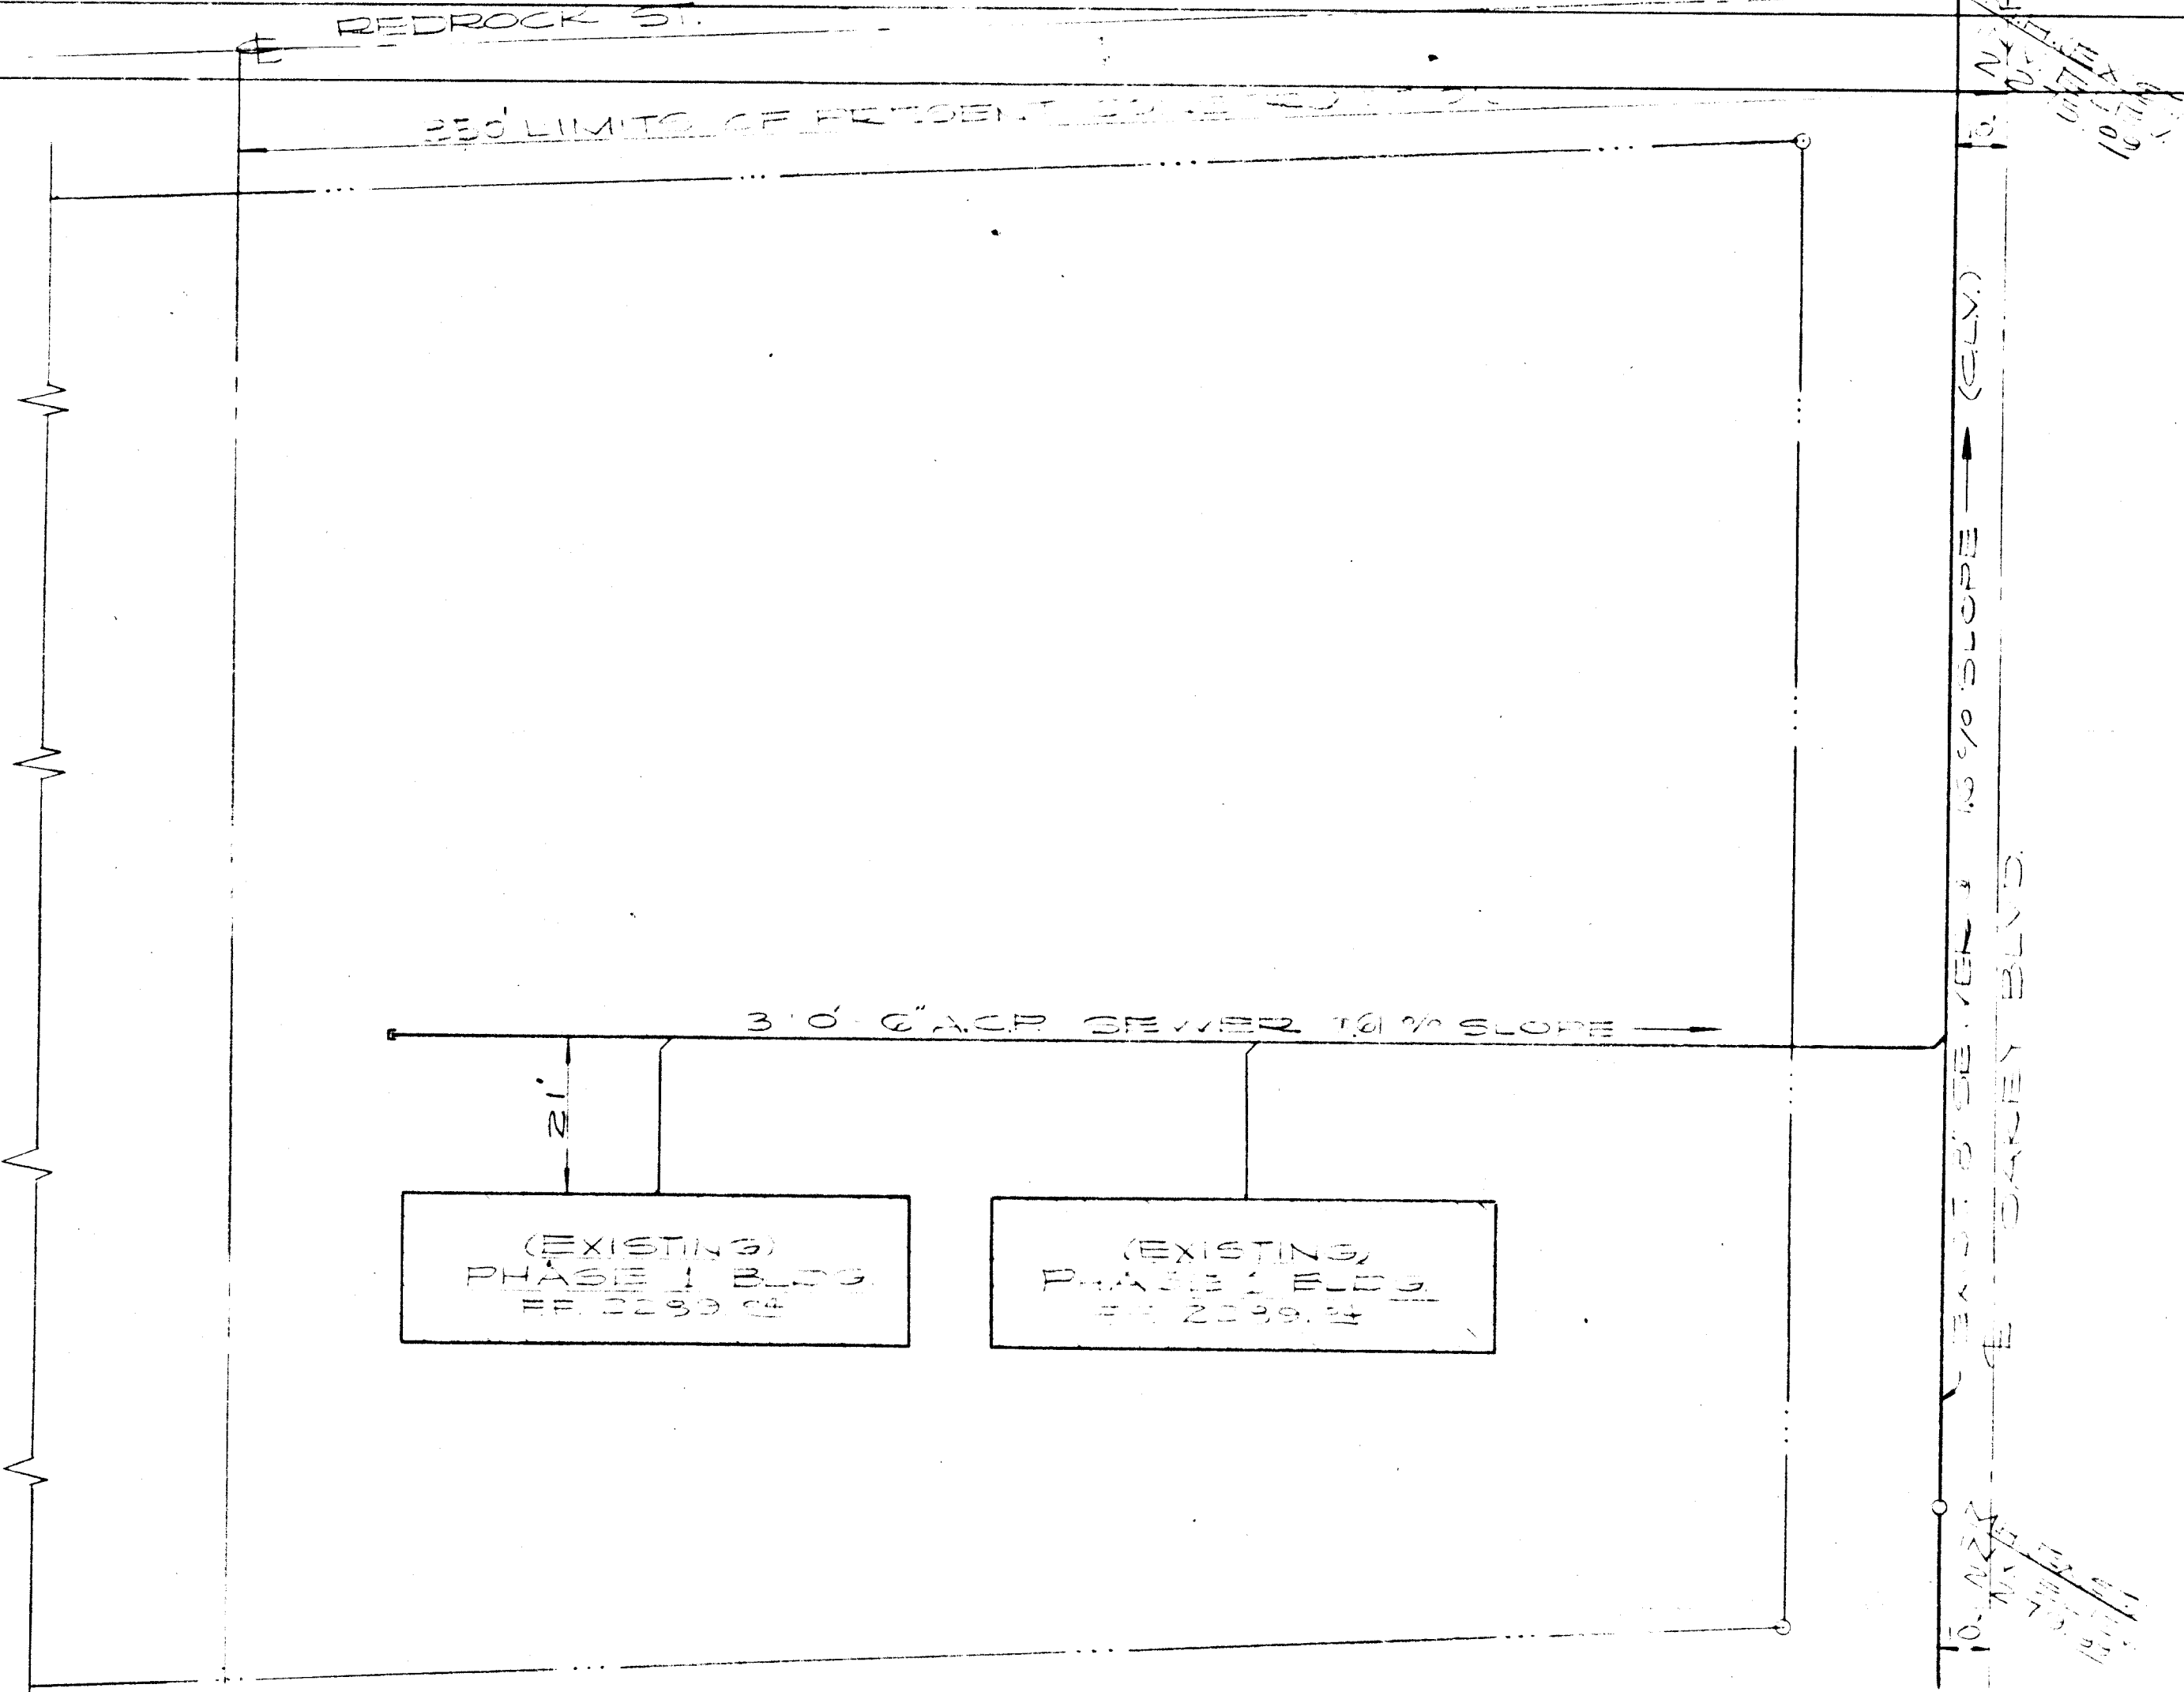

CLARK COUNTY DIST. HEALTH DEPT. DATE
CITY OF LAS VEGAS ENGINEERING DEPT. DATE 1-23-73

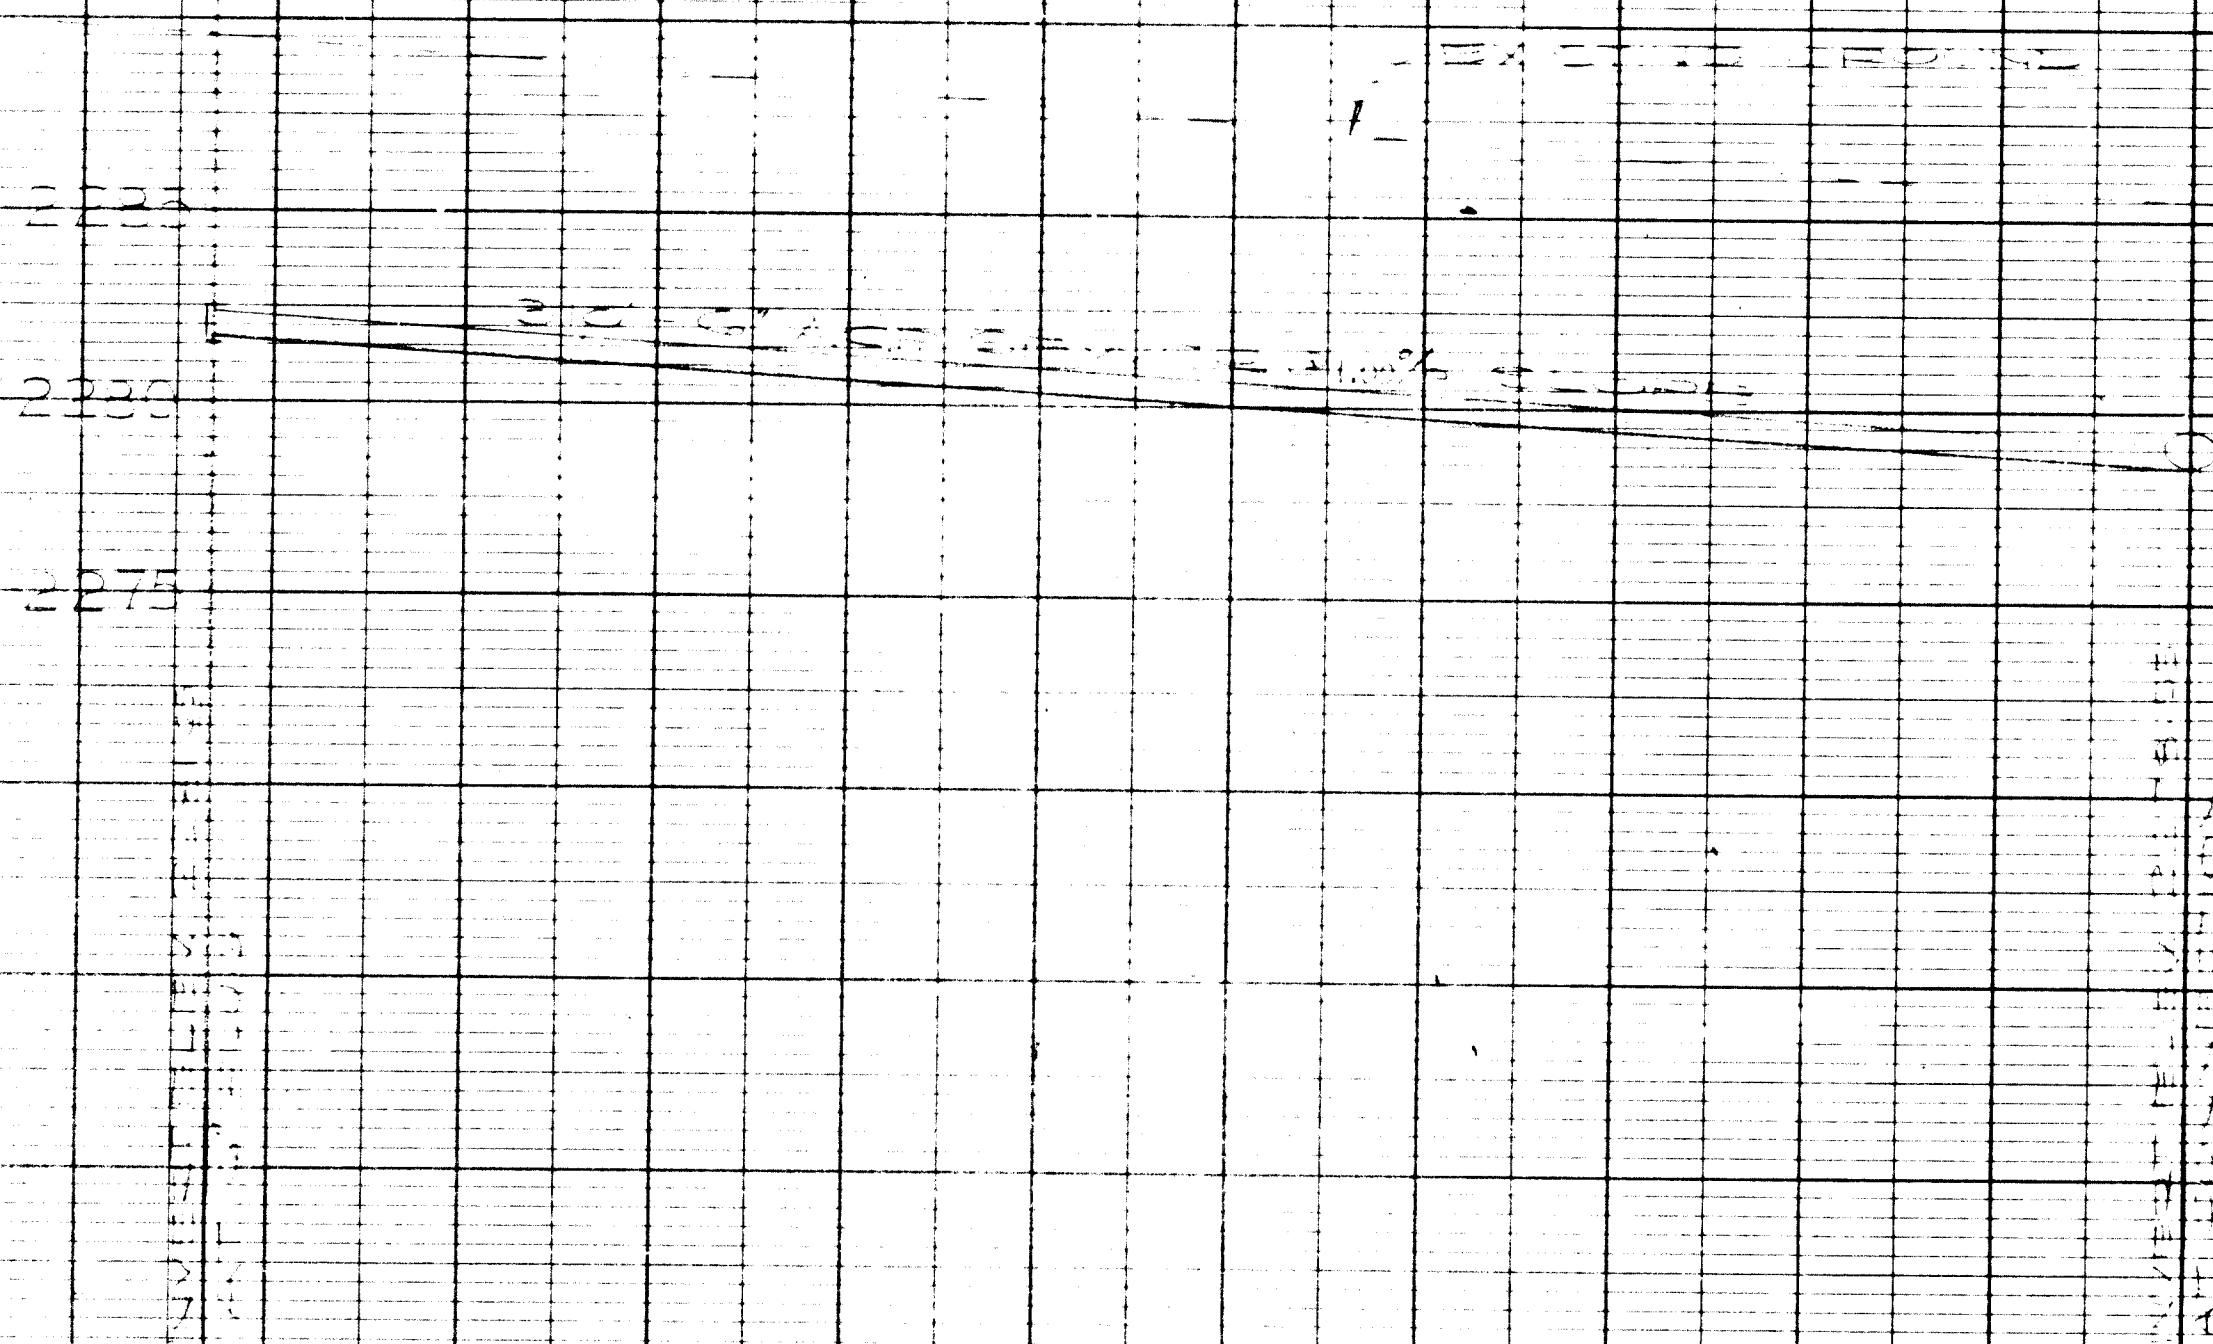

James Schell 1/20/73

NO.	DATE	REVISIONS	BY	CHKD.	APP'D.
ALCA ENGINEERING INC.					
DESIGNED	WALTER H. ALCA ENGINEER				
DRAWN	SOUTHERN NEVADA				
CHECKED	UNDERGROUND UTILITIES				
PROJ. ENGR.	SANITARY SEWER				
DATE	PLAN AND PROFILE				
4625 BOULDER HIGHWAY LAS VEGAS, NEVADA #89109 TEL. 401-7700				DRAWING NO. 012 SHEET 12 OF 14	

PLATE 1 - PLAN - PROFILE - S.A.S.
CLEARPRINT PAPER CO. S.F. CAL.
NO. 1000H-1

12-C-7

13 OF 14

715-59

3644