

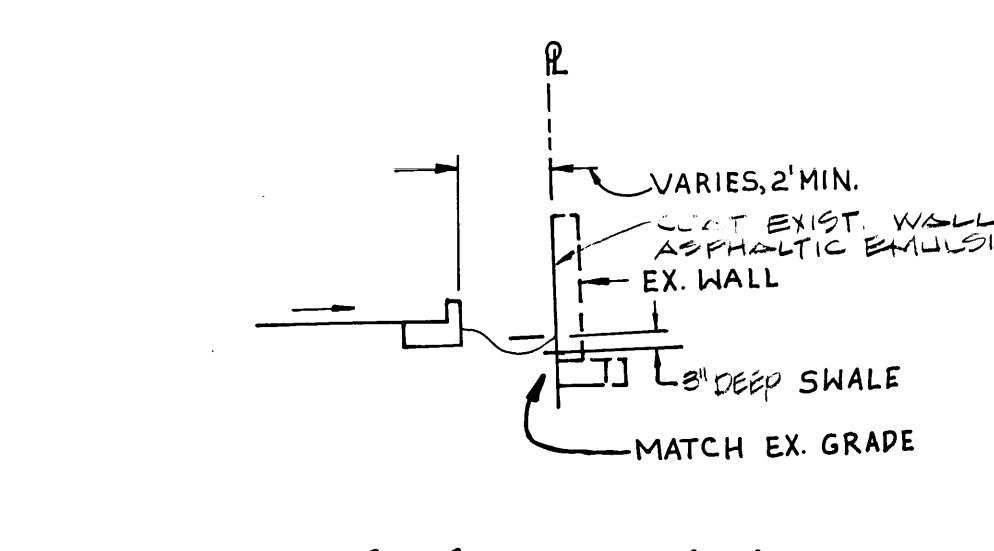
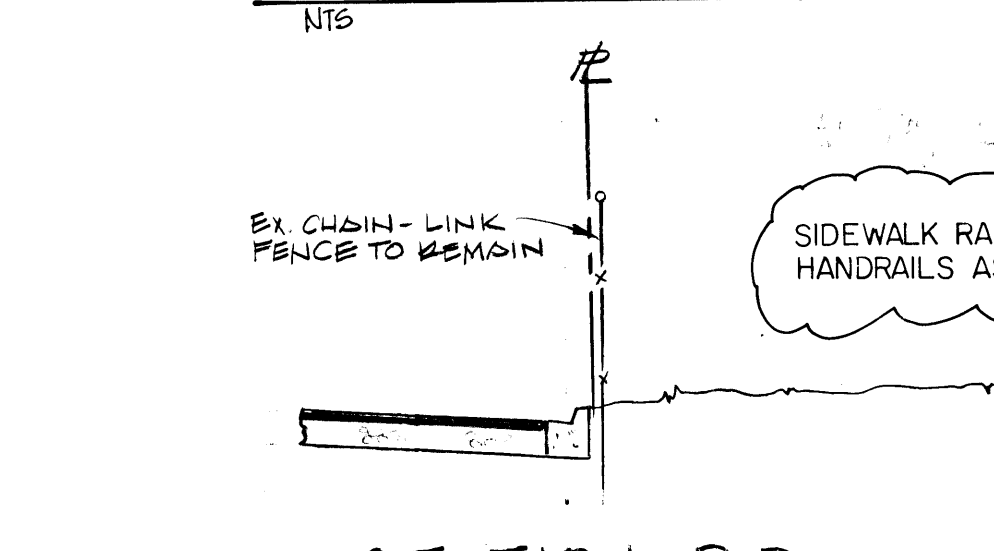
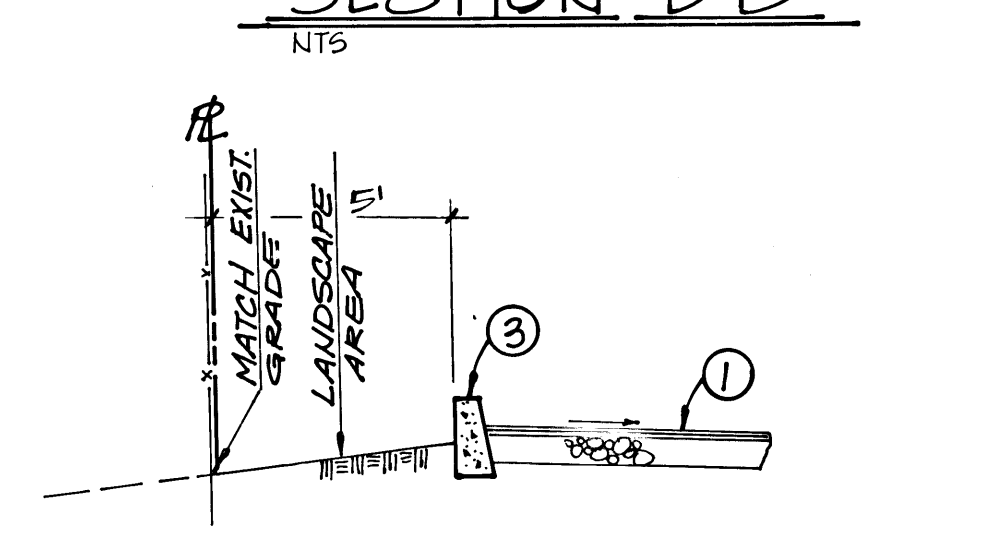
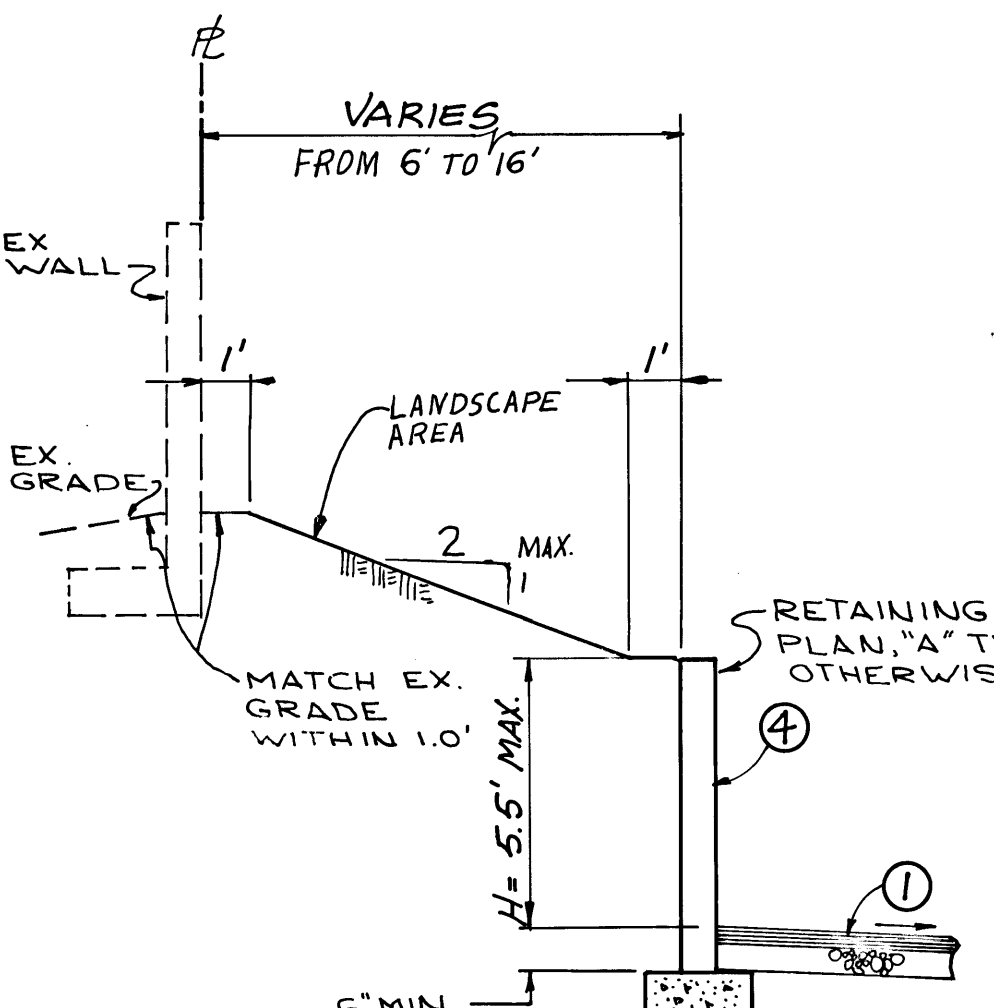


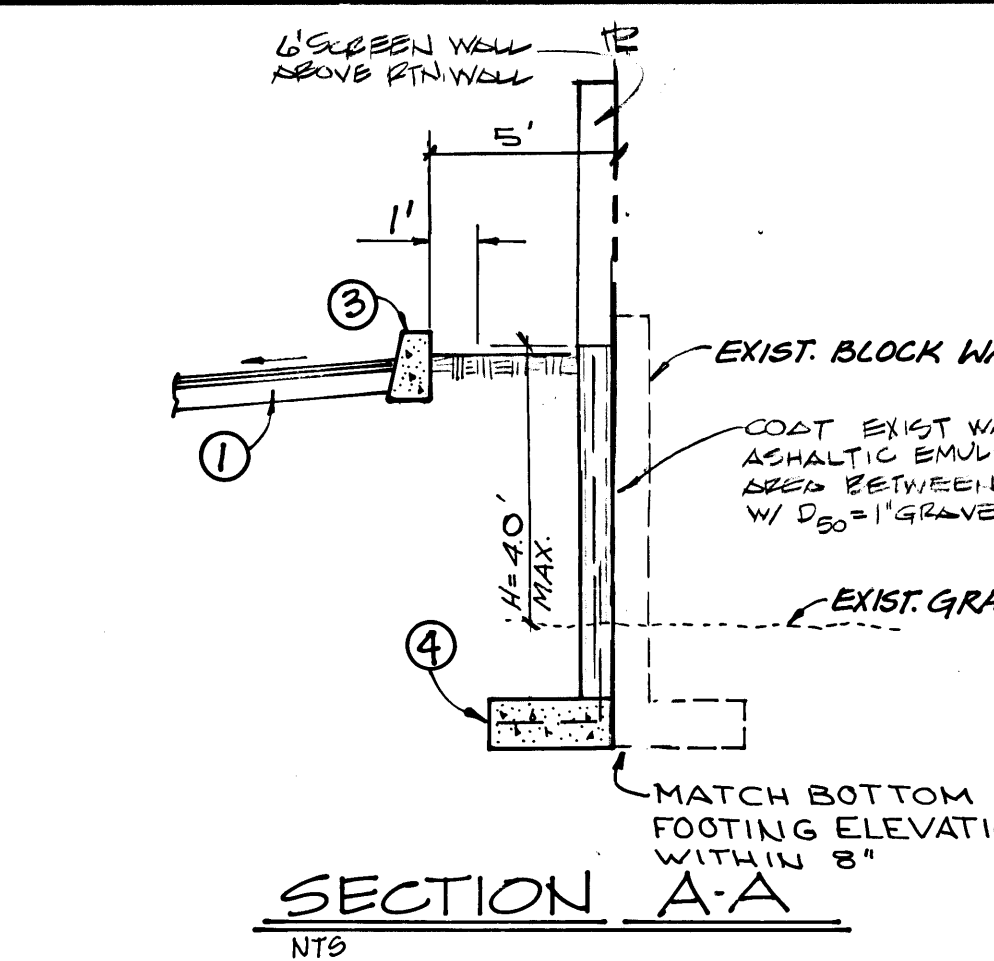


DRAINAGE CERTIFICATION
I CERTIFY THAT THIS GRADING PLAN IS IN CONFORMANCE WITH THE APPROVED DRAINAGE STUDY ON FILE AT THE CITY OF LAS VEGAS FOR THIS PROJECT.
MICHAEL J. CREHAN P.E. #10864
10/3/96
DATE

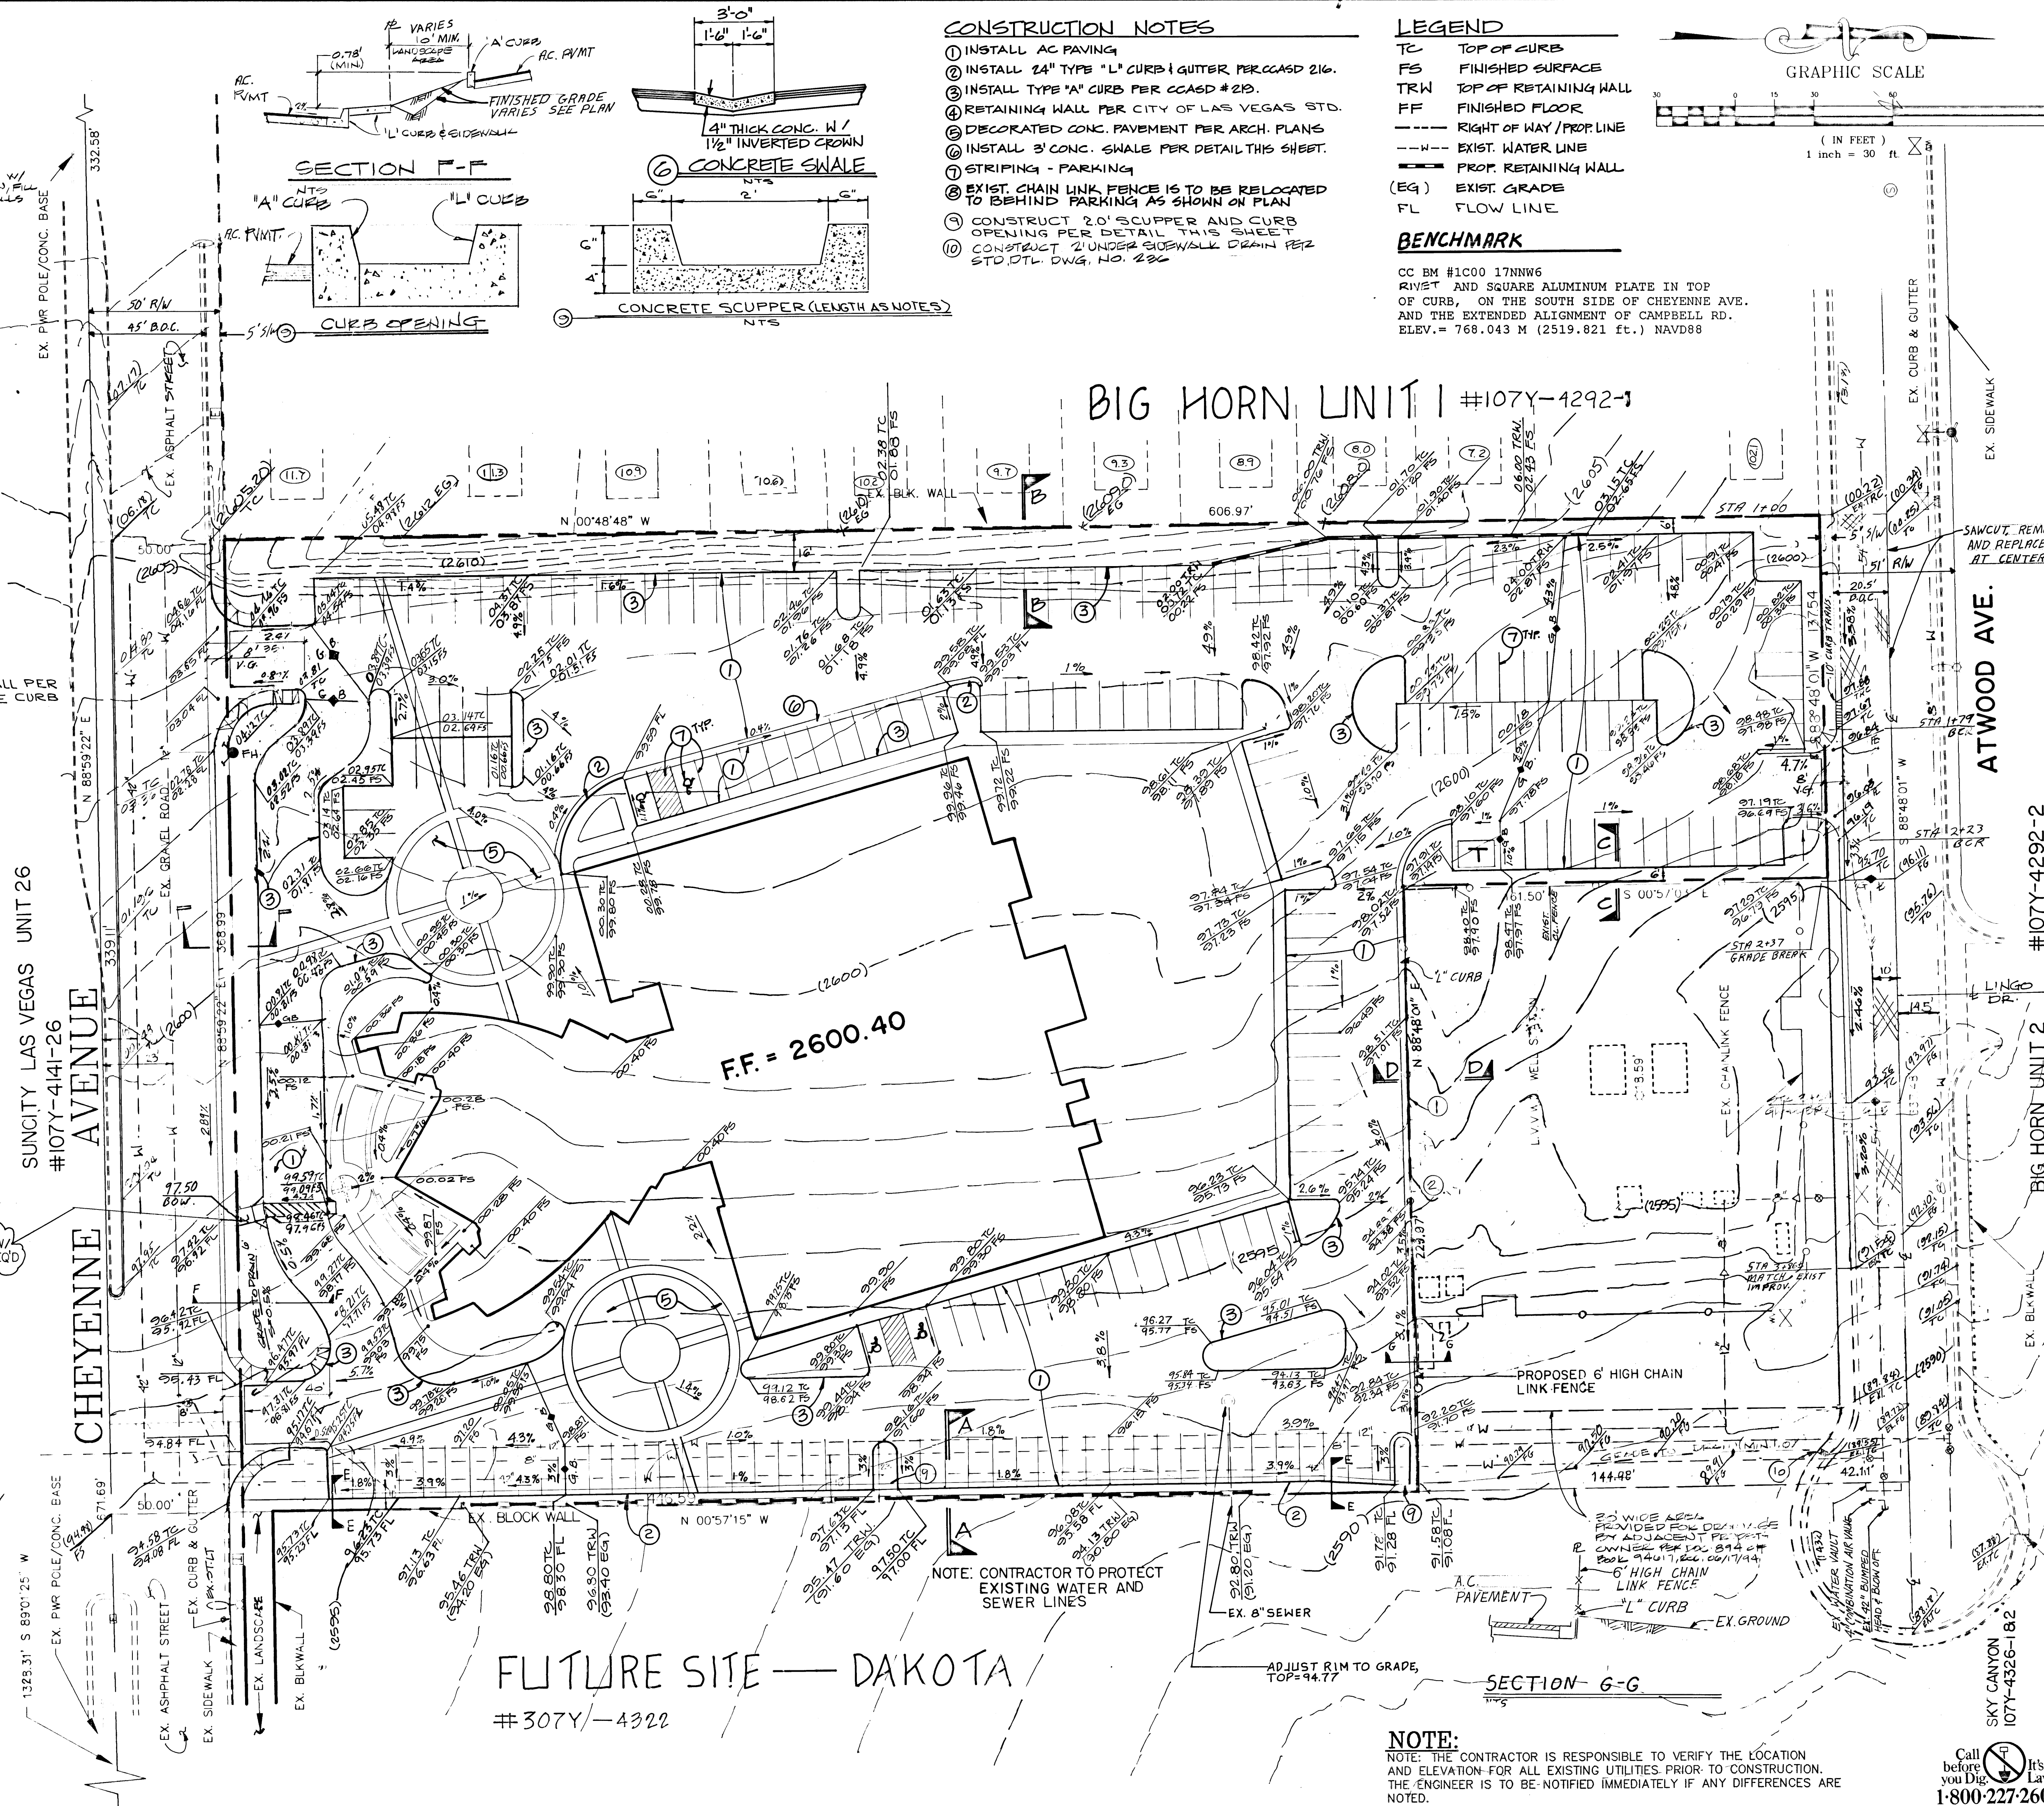

- CONSTRUCTION NOTES**
1. INSTALL AC PAVING
 2. INSTALL 24" TYPE "L" CURB & GUTTER PER CCASD 216.
 3. INSTALL TYPE "A" CURB PER CCASD #219.
 4. RETAINING WALL PER CITY OF LAS VEGAS STD.
 5. DECORATED CONC. PAVEMENT PER ARCH. PLANS
 6. INSTALL 3" CONC. SWALE PER DETAIL THIS SHEET.
 7. STRIPING - PARKING
 8. EXIST. CHAIN LINK FENCE IS TO BE RELOCATED TO BEHIND PARKING AS SHOWN ON PLAN
 9. CONSTRUCT 2.0' SCUPPER AND CURB OPENING PER DETAIL THIS SHEET
 10. CONSTRUCT 2" UNDER SIDEWALK DRAIN PER STD. DET. DWG. NO. 222

- LEGEND**
- TC TOP OF CURB
 - FS FINISHED SURFACE
 - TRW TOP OF RETAINING WALL
 - FF FINISHED FLOOR
 - RIGHT OF WAY / PROP. LINE
 - - - EXIST. WATER LINE
 - PROP. RETAINING WALL
 - (EQ) EXIST. GRADE
 - FL FLOW LINE
- BENCHMARK**
- CC BM #1000 17NNW6
RIVET AND SQUARE ALUMINUM PLATE IN TOP OF CURB, ON THE SOUTH SIDE OF CHEYENNE AVE. AND THE EXTENDED ALIGNMENT OF CAMPBELL RD.
ELEV. = 768.043 M (2519.821 ft.) NAVD88

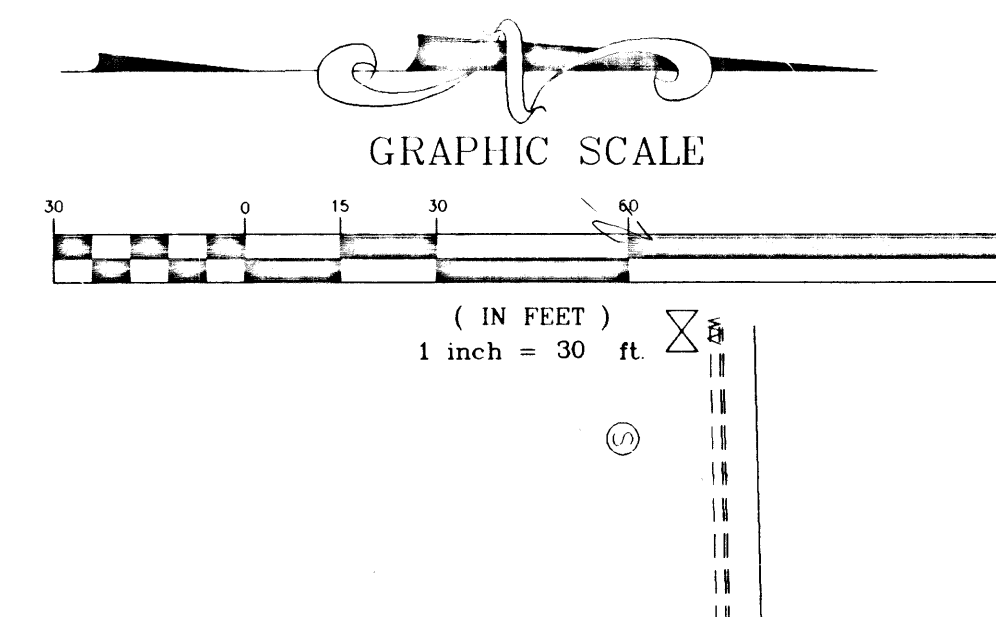

Standage & Truitt Engineering, Ltd.
CIVIL ENGINEERING AND SURVEYING
6855 W. CHARLESTON BOULEVARD
LAS VEGAS, NEVADA 89117
PHONE: (702) 255-2950

GRADING PLAN
MT. VIEW LUTHERAN CHURCH
CITY OF LAS VEGAS

PROFESSIONAL SEAL
MICHAEL J. CREHAN
CIVIL
NO. 10664
8/8/96

FILE
CE NO. 9510-24-03
DESIGNER
DRAWN BY
CHECKED BY
DATE: 12-6-95

SHEET NO.
2 of 5

107-V2577