


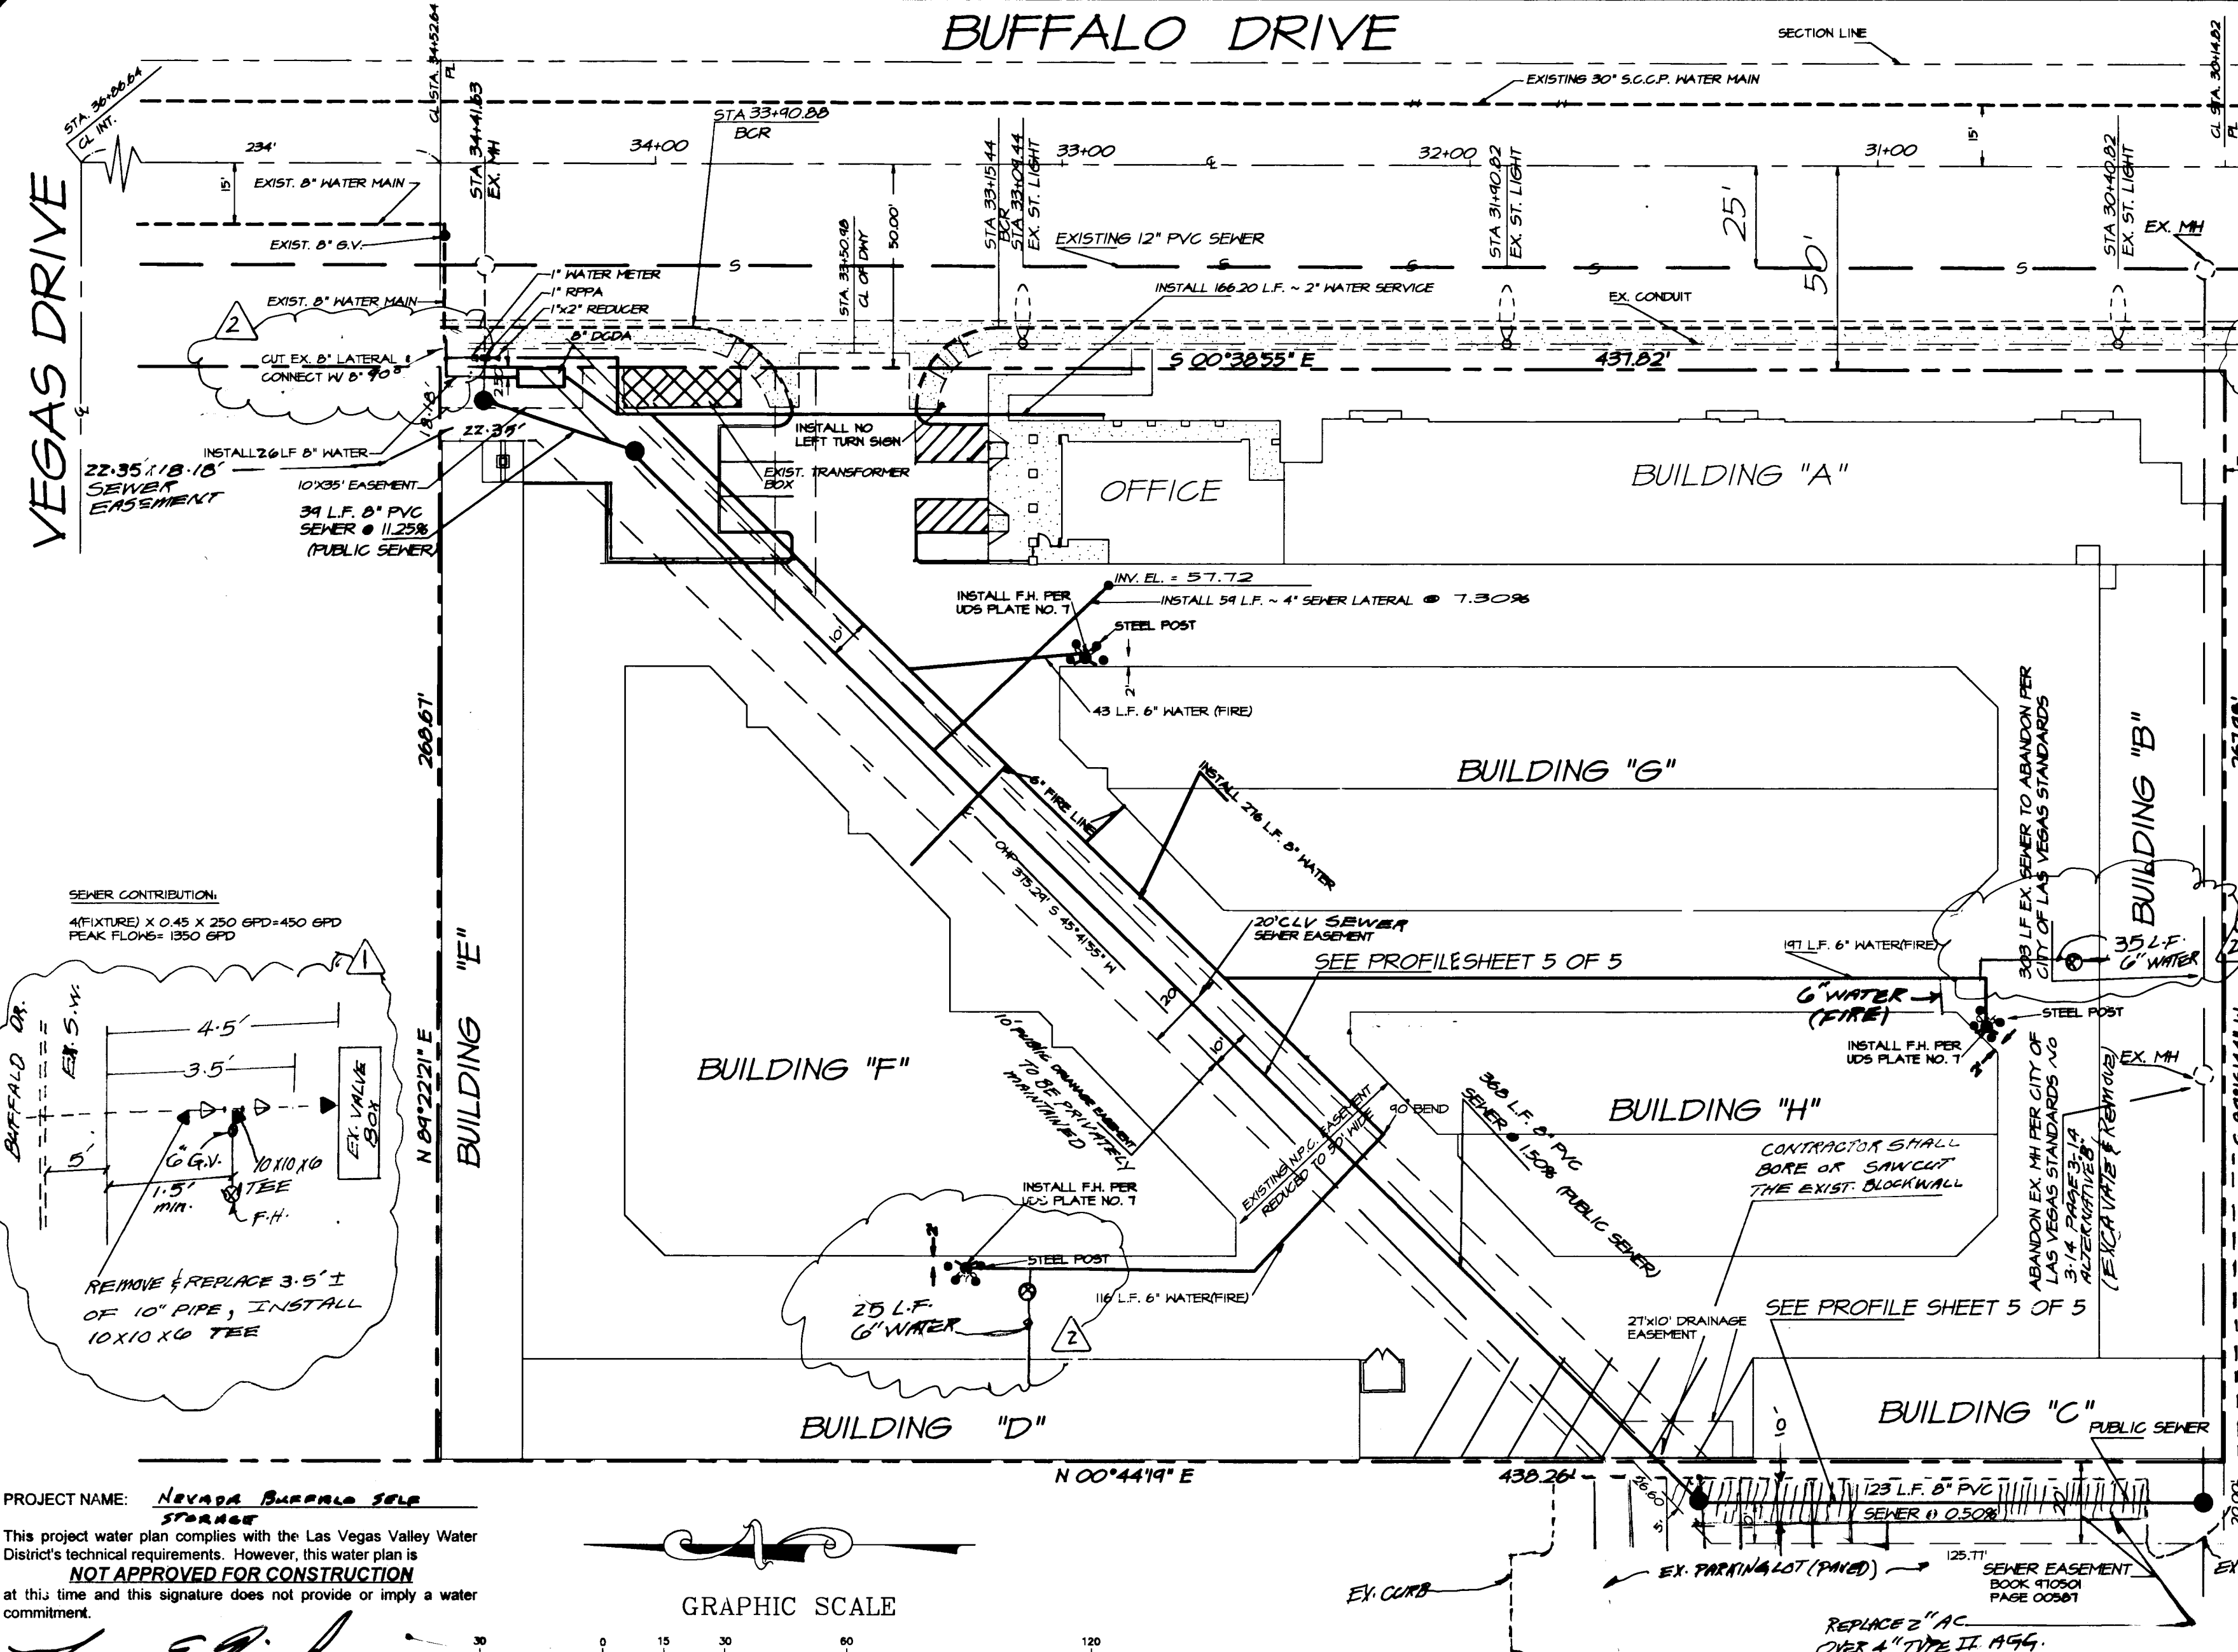

PROJECT NAME: Nevada Buffalo Self Storage
This project water plan complies with the Las Vegas Valley Water District's technical requirements. However, this water plan is NOT APPROVED FOR CONSTRUCTION at this time and this signature does not provide or imply a water commitment.



APPROVALS:
LAS VEGAS VALLEY WATER DISTRICT: 10/31/97
NEVADA POWER COMPANY: 7-15-97
SOUTHWEST GAS CORPORATION: 6/30/97
SPRINT/GENERAL ELECTRIC/NEVADA: 6/6/97
CITY OF LAS VEGAS FIRE DEPARTMENT: 6-9-97
LCI CORPORATION: 6/9/97

LEGEND

---	EXISTING WATER LINE
---	PROPOSED WATER LINE
⊗	EXISTING FIRE HYDRANT
⊗	PROPOSED FIRE HYDRANT
---	EXISTING MANHOLE
⊗	PROPOSED MANHOLE
⊗	EXISTING WATER VALVE
⊗	TRAFFIC CONTROL SIGN
---	PROPOSED SEWER
---	BLOW OFF
---	PROPOSED 1-1/4" PVC ST. LT. CONDUIT
---	100W HPS LUMINAIRE 1/4" GA. POLE
---	EXISTING STREET LIGHT

BASIS OF BEARINGS
S 84°22'21" W BEING THE NORTHLINE OF THE NORTHEAST ONE-QUARTER NE 1/4 OF SECTION 28, TOWNSHIP 20 SOUTH, RANGE 60 EAST, M.D.M. CITY OF LAS VEGAS, CLARK COUNTY, NEVADA PER FILE # 11, PAGE 4 OF SURVEYS.

BENCHMARK
CITY OF LAS VEGAS BENCH MARK # GLV00214
N.A.V.D. 88 ELEV. = 740.0340m
RIVET & ALUM. PLATE IN TOP OF CURB @ NORTHWEST CORNER LAKE HEAD @ BUFFALO DRIVE
ELEVATION = 2421.93 FEET

CALL BEFORE YOU DIG
1-800-227-2600

FIRE FLOW REQUIREMENT IS 1750 GAL. PER MIN. AT 20 POUNDS PER SQUARE INCH RESIDUAL

BUILDINGS	OFFICE/ MANAGERS UNIT	A	B	C	D	E	F	G	H
SQUARE FOOTAGE	2,345	7,650	5,850	2,875	5,625	4,440	26,180	25,800	16,200
NUMBER OF FLOORS	2	1	1	1	1	1	2	2	2
CONSTRUCTION TYPE	VN	11-N	11-N	11-N	11-N	11-N	11-N	11-N	11-N
HEIGHT ALLOWABLE/ACTUAL	40/25 FT.	55/14 FT.	55/14 FT.	55/14 FT.	55/14 FT.	55/14 FT.	55/20 FT.	55/20 FT.	55/20 FT.
FULLY SPRINKLER SYSTEM	NO	NO	NO	NO	NO	NO	YES	YES	YES

REDUCED PRESSURE PRINCIPLE ASSEMBLY

APPROVED REDUCED PRESSURE PRINCIPLE ASSEMBLY(S) SHALL BE INSTALLED PER THE UDACS PLATE NO. 11A NO WATER SHALL BE TAKEN FROM A SERVICE REQUIRING BACK-FLOW PREVENTION UNTIL THE REDUCED PRESSURE PRINCIPLE ASSEMBLY HAS BEEN SUCCESSFULLY TESTED BY THE LVVWD.

ANY BLOCK WALL OR OTHER FENCE MATERIAL SHALL BE DESIGNED AND CONSTRUCTED AROUND THE OUTSIDE OF THE EASEMENT(S) TO ALLOW THE DISTRICT DIRECT ACCESS FROM THE ADJACENT RIGHT-OF-WAY.

INSTALLATION OF DOUBLE CHECK DETECTOR ASSEMBLY

THE DOUBLE CHECK DETECTOR ASSEMBLIES SHALL BE INSTALLED IN ACCORDANCE WITH THE UDACS PLATE 20B.

ANY BLOCK WALL OR OTHER FENCE MATERIAL SHALL BE DESIGNED AND CONSTRUCTED AROUND THE OUTSIDE OF THE EASEMENT(S), SO AS TO ALLOW THE DISTRICT DIRECT ACCESS FROM THE ADJACENT RIGHT-OF-WAY.

FIRE HYDRANT INSTALLATION

FIRE HYDRANT(S) TO BE INSTALLED IN ACCORDANCE WITH THE UDACS STANDARD PLATE NO. 7

NOTE:
EXISTING UTILITY LOCATIONS SHOWN HEREON ARE APPROXIMATE ONLY. IT SHALL BE THE CONTRACTOR'S RESPONSIBILITY TO DETERMINE THE EXACT VERTICAL AND HORIZONTAL LOCATION OF ALL EXISTING UNDERGROUND UTILITIES PRIOR TO COMMENCING CONSTRUCTION. NO REPRESENTATION IS MADE THAT ALL EXISTING UTILITIES ARE SHOWN HEREON. THE ENGINEER ASSUMES NO RESPONSIBILITY FOR UTILITIES NOT SHOWN OR UTILITIES NOT SHOWN IN THEIR PROPER LOCATION.

CITY OF LAS VEGAS SEWER NOTES

- ALL CONSTRUCTION AND MATERIALS SHALL BE IN ACCORDANCE WITH THE LATEST EDITION OF THE DESIGN & CONSTRUCTION STANDARDS FOR WASTEWATER COLLECTION SYSTEMS AND THE UNIFORM STANDARD SPECIFICATIONS FOR PUBLIC WORKS CONSTRUCTION OFF-SITE IMPROVEMENTS, CLARK COUNTY AREA, NEVADA, AS AMENDED. IN ALL CASES, THESE STANDARDS SHALL SUPERSEDE THE UNIFORM STANDARD SPECIFICATIONS. IT WILL BE THE RESPONSIBILITY OF THE CONTRACTOR TO BE AWARE OF THE CONTENTS OF THE ABOVE SPECIFICATION BOOKS.
- IT SHALL BE THE CONTRACTOR'S RESPONSIBILITY TO PERFORM CONSTRUCTION AS PER PLAN. ANY ADDITIONS, DELETIONS, OR CHANGES SHALL FIRST MEET WITH THE APPROVAL OF THE CONTROLLING AGENCY.
- CHISEL "S" OR "B" IN CURBS WHERE SEWER OR GAS LATERALS PASS UNDER CURB.
- POLYVINYL (PVC) SEWER PIPE SHALL MEET ASTM D-3034 SDR 35 SPECIFICATIONS, AND INSTALLED WITH SAND BEDDING AND BACKFILL OF TYPE II GRAVEL.
- ALL MANHOLES IN PAVED STREETS 80 FT. R/W AND LARGER, SHALL HAVE CONCRETE COLLARS.
- TEE SADDLES SHALL BE USED TO CONNECT SEWER LATERALS TO EXISTING MAIN LINES UP TO 12 IN. DIA. SIZE. CONNECTIONS TO 15 IN. OR LARGER MAINS SHALL REQUIRE SPECIAL PROCEDURES.
- A SEWER MAIN CROSSING OVER A WATER MAIN OR LESS THAN 18 IN. UNDER A WATER MAIN MUST BE REINFORCED CONCRETE ENCASED PIPE FOR A DISTANCE OF NOT LESS THAN TEN FEET (10') ON EACH SIDE OF THE CENTERLINE OF THE WATER MAIN.
- ALL CONTRACTORS INSTALLING SEWER MAINS THAT WILL BE UNDER THE JURISDICTION OF THE CONTROLLING AGENCY MUST BE CLASS "A" CONTRACTORS.
- THE CITY OF LAS VEGAS WILL NOT ACCEPT ANY SEWER MAINS WHICH HAVE A VERTICAL DEFLECTION OF MORE THAN ONE TENTH (0.1) OF A FOOT FROM THE APPROVED CONSTRUCTION PLANS. SEWER MAINS FOUND TO EXCEED THIS TOLERANCE WILL HAVE TO BE REPAIRED OR REMOVED AND REPLACED TO THE SATISFACTION OF THE CITY ENGINEER PRIOR TO ACCEPTANCE BY THE CITY.


LAS VEGAS VALLEY WATER DISTRICT NOTES

- NO WORK SHALL BEGIN UNTIL THE WATER PLANS HAVE BEEN RELEASED FOR CONSTRUCTION BY THE LVVWD. FOLLOWING WATER PLAN APPROVAL, 10 HOUR NOTICE SHALL BE GIVEN TO THE LVVWD CUSTOMER SERVICE DEPARTMENT (258-7171) PRIOR TO THE START OF CONSTRUCTION. NOTICE MUST BE GIVEN BY 2:00 P.M. THE BUSINESS DAY PRIOR TO A LVVWD INSPECTION.
- ALL WORK SHALL CONFORM TO LVVWD STANDARD PLATES DRAWINGS, AND SPECIFICATIONS AND THE UNIFORM DESIGN AND CONSTRUCTION STANDARDS FOR WATER DISTRIBUTION SYSTEMS (UDACS), LATEST EDITION.
- ALL WORK, EXCEPT AS MODIFIED BY THESE PLATES OR BY NOTE 2, SHALL BE DONE IN ACCORDANCE WITH THE MOST CURRENT DRAFT OR EDITION OF THE UNIFORM STANDARD SPECIFICATIONS FOR PUBLIC WORKS CONSTRUCTION OFFSITE IMPROVEMENT, CLARK COUNTY AREA.
- A SINGLE PIPE MATERIAL SHALL BE USED THROUGHOUT THE PROJECT UNLESS OTHERWISE APPROVED BY THE LVVWD.
- ALL SERVICE LATERALS TWO (2) INCHES IN DIAMETER AND SMALLER SHALL BE COPPER TUBING WITH LVVWD APPROVED SERVICE SADDLES.
- ALL WATER METER BOXES SHALL BE LOCATED OUTSIDE OF DRIVEWAY AREAS.
- ALL VALVES SHALL BE LOCATED OUTSIDE OF DRIVEWAYS, VALLEY AND CURB CUTTERS.
- THE FOLLOWING REQUIREMENTS MUST BE MET IN THE EVENT A WATER LINE AND SANITARY OR STORM SEWER LINE CROSS:

A. MINIMUM EIGHTEEN (18) INCH VERTICAL SEPARATION (OUTSIDE TO OUTSIDE) MUST BE MAINTAINED WHEN THE WATER LINE IS INSTALLED OVER THE SANITARY OR STORM SEWER LINE. IF THE VERTICAL SEPARATION CANNOT BE MAINTAINED OR THE WATER LINE MUST BE PLACED UNDER THE SANITARY OR STORM SEWER LINE, THE SANITARY OR STORM SEWER LINE MUST BE CONSTRUCTED WITH ONE OF THE FOLLOWING OR, AS SHOWN ON THESE PLANS:

A. POTABLE WATER SUPPLY QUALITY MATERIAL.
B. ENCASEMENT, WITH FOUR (4) INCH CONCRETE (MINIMUM).
C. SLEEVING WITH POTABLE WATER SUPPLY QUALITY PIPE.

EACH PROVISION MUST EXTEND ALONG THE SANITARY OR STORM SEWER, ON EITHER SIDE OF THE MAIN, A MINIMUM 10 FOOT DISTANCE PERPENDICULAR TO THE WATER MAIN EXTERIOR.
- WARNING TAPE SHALL BE REQUIRED OVER ALL MAINS, ALL SIX (6) INCH DIAMETER AND LARGER SERVICE LATERALS AND ANY SERVICE LATERAL NOT INSTALLED PERPENDICULAR TO THE MAIN IN ACCORDANCE WITH STANDARD PLATE NO. 27.
- ALL WATER FACILITIES SHALL BE FILLED, DISINFECTED, PRESSURE TESTED, FLUSHED, FILLED AND AN ACCEPTABLE WATER SAMPLE OBTAINED PRIOR TO CONNECTION TO THE LVVWD'S DISTRIBUTION SYSTEM.
- THE CONTRACTOR MUST OBTAIN ALL METERS TWO (2) INCHES AND SMALLER FROM LVVWD CENTRAL STORES. TELEPHONE 258-3152 FORTY-EIGHT (48) HOURS PRIOR TO PICKUP.
- CONSTRUCTION MAY INTERRUPT SERVICE, WITH LVVWD APPROVAL AND PROPER NOTIFICATION BETWEEN THE HOURS OF 10 PM AND 5 AM, SUNDAY THROUGH THURSDAY. CIRCUMSTANCES MAY REQUIRE TEMPORARY SERVICE FEES. BE INSTALLED WITHOUT LVVWD REIMBURSEMENT. ANY TEMPORARY SERVICE FEE MUST HAVE PRIOR LVVWD APPROVAL.
- ALL WATER FACILITY CONSTRUCTION MATERIALS USED MUST BE AS LISTED ON THE UNIFORM STANDARD SPECIFICATIONS AND MANUFACTURER'S LISTING FOR NEW FACILITIES, LATEST REVISION OR SPECIFICALLY APPROVED ON THESE PLANS.

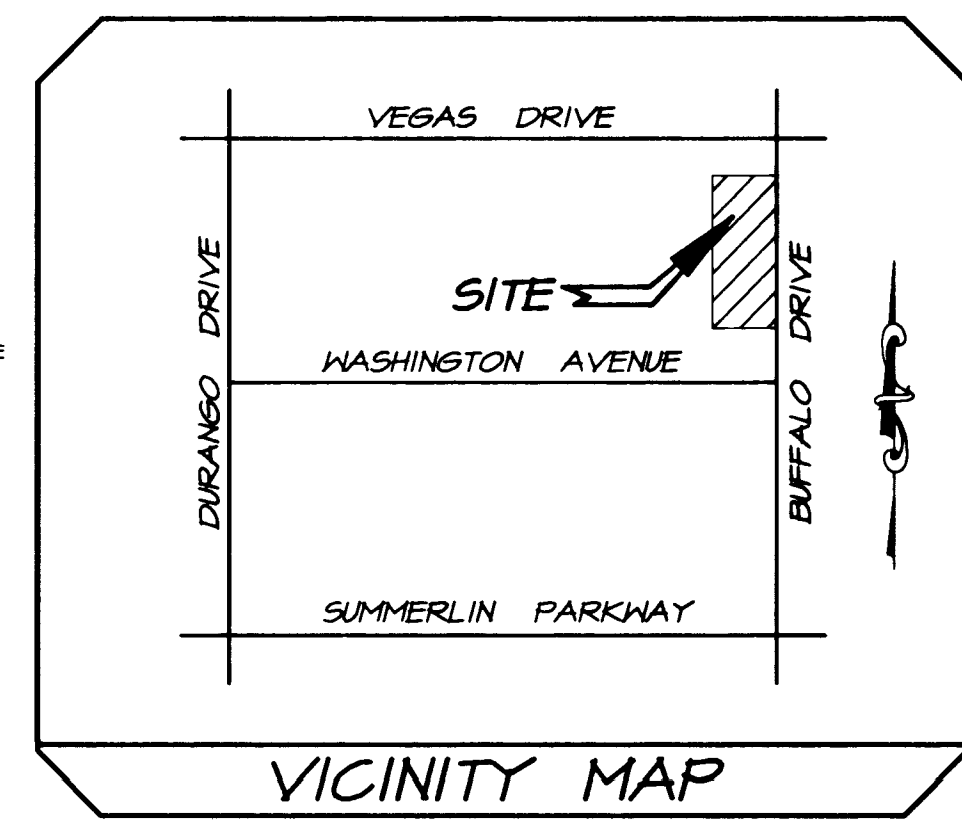

SEWER QUANTITY ESTIMATE

8" PVC SANITARY SEWER	530 L.F.
48" MANHOLE	4 EA.
4" SEWER LINE	59 L.F.
CLEANOUT	1 EA.

WATER QUANTITY ESTIMATE

DESCRIPTION	TOTAL	UNIT
8" PVC WATER LINE	247	L.F.
6" PVC WATER LINE	416	L.F.
1" COPPER WATER SERVICE	5	L.F.
2" WATER SERVICE	158	L.F.
1" WATER METER	1	EA.
1" R.P.P.A.	1	EA.
1" SERVICE SADDLE	1	EA.
1"x2" REDUCER	1	EA.
FIRE HYDRANT	4	EA.
8" DCDA	1	EA.
8" 45	2	EA.
10"x6" TAPPING SLEEVE & VALVE	1	EA.

CITY OF LAS VEGAS FIRE DEPT. NOTES

 

- ALL WORK SHALL BE DONE IN STRICT ACCORDANCE WITH THE CITY OF LAS VEGAS FIRE DEPARTMENT "HYDRANT SPECIFICATIONS", "HYDRANT INSTALLATION SPECIFICATIONS" AND ORDINANCE #3944.
- AUTHORIZED HYDRANTS FOR THIS PROJECT ARE:

A. KENNEDY GUARDIAN
B. MUELLER A-423 CENTURIAN
C. CLOW MODEL 2546 MEDALLION
- ON ANY NEW HOME OR BUILDING INSTALLATION ACCESSIBLE FIRE HYDRANTS SHALL BE INSTALLED BEFORE COMBUSTIBLE CONSTRUCTION COMMENCES AND SAID FIRE HYDRANTS SHALL BE IN GOOD WORKING ORDER WITH AN ADEQUATE WATER SUPPLY.
- CONTRACTOR SHALL PLACE A BLUE REFLECTIVE MARKER AT CENTER LINE OF STREET ADJACENT TO FIRE HYDRANT AS REQUIRED IN ORDINANCE #3944 TO IDENTIFY FIRE HYDRANT LOCATIONS.
- CALL THE LAS VEGAS BUILDING DEPARTMENT AT 224-2071 FOR UNDERGROUND INSPECTION, PRESSURE AND FLUSH VERIFICATION OF ALL FIRE HYDRANTS AND FIRE LINES BEFORE COVERING.
- PAINTING OF THE CURBS AND HYDRANT AND ANY WORK NECESSARY FOR PROTECTION OF HYDRANTS FROM PHYSICAL DAMAGE PER ORDINANCE #3944 SHALL BE COMPLETED BEFORE APPROVAL BY THE CITY OF LAS VEGAS FIRE DEPARTMENT.
- A PERMIT IS REQUIRED FROM THE FIRE DEPARTMENT FOR ON-SITE WATER LINE AND FIRE HYDRANT. THE PERMIT AND CONTRACTORS MATERIAL AND TEST CERTIFICATE FOR UNDERGROUND PIPING FORM SHALL BE OBTAINED FROM THE FIRE PROTECTION ENGINEER PRIOR TO ANY WORK BEGINNING.
- PRIVATE FIRE HYDRANTS SHALL BE PAINTED RED.
- A FLOW TEST MUST BE WITNESSED BY THE FIRE DEPARTMENT PRIOR TO OCCUPANCY FOR VERIFICATION OF REQUIRED ON-SITE WATER SUPPLY.
- ALL ON-SITE FIRE MAIN MATERIALS MUST BE U.L. LISTED A.J.W.A. APPROVED.
- FIRE HYDRANT SPACING:
RESIDENTIAL - 500 FEET UNSPRINKLERED, 1000 FEET SPRINKLERED.
COMMERCIAL INCLUDING MULTI-FAMILY - 300 FEET UNSPRINKLERED, 600 FEET SPRINKLERED.
- WHERE NEW WATER MAINS ARE EXTENDED ALONG STREETS, WHERE HYDRANTS ARE NOT NEEDED FOR PROTECTION OF STRUCTURES, FIRE HYDRANTS SHALL BE SPACED AT MAXIMUM 1000 FOOT SPACING TO PROVIDE FOR TRANSPORTATION HAZARDS.
- NO FIRE HYDRANT SHALL BE LOCATED WITHIN THE REQUIRED RADIUS OF CUL-DE-SAC OR WITHIN 20 FEET OF THE PERIMETER OF THE RADIUS OF THE CUL-DE-SAC.
- NO FIRE HYDRANT SHALL BE LOCATED WITHIN 6 FEET OF ANY CURB RETURN, DRIVEWAY, POWER POLE, STREET LIGHT OR ANY OTHER OBSTRUCTION.
- TWO SOURCES OF SUPPLY ARE REQUIRED WHENEVER THERE ARE 4 OR MORE FIRE HYDRANTS INSTALLED ON A SINGLE SYSTEM.
- NOT MORE THAN 2 HYDRANTS CAN BE OUT OF SERVICE DUE TO A SINGLE MAIN BREAK.
- FIRE APPARATUS ACCESS ROADS SHALL HAVE AN UNOBSTRUCTED WIDTH OF NOT LESS THAN 20 FEET PROVIDED NO PARKING IS ALLOWED, NOT LESS THAN 28 FEET IF PARALLEL PARKING IS ALLOWED ON ONE SIDE, AND NOT LESS THAN 36 FEET IF PARALLEL PARKING IS ALLOWED ON BOTH SIDES. VERTICAL CLEARANCE SHALL BE NOT LESS THAN 13 FEET 6 INCHES.
- THE TURNING RADIUS FOR ANY FIRE APPARATUS ACCESS ROAD AND/OR FIRE LINE, PUBLIC OR PRIVATE SHALL BE NOT LESS THAN 45 FEET OUTSIDE RADIUS AND 22 FEET INSIDE RADIUS.
- A FIRE APPARATUS ROAD SHALL BE REQUIRED WHEN ANY PORTION OF AN EXTERIOR WALL OF THE FIRST STORY IS LOCATED MORE THAN 150 FEET FROM A FIRED DEPARTMENT VEHICLE ACCESS. (SEE EXCEPTIONS IN UFG #4, SECTION 902.2)
- ALL DEAD END FIRE HYDRANTS APPARATUS ACCESS ROADS AND/OR FIRE LINES PUBLIC OR PRIVATE IN EXCESS OF 150 FEET IN LENGTH SHALL BE PROVIDED WITH AN APPROVED TURNAROUND AREA. SEE ORDINANCE #3944.
- ACCESS ROADS SHALL BE MARKED BY PLACING APPROVED SIGNS AT THE START OF THE DESIGNATED FIRE LANE, ONE SIGN AT THE END OF THE FIRE LANE AND WITH SIGNS AT INTERVALS OF 100 FEET ALONG ALL DESIGNATED FIRE LANES. SIGNS TO BE PLACED ON BOTH SIDES OF AN ACCESS ROADWAY IF NEEDED TO PREVENT PARKING ON EITHER SIDE. SIGNS TO BE INSTALLED NO HIGHER THAN 10 FEET OR LESS THAN 6 FEET FROM ROADWAY LEVEL. THE CURBS ALONG OR ON THE PAVEMENT OR CURB IF CURB IS NOT PRESENT, SHALL BE PAINTED WITH A RED WEATHER RESISTANT PAINT IN ADDITION TO THE SIGNS.
- ELECTRICALLY CONTROLLED ACCESS GATES SHALL BE PROVIDED WITH AN APPROVED EMERGENCY VEHICLE DETECTOR & RECEIVER SYSTEM. SAID SYSTEM SHALL BE INSTALLED IN ACCORDANCE WITH THE CITY OF LAS VEGAS GUIDELINE FOR AUTOMATIC EMERGENCY VEHICLE ACCESS GATES.

UTILITY PLAN
NEVADA BUFFALO SELF STORAGE
CITY OF LAS VEGAS, NEVADA

APPROVED
PROJECT NO. 1: 405
PROJECT MGR.: K. P.
DESIGNED BY: A. T.
DRAWN BY: D. R.
DATE: 5/17/97

SHEET
4
OF
5

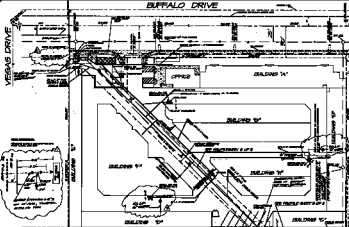

APPROVALS	LEND
<i>[Signature]</i> 11/2/77	OWNER
<i>[Signature]</i> 11/2/77	DESIGNER
<i>[Signature]</i> 11/2/77	ENGINEER
<i>[Signature]</i> 11/2/77	PLUMBER
<i>[Signature]</i> 11/2/77	ELECTRICIAN
<i>[Signature]</i> 11/2/77	Mechanical
<i>[Signature]</i> 11/2/77	Sanitary
<i>[Signature]</i> 11/2/77	Fire
<i>[Signature]</i> 11/2/77	Other

NOTES:

1. ALL WORK SHALL BE IN ACCORDANCE WITH THE CITY OF LAS VEGAS SPECIFICATIONS.
2. ALL MATERIALS SHALL BE OF THE BEST QUALITY AVAILABLE.
3. ALL WORK SHALL BE COMPLETED BY THE DATE SPECIFIED.
4. ALL WORK SHALL BE SUBJECT TO INSPECTION BY THE CITY OF LAS VEGAS.
5. ALL WORK SHALL BE SUBJECT TO INSPECTION BY THE CITY OF LAS VEGAS.

TEST DATE	TEST TIME	TEST PRESSURE (PSI)	TEST FLOW (GPM)	TEST RESULTS
11/2/77	10:00	100	1000	GOOD
11/2/77	10:10	100	1000	GOOD
11/2/77	10:20	100	1000	GOOD
11/2/77	10:30	100	1000	GOOD
11/2/77	10:40	100	1000	GOOD
11/2/77	10:50	100	1000	GOOD
11/2/77	11:00	100	1000	GOOD
11/2/77	11:10	100	1000	GOOD
11/2/77	11:20	100	1000	GOOD
11/2/77	11:30	100	1000	GOOD
11/2/77	11:40	100	1000	GOOD
11/2/77	11:50	100	1000	GOOD
11/2/77	12:00	100	1000	GOOD

REDUCED PRESSURE PRINCIPLE ASSEMBLY

THIS ASSEMBLY IS TO BE INSTALLED IN ACCORDANCE WITH THE CITY OF LAS VEGAS SPECIFICATIONS.

INSTALLATION OF DOUBLE CHECK DETECTOR ASSEMBLY

THIS ASSEMBLY IS TO BE INSTALLED IN ACCORDANCE WITH THE CITY OF LAS VEGAS SPECIFICATIONS.

PISTON HYDRANT INSTALLATION

THIS ASSEMBLY IS TO BE INSTALLED IN ACCORDANCE WITH THE CITY OF LAS VEGAS SPECIFICATIONS.

NOTES:

1. ALL WORK SHALL BE IN ACCORDANCE WITH THE CITY OF LAS VEGAS SPECIFICATIONS.
2. ALL MATERIALS SHALL BE OF THE BEST QUALITY AVAILABLE.
3. ALL WORK SHALL BE COMPLETED BY THE DATE SPECIFIED.
4. ALL WORK SHALL BE SUBJECT TO INSPECTION BY THE CITY OF LAS VEGAS.
5. ALL WORK SHALL BE SUBJECT TO INSPECTION BY THE CITY OF LAS VEGAS.

CITY OF LAS VEGAS SENIOR NOTES

1. ALL WORK SHALL BE IN ACCORDANCE WITH THE CITY OF LAS VEGAS SPECIFICATIONS.
2. ALL MATERIALS SHALL BE OF THE BEST QUALITY AVAILABLE.
3. ALL WORK SHALL BE COMPLETED BY THE DATE SPECIFIED.
4. ALL WORK SHALL BE SUBJECT TO INSPECTION BY THE CITY OF LAS VEGAS.
5. ALL WORK SHALL BE SUBJECT TO INSPECTION BY THE CITY OF LAS VEGAS.

LAS VEGAS VALLEY WATER DISTRICT NOTES

1. ALL WORK SHALL BE IN ACCORDANCE WITH THE CITY OF LAS VEGAS SPECIFICATIONS.
2. ALL MATERIALS SHALL BE OF THE BEST QUALITY AVAILABLE.
3. ALL WORK SHALL BE COMPLETED BY THE DATE SPECIFIED.
4. ALL WORK SHALL BE SUBJECT TO INSPECTION BY THE CITY OF LAS VEGAS.
5. ALL WORK SHALL BE SUBJECT TO INSPECTION BY THE CITY OF LAS VEGAS.

ITEM	QUANTITY	UNIT	PRICE	TOTAL
1. WATER TREATMENT	1000	CU YD	1.00	1000.00
2. WATER PUMP	1000	CU YD	1.00	1000.00
3. WATER PIPE	1000	CU YD	1.00	1000.00
4. WATER VALVE	1000	CU YD	1.00	1000.00
5. WATER FITTING	1000	CU YD	1.00	1000.00
6. WATER HUB	1000	CU YD	1.00	1000.00
7. WATER MANHOLE	1000	CU YD	1.00	1000.00
8. WATER INLET	1000	CU YD	1.00	1000.00
9. WATER OUTLET	1000	CU YD	1.00	1000.00
10. WATER CLEANOUT	1000	CU YD	1.00	1000.00

CITY OF LAS VEGAS FIRE DEPT. NOTES

1. ALL WORK SHALL BE IN ACCORDANCE WITH THE CITY OF LAS VEGAS SPECIFICATIONS.
2. ALL MATERIALS SHALL BE OF THE BEST QUALITY AVAILABLE.
3. ALL WORK SHALL BE COMPLETED BY THE DATE SPECIFIED.
4. ALL WORK SHALL BE SUBJECT TO INSPECTION BY THE CITY OF LAS VEGAS.
5. ALL WORK SHALL BE SUBJECT TO INSPECTION BY THE CITY OF LAS VEGAS.

UTILITY PLAN

NEVADA, BUFFALO BRIST STORMING

CITY OF LAS VEGAS, NEVADA

DATE: 11/2/77

BY: [Signature]

4

5