


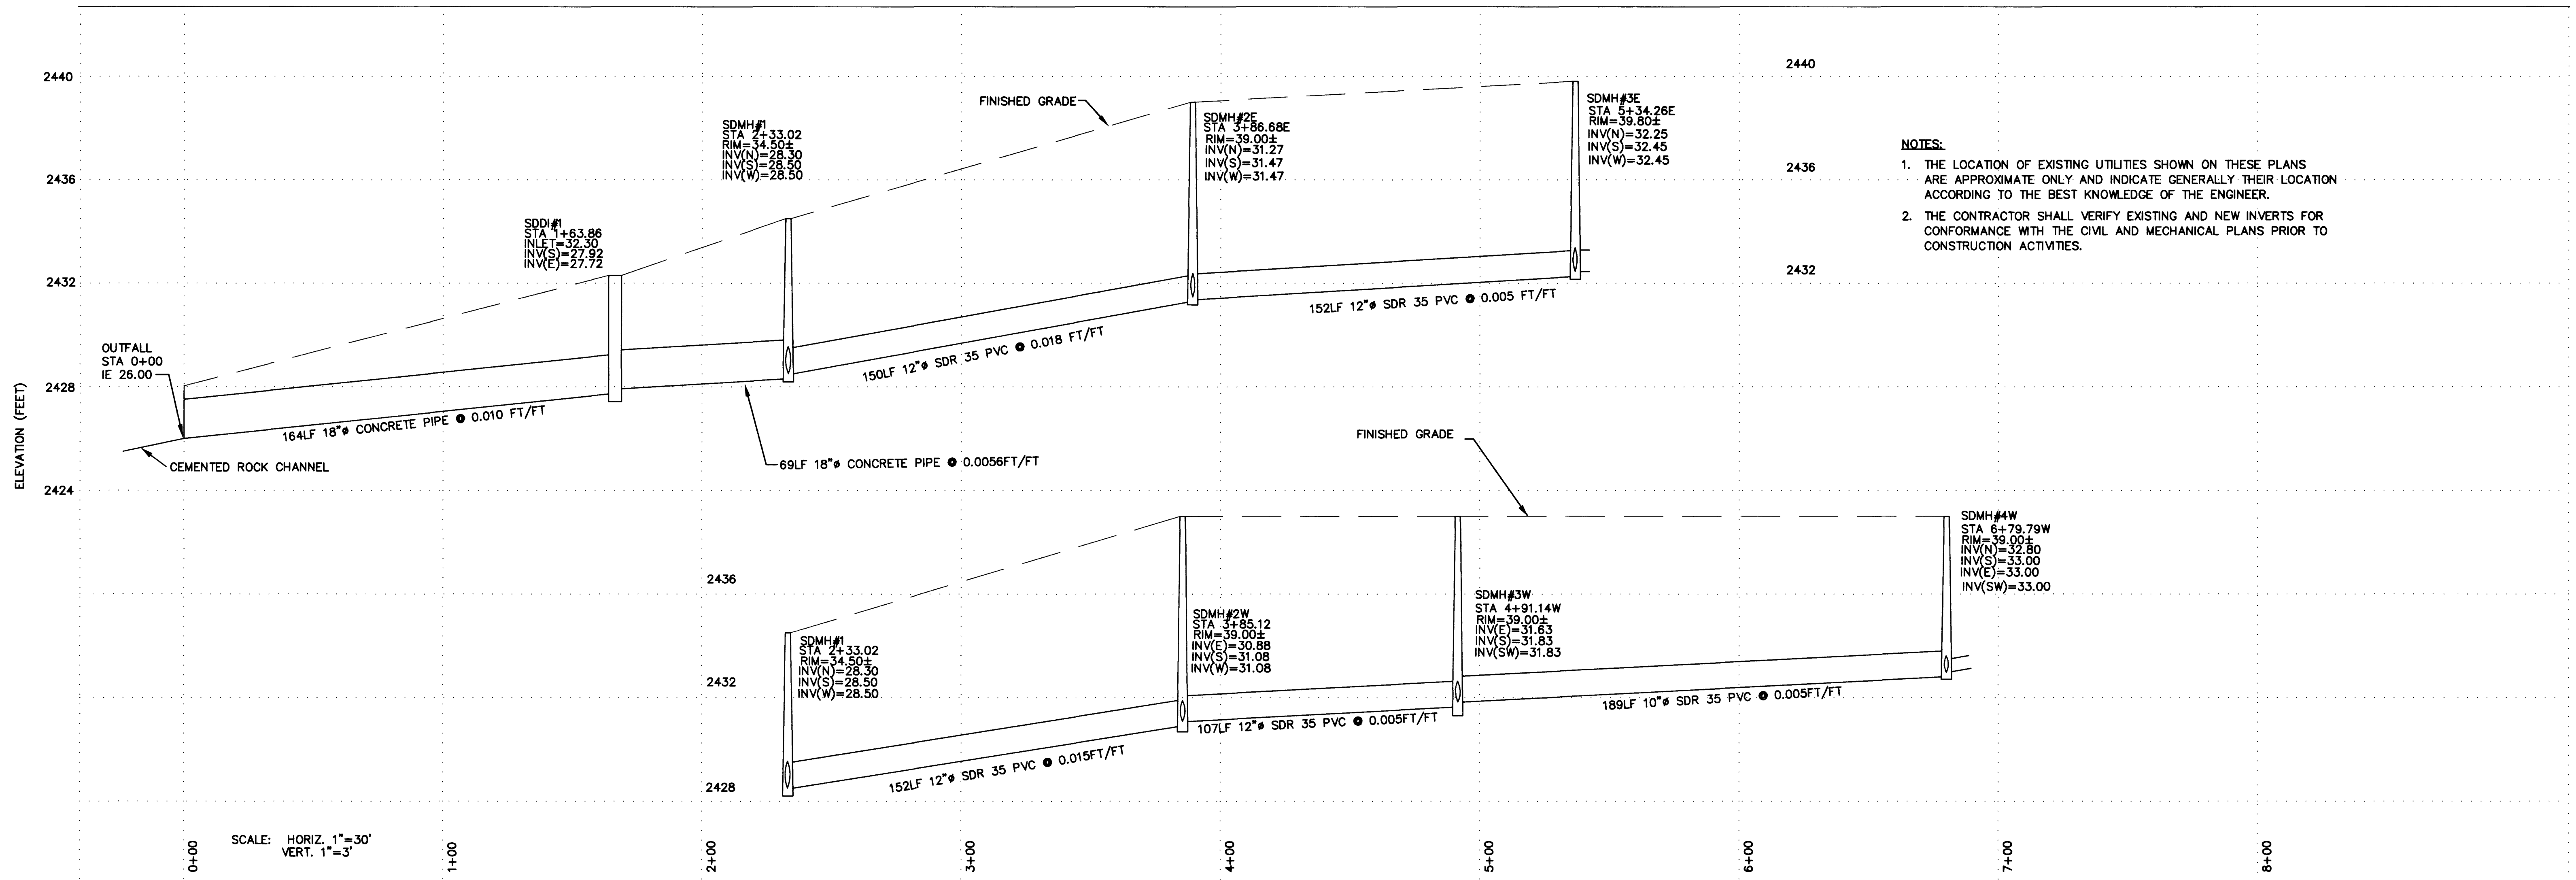

This drawing is the property of HARDING LAWSON ASSOCIATES, including all patented and patentable features, and/or confidential information and its use is conditioned upon the user's agreement not to reproduce the drawing, in whole or part, nor the material described thereon, nor the use of the drawing for any purpose other than specifically permitted in writing by HARDING LAWSON ASSOCIATES.

1	7-2-98 ADDENDUM 2 9/18/98 JLM		
NO.	DATE	REVISIONS	BY
			CHK


DRAWN:	JHM	PROJECT NO:	41712	FILE NAME:	DDRNPRO.DWG
ENGINEER:	JHM	SCALE:	1"=30'		
CHECKED:	GAH	APPROVED:	JLM		
DATE:	2/26/98	DATE:	7-17-98		




Harding Lawson Associates
Engineering and Environmental Services
5145 S. Arville St. Ste. A
Las Vegas, Nevada
(702) 251-5449

NORTHWEST FAMILY RECREATION CENTER
CITY OF LAS VEGAS
400 E. STEWART AVENUE
LAS VEGAS, NEVADA

ROOF AND POOL DECK
DRAINAGE SYSTEM PROFILE

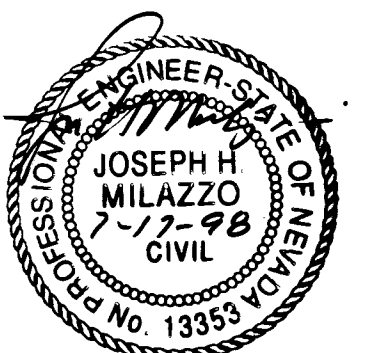

DRAWING:	C13
SHEET:	13 OF 17
REVISION NUMBER:	
DATE:	107-V2759

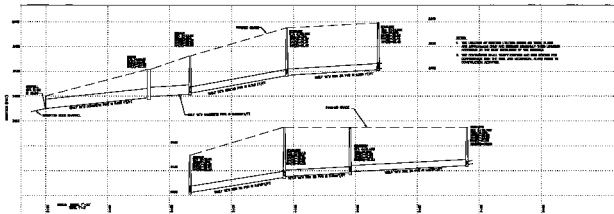

- NOTES:
1. SEE SECTION OF ROOFING SYSTEM DRAWING FOR DRAINAGE AND VENTILATION DETAILS AND FOR DRAINAGE SYSTEMS IN THE BASE COURSE OF THE BUILDING.
 2. SEE VENTILATION AND MECHANICAL AND ELECTRICAL DRAWINGS FOR DRAINAGE AND VENTILATION, AND FOR MECHANICAL AND ELECTRICAL SYSTEMS IN THE BASE COURSE OF THE BUILDING.



REVISIONS		DATE	BY	APP'D

PROJECT	NAME	DATE
DESIGNED BY	DATE	DATE
CHECKED BY	DATE	DATE
APPROVED BY	DATE	DATE

HILA Harding Lammson Associates
 ENGINEERING AND
 ARCHITECTURAL SERVICES
 400 E. STEWART AVENUE
 LAS VEGAS, NEVADA
 89101

NORTHWEST FAMILY RECREATION CENTER
 CITY OF LAS VEGAS
 400 E. STEWART AVENUE
 LAS VEGAS, NEVADA

**ROOF AND POOL DECK
 DRAINAGE SYSTEM PROFILE**

DATE: 11/11/11
 SHEET: 1 OF 17
 DRAWN BY: J. J. JONES
 CHECKED BY: J. J. JONES