



ABBREVIATIONS AND LEGEND


CURB AND GUTTER	EP
EDGE OF PAVEMENT	OL
GUTTER	UP
METERS	ME
VALVES	VA
FIRE HYDRANT	PH
STREET LIGHT	SL
UTILITY LINE	XX
EXISTING SEWER MANHOLE	SM
POWER POLE	PP
GAS	G
ELECTRIC	E
SANITARY SEWER	SS
STORMDRAIN	SD
FINISH GRADE	FG
TOP OF CURB	TC
FLOW LINE	FL
DIRECTION OF FLOW	XX
CONTOURS	XX.XX
EXISTING GRADE	(XX.XX)

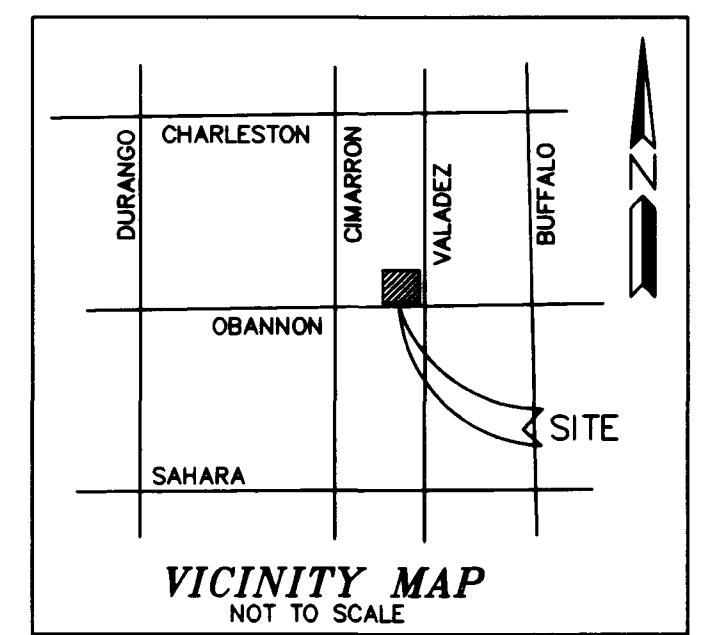

STREET LIGHT NOTES:
1. ALL HANDHOLE COVERS MUST BE INSTALLED, POLE CAPS POURED AND PULL BOX LIDS BOLTED DOWN PRIOR TO ENERGIZING CIRCUIT. ALL WIRES MUST HAVE THW INSULATION.
2. STREET LIGHT INSTALLATIONS SHALL CONFORM TO CITY OF LAS VEGAS STANDARD DRAWINGS AND SPECIFICATIONS.

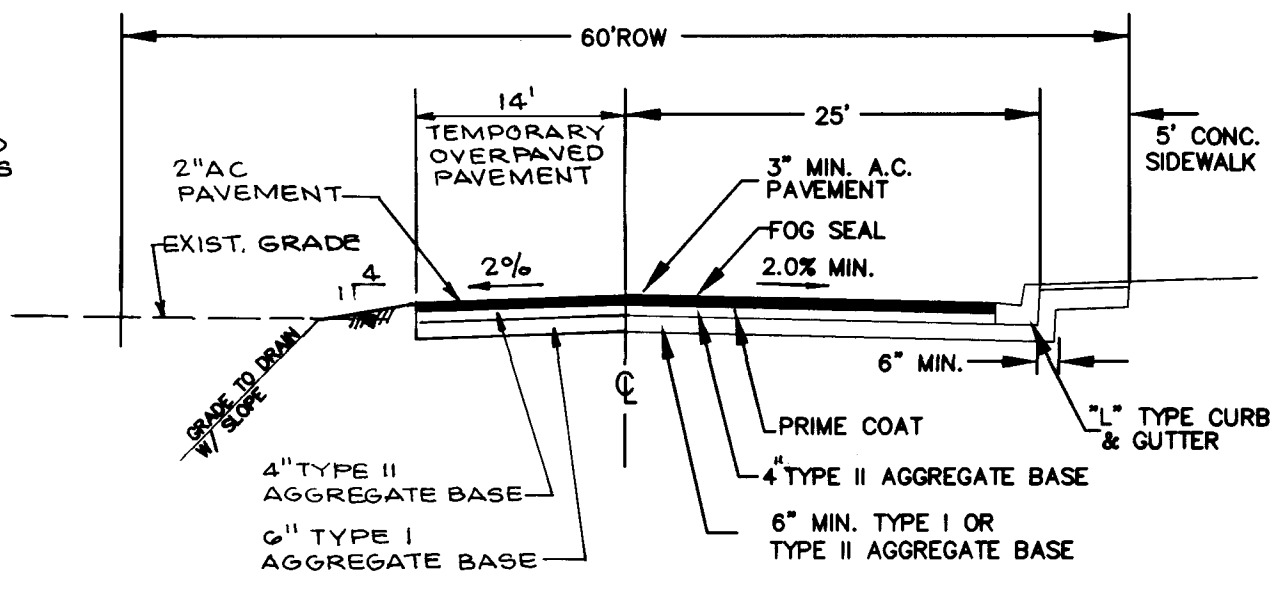

CURVE DATA
CI Δ=95°16'05"
R=20.00
T=21.93
L=33.25
(BACK OF CURVE)

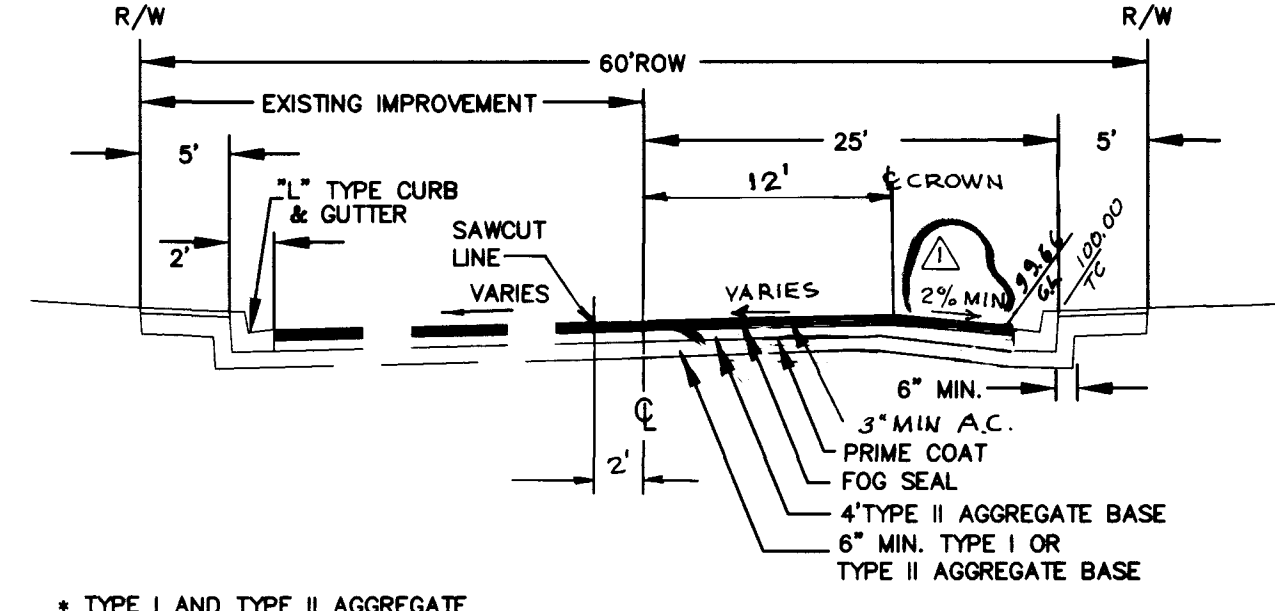


1. A.C. PAVEMENT TO BE 1/2" MAXIMUM ABOVE LIP OF GUTTER AFTER COMPACTION
2. THE GRADE BREAK OCCURRING IN THE CROSS SECTION SHALL FALL BETWEEN DRIVE LANES
3. STRUCTURAL SECTION SHOWN IN IS BASED ON A SUBGRADE "R" VALUE OF 20. OTHER STRUCTURAL SECTION MAY BE REQUIRED BASED ON THE ENGINEERING ANALYSIS OF "R" OR "CBR" VALUES DETERMINED BY SOIL TESTING.

VALADEZ STREET SECTION
NTS

- NOTE:
1. ADJUST EXISTING SEWER MANHOLE COVER TO MATCH NEW FINISH GRADE.
2. ADJUST EXISTING VALVE BOX COVER TO MATCH NEW FINISH GRADE.

QTY OF LAS VEGAS STANDARD DRAWINGS

TITLE	DWG. NO.
① 1/2" TYPE CURB AND GUTTER	218
② SIDEWALK	234
③ CROSS GUTTER	228
④ SIDEWALK RAMP, CASE 1	235
⑤ RESIDENTIAL DRIVEWAY	223

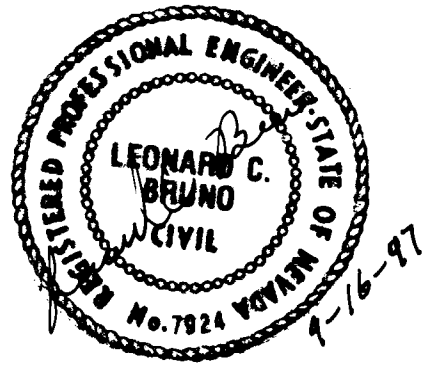

LB Engineering
LEONARDO BRUNO
940 S. MARTIN L. KING
LAS VEGAS, NV 89106
(702) 382-7559

Drawn by CC
Check by
Date
Scale 1" = 30'
APPR
NW VALADEZ & OBANNON ~ FIRE HYDRANT
HELLEN DU AND FRANK TSOU DEVELOPMENT

STREET PLAN AND PROFILE
OBANNON DRIVE AND
VALADEZ STREET

DRAWING NO.
C3
SHEET 3
OF 3

03-07

