
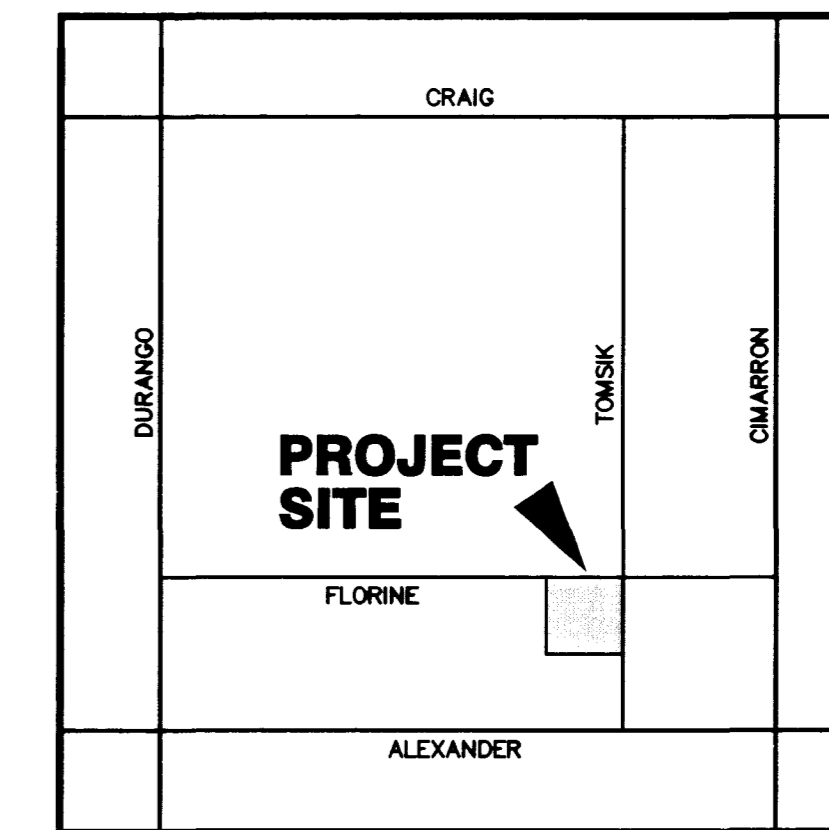


IMPROVEMENT PLANS FOR PARCEL MAP PM 7-99

CITY OF LAS VEGAS
STATE OF NEVADA
APN 138-04-404-015

PROJECT VICINITY
SEE AREA MAP

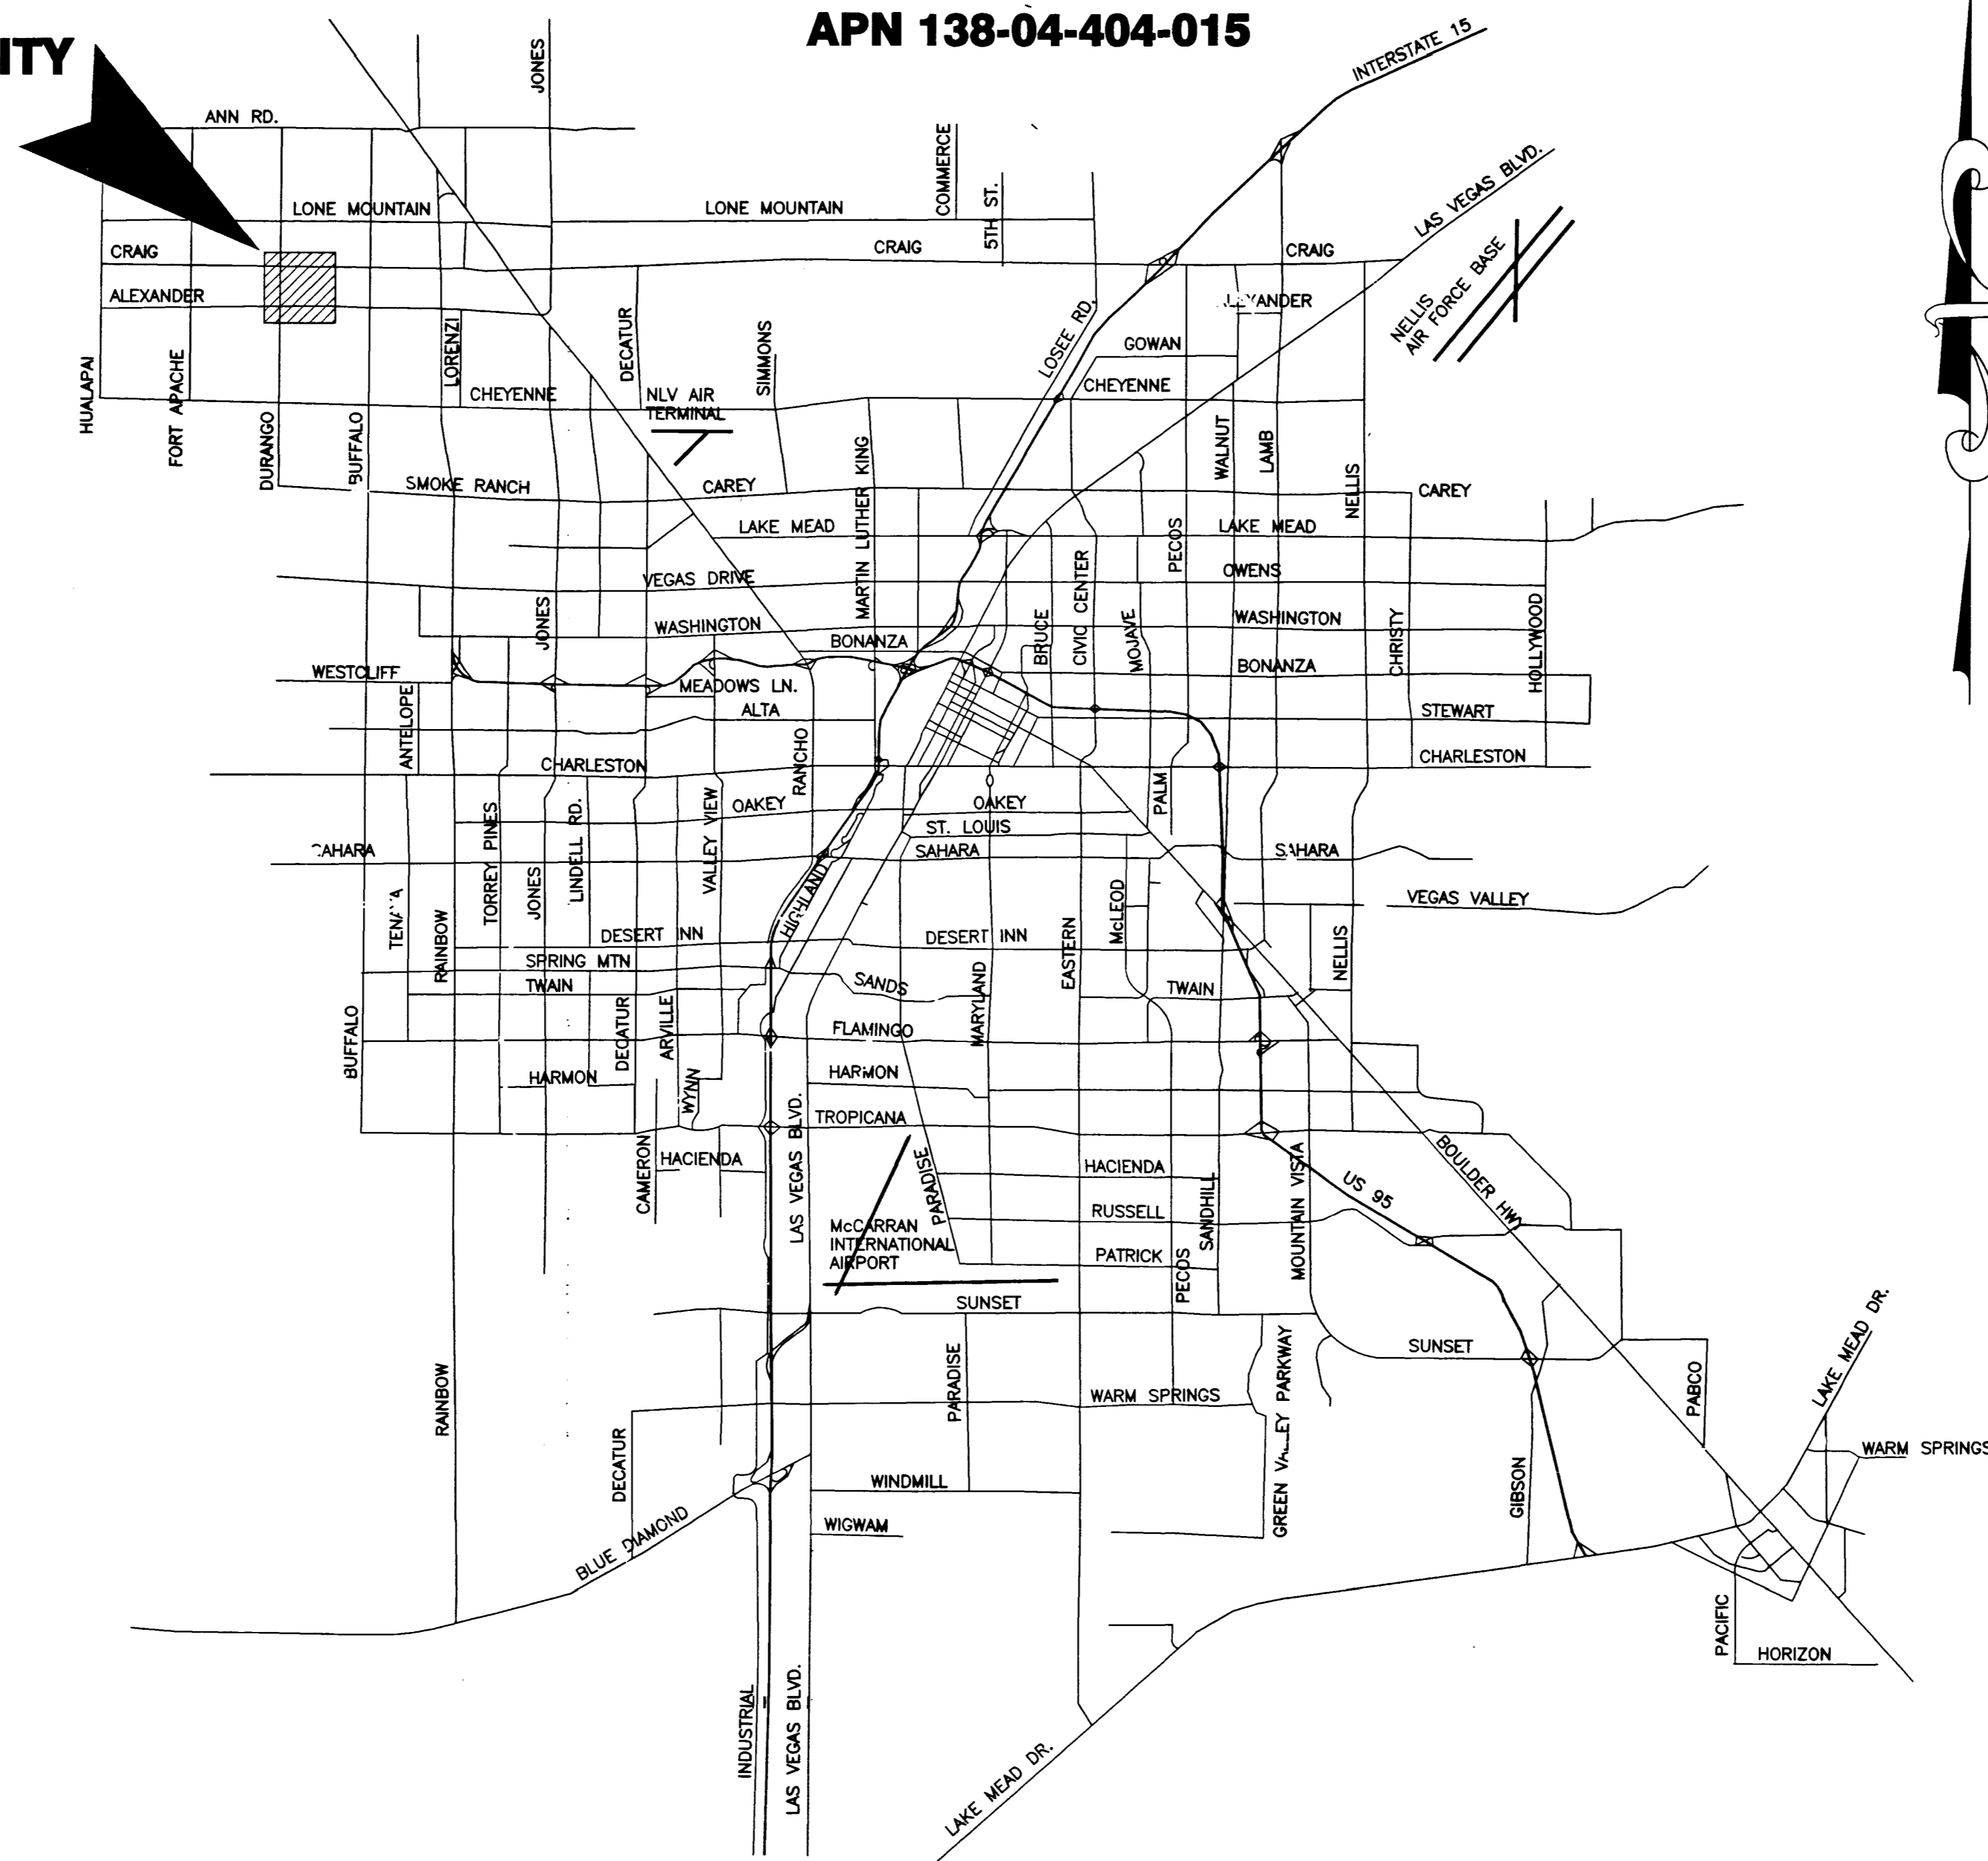

AREA MAP
SCALE: NONE

APPROVALS

Charles Kajkowski, Jr. 9-1-99 DATE
Charles Kajkowski, Jr., PE #4784
CITY PLANNING ENGINEER

APPROVAL OF THESE PLANS BY THE CITY ENGINEER IS LIMITED TO THOSE IMPROVEMENTS CONSTRUCTED IN THE DEDICATED RIGHT-OF-WAY AND/OR DEDICATED EASEMENTS. THIS APPROVAL DOES NOT AUTHORIZE THE CONSTRUCTION ON ANY IMPROVEMENTS THAT DEVIATE FROM ADOPTED STANDARDS AND/OR SPECIFICATIONS EXCEPT THOSE SPECIFICALLY LISTED UNDER DEVIATIONS FROM STANDARD. THE ENGINEER SHALL RESOLVE ANY DEVIATION OTHER THAN THOSE LISTED IN DEVIATIONS FROM STANDARDS IN FAVOR OF THE UNIFORM STANDARD DRAWINGS AND SPECIFICATIONS CLARK COUNTY AREA NEVADA.

Amel M. H. Al-Hadi 8-30-99 DATE
CITY FIRE MARSHAL

LAS VEGAS VALLEY WATER DISTRICT DATE

Juanita Rodriguez 8-30-99 DATE
NEVADA POWER COMPANY
THIS APPROVAL IS ONLY FOR THE PLACEMENT AND CLEARANCE OF STREET LIGHT AND SIGNAL LIGHT INSTALLATIONS

SHEET INDEX

SHEET #	SHEET	DESCRIPTION
1	C1	COVER SHEET / VICINITY MAP
2	C2	GENERAL NOTES & QUANTITY
3	C3	MASTER UTILITY PLAN
4	G1	GRADING PLAN
5	S1	FLORINE AVE. / TOMSIK ST. PLAN & PROFILE
6	S2	PRIVATE DRIVE PLAN & PROFILE
7	TS1	SIGNAGE, STRIPING AND STREETLIGHTING PLAN

CHARLES HOWELL

6433 STARCREST DRIVE
LAS VEGAS, NEVADA 89108
(702) 646-6899

<p>CHARLES HOWELL 6433 STARCREST DRIVE LAS VEGAS, NEVADA 89108 (702) 646-6899</p>	<p>ROBERT J. LANGAN ENGINEERING 107-3330 W. WINDY ROAD - SUITE 91 LAS VEGAS, NEVADA 89102 TEL: (702) 395-0146 FAX: (702) 395-5060</p>
<p>COVER SHEET VICINITY MAP</p>	<p>PARCEL MAP PM 7-99</p>
<p>DRAWN BY: R. J. LANGAN 8/25/99</p>	<p>DESIGNED BY: R. J. LANGAN 8/25/99</p>
<p>CHECKED BY: R. J. LANGAN 8/25/99</p>	<p>PROJECT NO: CH99-001</p>
<p>SCALE: 1" = 30' HOR. 1" = 3' VER.</p>	<p>SHEET 1 OF 7 SHEETS</p>
<p>DRAWING NO. 107-V3131</p>	<p>SEAL PROFESSIONAL ENGINEER ROBERT J. LANGAN No. 6487</p>

