

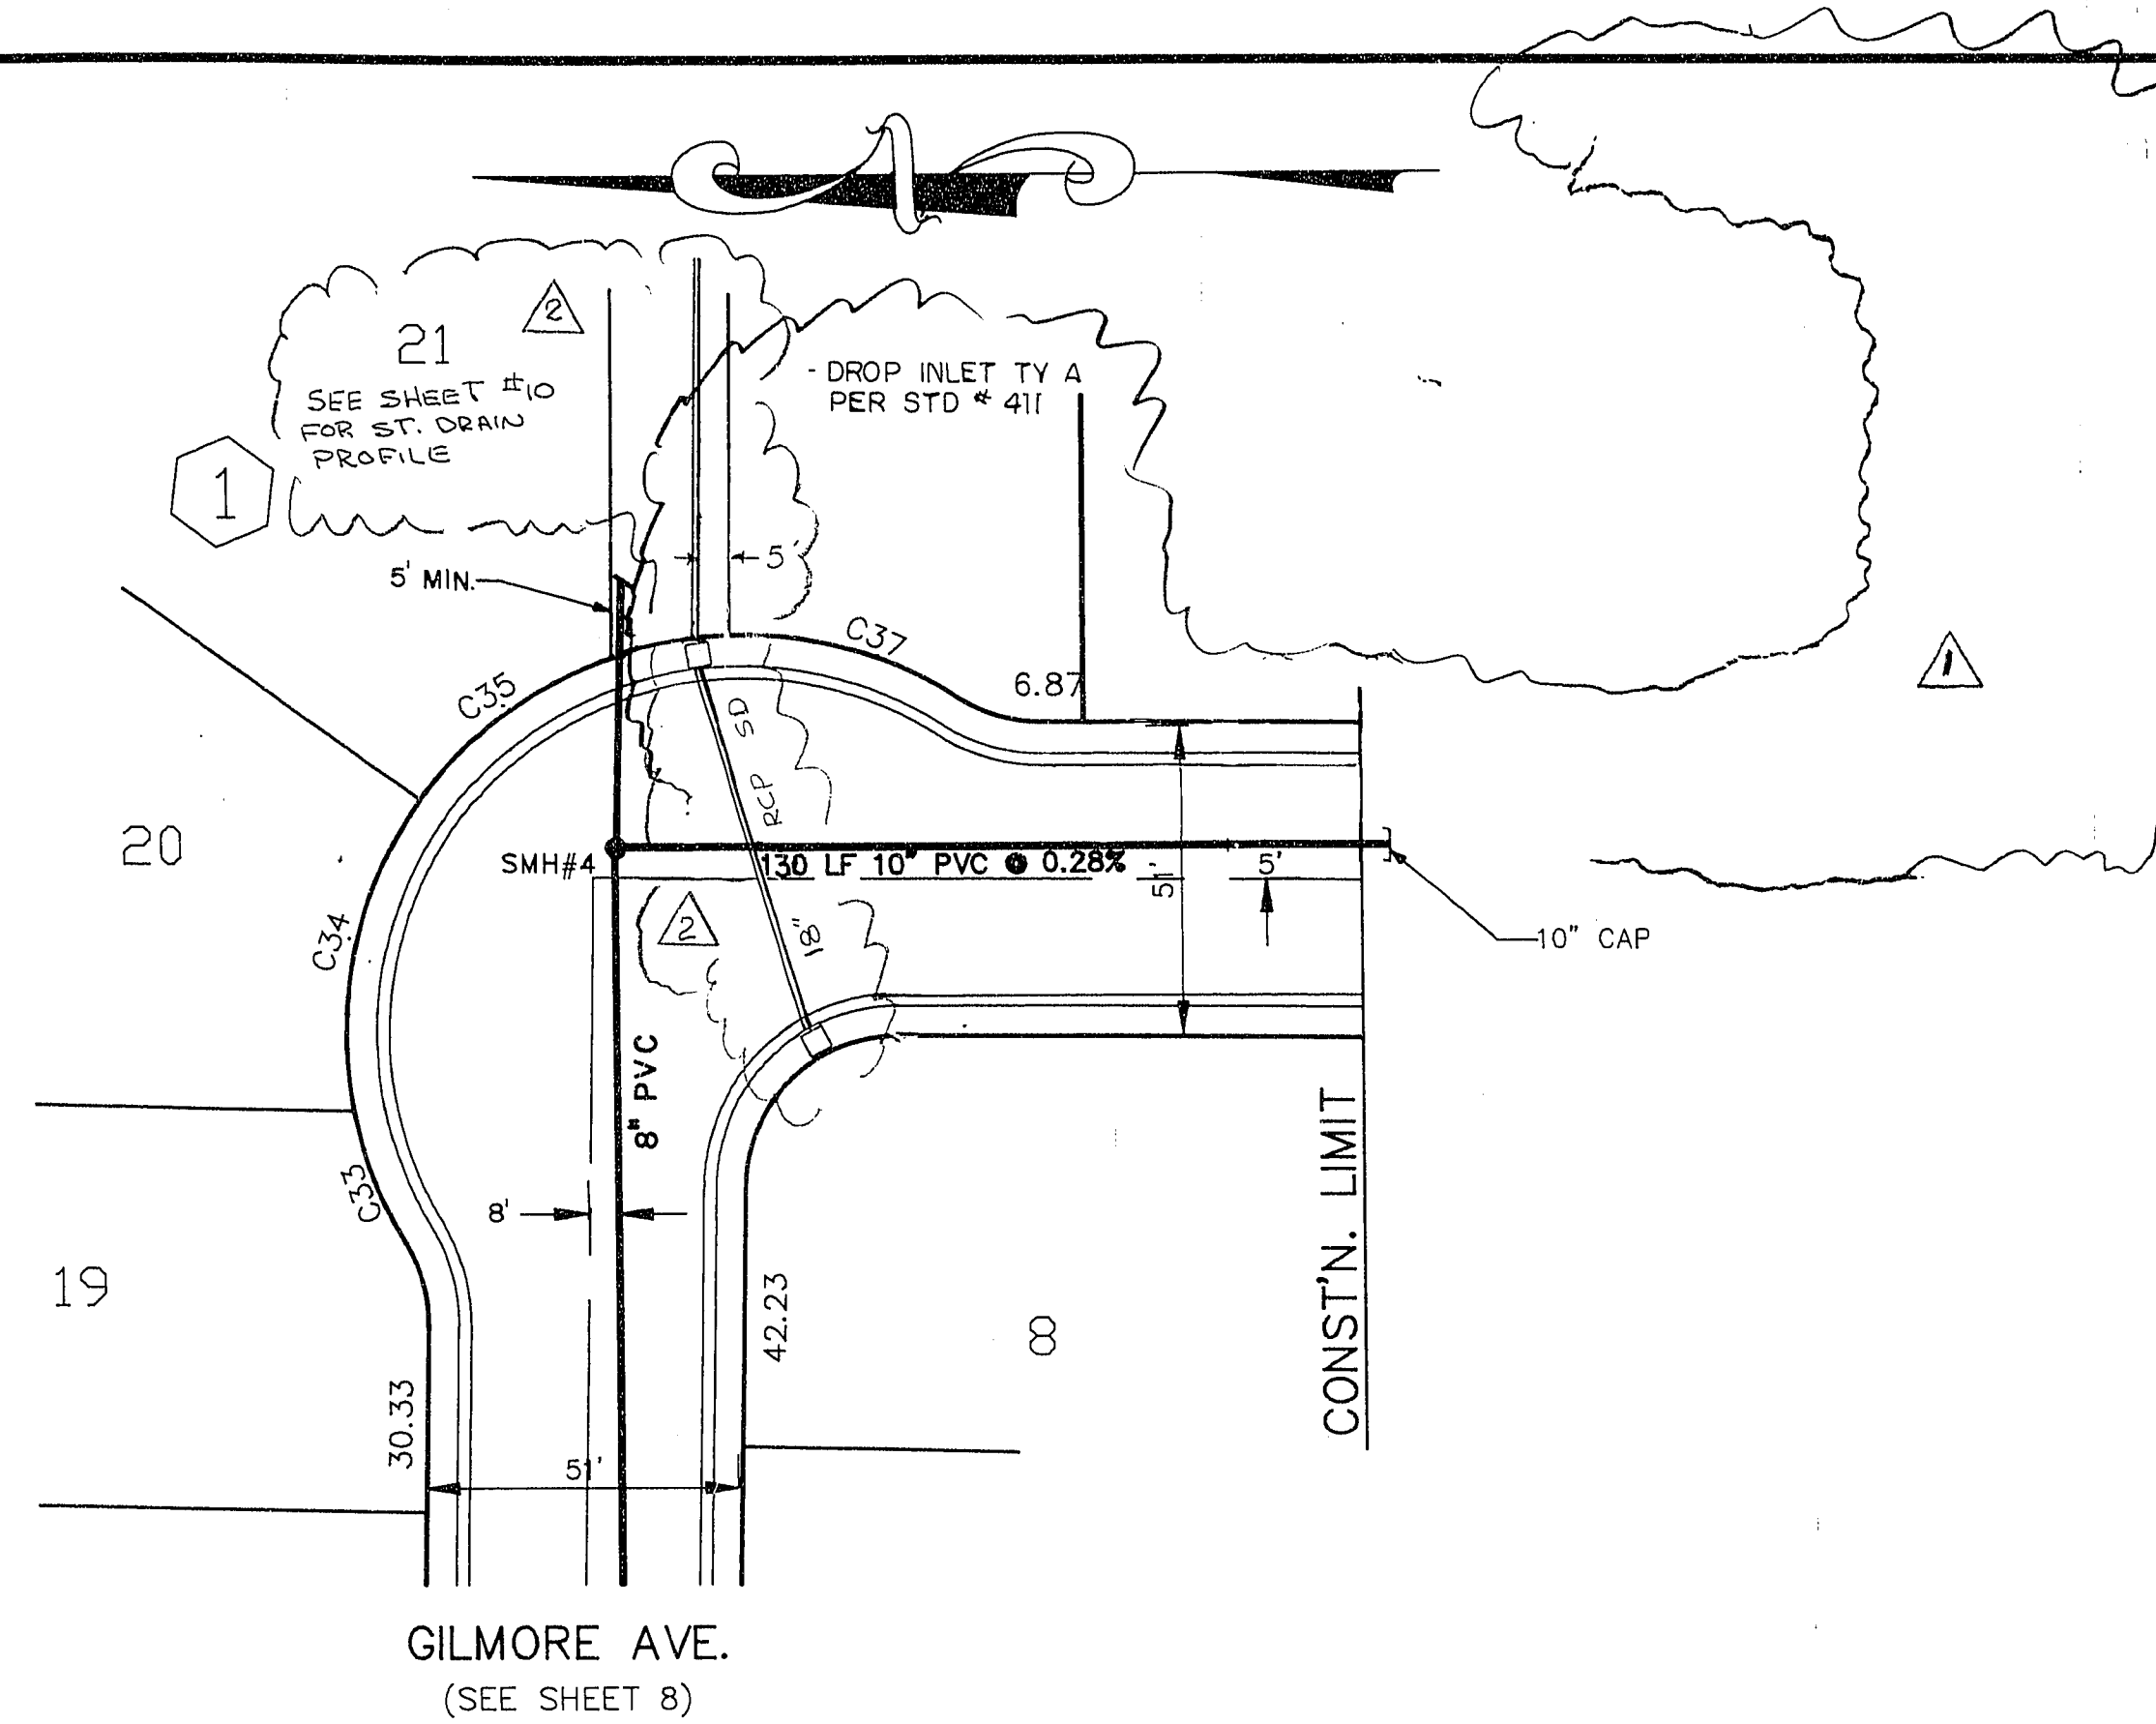


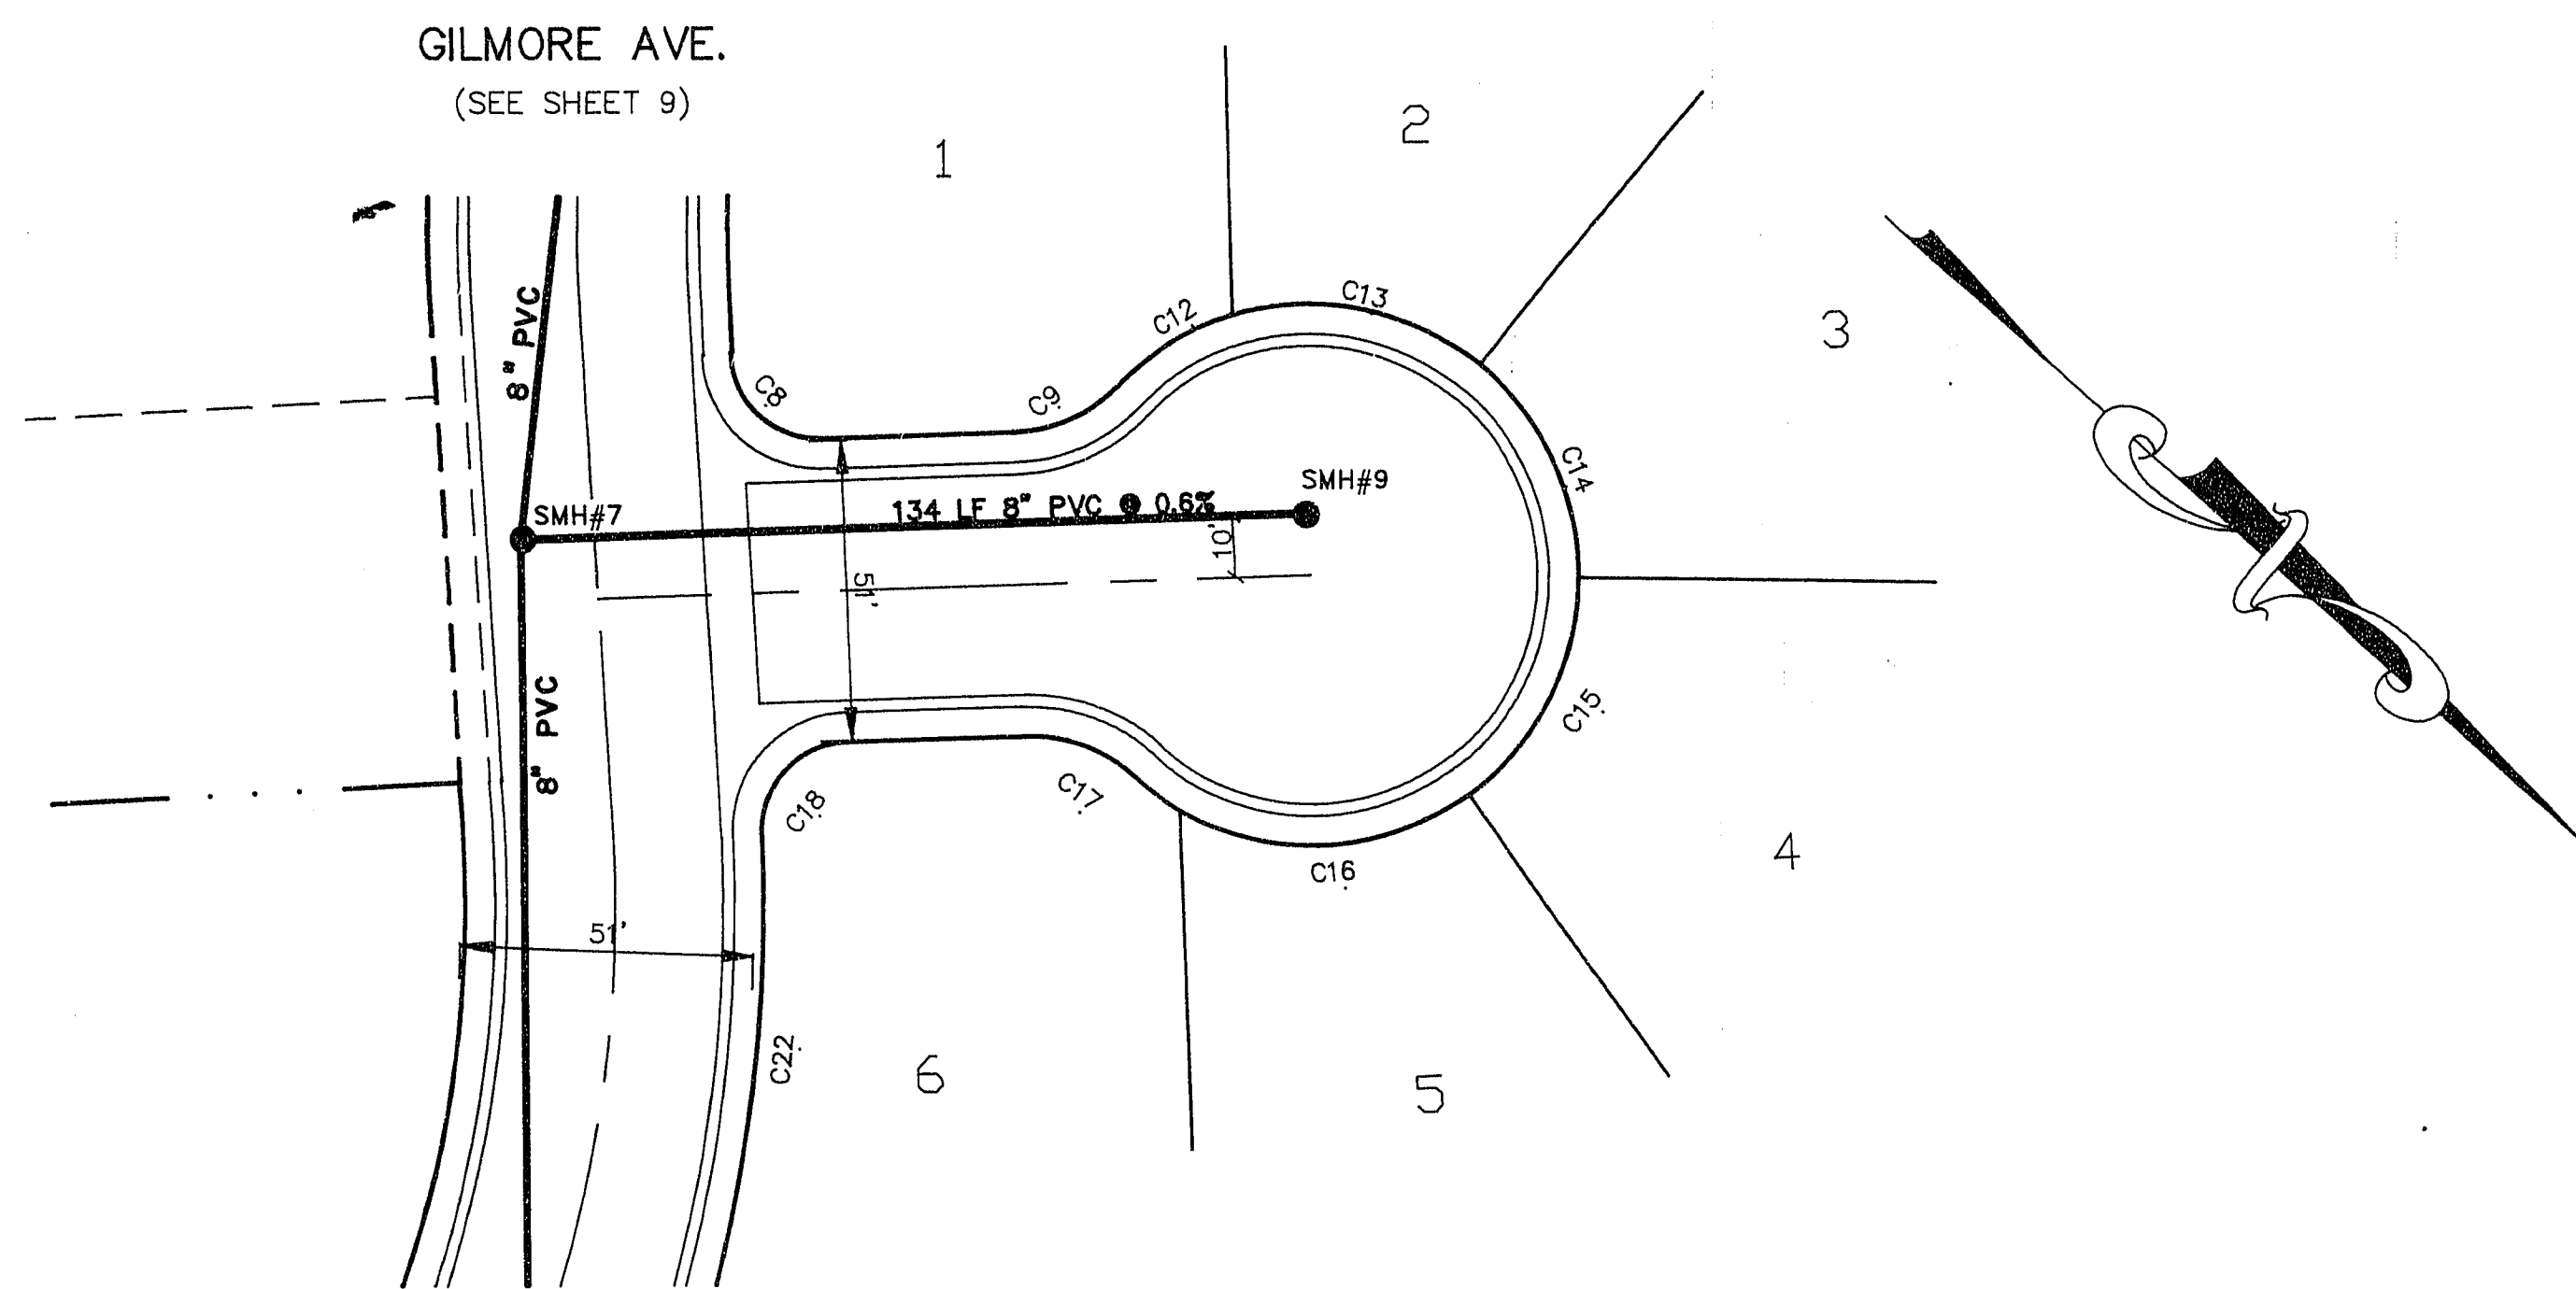


BESSEMER COURT

WHITE PLAINS DR.

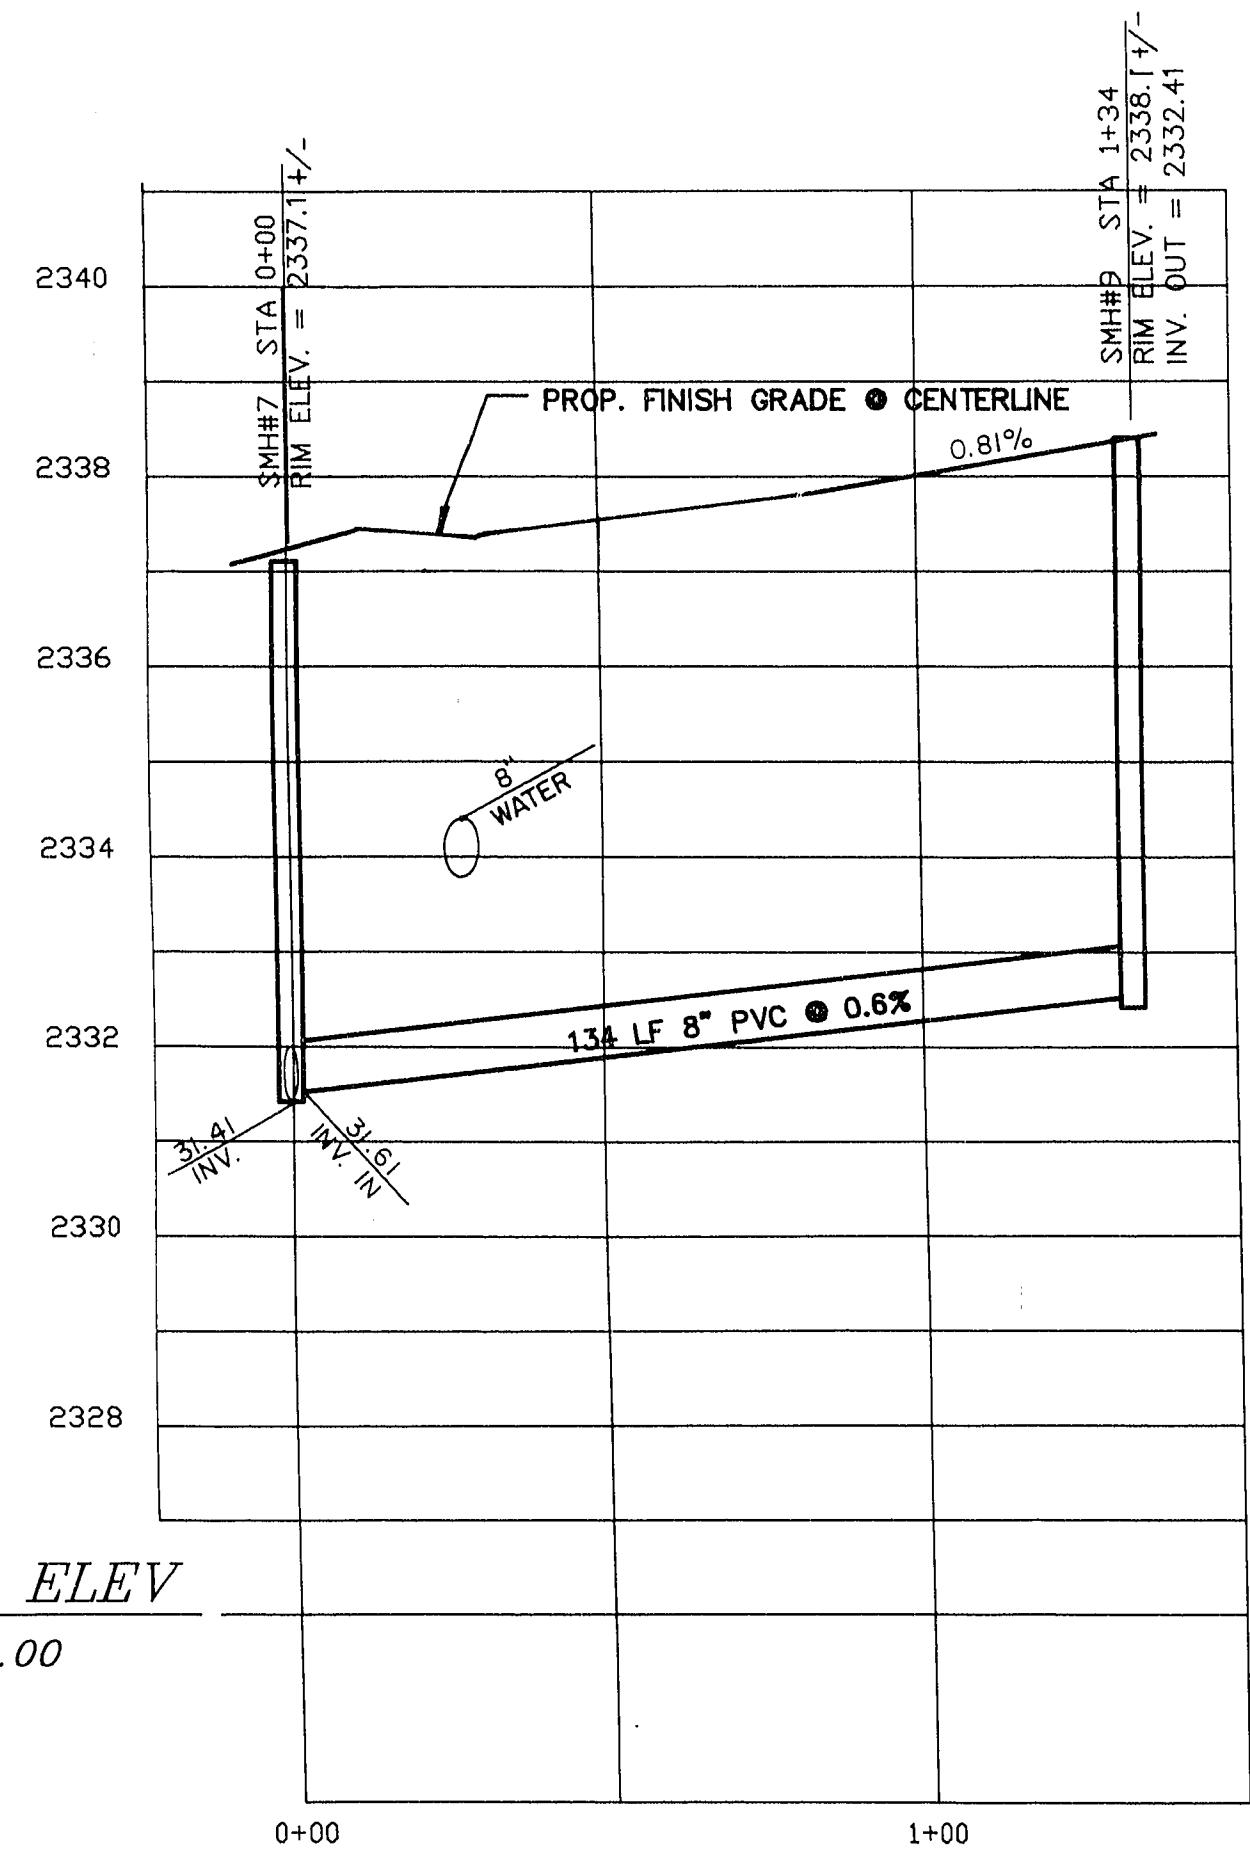

SCALE:
HOR. 1" = 30'
VER. 1" = 2'

DEAN W. RASMUSON
CIVIL
THIS STAMP IS FOR REVISIONS MADE TO THE APPROVED PLANS ON APRIL 15, 1993

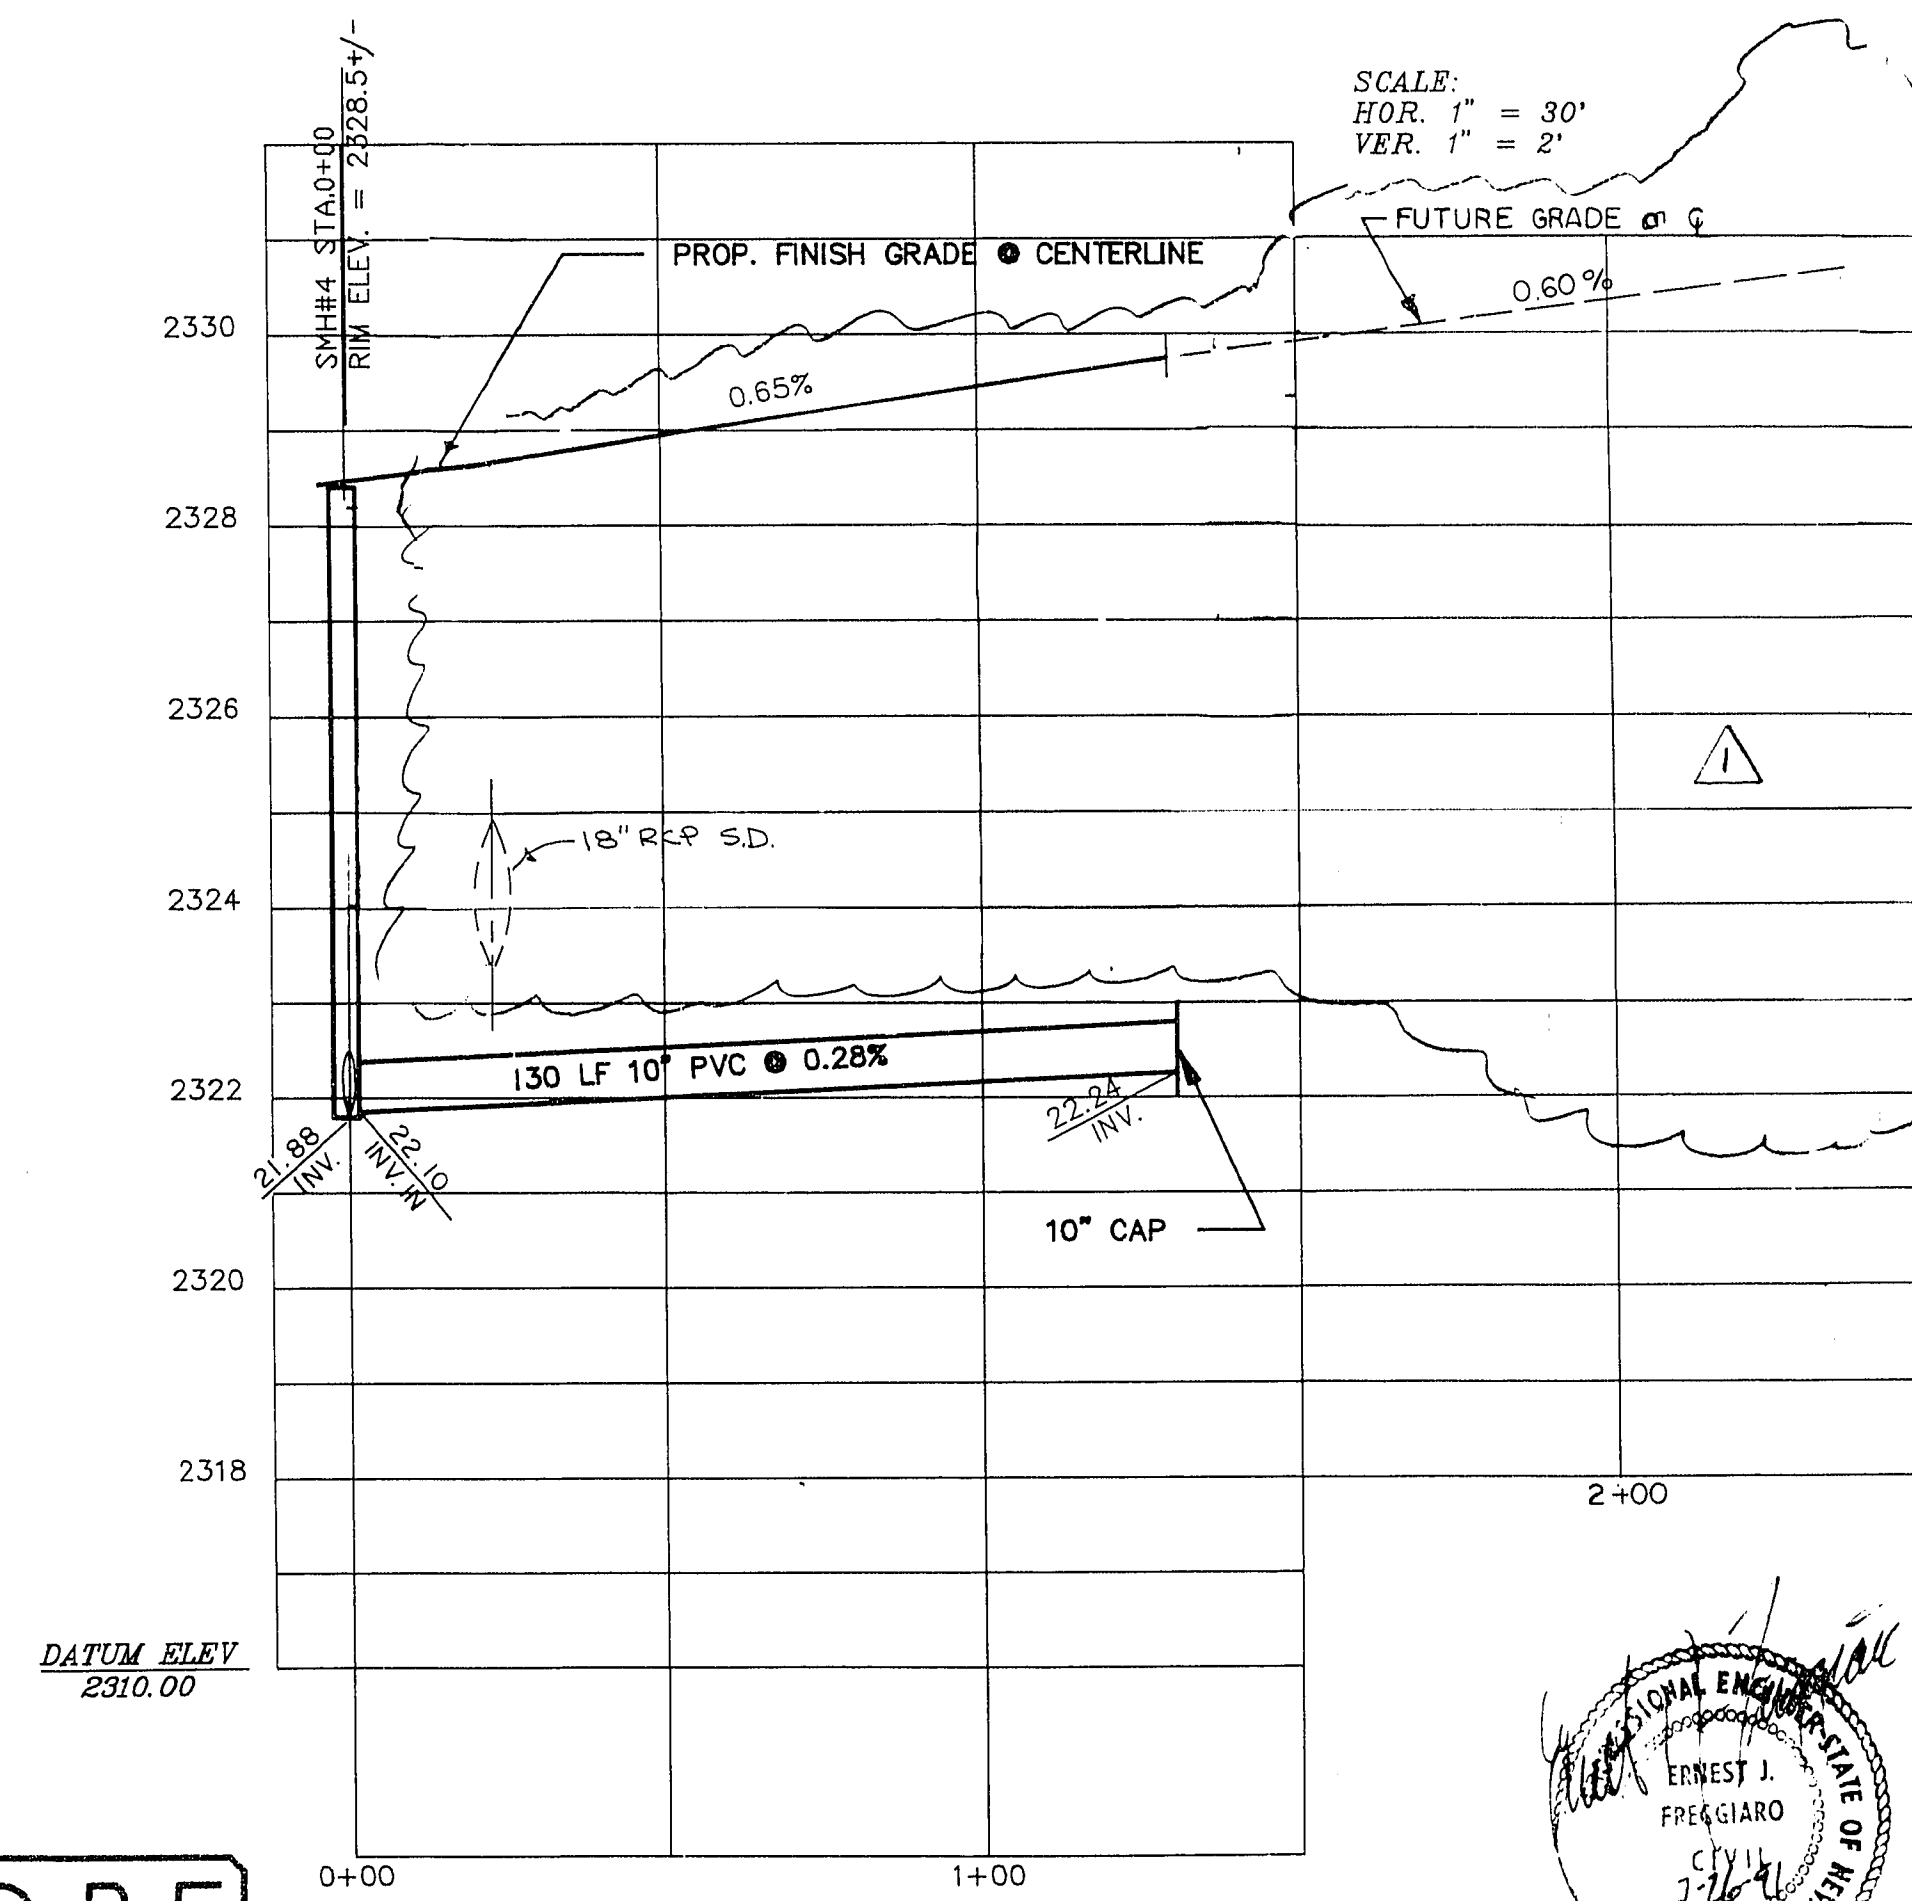

SCALE:
HOR. 1" = 30'
VER. 1" = 2'

DEAN W. RASMUSON
CIVIL
THIS STAMP IS FOR REVISIONS MADE TO THE APPROVED PLANS ON MAY 12, 1993

PENTACORE
Engineering, Inc.
6763 West Charleston Boulevard
Las Vegas, Nevada 89102
(702) 258-0115

ERNEST J. FREAGIARO
CIVIL
1264
1264

CASHDAN		844 E. SAHARA AVENUE LAS VEGAS, NEVADA 89104 (702) 735-7895 FAX (702) 735-6282	
APPROVALS	REVISIONS:	PIONEER ESTATES WEST PHASE - 1 LAS VEGAS, NEVADA SEWER PLAN AND PROFILE BESSEMER CT./WHITE PLAINS DR.	
DATE: JAN. 11, 1991	REVIS PER DRAINAGE UPDATE - DATED 1-15-93	DATE: JAN. 11, 1991	
JOB NO: 90-823	REVIS 5-12-93	JOB NO: 90-823	
DESIGNED: C.O.S.	REVIS 5-12-93	DESIGNED: C.O.S.	
DRAWN: R.Q.A.	REVIS 5-12-93	DRAWN: R.Q.A.	
CHKD BY: E.J.F.	REVIS 5-12-93	CHKD BY: E.J.F.	
SCALE: 1" = 30'	REVIS 5-12-93	SCALE: 1" = 30'	
SHEET:	REVIS 5-12-93	SHEET:	
13 OF 16	REVIS 5-12-93	13 OF 16	

3074-4209-1