
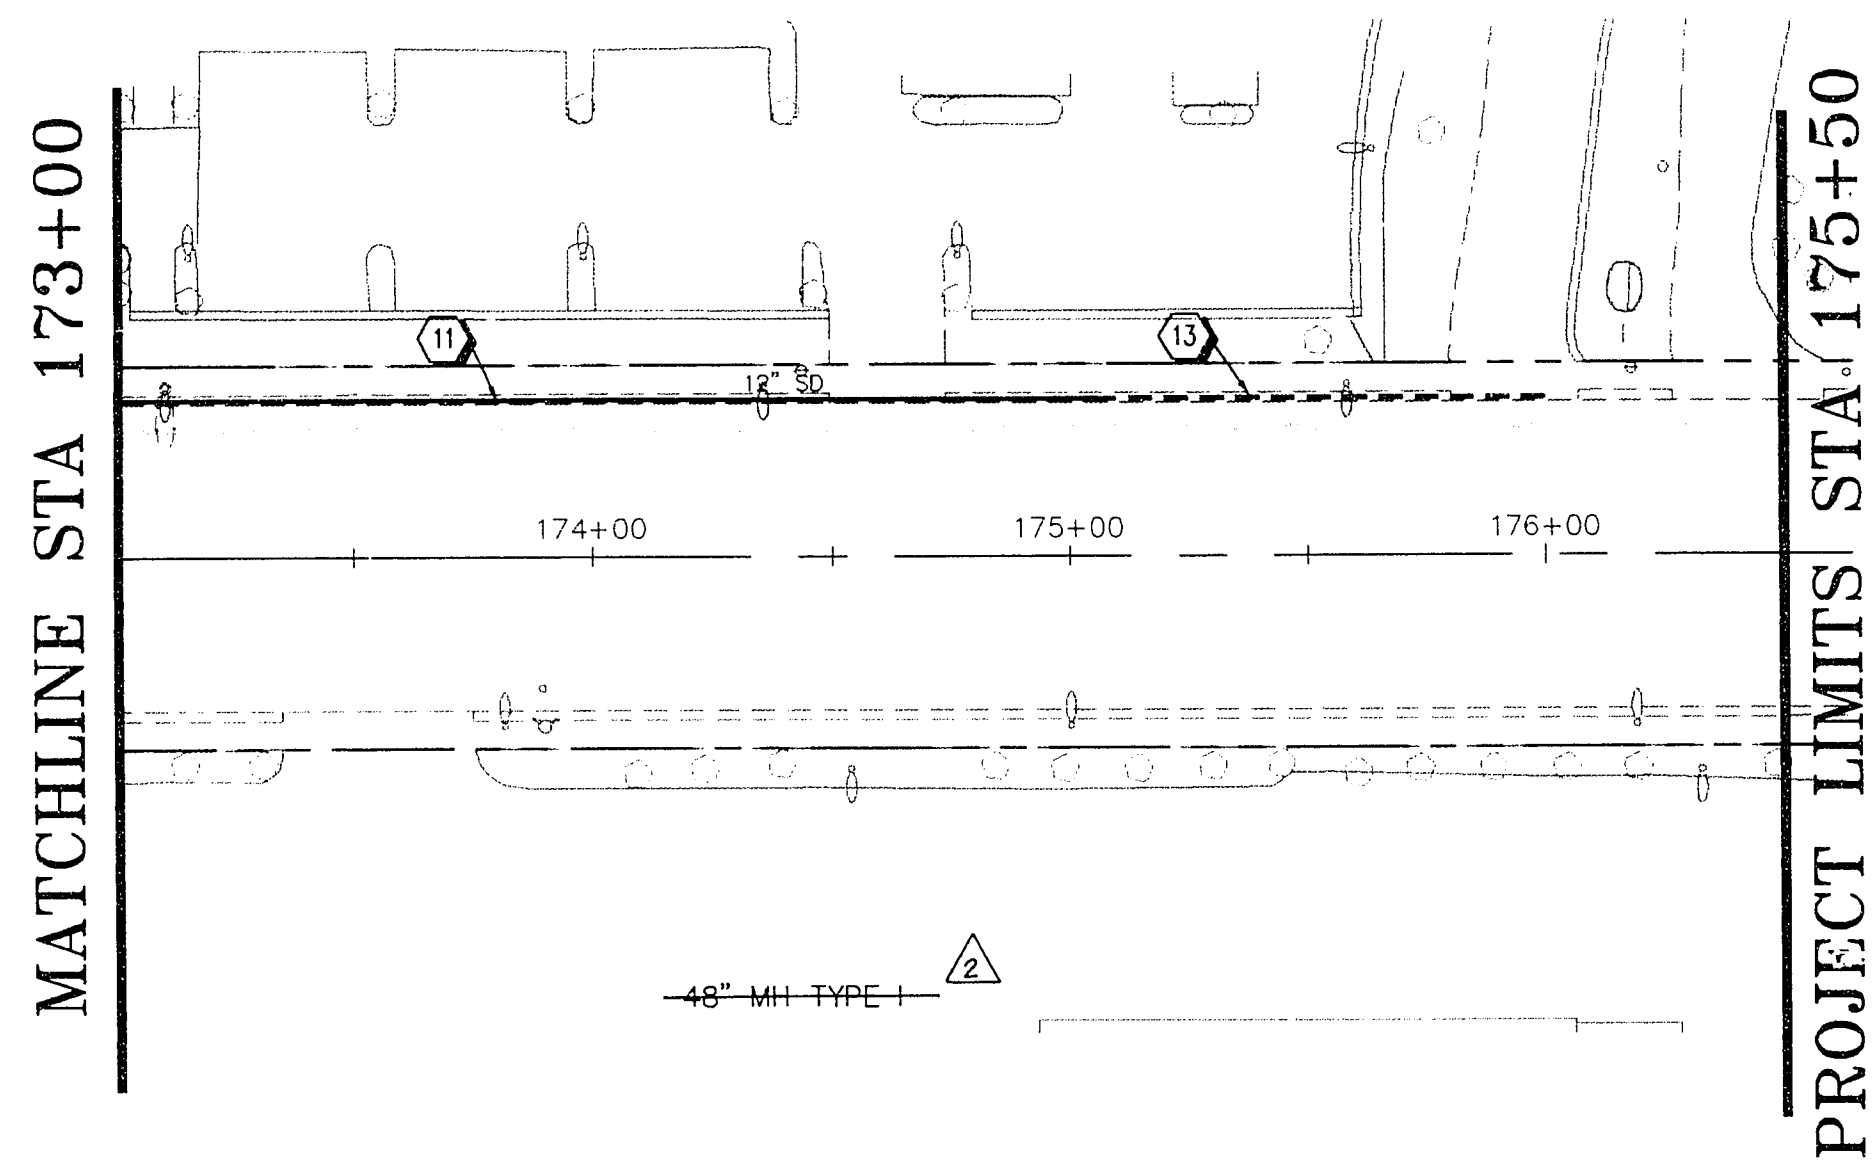


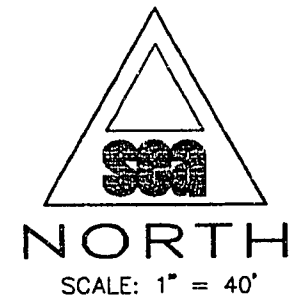

CONSTRUCTION NOTES


- ① SEE SANITARY SEWER (SS) SHEETS FOR WATERLINE RELOCATION.
- ② DEPRESS WATERLINE. SEE DETAIL SHEET D2.
- ③ ENCASE SD WITH 4" MIN. CONCRETE ENCASEMENT TO 10' MIN. EACH SIDE OF WATERLINE. -SEE SHEET D2-
- ④ SEE SANITARY SEWER (SS) SHEETS FOR GAS RELOCATION BY SW. GAS.
- ⑤ PLUG AND ABANDON STORM SEWER.
- ⑥ 2" GAS LINE TO BE RELOCATED BY S/W GAS CORP FROM APPROXIMATELY STA 66+45 TO 76+25, STA 101+00 TO STA 101+60, STA 109+70 TO STA 110+30 AND STA 115+30 TO STA 115+90.
- ⑦ CONNECT TO EXISTING MANHOLE (NO EXISTING STUBOUT) RECONSTRUCT MANHOLE AS REQUIRED.
- ⑧ REMOVE EXISTING INLET.
- ⑨ PLUG AND CAP EXISTING CULVERT.
- ⑩ RELOCATE WATER SERVICE LATERAL:
A. IF POLYETHYLENE, REMOVE AND REPLACE PER SPEC'S
B. IF COPPER, REPAIR AND ADJUST
- ⑪ REMOVE & REPLACE L-TYPE CURB & GUTTER (STD. DWG. NO.216)
- ⑫ CAUTION: THESE ARE ENERGIZED CABLES. A NPC QUALIFIED REPRESENTATIVE MUST BE PRESENT DURING CONSTRUCTION IN OR AROUND THIS EQUIPMENT. CALL 657-4117 FOR AN APPOINTMENT 48 HOURS PRIOR.
- ⑬ OUTLET DRAIN SEE SHEET D2

NOTE:
1. REFERENCE POTHOLE TABLE ON SHEET 2.
2. SEE CORRESPONDING S.S. SHEET

OAKLEY BOULEVARD

1"=40' (HORZ.)
1"=10' (VERT.)

Avoid cutting underground utility lines. If a cable.
Call before you Dig.
1-800-227-2600
UNDERGROUND SERVICE ALERT (USA)

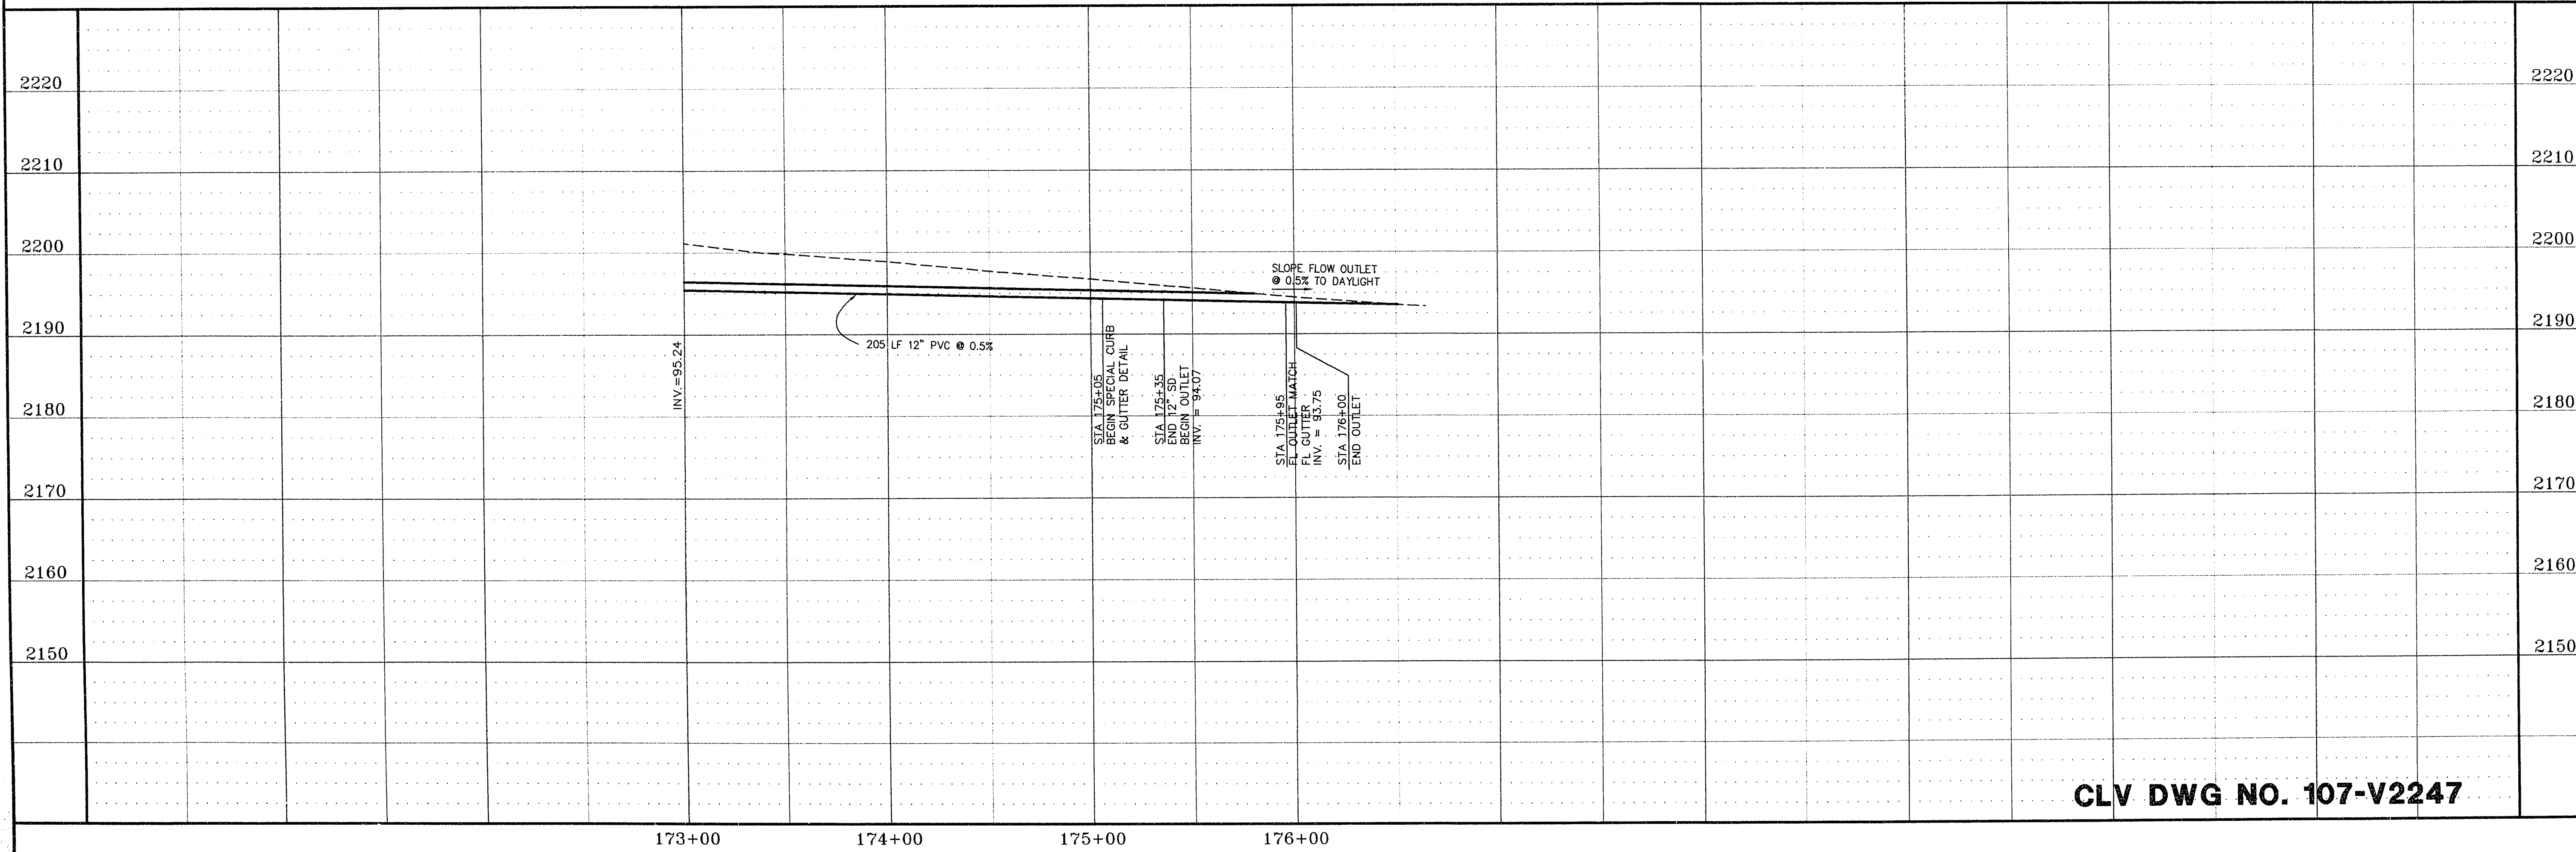

CLV DWG NO. 107-V2247


STORM DRAIN PLAN AND PROFILE
FROM STA. 173+00 TO STA. 175+50
OAKLEY BOULEVARD
RAINBOW BOULEVARD TO DECATUR BOULEVARD

JOB NO.: 2-241-072
ACAD FILE: OAKESD12
DESIGNED: RRS
DRAWN: TL
CHECKED: DP
DATE: JUNE 1995

SD12

58 OF 62 SHEETS

REVISIONS		
NO.	DESCRIPTION/DATE	BY
1	REVISED BY CLV II-01-12	

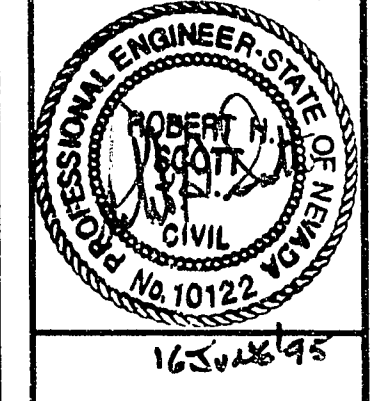

1100 GIER DRIVE
LAS VEGAS, NEVADA 89119
PHONE (702) 361-9050
FAX (702) 361-0659
SD12
CONSULTING ENGINEERS

NEVADA

CLARK COUNTY

CITY OF LAS VEGAS