


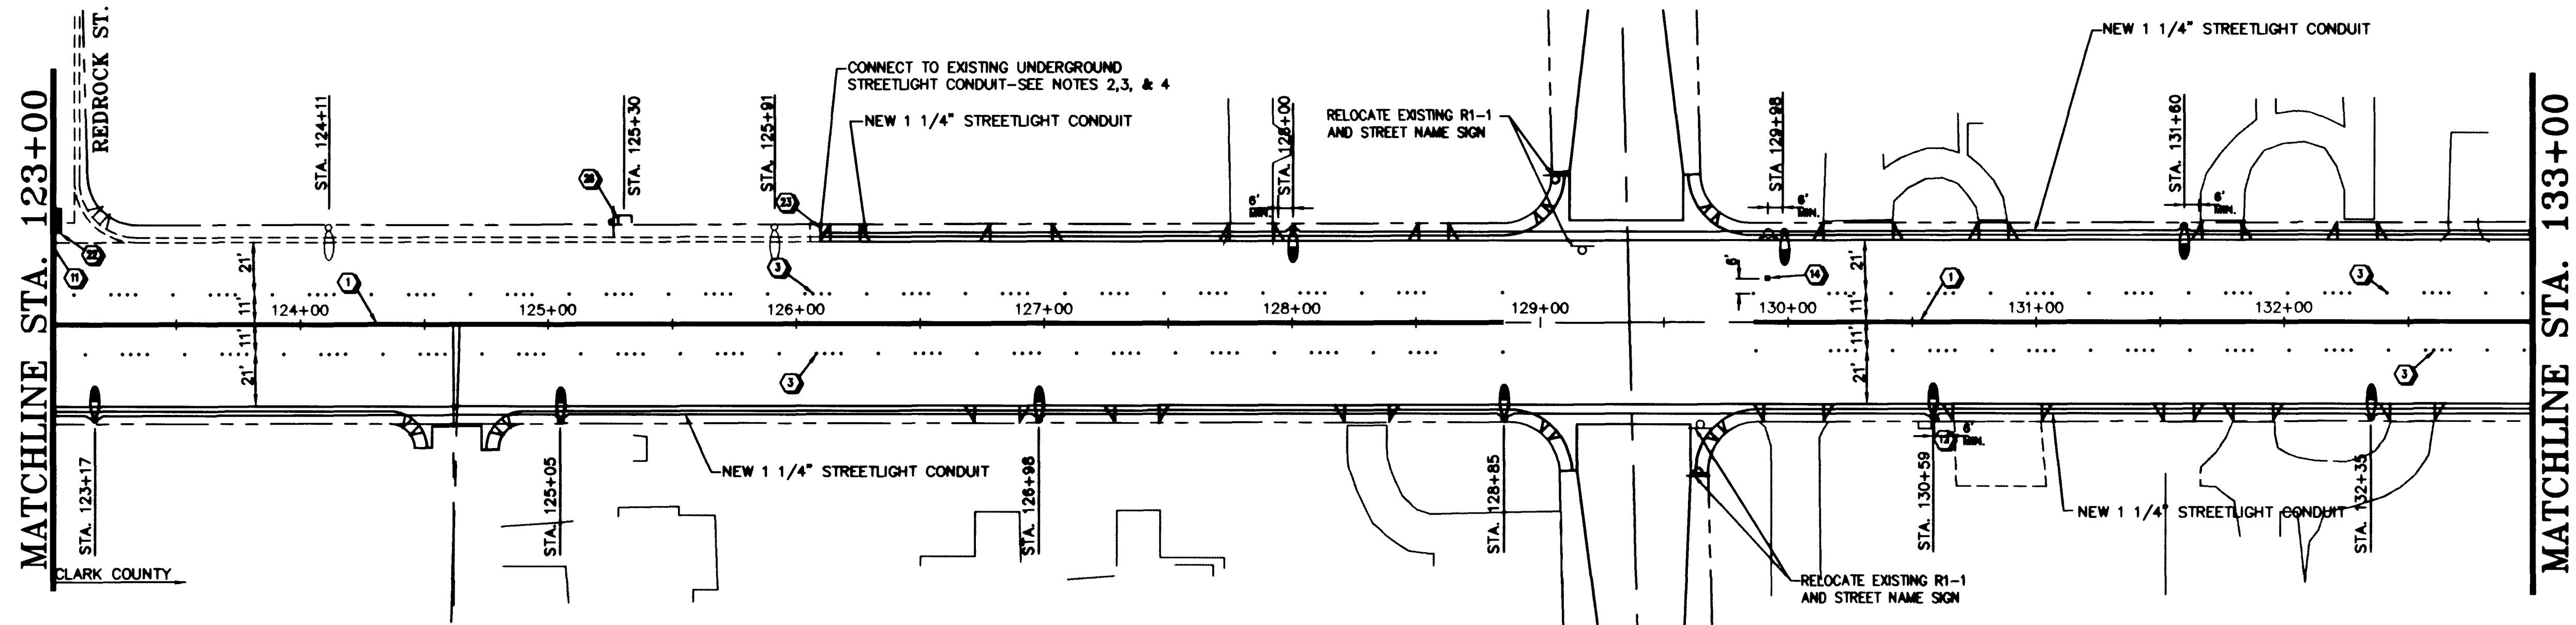


STREET LIGHTING NOTES

1. ALL STREET LIGHTS SHALL BE II GAGE SHAFTS WITH 200W HPS LUMINAIRE. ARM LENGTH = 8 FEET. SEE CLARK COUNTY AREA UNIFORM STD. DWGS. NO. 309 AND 318.
2. WHERE IT IS NECESSARY TO CONNECT STREET LIGHTS TO AN EXISTING UNDERGROUND CIRCUIT, THE CONTRACTOR SHALL VERIFY THE EXISTENCE OF A CONDUIT STUB OUT FROM THE POLE FOUNDATION OR LOCATION AT WHICH THE CONNECTION IS TO BE MADE. SHOULD SUCH STUB-OUTS BE MISSING, THE EXISTING FOUNDATION SHALL BE MODIFIED PER CLARK COUNTY AREA UNIFORM STD. DWG. NO. 320.
3. WHERE NEW STREET LIGHTS ARE TO BE ADDED TO AN EXISTING CIRCUIT, THE CONTRACTOR SHALL PROVIDE THE COMPLETE STREET LIGHT FOUNDATION & POLE, CONDUIT AND WIRES. TERMINATION WILL BE MADE BY CITY FORCES.
4. ALL NEW STREETLIGHT FOUNDATION CENTERLINES SHALL BE 4'-0" FROM THE TOP BACK OF CURB.
5. EXISTING STREETLIGHT CRASH CAPS ARE TO BE ADJUSTED (REMOVED & REPLACED) AS REQUIRED, TO MATCH NEW BACK OF SIDEWALK GRADES.
6. ALL LEGENDS AND SYMBOLS SHALL BE WHITE.
7. STREET LIGHT SERIES CIRCUIT WILL BE DISCONNECTED FOR THE CONTRACTOR. CONTACT CITY OF LAS VEGAS ELECTRICAL SERVICES AT 229-6331.
8. STREET LIGHT ELECTRICAL DISCONNECTIONS AND RECONNECTIONS SHALL BE DONE BY CITY FORCES AND COORDINATED WITH CLV ELECTRICAL SERVICES.

OAKEY BOULEVARD


CONSTRUCTION NOTES

1. STANDARD TYPE 1 CENTERLINE (YELLOW) PER STD DWG 244
2. STANDARD TYPE 2 CENTERLINE (YELLOW) PER STD DWG 244
3. STANDARD TYPE 5 LANE LINE PER STD DWG 244A
4. NOT USED
5. CONTINUOUS 12" WHITE LINE COLD FORMED POLYMER
6. EXISTING R1-1 WITH STREET NAME SIGNS TO REMAIN
7. EXISTING R1-1 TO REMAIN
8. NEW STANDARD STREET NAME SIGN SEE CLARK COUNTY AREA UNIFORM STD. DWGS 249, 250 & 251
9. NEW R1-1
10. CONTINUOUS 24" WHITE STOP BAR, 4' BEHIND CROSSWALK COLD FORMED POLYMER
11. 10' CROSSWALKS LOCATED PER CLARK COUNTY AREA UNIFORM STD. DWGS 254
12. EXISTING CAT TRANSIT SYSTEM SIGN TO REMAIN
13. EXISTING R8-3A TO REMAIN
14. NEW 2-WAY BLUE REFLECTIVE MARKER, CENTERED IN DRIVING LANE
15. REPLACE R2-1(25) WITH NEW R2-1(35)
16. NEW R8-3A WITH R7-IAP PLACARD-BANDED TO STREETLIGHT POLE
17. NEW R7-IAP PLACARD-BANDED TO STREET LIGHT POLE BELOW EXISTING R8-3A
18. INSTALL NEW R1-3 SUPPLEMENTARY PLATE
19. 133 FT OF LANE MARKING SEE CLARK COUNTY AREA STD DWG 248
20. TACK ON ISLAND CURB PER CLV MODIFIED STD DWG 220-A LENGTH = 200' WIDTH = 1' FILL GAP WITH 6" CONCRETE
21. NEW R6-1R WITH POST AND FOUNDATION
22. CONTINUOUS 24" WHITE COLD FORMED POLYMER AT LANE LINES AND LANE CENTERS
23. REMOVE EXISTING SIGN, POST, AND FOUNDATION
24. NEW S2-1 WITH POST AND FOUNDATION
25. REPLACE R1-1 WITH NEW S2-1
26. NEW C.A.T. SIGN
27. INSTALL NEW PHOTOELECTRIC CONTROL PER STD. DWG. 327

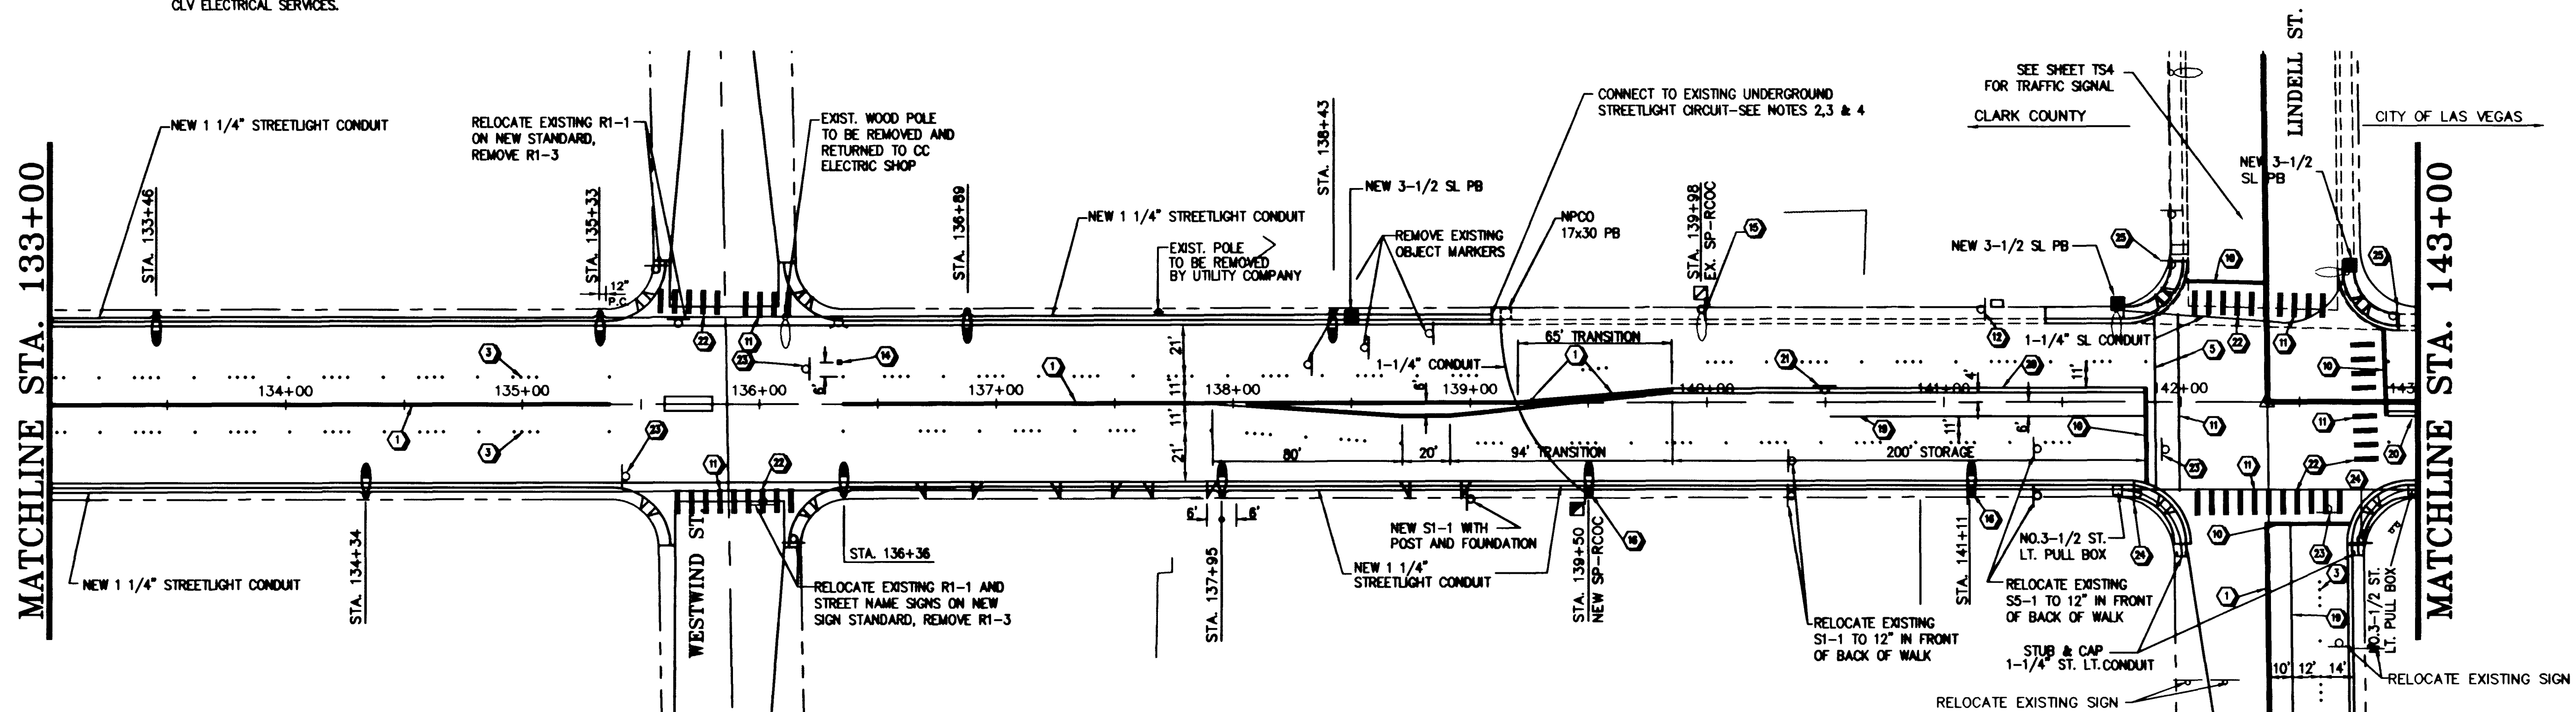

OAKEY BOULEVARD

CLV DWG NO. 107-V2247

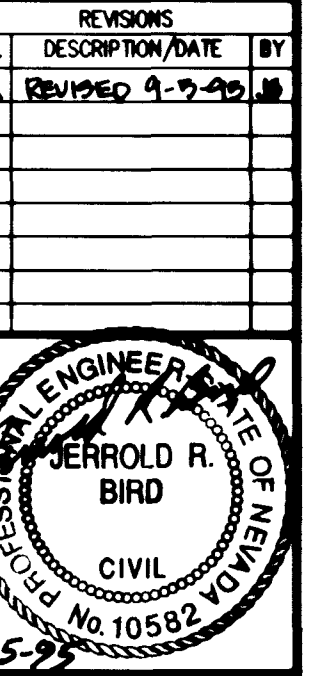

100 GREER DRIVE
LAS VEGAS, NEVADA 89119
PHONE (702) 361-9050
FAX (702) 361-0669
Incorporated
S&B
CONSULTING ENGINEERS

NEVADA

STRIPING AND STREET LIGHTING PLAN
FROM STA. 123+00 TO STA. 143+00
OAKEY BOULEVARD
RAINBOW BLVD. TO DECATUR BLVD.

CLARK COUNTY

 
CITY OF LAS VEGAS

JOB NO.: 2-241-073
ACAD FILE: OAKELS04
DESIGNED: J.B.
DRAWN: J.H.
CHECKED: D.P.
DATE: JUNE 1995

T4

28 OF 62 SHEETS

Call
before you
Dig.
1-800-227-2900




- NOTES:**
1. ALL LIGHTING SHALL BE IN ACCORDANCE WITH THE LATEST EDITION OF THE ILLUMINANCE ENGINEERING SOCIETY (IES) HANDBOOK.
 2. ALL LIGHTING SHALL BE IN ACCORDANCE WITH THE LATEST EDITION OF THE ILLUMINANCE ENGINEERING SOCIETY (IES) HANDBOOK.
 3. ALL LIGHTING SHALL BE IN ACCORDANCE WITH THE LATEST EDITION OF THE ILLUMINANCE ENGINEERING SOCIETY (IES) HANDBOOK.
 4. ALL LIGHTING SHALL BE IN ACCORDANCE WITH THE LATEST EDITION OF THE ILLUMINANCE ENGINEERING SOCIETY (IES) HANDBOOK.
 5. ALL LIGHTING SHALL BE IN ACCORDANCE WITH THE LATEST EDITION OF THE ILLUMINANCE ENGINEERING SOCIETY (IES) HANDBOOK.
 6. ALL LIGHTING SHALL BE IN ACCORDANCE WITH THE LATEST EDITION OF THE ILLUMINANCE ENGINEERING SOCIETY (IES) HANDBOOK.
 7. ALL LIGHTING SHALL BE IN ACCORDANCE WITH THE LATEST EDITION OF THE ILLUMINANCE ENGINEERING SOCIETY (IES) HANDBOOK.
 8. ALL LIGHTING SHALL BE IN ACCORDANCE WITH THE LATEST EDITION OF THE ILLUMINANCE ENGINEERING SOCIETY (IES) HANDBOOK.
 9. ALL LIGHTING SHALL BE IN ACCORDANCE WITH THE LATEST EDITION OF THE ILLUMINANCE ENGINEERING SOCIETY (IES) HANDBOOK.
 10. ALL LIGHTING SHALL BE IN ACCORDANCE WITH THE LATEST EDITION OF THE ILLUMINANCE ENGINEERING SOCIETY (IES) HANDBOOK.

OAKLEY BOULEVARD

CONTINUATION NOTES

- | | |
|--|---|
| <p>1. ALL LIGHTING SHALL BE IN ACCORDANCE WITH THE LATEST EDITION OF THE ILLUMINANCE ENGINEERING SOCIETY (IES) HANDBOOK.</p> <p>2. ALL LIGHTING SHALL BE IN ACCORDANCE WITH THE LATEST EDITION OF THE ILLUMINANCE ENGINEERING SOCIETY (IES) HANDBOOK.</p> <p>3. ALL LIGHTING SHALL BE IN ACCORDANCE WITH THE LATEST EDITION OF THE ILLUMINANCE ENGINEERING SOCIETY (IES) HANDBOOK.</p> <p>4. ALL LIGHTING SHALL BE IN ACCORDANCE WITH THE LATEST EDITION OF THE ILLUMINANCE ENGINEERING SOCIETY (IES) HANDBOOK.</p> <p>5. ALL LIGHTING SHALL BE IN ACCORDANCE WITH THE LATEST EDITION OF THE ILLUMINANCE ENGINEERING SOCIETY (IES) HANDBOOK.</p> <p>6. ALL LIGHTING SHALL BE IN ACCORDANCE WITH THE LATEST EDITION OF THE ILLUMINANCE ENGINEERING SOCIETY (IES) HANDBOOK.</p> <p>7. ALL LIGHTING SHALL BE IN ACCORDANCE WITH THE LATEST EDITION OF THE ILLUMINANCE ENGINEERING SOCIETY (IES) HANDBOOK.</p> <p>8. ALL LIGHTING SHALL BE IN ACCORDANCE WITH THE LATEST EDITION OF THE ILLUMINANCE ENGINEERING SOCIETY (IES) HANDBOOK.</p> <p>9. ALL LIGHTING SHALL BE IN ACCORDANCE WITH THE LATEST EDITION OF THE ILLUMINANCE ENGINEERING SOCIETY (IES) HANDBOOK.</p> <p>10. ALL LIGHTING SHALL BE IN ACCORDANCE WITH THE LATEST EDITION OF THE ILLUMINANCE ENGINEERING SOCIETY (IES) HANDBOOK.</p> | <p>11. ALL LIGHTING SHALL BE IN ACCORDANCE WITH THE LATEST EDITION OF THE ILLUMINANCE ENGINEERING SOCIETY (IES) HANDBOOK.</p> <p>12. ALL LIGHTING SHALL BE IN ACCORDANCE WITH THE LATEST EDITION OF THE ILLUMINANCE ENGINEERING SOCIETY (IES) HANDBOOK.</p> <p>13. ALL LIGHTING SHALL BE IN ACCORDANCE WITH THE LATEST EDITION OF THE ILLUMINANCE ENGINEERING SOCIETY (IES) HANDBOOK.</p> <p>14. ALL LIGHTING SHALL BE IN ACCORDANCE WITH THE LATEST EDITION OF THE ILLUMINANCE ENGINEERING SOCIETY (IES) HANDBOOK.</p> <p>15. ALL LIGHTING SHALL BE IN ACCORDANCE WITH THE LATEST EDITION OF THE ILLUMINANCE ENGINEERING SOCIETY (IES) HANDBOOK.</p> <p>16. ALL LIGHTING SHALL BE IN ACCORDANCE WITH THE LATEST EDITION OF THE ILLUMINANCE ENGINEERING SOCIETY (IES) HANDBOOK.</p> <p>17. ALL LIGHTING SHALL BE IN ACCORDANCE WITH THE LATEST EDITION OF THE ILLUMINANCE ENGINEERING SOCIETY (IES) HANDBOOK.</p> <p>18. ALL LIGHTING SHALL BE IN ACCORDANCE WITH THE LATEST EDITION OF THE ILLUMINANCE ENGINEERING SOCIETY (IES) HANDBOOK.</p> <p>19. ALL LIGHTING SHALL BE IN ACCORDANCE WITH THE LATEST EDITION OF THE ILLUMINANCE ENGINEERING SOCIETY (IES) HANDBOOK.</p> <p>20. ALL LIGHTING SHALL BE IN ACCORDANCE WITH THE LATEST EDITION OF THE ILLUMINANCE ENGINEERING SOCIETY (IES) HANDBOOK.</p> |
|--|---|

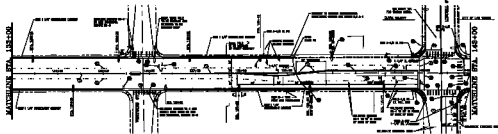

OAKLEY BOULEVARD

CLV DWG NO. 107-V8247



THE CITY OF LOS ANGELES
DEPARTMENT OF TRANSPORTATION
STREETWORKS AND STREET LIGHTING DIVISION

STREETWORKS AND STREET LIGHTING PLAN

FROM STA. 135+00 TO STA. 145+00
OAKLEY BOULEVARD, LOS ANGELES, CALIF.

T4