


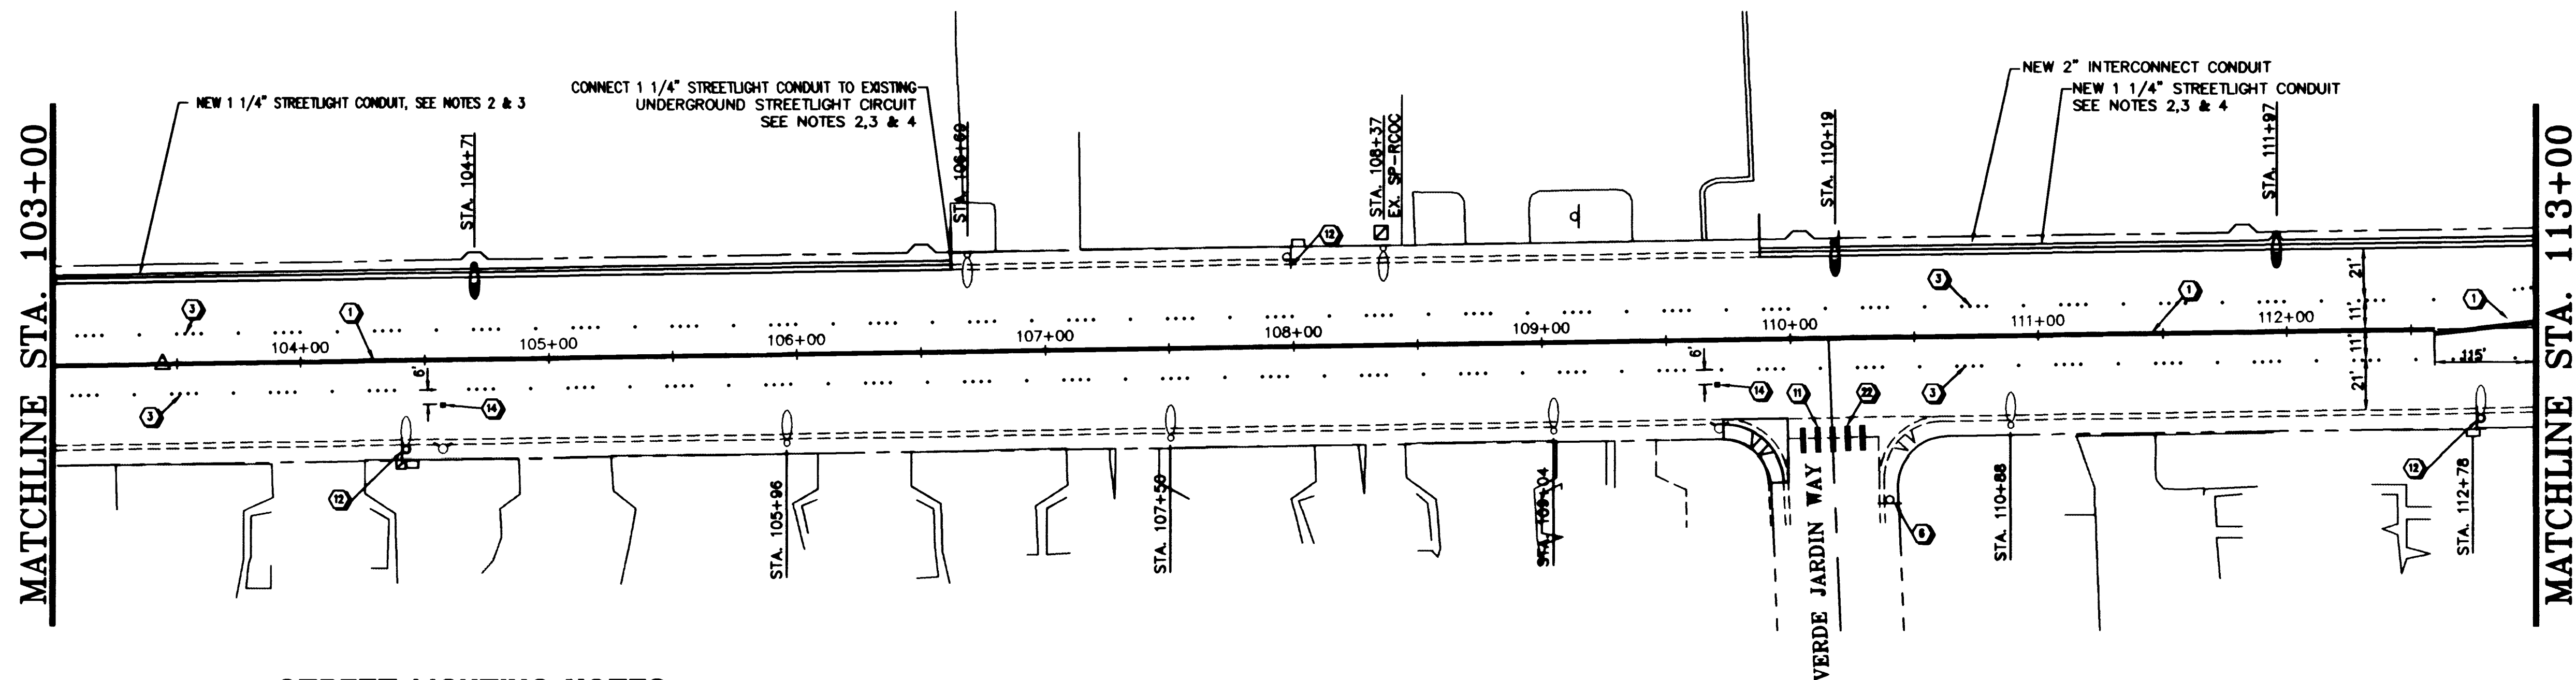


STREET LIGHTING NOTES

1. ALL STREET LIGHTS SHALL BE II GAGE SHAFTS WITH 200W HPS LUMINAIRE. ARM LENGTH = 8 FEET. SEE CLARK COUNTY AREA UNIFORM STD. DWGS. NO. 309 AND 318.
2. WHERE IT IS NECESSARY TO CONNECT STREET LIGHTS TO AN EXISTING UNDERGROUND CIRCUIT, THE CONTRACTOR SHALL VERIFY THE EXISTENCE OF A CONDUIT STUB OUT FROM THE POLE FOUNDATION OR LOCATION AT WHICH THE CONNECTION IS TO BE MADE. SHOULD SUCH STUB-OUTS BE MISSING, THE EXISTING FOUNDATION SHALL BE MODIFIED PER CLARK COUNTY AREA UNIFORM STD. DWG. NO. 320.
3. WHERE NEW STREET LIGHTS ARE TO BE ADDED TO AN EXISTING CIRCUIT, THE CONTRACTOR SHALL PROVIDE THE COMPLETE STREET LIGHT FOUNDATION & POLE, CONDUIT AND WIRES. TERMINATION WILL BE MADE BY CITY FORCES.
4. ALL NEW STREETLIGHT FOUNDATION CENTERLINES SHALL BE 4'-0" FROM THE TOP BACK OF CURB.
5. EXISTING STREETLIGHT CRASH CAPS ARE TO BE ADJUSTED (REMOVED & REPLACED) AS REQUIRED, TO MATCH NEW BACK OF SIDEWALK GRADES.
6. ALL LEGENDS AND SYMBOLS SHALL BE WHITE.
7. STREET LIGHT SERIES CIRCUIT WILL BE DISCONNECTED FOR THE CONTRACTOR. CONTACT CITY OF LAS VEGAS ELECTRICAL SERVICES AT 229-6331.
8. STREET LIGHT ELECTRICAL DISCONNECTIONS AND RECONNECTIONS SHALL BE DONE BY CITY FORCES AND COORDINATED WITH CLV ELECTRICAL SERVICES.

Oakey Boulevard

CONSTRUCTION NOTES

1. STANDARD TYPE 1 CENTERLINE (YELLOW) PER STD DWG 244
2. STANDARD TYPE 2 CENTERLINE (YELLOW) PER STD DWG 244
3. STANDARD TYPE 5 LANE LINE PER STD DWG 244A
4. NOT USED
5. CONTINUOUS 12" WHITE LINE COLD FORMED POLYMER
6. EXISTING R1-1 WITH STREET NAME SIGNS TO REMAIN
7. EXISTING R1-1 TO REMAIN
8. NEW STANDARD STREET NAME SIGN SEE CLARK COUNTY AREA UNIFORM STD. DWGS 249, 250 & 251
9. NEW R1-1
10. CONTINUOUS 24" WHITE STOP BAR, 4' BEHIND CROSSWALK COLD FORMED POLYMER
11. 10' CROSSWALKS LOCATED PER CLARK COUNTY AREA UNIFORM STD. DWGS 254
12. EXISTING CAT TRANSIT SYSTEM SIGN TO REMAIN
13. EXISTING R8-3A TO REMAIN
14. NEW 2-WAY BLUE REFLECTIVE MARKER, CENTERED IN DRIVING LANE
15. REPLACE R2-1(25) WITH NEW R2-1(35)
16. NEW R8-3A WITH R7-IAP PLACARD-BANDED TO STREETLIGHT POLE
17. NEW R7-IAP PLACARD-BANDED TO STREET LIGHT POLE BELOW EXISTING R8-3A
18. INSTALL NEW R1-3 SUPPLEMENTARY PLATE
19. 133 FT OF LANE MARKING SEE CLARK COUNTY AREA STD DWG 246
20. TACK ON ISLAND CURB PER CLV MODIFIED STD DWG 220-A LENGTH = 200' WIDTH = 1' FILL GAP WITH 4" CONCRETE
21. NEW R8-1R WITH POST AND FOUNDATION
22. CONTINUOUS 24" WHITE COLD FORMED POLYMER AT LANE LINES AND LANE CENTERS
23. REMOVE EXISTING SIGN, POST, AND FOUNDATION
24. NEW S2-1 WITH POST AND FOUNDATION
25. REPLACE R1-1 WITH NEW S2-1
26. NEW C.A.T. SIGN
27. INSTALL NEW PHOTOELECTRIC CONTROL PER STD. DWG. 327

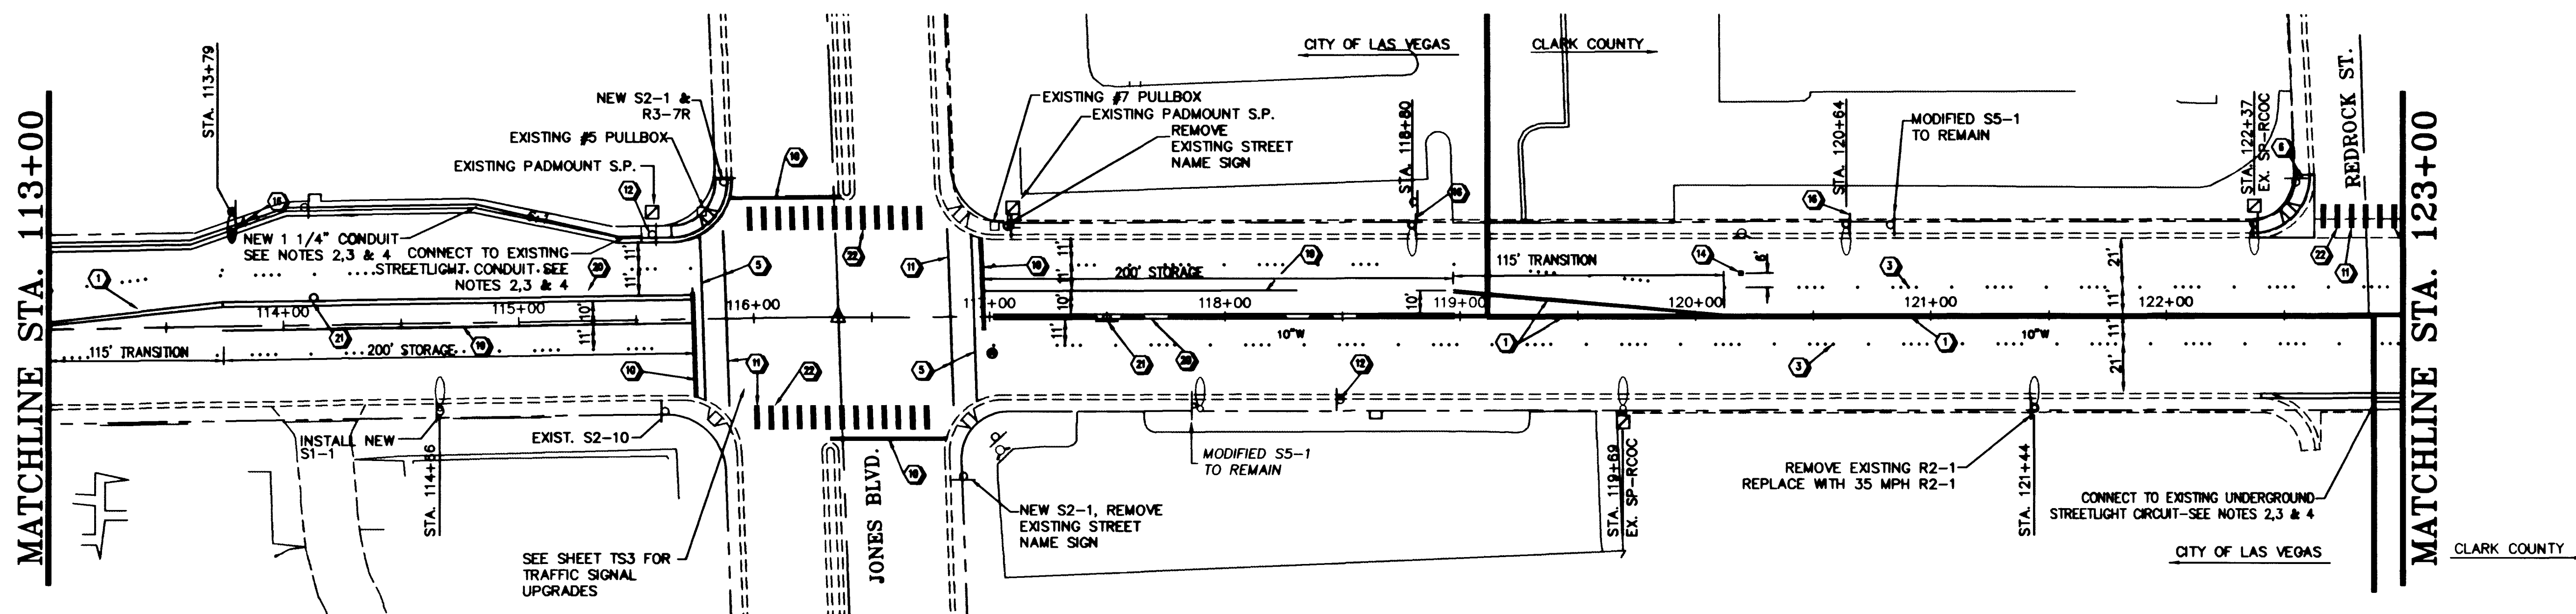

Oakey Boulevard

CLV DWG NO. 107-V2247

NO.	REVISIONS	DESCRIPTION/DATE	BY
1	REVISION	9-2-78	

100 GRIER DRIVE
LAS VEGAS, NEVADA 89119
PHONE (702) 361-9060
FAX (702) 361-0650

INCORPORATED

CONSULTING ENGINEERS


STRIPING AND STREET LIGHTING PLAN
FROM STA. 103+00 TO STA. 123+00
OAKLEY BOULEVARD
RAINBOW BLVD. TO DECATUR BLVD.

JOB NO.	2-241-073
ACAD FILE	OAKEL503
DESIGNED	J.B.
DRAWN	T.H.
CHECKED	D.P.
DATE	JUNE 1995

T3

27 OF 62 SHEETS

Call
before you
Dig.
1-800-227-2800

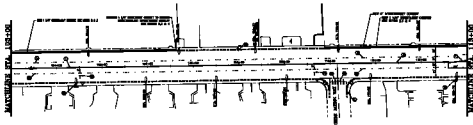

STREET LIGHTING NOTES

 
1. STREET LIGHTING SHALL BE PROVIDED AT THE FOLLOWING LOCATIONS:
2. STREET LIGHTING SHALL BE PROVIDED AT THE FOLLOWING LOCATIONS:
3. STREET LIGHTING SHALL BE PROVIDED AT THE FOLLOWING LOCATIONS:
4. STREET LIGHTING SHALL BE PROVIDED AT THE FOLLOWING LOCATIONS:
5. STREET LIGHTING SHALL BE PROVIDED AT THE FOLLOWING LOCATIONS:
6. STREET LIGHTING SHALL BE PROVIDED AT THE FOLLOWING LOCATIONS:
7. STREET LIGHTING SHALL BE PROVIDED AT THE FOLLOWING LOCATIONS:
8. STREET LIGHTING SHALL BE PROVIDED AT THE FOLLOWING LOCATIONS:
9. STREET LIGHTING SHALL BE PROVIDED AT THE FOLLOWING LOCATIONS:
10. STREET LIGHTING SHALL BE PROVIDED AT THE FOLLOWING LOCATIONS:

OAKLEY BOULEVARD

CONSTRUCTION NOTES

1. ALL CONSTRUCTION SHALL BE IN ACCORDANCE WITH THE LATEST EDITIONS OF THE CALIFORNIA STANDARD SPECIFICATIONS FOR HIGHWAY CONSTRUCTION.
2. ALL CONSTRUCTION SHALL BE IN ACCORDANCE WITH THE LATEST EDITIONS OF THE CALIFORNIA STANDARD SPECIFICATIONS FOR HIGHWAY CONSTRUCTION.
3. ALL CONSTRUCTION SHALL BE IN ACCORDANCE WITH THE LATEST EDITIONS OF THE CALIFORNIA STANDARD SPECIFICATIONS FOR HIGHWAY CONSTRUCTION.
4. ALL CONSTRUCTION SHALL BE IN ACCORDANCE WITH THE LATEST EDITIONS OF THE CALIFORNIA STANDARD SPECIFICATIONS FOR HIGHWAY CONSTRUCTION.
5. ALL CONSTRUCTION SHALL BE IN ACCORDANCE WITH THE LATEST EDITIONS OF THE CALIFORNIA STANDARD SPECIFICATIONS FOR HIGHWAY CONSTRUCTION.
6. ALL CONSTRUCTION SHALL BE IN ACCORDANCE WITH THE LATEST EDITIONS OF THE CALIFORNIA STANDARD SPECIFICATIONS FOR HIGHWAY CONSTRUCTION.
7. ALL CONSTRUCTION SHALL BE IN ACCORDANCE WITH THE LATEST EDITIONS OF THE CALIFORNIA STANDARD SPECIFICATIONS FOR HIGHWAY CONSTRUCTION.
8. ALL CONSTRUCTION SHALL BE IN ACCORDANCE WITH THE LATEST EDITIONS OF THE CALIFORNIA STANDARD SPECIFICATIONS FOR HIGHWAY CONSTRUCTION.
9. ALL CONSTRUCTION SHALL BE IN ACCORDANCE WITH THE LATEST EDITIONS OF THE CALIFORNIA STANDARD SPECIFICATIONS FOR HIGHWAY CONSTRUCTION.
10. ALL CONSTRUCTION SHALL BE IN ACCORDANCE WITH THE LATEST EDITIONS OF THE CALIFORNIA STANDARD SPECIFICATIONS FOR HIGHWAY CONSTRUCTION.

- 1. ALL CONSTRUCTION SHALL BE IN ACCORDANCE WITH THE LATEST EDITIONS OF THE CALIFORNIA STANDARD SPECIFICATIONS FOR HIGHWAY CONSTRUCTION.
- 2. ALL CONSTRUCTION SHALL BE IN ACCORDANCE WITH THE LATEST EDITIONS OF THE CALIFORNIA STANDARD SPECIFICATIONS FOR HIGHWAY CONSTRUCTION.
- 3. ALL CONSTRUCTION SHALL BE IN ACCORDANCE WITH THE LATEST EDITIONS OF THE CALIFORNIA STANDARD SPECIFICATIONS FOR HIGHWAY CONSTRUCTION.
- 4. ALL CONSTRUCTION SHALL BE IN ACCORDANCE WITH THE LATEST EDITIONS OF THE CALIFORNIA STANDARD SPECIFICATIONS FOR HIGHWAY CONSTRUCTION.
- 5. ALL CONSTRUCTION SHALL BE IN ACCORDANCE WITH THE LATEST EDITIONS OF THE CALIFORNIA STANDARD SPECIFICATIONS FOR HIGHWAY CONSTRUCTION.
- 6. ALL CONSTRUCTION SHALL BE IN ACCORDANCE WITH THE LATEST EDITIONS OF THE CALIFORNIA STANDARD SPECIFICATIONS FOR HIGHWAY CONSTRUCTION.
- 7. ALL CONSTRUCTION SHALL BE IN ACCORDANCE WITH THE LATEST EDITIONS OF THE CALIFORNIA STANDARD SPECIFICATIONS FOR HIGHWAY CONSTRUCTION.
- 8. ALL CONSTRUCTION SHALL BE IN ACCORDANCE WITH THE LATEST EDITIONS OF THE CALIFORNIA STANDARD SPECIFICATIONS FOR HIGHWAY CONSTRUCTION.
- 9. ALL CONSTRUCTION SHALL BE IN ACCORDANCE WITH THE LATEST EDITIONS OF THE CALIFORNIA STANDARD SPECIFICATIONS FOR HIGHWAY CONSTRUCTION.
- 10. ALL CONSTRUCTION SHALL BE IN ACCORDANCE WITH THE LATEST EDITIONS OF THE CALIFORNIA STANDARD SPECIFICATIONS FOR HIGHWAY CONSTRUCTION.



OAKLEY BOULEVARD

CLV DWG NO. 107-V2847

STREETING AND STREET LIGHTING PLAN
FROM 107-V2847 TO 107-V2848
NAME OF MAP TO INDICATE MAP.

DATE	10/1/00
BY	CLV
CHECKED BY	CLV
APPROVED BY	CLV
DATE	10/1/00

T3