


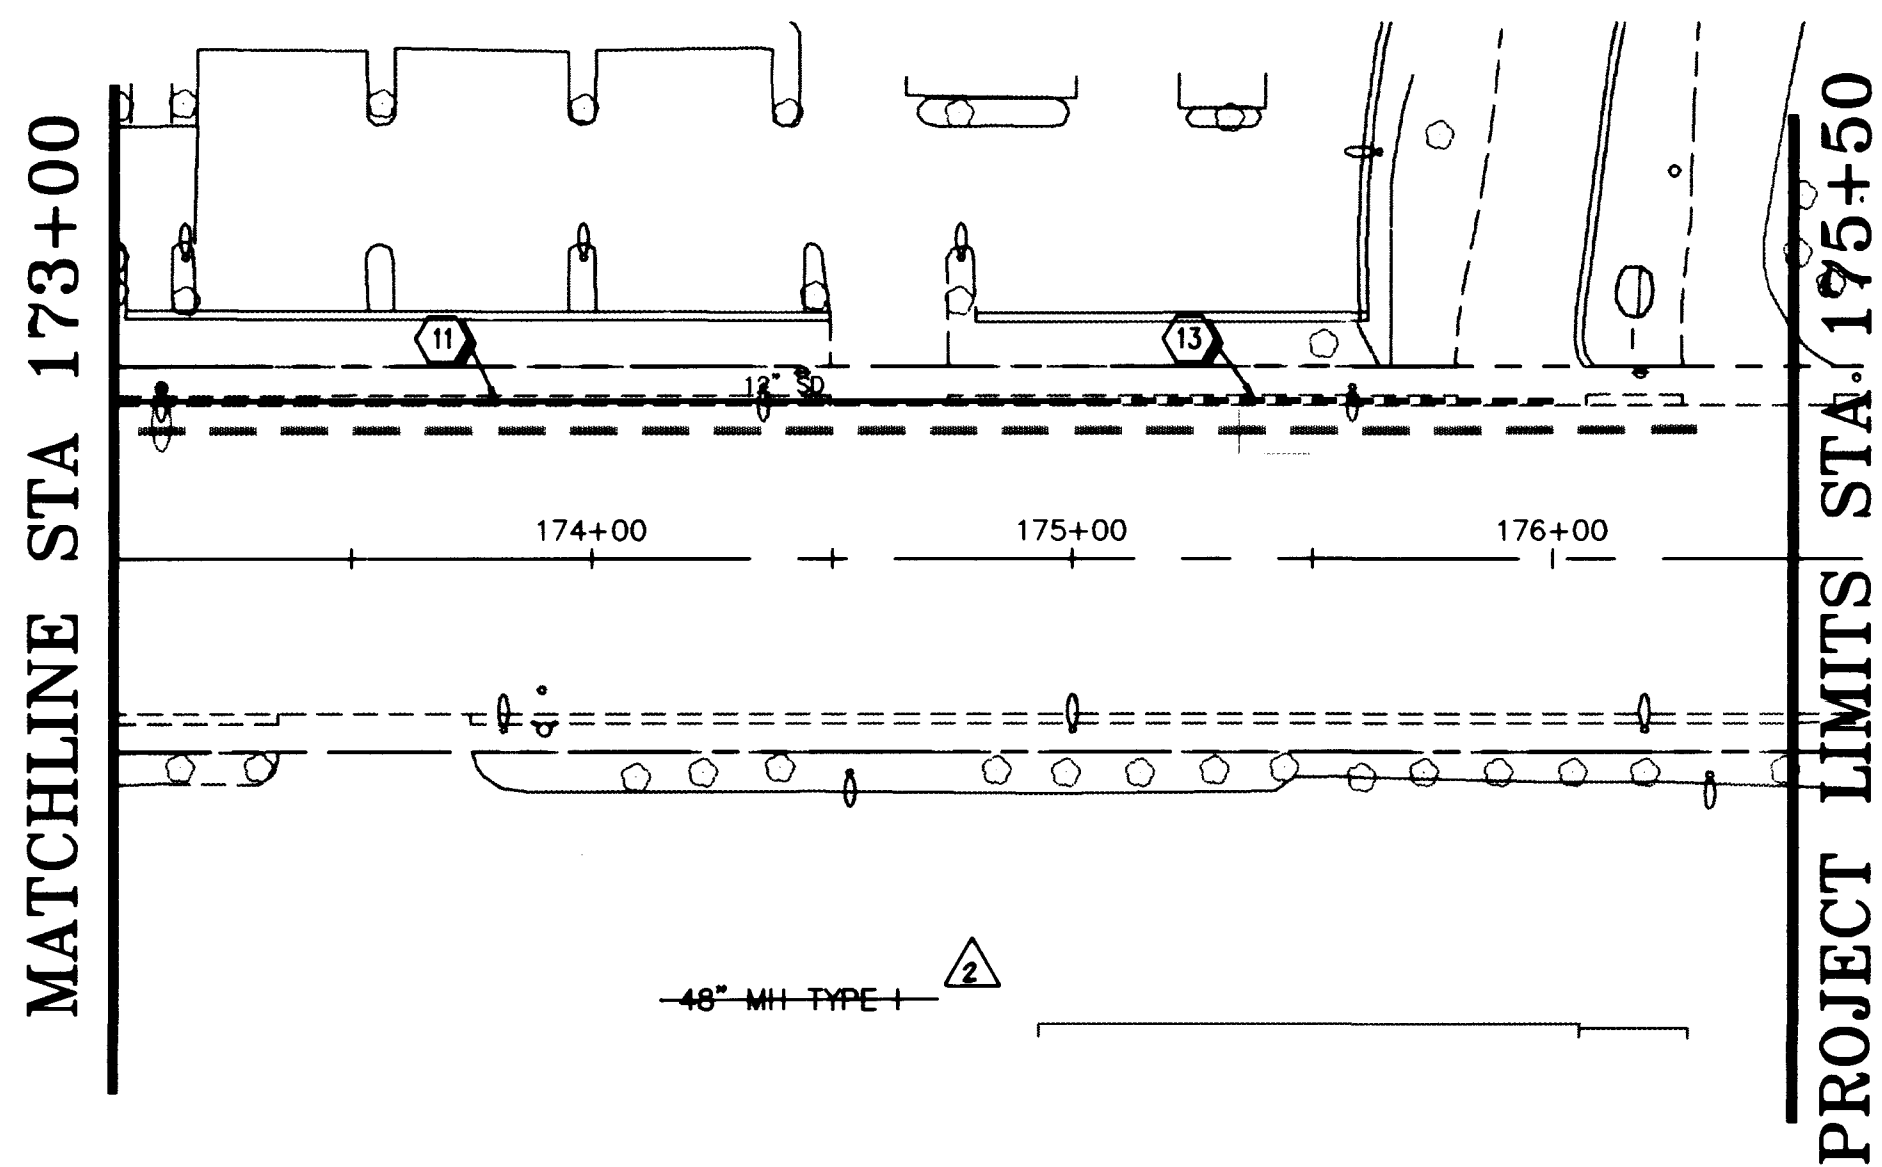

CONSTRUCTION NOTES


- 1. SEE SANITARY SEWER (SS) SHEETS FOR WATERLINE RELOCATION.
- 2. DEPRESS WATERLINE. SEE DETAIL SHEET D2.
- 3. ENCASE SD WITH 4" MIN. CONCRETE ENCASEMENT TO 10' MIN. EACH SIDE OF WATERLINE. -SEE SHEET D2-
- 4. SEE SANITARY SEWER (SS) SHEETS FOR GAS RELOCATION BY SW. GAS.
- 5. PLUG AND ABANDON STORM SEWER.
- 6. 2" GAS LINE TO BE RELOCATED BY S/W GAS CORP FROM APPROXIMATELY STA 66+45 TO 76+25; STA 101+00 TO STA 101+60, STA 109+70 TO STA 110+30 AND STA 115+30 TO STA 115+90.
- 7. CONNECT TO EXISTING MANHOLE (NO EXISTING STUBOUT) RECONSTRUCT MANHOLE AS REQUIRED.
- 8. REMOVE EXISTING INLET.
- 9. PLUG AND CAP EXISTING CULVERT.
- 10. RELOCATE WATER SERVICE LATERAL:
 - A. IF POLYETHYLENE, REMOVE AND REPLACE PER SPEC'S
 - B. IF COPPER, REPAIR AND ADJUST
- 11. REMOVE & REPLACE L-TYPE CURB & GUTTER (STD. DWG. NO.216)
- 12. CAUTION: THESE ARE ENERGIZED CABLES. A NPC QUALIFIED REPRESENTATIVE MUST BE PRESENT DURING CONSTRUCTION IN OR AROUND THIS EQUIPMENT. CALL 657-4117 FOR AN APPOINTMENT 48 HOURS PRIOR.
- 13. OUTLET DRAIN SEE SHEET D2

NOTE:
1. REFERENCE POTHOLE TABLE ON SHEET 2.
2. SEE CORRESPONDING S.S. SHEET

OAKEY BOULEVARD

1"=40' (HORZ.)
1"=10' (VERT.)

Avoid cutting underground utility lines. It's costly.
Call before you Dig.
1-800-227-2800
NEVADA STATE CREDIT CARD

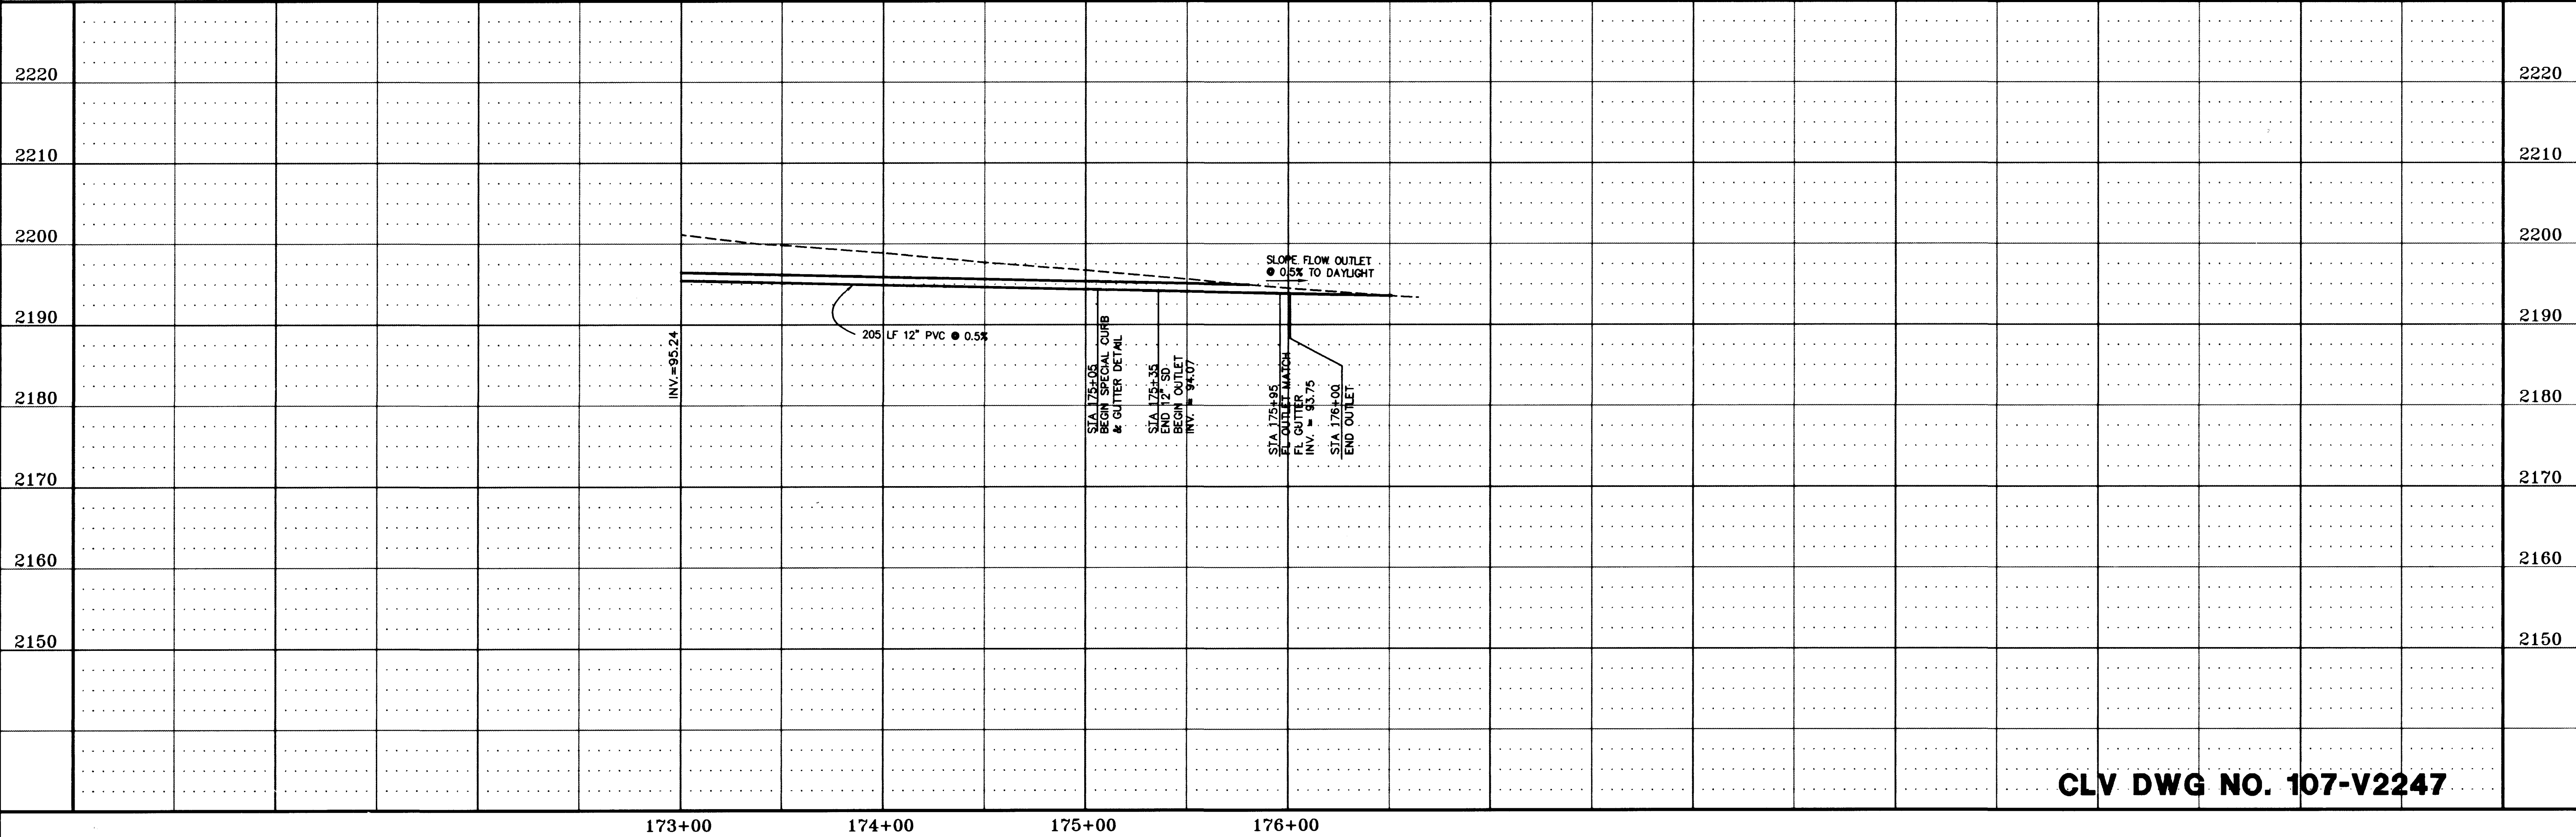

CLV DWG NO. 107-V2247

REVISIONS

NO.	DESCRIPTION/DATE	BY
1	REVISED BY CLV 11-01-95	

163-1648

1100 ORIER DRIVE
LAS VEGAS, NEVADA 89119
PHONE (702) 361-9050
FAX (702) 361-0669

Incorporated

CONSULTING ENGINEERS

NEVADA

CLARK COUNTY


CITY OF LAS VEGAS

STORM DRAIN PLAN AND PROFILE
FROM STA. 173+00 TO STA. 175+50
OAKEY BOULEVARD
RAINBOW BOULEVARD TO DECATUR BOULEVARD

JOB NO: 2-241-072
ACAD FILE: OAKESD12
DESIGNED: RHS
DRAWN: TL
CHECKED: DP
DATE: JUNE 1995

SD12

 58 OF 62 SHEETS



DAVEY HOLLOWAY
DAVEY

1. THE COMPANY'S NAME IS THE COMPANY'S NAME. 2. THE COMPANY'S NAME IS THE COMPANY'S NAME. 3. THE COMPANY'S NAME IS THE COMPANY'S NAME. 4. THE COMPANY'S NAME IS THE COMPANY'S NAME. 5. THE COMPANY'S NAME IS THE COMPANY'S NAME. 6. THE COMPANY'S NAME IS THE COMPANY'S NAME. 7. THE COMPANY'S NAME IS THE COMPANY'S NAME. 8. THE COMPANY'S NAME IS THE COMPANY'S NAME. 9. THE COMPANY'S NAME IS THE COMPANY'S NAME. 10. THE COMPANY'S NAME IS THE COMPANY'S NAME.	11. THE COMPANY'S NAME IS THE COMPANY'S NAME. 12. THE COMPANY'S NAME IS THE COMPANY'S NAME. 13. THE COMPANY'S NAME IS THE COMPANY'S NAME. 14. THE COMPANY'S NAME IS THE COMPANY'S NAME. 15. THE COMPANY'S NAME IS THE COMPANY'S NAME. 16. THE COMPANY'S NAME IS THE COMPANY'S NAME. 17. THE COMPANY'S NAME IS THE COMPANY'S NAME. 18. THE COMPANY'S NAME IS THE COMPANY'S NAME. 19. THE COMPANY'S NAME IS THE COMPANY'S NAME. 20. THE COMPANY'S NAME IS THE COMPANY'S NAME.
--	---

Call before you dig.

[illegible]

STORM DRAIN PLAN AND PROFILE
FROM STA. 17+00 TO STA. 17+00
COUNT 850474-1-10

SD12

AS BUILT

142.00 d