


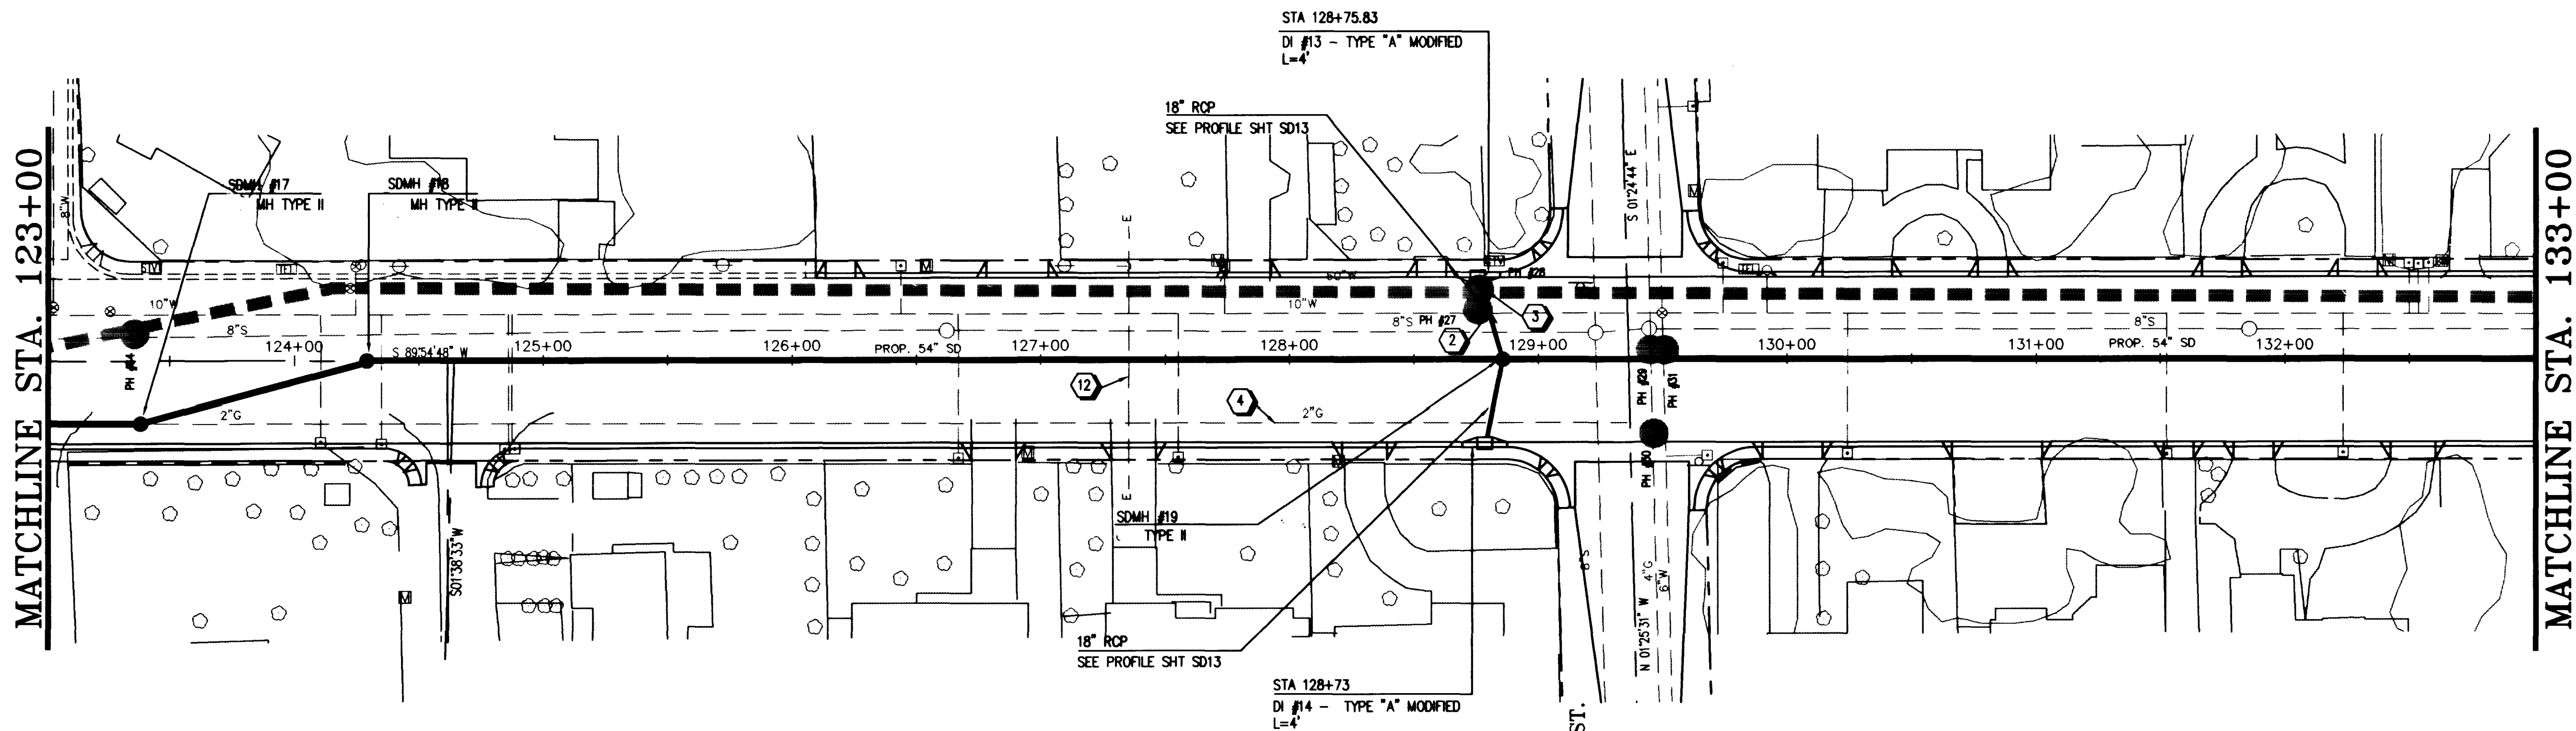

Call
before you
Dig.
1-800-227-2800


- NOTE:
1. REFERENCE POTHOLE TABLE ON SHEET 2.
 2. SEE CORRESPONDING S.S. SHEET

OAKLEY BOULEVARD

HORIZONTAL SCALE 1"=40'
VERTICAL SCALE 1"=10'

CONSTRUCTION NOTES

1. SEE SANITARY SEWER (SS) SHEETS FOR WATERLINE RELOCATION.
2. DEPRESS WATERLINE. SEE DETAIL SHEET D2.
3. ENCASE SD WITH 4" MIN. CONCRETE ENCASEMENT TO 10' MIN. EACH SIDE OF WATERLINE. -SEE SHEET D2-
4. SEE SANITARY SEWER (SS) SHEETS FOR GAS RELOCATION BY SW. GAS.
5. PLUG AND ABANDON STORM SEWER.
6. 2" GAS LINE TO BE RELOCATED BY S/W GAS CORP FROM APPROXIMATELY STA 66+45 TO 76+25, STA 101+00 TO STA 101+60, STA 109+70 TO STA 110+30 AND STA 115+30 TO STA 115+90.
7. CONNECT TO EXISTING MANHOLE (NO EXISTING STUBOUT) RECONSTRUCT MANHOLE AS REQUIRED.
8. REMOVE EXISTING INLET.
9. PLUG AND CAP EXISTING CULVERT.
10. RELOCATE WATER SERVICE LATERAL:
A. IF POLYETHYLENE, REMOVE AND REPLACE PER SPEC'S
B. IF COPPER, REPAIR AND ADJUST
11. REMOVE & REPLACE L-TYPE CURB & GUTTER (STD. DWG. NO.216)
12. CAUTION: THESE ARE ENERGIZED CABLES. A NPC QUALIFIED REPRESENTATIVE MUST BE PRESENT DURING CONSTRUCTION IN OR AROUND THIS EQUIPMENT. CALL 657-4117 FOR AN APPOINTMENT 48 HOURS PRIOR.

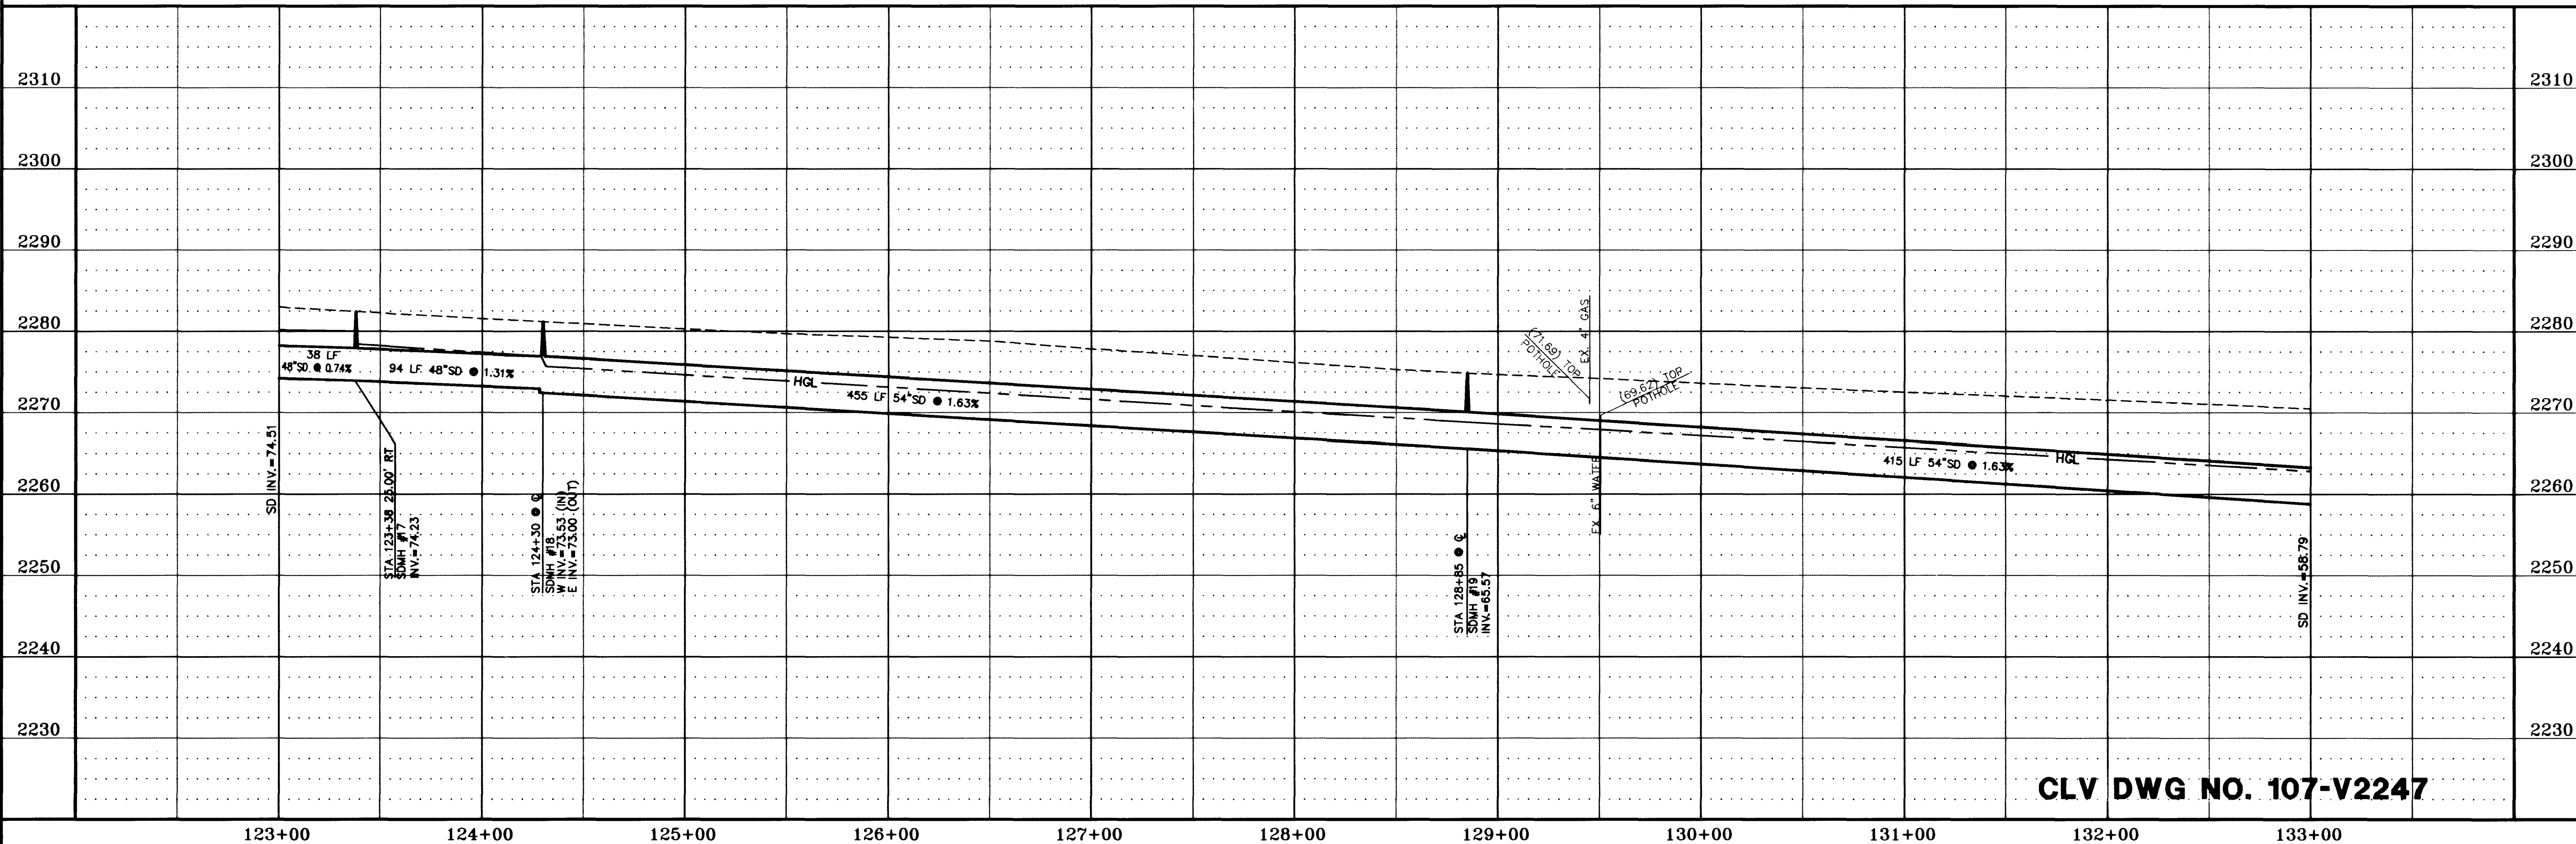

CLV DWG NO. 107-V2247

REVISIONS

NO.	DESCRIPTION/DATE	BY
1	REVISED BY CLV 11-01-95	

1100 GRIER DRIVE
LAS VEGAS, NEVADA 89119
PHONE (702) 361-9050
FAX (702) 361-0659

INCORPORATED
CLV
CONSULTING ENGINEERS

NEVADA

STORM DRAIN PLAN AND PROFILE
FROM STA. 123+00 TO STA. 133+00
OAKLEY BOULEVARD
RAINBOW BLVD. TO DECATUR BLVD.

CITY OF LAS VEGAS
CLARK COUNTY

JOB NO.: 2-241-073
ACAD FILE: OAKESD07
DESIGNED: RJS
DRAWN: TL
CHECKED: DP
DATE: JUNE 1995

SD7

53 OF 62 SHEETS

AS BUILT

18.2.105



DANIEL HOUTCHANS
 MEMBER SINCE 2006

STORM DRAIN PLAN AND PROFILE
PROJECT: 474, 33-00 JEFF. EST-04
DRAWN: 10/10/04
REVISIONS: 1.00
DATE: 10/10/04

- SD7

100

14.5-105