
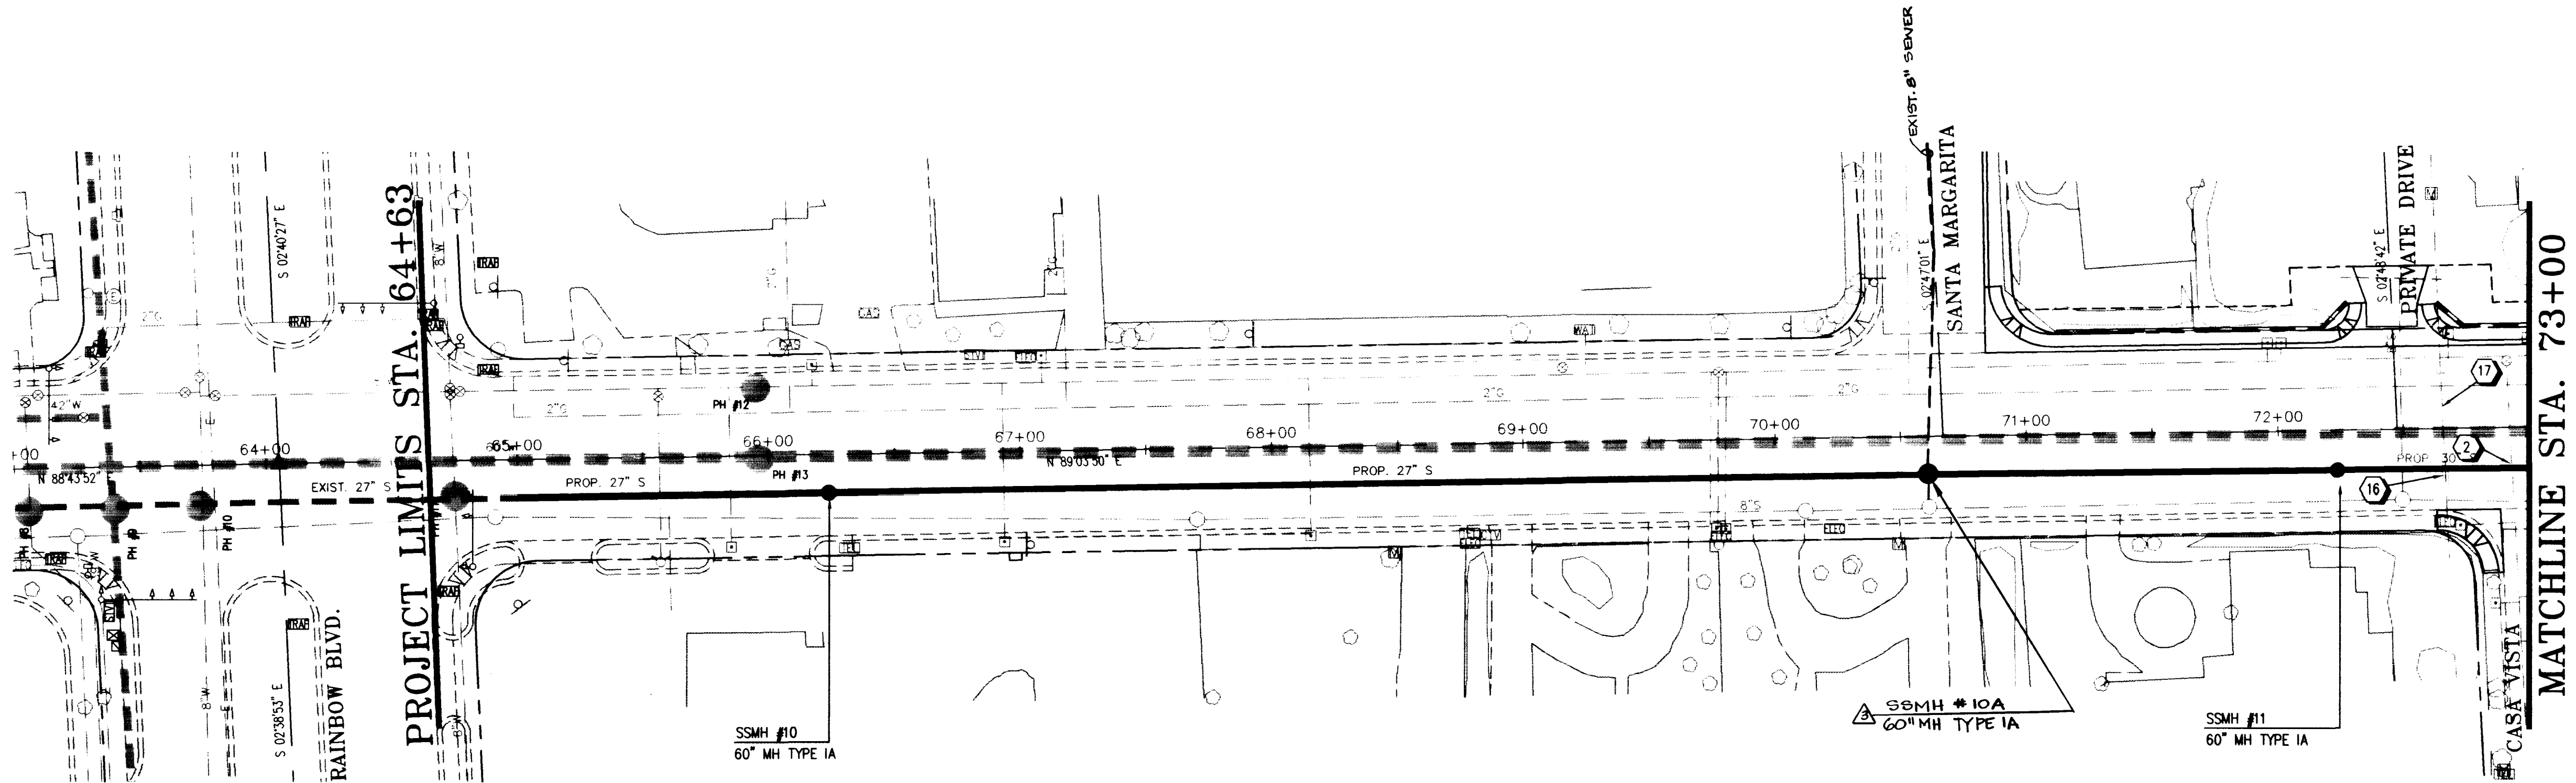


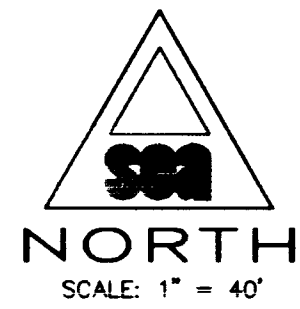

NOTE:
1. REFERENCE POTHOLE TABLE ON SHEET 2.

OAKLEY BOULEVARD

HORIZONTAL SCALE 1"=40'
VERTICAL SCALE 1"=10'

CONSTRUCTION NOTES

- ① RELOCATE WATER SERVICE LATERAL:
A. IF POLYETHYLENE, REMOVE AND REPLACE PER SPEC'S
B. IF COPPER, REPAIR AND ADJUST
- ② ENCASE SANITARY SEWER WITH 4" MIN. CONC. ENCASEMENT TO 10 FT. MIN. EACH SIDE FROM WATERLINE - SEE SHEET D2
- ③ DEPRESS WATERLINE. SEE DETAIL SHEET D2
- ④ CONNECT TO EXISTING MANHOLE (NO EXISTING STUBOUT) RECONSTRUCT MANHOLE AS REQUIRED.
- ⑤ ABANDON WATERLINE AND APPURTENANCES
- ⑥ RELOCATE 8" WATERLINE TO 30' RT. STA. 90+63 TO STA 94+90
- ⑦ ATTACH EXISTING FIRE HYDRANT TO NEW VALVE
- ⑧ NEW VALVE
- ⑨ CONNECT TO EXISTING WATERLINE
- ⑩ RELOCATE 10" WATERLINE TO 10' RT. STA 116+10 TO STA 122+95
- ⑪ CONNECT EXISTING SERVICE LATERALS TO NEW WATERLINE
- ⑫ GAS RELOCATION BY SW GAS APPROX. STA 116+80 TO STA 161+70 AND STA 164+60 TO STA 167+60
- ⑬ RELOCATE 8" WATERLINE TO 1' LT. STA 161+40 TO STA 167+60
- ⑭ CONNECT EXISTING 6" FIRE HYDRANT LINE TO NEW WATERLINE
- ⑮ CAP AND PLUG
- ⑯ CONCRETE ENCASE ELEC. TELE. OR CATV CONDUITS PER UTILITY CO. STANDARD IF LESS THAN 18" CLEARANCE
- ⑰ CAUTION: THESE ARE ENERGIZED CABLES. A NPC QUALIFIED REPRESENTATIVE MUST BE PRESENT DURING CONSTRUCTION IN OR AROUND THIS EQUIPMENT. CALL 657-4117 FOR AN APPOINTMENT 48 HOURS PRIOR.

Call
before you
Dig.
1-800-227-2600
(Nevada Only)

SEWER PLAN AND PROFILE
FROM STA. 63+00 TO STA. 73+00
OAKLEY BOULEVARD
RAINBOW BLVD. TO DECATUR BLVD.

JOB NO: 2-241-073
ACAD FILE: OAKESS01
DESIGNED: DP
DRAWN: TL
CHECKED: TL
DATE: JUNE 1995


SS1

36 OF 62 SHEETS

CLV DWG NO. 107-V2247

AS BUILT

12.2.57

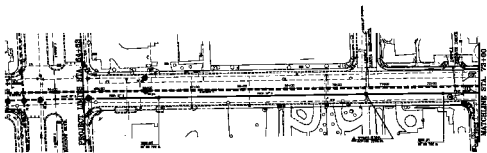

OAKLEY BOULEVARD

SECTION 100' TO 100'

CONSTRUCTION NOTES

1. SEE PLAN FOR EXISTING AND PROPOSED CURBS AND GUTTERS.
2. SEE PLAN FOR EXISTING AND PROPOSED SIDEWALKS.
3. SEE PLAN FOR EXISTING AND PROPOSED DRIVEWAYS.
4. SEE PLAN FOR EXISTING AND PROPOSED UTILITIES.
5. SEE PLAN FOR EXISTING AND PROPOSED LANDSCAPING.
6. SEE PLAN FOR EXISTING AND PROPOSED FURNISHINGS.
7. SEE PLAN FOR EXISTING AND PROPOSED SIGNAGE.
8. SEE PLAN FOR EXISTING AND PROPOSED LIGHTING.
9. SEE PLAN FOR EXISTING AND PROPOSED TRAFFIC CONTROL.
10. SEE PLAN FOR EXISTING AND PROPOSED SAFETY FEATURES.
11. SEE PLAN FOR EXISTING AND PROPOSED ACCESSIBILITY.
12. SEE PLAN FOR EXISTING AND PROPOSED ENVIRONMENTAL FEATURES.
13. SEE PLAN FOR EXISTING AND PROPOSED HISTORIC PRESERVATION.
14. SEE PLAN FOR EXISTING AND PROPOSED CULTURAL RESOURCES.
15. SEE PLAN FOR EXISTING AND PROPOSED ARCHITECTURAL FEATURES.
16. SEE PLAN FOR EXISTING AND PROPOSED ART INSTALLATIONS.
17. SEE PLAN FOR EXISTING AND PROPOSED PUBLIC ART.
18. SEE PLAN FOR EXISTING AND PROPOSED COMMUNITY DEVELOPMENT.
19. SEE PLAN FOR EXISTING AND PROPOSED ECONOMIC DEVELOPMENT.
20. SEE PLAN FOR EXISTING AND PROPOSED SOCIAL SERVICES.


SEE PLAN FOR
CALL
FOR
DIA.
DETAILS

THE FIRM SHALL BE RESPONSIBLE FOR THE DESIGN AND CONSTRUCTION OF THE PROJECT AND SHALL BE RESPONSIBLE FOR THE ACCURACY OF THE INFORMATION PROVIDED TO THE CLIENT.

SEWER PLAN AND PROFILE
FROM STA. 64+00 TO STA. 73+00
ALABAMA HIGHWAY DEPARTMENT

SS1

12-2-97

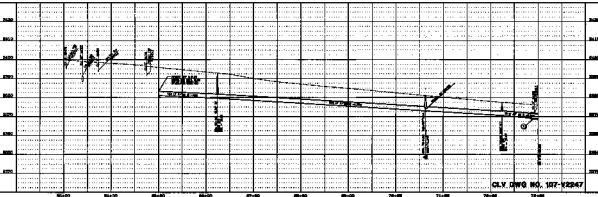

CLY DWG NO. 187-12247

AS BUILT