


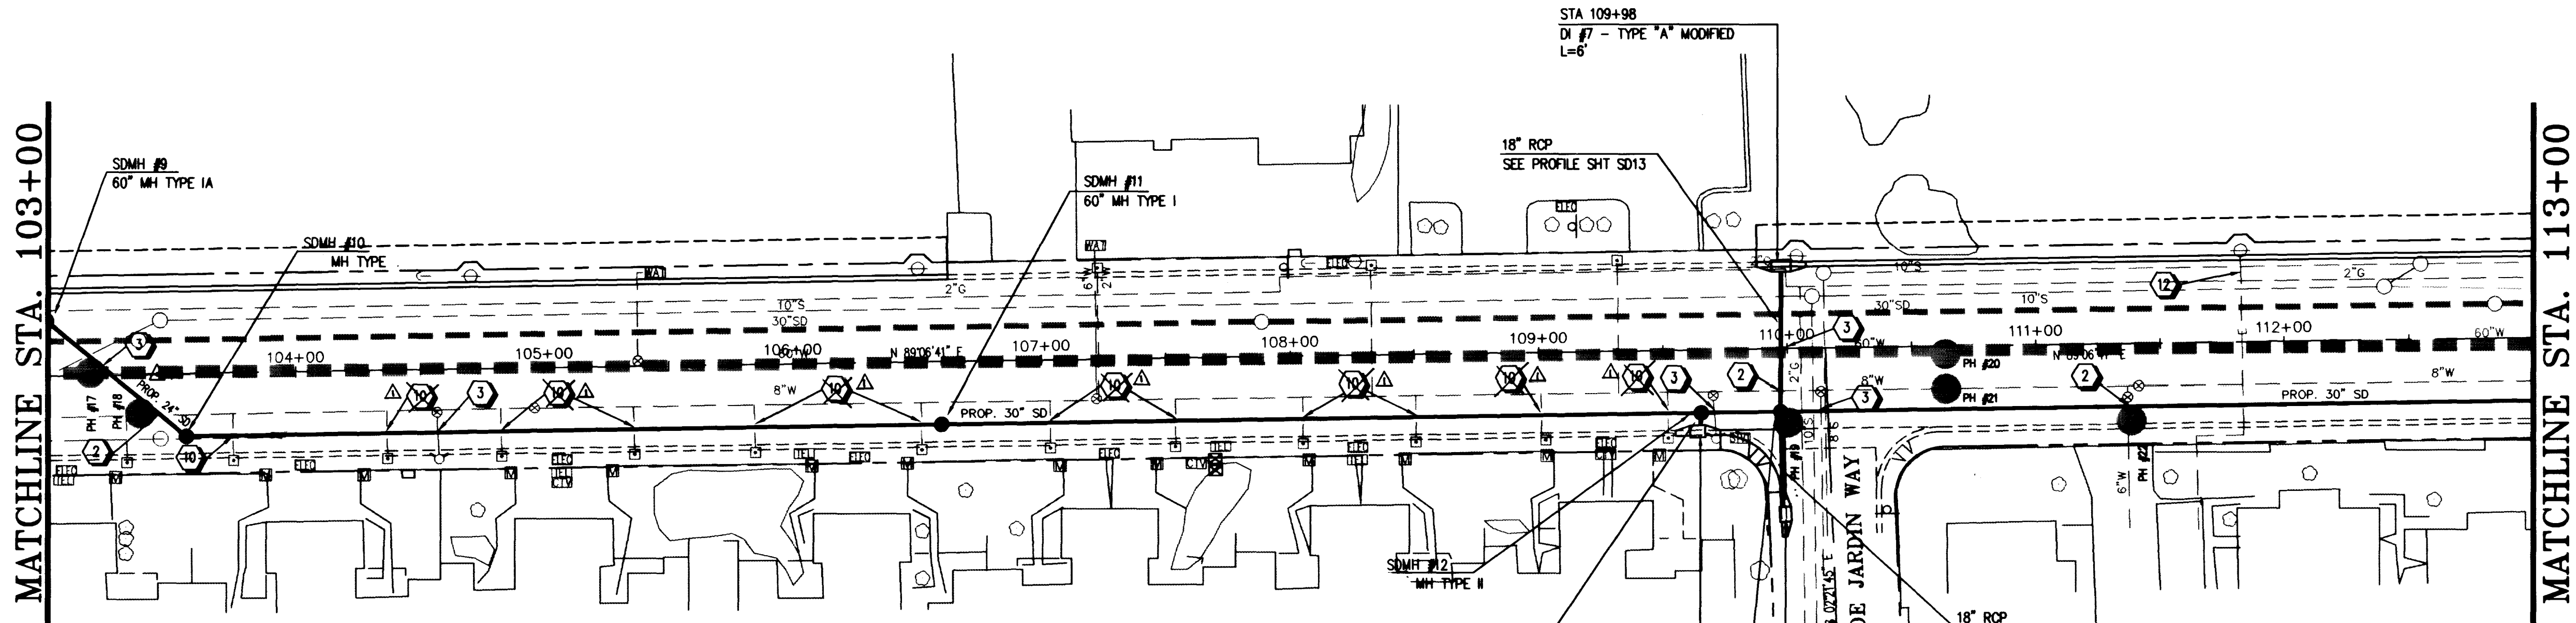


CONSTRUCTION NOTES

- SEE SANITARY SEWER (SS) SHEETS FOR WATERLINE RELOCATION.
- DEPRESS WATERLINE. SEE DETAIL SHEET D2.
- ENCASE SD WITH 4" MIN. CONCRETE ENCASEMENT TO 10' MIN. EACH SIDE OF WATERLINE. -SEE SHEET D2-
- SEE SANITARY SEWER (SS) SHEETS FOR GAS RELOCATION BY SW. GAS.
- PLUG AND ABANDON STORM SEWER.
- 2" GAS LINE TO BE RELOCATED BY S/W GAS CORP FROM APPROXIMATELY STA 66+45 TO 76+25, STA 101+00 TO STA 101+60, STA 109+70 TO STA 110+30 AND STA 115+30 TO STA 115+90.
- CONNECT TO EXISTING MANHOLE (NO EXISTING STUBOUT) RECONSTRUCT MANHOLE AS REQUIRED.
- REMOVE EXISTING INLET.
- PLUG AND CAP EXISTING CULVERT.
- RELOCATE WATER SERVICE LATERAL:
A. IF POLYETHYLENE, REMOVE AND REPLACE PER SPEC'S
B. IF COPPER, REPAIR AND ADJUST
- REMOVE & REPLACE L-TYPE CURB & GUTTER (STD. DWG. NO.216)
- CAUTION: THESE ARE ENERGIZED CABLES. A NPC QUALIFIED REPRESENTATIVE MUST BE PRESENT DURING CONSTRUCTION IN OR AROUND THIS EQUIPMENT. CALL 657-4117 FOR AN APPOINTMENT 48 HOURS PRIOR.

Oakey Boulevard

HORIZONTAL SCALE 1"=40'
VERTICAL SCALE 1"=10'

Call
before you
Dig.
1-800-227-2600
UNDERGROUND SERVICE ALERT (USA)

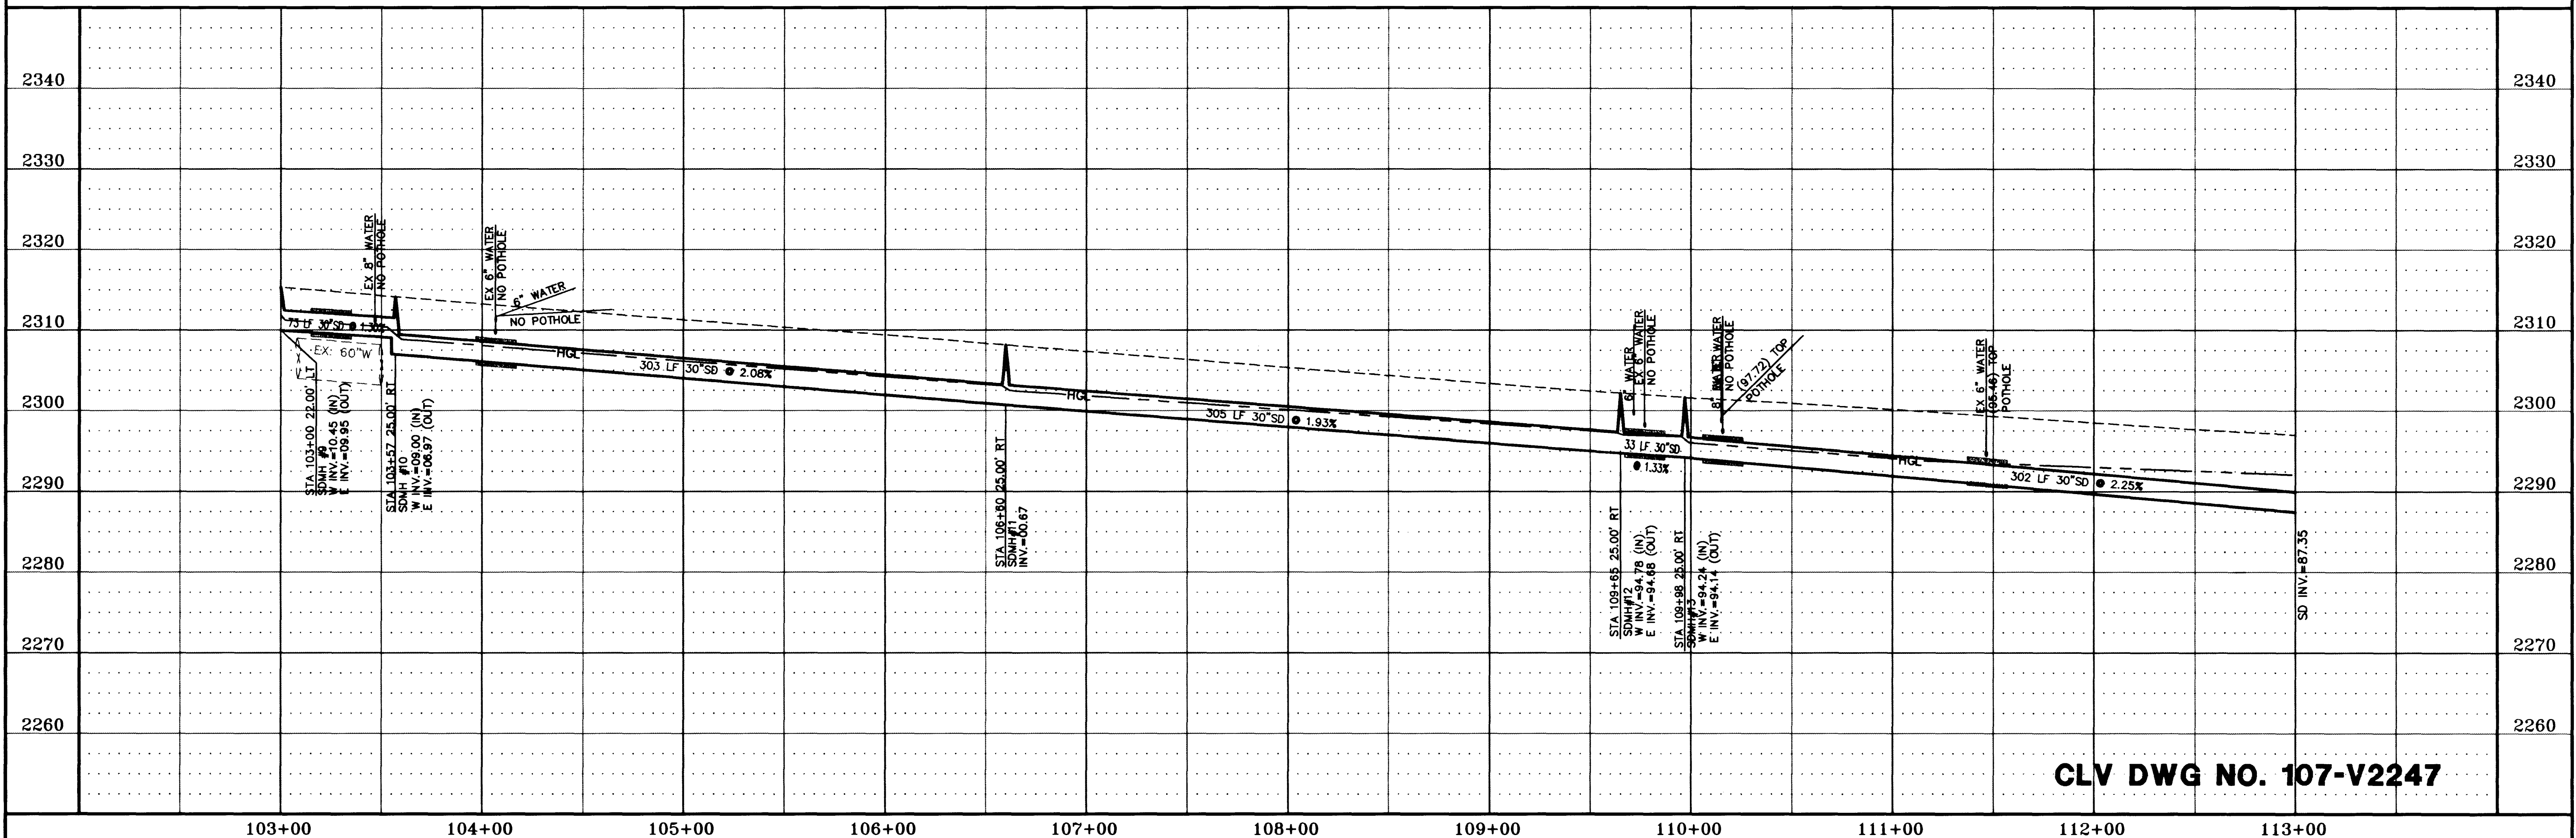

CLV DWG NO. 107-V2247

AS BUILT

REVISIONS
NO. DESCRIPTION/DATE BY
1. REVISED BY CLV 11-11-95

16 June 98

100 GRIER DRIVE
LAS VEGAS, NEVADA 89119
PHONE (702) 361-9050
FAX (702) 361-0659
Incorporated

CONSULTING ENGINEERS


NEVADA
CLARK COUNTY
CITY OF LAS VEGAS

JOB NO.: 2-241-073
ACAD FILE: OAKESD05
DESIGNED: RHS
DRAWN: TL
CHECKED: DP
DATE: JUNE 1995

SD5
51 OF 62 SHEETS

STORM DRAIN PLAN AND PROFILE
FROM STA. 103+00 TO STA. 113+00
Oakey Boulevard
RAINBOW BLVD. TO DECATUR BLVD.

18-j-183

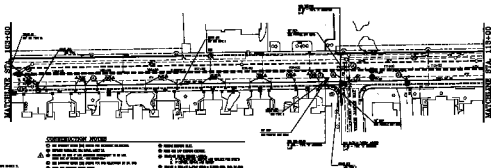


CONSTRUCTION NOTES

- [illegible]

CAKEY HOLEYARD

THE

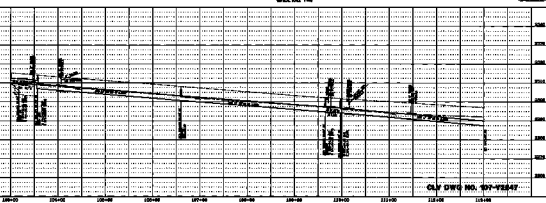

CLY DVD NO. 03-4341

AS SUPPLY

19-2-105