


MATCHLINE STA. 103+00

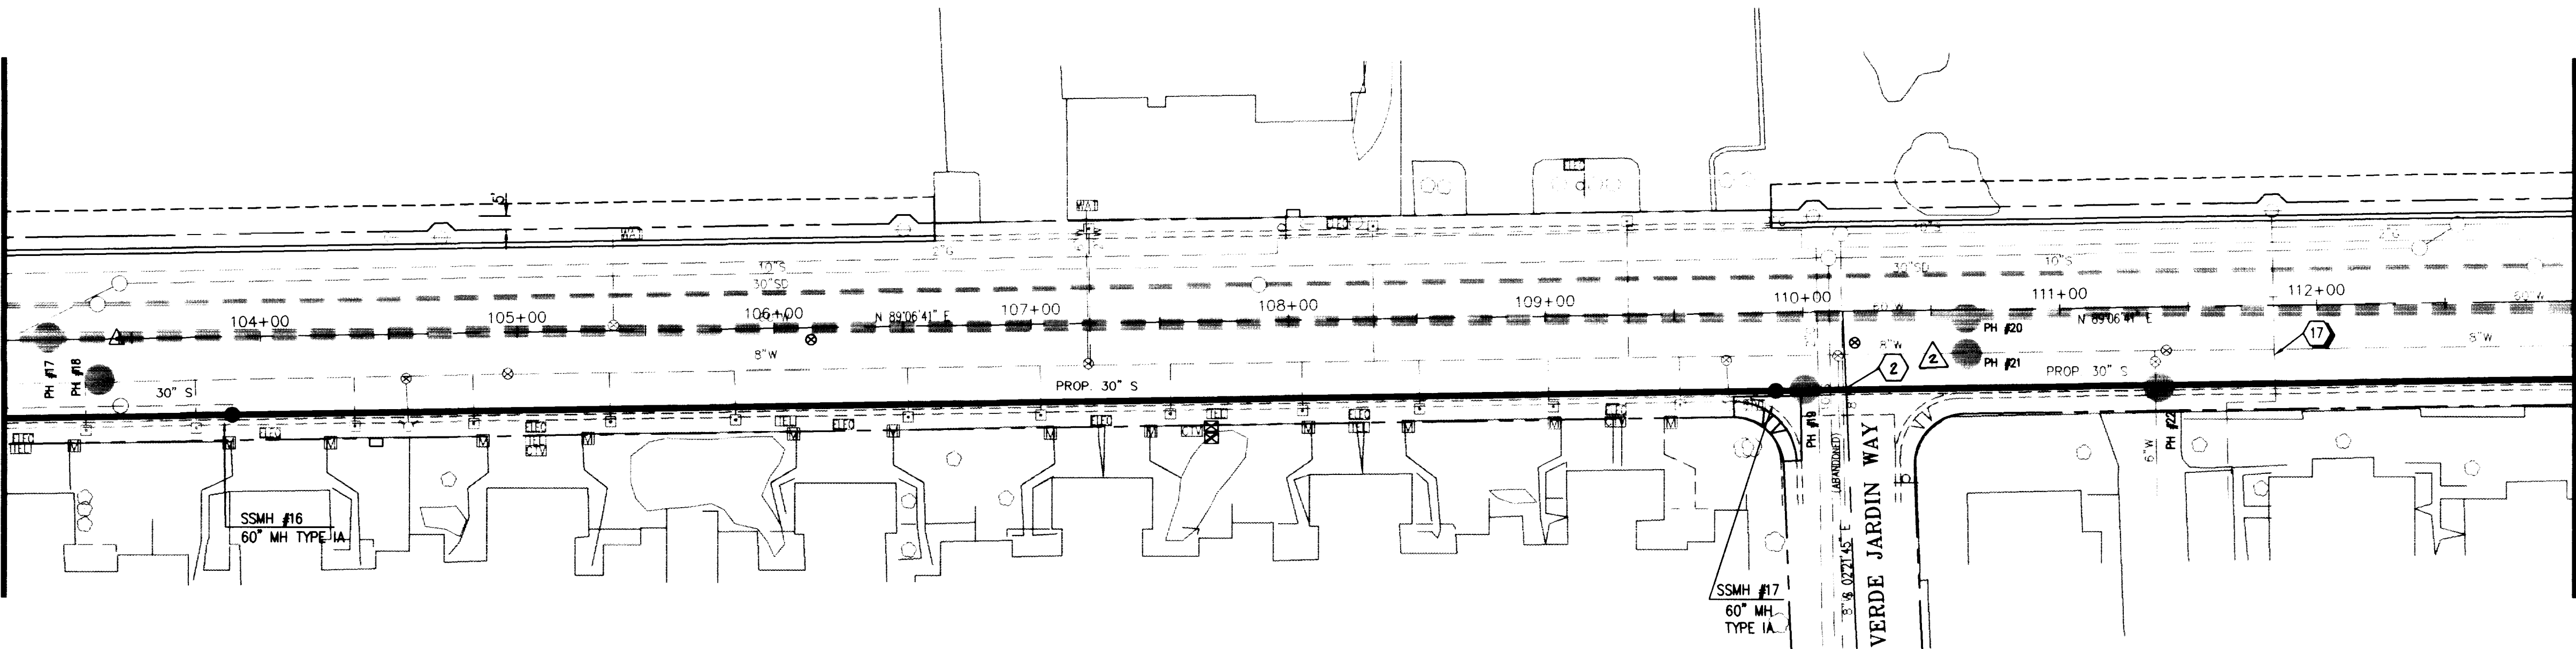

MATCHLINE STA. 113+00


NOTE:
1. REFERENCE POTHOLE TABLE ON SHEET 2.

OAKEY BOULEVARD
HORIZONTAL SCALE 1"=40'
VERTICAL SCALE 1"=10'

CONSTRUCTION NOTES

- ① RELOCATE WATER SERVICE LATERAL:
A. IF POLYETHYLENE, REMOVE AND REPLACE PER SPEC'S
B. IF COPPER, REPAIR AND ADJUST
- ② ENCASE SANITARY SEWER WITH 4" MIN. CONC. ENCASEMENT TO 10 FT. MIN. EACH SIDE FROM WATERLINE. SEE SHEET D2
- ③ DEPRESS WATERLINE. SEE DETAIL SHEET D2
- ④ CONNECT TO EXISTING MANHOLE (NO EXISTING STUBOUT) RECONSTRUCT MANHOLE AS REQUIRED.
- ⑤ ABANDON WATERLINE AND APPURTENANCES
- ⑥ RELOCATE 8" WATERLINE TO 30" RT. STA. 90+63 TO STA 94+90
- ⑦ ATTACH EXISTING FIRE HYDRANT TO NEW VALVE
- ⑧ NEW VALVE
- ⑨ CONNECT TO EXISTING WATERLINE
- ⑩ RELOCATE 10" WATERLINE TO 10' RT. STA 116+10 TO STA 122+95
- ⑪ CONNECT EXISTING SERVICE LATERALS TO NEW WATERLINE
- ⑫ GAS RELOCATION BY SW GAS APPROX. STA 116+80 TO STA 161+70 AND STA 164+60 TO STA 167+60
- ⑬ RELOCATE 8" WATERLINE TO 1' LT. STA 161+40 TO STA 167+60
- ⑭ CONNECT EXISTING 6" FIRE HYDRANT LINE TO NEW WATERLINE
- ⑮ CAP AND PLUG
- ⑯ CONCRETE ENCASE ELEC. TELE. OR CATV CONDUITS PER UTILITY CO. STANDARD IF LESS THAN 18" CLEARANCE
- ⑰ CAUTION: THESE ARE ENERGIZED CABLES. A NPC QUALIFIED REPRESENTATIVE MUST BE PRESENT DURING CONSTRUCTION IN OR AROUND THIS EQUIPMENT. CALL 657-4117 FOR AN APPOINTMENT 48 HOURS PRIOR.

Call
before you
Dig.
1-800-227-2800
Residential Service Dept.

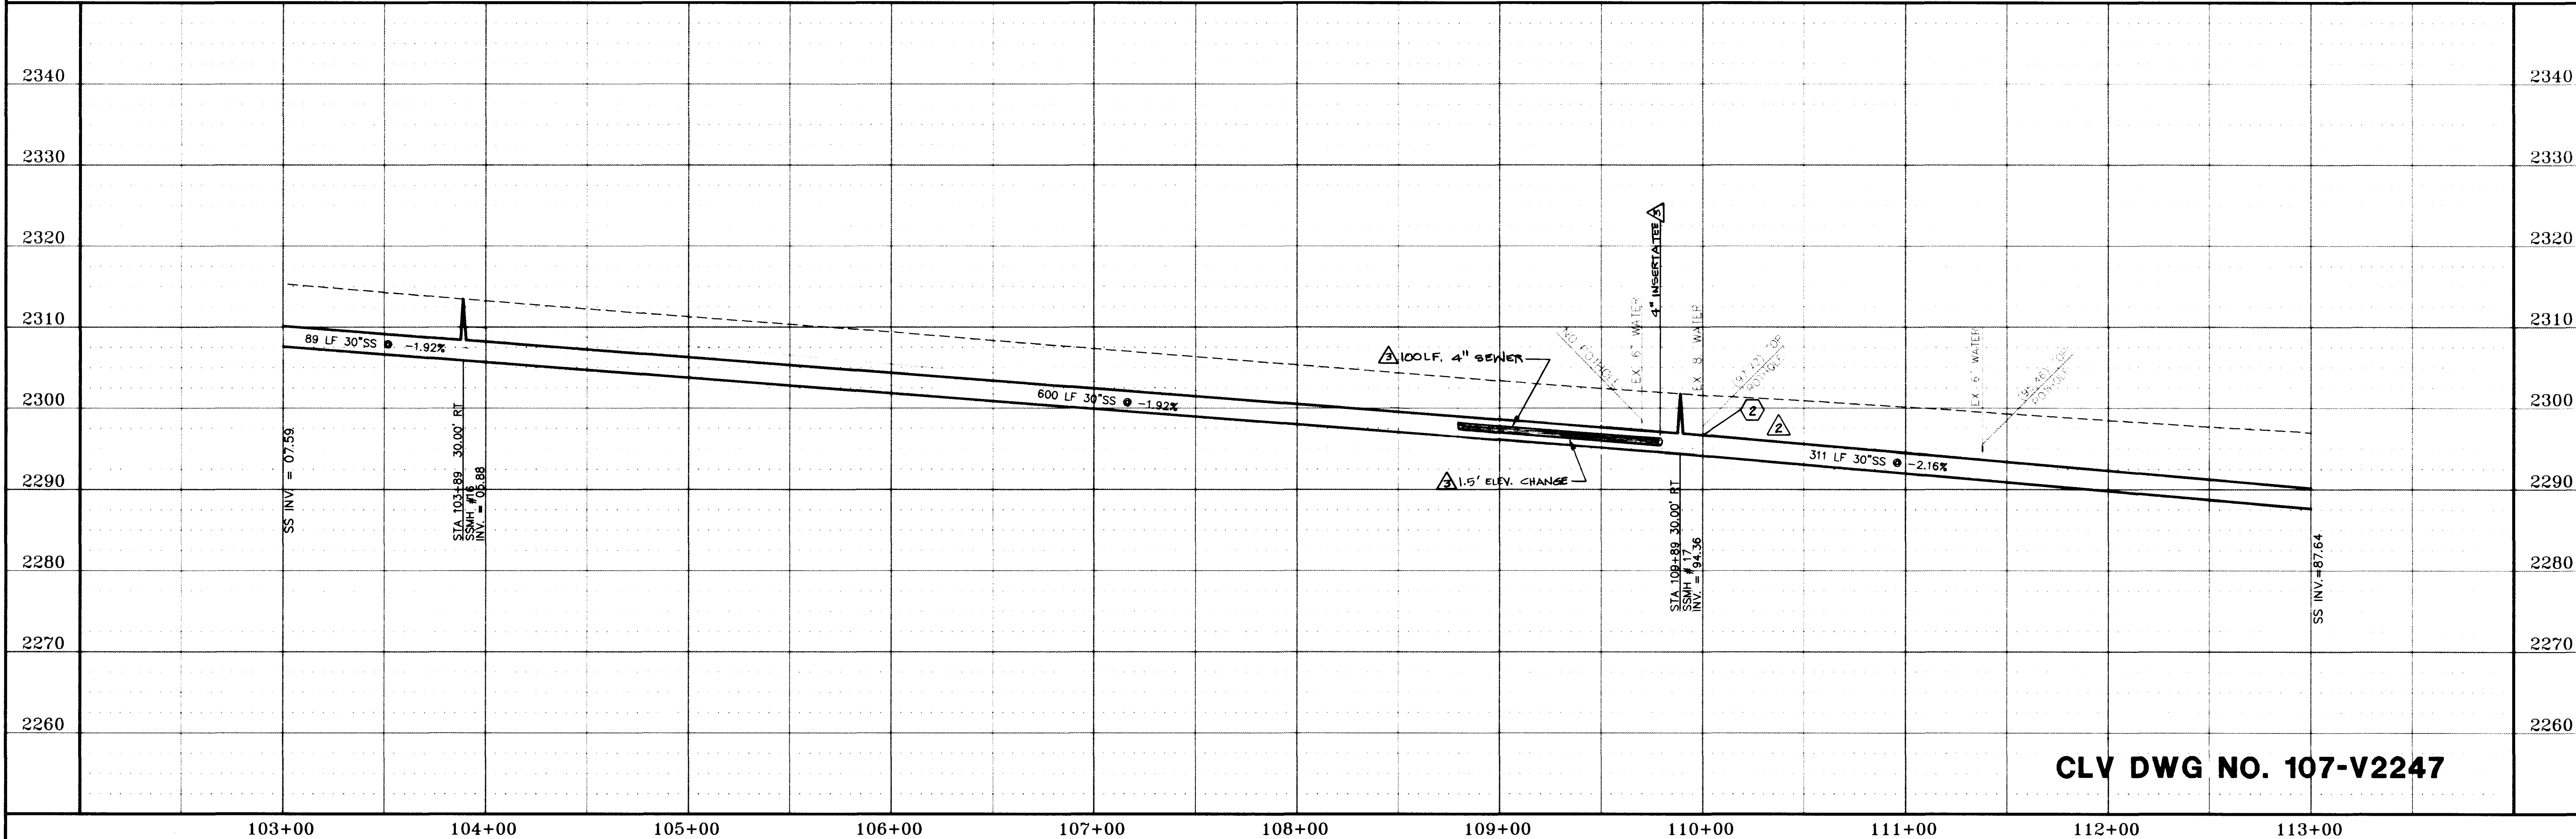

CLV DWG NO. 107-V2247

AS BUILT

REVISIONS
NO. DESCRIPTION/DATE BY
1 REVISED BY CLV 11-01-95
2 AS-BUILT

1100 GRIER DRIVE
LAS VEGAS, NEVADA 89119
PHONE (702) 361-9050
FAX (702) 361-0659
Incorporated


CONSULTING ENGINEERS

NEVADA
CLARK COUNTY
CITY OF LAS VEGAS

SEWER PLAN AND PROFILE
FROM STA. 103+00 TO STA. 113+00
OAKEY BOULEVARD
RAINBOW BLVD. TO DECATUR BLVD.

JOB NO.: 2-241-073
ACAD FILE: OAKES05
DESIGNED: DP
DRAWN: TL
CHECKED: TL
DATE: JUNE 1995

SS5
40 OF 62 SHEETS

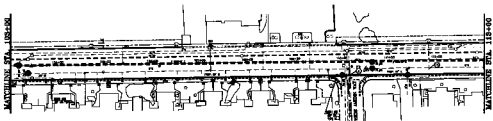


SEE SHEET 118-00 FOR PREVIOUS STATIONING

OAKLEY BOULEVARD

SECTION 118-00

- GENERAL NOTES:**
1. ALL WORK SHALL BE IN ACCORDANCE WITH THE LATEST EDITIONS OF THE CALIFORNIA STANDARD SPECIFICATIONS FOR HIGHWAY CONSTRUCTION, DIVISION 1, AND THE LATEST EDITIONS OF THE CALIFORNIA STANDARD SPECIFICATIONS FOR HIGHWAY MATERIALS, DIVISION 2.
 2. THE CONTRACTOR SHALL BE RESPONSIBLE FOR OBTAINING ALL NECESSARY PERMITS FROM THE APPROPRIATE AGENCIES.
 3. THE CONTRACTOR SHALL BE RESPONSIBLE FOR OBTAINING ALL NECESSARY EASEMENTS FROM THE PROPERTY OWNERS.
 4. THE CONTRACTOR SHALL BE RESPONSIBLE FOR OBTAINING ALL NECESSARY UTILITIES INFORMATION FROM THE APPROPRIATE UTILITIES COMPANIES.
 5. THE CONTRACTOR SHALL BE RESPONSIBLE FOR OBTAINING ALL NECESSARY RIGHT-OF-WAY INFORMATION FROM THE APPROPRIATE AGENCIES.
 6. THE CONTRACTOR SHALL BE RESPONSIBLE FOR OBTAINING ALL NECESSARY CONSTRUCTION PERMITS FROM THE APPROPRIATE AGENCIES.
 7. THE CONTRACTOR SHALL BE RESPONSIBLE FOR OBTAINING ALL NECESSARY CONSTRUCTION PERMITS FROM THE APPROPRIATE AGENCIES.
 8. THE CONTRACTOR SHALL BE RESPONSIBLE FOR OBTAINING ALL NECESSARY CONSTRUCTION PERMITS FROM THE APPROPRIATE AGENCIES.
 9. THE CONTRACTOR SHALL BE RESPONSIBLE FOR OBTAINING ALL NECESSARY CONSTRUCTION PERMITS FROM THE APPROPRIATE AGENCIES.
 10. THE CONTRACTOR SHALL BE RESPONSIBLE FOR OBTAINING ALL NECESSARY CONSTRUCTION PERMITS FROM THE APPROPRIATE AGENCIES.

Cell
History
DLS
11/11/2011

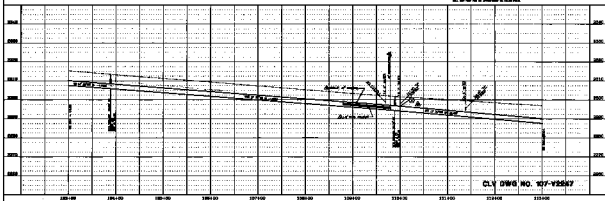

CLV DWG NO. 107-22267

SEWER PLAN AND PROFILE
FROM 118+00 TO 119+00
STATIONING IN FEET
118+00 118+100 118+200 118+300 118+400 118+500 118+600 118+700 118+800 118+900 119+00

555

AS BUILT

Arg-410