


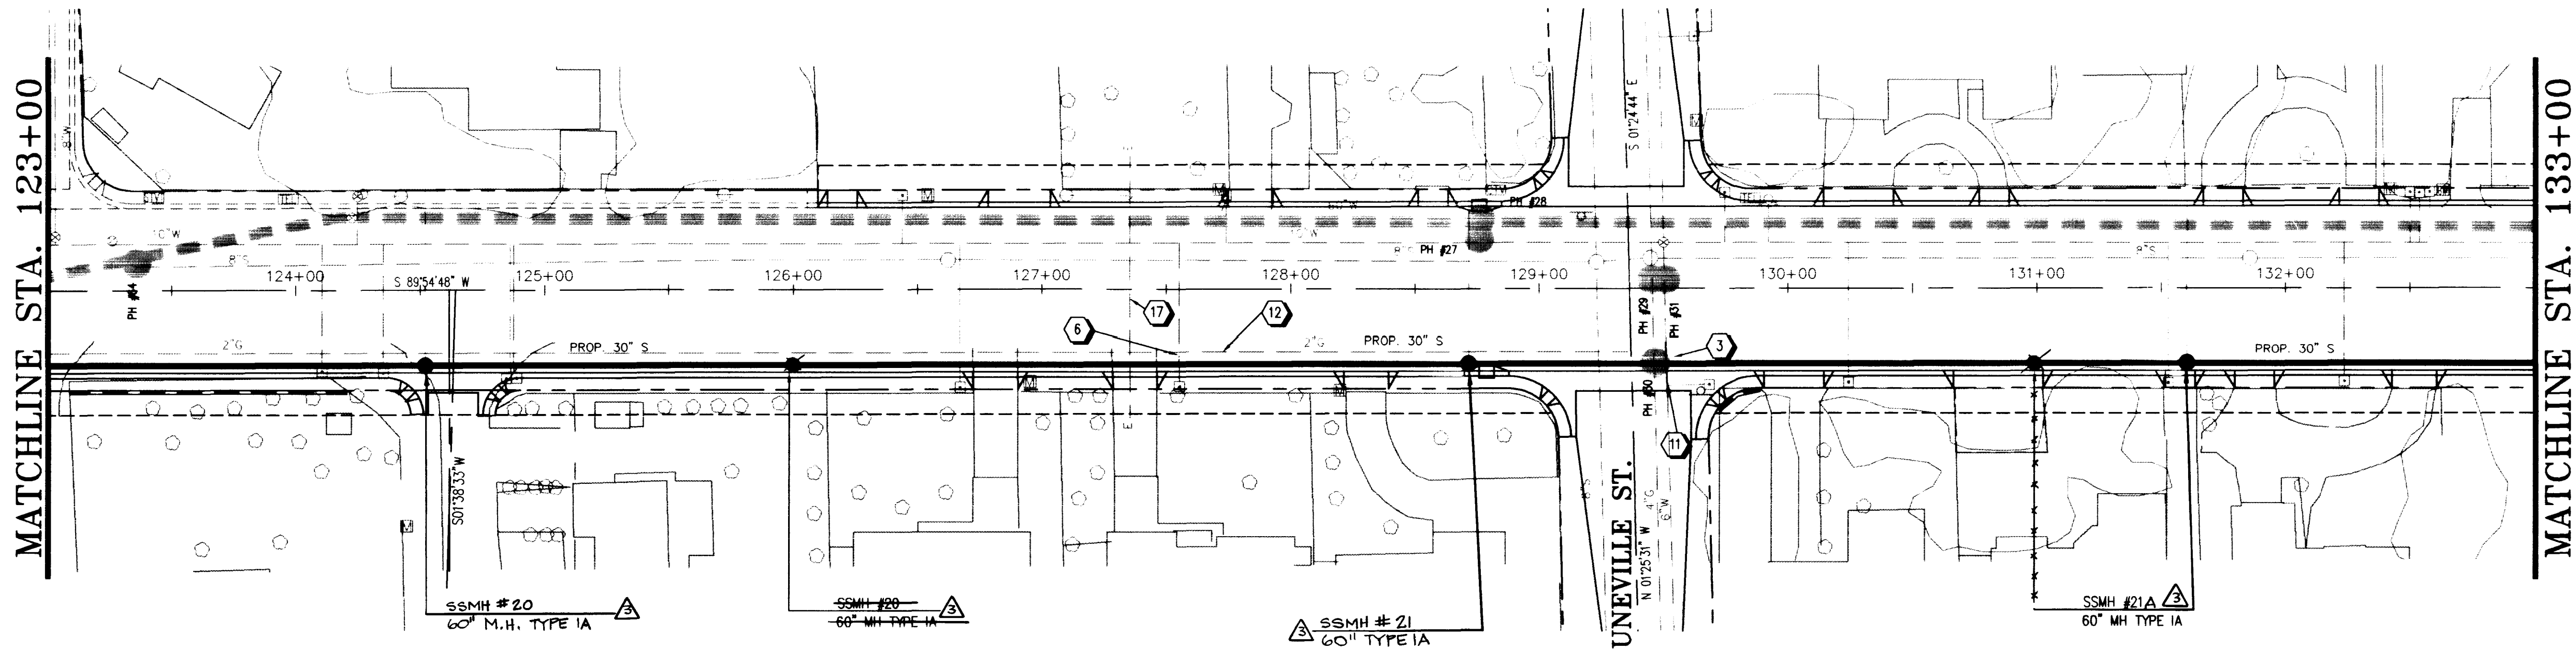

NOTE:
1. REFERENCE POTHOLE TABLE ON SHEET 2.


Oakey Boulevard

HORIZONTAL SCALE 1"=40'
VERTICAL SCALE 1"=10'

CONSTRUCTION NOTES

- ① RELOCATE WATER SERVICE LATERAL:
A. IF POLYETHYLENE, REMOVE AND REPLACE PER SPEC'S
B. IF COPPER, REPAIR AND ADJUST
- ② ENCASE SANITARY SEWER WITH 4" MIN. CONC. ENCASEMENT TO 10 FT. MIN. EACH SIDE FROM WATERLINE. SEE SHEET D2.
- ③ DEPRESS WATERLINE. SEE DETAIL SHEET D2
- ④ CONNECT TO EXISTING MANHOLE (NO EXISTING STUBOUT) RECONSTRUCT MANHOLE AS REQUIRED.
- ⑤ ABANDON WATERLINE AND APPURTENANCES
- ⑥ RELOCATE 8" WATERLINE TO 30" RT. STA. 90+63 TO STA 94+90
- ⑦ ATTACH EXISTING FIRE HYDRANT TO NEW VALVE
- ⑧ NEW VALVE
- ⑨ CONNECT TO EXISTING WATERLINE
- ⑩ RELOCATE 10" WATERLINE TO 10" RT. STA 116+10 TO STA 122+95
- ⑪ CONNECT EXISTING SERVICE LATERALS TO NEW WATERLINE
- ⑫ GAS RELOCATION BY SW GAS APPROX. STA 116+80 TO STA 161+70 AND STA 164+60 TO STA 167+60
- ⑬ RELOCATE 8" WATERLINE TO 1' LT. STA 161+40 TO STA 167+60
- ⑭ CONNECT EXISTING 6" FIRE HYDRANT LINE TO NEW WATERLINE
- ⑮ CAP AND PLUG
- ⑯ CONCRETE ENCASE ELEC, TELE, OR CATV CONDUITS PER UTILITY CO. STANDARD IF LESS THAN 18" CLEARANCE
- ⑰ CAUTION: THESE ARE ENERGIZED CABLES. A NPC QUALIFIED REPRESENTATIVE MUST BE PRESENT DURING CONSTRUCTION IN OR AROUND THIS EQUIPMENT. CALL 657-4117 FOR AN APPOINTMENT 48 HOURS PRIOR.

Call
before you
Dig.
1-800-227-2600
UNDERGROUND SERVICE ALERT (USA)

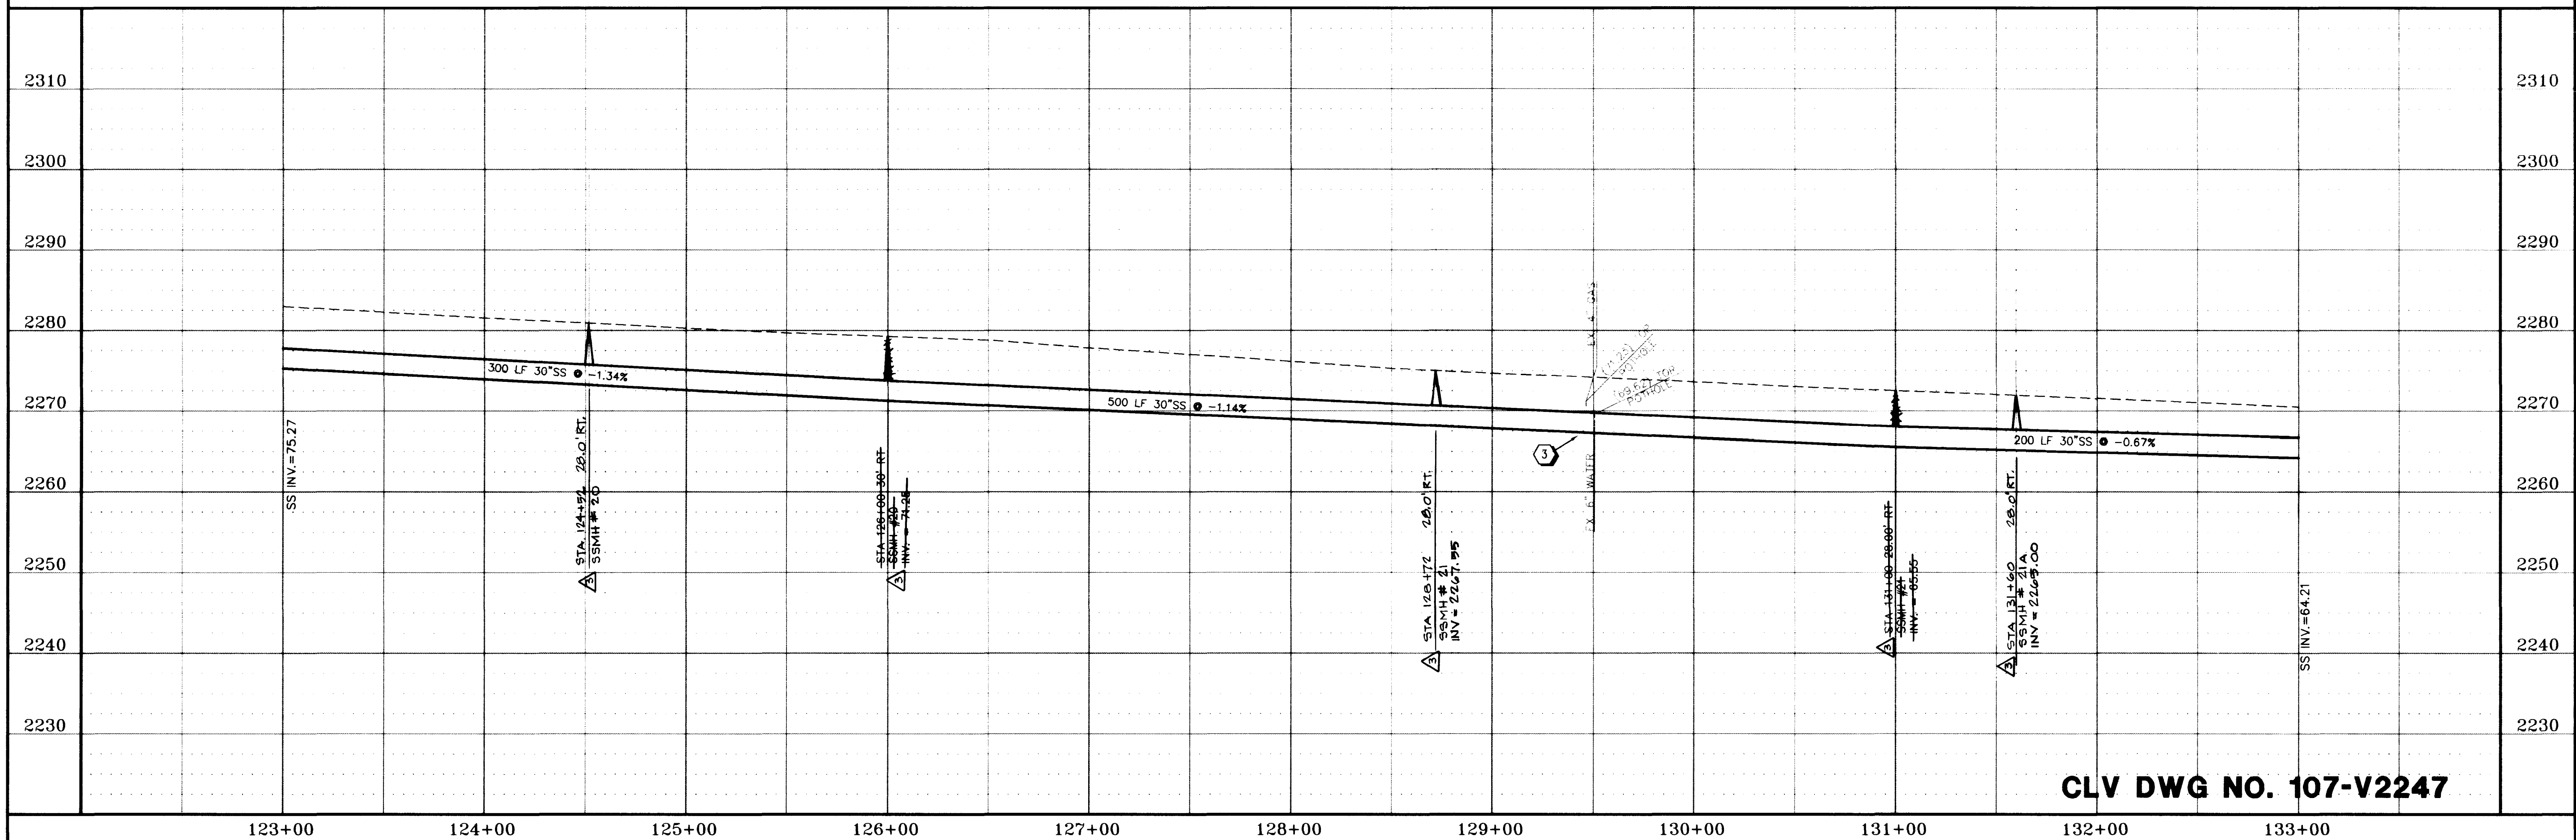

CLV DWG NO. 107-V2247


AS BUILT

SS7


SEWER PLAN AND PROFILE
FROM STA. 123+00 TO STA. 133+00
Oakey Boulevard
RAINBOW BLVD. TO DECATUR BLVD.

JOB NO. 2-241-073
ACAD FILE: OAKESS07
DESIGNED: DP
DRAWN: TL
CHECKED: TL
DATE: JUNE 1995

1100 GRIER DRIVE
LAS VEGAS, NEVADA 89119
PHONE (702) 361-9050
FAX (702) 361-0859
Incorporated
SS7
CONSULTING ENGINEERS

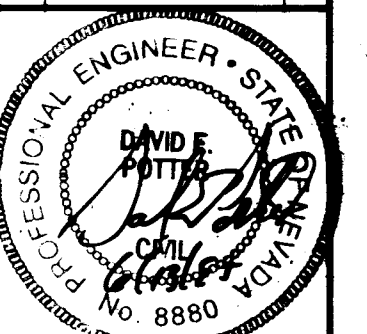

NO.	REVISIONS	DESCRIPTION/DATE	BY
1	REVISED BY CLV	11-01-95	AS - BUILT

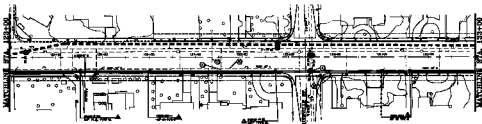

OAKLEY BOULEVARD

SECTION 101

CONSTRUCTION NOTES

1. ALL CONSTRUCTION SHALL BE IN ACCORDANCE WITH THE LATEST EDITIONS OF THE STANDARD SPECIFICATIONS FOR HIGHWAY CONSTRUCTION, AS ADOPTED BY THE BOARD OF SUPERVISORS.
2. THE SEWER SHALL BE CONSTRUCTED IN ACCORDANCE WITH THE LATEST EDITIONS OF THE STANDARD SPECIFICATIONS FOR SEWER CONSTRUCTION, AS ADOPTED BY THE BOARD OF SUPERVISORS.
3. THE SEWER SHALL BE CONSTRUCTED IN ACCORDANCE WITH THE LATEST EDITIONS OF THE STANDARD SPECIFICATIONS FOR SEWER CONSTRUCTION, AS ADOPTED BY THE BOARD OF SUPERVISORS.
4. THE SEWER SHALL BE CONSTRUCTED IN ACCORDANCE WITH THE LATEST EDITIONS OF THE STANDARD SPECIFICATIONS FOR SEWER CONSTRUCTION, AS ADOPTED BY THE BOARD OF SUPERVISORS.
5. THE SEWER SHALL BE CONSTRUCTED IN ACCORDANCE WITH THE LATEST EDITIONS OF THE STANDARD SPECIFICATIONS FOR SEWER CONSTRUCTION, AS ADOPTED BY THE BOARD OF SUPERVISORS.
6. THE SEWER SHALL BE CONSTRUCTED IN ACCORDANCE WITH THE LATEST EDITIONS OF THE STANDARD SPECIFICATIONS FOR SEWER CONSTRUCTION, AS ADOPTED BY THE BOARD OF SUPERVISORS.
7. THE SEWER SHALL BE CONSTRUCTED IN ACCORDANCE WITH THE LATEST EDITIONS OF THE STANDARD SPECIFICATIONS FOR SEWER CONSTRUCTION, AS ADOPTED BY THE BOARD OF SUPERVISORS.
8. THE SEWER SHALL BE CONSTRUCTED IN ACCORDANCE WITH THE LATEST EDITIONS OF THE STANDARD SPECIFICATIONS FOR SEWER CONSTRUCTION, AS ADOPTED BY THE BOARD OF SUPERVISORS.
9. THE SEWER SHALL BE CONSTRUCTED IN ACCORDANCE WITH THE LATEST EDITIONS OF THE STANDARD SPECIFICATIONS FOR SEWER CONSTRUCTION, AS ADOPTED BY THE BOARD OF SUPERVISORS.
10. THE SEWER SHALL BE CONSTRUCTED IN ACCORDANCE WITH THE LATEST EDITIONS OF THE STANDARD SPECIFICATIONS FOR SEWER CONSTRUCTION, AS ADOPTED BY THE BOARD OF SUPERVISORS.

Call
before you
dig

STATION	128+00	128+10	128+20	128+30	128+40	128+50	128+60	128+70	128+80	128+90	129+00
128+00	128+00	128+00	128+00	128+00	128+00	128+00	128+00	128+00	128+00	128+00	128+00
128+10	128+10	128+10	128+10	128+10	128+10	128+10	128+10	128+10	128+10	128+10	128+10
128+20	128+20	128+20	128+20	128+20	128+20	128+20	128+20	128+20	128+20	128+20	128+20
128+30	128+30	128+30	128+30	128+30	128+30	128+30	128+30	128+30	128+30	128+30	128+30
128+40	128+40	128+40	128+40	128+40	128+40	128+40	128+40	128+40	128+40	128+40	128+40
128+50	128+50	128+50	128+50	128+50	128+50	128+50	128+50	128+50	128+50	128+50	128+50
128+60	128+60	128+60	128+60	128+60	128+60	128+60	128+60	128+60	128+60	128+60	128+60
128+70	128+70	128+70	128+70	128+70	128+70	128+70	128+70	128+70	128+70	128+70	128+70
128+80	128+80	128+80	128+80	128+80	128+80	128+80	128+80	128+80	128+80	128+80	128+80
128+90	128+90	128+90	128+90	128+90	128+90	128+90	128+90	128+90	128+90	128+90	128+90
129+00	129+00	129+00	129+00	129+00	129+00	129+00	129+00	129+00	129+00	129+00	129+00

CLV DWG NO. 107-4242

SEWER PLAN AND PROFILE
FROM OAKLEY BOULEVARD
TO MANHOLE 128+00

857

AS BUILT

10-8-95