


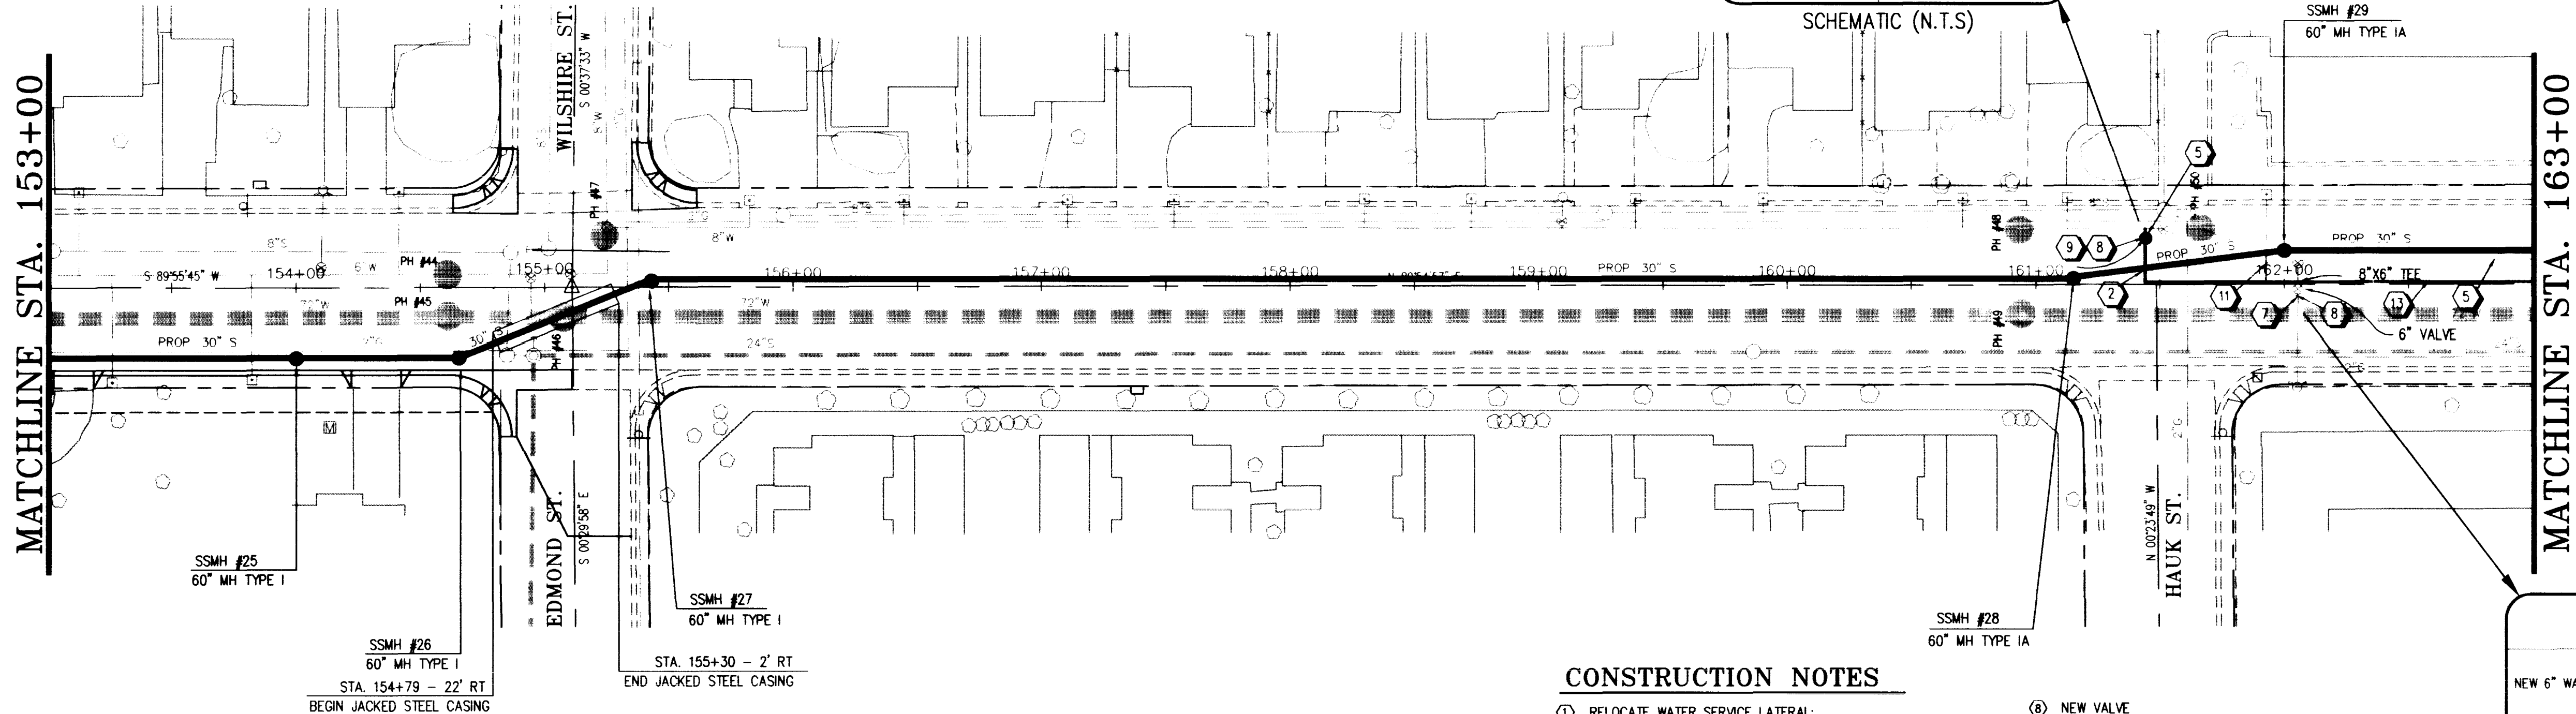

MATCHLINE STA. 153+00




NOTE:
1. REFERENCE POTHOLE TABLE ON SHEET 2.

Oakey Boulevard


HORIZONTAL SCALE 1"=40'
VERTICAL SCALE 1"=10'

CONSTRUCTION NOTES

- ① RELOCATE WATER SERVICE LATERAL:
A. IF POLYETHYLENE, REMOVE AND REPLACE PER SPEC'S
B. IF COPPER, REPAIR AND ADJUST
- ② ENCASE SANITARY SEWER WITH 4" MIN. CONC. ENCASEMENT TO 10 FT. MIN. EACH SIDE FROM WATERLINE - SEE SHEET D2-
- ③ DEPRESS WATERLINE, SEE DETAIL SHEET D2
- ④ CONNECT TO EXISTING MANHOLE (NO EXISTING STUBOUT) RECONSTRUCT MANHOLE AS REQUIRED.
- ⑤ ABANDON WATERLINE AND APPURTENANCES
- ⑥ RELOCATE 8" WATERLINE TO 30" RT. STA. 90+63 TO STA 94+90
- ⑦ ATTACH EXISTING FIRE HYDRANT TO NEW VALVE
- ⑧ NEW VALVE
- ⑨ CONNECT TO EXISTING WATERLINE
- ⑩ RELOCATE 10" WATERLINE TO 10' RT. STA 116+10 TO STA 122+95
- ⑪ CONNECT EXISTING SERVICE LATERALS TO NEW WATERLINE
- ⑫ GAS RELOCATION BY SW GAS APPROX. STA 116+80 TO STA 161+70 AND STA 164+60 TO STA 167+60
- ⑬ RELOCATE 8" WATERLINE TO 1' LT. STA 161+40 TO STA 167+60
- ⑭ CONNECT EXISTING 6" FIRE HYDRANT LINE TO NEW WATERLINE
- ⑮ CAP AND PLUG
- ⑯ CONCRETE ENCASE ELEC. TELE. OR CATV CONDUITS PER UTILITY CO. STANDARD IF LESS THAN 18" CLEARANCE
- ⑰ CAUTION: THESE ARE ENERGIZED CABLES. A NPC QUALIFIED REPRESENTATIVE MUST BE PRESENT DURING CONSTRUCTION IN OR AROUND THIS EQUIPMENT. CALL 657-4117 FOR AN APPOINTMENT 48 HOURS PRIOR.

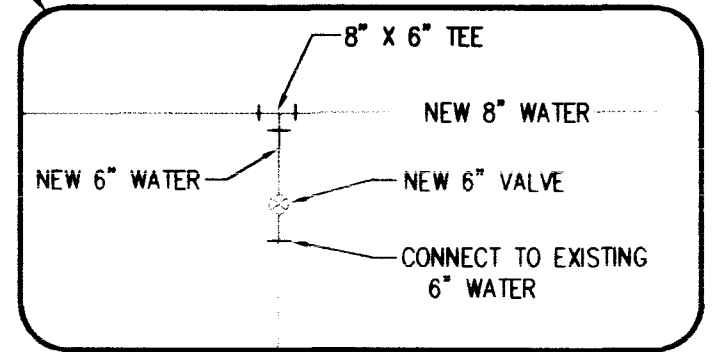


SCHEMATIC (N.T.S.)

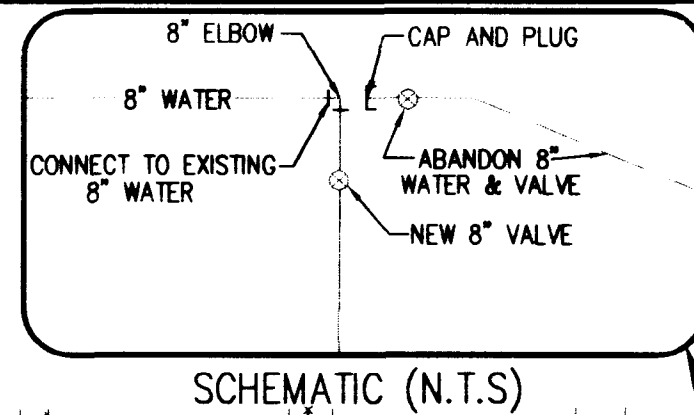


SCHEMATIC (N.T.S.)

Call
before you
Dig.
1-800-227-2600
UNDERGROUND SERVICE ALERT (USA)

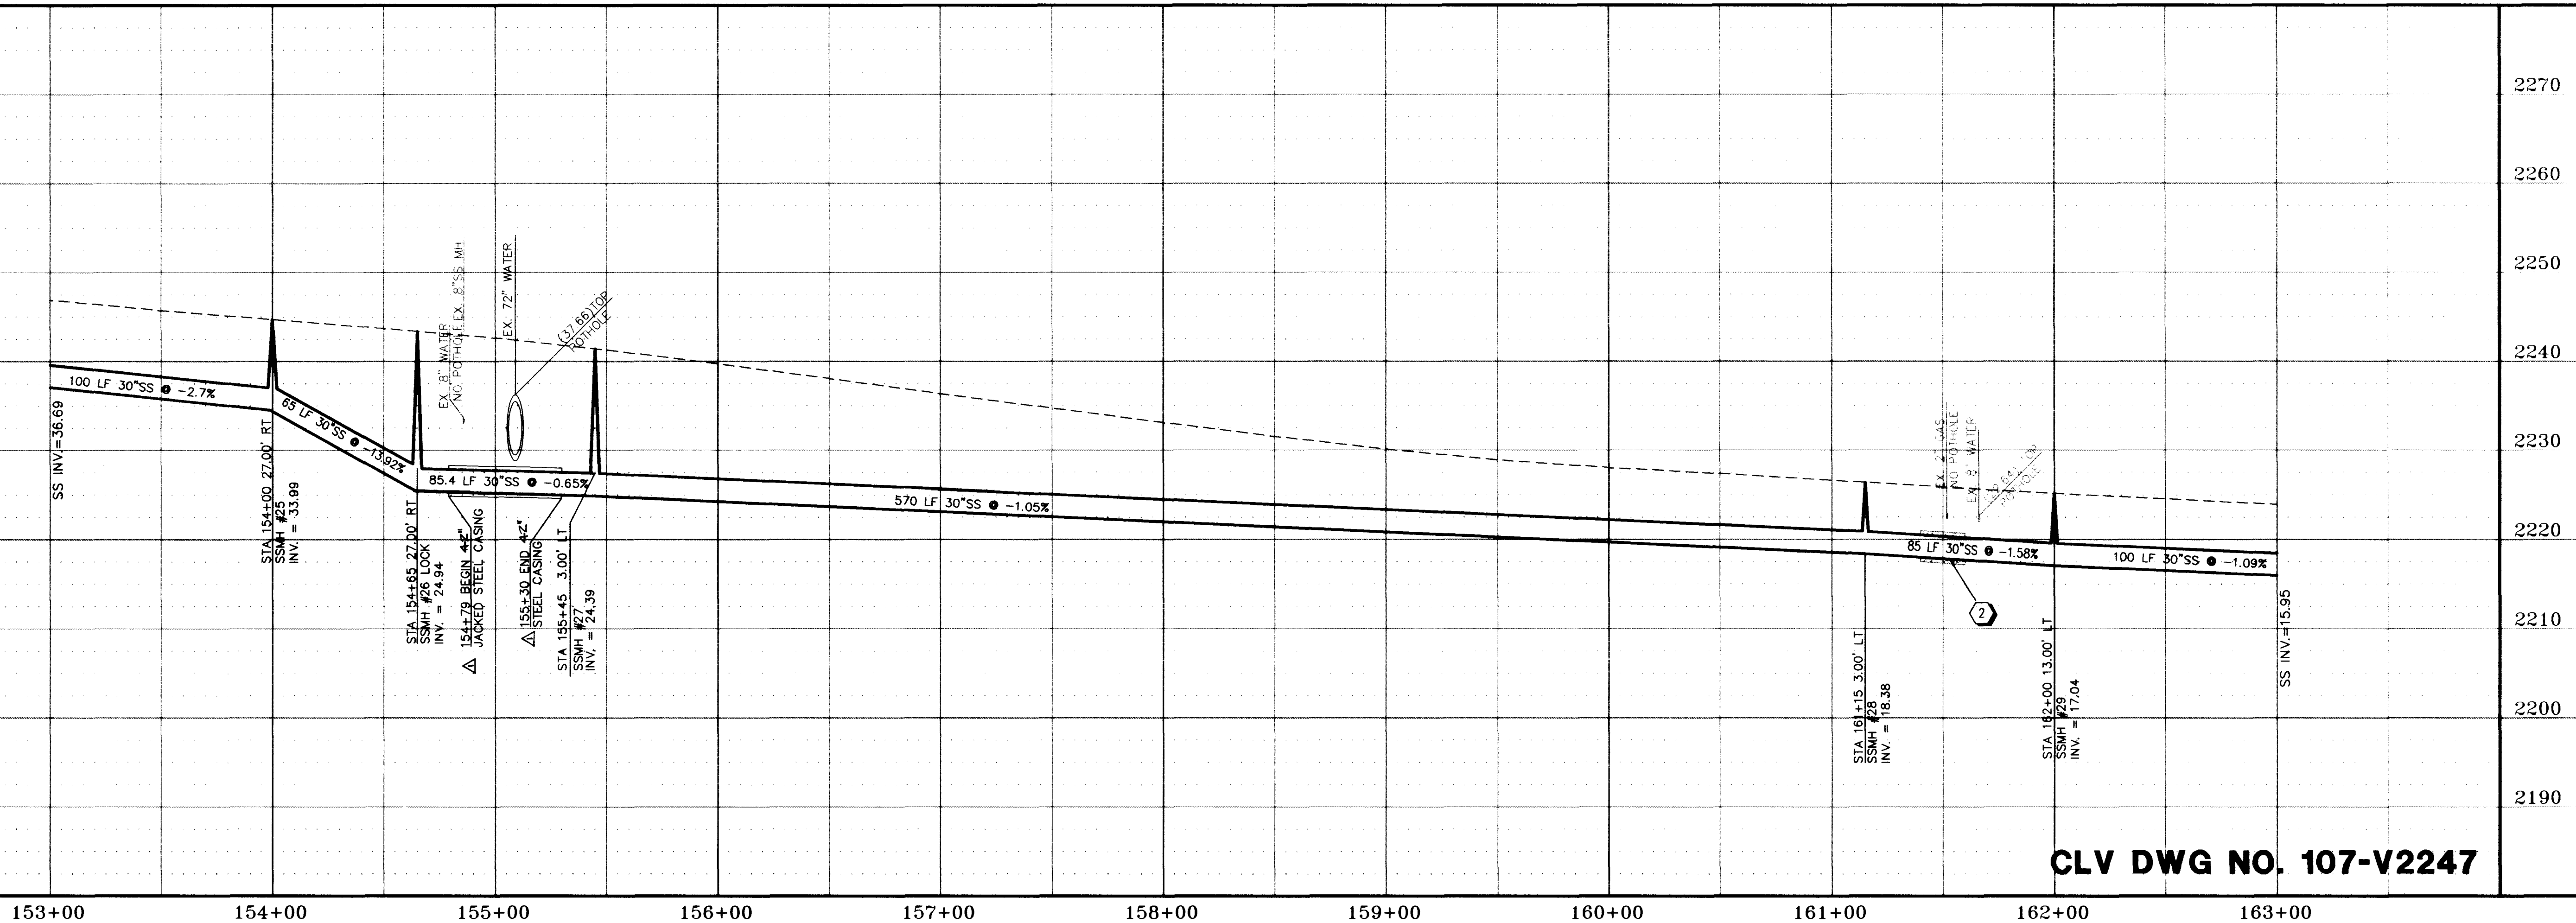

CLV DWG NO. 107-V2247

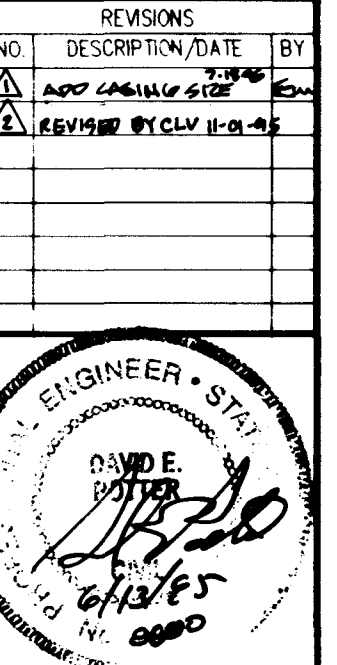


1100 GRER DRIVE
LAS VEGAS, NEVADA 89119
PHONE (702) 361-9050
FAX (702) 361-0659
Incorporated
SS10
CONSULTING ENGINEERS

SEWER PLAN AND PROFILE
FROM STA. 153+00 TO STA. 163+00
Oakey Boulevard
RAINBOW BLVD. TO DECATUR BLVD.

JOB NO. 2-241-073
ACAD FILE OAKES10
DESIGNED: DP
DRAWN: TL
CHECKED: TL
DATE: JUNE 1995

SS10

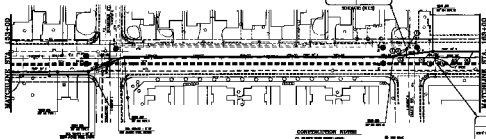

1. EXISTING PROFILE SHOWN IN DASH


OAKLEY BOULEVARD

100' WIDE R.S.

- CONSTRUCTION NOTES**
- 1. EXISTING SEWER LINE TO BE REMOVED AND REPLACED WITH 12" DIA. RCP.
 - 2. EXISTING SEWER LINE TO BE REMOVED AND REPLACED WITH 12" DIA. RCP.
 - 3. EXISTING SEWER LINE TO BE REMOVED AND REPLACED WITH 12" DIA. RCP.
 - 4. EXISTING SEWER LINE TO BE REMOVED AND REPLACED WITH 12" DIA. RCP.
 - 5. EXISTING SEWER LINE TO BE REMOVED AND REPLACED WITH 12" DIA. RCP.
 - 6. EXISTING SEWER LINE TO BE REMOVED AND REPLACED WITH 12" DIA. RCP.
 - 7. EXISTING SEWER LINE TO BE REMOVED AND REPLACED WITH 12" DIA. RCP.
 - 8. EXISTING SEWER LINE TO BE REMOVED AND REPLACED WITH 12" DIA. RCP.
 - 9. EXISTING SEWER LINE TO BE REMOVED AND REPLACED WITH 12" DIA. RCP.
 - 10. EXISTING SEWER LINE TO BE REMOVED AND REPLACED WITH 12" DIA. RCP.

- NOTES**
- 1. SEE PLAN FOR EXISTING SEWER LINE.
 - 2. SEE PLAN FOR EXISTING SEWER LINE.
 - 3. SEE PLAN FOR EXISTING SEWER LINE.
 - 4. SEE PLAN FOR EXISTING SEWER LINE.
 - 5. SEE PLAN FOR EXISTING SEWER LINE.
 - 6. SEE PLAN FOR EXISTING SEWER LINE.
 - 7. SEE PLAN FOR EXISTING SEWER LINE.
 - 8. SEE PLAN FOR EXISTING SEWER LINE.
 - 9. SEE PLAN FOR EXISTING SEWER LINE.
 - 10. SEE PLAN FOR EXISTING SEWER LINE.

Call
before you
Dig

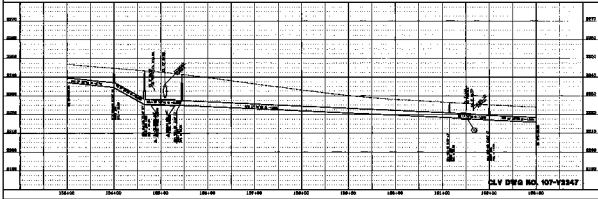

CLV DWG NO. 107-V3247

8810

NO. 107-V3247
100' WIDE R.S.
100' WIDE R.S.
100' WIDE R.S.

SEWER PLAN AND PROFILE
FROM STA. 133+00 TO STA. 163+00
ALONG OAKLEY BOULEVARD, 100' WIDE R.S.

DATE: 10/1/80
BY: [Signature]
CHECKED: [Signature]
APPROVED: [Signature]

8810