



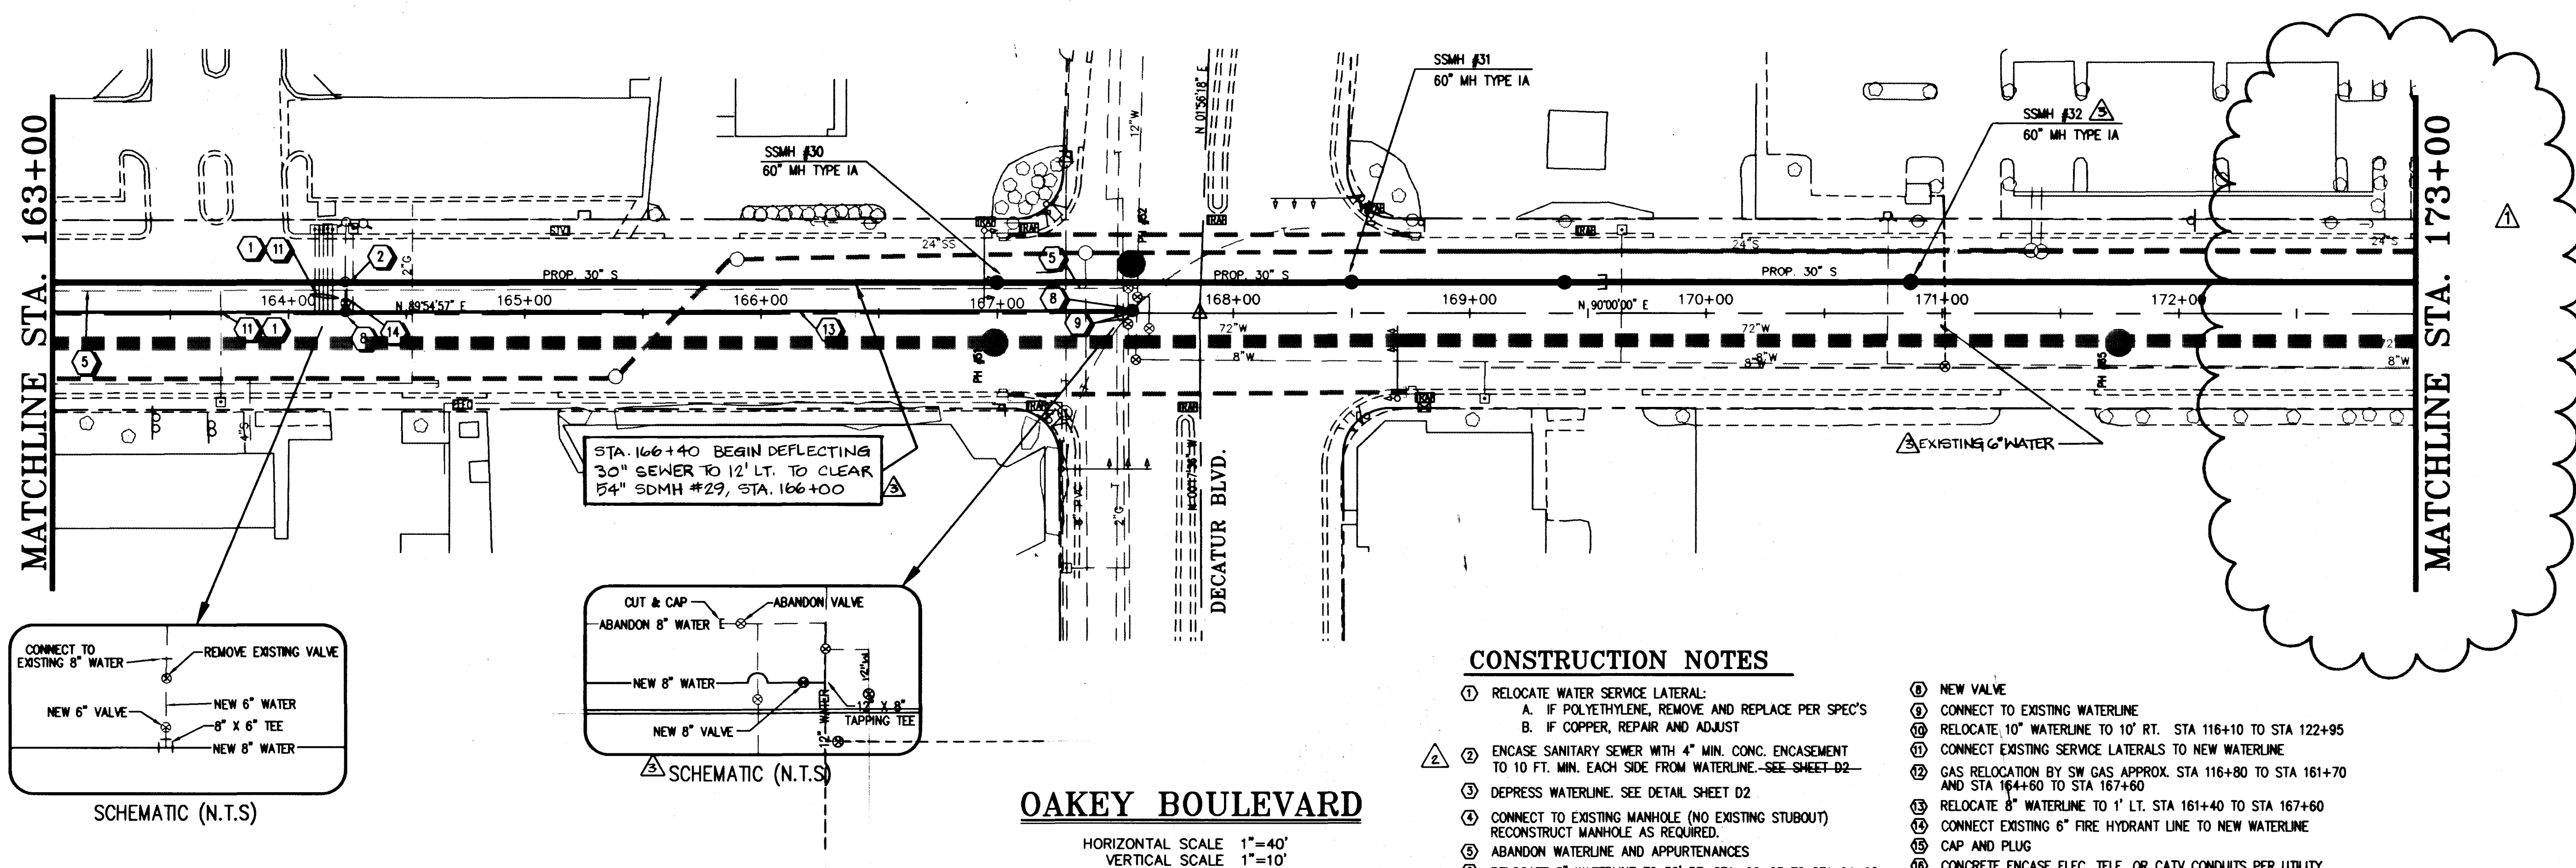

CONSTRUCTION NOTES

1. RELOCATE WATER SERVICE LATERAL:
A. IF POLYETHYLENE, REMOVE AND REPLACE PER SPEC'S
B. IF COPPER, REPAIR AND ADJUST
2. ENCASE SANITARY SEWER WITH 4" MIN. CONC. ENCASEMENT TO 10 FT. MIN. EACH SIDE FROM WATERLINE--SEE SHEET D2--
3. DEPRESS WATERLINE. SEE DETAIL SHEET D2
4. CONNECT TO EXISTING MANHOLE (NO EXISTING STUBOUT) RECONSTRUCT MANHOLE AS REQUIRED.
5. ABANDON WATERLINE AND APPURTENANCES
6. RELOCATE 8" WATERLINE TO 30' RT. STA. 90+63 TO STA 94+60
7. ATTACH EXISTING FIRE HYDRANT TO NEW VALVE
8. NEW VALVE
9. CONNECT TO EXISTING WATERLINE
10. RELOCATE 10" WATERLINE TO 10' RT. STA 116+10 TO STA 122+95
11. CONNECT EXISTING SERVICE LATERALS TO NEW WATERLINE
12. GAS RELOCATION BY SW GAS APPROX. STA 116+80 TO STA 161+70 AND STA 164+80 TO STA 167+60
13. RELOCATE 8" WATERLINE TO 1' LT. STA 161+40 TO STA 167+60
14. CONNECT EXISTING 6" FIRE HYDRANT LINE TO NEW WATERLINE
15. CAP AND PLUG
16. CONCRETE ENCASE ELEC, TELE, OR CATV CONDUITS PER UTILITY CO. STANDARD IF LESS THAN 18" CLEARANCE
17. CAUTION: THESE ARE ENERGIZED CABLES. A NPC QUALIFIED REPRESENTATIVE MUST BE PRESENT DURING CONSTRUCTION IN OR AROUND THIS EQUIPMENT. CALL 657-4117 FOR AN APPOINTMENT 48 HOURS PRIOR.

Call
before you
Dig.
1-800-227-2600
(Nevada Office Only)

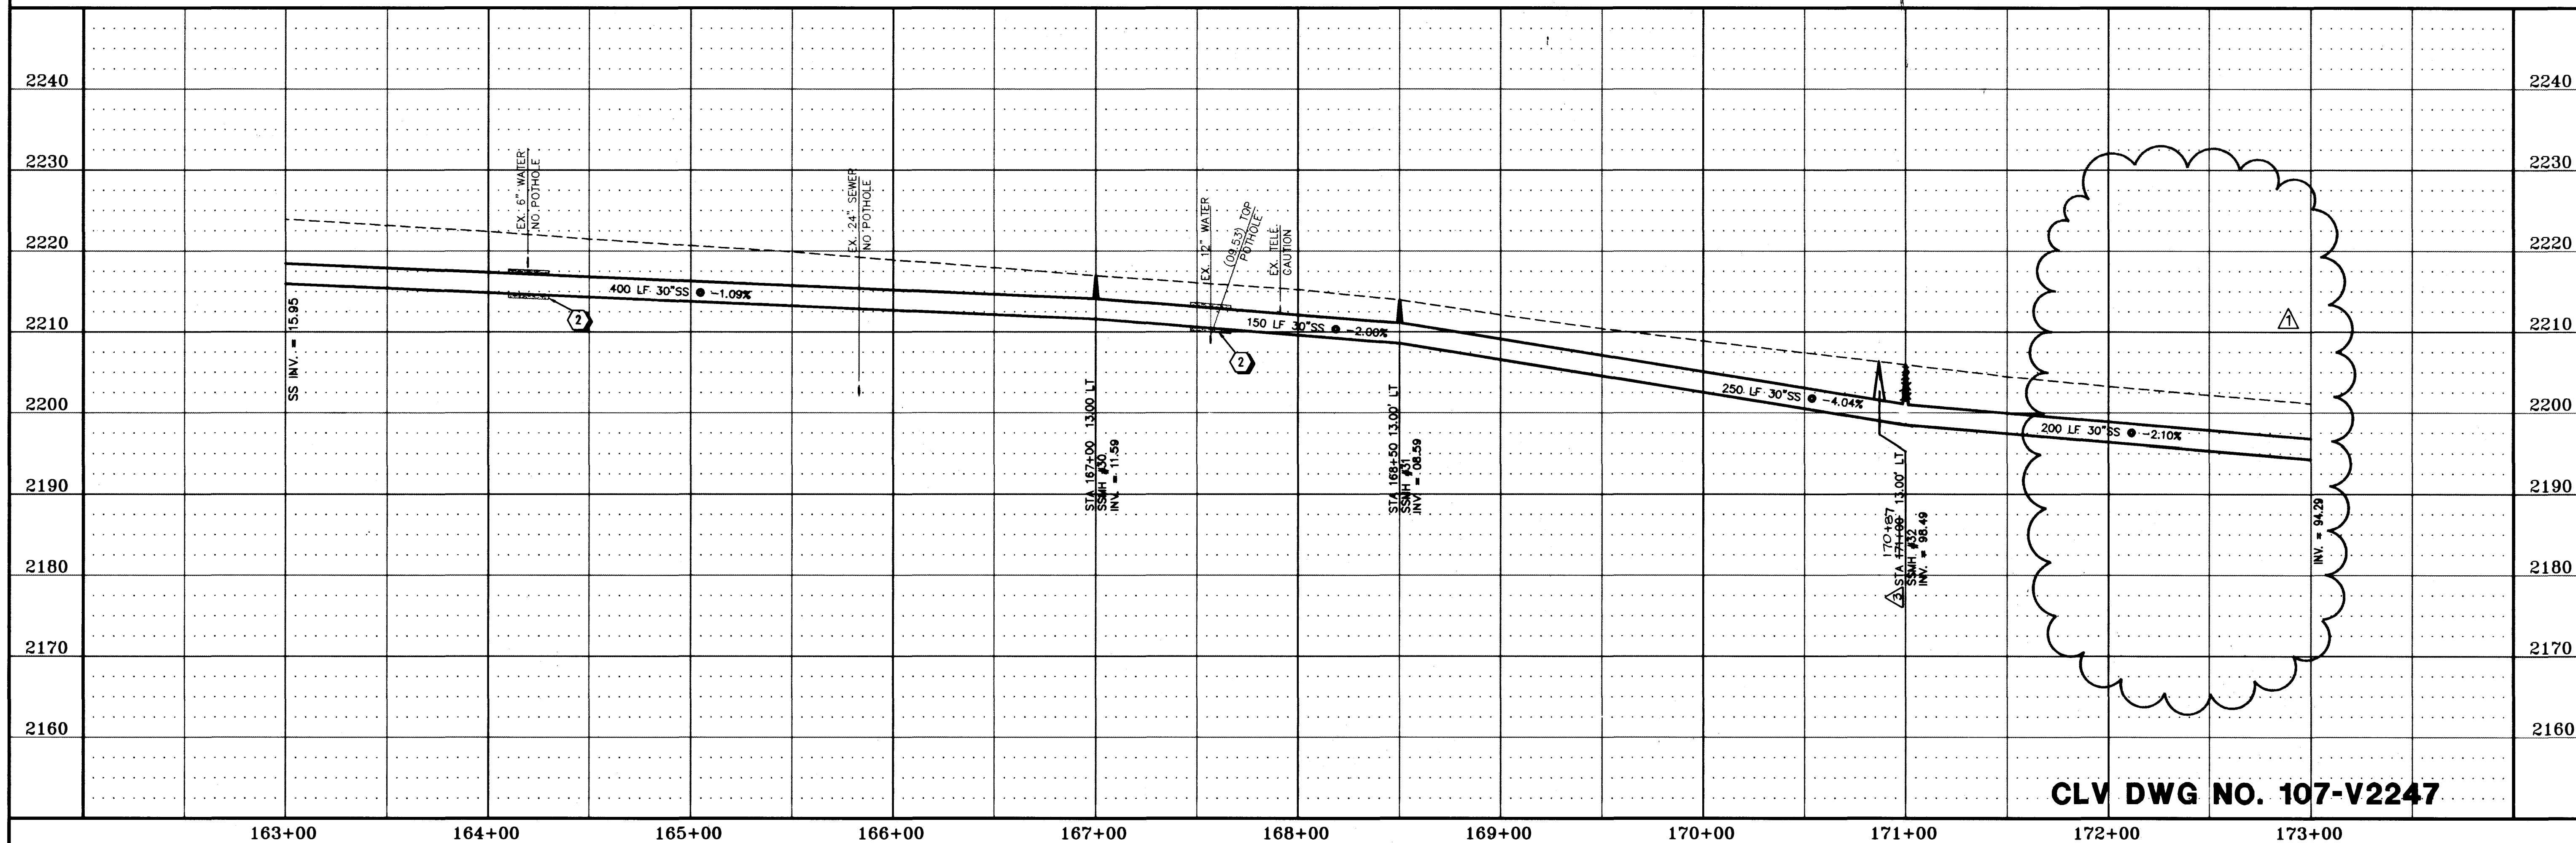

CLV DWG NO. 107-V2247

REVISIONS
NO. DESCRIPTION/DATE BY
1. ADD SEWER 8-22-95 DP
2. REVISED BY CLV 11-01-95
3. AS-BUILT

100 GRIER DRIVE
LAS VEGAS, NEVADA 89119
PHONE (702) 361-9050
FAX (702) 361-0659

INCORPORATED



CONSULTING ENGINEERS

SEWER PLAN AND PROFILE
FROM STA. 163+00 TO STA. 173+00
OAKLEY BOULEVARD
RAINBOW BLVD. TO DECATUR BLVD.

JOB NO.: 2-241-073
ACAD FILE: OAKESS11
DESIGNED: DP
DRAWN: TL
CHECKED: TL
DATE: JUNE 1995

SS11
46 OF 61 SHEETS

CITY OF LAS VEGAS
CLARK COUNTY
NEVADA

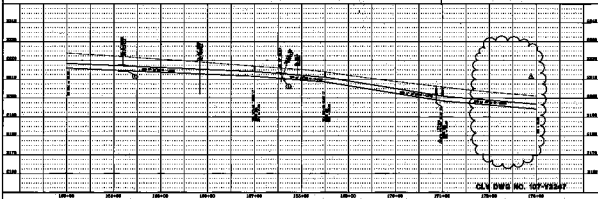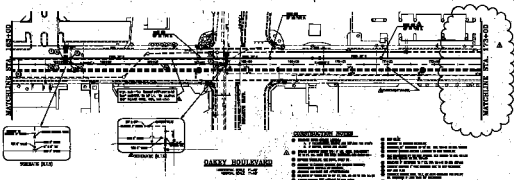

8811

SEWER PLAN AND PROFILE
 FROM ST. 153+00 TO ST. 173+00
 HANCOCK BLVD. TO SEWAGE PLANT

AS BUILT

19-2-98