


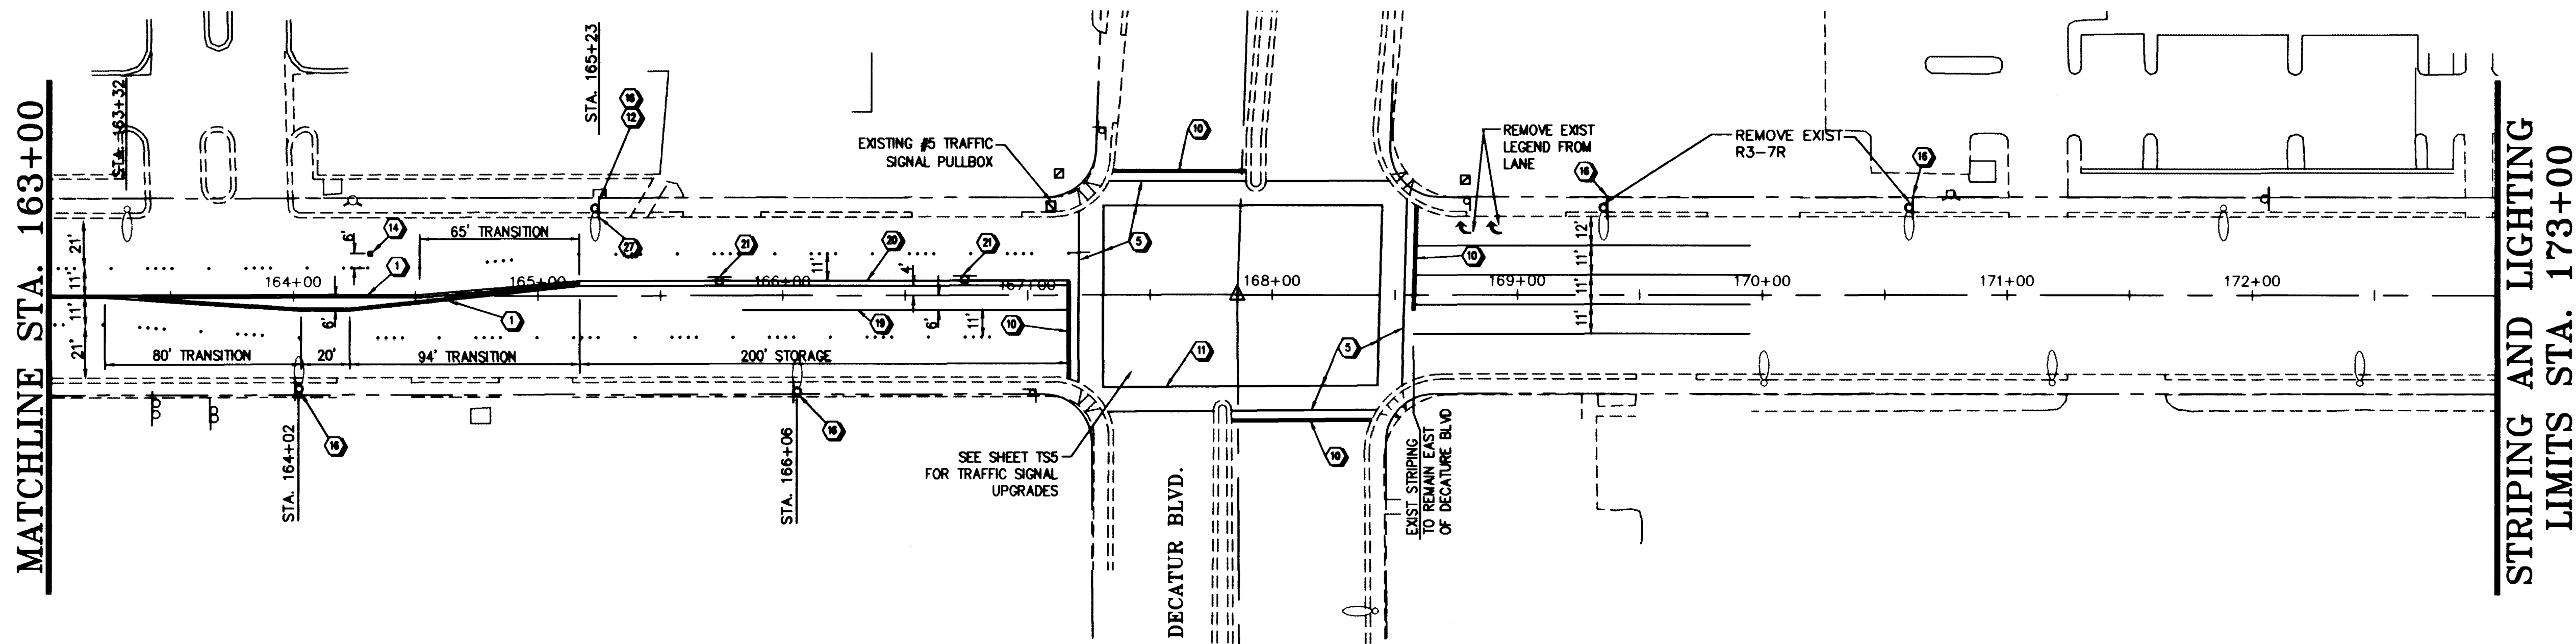

OAKLEY BOULEVARD

STREET LIGHTING NOTES

1. ALL STREET LIGHTS SHALL BE II GAGE SHAFTS WITH 200W HPS LUMINAIRE. ARM LENGTH = 8 FEET. SEE CLARK COUNTY AREA UNIFORM STD. DWGS. NO. 309 AND 318.
2. WHERE IT IS NECESSARY TO CONNECT STREET LIGHTS TO AN EXISTING UNDERGROUND CIRCUIT, THE CONTRACTOR SHALL VERIFY THE EXISTANCE OF A CONDUIT STUB OUT FROM THE POLE FOUNDATION OR LOCATION AT WHICH THE CONNECTION IS TO BE MADE. SHOULD SUCH STUB-OUTS BE MISSING, THE EXISTING FOUNDATION SHALL BE MODIFIED PER CLARK COUNTY AREA UNIFORM STD. DWG. NO. 320.
3. WHERE NEW STREET LIGHTS ARE TO BE ADDED TO AN EXISTING CIRCUIT, THE CONTRACTOR SHALL PROVIDE THE COMPLETE STREET LIGHT FOUNDATION & POLE, CONDUIT AND WIRES. TERMINATION WILL BE MADE BY CITY FORCES.
4. ALL NEW STREETLIGHT FOUNDATION CENTERLINES SHALL BE 4'-0" FROM THE TOP BACK OF CURB.
5. EXISTING STREETLIGHT CRASH CAPS ARE TO BE ADJUSTED (REMOVED & REPLACED) AS REQUIRED, TO MATCH NEW BACK OF SIDEWALK GRADES.
6. ALL LEGENDS AND SYMBOLS SHALL BE WHITE.
7. STREET LIGHT SERIES CIRCUIT WILL BE DISCONNECTED FOR THE CONTRACTOR. CONTACT CITY OF LAS VEGAS ELECTRICAL SERVICES AT 229-6331.
8. STREET LIGHT ELECTRICAL DISCONNECTIONS AND RECONNECTIONS SHALL BE DONE BY CITY FORCES AND COORDINATED WITH CLV ELECTRICAL SERVICES.

CONSTRUCTION NOTES

1. STANDARD TYPE 1 CENTERLINE (YELLOW) PER STD DWG 244
2. STANDARD TYPE 2 CENTERLINE (YELLOW) PER STD DWG 244
3. STANDARD TYPE 5 LANE LINE PER STD DWG 244A
4. NOT USED
5. CONTINUOUS 12" WHITE LINE COLD FORMED POLYMER
6. EXISTING R1-1 WITH STREET NAME SIGNS TO REMAIN
7. EXISTING R1-1 TO REMAIN
8. NEW STANDARD STREET NAME SIGN SEE CLARK COUNTY AREA UNIFORM STD. DWGS 249, 250 & 251
9. NEW R1-1
10. CONTINUOUS 24" WHITE STOP BAR, 4' BEHIND CROSSWALK COLD FORMED POLYMER
11. 10' CROSSWALKS LOCATED PER CLARK COUNTY AREA UNIFORM STD. DWGS 254
12. EXISTING CAT TRANSIT SYSTEM SIGN TO REMAIN
13. EXISTING R8-3A TO REMAIN
14. NEW 2-WAY BLUE REFLECTIVE MARKER, CENTERED IN DRIVING LANE
15. REPLACE R2-1(25) WITH NEW R2-1(35)
16. NEW R8-3A WITH R7-IAP PLACARD-BANDED TO STREETLIGHT POLE
17. NEW R7-IAP PLACARD-BANDED TO STREET LIGHT POLE BELOW EXISTING R8-3A
18. INSTALL NEW R1-3 SUPPLEMENTARY PLATE
19. 133 FT OF LANE MARKING SEE CLARK COUNTY AREA STD DWG 246
20. TACK ON ISLAND CURB PER CLV MODIFIED STD DWG 220-A LENGTH = 200' WIDTH = 1' FILL GAP WITH 6" CONCRETE
21. NEW R6-1R WITH POST AND FOUNDATION
22. CONTINUOUS 24" WHITE COLD FORMED POLYMER AT LANE LINES AND LANE CENTERS
23. REMOVE EXISTING SIGN, POST, AND FOUNDATION
24. NEW S2-1 WITH POST AND FOUNDATION
25. REPLACE R1-1 WITH NEW S2-1
26. NEW C.A.T. SIGN
27. INSTALL NEW PHOTOELECTRIC CONTROL PER STD. DWG. 327

Call
before you
Dig.
1-800-227-2800

CLV DWG NO. 107-V2247

REVISIONS		
NO.	DESCRIPTION/DATE	BY
1	REVISED 9-2-95	JB

100 GRIER DRIVE
LAS VEGAS, NEVADA 89119
PHONE (702) 361-9050
FAX (702) 361-0659

SEI
CONSULTING ENGINEERS

Professional Engineer Seal: HAROLD R. BIRD, CIVIL, No. 10582, EXPIRATION DATE 2-5-95

STRIPING AND STREET LIGHTING PLAN
FROM STA. 163+00 TO STA. 173+00
OAKLEY BOULEVARD
RAINBOW BLVD. TO DECATUR BLVD.


JOB NO.:	2-241-073
ACAD FILE:	OAKELS06
DESIGNED:	J.B.
DRAWN:	T.H.
CHECKED:	D.P.
DATE:	JUNE 1995

T6
30 OF 62 SHEETS

AS BUILT

106

18-2-81

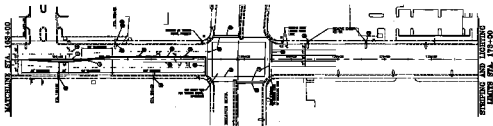**QAINCY_HOULSTYARD**

CLV DWG NO. 907-V2247

AS NOTED

STRAPPING AND STREET LIGHTING PLAN
FROM ST. JAMES TO E. 17th
STREET, MILWAUKEE
RAMPAGE BLVD. TO INDIAN BLVD.

T6