


Call before
you Dig
1-800-227-2600

BUFFALO DRIVE
(PUBLIC STREET)

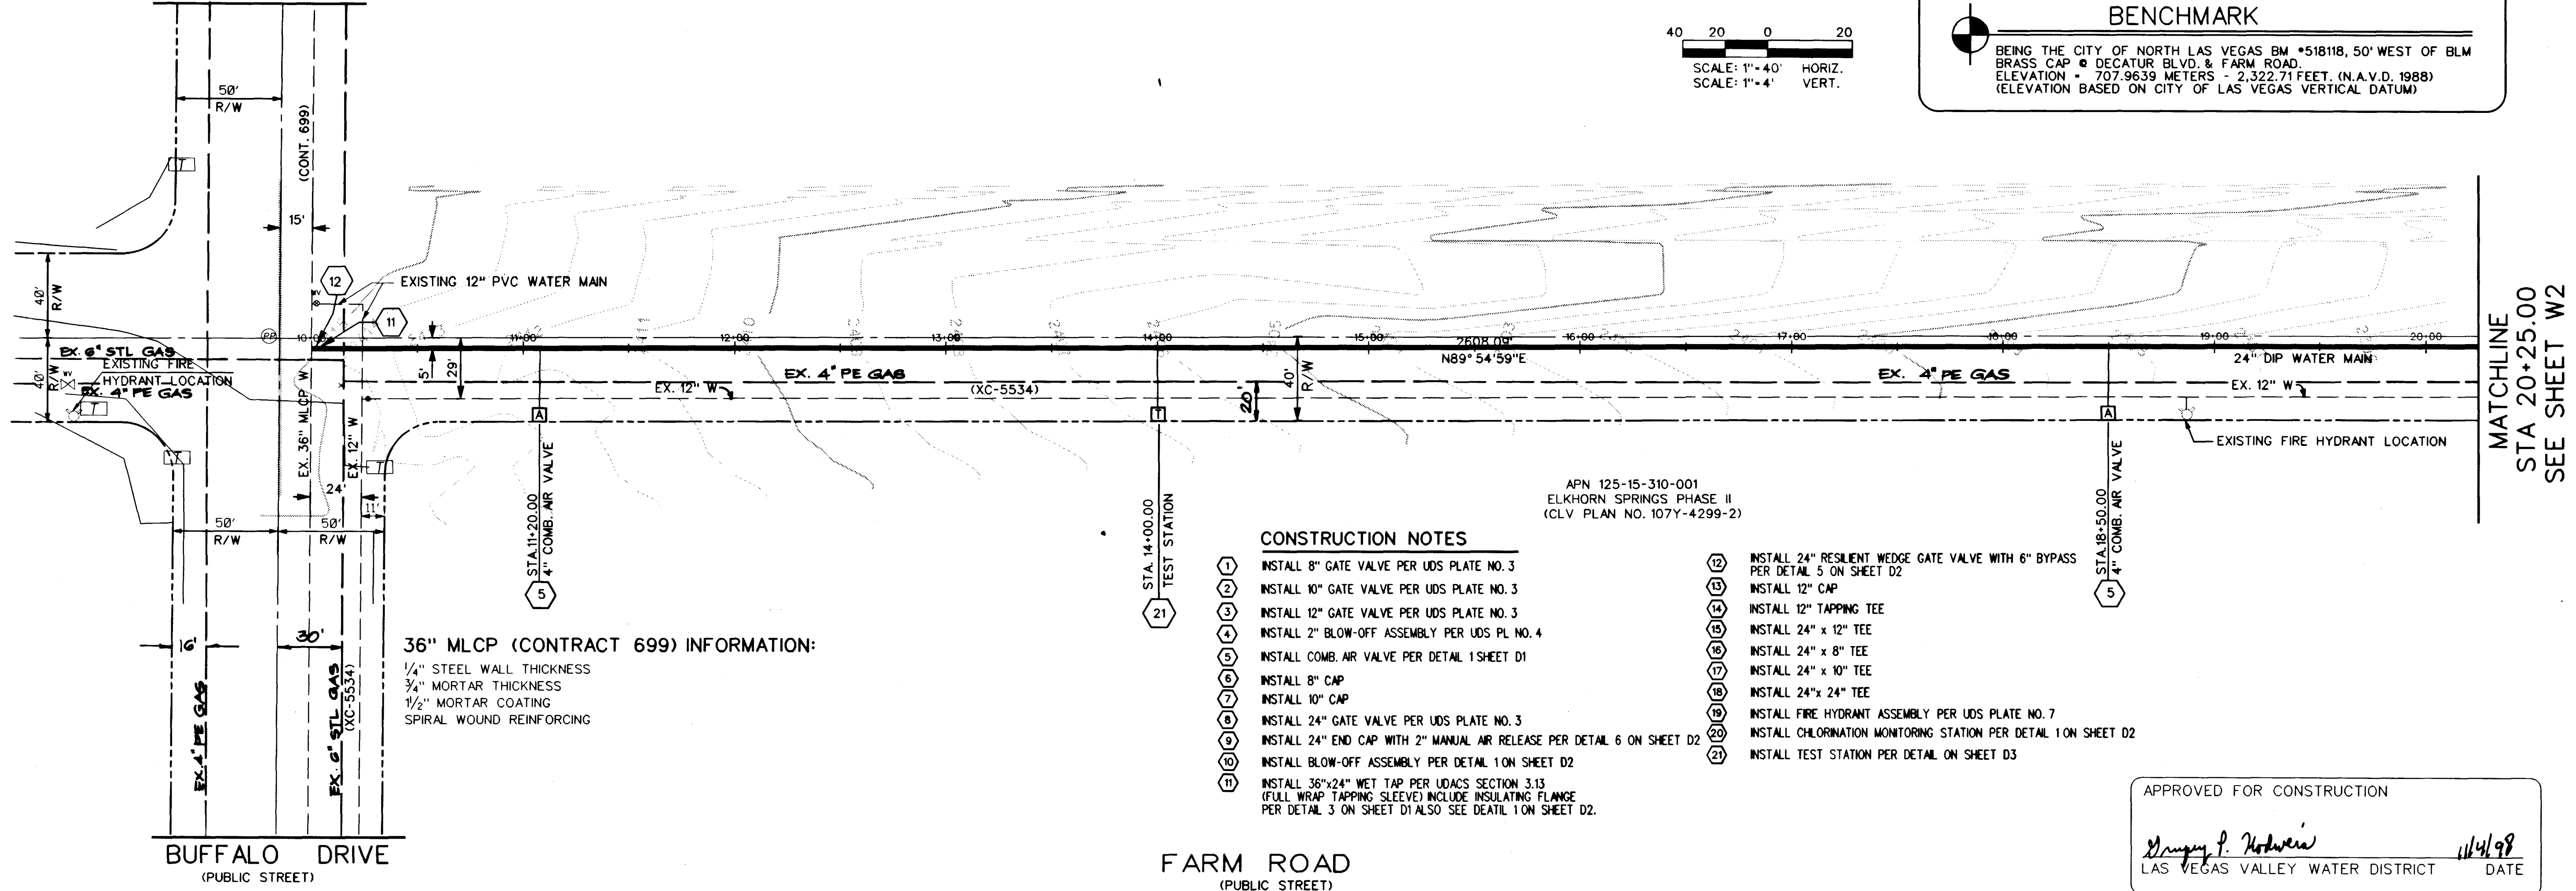


CONSTRUCTION NOTES

1. INSTALL 8" GATE VALVE PER UDS PLATE NO. 3
2. INSTALL 10" GATE VALVE PER UDS PLATE NO. 3
3. INSTALL 12" GATE VALVE PER UDS PLATE NO. 3
4. INSTALL 2" BLOW-OFF ASSEMBLY PER UDS PL. NO. 4
5. INSTALL COMB. AIR VALVE PER DETAIL 1 SHEET D1
6. INSTALL 8" CAP
7. INSTALL 10" CAP
8. INSTALL 24" GATE VALVE PER UDS PLATE NO. 3
9. INSTALL 24" END CAP WITH 2" MANUAL AIR RELEASE PER DETAIL 6 ON SHEET D2
10. INSTALL BLOW-OFF ASSEMBLY PER DETAIL 1 ON SHEET D2
11. INSTALL 36"x24" WET TAP PER UDACS SECTION 3.13 (FULL WRAP TAPPING SLEEVE) INCLUDE INSULATING FLANGE PER DETAIL 3 ON SHEET D1 ALSO SEE DETAIL 1 ON SHEET D2.
12. INSTALL 24" RESILIENT WEDGE GATE VALVE WITH 6" BYPASS PER DETAIL 5 ON SHEET D2
13. INSTALL 12" CAP
14. INSTALL 12" TAPPING TEE
15. INSTALL 24" x 12" TEE
16. INSTALL 24" x 8" TEE
17. INSTALL 24" x 10" TEE
18. INSTALL 24" x 24" TEE
19. INSTALL FIRE HYDRANT ASSEMBLY PER UDS PLATE NO. 7
20. INSTALL CHLORINATION MONITORING STATION PER DETAIL 1 ON SHEET D2
21. INSTALL TEST STATION PER DETAIL ON SHEET D3

APPROVED FOR CONSTRUCTION


Gregory P. Hordern
LAS VEGAS VALLEY WATER DISTRICT
DATE 11/4/98

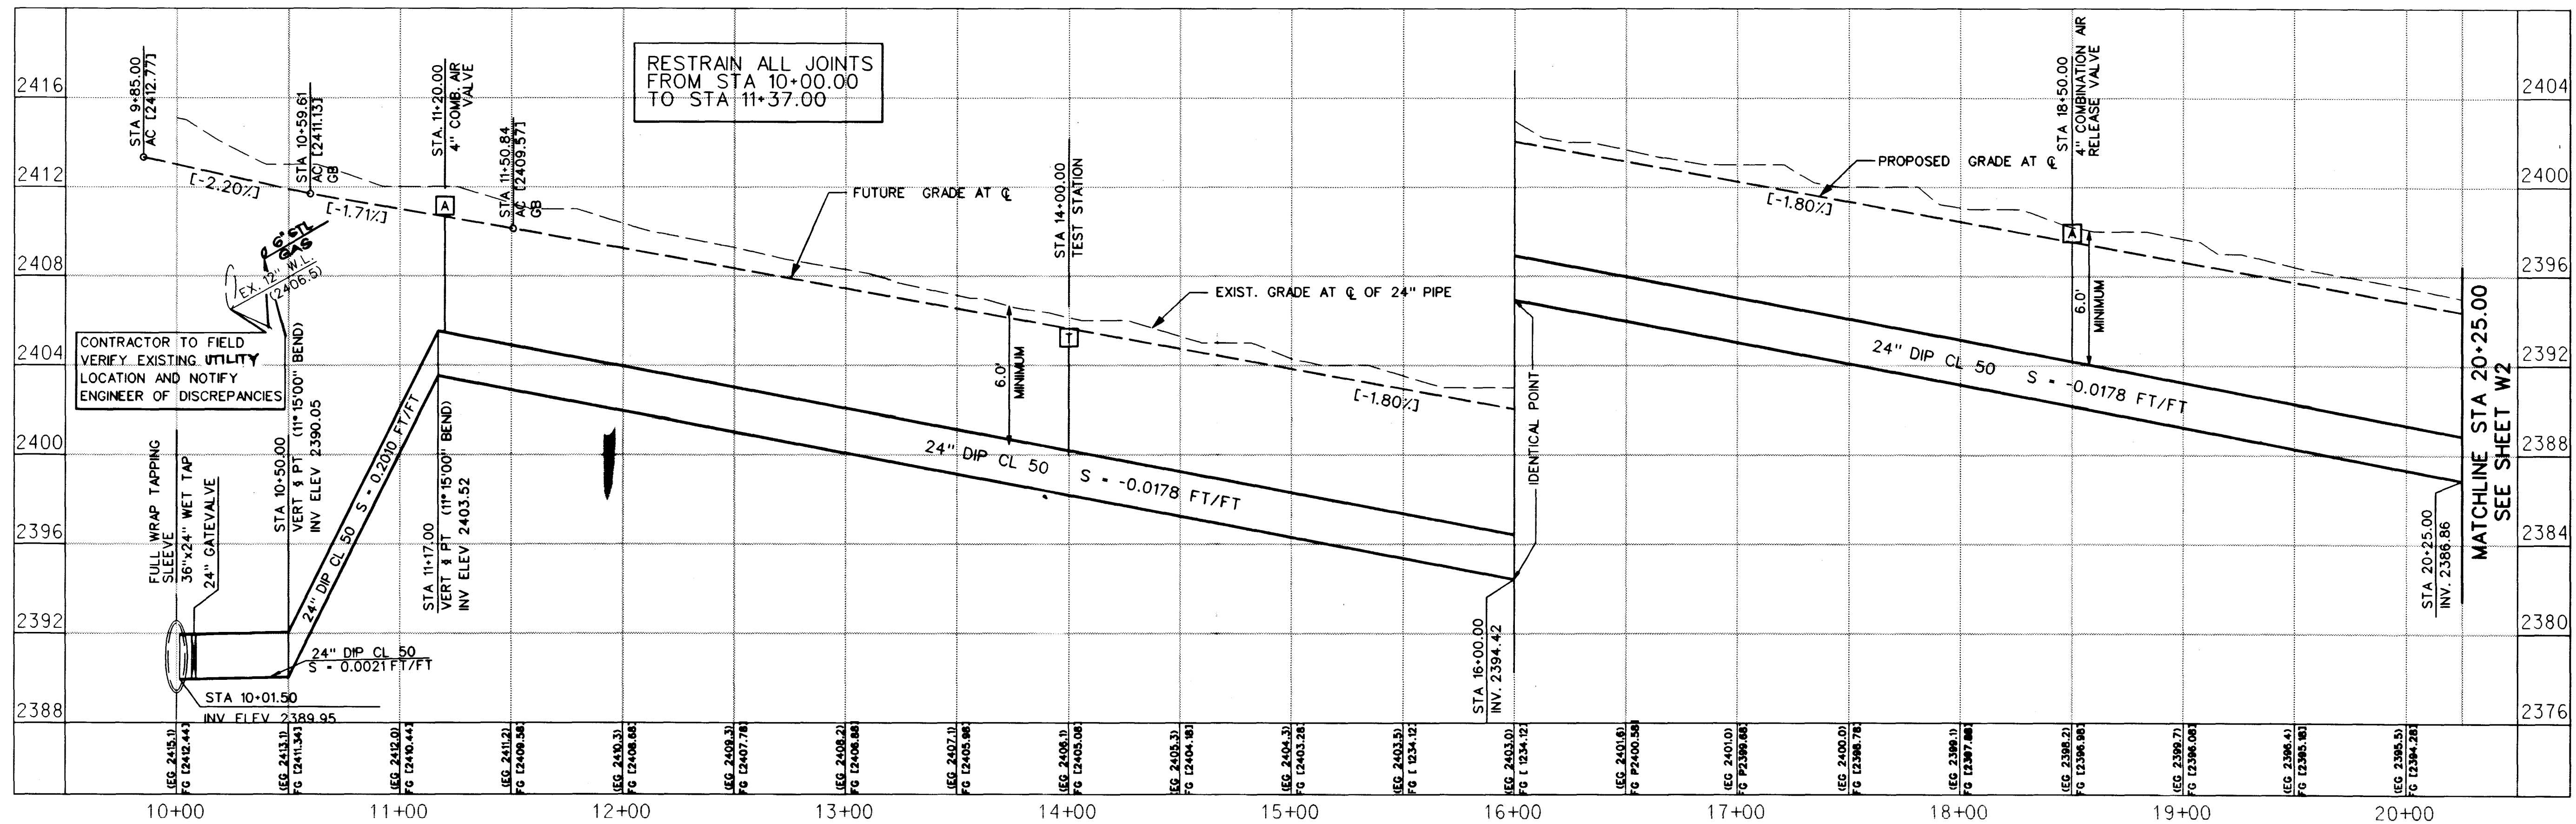

THE GATES, L.L.C.
236 SOUTH RAINBOW BLVD.
SUITE 311
LAS VEGAS, NEVADA 89129

24" WATER MAIN
PLAN AND PROFILE
STA 10+00.00 TO STA 20+25.00
OFFSITE WATER PLANS
FOR
LYNBROOK

DRAWN BY: BB 5/11/98
DESIGNED BY: BB 5/11/98
CHECKED BY: MV 5/15/98
PROJECT NO: 9802003
SCALE: 1" = 40' HOR.
1" = 4' VERT.

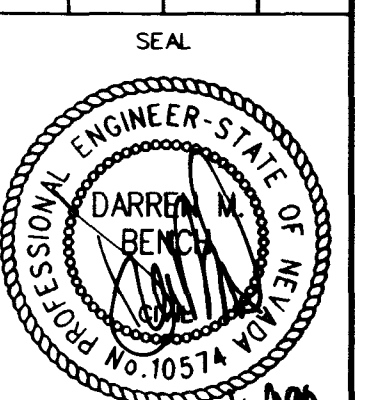



SHEET
W1
6 OF 19 SHEETS
DRAWING NO.

4175 Cameron Street
Suite A
Las Vegas, NV 89103
Tel: (702) 368-3008
Fax: (702) 368-0047



Call before
you dig
1-800-227-2600

BUFFALO DRIVE

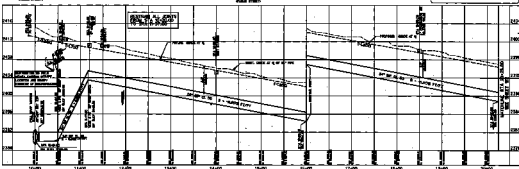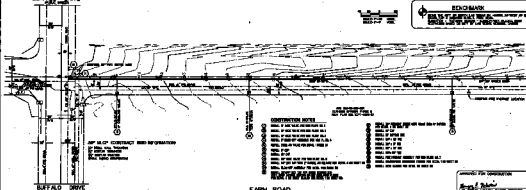

THE GATNER, L.L.C.
 1000 N. 10TH AVE.
 SUITE 200
 MINNEAPOLIS, MN 55412
 PHONE: 612.338.1111
 FAX: 612.338.1112
 WWW.GATNER.COM

**WATER MAIN
 PLAN AND PROFILE
 STA 10+00 TO STA 20+00
 FOR
 FUTURE WATER PLANS
 FOR
 LATERAL
 LATERAL**

**DATE: 10/15/2010
 DRAWN BY: J. GATNER
 CHECKED BY: J. GATNER
 APPROVED BY: J. GATNER**

10+00 11+00 12+00 13+00 14+00 15+00 16+00 17+00 18+00 19+00 20+00

24.00 23.50 23.00 22.50 22.00 21.50 21.00 20.50 20.00 19.50 19.00 18.50 18.00 17.50 17.00 16.50 16.00 15.50 15.00 14.50 14.00 13.50 13.00 12.50 12.00 11.50 11.00 10.50 10.00