



Avoid cutting underground utility lines. It's costly.
Call before you Dig
1-800-227-2600

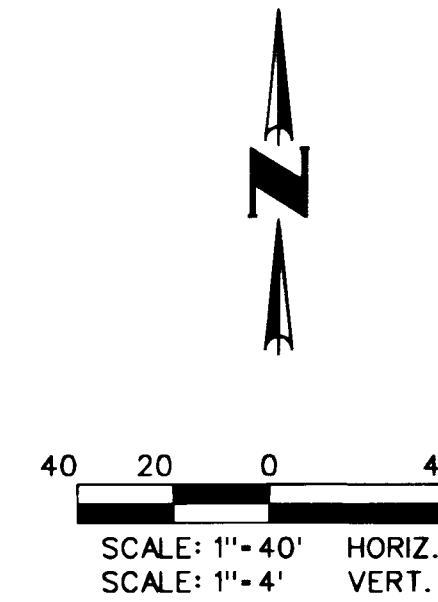

BASIS OF BEARING
BEING THE NORTH LINE OF THE LOT 63, AS IT IS SHOWN ON THE RECORD OF SURVEY IN FILE 52, OF SURVEYS, PAGE 70, OFFICIAL RECORDS OF CLARK COUNTY, NEVADA, WHICH BEARS: SOUTH 85°04'37" WEST.


BENCHMARK
BEING THE CITY OF NORTH LAS VEGAS BM *518118, 50' WEST OF BLM BRASS CAP @ DECATUR BLVD. & FARM ROAD.
ELEVATION = 707.9639 METERS = 2,322.71 FEET. (N.A.V.D. 1988)
(ELEVATION BASED ON CITY OF LAS VEGAS VERTICAL DATUM)

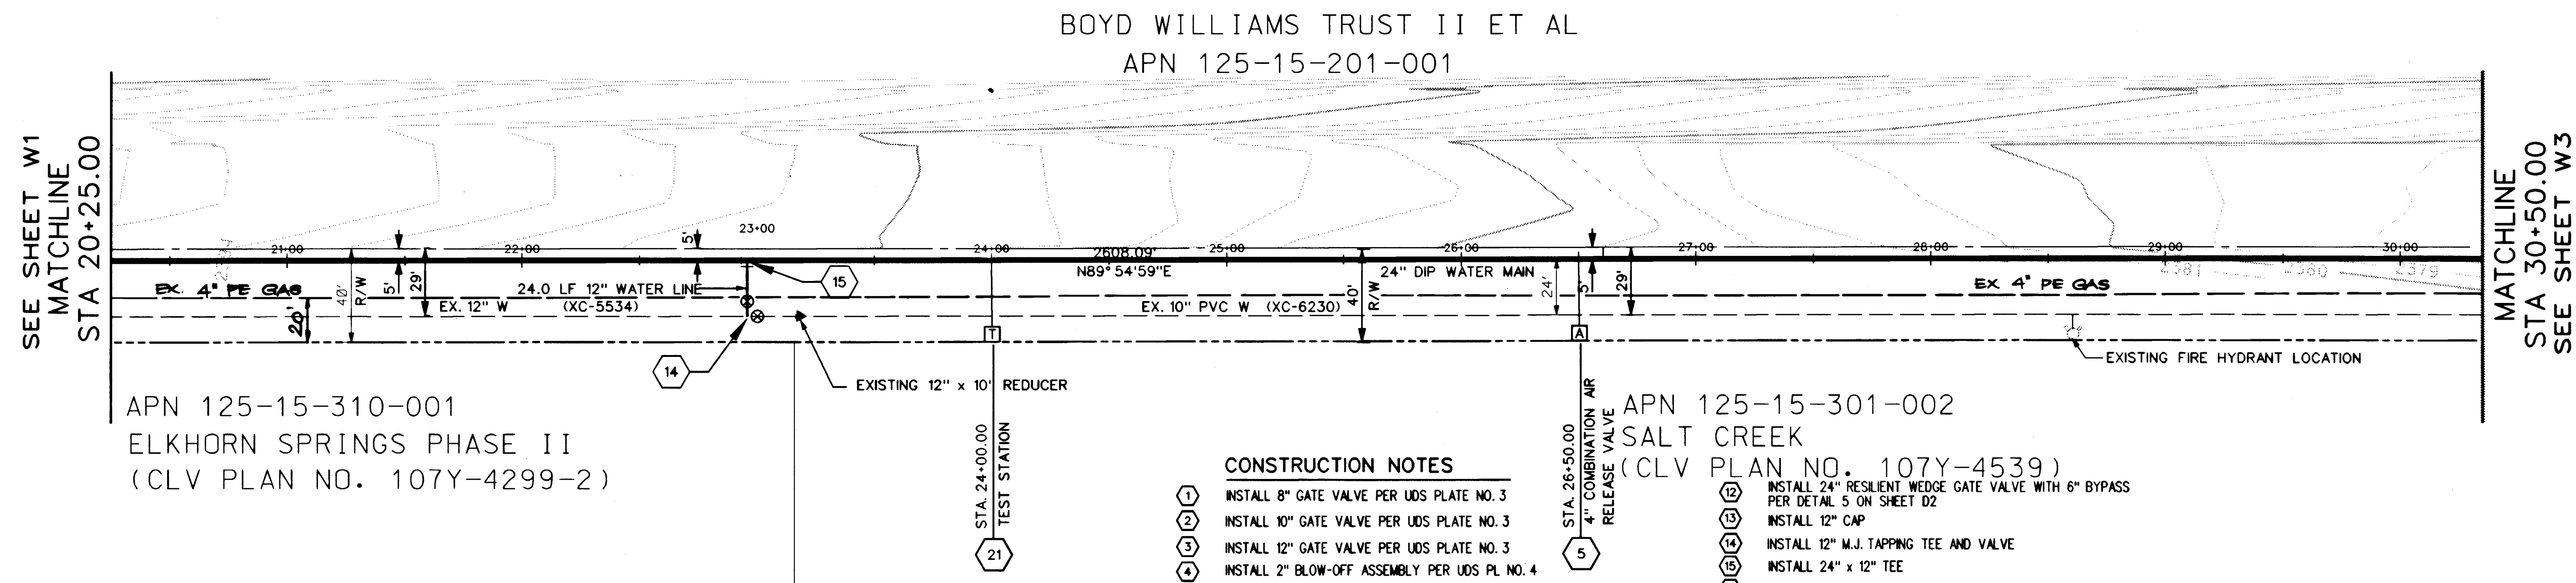

- CONSTRUCTION NOTES**
- INSTALL 8" GATE VALVE PER UDS PLATE NO. 3
 - INSTALL 10" GATE VALVE PER UDS PLATE NO. 3
 - INSTALL 12" GATE VALVE PER UDS PLATE NO. 3
 - INSTALL 2" BLOW-OFF ASSEMBLY PER UDS PL. NO. 4
 - INSTALL COMB. AIR VALVE PER DETAIL 1 ON SHEET D1
 - INSTALL 8" CAP
 - INSTALL 10" CAP
 - INSTALL 24" GATE VALVE PER UDS PLATE NO. 3
 - INSTALL 24" END CAP WITH 2" MANUAL AIR RELEASE PER DETAIL 6 ON SHEET D2
 - INSTALL BLOW-OFF ASSEMBLY PER DETAIL 1 ON SHEET D2
 - INSTALL 36"x24" WET TAP PER UDS SECTION 3.13 (FULL WRAP TAPPING SLEEVE) INCLUDE INSULATING FLANGE PER DETAIL 3 ON SHEET D1 ALSO SEE DETAIL 1 ON SHEET D2.
 - INSTALL 24" RESILIENT WEDGE GATE VALVE WITH 6" BYPASS PER DETAIL 5 ON SHEET D2
 - INSTALL 12" CAP
 - INSTALL 12" M.J. TAPPING TEE AND VALVE
 - INSTALL 24" x 12" TEE
 - INSTALL 24" x 8" TEE
 - INSTALL 24" x 10" TEE
 - INSTALL 24" x 24" TEE
 - INSTALL FIRE HYDRANT ASSEMBLY PER UDS PLATE NO. 7
 - INSTALL CHLORINATION MONITORING STATION PER DETAIL 1 ON SHEET D2
 - INSTALL TEST STATION PER DETAIL ON SHEET D3

APPROVED FOR CONSTRUCTION

Darwin B. Benoit 11/4/98
LAS VEGAS VALLEY WATER DISTRICT DATE

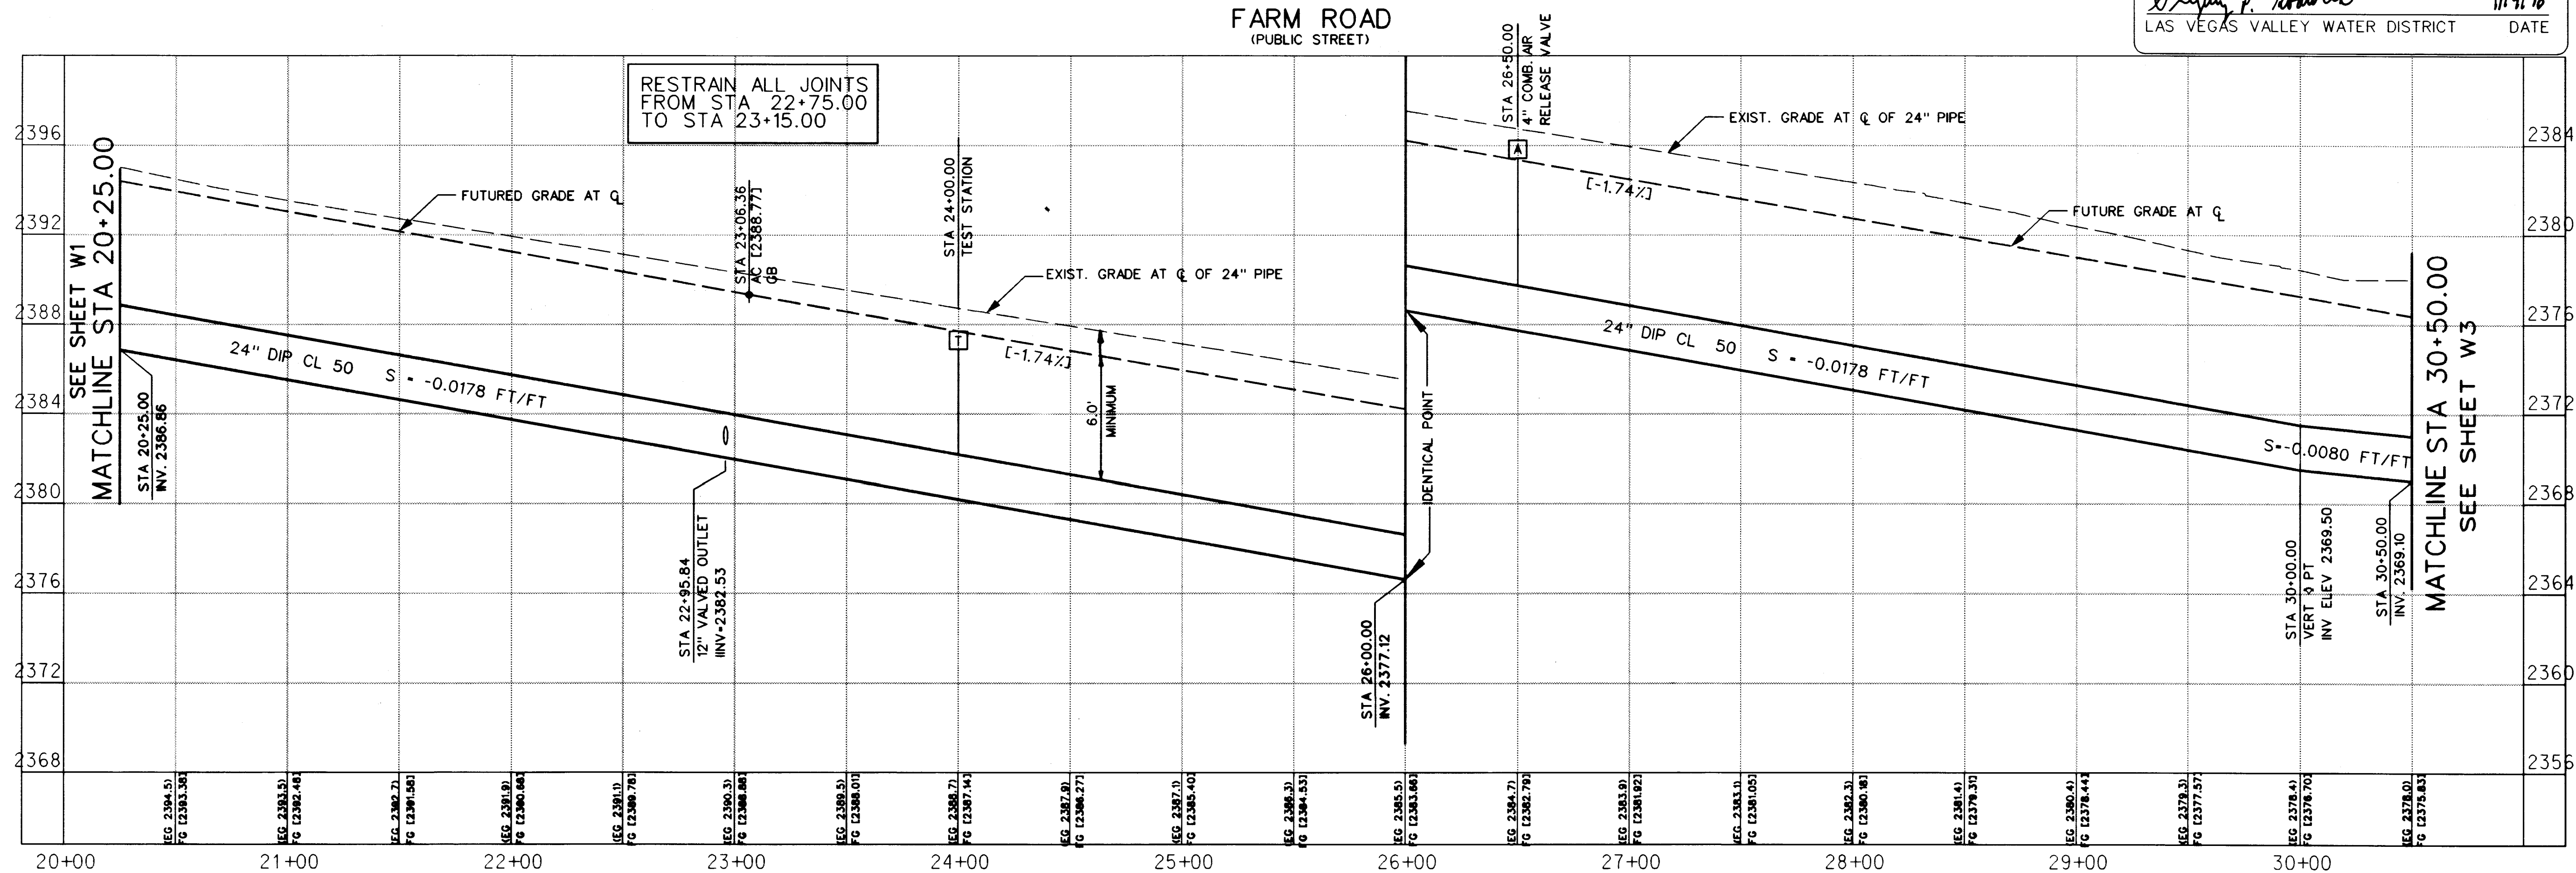

SHEET		5/11/98	
DRAWN BY:		5/11/98	
DESIGNED BY:		5/11/98	
CHECKED BY:		5/15/98	
PROJECT NO:		9592003	
SCALE:		1" = 40' HOR. 1" = 4' VERT.	

THE GATES, L.L.C.
236 SOUTH RAINBOW BLVD.
SUITE 311
LAS VEGAS, NEVADA 89129
Tel: (702) 368-3008
Fax: (702) 368-0047

CONSULTANTS INC.
LAS VEGAS

**24" WATER MAIN
PLAN AND PROFILE
STA 20+25.00 TO STA 30+50.00
OFFSITE WATER PLANS
FOR
LYNBROOK**


SHEET
W2
7 OF 19 SHEETS
DRAWING NO.

Call before
you dig
1-800-227-2600


THE UNIVERSITY OF CHICAGO PRESS

U.S. GOVERNMENT PRINTING OFFICE: 1964

BOYD WILLIAMS TRUST II ET AL
APN 125-15-201-001

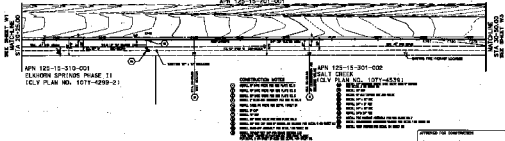

Don't Know

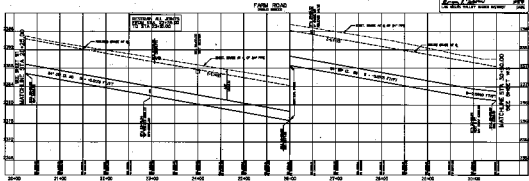

STY WELVE 101

2017年4月25日

10

116-015