
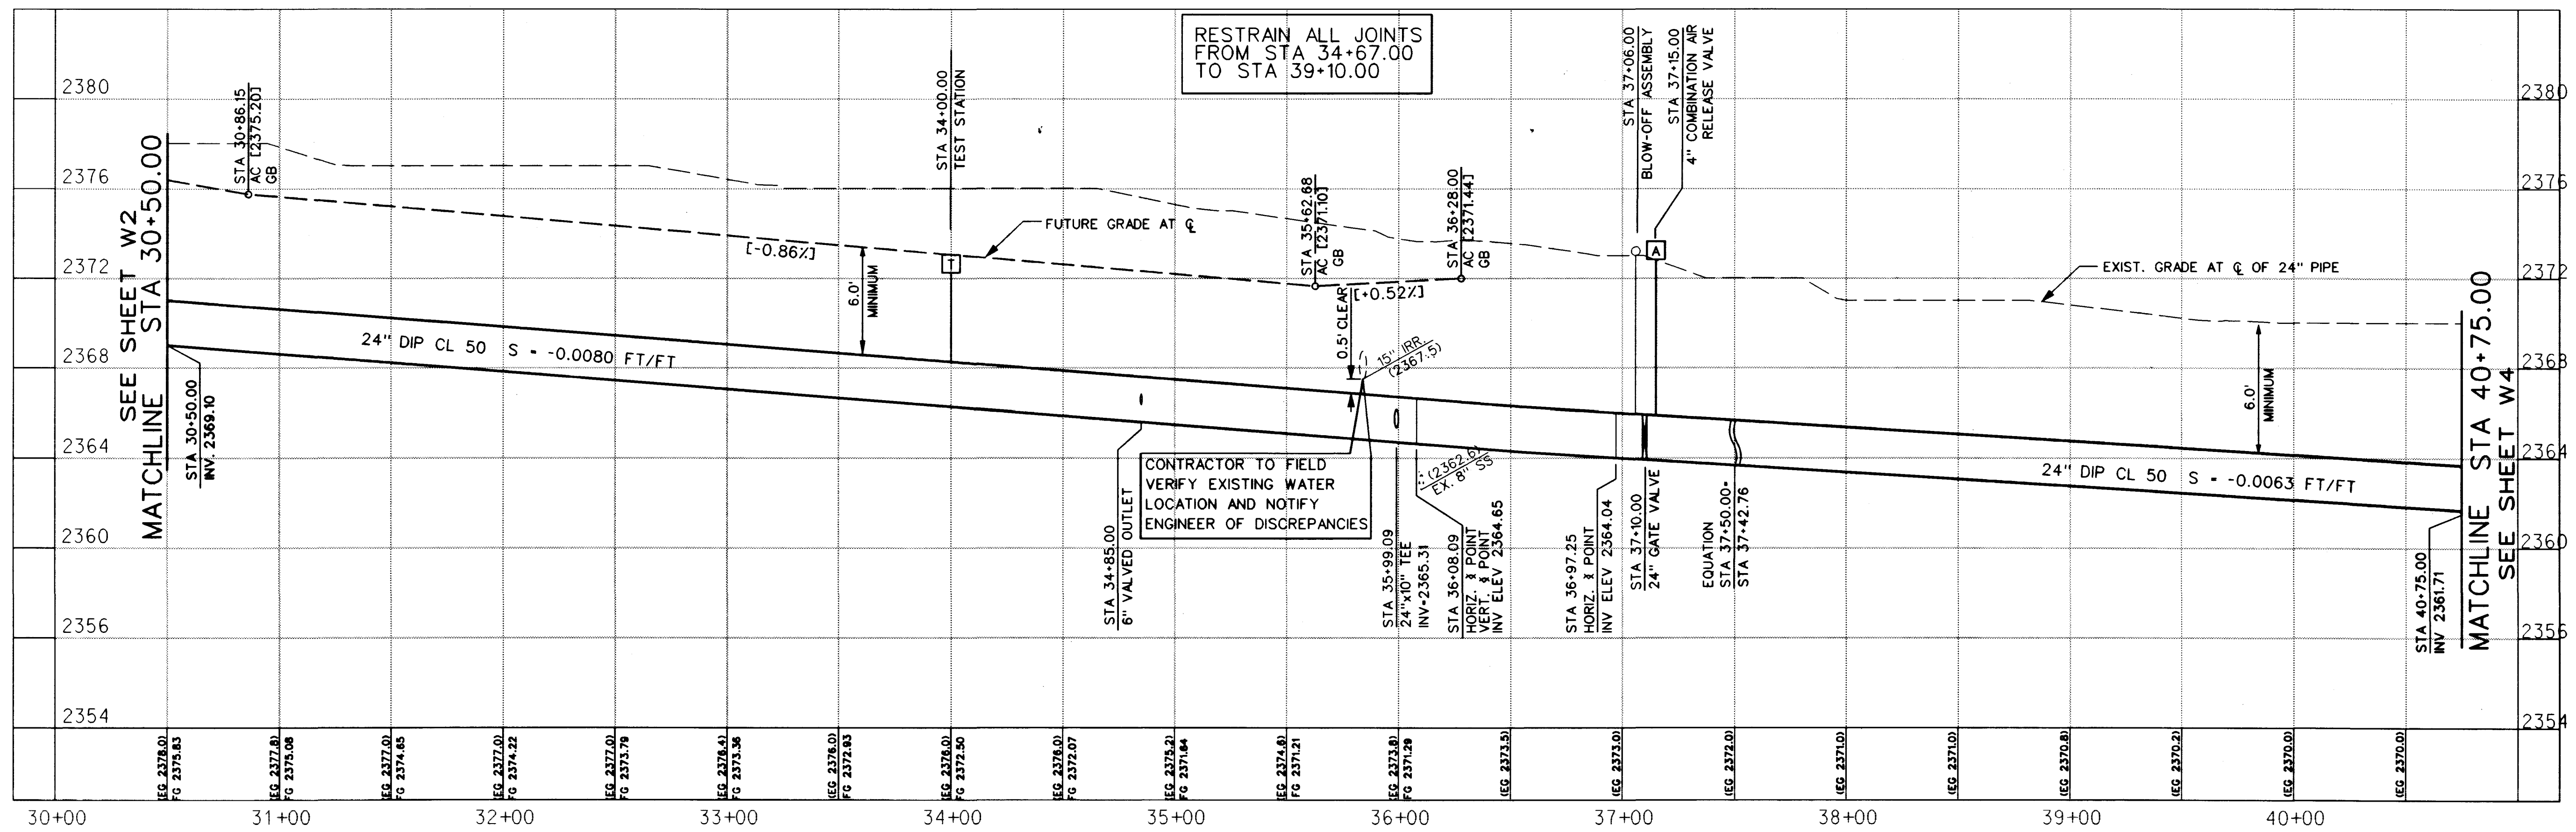


Avoid cutting underground utility lines. It's costly.

Call before
you Dig

1-800-227-2600

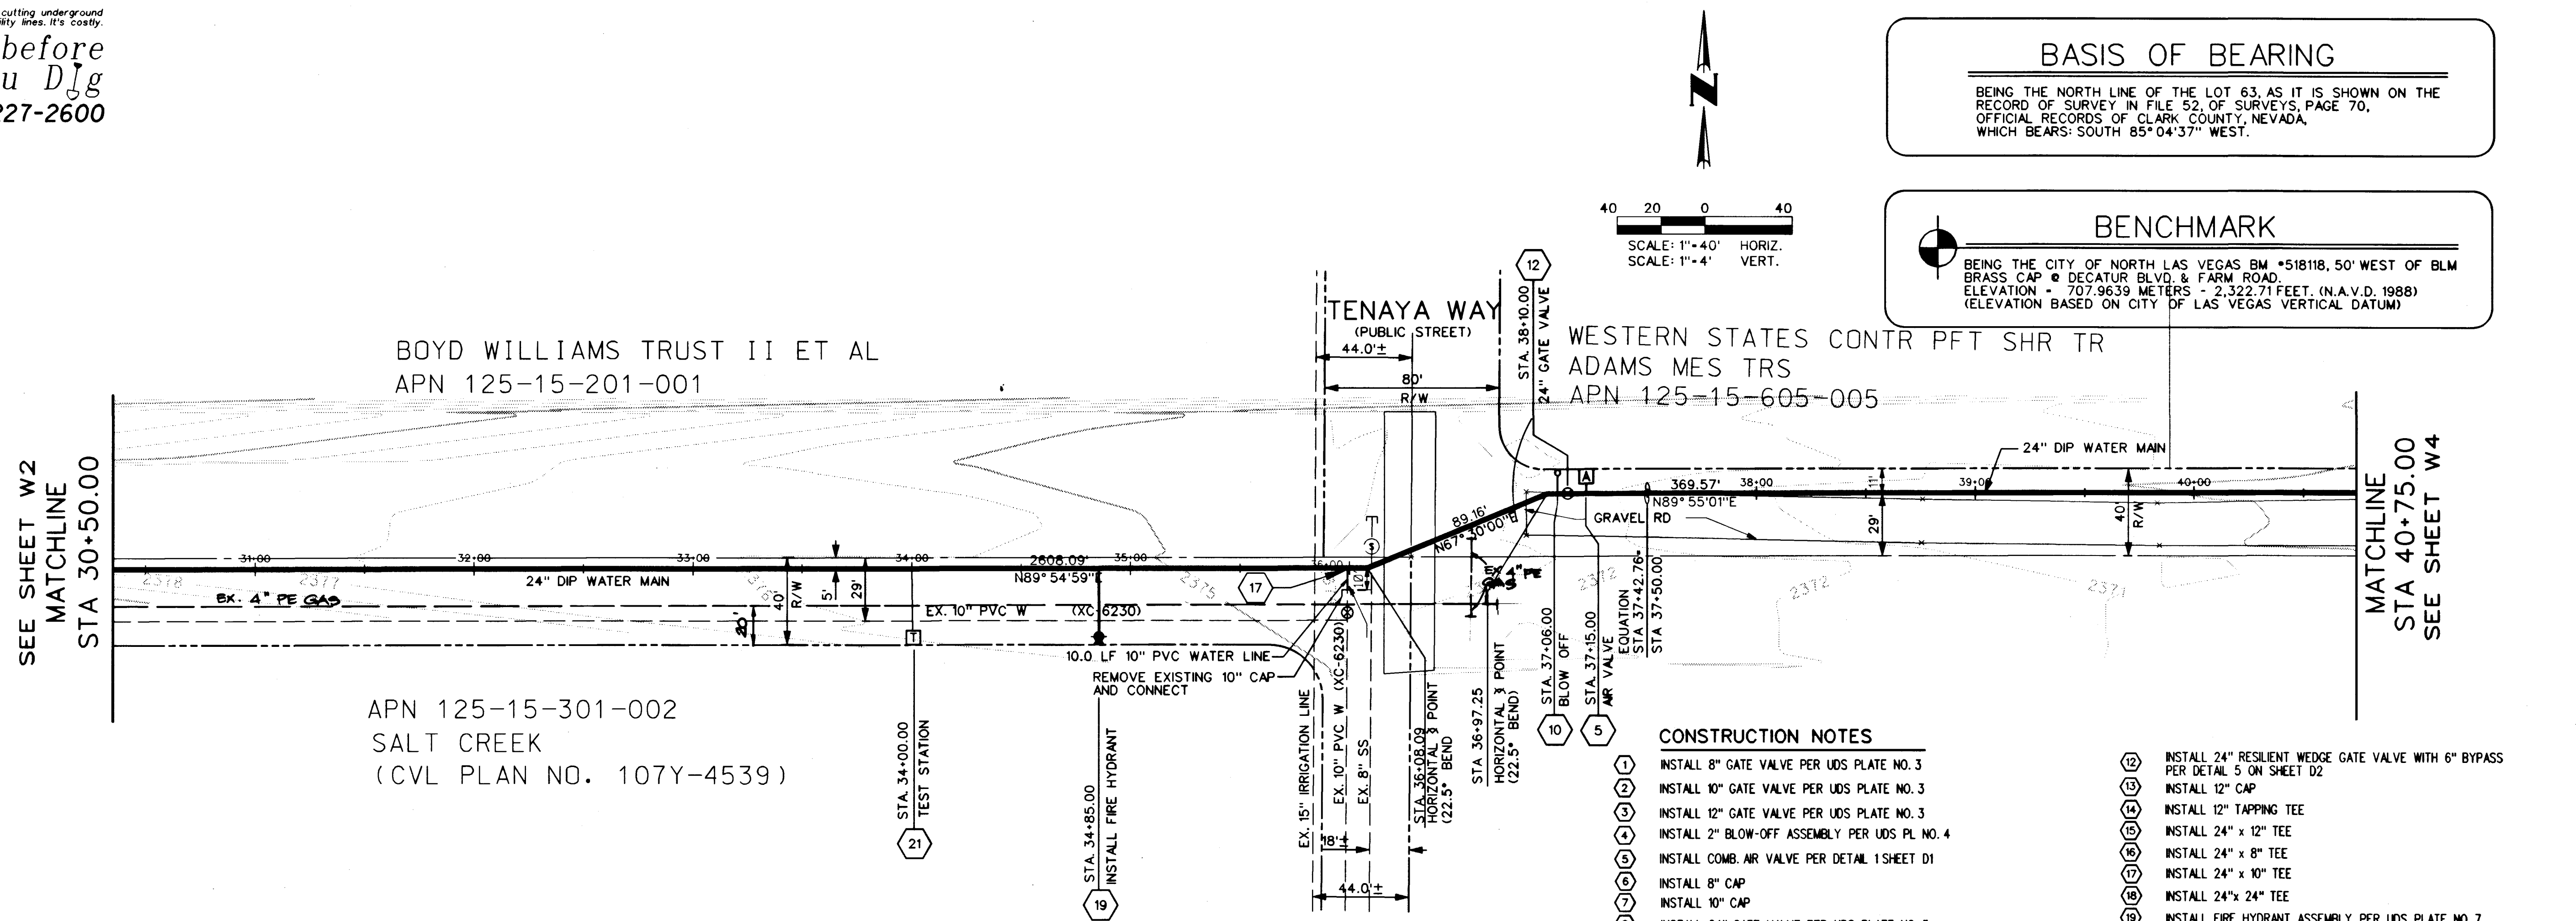

THE GATES, L.L.C.
236 SOUTH RAINBOW BLVD.
SUITE 204
DALLAS, TEXAS 75244

SHEET	24" WATER MAIN PLAN AND PROFILE STA 30+50.00 TO STA 40+75.00
TITLE	OFFSITE WATER PLANS FOR LYNBROOK

DRAWN BY: BB	5/11/98
DESIGNED BY: BB	5/11/98
CHECKED BY: MV	5/15/98
PROJECT NO: 98902003	SCALE: 1"= 40' HOR. 1"= 4' VERT.

SEAL





The seal is circular with a double-line border. The outer ring contains the text "PROFESSIONAL ENGINEER - STATE OF NEVADA" at the top and "No. 10574" at the bottom. The center of the seal contains the name "DARREN M. BENCH" and the word "CIVIL" below it. A large, stylized signature is written across the center, and the date "10/19/97" is handwritten in the bottom right corner of the seal area.

SHEET
W3
8 OF 19 SHEETS

DRAWING NO.

Call before
you dig
1-800-337-9400

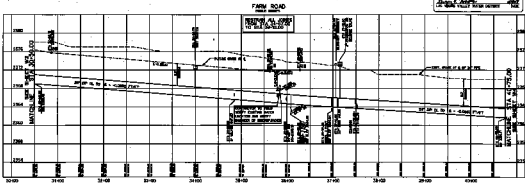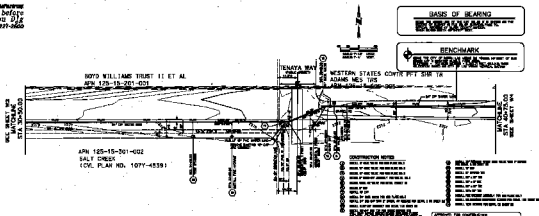

JPMORGAN CHASE & CO.

34" WATER MAIN
PLAN AND PROFILE
STA 30+00 TO STA 42+00
OFFSET WATER PLANS
FOR
LYNDEN

Item	Unit	Quantity	Price	Total
1. 1000	1000	1000	1000	1000
2. 1000	1000	1000	1000	1000
3. 1000	1000	1000	1000	1000
66. 1000	1000	1000	1000	1000
67. 1000	100			

