



Avoid cutting underground utility lines. It's costly.
Call before you Dig
1-800-227-2600

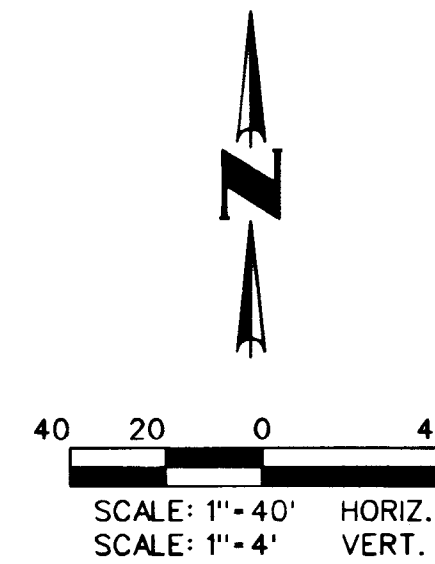


BASIS OF BEARING
BEING THE NORTH LINE OF THE LOT 63, AS IT IS SHOWN ON THE RECORD OF SURVEY IN FILE 52, OF SURVEYS, PAGE 70, OFFICIAL RECORDS OF CLARK COUNTY, NEVADA, WHICH BEARS: SOUTH 85°04'37" WEST.

BENCHMARK
BEING THE CITY OF NORTH LAS VEGAS BM #518118, 50' WEST OF BLM BRASS CAP @ DECATUR BLVD. & FARM ROAD.
ELEVATION = 707.9639 METERS = 2,322.71 FEET, (N.A.V.D. 1988)
(ELEVATION BASED ON CITY OF LAS VEGAS VERTICAL DATUM)

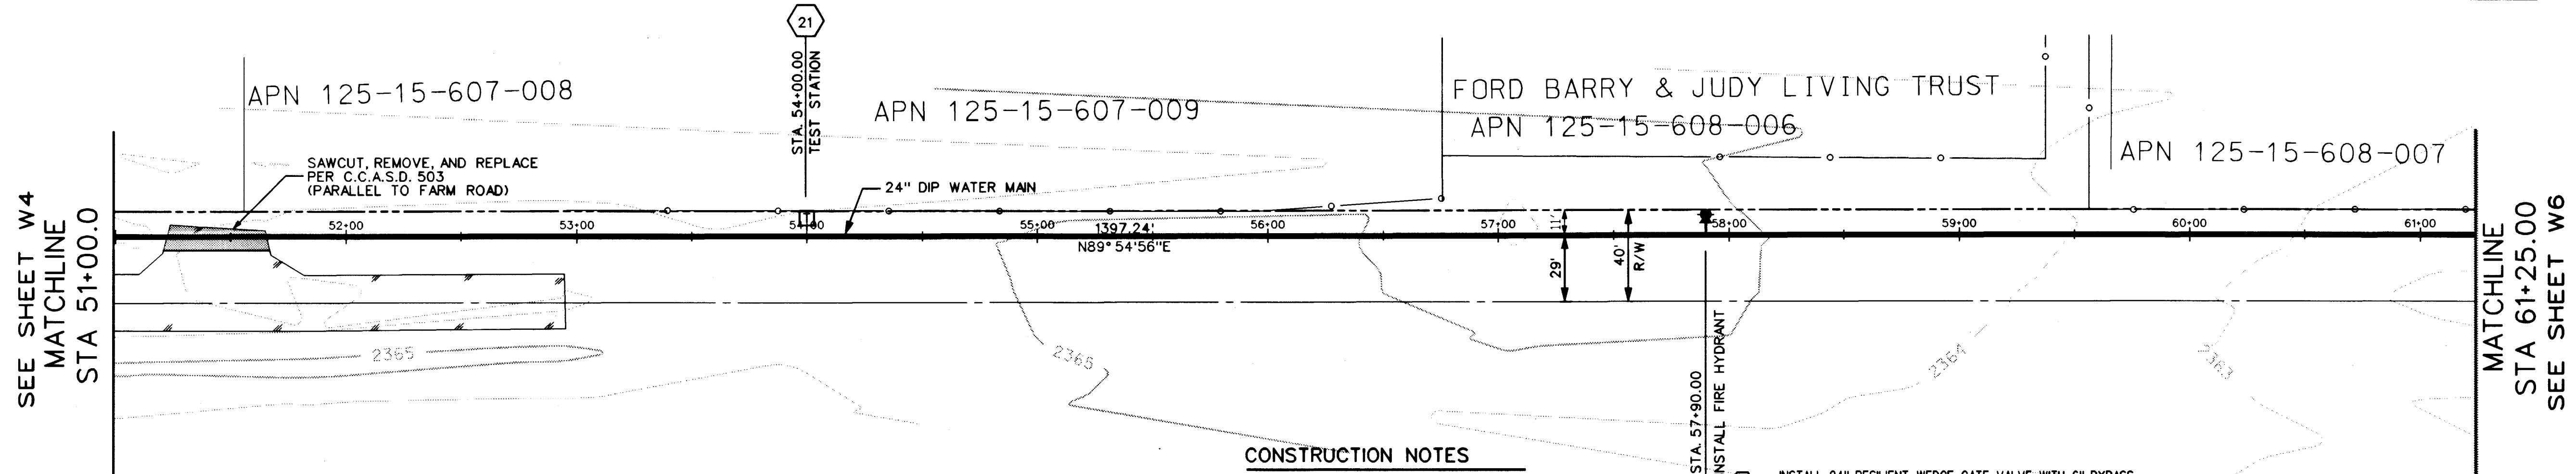


- CONSTRUCTION NOTES**
1. INSTALL 8" GATE VALVE PER UDS PLATE NO. 3
 2. INSTALL 10" GATE VALVE PER UDS PLATE NO. 3
 3. INSTALL 12" GATE VALVE PER UDS PLATE NO. 3
 4. INSTALL 2" BLOW-OFF ASSEMBLY PER UDS PL. NO. 4
 5. INSTALL COMB. AIR VALVE PER DETAIL 1 SHEET D1
 6. INSTALL 8" CAP
 7. INSTALL 10" CAP
 8. INSTALL 24" GATE VALVE PER UDS PLATE NO. 3
 9. INSTALL 24" END CAP WITH 2" MANUAL AIR RELEASE PER DETAIL 6 ON SHEET D2
 10. INSTALL BLOW-OFF ASSEMBLY PER DETAIL 1 ON SHEET D2
 11. INSTALL 36"x24" WET TAP PER UDCS SECTION 3.13 (FULL WRAP TAPPING SLEEVE) INCLUDE INSULATING FLANGE PER DETAIL 3 ON SHEET D1 ALSO SEE DETAIL 1 ON SHEET D2.
 12. INSTALL 24" RESILIENT WEDGE GATE VALVE WITH 6" BYPASS PER DETAIL 5 ON SHEET D2
 13. INSTALL 12" CAP
 14. INSTALL 12" TAPPING TEE
 15. INSTALL 24" x 12" TEE
 16. INSTALL 24" x 8" TEE
 17. INSTALL 24" x 10" TEE
 18. INSTALL 24" x 24" TEE
 19. INSTALL FIRE HYDRANT ASSEMBLY PER UDS PLATE NO. 7
 20. INSTALL CHLORINATION MONITORING STATION PER DETAIL 1 ON SHEET D2
 21. INSTALL TEST STATION PER DETAIL ON SHEET D3


APPROVED FOR CONSTRUCTION
Dwight P. Rodwin
LAS VEGAS VALLEY WATER DISTRICT
DATE 11/1/98

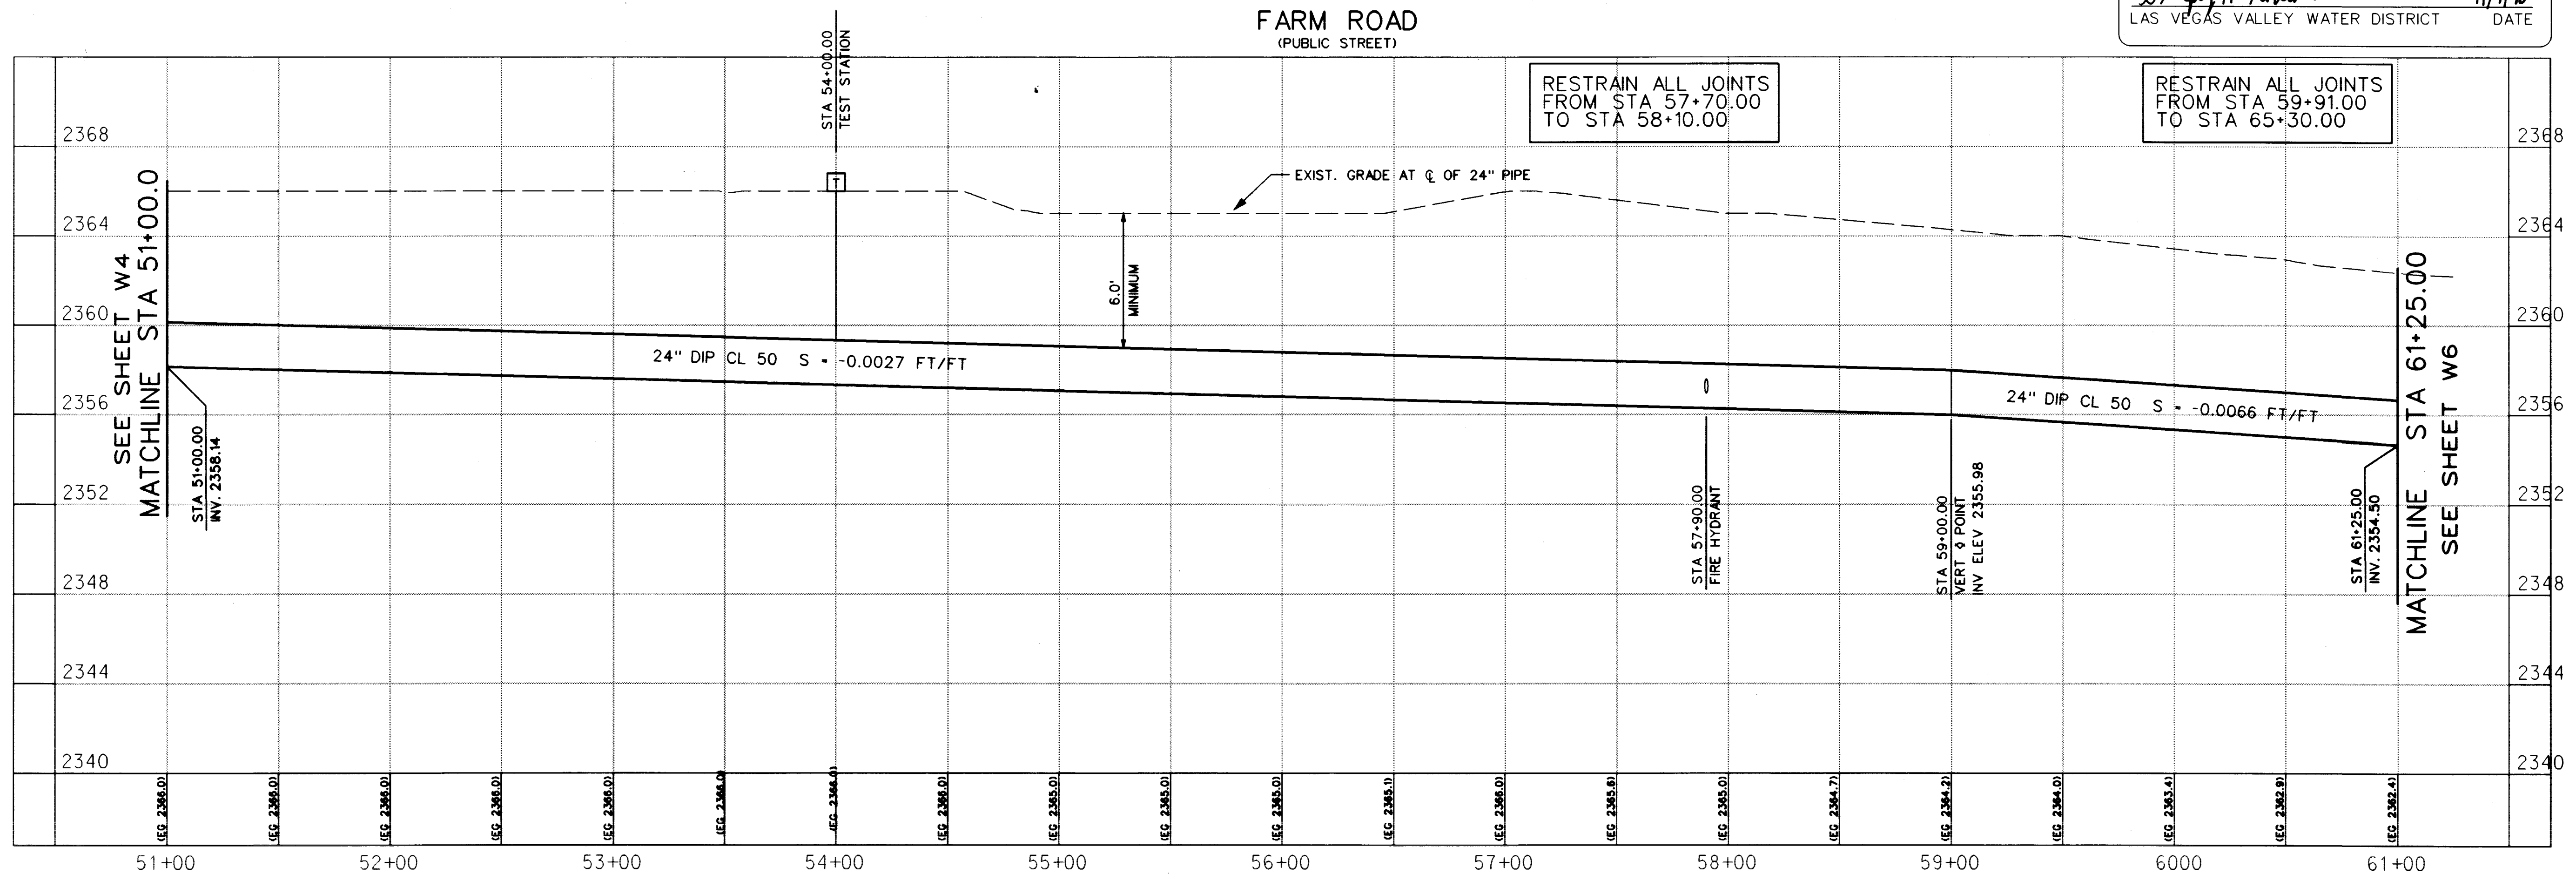

SHEET 5 OF 19 SHEETS DRAWING NO. 98902003		PROJECT NO. 98902003		SCALE: 1" = 40' HOR. 1" = 4' VERT.	
DESIGNED BY: BB		CHECKED BY: MW		PROJECT NO. 98902003	
DRAWN BY: BB		DESIGNED BY: BB		PROJECT NO. 98902003	
5/11/98		5/11/98		5/15/98	
TITLE: 24" WATER MAIN PLAN AND PROFILE STA 51+00.00 TO STA 61+25.00 OFFSITE WATER PLANS FOR LYNBROOK					
THE GATES, L.L.C. 236 SOUTH RAINBOW BLVD. SUITE 311 LAS VEGAS, NEVADA 89129 4175 Cameron Street Suite A Las Vegas, NV 89103 Tel: (702) 368-0008 Fax: (702) 368-0047					

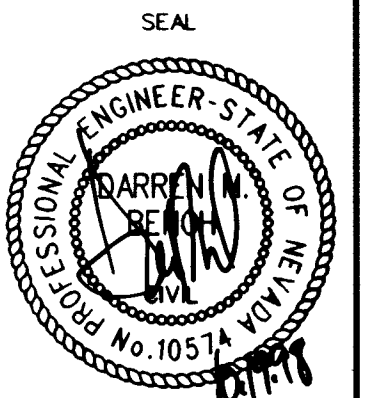

Call before
you dig
1-800-277-2600

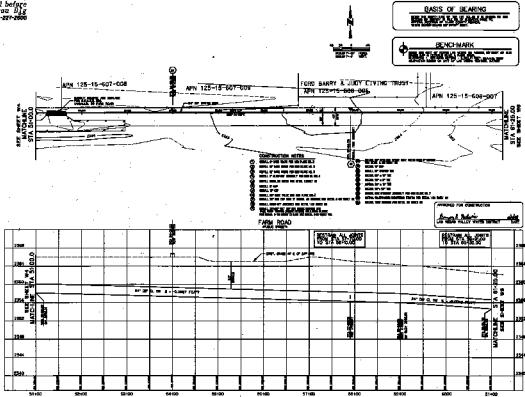

THE GATES, L.L.C.

**PROPOSED NEW
COMMITTEE**

WILSON, J. W. 1994. *Journal of Great Lakes Research* 20: 1-10.

132

CH

DATE

1

11

6

[illegible]

1