


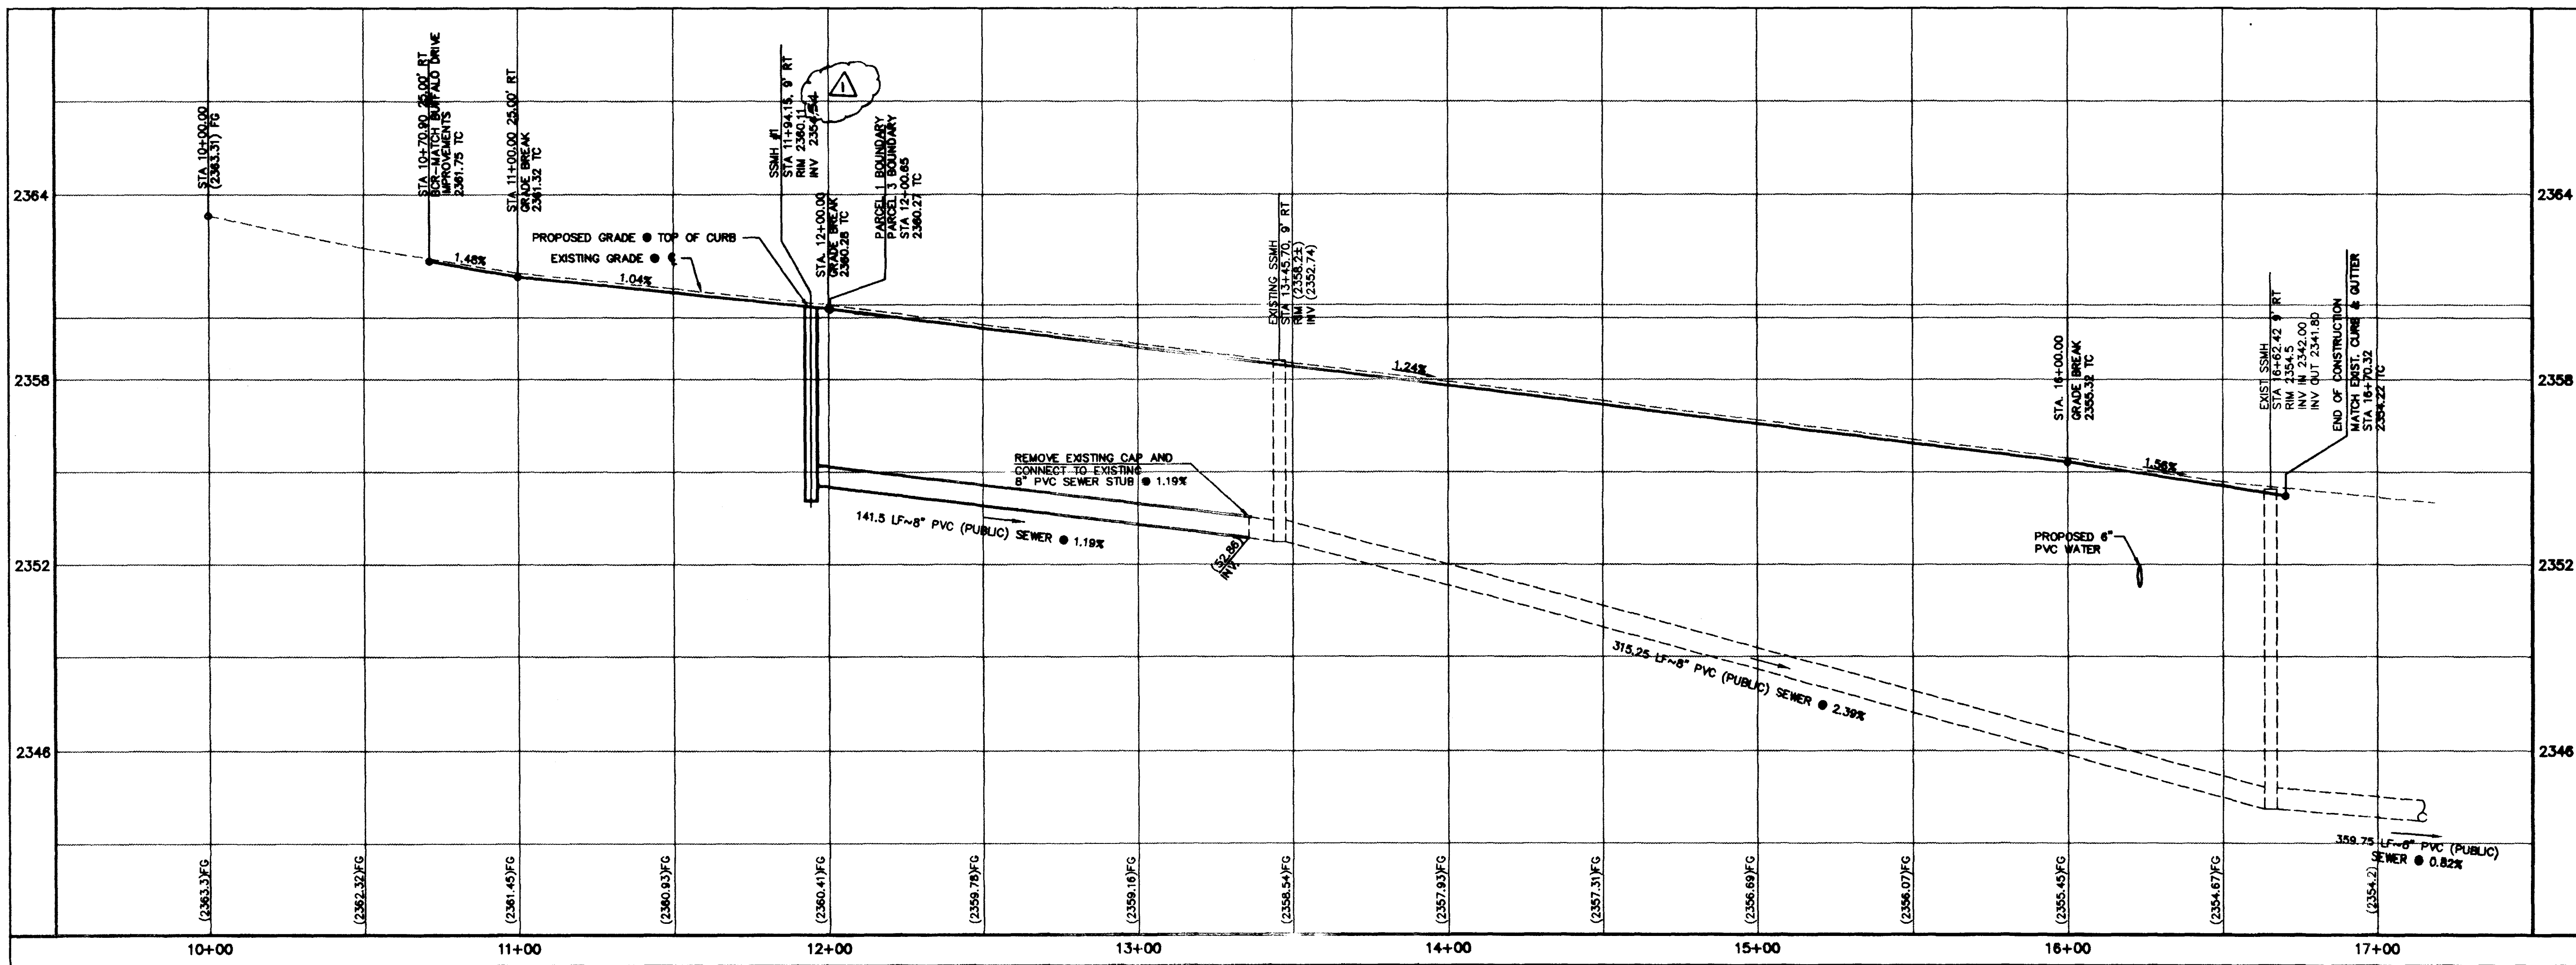

- ① REMOVE CAP & CONNECT TO EXISTING WATER LINE
- ② INSTALL 6" GATE VALVE
- ③ INSTALL 6" PVC WATER LINE
- ④ INSTALL 6"-90° ELBOW w/THRUST BLOCKS
- ⑤ INSTALL 6" CAP w/2" BLOW-OFF ASSEMBLY
- ⑥ INSTALL FIRE HYDRANT ASSEMBLY.

FOR ESTIMATE OF QUANTITIES SEE SHEET 1.
FOR DETAILED UTILITY LOCATIONS, SEE UTILITY
PLAN, SHEET 4.


- ① CONSTRUCT "I" TYPE CURB & GUTTER PER U.S.D. #218
- ② CONSTRUCT 5' WIDE CONCRETE SIDEWALK PER U.S.D. #234
- ③ CONSTRUCT SIDEWALK RAMP PER U.S.D. #235, CASE 1, $A=4.5'$ - $B=12'$
- ④ CONSTRUCT SIDEWALK DRAIN PER U.S.D. #

UTILITY LOCATIONS SHOWN HEREON ARE APPROXIMATE ONLY. IT SHALL BE THE CONTRACTOR'S RESPONSIBILITY TO DETERMINE THE EXACT HORIZONTAL AND VERTICAL LOCATION OF ALL EXISTING UNDERGROUND UTILITIES PRIOR TO COMMENCING CONSTRUCTION. NO REPRESENTATION IS MADE THAT ALL EXISTING UTILITIES ARE SHOWN HEREON. THE ENGINEER ASSUMES NO RESPONSIBILITY FOR UTILITIES NOT SHOWN OR UTILITIES NOT SHOWN IN THEIR PROPER LOCATION.

**Avoid calling underground
utility lines. It's costly.
Call
before you
Dig
1-800-227-2600
UNDERGROUND SERVICE (USA)**

"A ← Built"

642-001-942

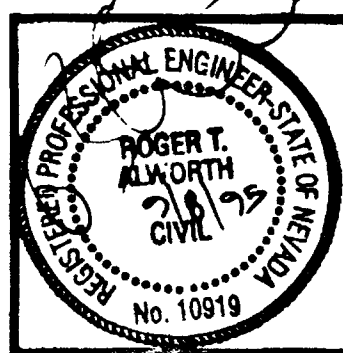[illegible]

L. R. NELSON CONSULTING ENGINEERS, INC.

•STRUCTURAL 3035 East Patrick Lane Suite 9
Las Vegas, Nevada 89120
•CIVIL (702) 798-7978
•SURVEY (702) 451-2296 FAX

PLAN AND PROFILE
ATWOOD AVENUE

PM - 5 - 95
RIED ROCK STORAGE LLC
OFF-SITE IMPROVEMENTS

NEVADA

CITY OF LAS VEGAS

SHEET NUMBER

2

OF 4 SHEETS

