

H:\CAD\LAND\4820\SHILLS\4820SHILL.FR1 Mor 8 11:16:27 1996 PLOTTED BY:RAJ

BENCHMARK


CONTROL POINT "SPANKY" A
BRASS CAP SET IN CONCRETE STAMPED
"42" SET BY GC WALLACE ENGINEERING AND
USED FOR BENCHMARK FOR SUMMERLIN
CONSTRUCTION.

ELEVATION: 2825.38 (NVGD'29)
ELEVATION EQUATION : (NVGD'29) ELEV. +2.437 = NAVD '88 ELEV.

2 working
days
Call
before you
Dig


1-800-227-2600

UNDEVELOPED
(FUTURE)
SUMMERLIN PARKWAY

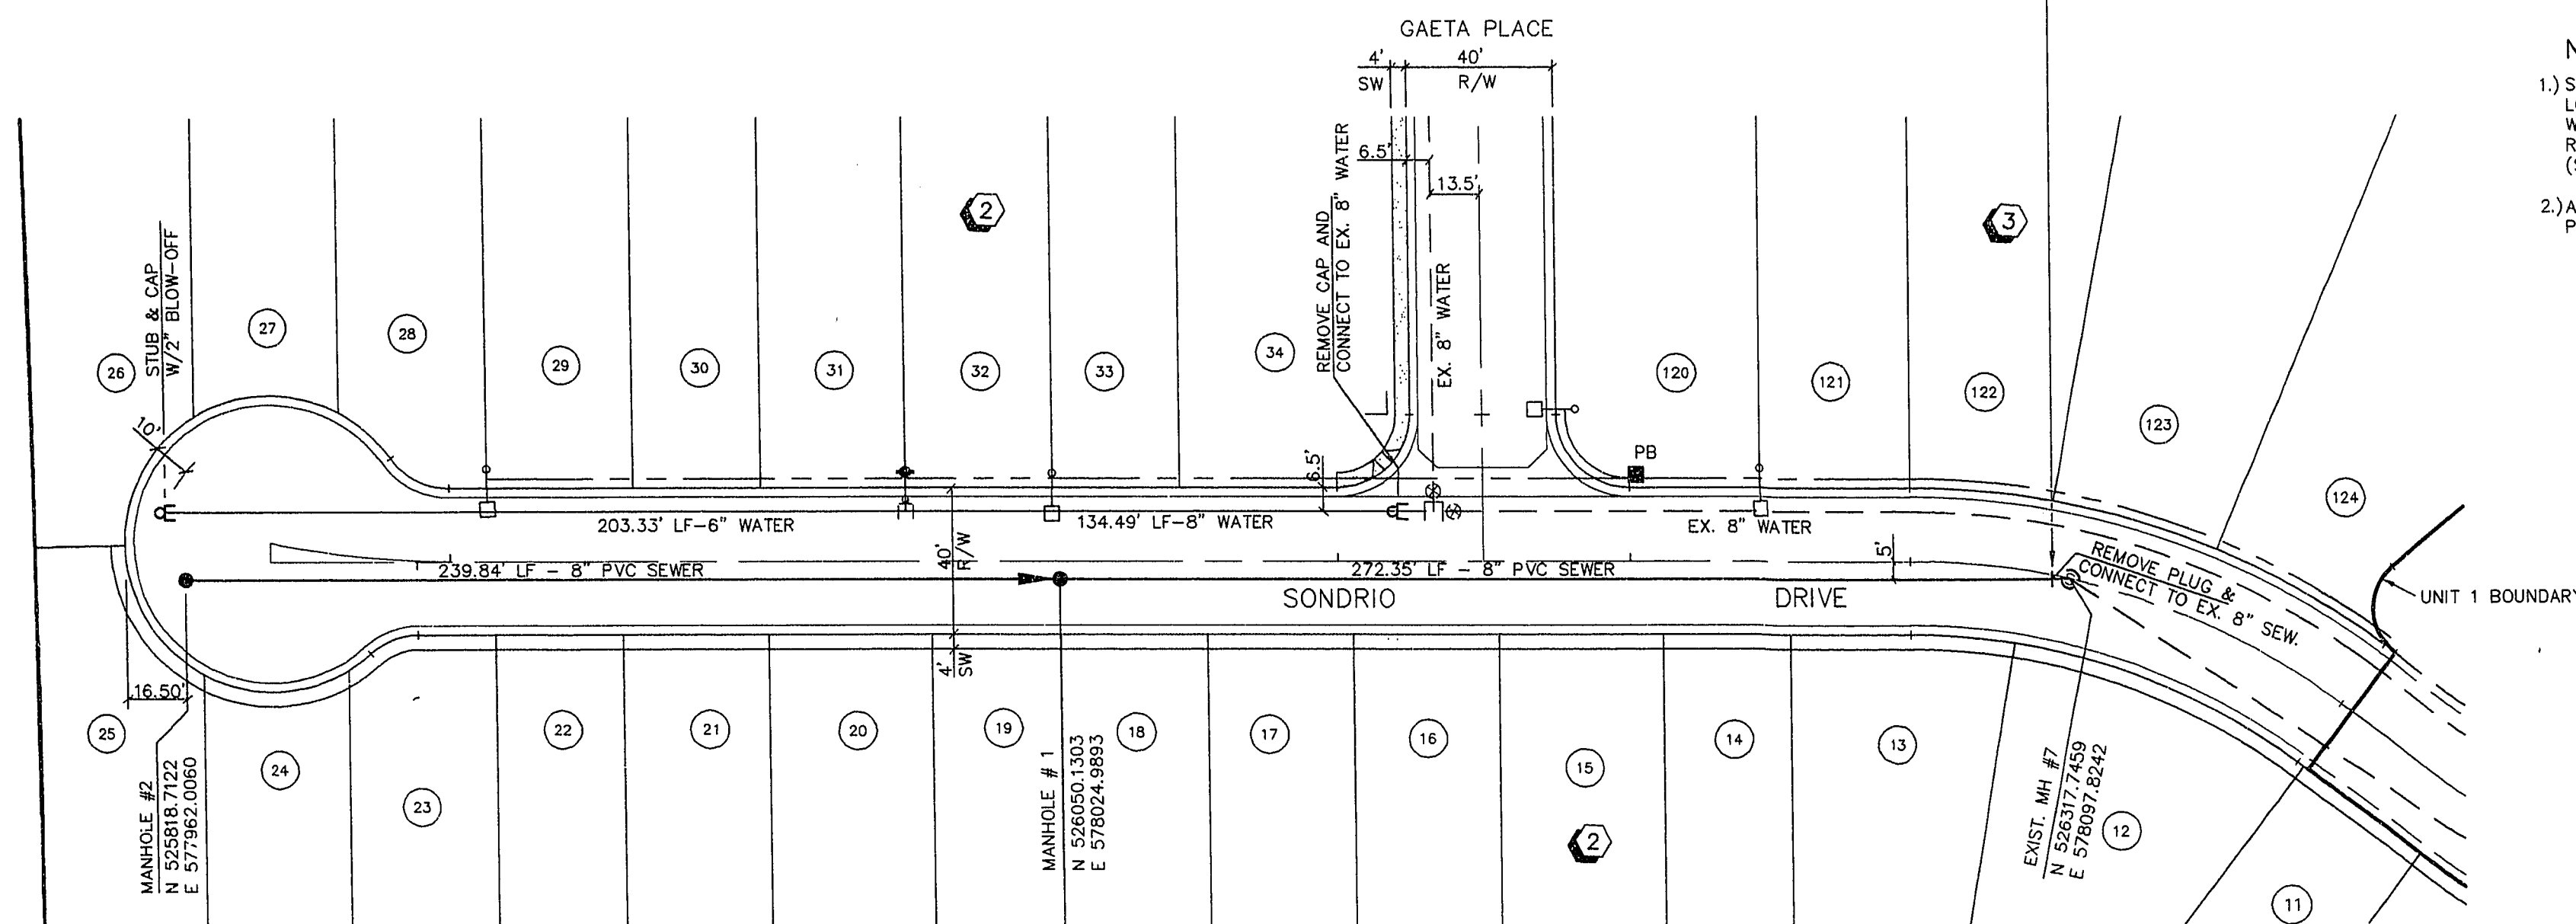



SONDRIO DRIVE (PUBLIC)

NOTE:
CONTRACTOR TO VERIFY HORIZONTAL AND VERTICAL
ALIGNMENT OF EXISTING UTILITIES AND TO NOTIFY
THE ENGINEER IMMEDIATELY OF ANY DISCREPANCIES
PRIOR TO CONSTRUCTION.

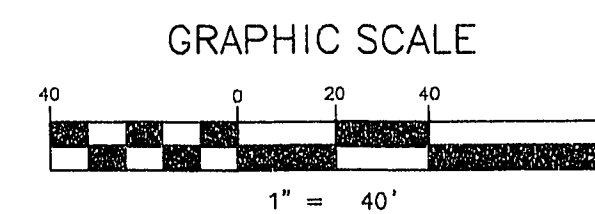

NOTES:

- 1.) SEWER WYES AND LATERALS FOR
LOTS 1 THRU 12, 123 AND 124
WERE INSTALLED WITH UNIT 1.
REFER TO MASTER UTILITY PLAN
(SHT.S) FOR LOCATION.
- 2.) ALL SANITARY SEWERS ARE
PUBLICLY OWNED AND MAINTAINED.

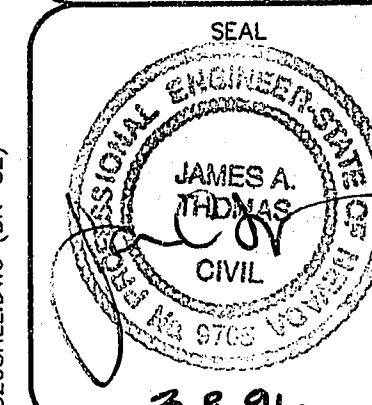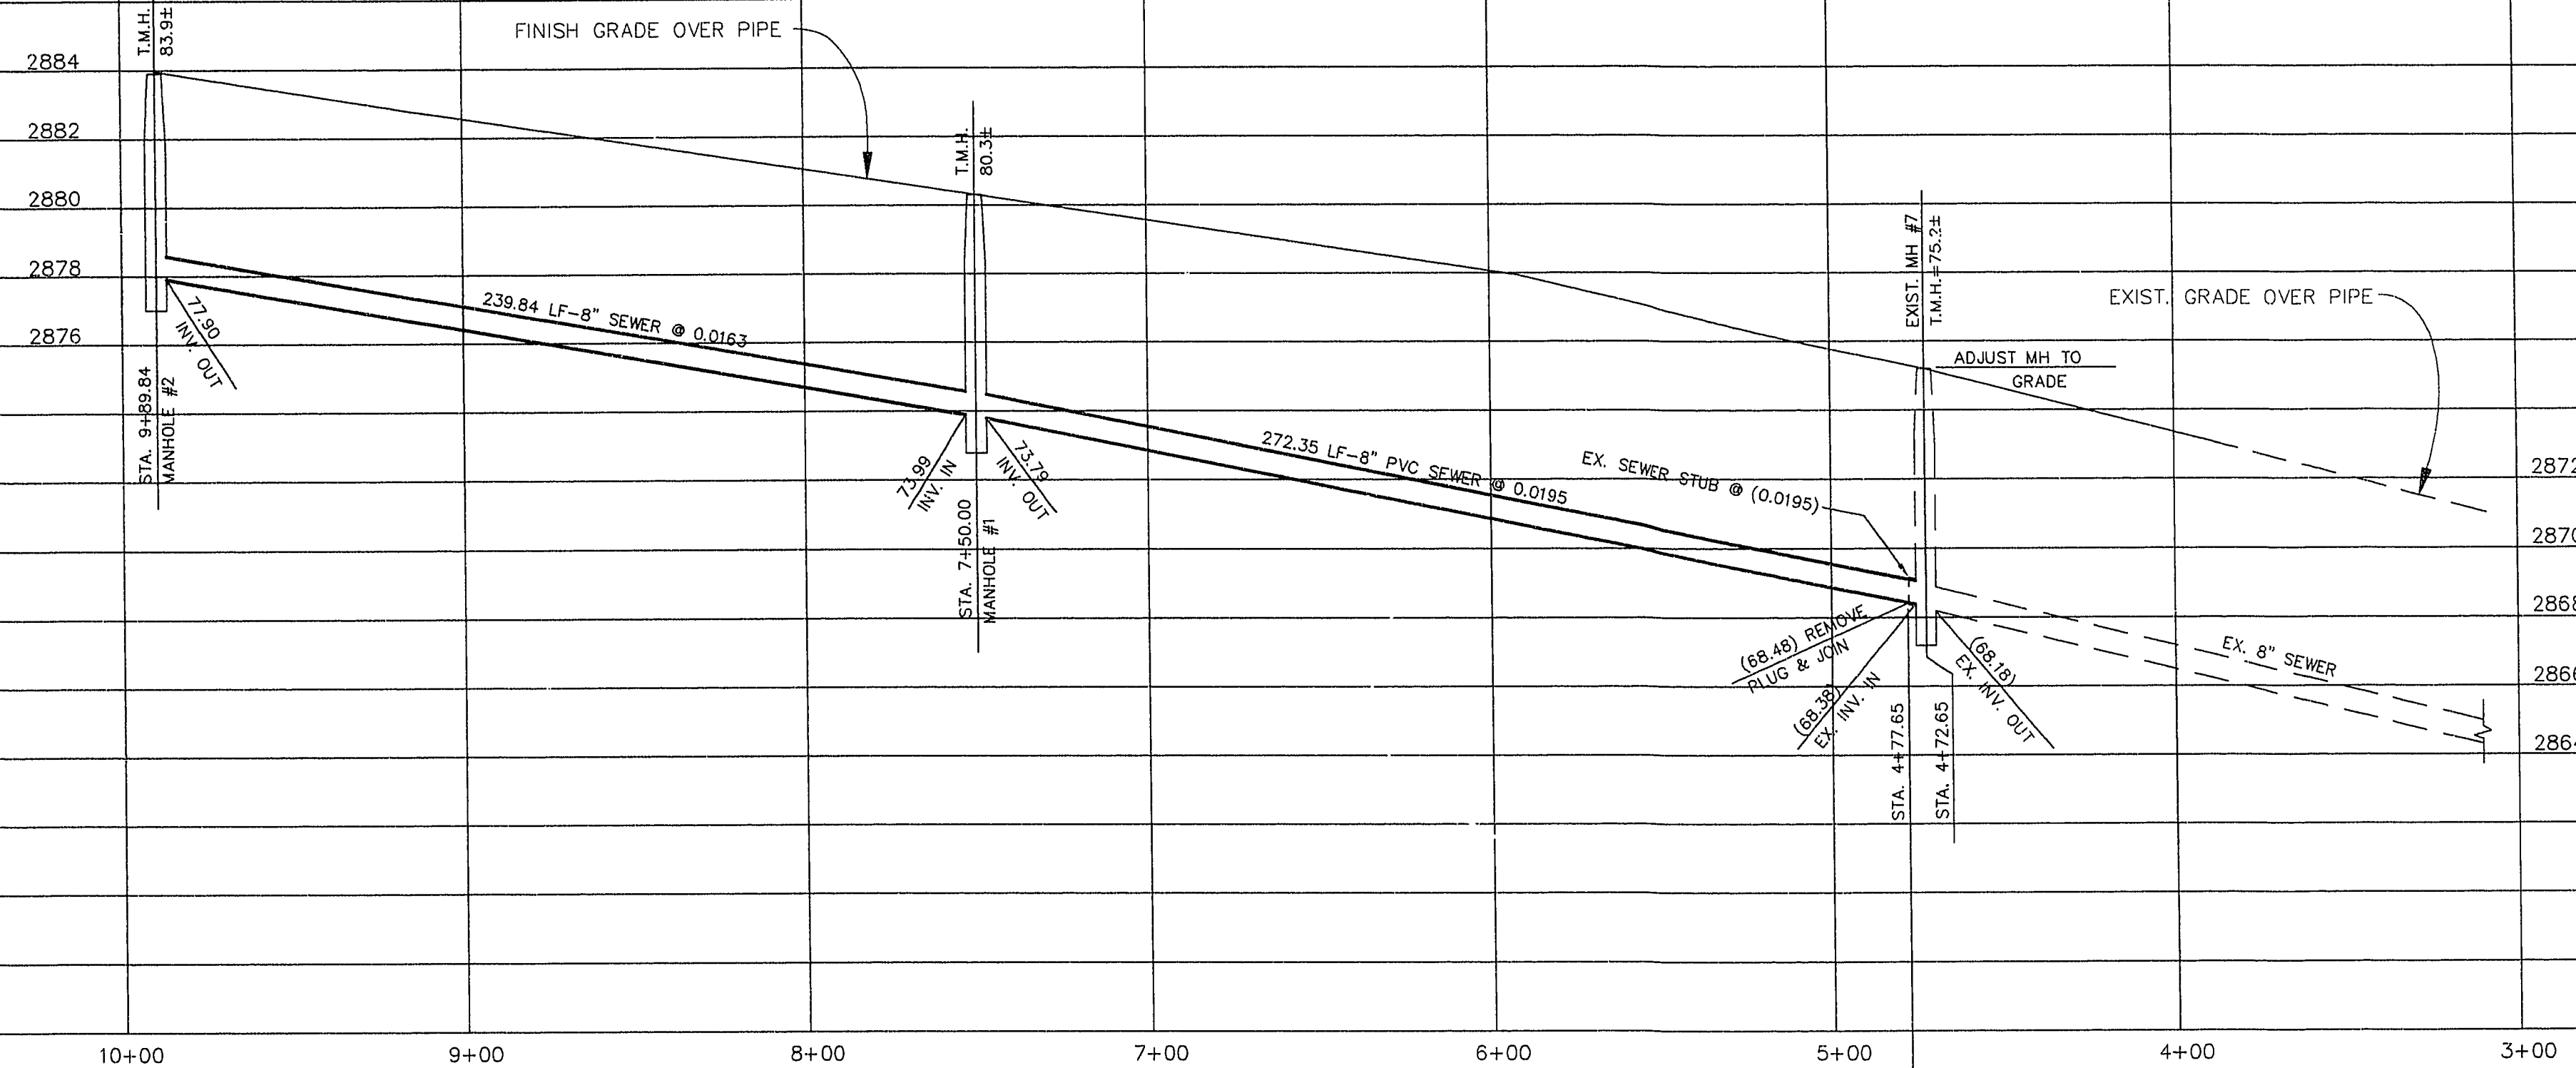

WO NO. 4820-2

BY RTS/JEM

DATE NOV. 95'

SCALE: HORIZ. 1"=40'

VERT. 1"=4'

SHEET 6 OF 6 SHEETS

PLASTER DEVELOPMENT
CITY OF LAS VEGAS



SEWER PLAN - PROFILE
SONDRIO DRIVE
INDIAN HILLS
UNIT 2

CONSULTING ENGINEERS, PLANNERS & LAND SURVEYORS
2727 SOUTH RAINBOW BOULEVARD
LAS VEGAS, NEVADA 89102-5148 PHONE (702) 873-7550 FAX (702) 362-2597