



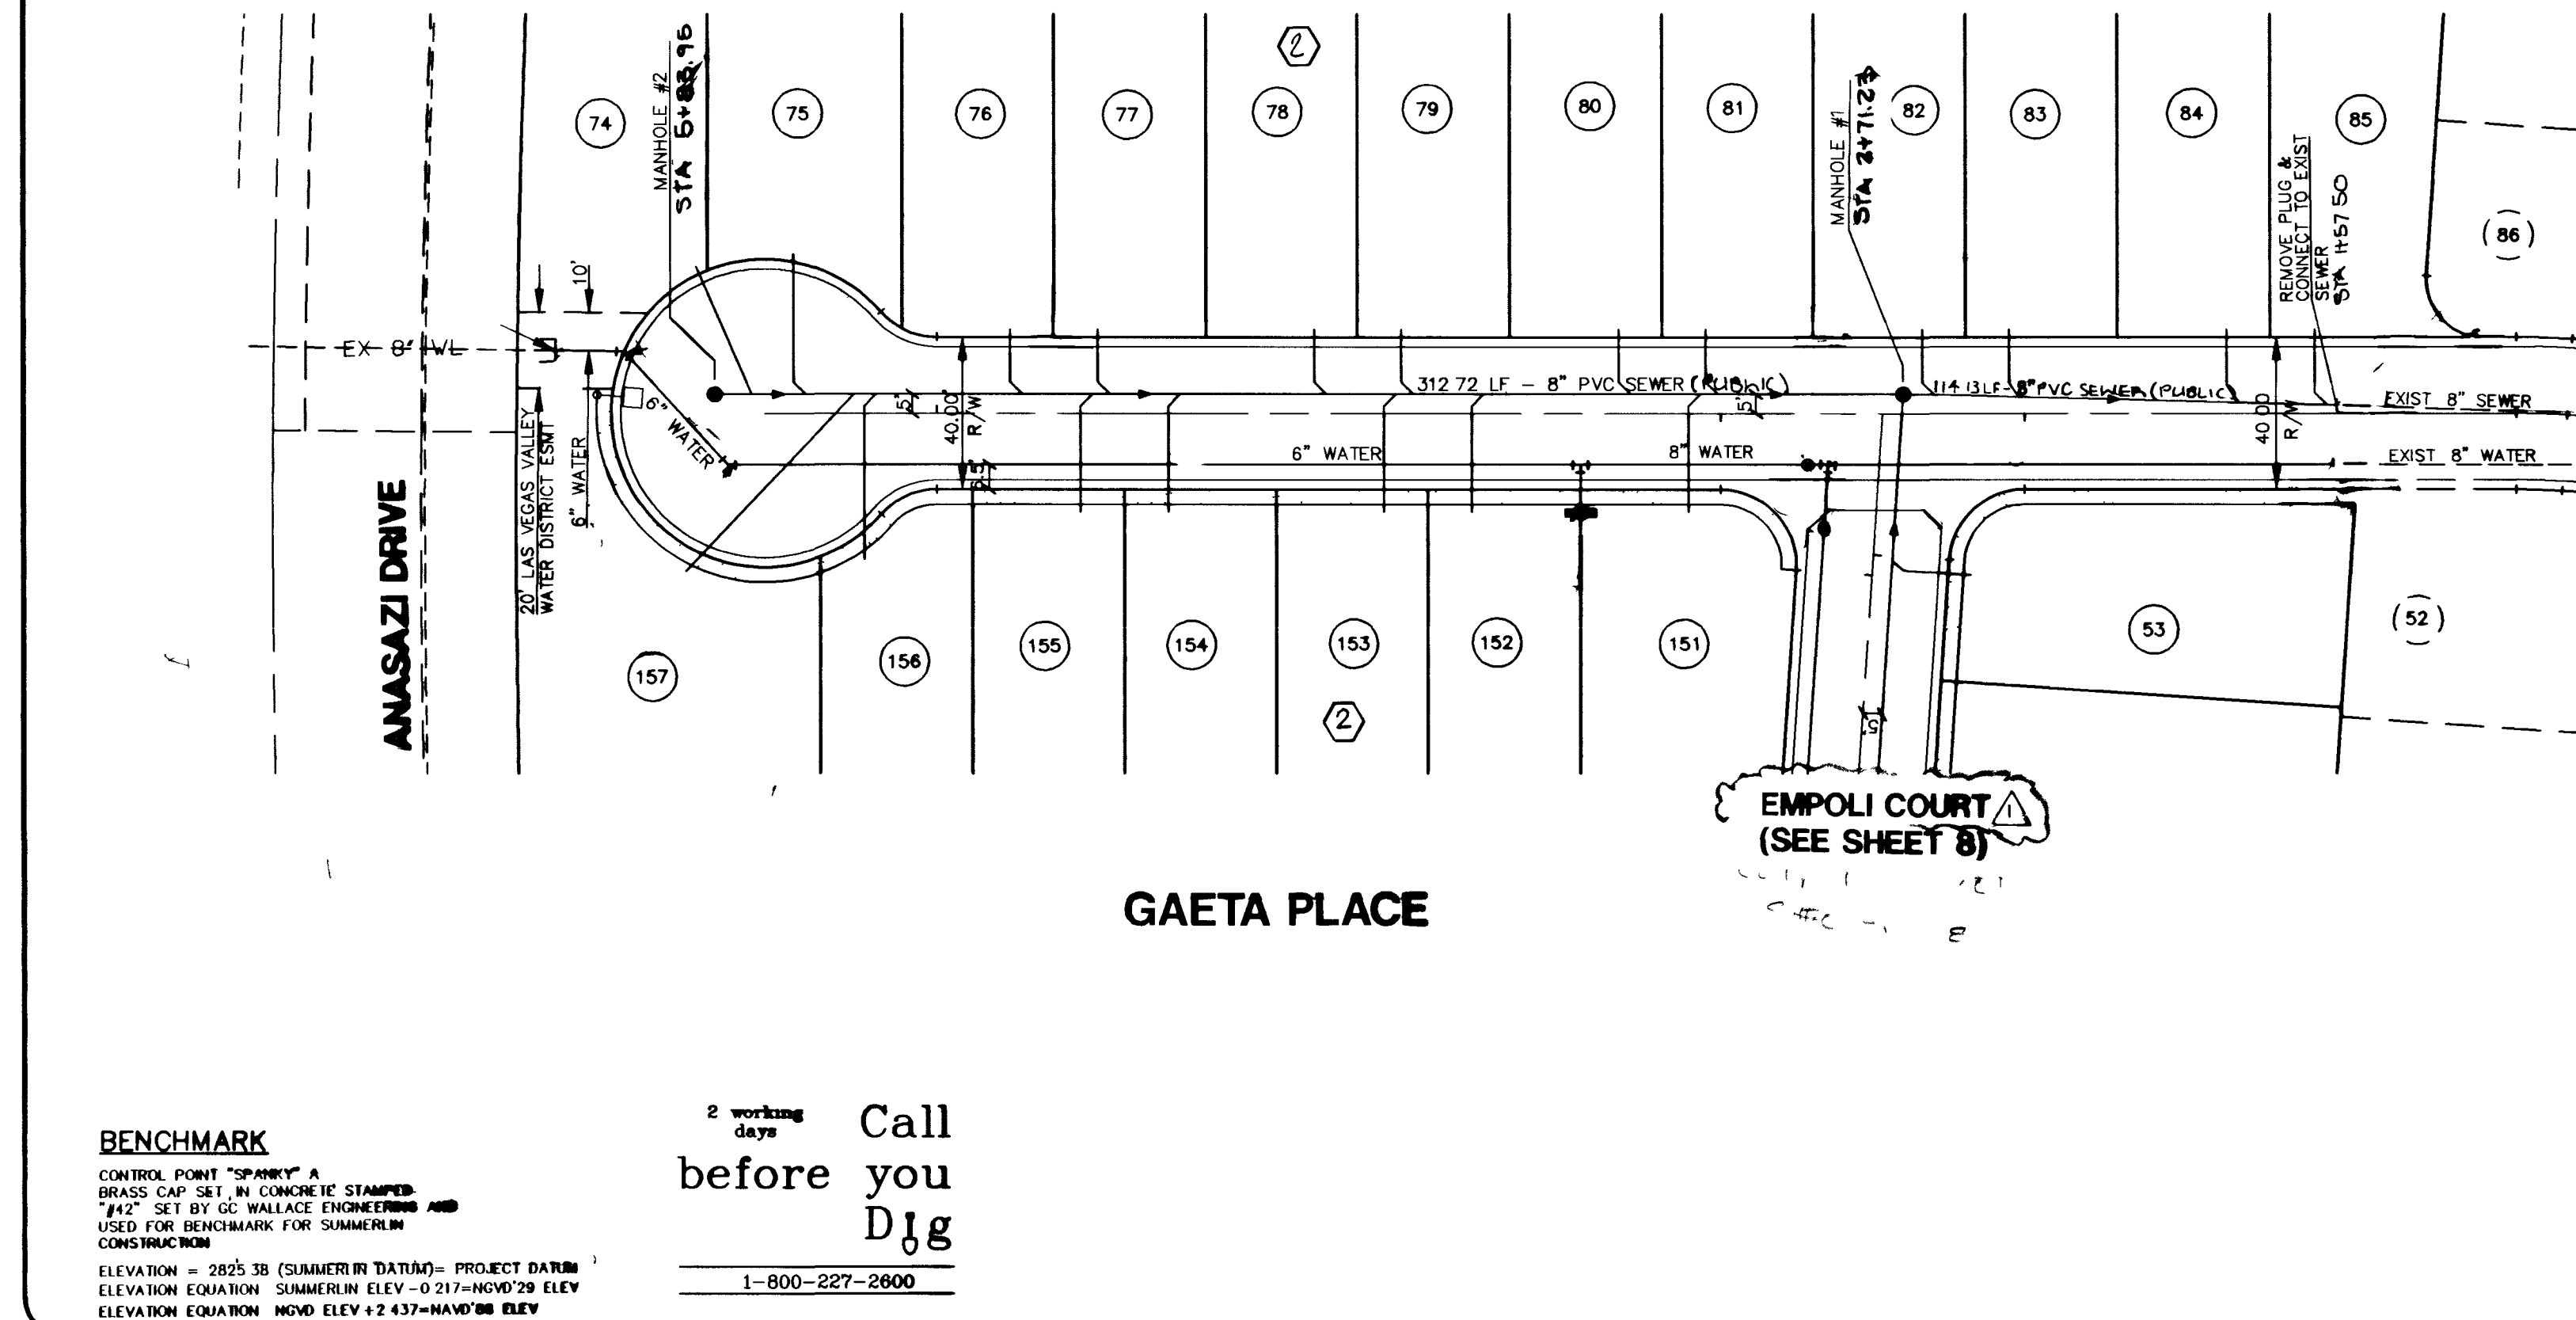


BENCHMARK
CONTROL POINT "SPARKY" A
BRASS CAP SET IN CONCRETE STAMPED
"42" SET BY G. WALLACE ENGINEERS AND
USED FOR BENCHMARK FOR SUMMERLIN
CONSTRUCTION
ELEVATION = 2825.38 (SUMMERLIN DATUM) - PROJECT DATUM
ELEVATION EQUATION: SUMMERLIN ELEV - 0.217 = NOWO 28 ELEV
ELEVATION EQUATION: NOWO ELEV + 2.437 = BENCHMARK ELEV


2 working days
Call before you Dig
1-800-227-2600

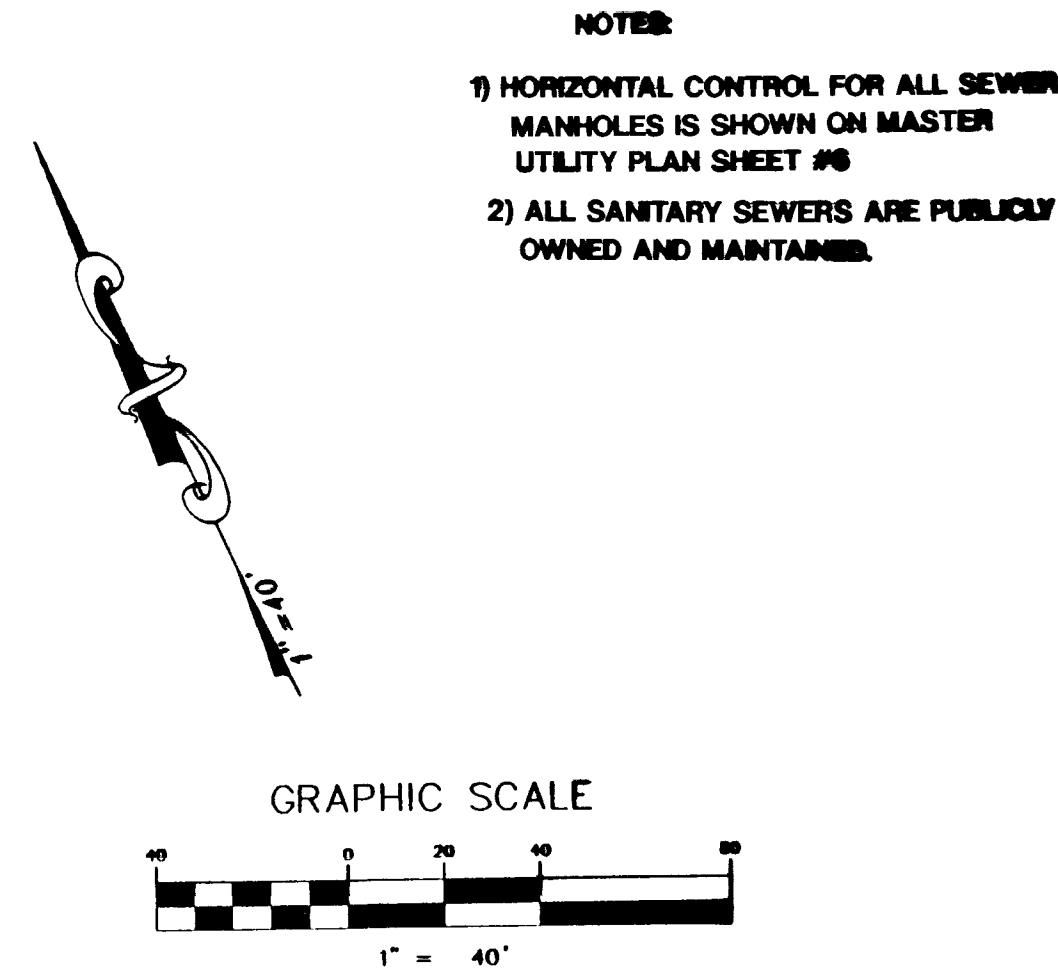

NOTES:
1) HORIZONTAL CONTROL FOR ALL SEWER MANHOLES IS SHOWN ON MASTER UTILITY PLAN SHEET #8
2) ALL SANITARY SEWERS ARE PUBLICLY OWNED AND MAINTAINED.

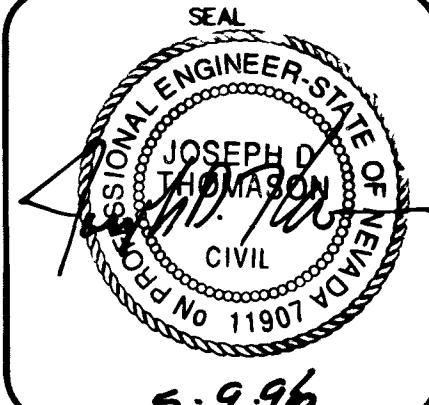

WO NO **4820-3**
BY
DATE **JAN '96**
SCALE HORIZ 1"=40'
SCALE VERT 1"=4'
SHEET **7** OF 8 SHEETS

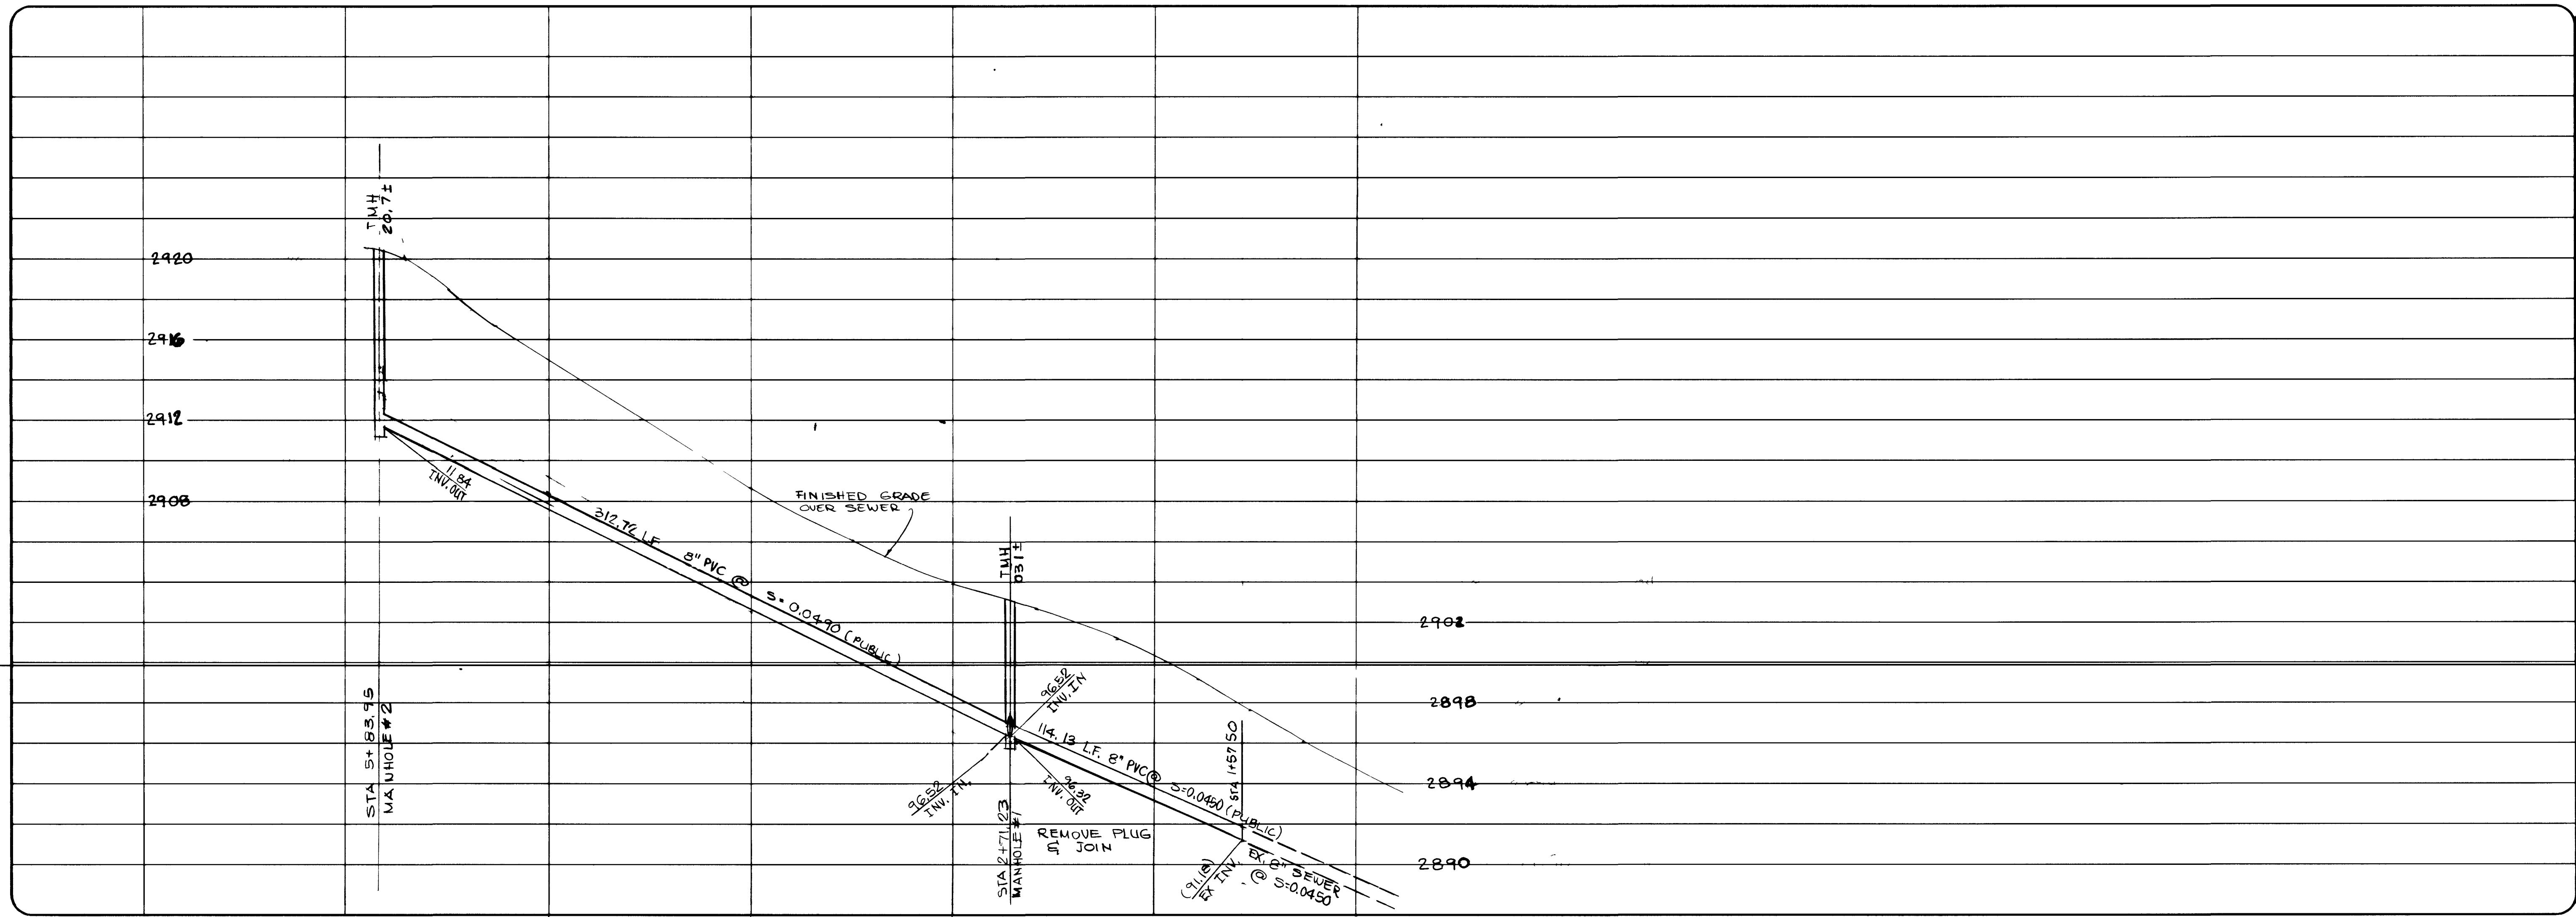

PLASTER DEVELOPMENT CITY OF LAS VEGAS
CONSULTING ENGINEERS • PLANNERS • LAND SURVEYORS
2727 SOUTH RAINBOW BOULEVARD
LAS VEGAS, NEVADA 89102-5148 PHONE (702) 873-7550 FAX (702) 362-2597
REVISION
1 7.31.96 MDM BY
2 8/10/96 RB
3

629

11-23-23

307Y-44/0-3

