

APPROVALS:

CITY OF LAS VEGAS
CITY ENGINEER


12-6-88
DATE

CITY OF LAS VEGAS
FIRE MARSHALL


11/30/88
DATE

NEVADA POWER COMPANY
NEVADA POWER COMPANY APPROVES THE POINT
OF SERVICE TO THE STREET LIGHT SYSTEM. THIS
SHALL NOT BE DEEMED TO CONSENT TO THE PLACE-
MENT OF THE LIGHT POLES WHICH MAY BE IN
CONFLICT WITH NEVADA POWER COMPANY'S PRIOR
RIGHTS AND/OR FACILITIES.

10-13-88
DATE

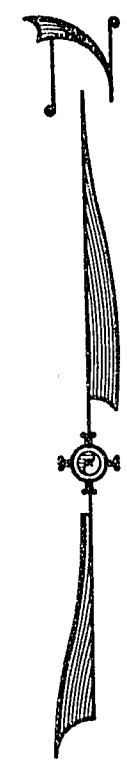


1" = 30'

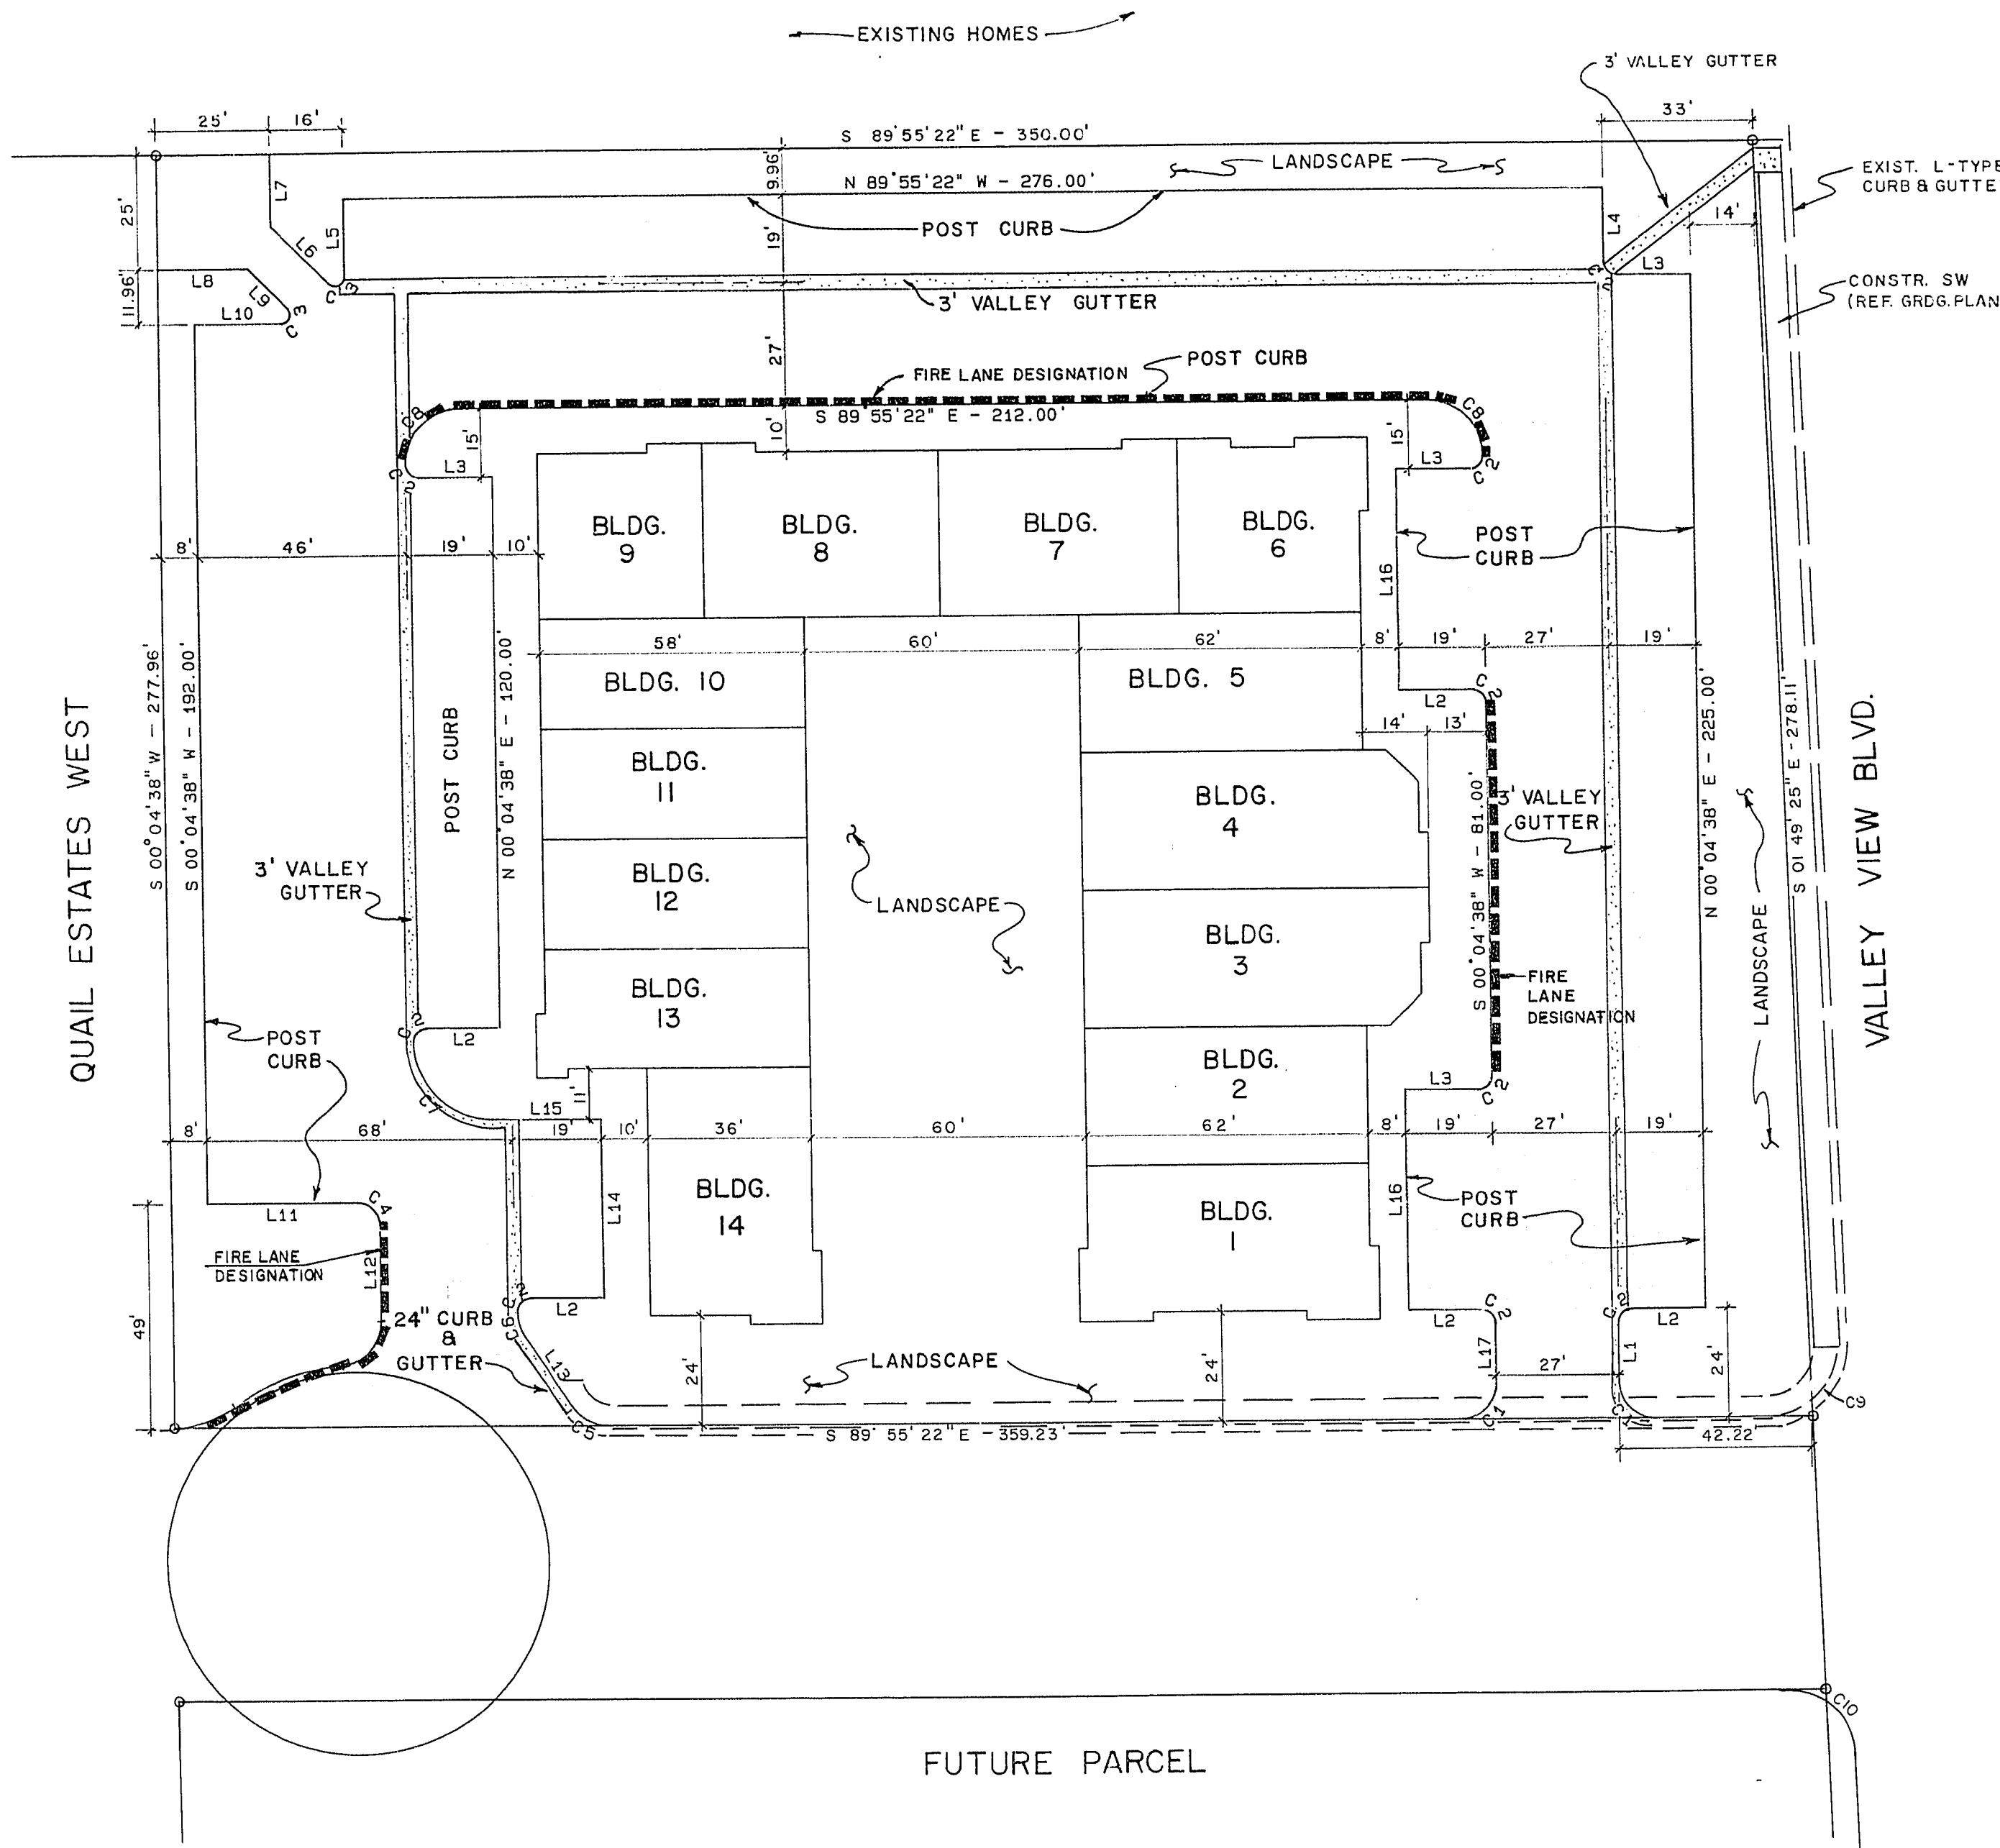

LINE	BEARING	DISTANCE
L1	N 00°04'38" E	13.00'
L2	S 89°55'22" E	16.00'
L3	N 89°55'22" W	16.00'
L4	N 00°04'38" E	16.00'
L5	S 00°04'38" W	17.00'
L6	N 44°55'22" W	17.80'
L7	N 00°04'38" E	15.79'
L8	S 89°55'22" E	19.87'
L9	S 44°55'22" E	12.09'
L10	N 89°55'22" W	19.00'
L11	S 89°55'22" E	33.00'
L12	S 00°04'38" W	20.85'
L13	N 33°37'29" W	18.03'
L14	N 00°04'38" E	39.00'
L15	N 89°55'22" W	24.00'
L16	S 00°04'38" W	48.00'
L17	S 00°04'38" W	13.00'

CURVE	DELTA	RADIUS	LENGTH	CHORD	TANGENT
C1	90°00'00"	8.00'	12.57'	11.31'	8.00'
C2	90°00'00"	3.00'	4.71'	4.24'	3.00'
C3	135°00'00"	2.00'	4.71'	3.70'	4.83'
C4	90°00'00"	5.00'	7.85'	7.07'	5.00'
C5	55°17'53"	10.00'	8.83'	9.44'	5.35'
C6	33°42'07"	10.00'	5.88'	5.80'	3.03'
C7	90°00'00"	17.00'	26.70'	24.04'	17.00'
C8	90°00'00"	12.00'	16.85'	16.97'	12.00'
C9	91°54'03"	15.00'	24.06'	21.56'	15.51'
C10	88°05'57"	15.00'	23.06'	20.86'	14.51'

NOTE:
REF. ARCH. PLANS FOR:
BUILDING DIMENSIONS,
SIDEWALK DIMENSIONS AND
CONFIGURATIONS.

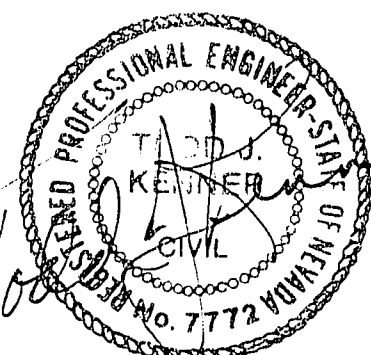

10/13/88

Sheet 2 of 6

12.9.51

1074-4009

QUAIL ESTATES WEST PROFESSIONAL OFFICE
SITE PLAN
LAS VEGAS, CLARK COUNTY, NEVADA

DESIGNED BY: MJF
DRAWN BY: TCB
CHECKED BY: TJK
DATE: AUGUST 1988

SHEET
S-1
OF
5

SUMMIT
ENGINEERING
CORPORATION
CONSULTING ENGINEERS AND SURVEYORS
175 E. PERD AVENUE SUITE C-34
LAS VEGAS, NEVADA 89101 (360-180)

SCALE
1" = 30'
HORIZ
VERT
JOB No. 7217
DRAWING No.