


1" = 30'

RANCHO DRIVE

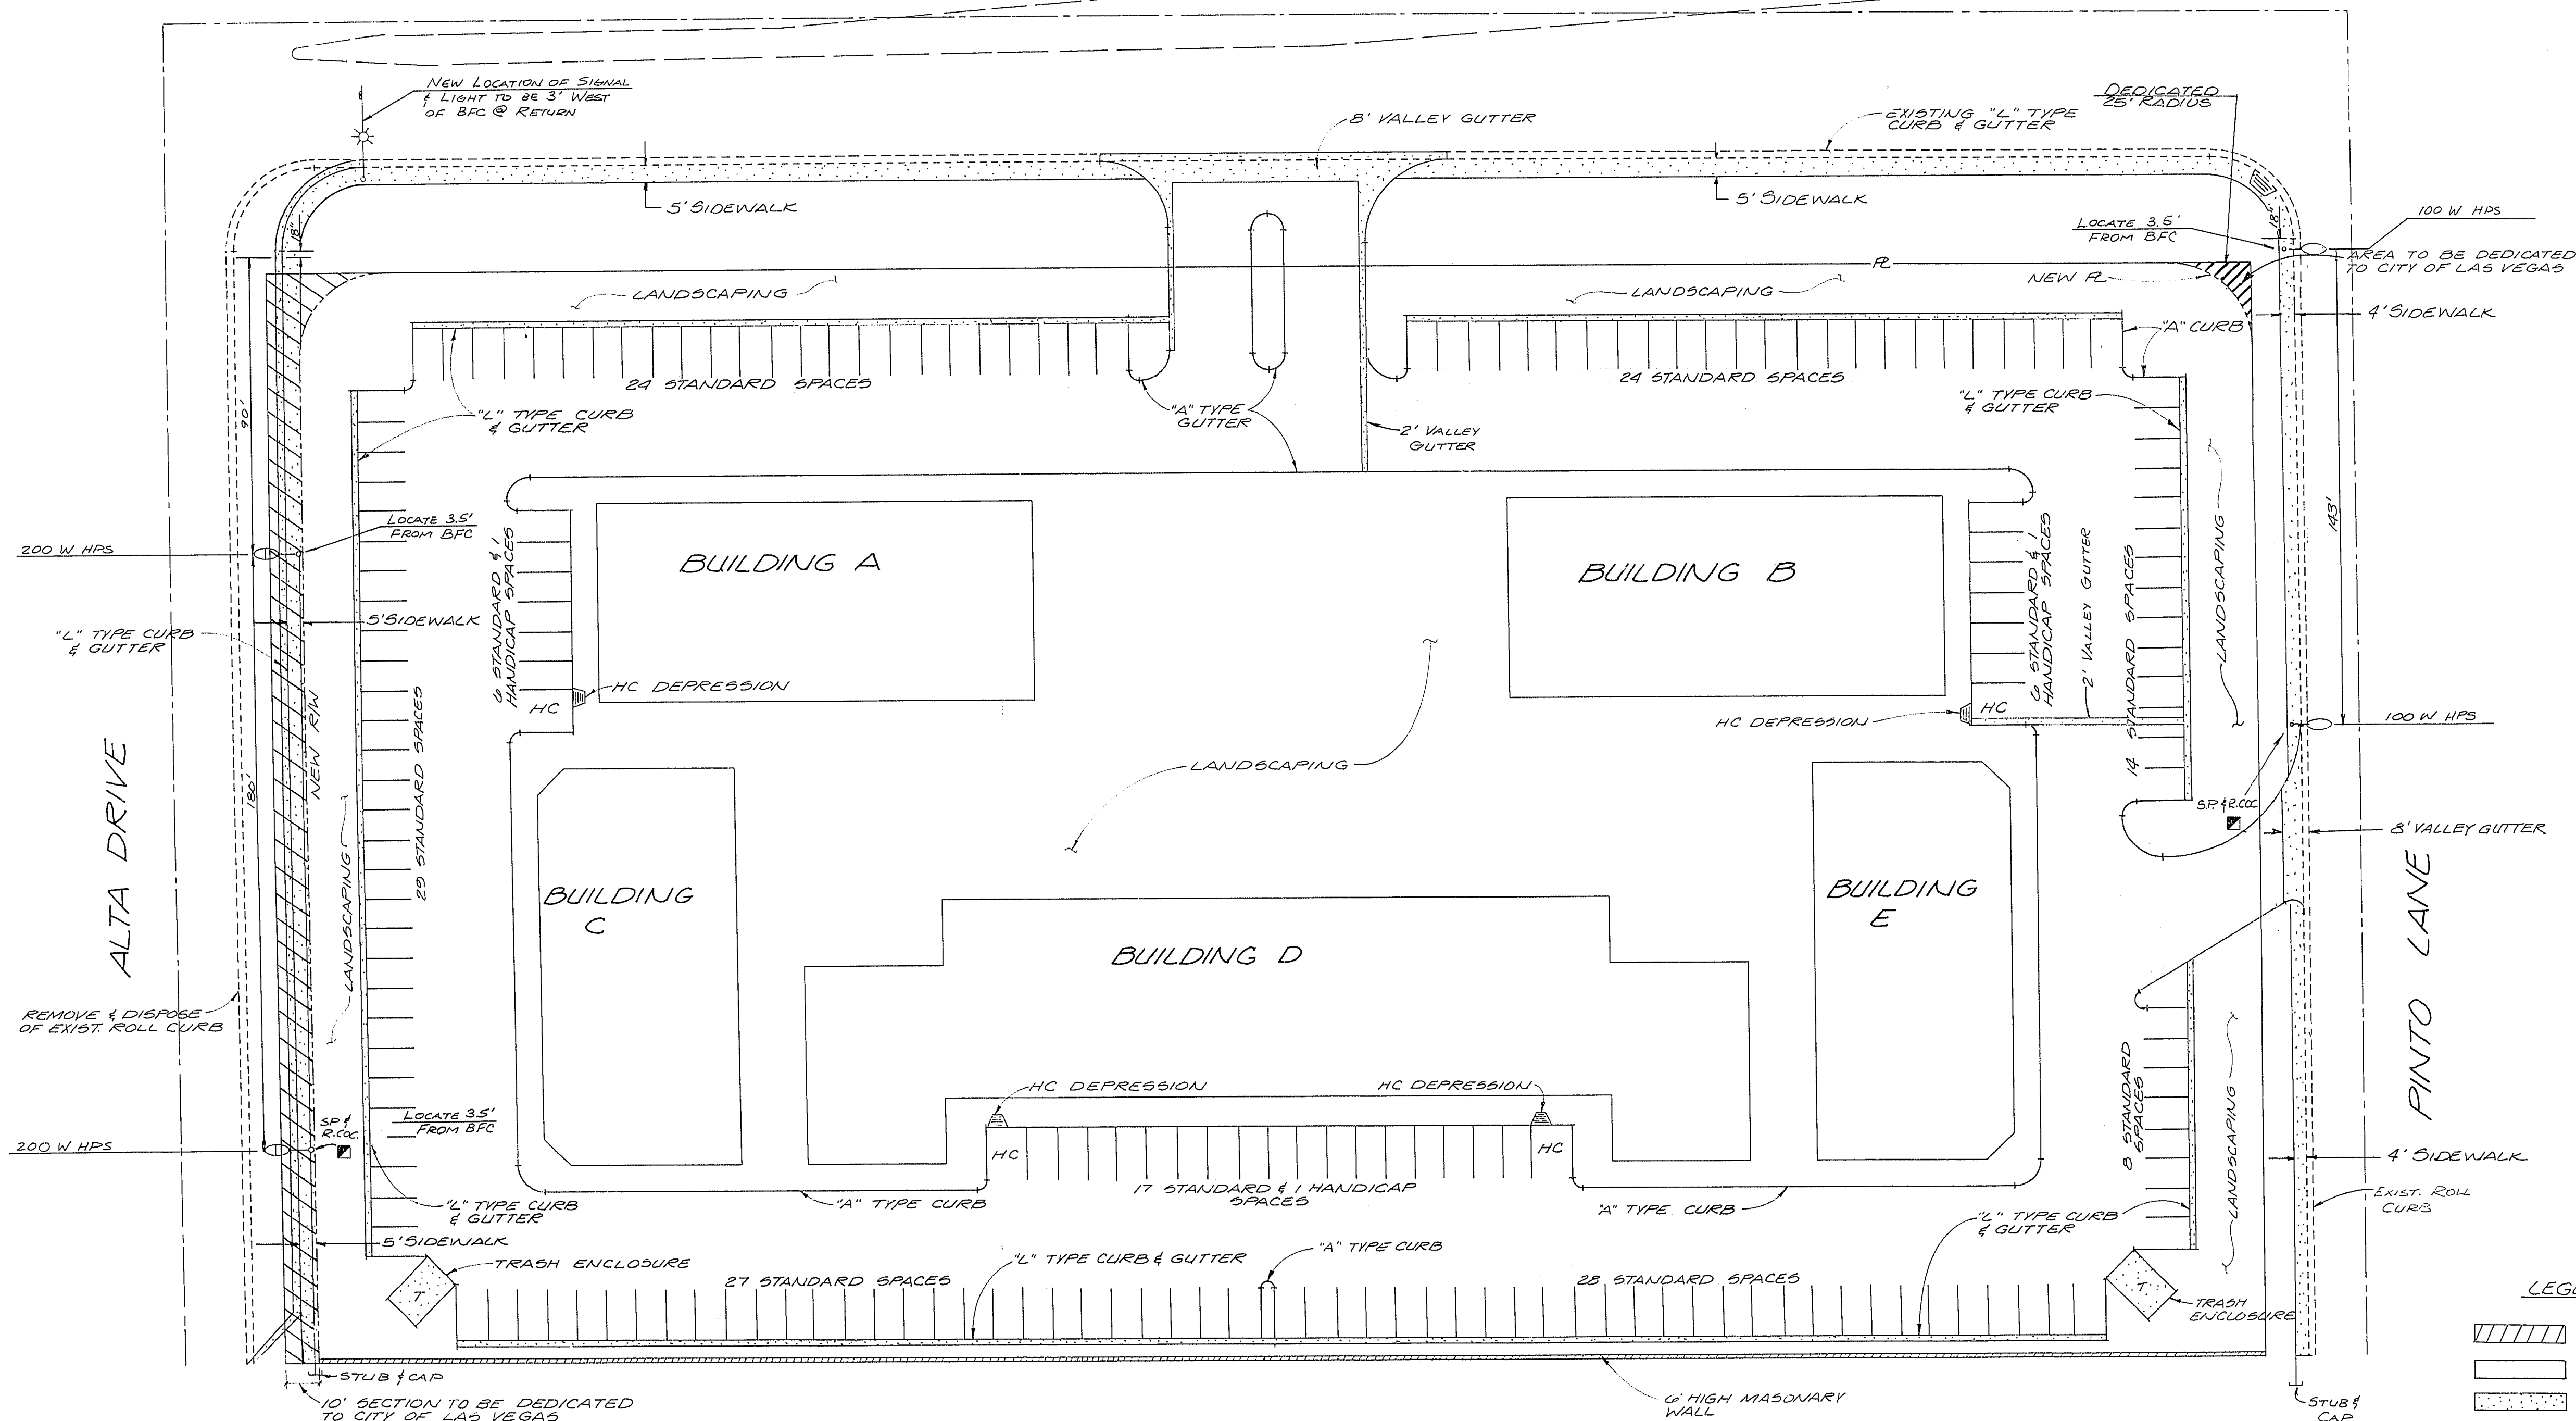

CITY OF LAS VEGAS STREET NOTES:

- 1) A.C. PAVEMENT TO BE 1/2" ABOVE LIP OF GUTTER AFTER COMPACTION.
- 2) SUBGRADE FOR TYPE I UNDER CURB AND GUTTER AND UNDER A.C. (WHERE REQUIRED) TO BE CONTINUOUS.
- 3) FOG SEAL TO BE APPLIED AFTER FINAL CORRECTIONS AND ADJUSTMENTS HAVE BEEN MADE.
- 4) THE MAXIMUM GRADE BREAK OCCURRING IN THE CROSS SECTION SHALL BE 2% AND SHALL FALL BETWEEN DRIVING LANES OR BETWEEN A DRIVING LANE AND A PARKING LANE.
- 5) IN PLACE NATIVE MATERIAL (NON-CEMENTED) MAY BE SUBSTITUTED FOR TYPE I AGGREGATE BASE PROVIDED THE FOLLOWING CONDITION IS MET: ALL OTHER REQUIREMENTS ARE THE SAME AS FOR TYPE I.
 - a) The Native soil falls within the gradation tolerance of Type I or Type II or is classified as GP or GW by the unified classification system (all material to pass a 3" sieve).

- 6) IN PLACE NATIVE MATERIAL (CEMENTED) MAY BE SUBSTITUTED FOR TYPE I AGGREGATE BASE PROVIDED THAT THE ENTIRE RIGHT OF WAY IS SUFFICIENTLY BALL BROKEN (BACK OF SIDEWALK TO BACK OF SIDEWALK). THE BALL BROKEN AREAS SHALL BE LEVELED AND COMPACTED AS PER SPECIFICATION.
- 7) OWNER AGREES THAT IF THE EXISTING MATERIAL DOES NOT CONFORM TO STANDARD SPECIFICATIONS FOR TYPE I GRAVEL BASE THEN MATERIAL MEETING THOSE SPECIFICATIONS WILL BE IMPORTED.


CITY OF LAS VEGAS STREET LIGHT NOTES:

- 1) ALL STREET LIGHTING INSTALLATIONS SHALL CONFORM TO THE LATEST ISSUE OF THE STANDARD DETAILS AND SPECIFICATIONS OF THE CITY OF LAS VEGAS, AND SHALL ALSO CONFORM TO THE UNIFORM STANDARD SPECIFICATIONS FOR PUBLIC WORKS CONSTRUCTION OF OFF-SITE IMPROVEMENTS, CLARK COUNTY AREA, 1978, UNLESS OTHERWISE NOTED.
- 2) SEE UNIFORM STANDARD DRAWINGS FOR PUBLIC WORKS CONSTRUCTION CITY OF LAS VEGAS DRAWING NO. 623L.0004.

NOTES:

SEE UNIFORM STANDARD DRAWINGS FOR THE CLARK COUNTY AREA SPECIFICATIONS ON TYPE OF STREET LIGHTING STANDARD AND ASSEMBLY.

LEGEND			
	DEDICATED AREA		EXISTING CURB
	A.C. PAVING		HANDICAP RAMP
	CONCRETE		TRASH ENCLOSURE
	PROPOSED SERVICE POINT		

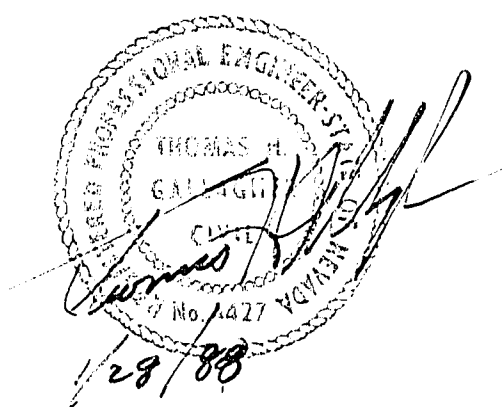

SHEET
C-5
OF
8

ENGINEERING
CORPORATION
CONSULTING ENGINEERS AND SURVEYORS
2015 N. MOUNTAIN VIEW BLVD., SUITE 100
LAS VEGAS, NEVADA 89102-1001
702-735-1801

SCALE:
HORIZ. 1"=50'
VERT. 1"=10'

JOB NO. 7117

DRAWING NO.

QUAIL PARK V
PARKING, PAVING & LIGHTING PLAN

CLARK COUNTY, NEVADA
LAS VEGAS

REV.	DATE	DESCRIPTION	BY	APP'D
1	12/29/88	ADD SIDEWALK FOR GUT TO PINTO LN	KJE	RLA
2	6/15/89		RLA	

DESIGNED BY: MAD/KJE

DRAWN BY:

CHECKED BY:

DATE: JANUARY 1988