


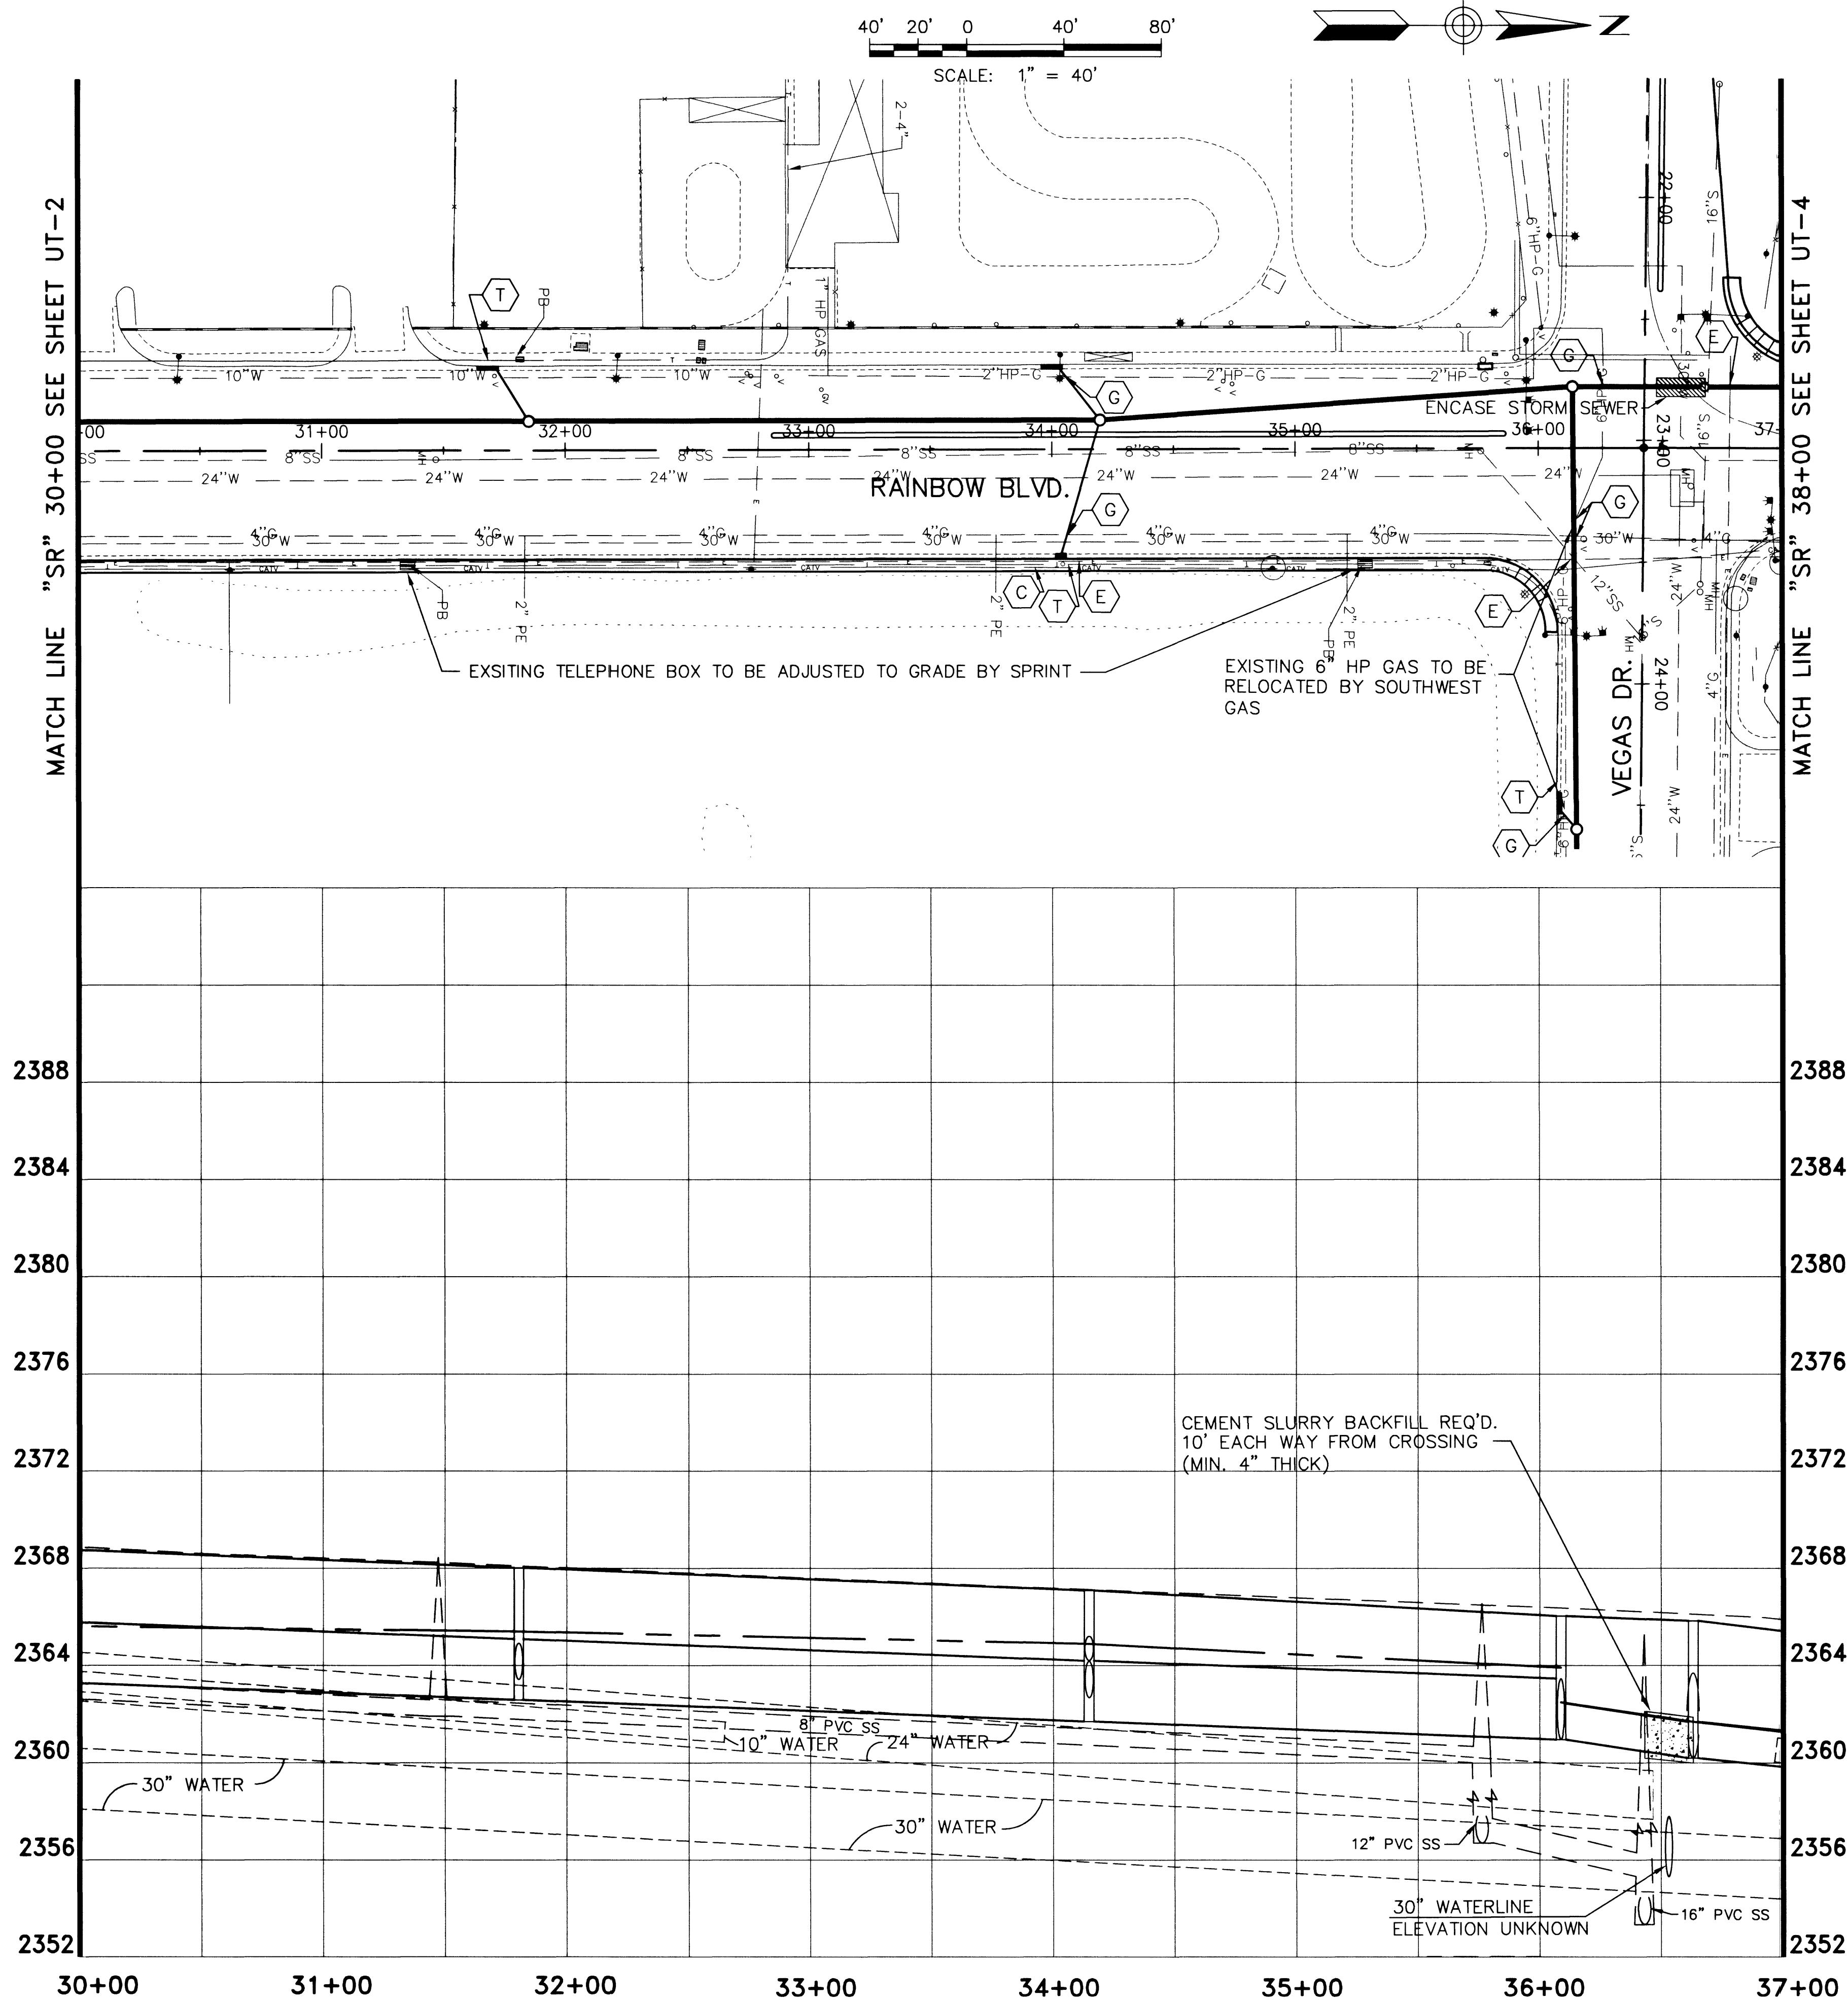


POTENTIAL UTILITY CONFLICTS:

- (C) EXISTING UNDERGROUND CABLE TO BE RELOCATED BY COX COMMUNICATIONS. IF FOUND TO BE A CONFLICT DURING CONSTRUCTION
  - (E) EXISTING UNDERGROUND POWER TO BE RELOCATED BY NEVADA POWER. IF FOUND TO BE A CONFLICT DURING CONSTRUCTION
  - (G) EXISTING UNDERGROUND GAS TO BE RELOCATED BY SOUTHWEST GAS. IF FOUND TO BE A CONFLICT DURING CONSTRUCTION
  - (T) EXISTING UNDERGROUND TELEPHONE TO BE RELOCATED BY SPRINT CENTRAL TELEPHONE. IF FOUND TO BE A CONFLICT DURING CONSTRUCTION
- SEE SI SHEETS FOR RELOCATION OF EXISTING STREET LIGHTS  
SEE TS SHEETS FOR RELOCATION OF EXISTING TRAFFIC SIGNALS

BASIS OF BEARINGS  
NORTH 00°05'50" WEST, BEING THE BEARING OF THE WEST LINE OF THE SOUTHWEST QUARTER (SW 1/4) OF THE SOUTHWEST QUARTER (SW 1/4) OF SECTION 23, T. 20 S., R. 60 E., M.D.M., CLARK COUNTY, NEVADA, AS SHOWN ON FILE 80 OF PARCEL MAPS, AT PAGE 46.

BENCHMARK  
CITY OF LAS VEGAS BENCHMARK: 1LV00 26W4 RIVET AND PLATE IN TOP OF CURB, NORTHEAST RETURN OF RAINBOW BLVD AND WASHINGTON AVE. ELEV. = 724.7549 METERS (PUBLISHED NAVD'88) ELEV. = 2377.80 U.S. SURVEY FEET (CALCULATED NAVD'88)

CITY OF LAS VEGAS BENCHMARK: OLVOO 14SW5 RIVET AND PLATE IN TOP OF CURB, NORTHEAST RETURN OF SMOKE RANCH RD AND LORENZI BLVD. ELEV. = 708.7363 METERS (PUBLISHED NAVD'88) ELEV. = 2325.25 U.S. SURVEY FEET (CALCULATED NAVD'88)

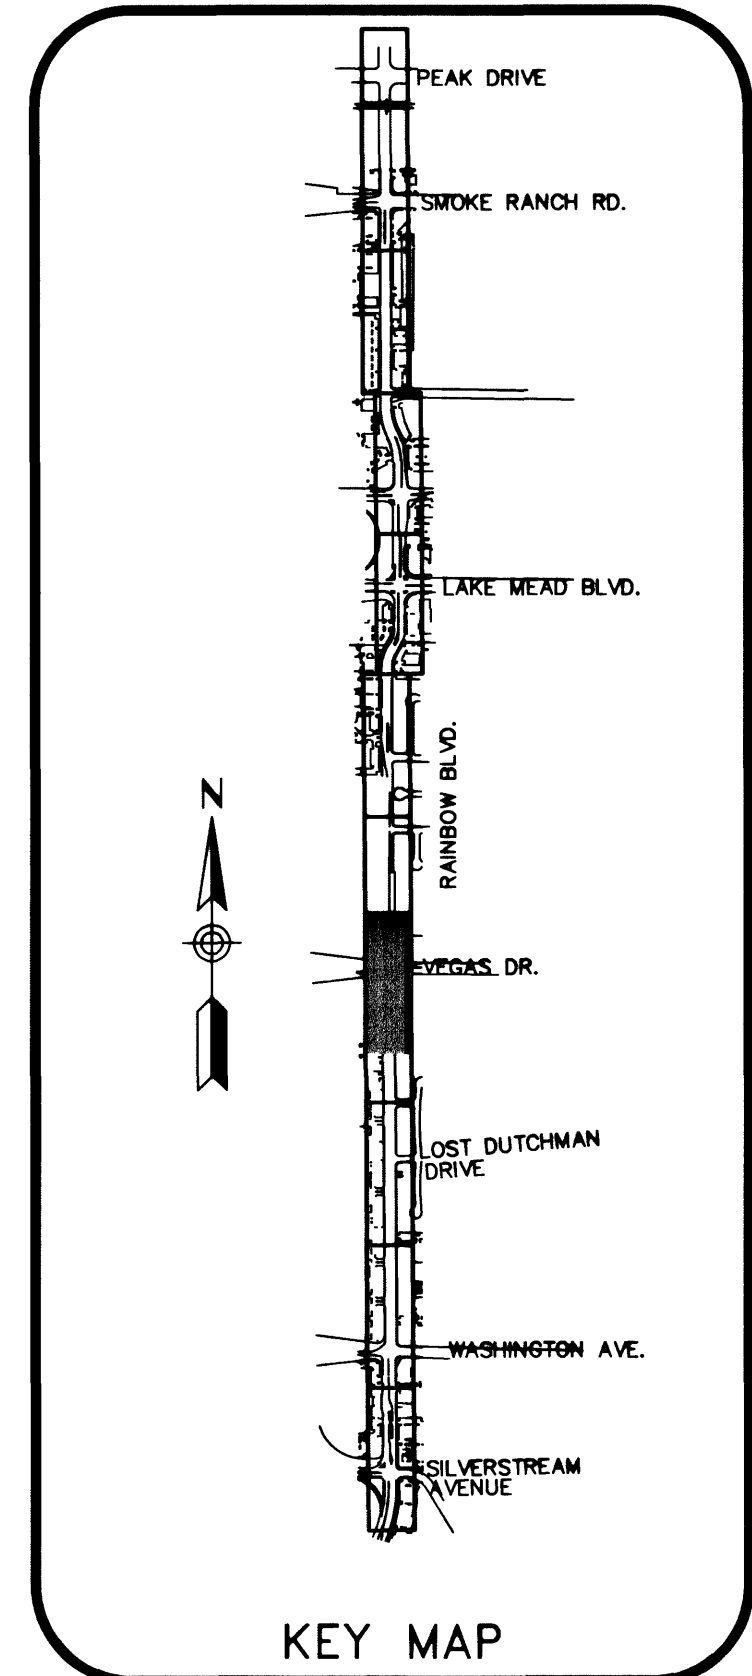

2/28/02  
Las Vegas Valley Water District Date

Call before you Dig.  
1-800-227-2600  
UNDERGROUND SERVICE (USA)  
CLARK COUNTY TRAFFIC MANAGEMENT  
OPERATIONS UNIT (702) 455-7544



|                                                                                                              |             |                 |             |                  |
|--------------------------------------------------------------------------------------------------------------|-------------|-----------------|-------------|------------------|
| PROJ NO: W7X70800                                                                                            | DESIGN: DEP | DATE: 2/14/2002 | SCALE: 1:40 | CADFILE: [blank] |
| <b>Professional Engineer Seal</b><br>DAVID E. POTTER<br>CIVIL<br>No. 8880                                    |             |                 |             |                  |
| STAMP DATE: 2/28/02                                                                                          |             |                 |             |                  |
| 5450 W. SARARA AVE., SUITE 150<br>LAS VEGAS, NEVADA 89102-1948<br>PHONE (702) 896-1730<br>FAX (702) 896-1731 |             |                 |             |                  |
| <b>Sverdrup</b><br>CIVIL, INC.                                                                               |             |                 |             |                  |
| RAINBOW BOULEVARD<br>SILVERSTREAM AVE. TO SMOKE RANCH ROAD                                                   |             |                 |             |                  |
| UTILITY PLAN & PROFILE<br>"SR" 30+00 TO "SR" 37+00                                                           |             |                 |             |                  |
| SHEET<br>UT-3<br>58 OF 110 SHEETS                                                                            |             |                 |             |                  |
| DRAWING NO.<br>107-V3519                                                                                     |             |                 |             |                  |