



REMOVE AND RESET AIR VALVE COVER FOR SIDEWALK REPLACEMENT PER UDACS STD. PLATE NOS. 37A OR 37B

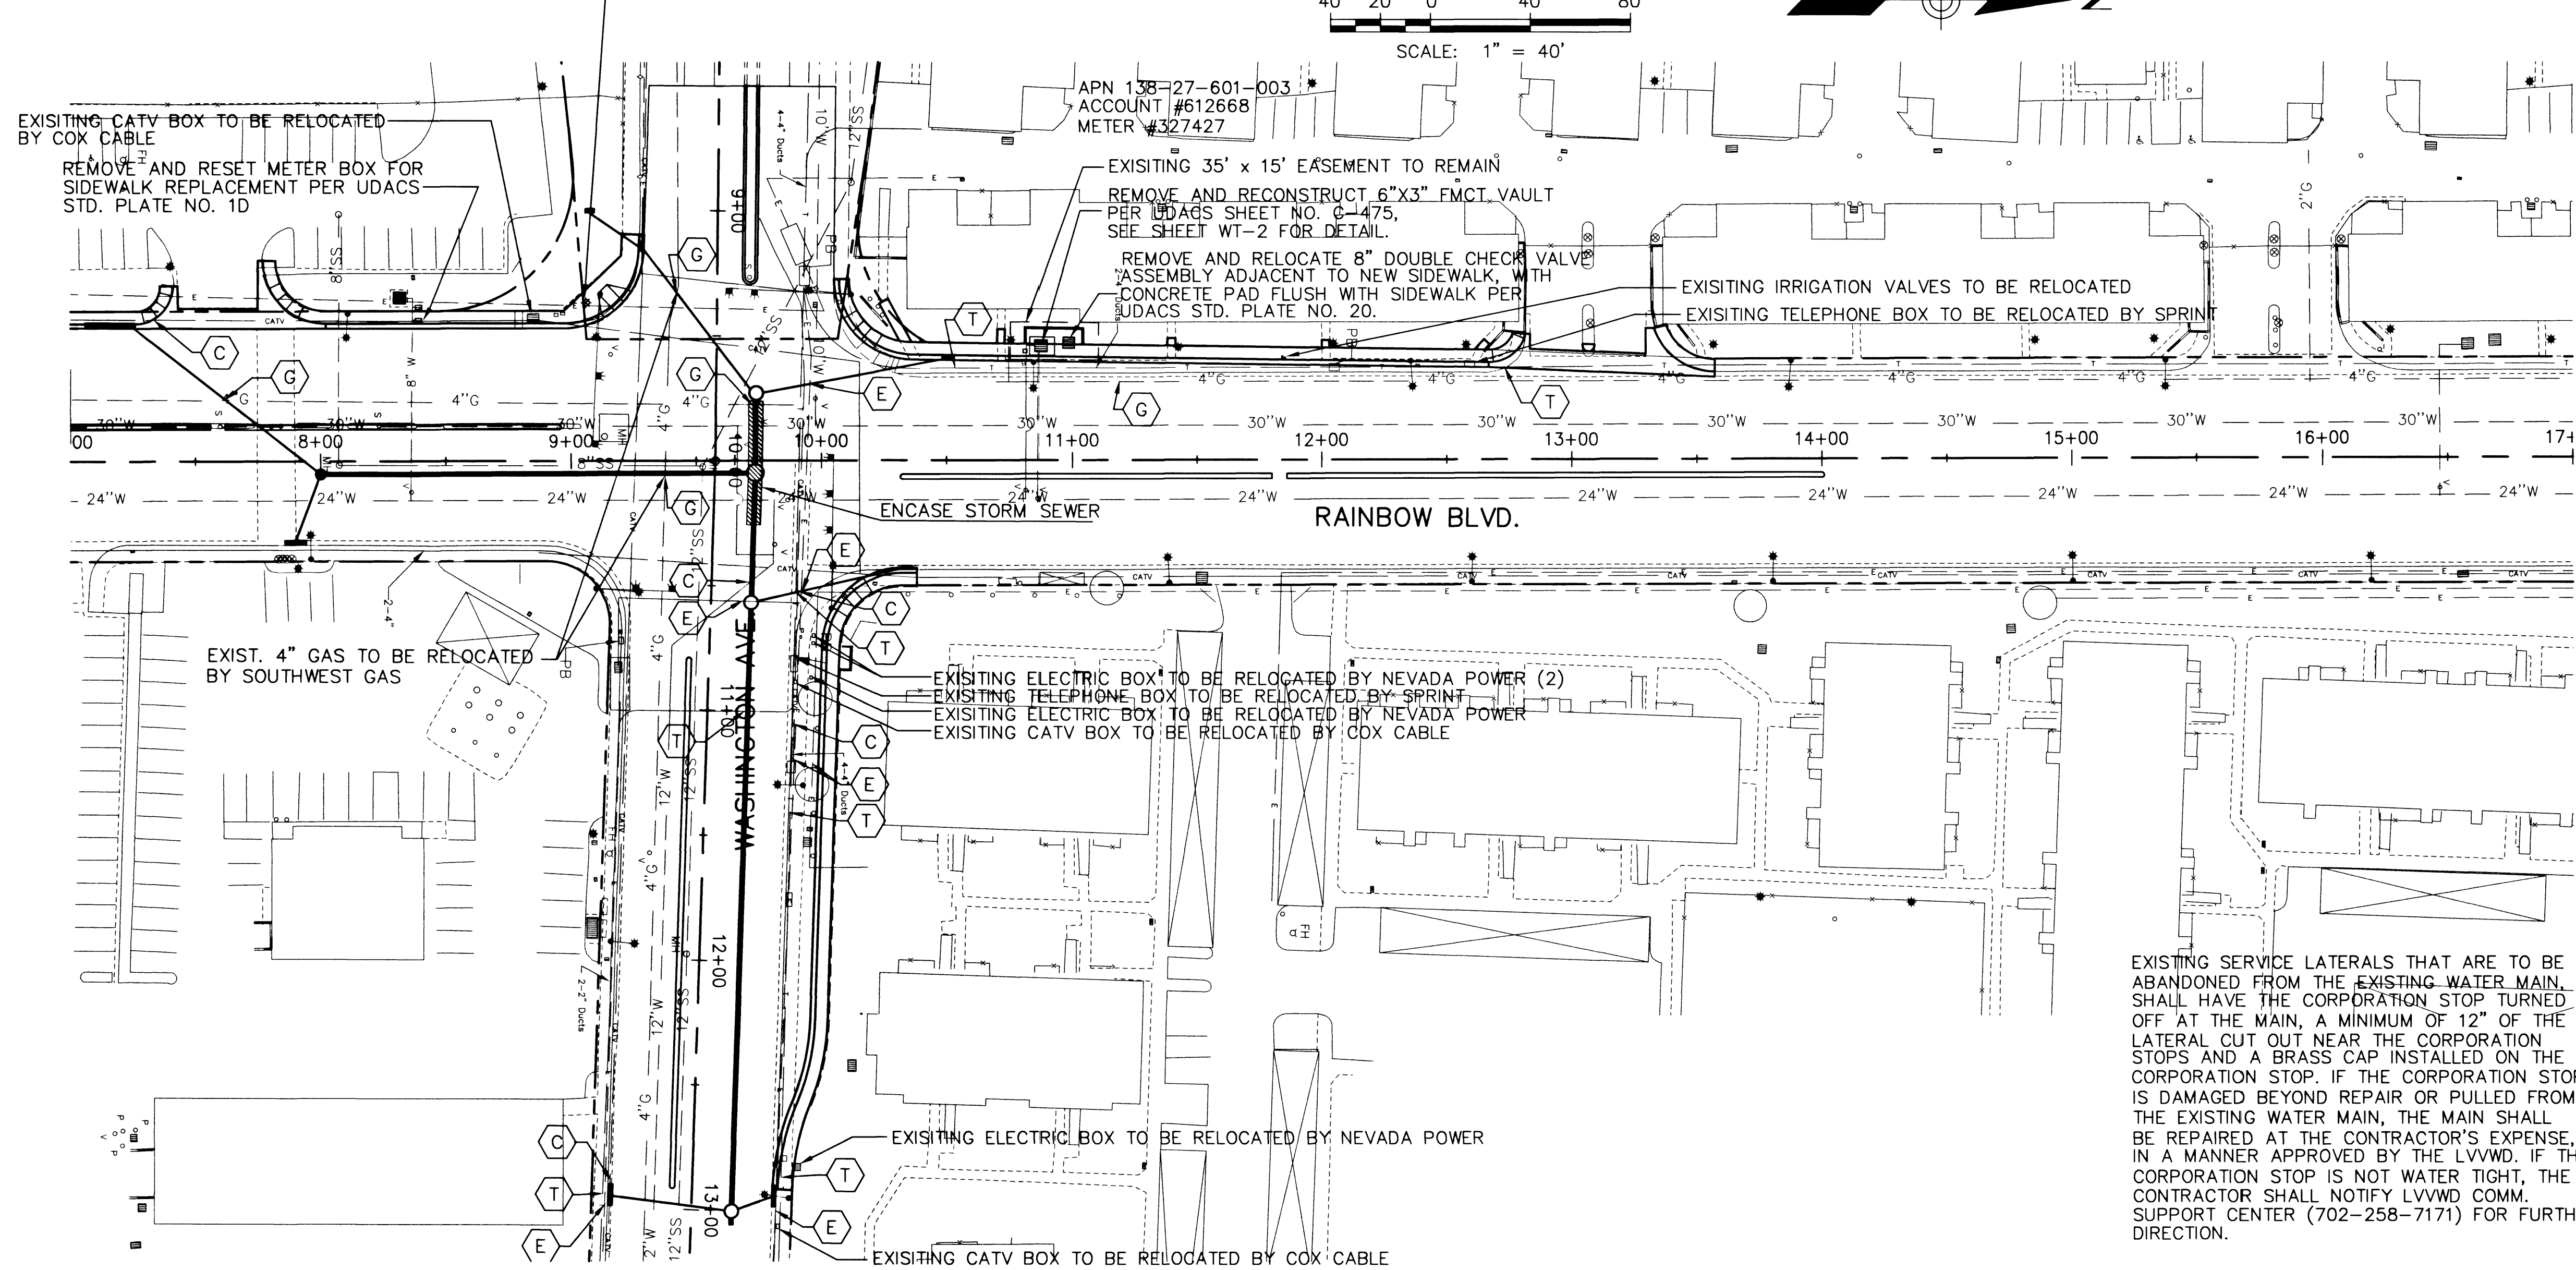

EXISTING SERVICE LATERALS THAT ARE TO BE ABANDONED FROM THE EXISTING WATER MAIN, SHALL HAVE THE CORPORATION STOP TURNED OFF AT THE MAIN, A MINIMUM OF 12" OF THE LATERAL CUT OUT NEAR THE CORPORATION STOPS AND A BRASS CAP INSTALLED ON THE CORPORATION STOP. IF THE CORPORATION STOP IS DAMAGED BEYOND REPAIR OR PULLED FROM THE EXISTING WATER MAIN, THE MAIN SHALL BE REPAIRED AT THE CONTRACTOR'S EXPENSE, IN A MANNER APPROVED BY THE LVVWD. IF THE CORPORATION STOP IS NOT WATER TIGHT, THE CONTRACTOR SHALL NOTIFY LVVWD COMM. SUPPORT CENTER (702-258-7171) FOR FURTHER DIRECTION.

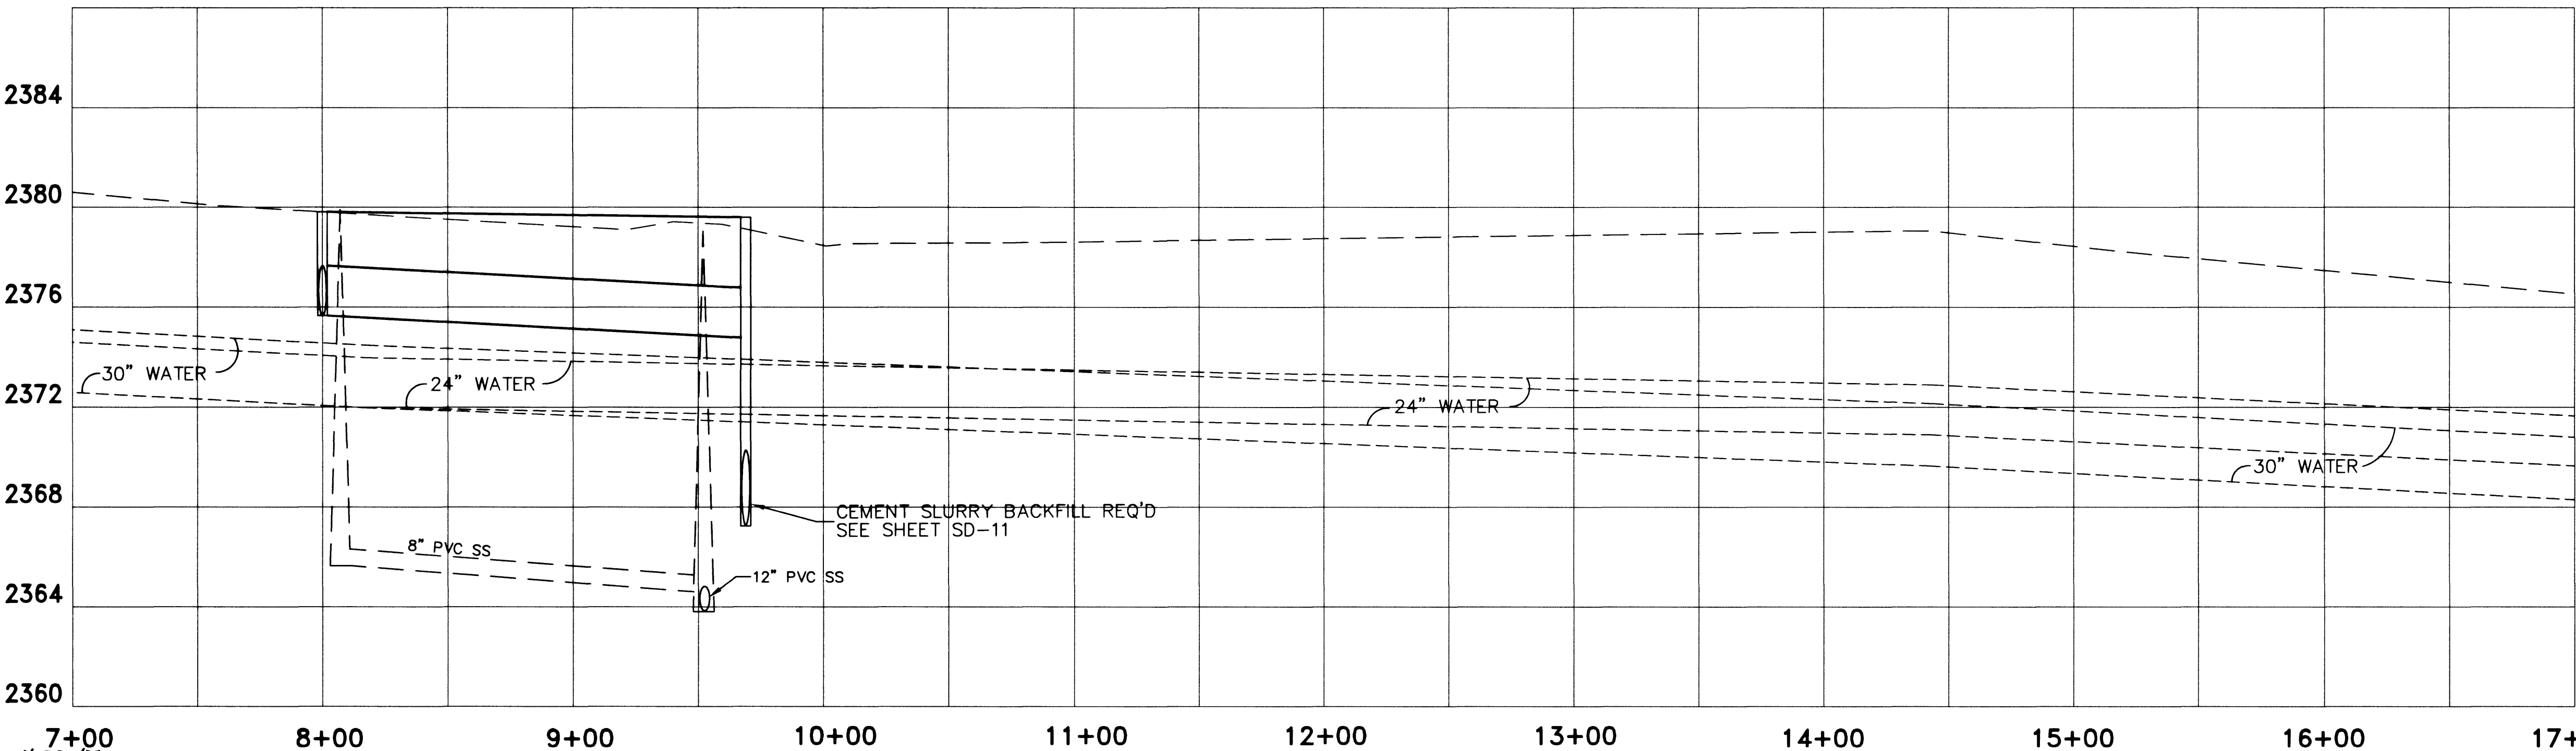


POTENTIAL UTILITY CONFLICTS:

- (C) EXISTING UNDERGROUND CABLE TO BE RELOCATED BY COX COMMUNICATIONS IF FOUND TO BE A CONFLICT DURING CONSTRUCTION
 - (E) EXISTING UNDERGROUND POWER TO BE RELOCATED BY NEVADA POWER IF FOUND TO BE A CONFLICT DURING CONSTRUCTION
 - (G) EXISTING UNDERGROUND GAS TO BE RELOCATED BY SOUTHWEST GAS IF FOUND TO BE A CONFLICT DURING CONSTRUCTION
 - (T) EXISTING UNDERGROUND TELEPHONE TO BE RELOCATED BY SPRINT CENTRAL TELEPHONE IF FOUND TO BE A CONFLICT DURING CONSTRUCTION
- SEE SL SHEETS FOR RELOCATION OF EXISTING STREET LIGHTS
SEE TS SHEETS FOR RELOCATION OF EXISTING TRAFFIC SIGNALS

BASIS OF BEARINGS
NORTH 00°05'50" WEST, BEING THE BEARING OF THE WEST LINE OF THE SOUTHWEST QUARTER (SW 1/4) OF THE SOUTHWEST QUARTER (SW 1/4) OF SECTION 23, T. 20 S., R. 60 E., M.D.M., CLARK COUNTY, NEVADA, AS SHOWN ON FILE 80 OF PARCEL MAPS, AT PAGE 46.

BENCHMARK
CITY OF LAS VEGAS BENCHMARK: 1LV00 26W4 RIVET AND PLATE IN TOP OF CURB, NORTHEAST RETURN OF RAINBOW BLVD AND WASHINGTON AVE. ELEV. = 724.7549 METERS (PUBLISHED NAVD'88) ELEV. = 2377.80 U.S. SURVEY FEET (CALCULATED NAVD'88)

CITY OF LAS VEGAS BENCHMARK: 0LV00 14SW5 RIVET AND PLATE IN TOP OF CURB, NORTHEAST RETURN OF SMOKE RANCH RD AND LORENZI BLVD. ELEV. = 708.7363 METERS (PUBLISHED NAVD'88) ELEV. = 2325.25 U.S. SURVEY FEET (CALCULATED NAVD'88)

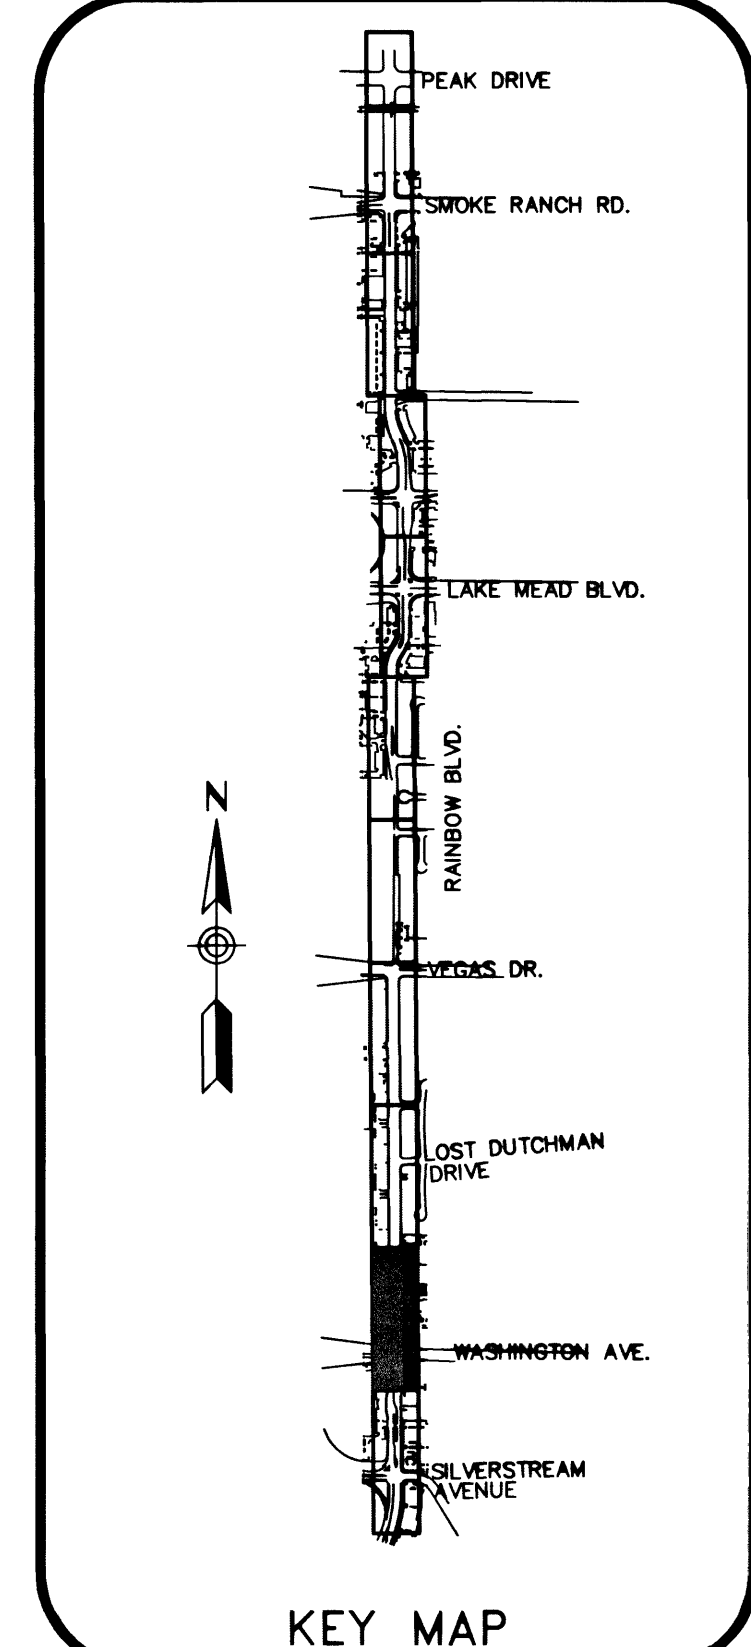

Las Vegas Valley Water District Date 2/28/12

Call before you Dig.
1-800-227-2600
UNDERGROUND SERVICE (USA)
CLARK COUNTY TRAFFIC MANAGEMENT OPERATIONS UNIT (702) 455-7544

AVOID HITTING OVERHEAD POWER LINES. IT'S COSTLY!
CALL BEFORE YOU DIG OVERHEAD
1-702-593-6111

PROJ NO: W7X70800
DESIGN: DEP
DATE: 2/14/2002
SCALE: 1:40
CADFILE: W7X70800

STAMP DATE: 2/28/12

5450 W. SHARLA AVE. SUITE 150
LAS VEGAS, NEVADA 89102-1848
PHONE: (702) 890-2100
FAX: (702) 890-1101

Sverdrup
CIVIL, INC.

RAINBOW BOULEVARD
SILVERSTREAM AVE. TO SMOKE RANCH ROAD
UTILITY PLAN & PROFILE
"SR" 7+00 TO "SR" 17+00

SHEET
UT-1
56 OF 110 SHEETS
DRAWING NO.
107-V3519