
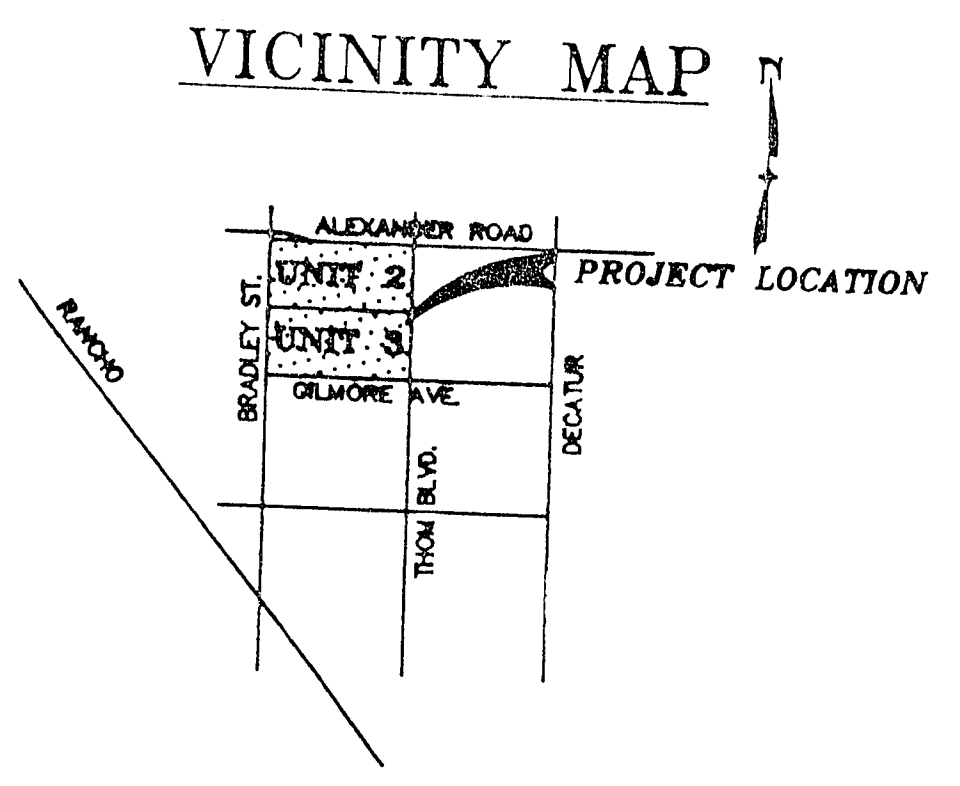
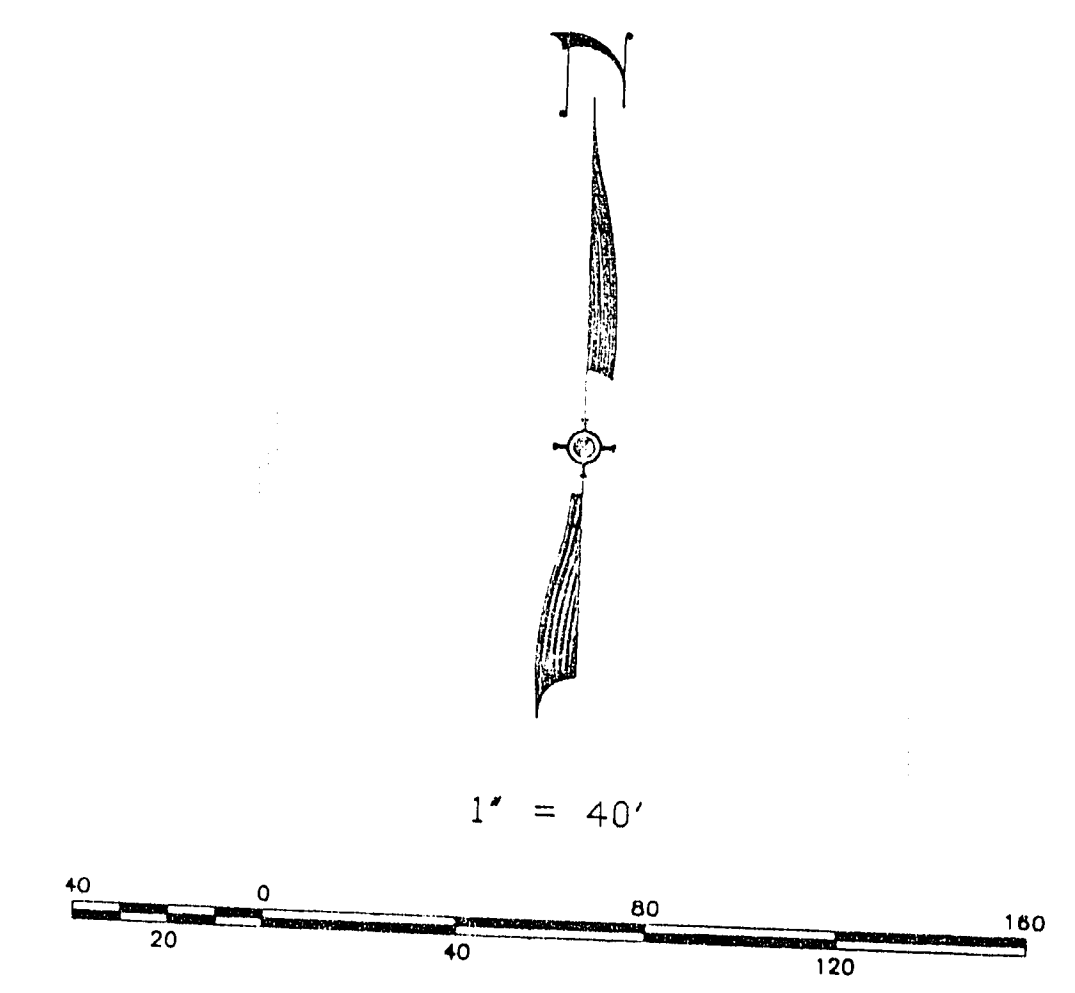


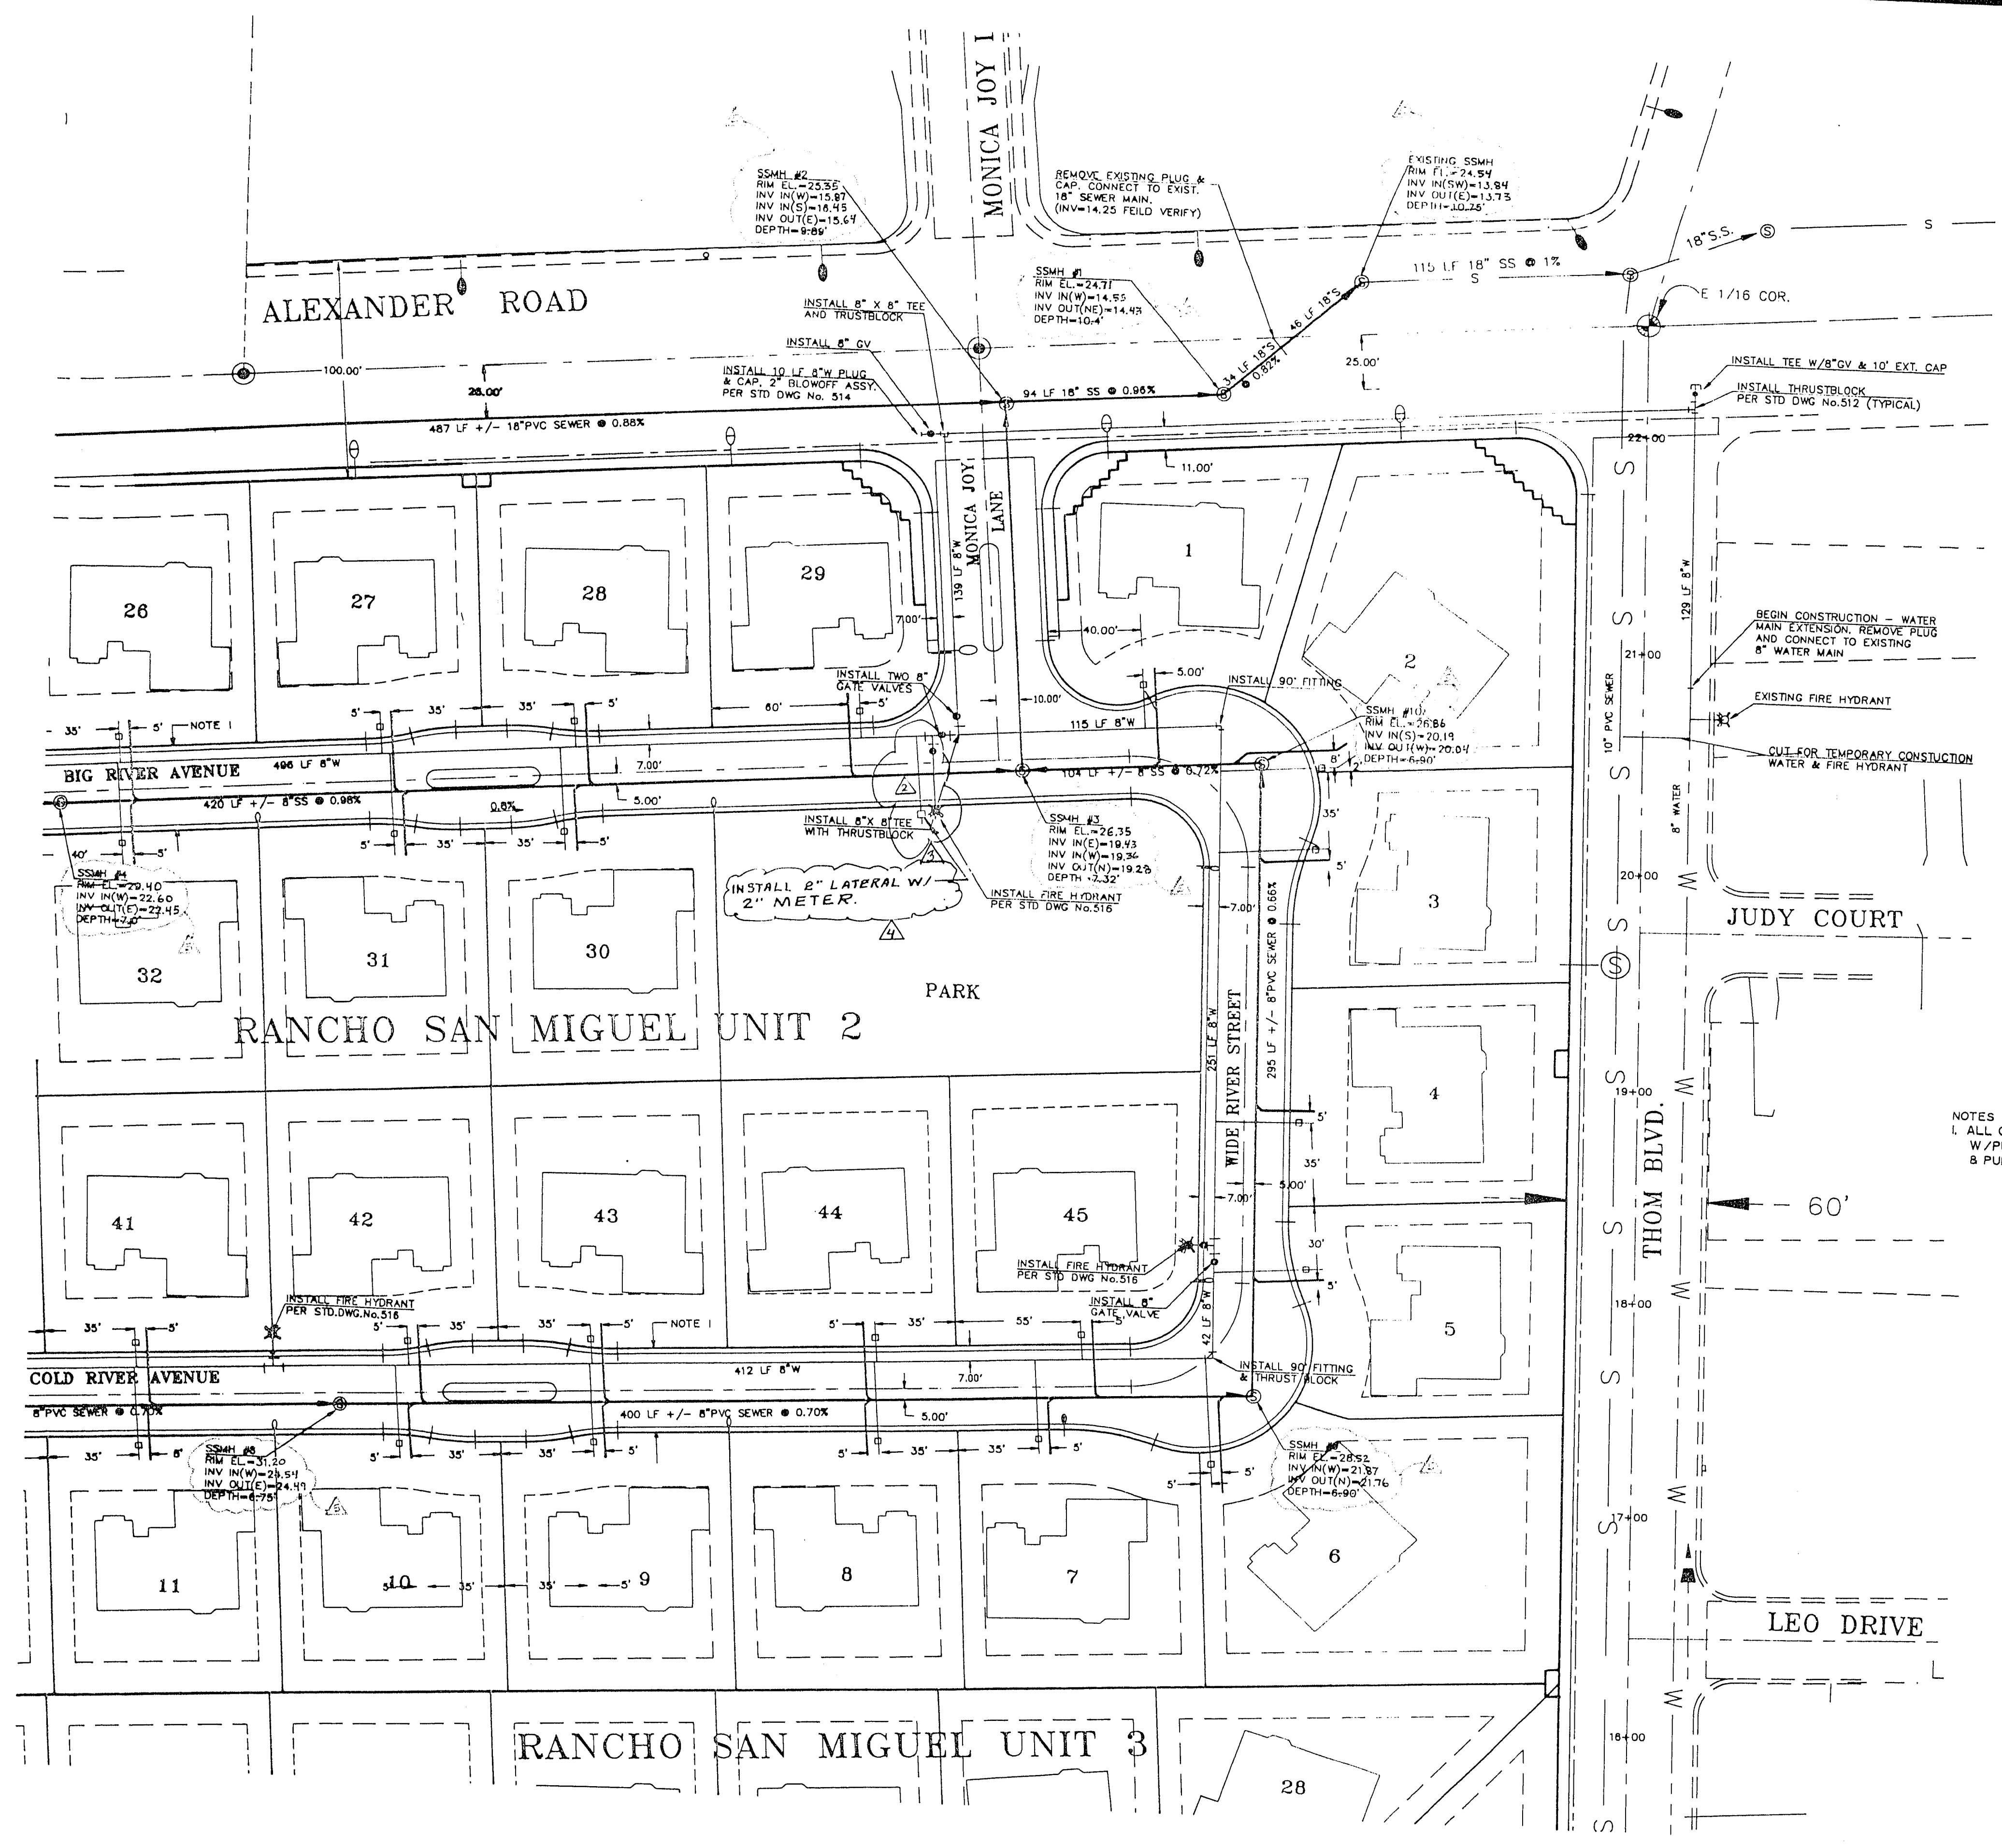

NOTES
1. ALL ON-SITE STREETS ARE PRIVATE
W/PUBLIC UTILITY EASEMENT
2. PUBLIC SEWER EASEMENT

LAS VEGAS FIRE DEPARTMENT

Fire Flow Requirements 1500 gallons per minute at 20 pounds per square inch residual.

BASED ON:
Square footage: 2500 SF SFR

Largest area between and separation walls: 3000 SF (MAX) SFR

Height: 20'

Type of Construction: V-N

Exposure: _____

Sprinkler System: NONE



Roof Construction: TILE

Reviewed By: _____

Date: _____

I, James A. Dale, a Professional Land Surveyor in the state of Nevada, hereby certify that the information shown hereon reflects as-built conditions.

James A. Dale
JAMES A. DALE
DATE 3/30/94

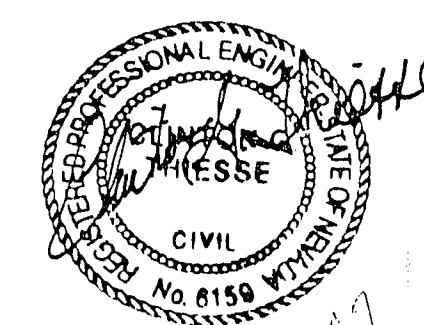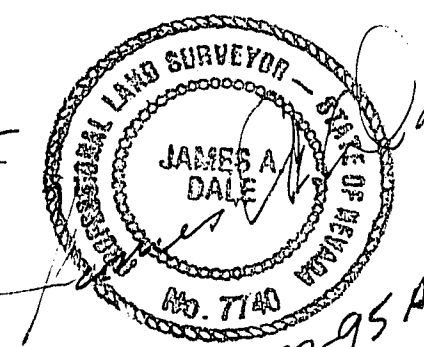

SUMMIT
ENGINEERING CORPORATION
CONSULTING ENGINEERS AND SURVEYORS
1845 SOUTH HENDERSON, LAS VEGAS, NEVADA 89102
PHONE (702) 253-3347 FAX (702) 253-3347

DESIGNED BY: BL/CCT
DRAWN BY: IFG
CHECKED BY: CCT

NEVADA
CLARK COUNTY
LAS VEGAS

Sheet 1 of 2
RANCHO SAN MIGUEL UNIT 2
UTILITY PLAN - EAST HALF
SEWER AS-BUILTS

REV.	DATE	DESCRIPTION	BY	APP'D.
1	5/26/94	ADDED NOTE 1	KKA	JTA
2	6/01/94	ADDED 2-METER WATER LATERAL	KKA	JTA
3	8/01/94	REVISED WATER METER TO 1"	JTA	JTA
4	8/01/94	REVISED WATER METER TO 2"	JTA	JTA
5	8/18/95	AS-BUILT SEWER INFORMATION	JTA	JTA

SCALE
HORIZ. 1"=40'
VERT. NONE

SHEET
9 OF 15

JOB NO. 70648