


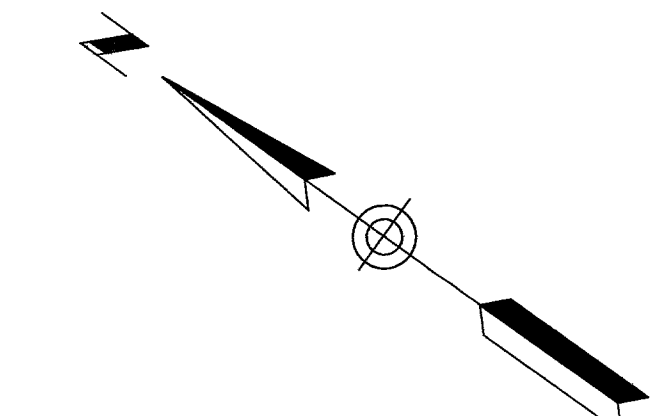


①	"RS" 10+00.00 TO "RS" 20+00.00	RELINE EXISTING SANITARY SEWER PER SPECIFICATIONS
②	"RS" 10+00.00 "RS" 10+48.33 "RS" 11+32.86 "RS" 14+21.00 "RS" 18+34.65	REHABILITATE EXISTING MANHOLE PER SPECIFICATIONS
④	"RS" 14+21.00	RESTORE BURIED MANHOLE


~~APPROVED FOR CONSTRUCTION~~

~~_____
LAS VEGAS VALLEY WATER DISTRICT~~

~~_____
DATE~~

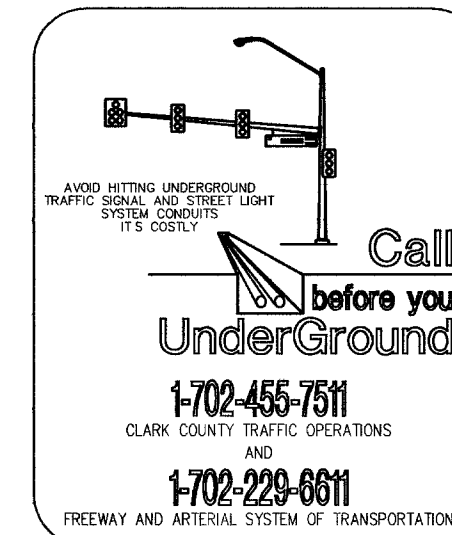

SAFETY ALERT
 Call 
 Before You
 Overhead
 1-702-593-6111

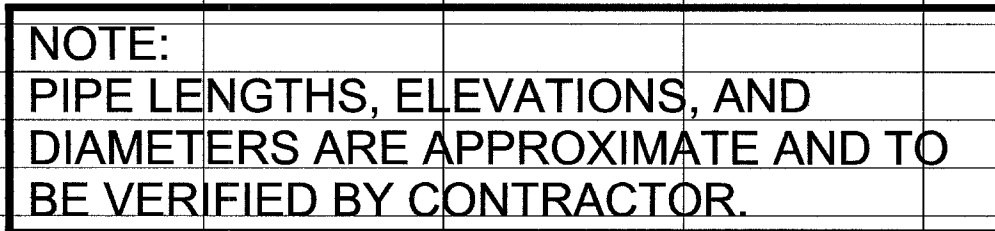[illegible]

DEPARTMENT OF PUBLIC WORKS
ENGINEERING DESIGN SECTION

CITY ENGINEER:	CHARLES KAUKOWSKI JR, P.E.
PROGRAM MANAGER:	VALERIE FLOCK, P.E.
DESIGNED BY: RUP	HORIZONTAL SCALE: 1"=40'
DRAWN BY: JPS	VERTICAL SCALE: 1"=4'
CHECKED BY: TC	DATE: 1/12/05



TITLE: RANCHO DR., OWENS AVE.,
HARRIS AVE., AND CHARELSTON BLVD.
SANITARY SEWER REHABILITATION

SHEET: PLAN AND PROFILE - RANCHO DRIVE
"RS" 10+00.00 TO "RS" 20+00.00



FILE NAME: X:\885-Rancho\basesheets\Rancho-ss_pp1.dwg - 3/08/05 - 9:14:42 JPS