

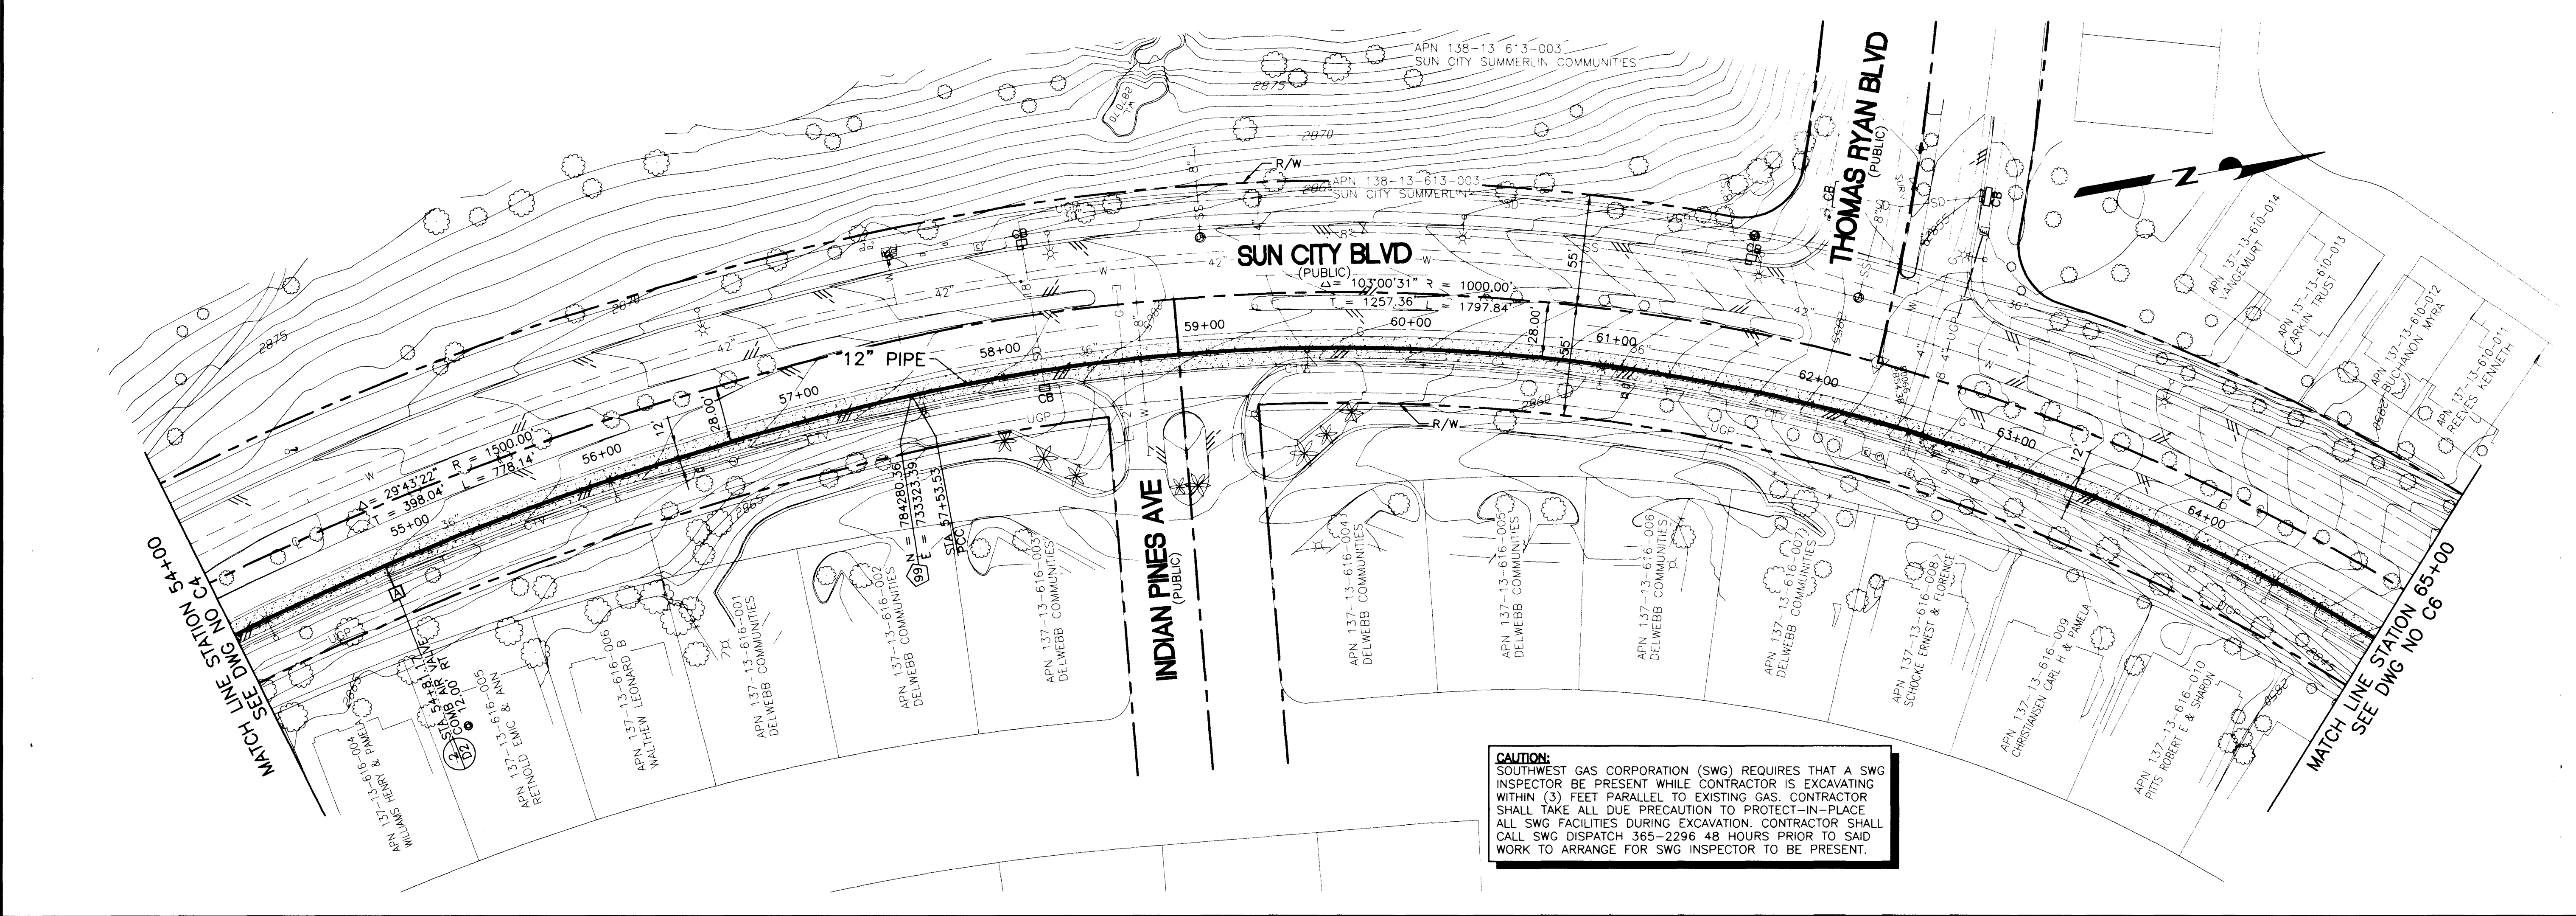
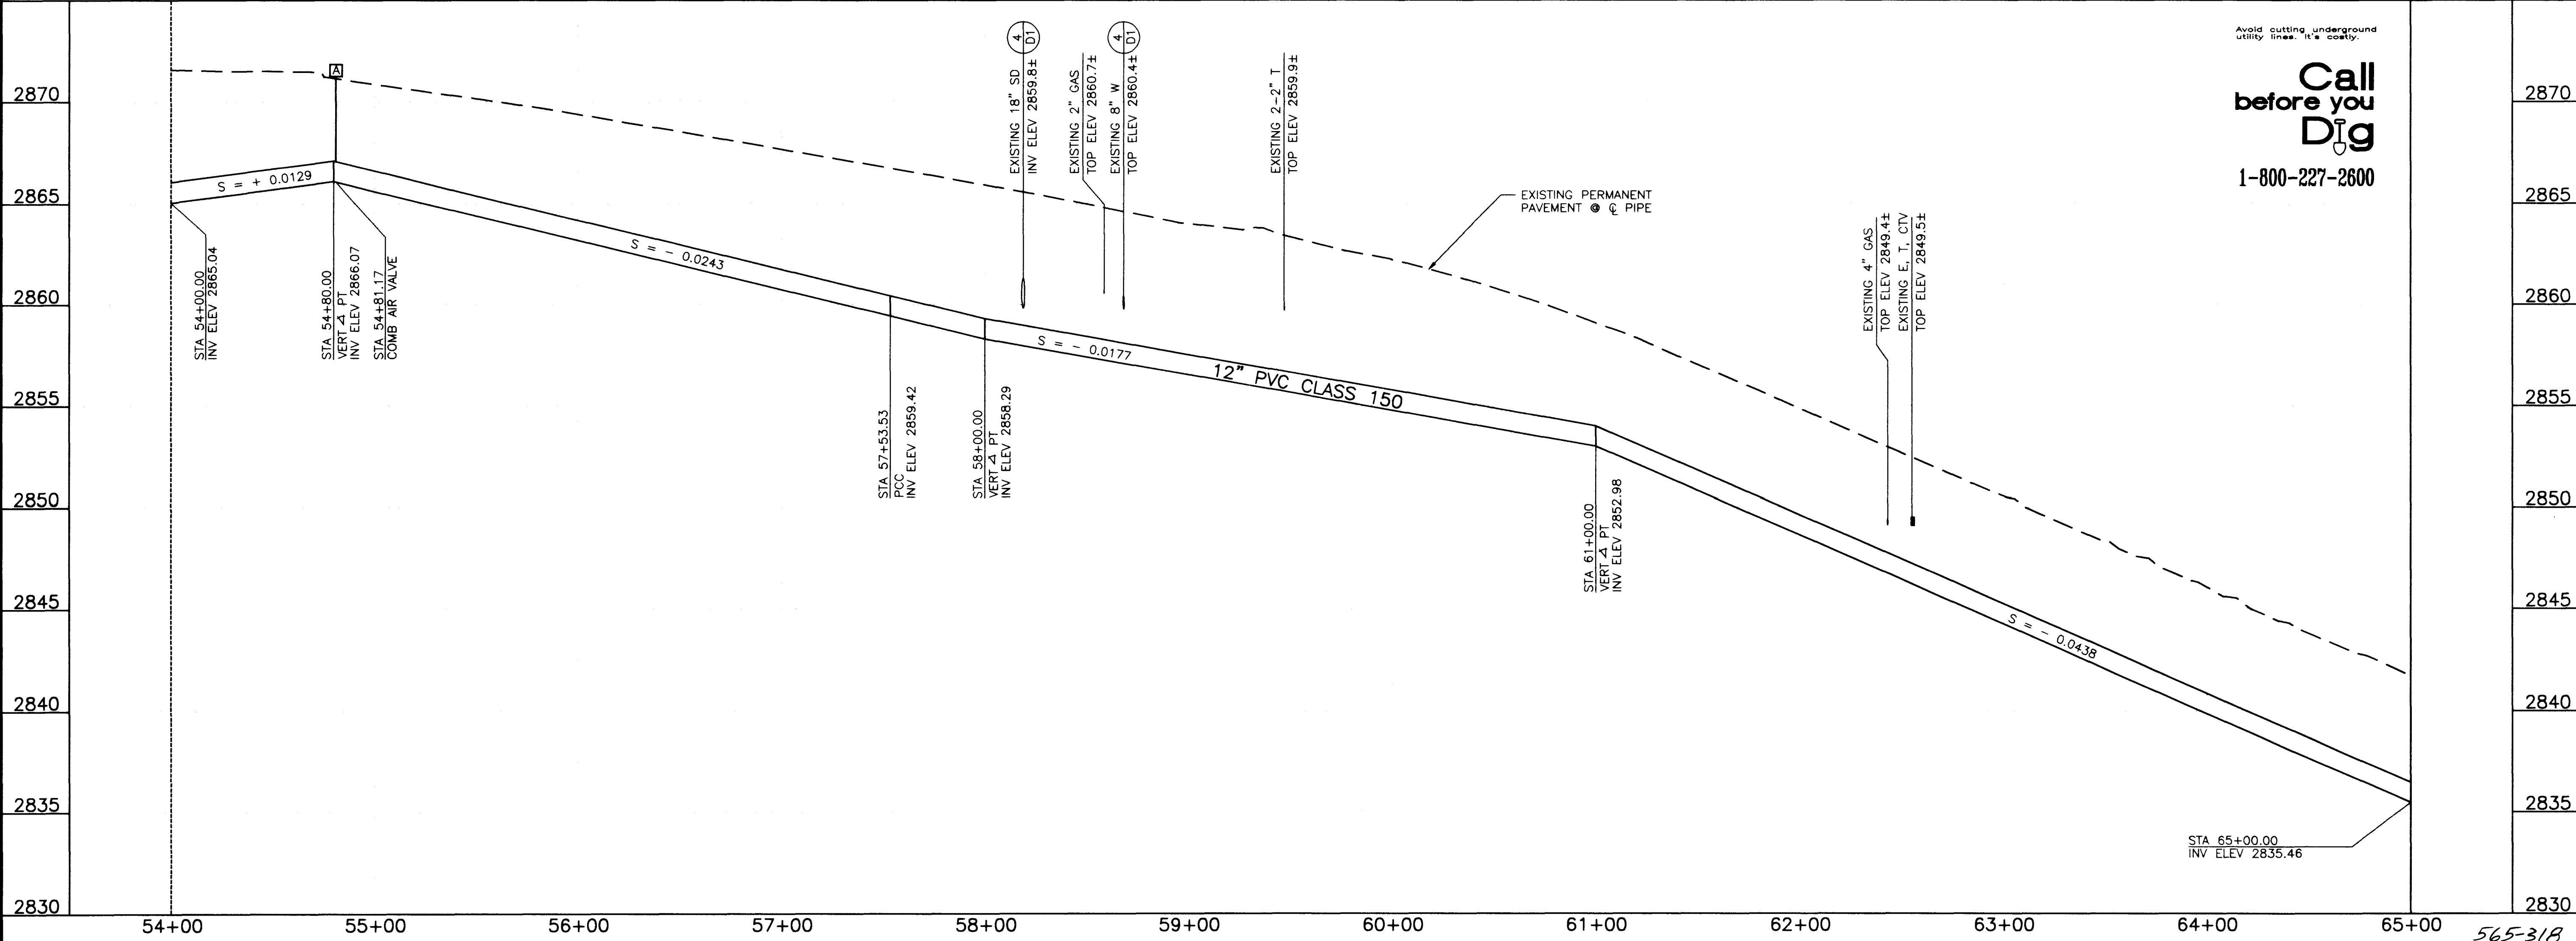


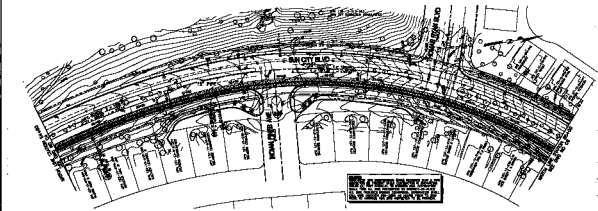

 CONTRACT NUMBER 898 DRAWING NUMBER C5 SHEET 16 OF 57	DRAWN BY: M. GLEZAN CHECKED BY: M. PETERSON RECOMMENDED BY: RAM G. JANGA ACCEPTED BY: <i>Andrew W. Richardson</i> DATE: 11/15/98 R.P.E. NO. DATE: 12702 R.P.E. NO. DATE: 8573 ANDREW W. RICHARDSON	RECYCLED WATER DISTRIBUTION SYSTEM - ON-SITE USERS IRRIGATION SUN CITY RECYCLED PIPELINE PLAN AND PROFILE STA 54+00 TO STA 65+00		VERIFY SCALE 1/2" = 0' 1/2" = 1' 1/2" = 1/2'	LAS VEGAS VALLEY WATER DISTRICT GREELEY AND HANSEN ENGINEERS 4625 SOUTH POLARIS AVENUE, SUITE 210 LAS VEGAS, NEVADA 89103
		SCALE HORIZONTAL 1" = 40' VERTICAL 1" = 4'			

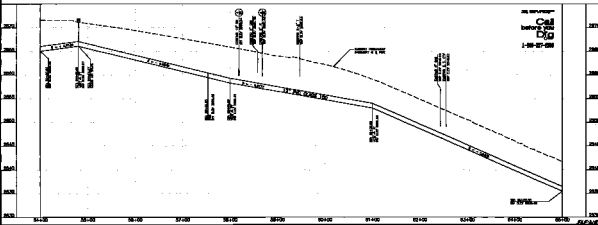

 898	PROJECT: RECYCLED WATER DISTRIBUTION SYSTEM - 60-600 LARGO REVEALER CITY: SAN JOSE COUNTY: SAN JOSE DRAWN BY: ANDY HANSEN DATE: 08/10/2010	PROJECT: RECYCLED WATER DISTRIBUTION SYSTEM - 60-600 LARGO REVEALER CITY: SAN JOSE COUNTY: SAN JOSE DRAWN BY: ANDY HANSEN DATE: 08/10/2010	PROJECT: RECYCLED WATER DISTRIBUTION SYSTEM - 60-600 LARGO REVEALER CITY: SAN JOSE COUNTY: SAN JOSE DRAWN BY: ANDY HANSEN DATE: 08/10/2010
	PROJECT: RECYCLED WATER DISTRIBUTION SYSTEM - 60-600 LARGO REVEALER CITY: SAN JOSE COUNTY: SAN JOSE DRAWN BY: ANDY HANSEN DATE: 08/10/2010	PROJECT: RECYCLED WATER DISTRIBUTION SYSTEM - 60-600 LARGO REVEALER CITY: SAN JOSE COUNTY: SAN JOSE DRAWN BY: ANDY HANSEN DATE: 08/10/2010	PROJECT: RECYCLED WATER DISTRIBUTION SYSTEM - 60-600 LARGO REVEALER CITY: SAN JOSE COUNTY: SAN JOSE DRAWN BY: ANDY HANSEN DATE: 08/10/2010