


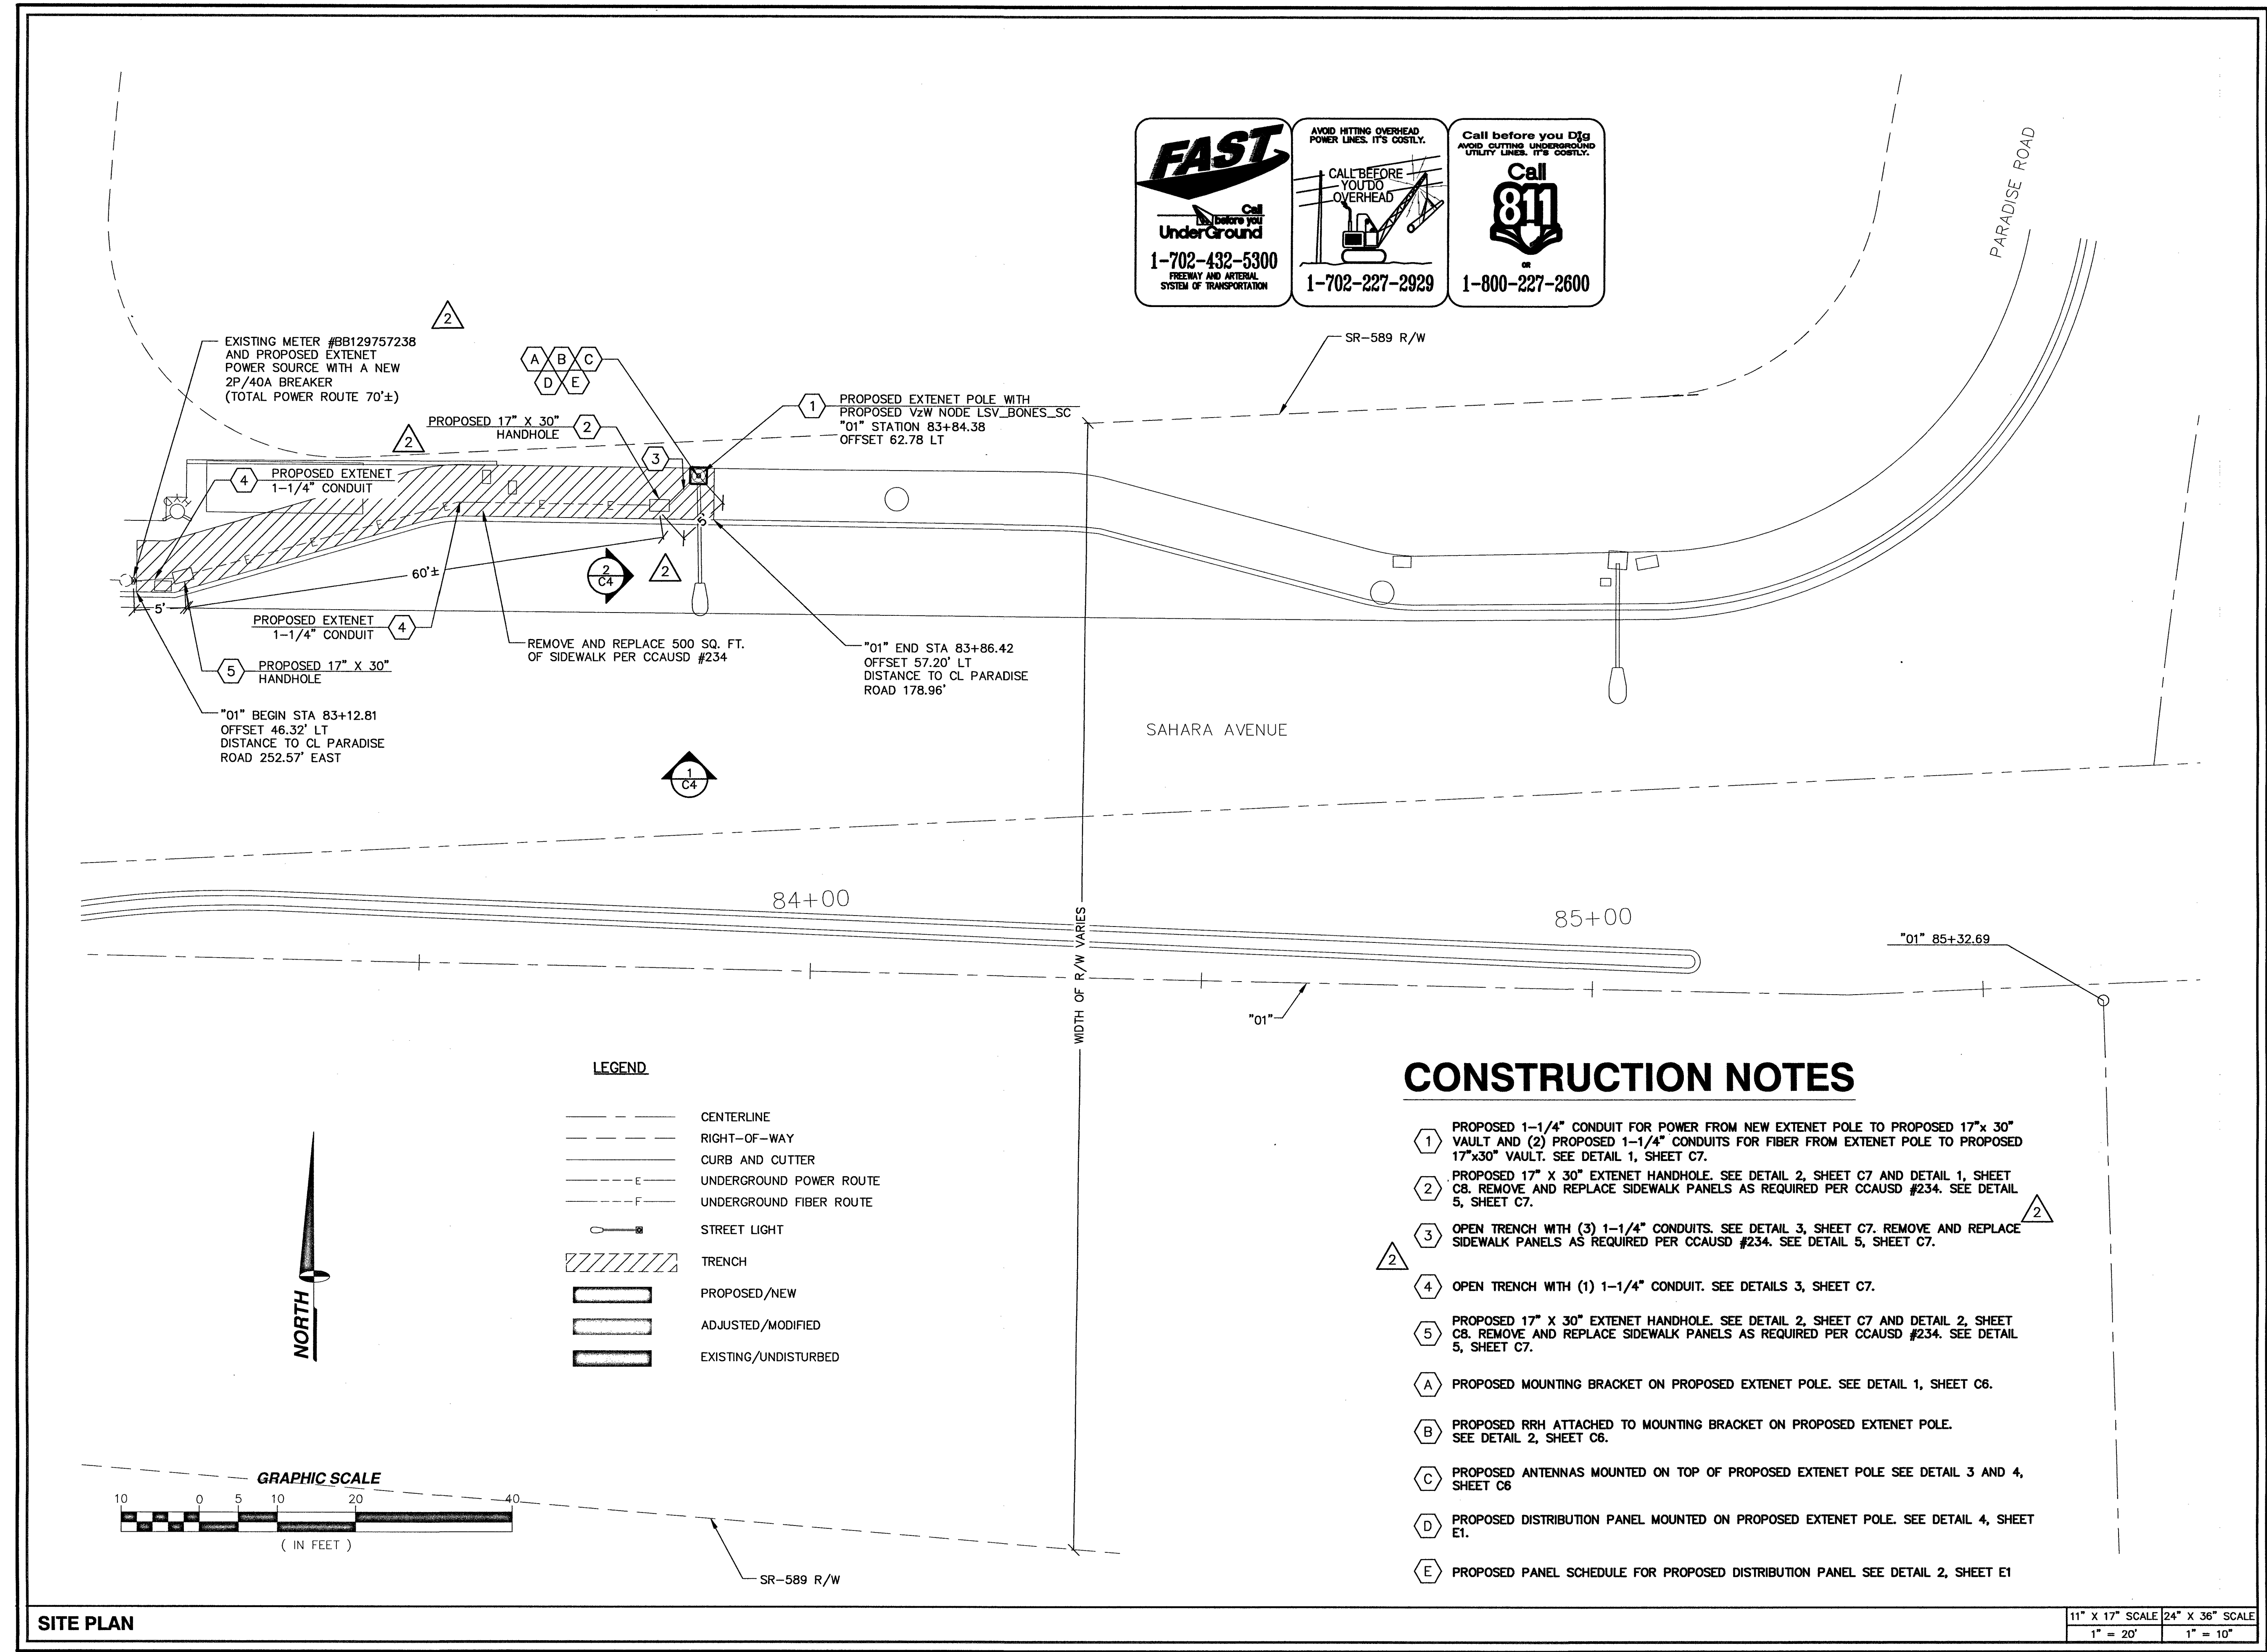

FAST
Call before you Dig
UnderGround
1-702-432-5300
FREEWAY AND ARTERIAL
SYSTEM OF TRANSPORTATION

AVOID HITTING OVERHEAD
POWER LINES. IT'S COSTLY.
CALL BEFORE
YOU DIG
OVERHEAD
1-702-227-2929

Call before you Dig
AVOID CUTTING UNDERGROUND
UTILITY LINES. IT'S COSTLY.
Call
811
1-800-227-2600

extenetSM
SYSTEMS
3030 WARRENVILLE ROAD, SUITE 340
LISLE, ILLINOIS 60532

PROJECT INFORMATION:
LSV_BONES_SC
SW-NV-LVSTEXP4-VZW
SW-NV-LVSTRI-00136
UNADDRESSED POLE
SAHARA AVENUE AND
PARADISE ROAD
LAS VEGAS, NEVADA 89109
CURRENT ISSUE DATE:
10/10/18
ISSUED FOR:
PROPOSED WORK
REV.: DATE: DESCRIPTION: BY:

2	10/10/18	EQUIPMENT UPDATE	D.S.
1	09/08/17	NDOT SUBMITTAL	V.H.
0	03/17/17	90% PERMITTING	V.H.

PLANS PREPARED BY:
SPECTRUM
SPECTRUM SERVICES, INC.
4850 WEST OQUENDO ROAD
LAS VEGAS, NEVADA 89118
PHONE: (702) 367-7705
FAX: (702) 367-8733
LICENSURE:

SHEET TITLE:
SITE PLAN
SHEET NUMBER: C3 REVISION: 2



PROJECT INFORMATION:
LSV_BONES_SC
SW-NV-LVSTEXP4-VZW
SW-NV-LVSTRI-00136

UNADDRESSED POLE
SAHARA AVENUE AND
PARADISE ROAD
LAS VEGAS, NEVADA 89109

CURRENT ISSUE DATE:
10/10/18

ISSUED FOR:
PROPOSED WORK


REV.: DATE: DESCRIPTION: BY:

REV.	DATE	DESCRIPTION	BY
2	10/10/18	EQUIPMENT UPDATE	D.S.
1	09/08/17	NDOT SUBMITTAL	V.H.
0	03/17/17	90% PERMITTING	V.H.

PLANS PREPARED BY:

SPECTRUM
SPECTRUM SERVICES, INC.
4850 WEST OQUENDO ROAD
LAS VEGAS, NEVADA 89118
PHONE: (702) 367-7705
FAX: (702) 367-8733

LICENSURE:

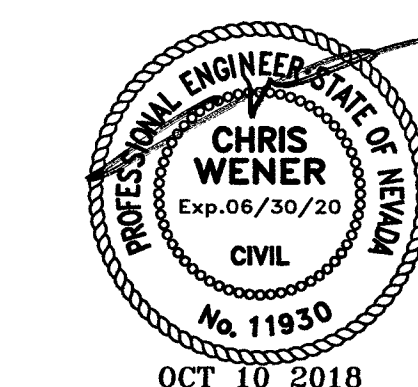

SHEET TITLE:

CONSTRUCTION DETAILS

SHEET NUMBER: REVISION:

C8 2

LEGEND


- CENTERLINE
- RIGHT-OF-WAY
- CURB AND CUTTER
- UNDERGROUND POWER ROUTE
- UNDERGROUND FIBER ROUTE
- STREET LIGHT
- TRENCH
- PROPOSED/NEW
- ADJUSTED/MODIFIED
- EXISTING/UNDISTURBED

NOT USED

SCALE: NONE 6

LEGEND

SCALE: NONE 3

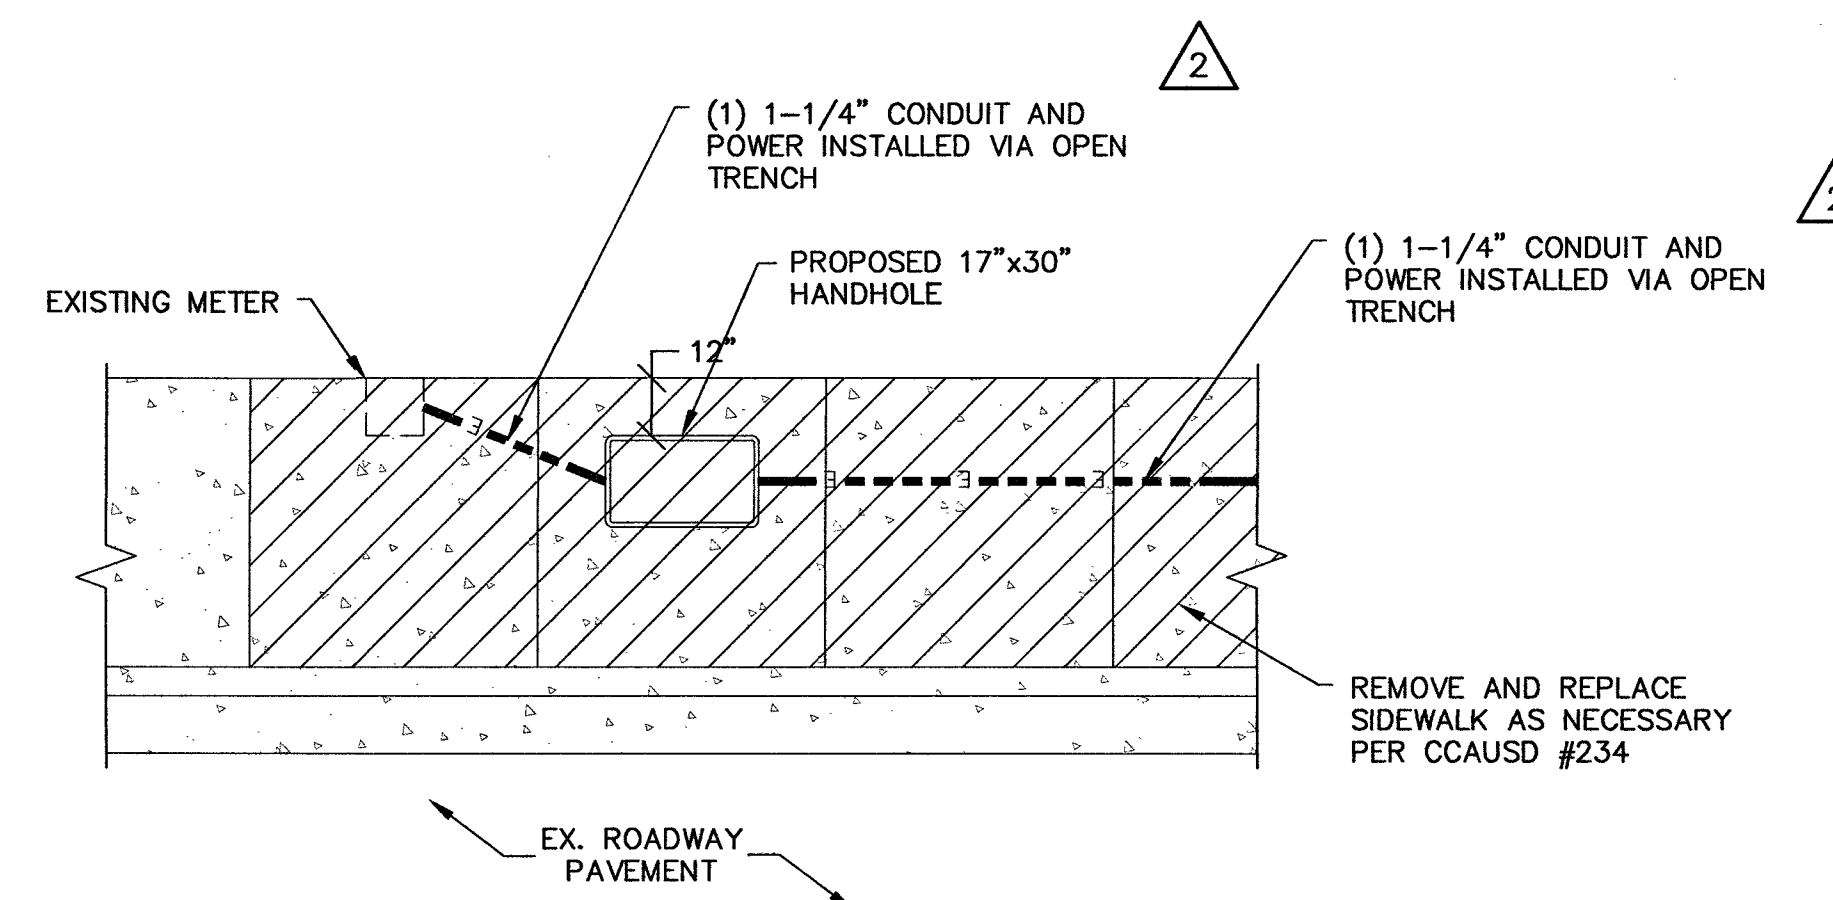


NOT USED

SCALE: NONE 5

POWER INSTALLATION UNDER SIDEWALK AT METER

SCALE: NONE 2

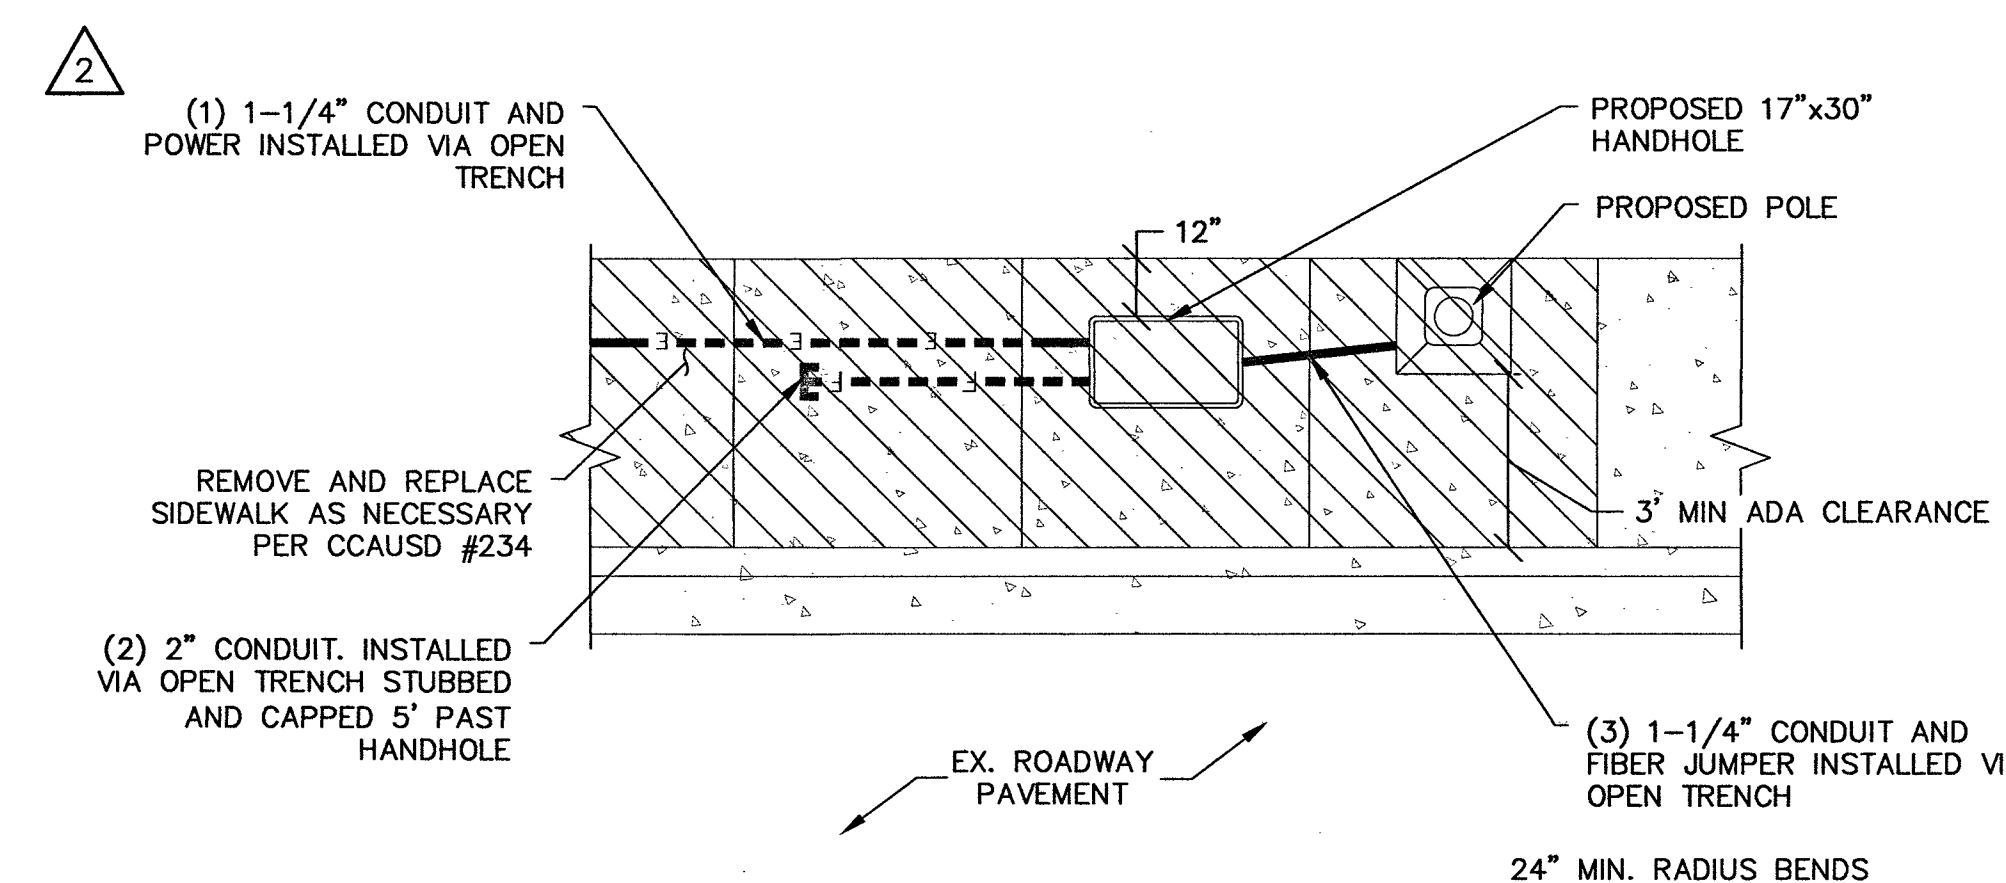

NOT USED

SCALE: NONE 4

POWER AND FIBER INSTALLATION UNDER SIDEWALK AT PROPOSED POLE

SCALE: NONE 1