

[illegible]

32-03-031-20 A-216231-11049

CS.01

3 OF 30

PROJECT NO. 201328-00

CHECKED: SCD

DESIGNER: SCD

DRAWN: JC

DATE: 3/2018

301328-00

PROJECT NO.

201328-00

CHECKED: SCD

201328-00

DESIGNER: SCD

201328-00

DRAWN: JC

201328-00

DATE: 3/2018

301328-00

PROJECT NO.

201328-00

CHECKED: SCD

201328-00

DESIGNER: SCD

201328-00

DRAWN: JC

201328-00

DATE: 3/2018

301328-00

PROJECT NO.

201328-00

CHECKED: SCD

201328-00

DESIGNER: SCD

201328-00

DRAWN: JC

201328-00

DATE: 3/2018

301328-00

PROJECT NO.

201328-00

CHECKED: SCD

201328-00

DESIGNER: SCD

201328-00

DRAWN: JC

201328-00

DATE: 3/2018

301328-00

PROJECT NO.

201328-00

CHECKED: SCD

201328-00

DESIGNER: SCD

201328-00

DRAWN: JC

201328-00

DATE: 3/2018

301328-00

PROJECT NO.

201328-00

CHECKED: SCD

201328-00

DESIGNER: SCD

201328-00

DRAWN: JC

201328-00

DATE: 3/2018

301328-00

PROJECT NO.

201328-00

CHECKED: SCD

201328-00

DESIGNER: SCD

201328-00

DRAWN: JC

201328-00

DATE: 3/2018

301328-00

PROJECT NO.

201328-00

CHECKED: SCD

201328-00

DESIGNER: SCD

201328-00

DRAWN: JC

201328-00

DATE: 3/2018

301328-00

PROJECT NO.

201328-00

CHECKED: SCD

201328-00

DESIGNER: SCD

201328-00

DRAWN: JC

201328-00

DATE: 3/2018

The main site plan illustrates the proposed development on a sloped terrain. Key features include:
 - **Elevated Parking Structure:** A large rectangular structure with a dashed outline, situated on a slope.
 - **Match Line:** A vertical dashed line on the right side, labeled 'MATCH LINE SEE SHT CS.03'.
 - **Elevations:** Numerous spot elevations (e.g., 3400.0, 3401.2, 3402.5) and finished floor elevations (FF=(3405.22)) are marked throughout the plan.
 - **Infrastructure:** A road labeled 'VIA OLIVERO AVE.' runs horizontally across the top. A 'PROPERTY LINE' is indicated near the center.
 - **Topography:** Contour lines and spot elevations define the site's topography.
 - **Legend:** A legend in the bottom left corner defines symbols for 'FINISH GRADE', 'RIGHT-OF-WAY', 'CENTERLINE', 'FLOW LINE', 'EXISTING', 'FINISH FLOOR', 'TOP OF CURB', 'POINT OF TANGENCY', 'SLOPE', 'SLOPE VARIATION', 'SLOPE BREAK', 'SLOPE CHANGE', 'SLOPE INTERSECTION', 'SLOPE TERMINATION', 'SLOPE BEGINNING', 'SLOPE ENDING', 'SLOPE CHANGE', 'SLOPE INTERSECTION', 'SLOPE TERMINATION', 'SLOPE BEGINNING', 'SLOPE ENDING'.
 - **Scale:** A graphic scale bar at the bottom left indicates 1 inch = 30 feet.

50.50 THE SEE SHITAM

FF=(3405.22)

FF=(3405.22)

301328-00

PROJECT NO.

201328-00

CHECKED: SCD

201328-00

DESIGNER: SCD

201328-00

DRAWN: JC

201328-00

DATE: 3/2018

301328-00

PROJECT NO.

201328-00

CHECKED: SCD

201328-00

DESIGNER: SCD

201328-00

DRAWN: JC

201328-00

DATE: 3/2018

301328-00

PROJECT NO.

201328-00

CHECKED: SCD

201328-00

DESIGNER: SCD

201328-00

DRAWN: JC

201328-00

DATE: 3/2018

301328-00

PROJECT NO.

201328-00

CHECKED: SCD

201328-00

DESIGNER: SCD

201328-00

DRAWN: JC

201328-00

DATE: 3/2018

301328-00

PROJECT NO.

201328-00

CHECKED: SCD

201328-00

DESIGNER: SCD

201328-00

DRAWN: JC

201328-00

DATE: 3/2018

301328-00

PROJECT NO.

201328-00

CHECKED: SCD

201328-00

DESIGNER: SCD

201328-00

DRAWN: JC

201328-00

DATE: 3/2018

301328-00

PROJECT NO.

201328-00

CHECKED: SCD

201328-00

DESIGNER: SCD

201328-00

DRAWN: JC

201328-00

DATE: 3/2018

301328-00

PROJECT NO.

201328-00

CHECKED: SCD

201328-00

DESIGNER: SCD

201328-00

DRAWN: JC

201328-00

DATE: 3/2018

301328-00

PROJECT NO.

201328-00

CHECKED: SCD

201328-00

DESIGNER: SCD

201328-00

DRAWN: JC

201328-00

DATE: 3/2018

301328-00

PROJECT NO.

201328-00

CHECKED: SCD

201328-00

DESIGNER: SCD

201328-00

DRAWN: JC

201328-00

DATE: 3/2018

301328-00

PROJECT NO.

201328-00

CHECKED: SCD

201328-00

DESIGNER: SCD

201328-00

DRAWN: JC

201328-00

DATE: 3/2018

301328-00

PROJECT NO.

201328-00

CHECKED: SCD

201328-00

DESIGNER: SCD

201328-00

DRAWN: JC

201328-00

DATE: 3/2018

301328-00

PROJECT NO.

201328-00

CHECKED: SCD

201328-00

DESIGNER: SCD

201328-00

DRAWN: JC

201328-00

DATE: 3/2018

301328-00

PROJECT NO.

201328-00

CHECKED: SCD

201328-00

DESIGNER: SCD

201328-00

DRAWN: JC

201328-00

DATE: 3/2018

301328-00

PROJECT NO.

201328-00

CHECKED: SCD

201328-00

DESIGNER: SCD

201328-00

DRAWN: JC

201328-00

DATE: 3/2018

301328-00

PROJECT NO.

201328-00

CHECKED: SCD

201328-00

DESIGNER: SCD

201328-00

DRAWN: JC

201328-00

DATE: 3/2018

301328-00

PROJECT NO.

201328-00

CHECKED: SCD

201328-00

DESIGNER: SCD

201328-00

DRAWN: JC

201328-00

DATE: 3/2018

301328-00

PROJECT NO.

201328-00

CHECKED: SCD

201328-00

DESIGNER: SCD

201328-00

DRAWN: JC

201328-00

DATE: 3/2018

301328-00

PROJECT NO.

201328-00

CHECKED: SCD

201328-00

DESIGNER: SCD

201328-00

DRAWN: JC

201328-00

DATE: 3/2018

301328-00

PROJECT NO.

201328-00

CHECKED: SCD

201328-00

DESIGNER: SCD

201328-00

DRAWN: JC

201328-00

DATE: 3/2018

301328-00

PROJECT NO.

201328-00

CHECKED: SCD

201328-00

DESIGNER: SCD

201328-00

DRAWN: JC

201328-00

DATE: 3/2018

301328-00

PROJECT NO.

201328-00

CHECKED: SCD

201328-00

DESIGNER: SCD

201328-00

DRAWN: JC

201328-00

DATE: 3/2018

301328-00

PROJECT NO.

201328-00

CHECKED: SCD

201328-00

DESIGNER: SCD

201328-00

DRAWN: JC

201328-00

DATE: 3/2018

301328-00

PROJECT NO.

201328-00

CHECKED: SCD

201328-00




DESIGNER: SCD

201328-00

DRAWN: JC

201328-00

DATE: 3/2018

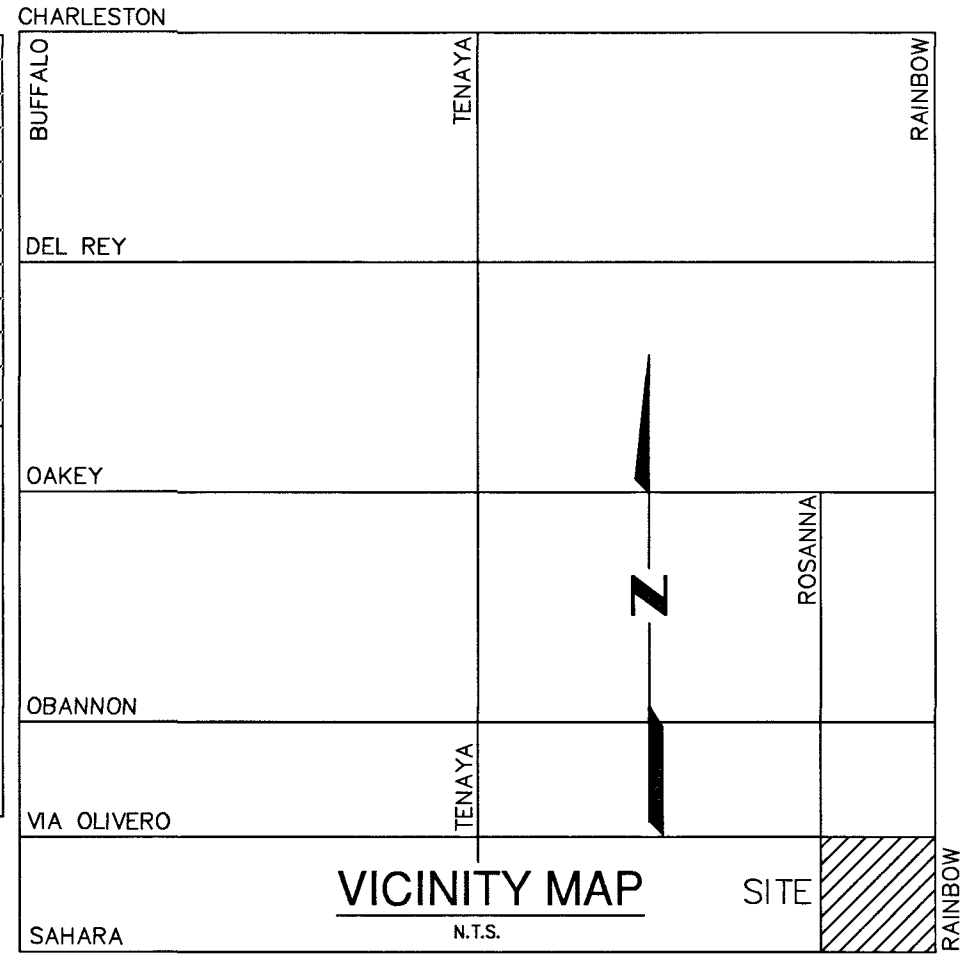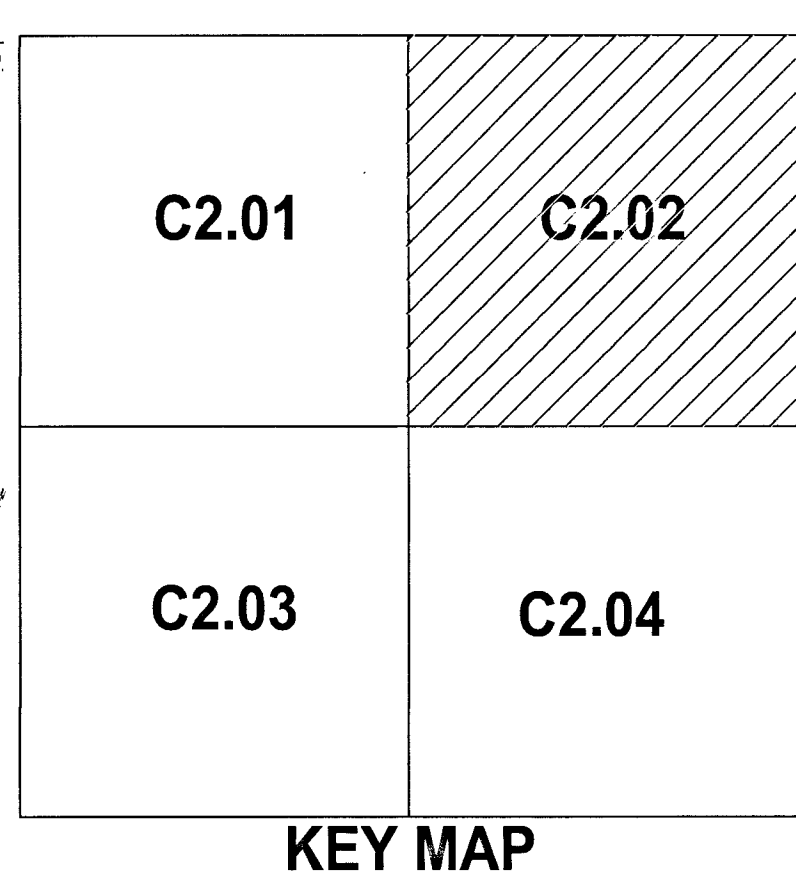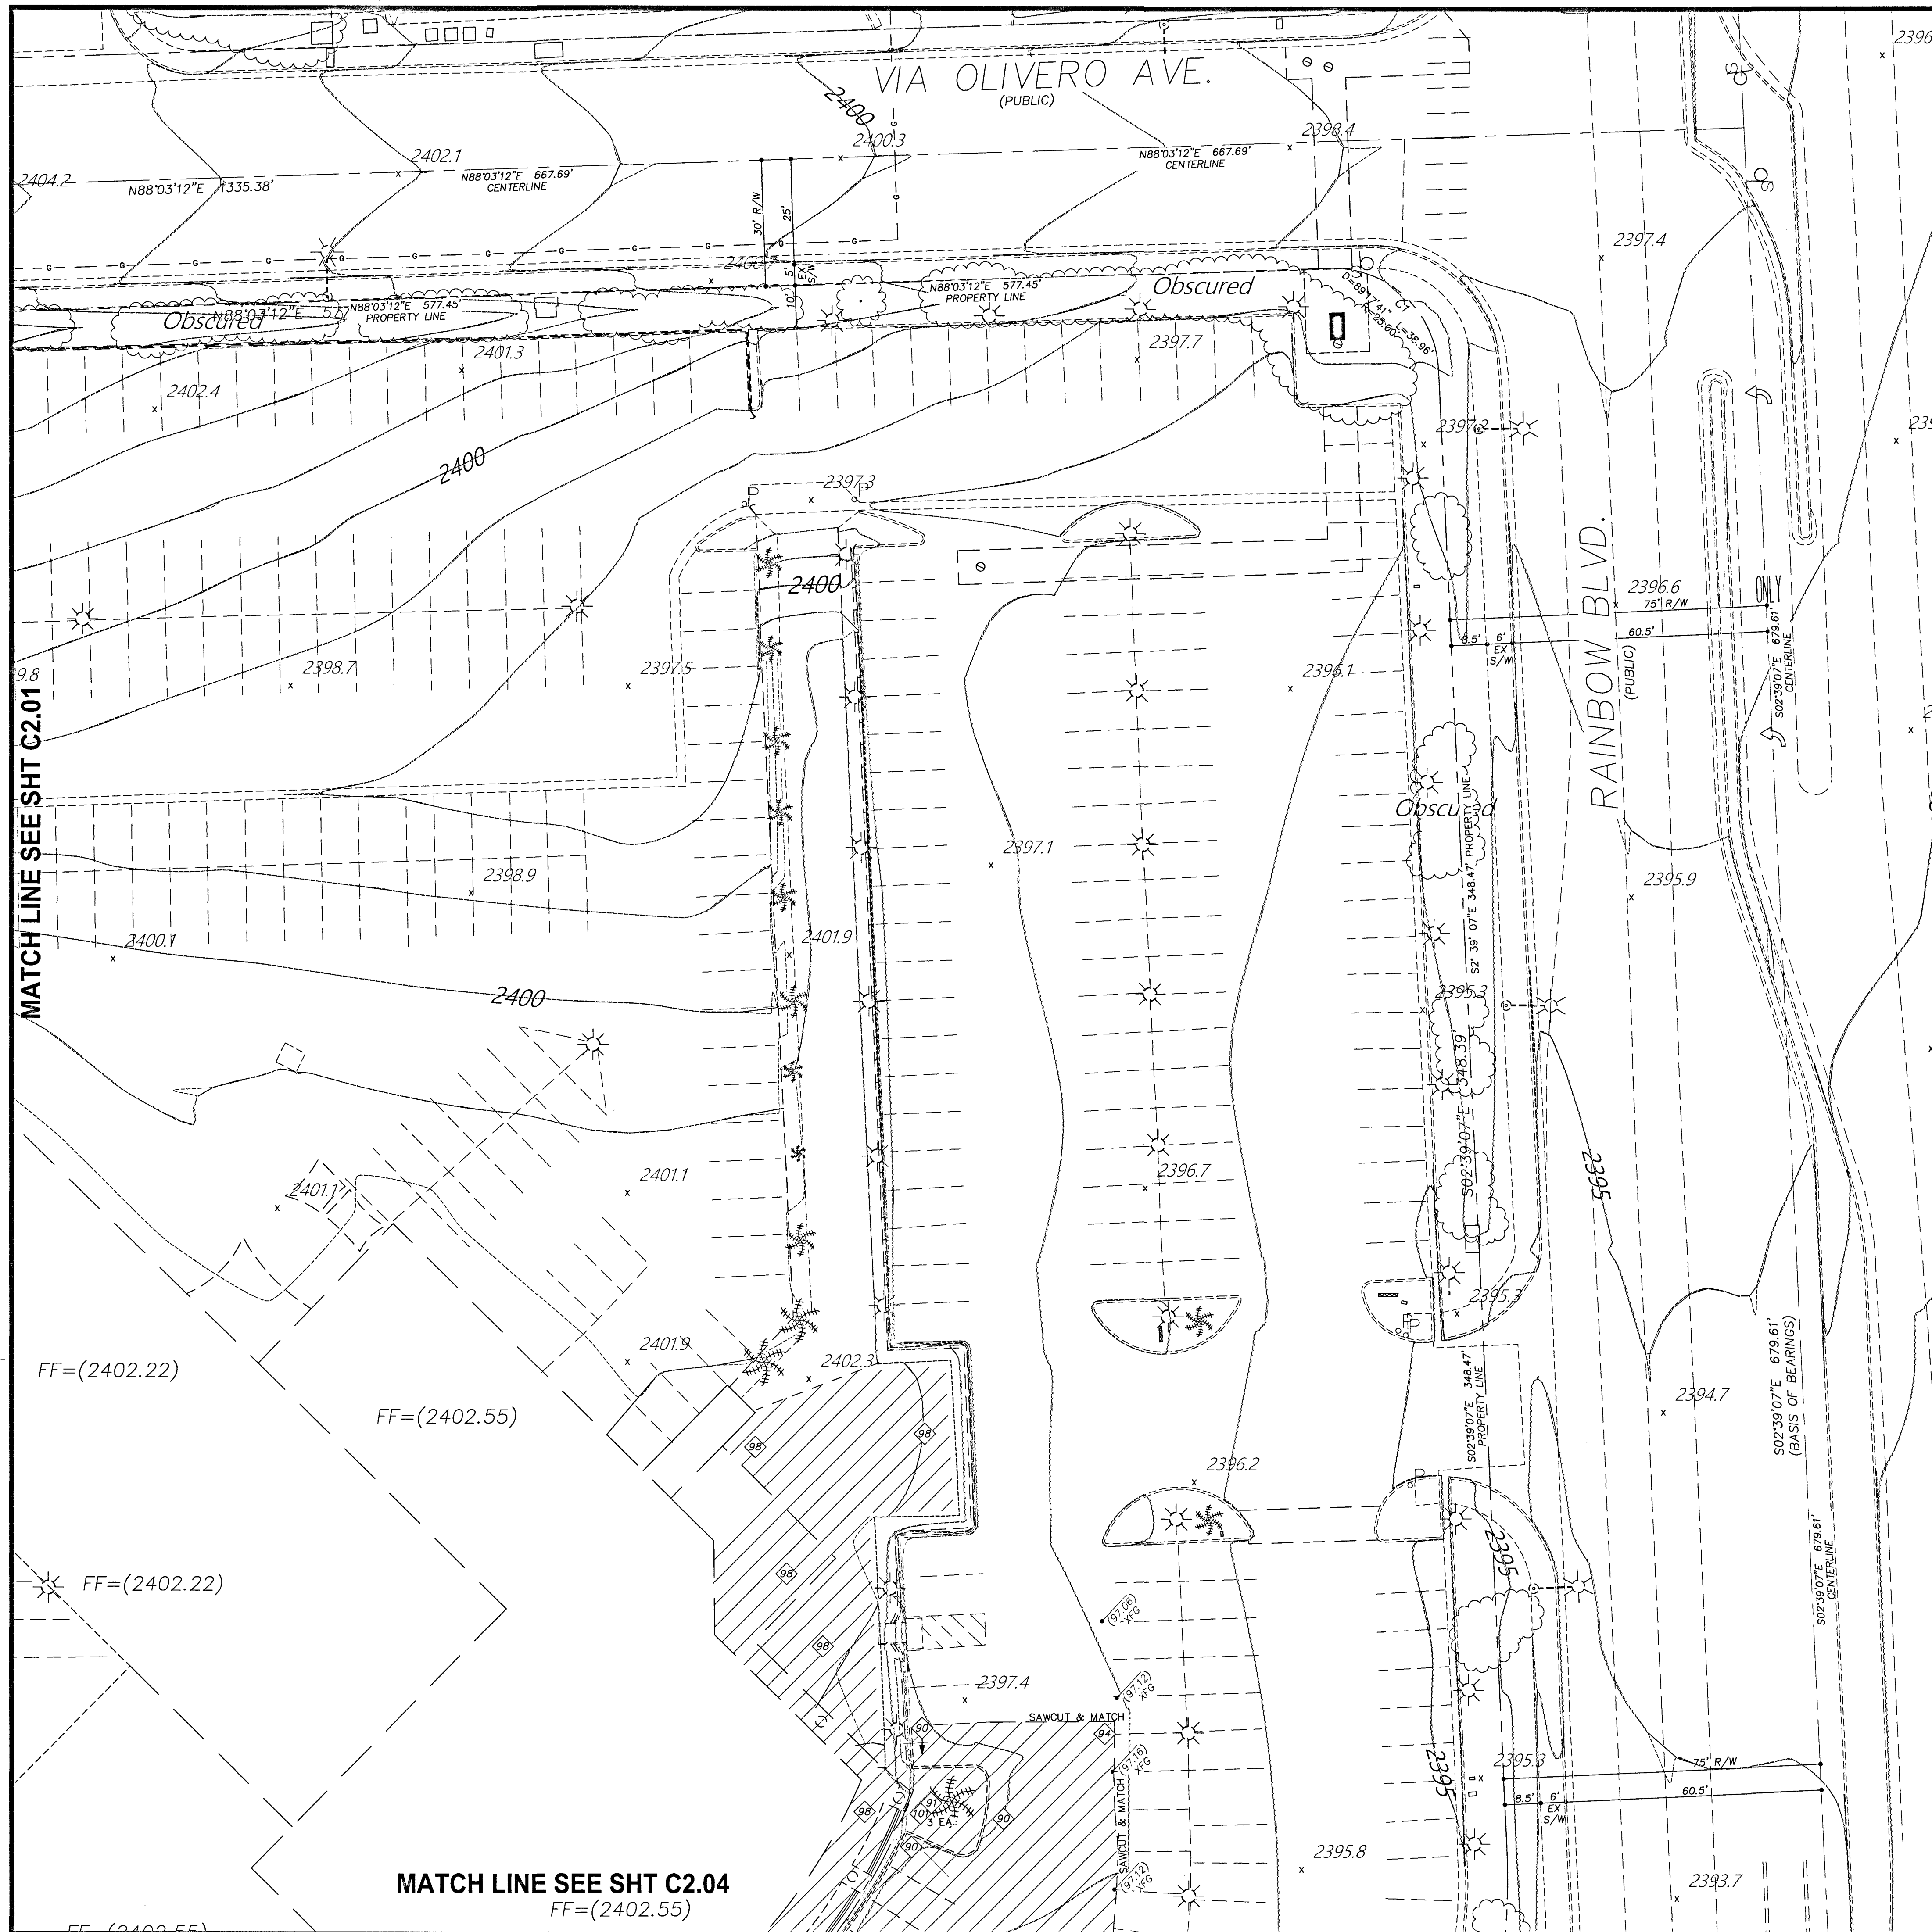

DEMOLITION NOTES	
80	REMOVE EX CURB
81	REMOVE EX PLANT MATERIAL & CAP IRRIGATION (EXCEPT PALM TREES)
82	REMOVE AREA LIGHT & FOUNDATION—INSTALL NO. 3-1/2\"/>
83	REMOVE EX SIGN & SALVAGE FOR RE-USE
84	SAWCUT & REMOVE EX AC PAVING & SALVAGE BASE MATERIAL FOR RE-USE
85	REMOVE EX WALL
86	REMOVE EX CONCRETE VALLEY GUTTER
87	REMOVE EX CANOPY, SUPPORTS, & FOUNDATIONS
88	REMOVE EX CONCRETE WALK
89	REMOVE AREA LIGHT & FOUNDATION—INSTALL NO. 3-1/2\"/>
90	REMOVE EX CONCRETE STAIRS
91	REMOVE EX PALM TREE & SALVAGE FOR RE-USE (16 EA.)
92	
93	
94	PROTECT EX LOOP DETECTORS IN PLACE
95	PROTECT EX AREA LIGHT & CONCRETE BASE IN PLACE
96	PROTECT EX ELECTRICAL TRANSFORMER IN PLACE

PROTECT IN PLACE AND ADJUST LVVWD EXISTING FACILITIES TO FINISHED GRADE PER UDACS. ALL LVVWD FACILITIES SHALL BE ACCESSIBLE AT ALL TIMES.

APPROVED FOR CONSTRUCTION
[Signature]
LAS VEGAS VALLEY WATER DISTRICT ENGINEERING SERVICES
PROJECT NO. 126375 FIRST APPROVED DATE 8/21/18
LVVWD APPROVED FIRE FLOW: TOTAL = 3000 GPM / ONSITE = 3000 GPM

BENCHMARK

CLARK CO. VERTICAL CONTROL V.2003 PT. "7C10 25WS 1997" (NAVD 88), RIVET & ROUND ALUM. PLATE IN TC, NE COR. OF RAINBOW & SAHARA, NEAR THE PC OF RAINBOW. ELEV.=2,392.63 (US SURVEY FEET) = 729.274 (METERS) - INFORMATION PROVIDED BY COLLINS ENG. DATED 1/08/18.

ADD 2300.00 FEET TO ALL GRADES FOR TRUE MEAN SEA ELEVATION, EXCEPT FOR CONTOURS AND FINISH FLOOR ELEVATION

BASIS OF BEARING

S 02°39'07\"/>

GEOTECHNICAL REPORT

ALL GRADING SHALL CONFORM TO THE GEOTECHNICAL REPORT PREPARED BY McGETTIGAN CONSULTING, LLC, DATED 02/27/18, PROJECT NO. 1800701.


REFERENCE INFORMATION

APN 163-03-806-010
DEED 20160725:01560
PM FILE 123, PAGE 49

ZONING INFORMATION
GENERAL COMMERCIAL (C2)
PROJ-72240, SER-72366, DS#4963, PMP#72875
WARD 1 - TARKANIAN

LEGAL DESCRIPTION
POR. GOVT LOTS 130, 131 & 132 WITHIN SE1/4 SE1/4 SEC. 3, T.21S., R.60E., CITY OF LAS VEGAS, CLARK CO. NV.—ROS FILE 128, PAGE 46, #20030226:1042

FLOOD ZONE
UNSHADED ZONE "X", COMMUNITY MAP 32003 C 02165 D, DATED 11/16/2011
AN AREA DETERMINED TO BE OUTSIDE OF THE 0.2% ANNUAL CHANCE FLOOD PLAIN

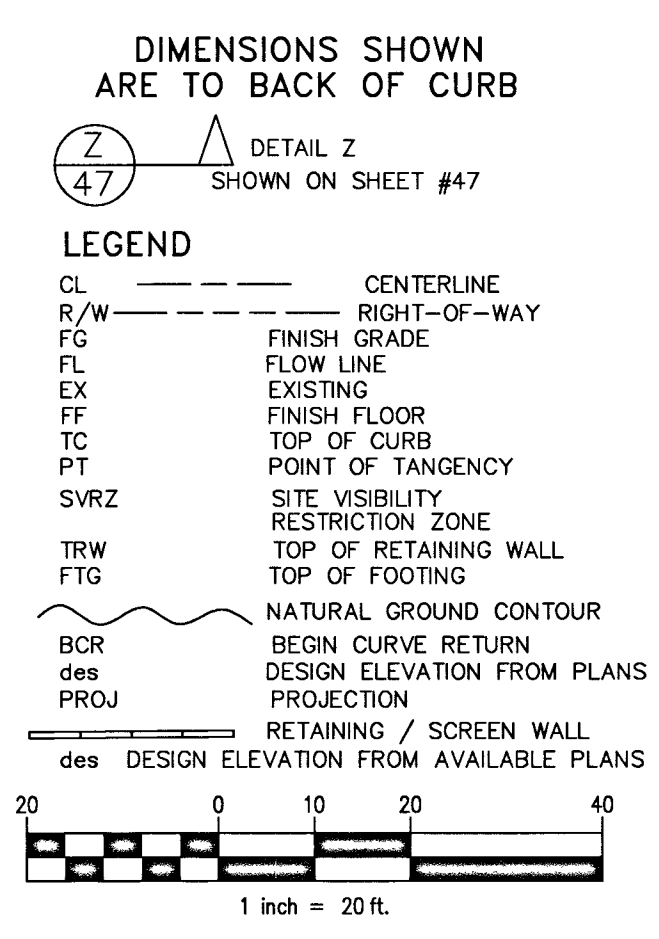

CLARK CO., NEVADA

BMW OF LAS VEGAS

DEMOLITION PLAN 02


CITY OF LAS VEGAS

DATE: 3/2018
DRAFTER: JC
DESIGNER: SCD
CHECKED: SCD
PROJECT NO. 701326.00

PROFESSIONAL ENGINEER - STATE OF NEVADA
SAM C. DUNNAM
EXP. 12-31-18
CIVIL

C2.02
SHEET 4 OF 20
CLV # L18-00533

PROJ# 126375-A QS-163-03-SE

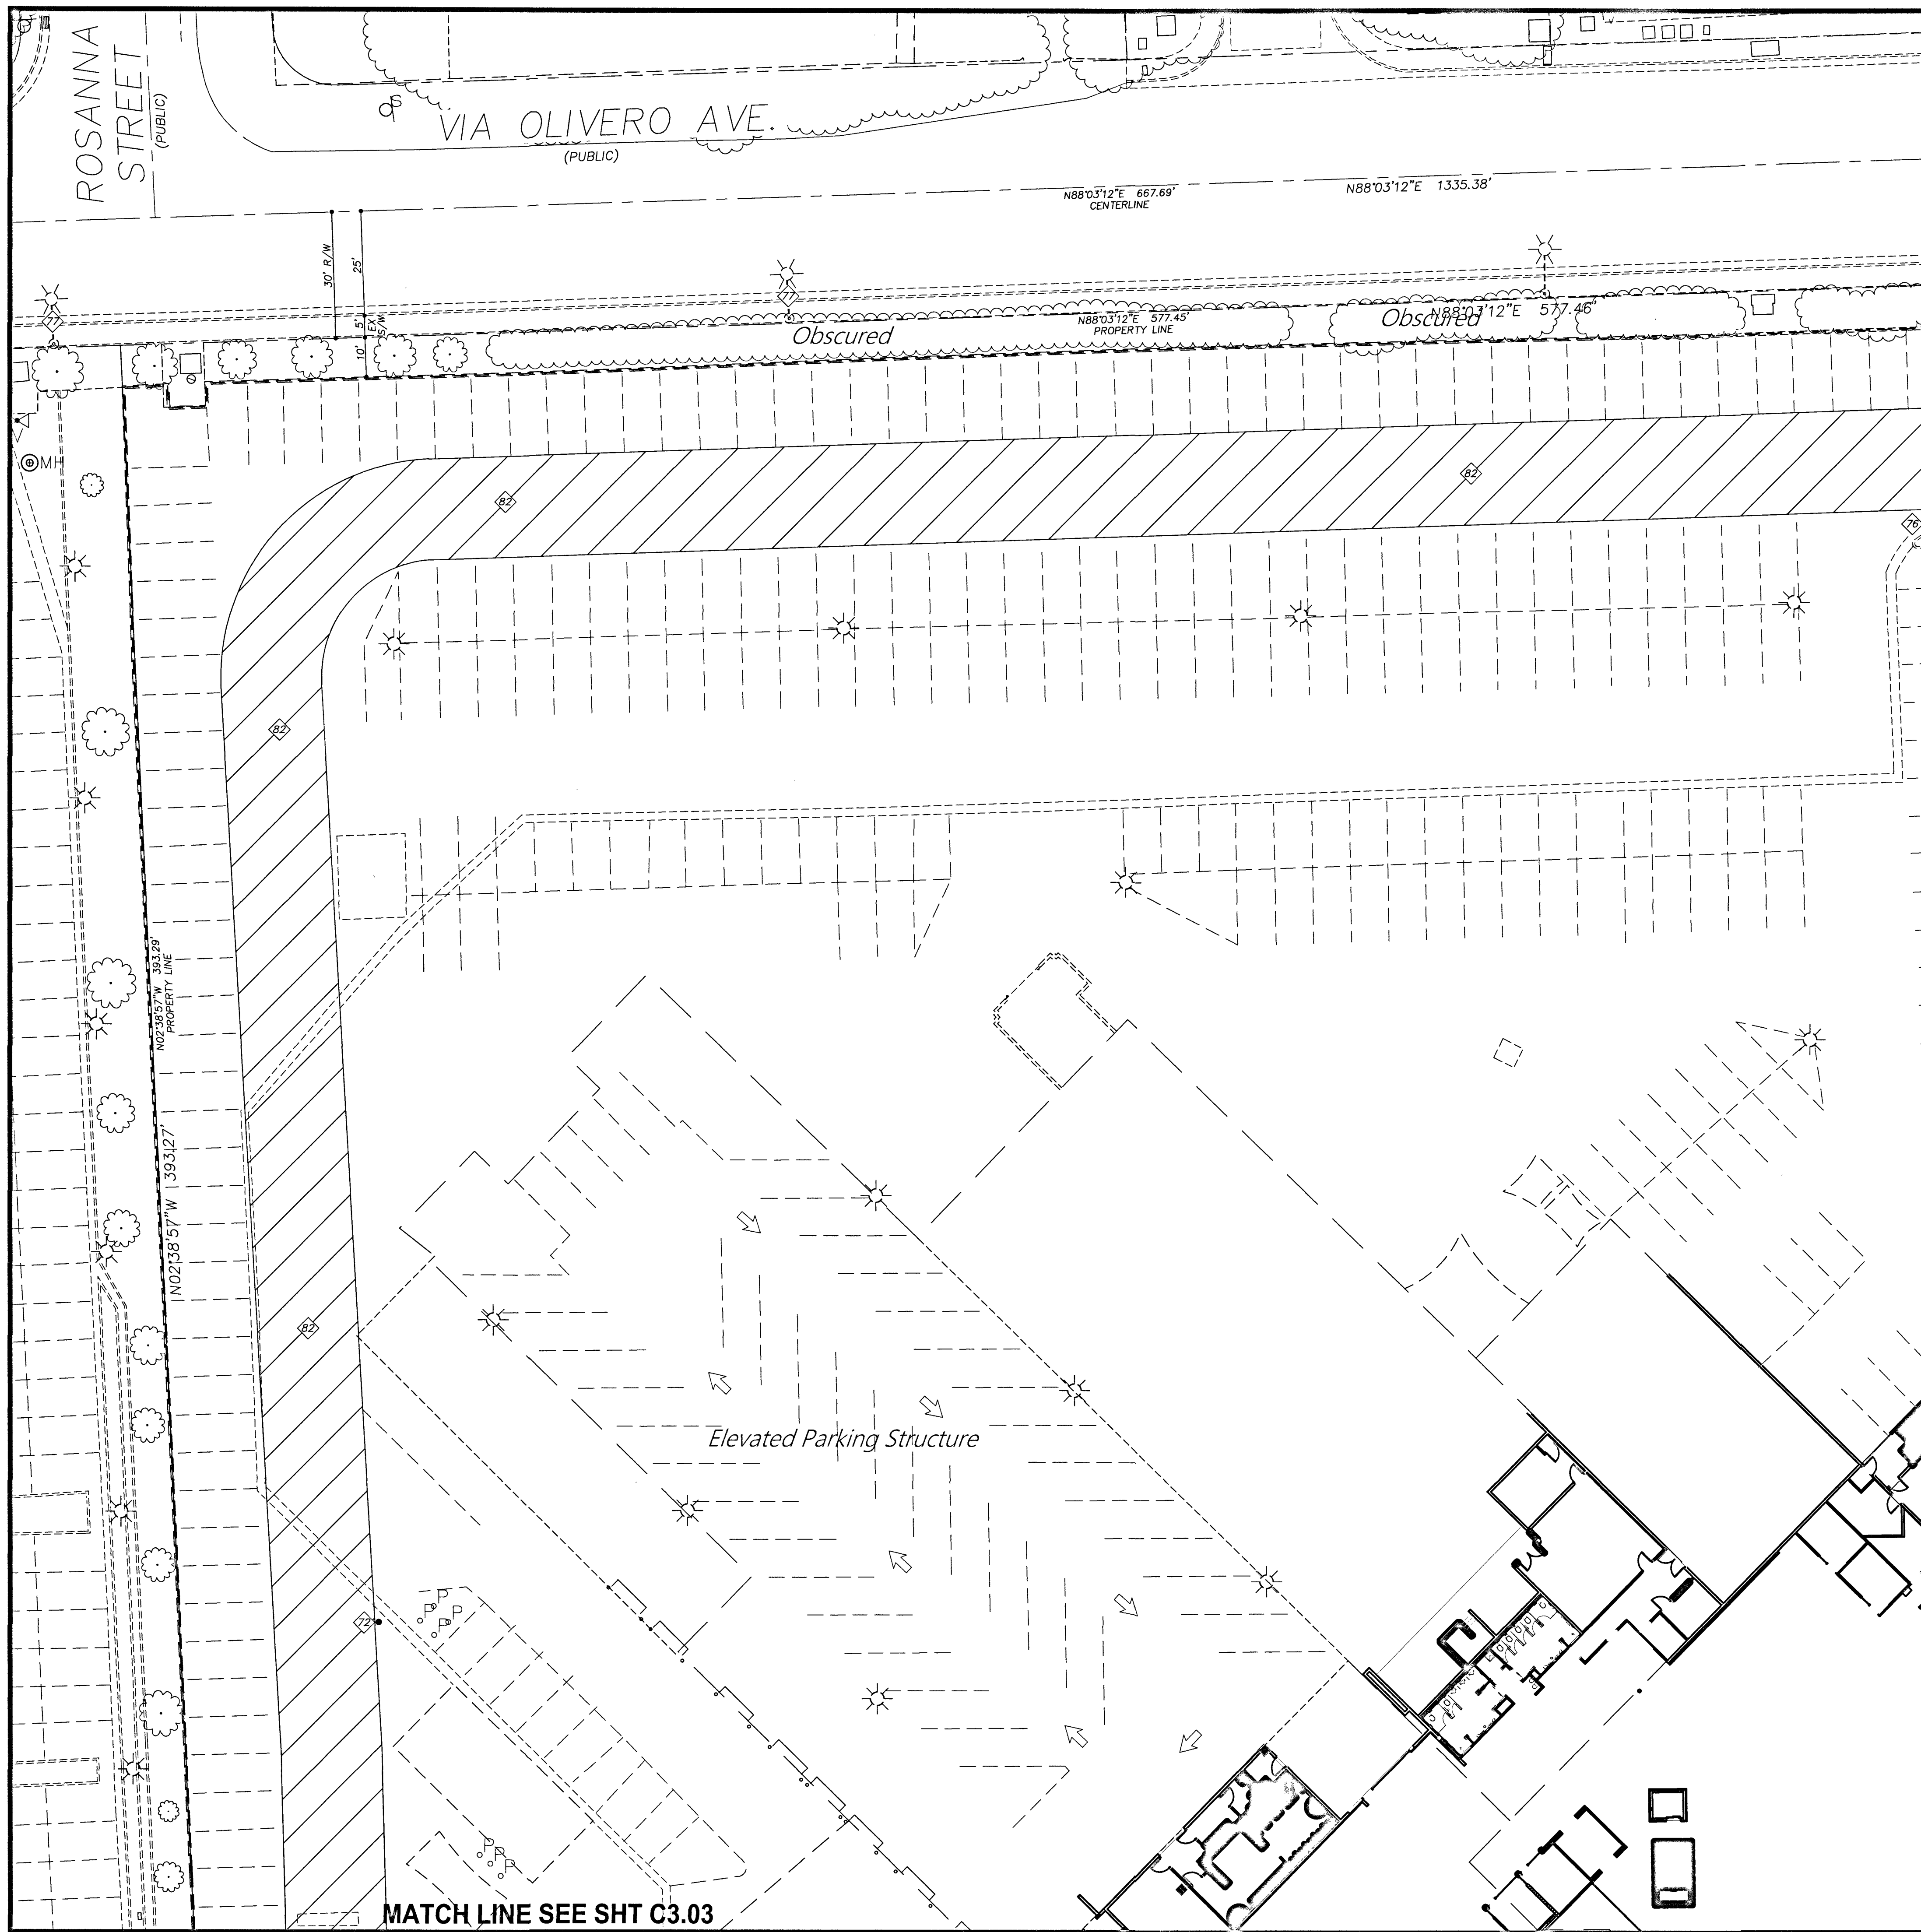

MATCH LINE SEE SHT C3.02



CITY OF LAS VEGAS FIRE DEPT.
DATE: 7/5/18

DIMENSIONS SHOWN ARE TO BACK OF CURB


LEGEND

- CL CENTERLINE
- R/W RIGHT-OF-WAY
- FG FINISH GRADE
- FL FLOW LINE
- EX EXISTING
- FF FINISH FLOOR
- TC TOP OF CURB
- PT POINT OF TANGENCY
- SVRZ SITE VISIBILITY RESTRICTION ZONE
- TRW TOP OF RETAINING WALL
- FTG TOP OF FOOTING
- BCR BEGIN CURVE RETURN
- DES DESIGN ELEVATION FROM PLANS
- PROJ PROJECTION
- RETAINING / SCREEN WALL
- DES DESIGN ELEVATION FROM AVAILABLE PLANS

SCALE
1 inch = 20 ft.

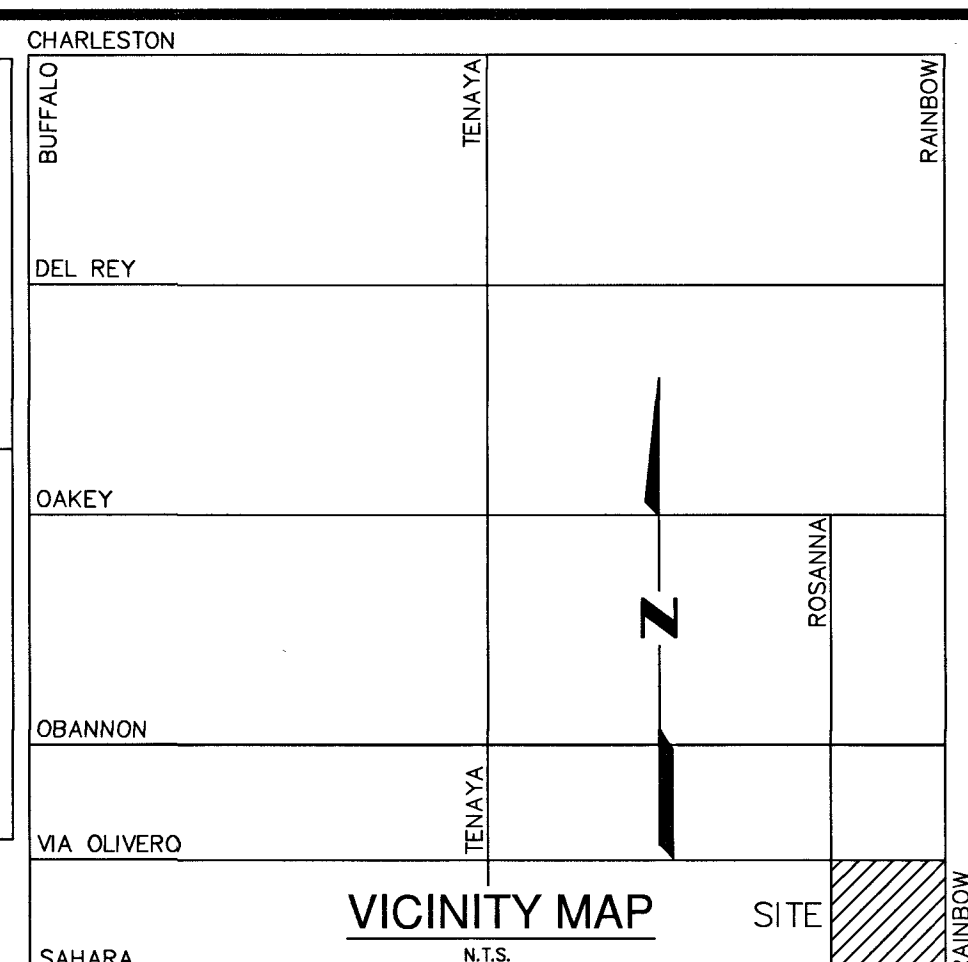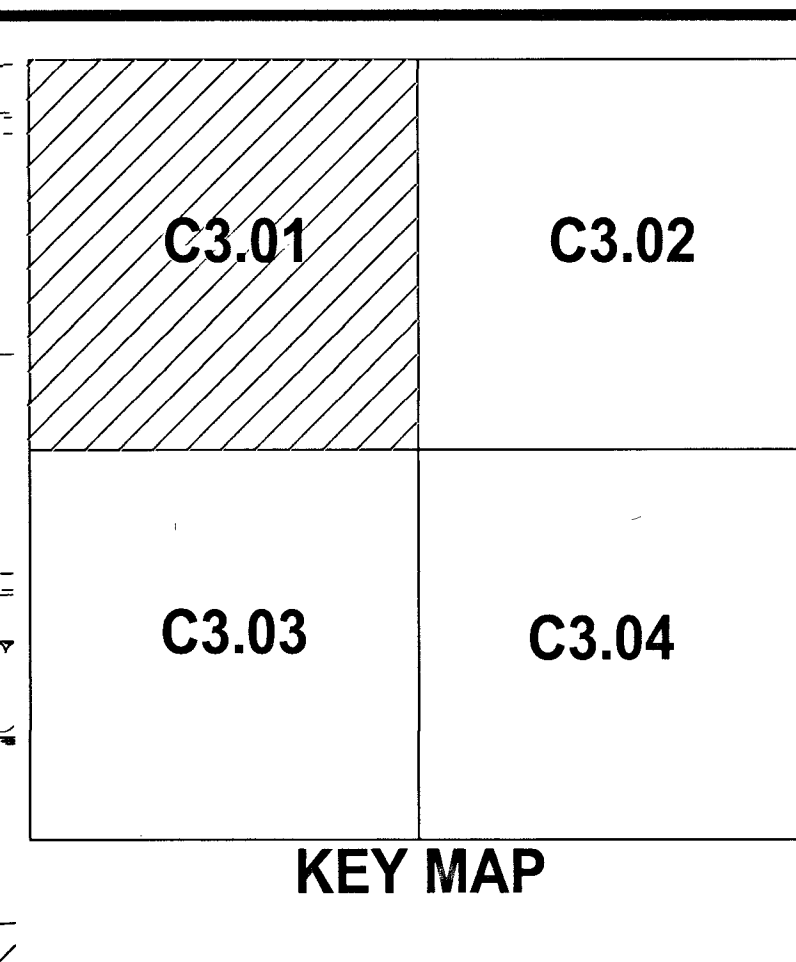

TRAFFIC NOTES	
NO.	ITEM
71	INSTALL 4" WIDE WHITE PAINTED SOLID PARKING LINE
72	INSTALL 4" WIDE WHITE PAINTED DIAGONAL SOLID LINE @ 36" ON CENTER
73	INSTALL BLUE REFLECTIVE RAISED PAVEMENT MARKER @ 10' FROM FACE OF CURB ADJACENT TO FIRE HYDRANT
74	CONSTRUCT HANDICAP ACCESSIBLE PARKING SPACE PER DETAIL #73 SHEET C5.02
75	INSTALL PRE-CAST CONCRETE BUMPER BLOCK PER STD DWG #238 (OR SIMILAR)
76	INSTALL "NO PARKING-FIRE LANE" SIGN PER STD DWG #249.1
77	PAINT CURB RED & STENCIL IN WHITE PAINT "NO PARKING-FIRE LANE" @ 50' ON CENTER
78	EX R7-1op SIGN
79	EX R1-1 & D-1 SIGNS
80	EX R2-1 (45) SIGN
81	EX M5-6 SIGN
82	EX I-8 LIBRARY SIGN
83	FIRE TRUCK ROUTE - 24' WIDE - 52' / 28' RADII (TYP.)

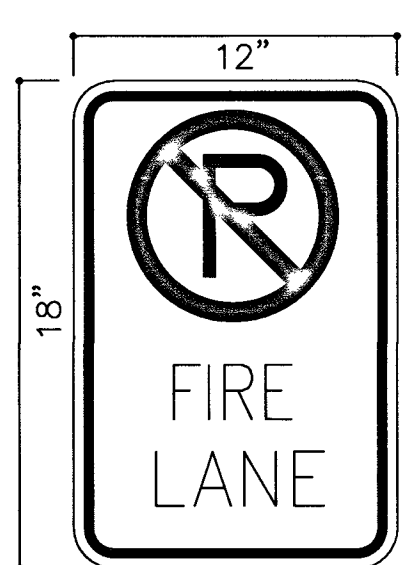

BENCHMARK

CLARK CO. VERTICAL CONTROL V.2003 PT. "7C10 25WS 1997" (NAVD 88), RIVET & ROUND ALUM. PLATE IN TC, NE COR. OF RAINBOW & SAHARA, NEAR THE PC OF RAINBOW. ELEV.=2,392.63 (US SURVEY FEET) = 729.274 (METERS) - INFORMATION PROVIDED BY COLLINS ENG. DATED 1/08/18.

ADD 2300.00 FEET TO ALL GRADES FOR TRUE MEAN SEA ELEVATION, EXCEPT FOR CONTOURS AND FINISH FLOOR ELEVATION

BASIS OF BEARING

S 02°39'07" E, BEING THE BEARING OF THE CENTERLINE OF RAINBOW & THE EAST LINE OF THE SE 1/4 OF THE SE 1/4 OF SEC. 3, T.21S., R.60E., M.D.M., CITY OF LAS VEGAS, CLARK CO., NV, AS SHOWN IN FILE 128 OF SURVEYS, PAGE 46.

GEOTECHNICAL REPORT

ALL GRADING SHALL CONFORM TO THE GEOTECHNICAL REPORT PREPARED BY McGETTIGAN CONSULTING, LLC, DATED 02/27/18, PROJECT NO. 1800701.

REFERENCE INFORMATION

APN 163-03-806-010
DEED 20160725/01560
PM FILE 123, PAGE 49

ZONING INFORMATION
GENERAL COMMERCIAL (C2)
PROJ-72340, SDR-72366, DS#4963, PMP#72875
WARD 1 - TARKANIAN

LEGAL DESCRIPTION
POR. GOVT LOTS 130, 131 & 132 WITHIN SE1/4 SE1/4 SEC. 3, T.21S., R.60E., CITY OF LAS VEGAS, CLARK CO. NV.-ROS FILE 128, PAGE 46, #20030228.1042

FLOOD ZONE
UNSHADED ZONE "X", COMMUNITY MAP 32003 C 02165 D, DATED 11/16/2011
AN AREA DETERMINED TO BE OUTSIDE OF THE 0.2% ANNUAL CHANCE FLOOD PLAIN

CLARK CO., NEVADA

BMW OF LAS VEGAS

TRAFFIC/HORIZONTAL CONTROL PLAN 01

CITY OF LAS VEGAS

DATE: 3/2018

DRAFTER: JC




DESIGNER: SCD

CHECKED: SCD

PROJECT NO. 701326.00


PROFESSIONAL ENGINEER - STATE OF NEVADA
SAM C. DUNNAM
EXP. 12-31-18
CIVIL

C3.01
SHEET 7 OF 20
CLV # L18-00533

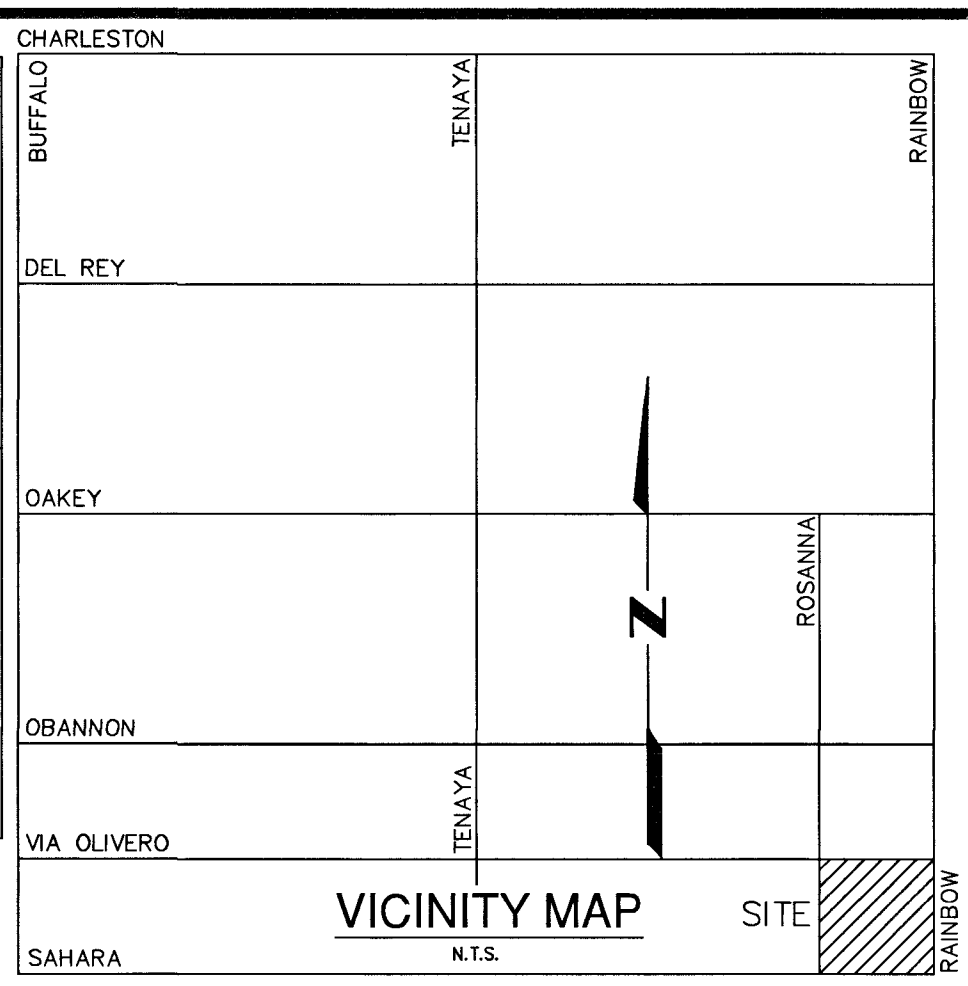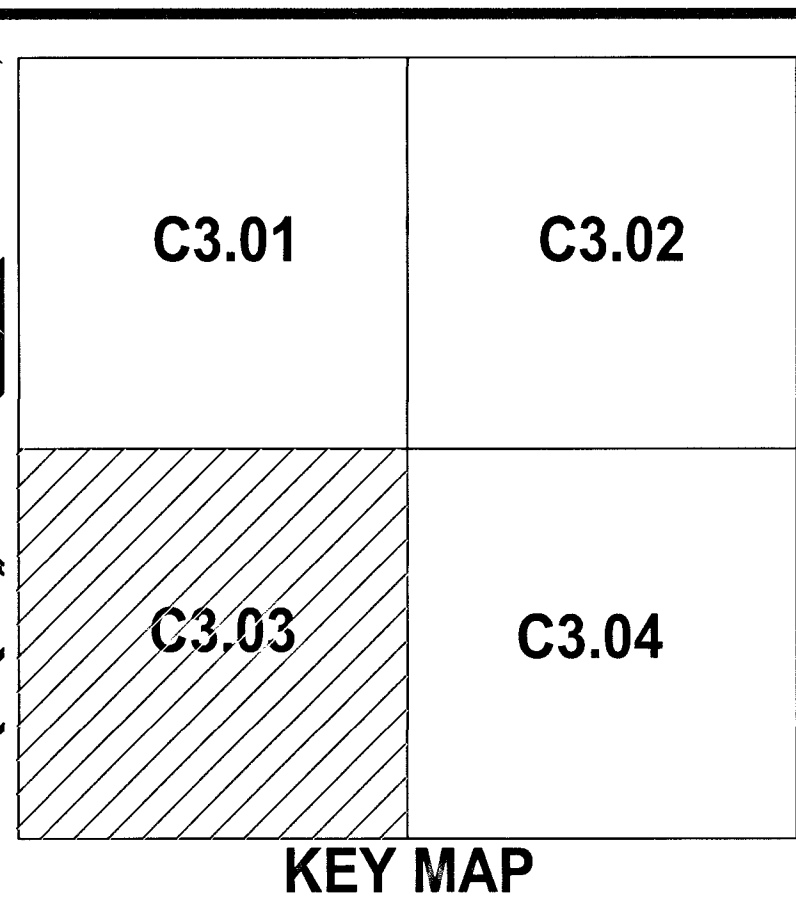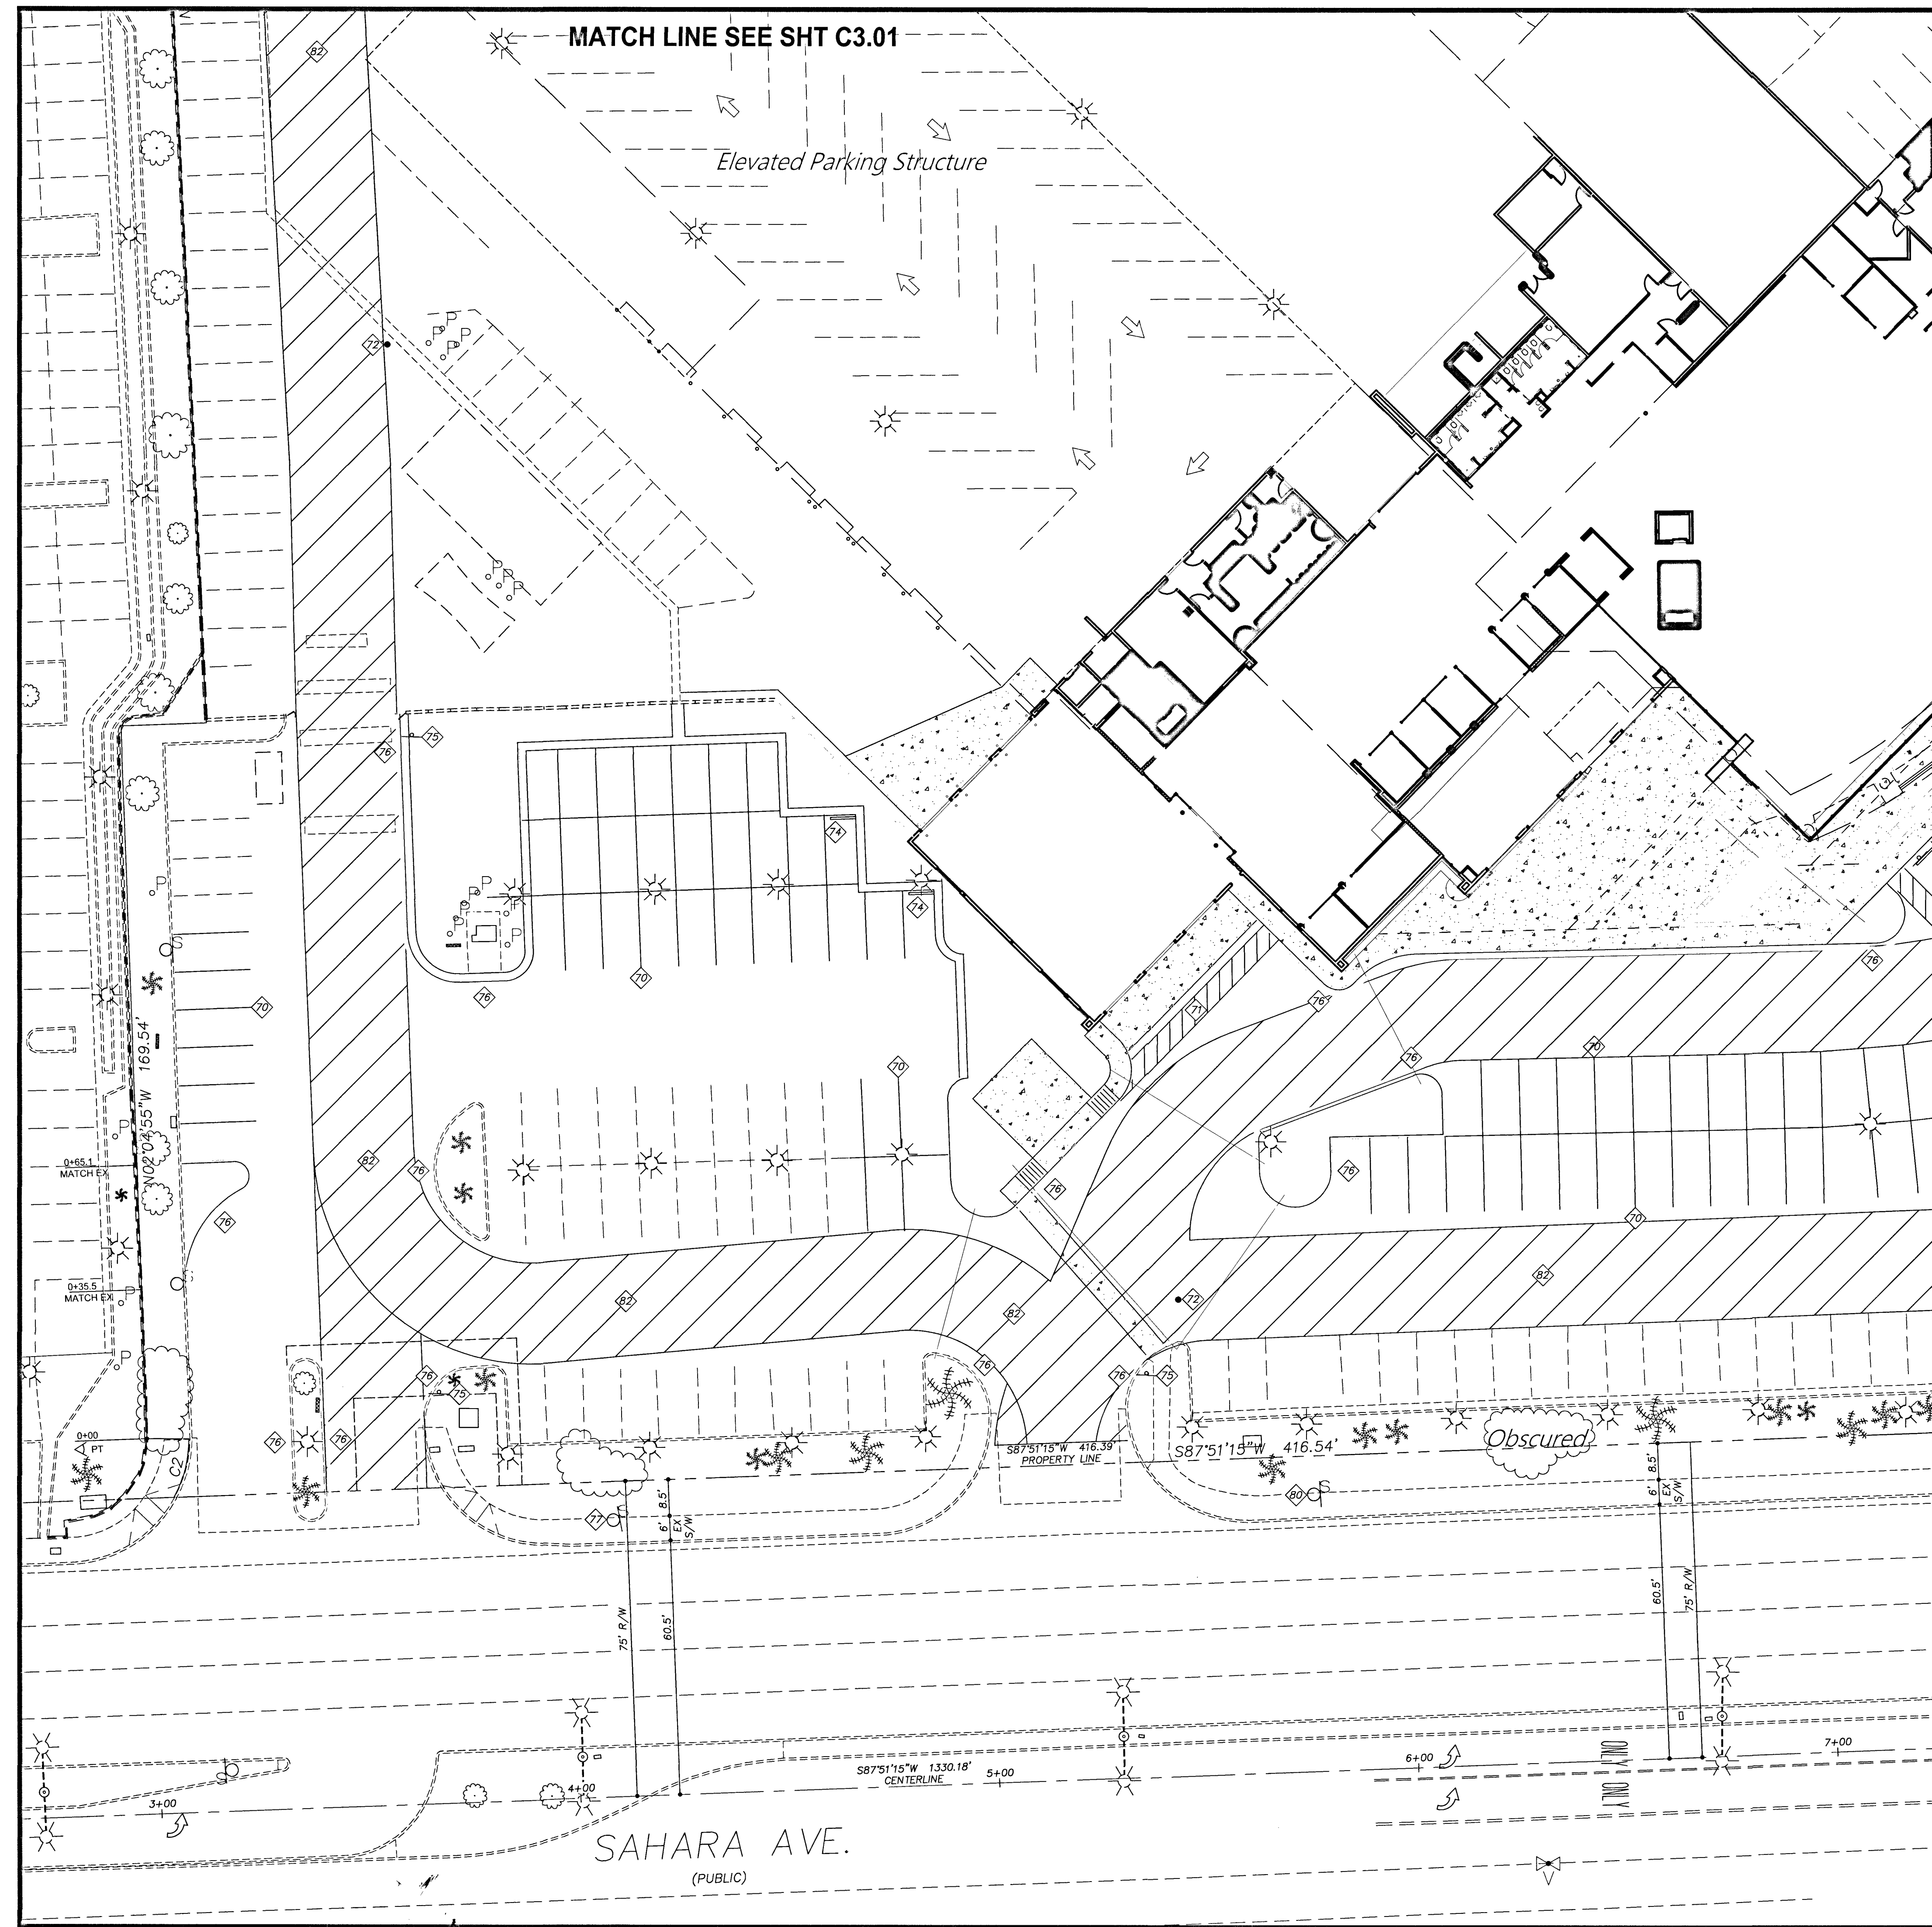

TRAFFIC NOTES	
NO	ITEM
70	INSTALL 4" WIDE WHITE PAINTED SOLID PARKING LINE
71	INSTALL 4" WIDE WHITE PAINTED DIAGONAL SOLID LINE @ 36" ON CENTER
72	NOT USED
73	CONSTRUCT HANDICAP ACCESSIBLE PARKING SPACE PER DETAIL #73 SHEET C5.02
74	INSTALL PRE-CAST CONCRETE BUMPER BLOCK PER STD DWG #238 (OR SIMILAR)
75	INSTALL "NO PARKING-FIRE LANE" SIGN PER STD DWG #249.1
76	PAINT CURB RED & STENCIL IN WHITE PAINT "NO PARKING-FIRE LANE" @ 50" ON CENTER
77	EX R7-1ap SIGN
78	EX R1-1 & D-1 SIGNS
79	EX R2-1 (45) SIGN
80	EX M5-6 SIGN
81	EX I-8 LIBRARY SIGN
82	FIRE TRUCK ROUTE - 24' WIDE - 52' / 28' RADII (TYP.)

MATCH LINE SEE SHT C3.04

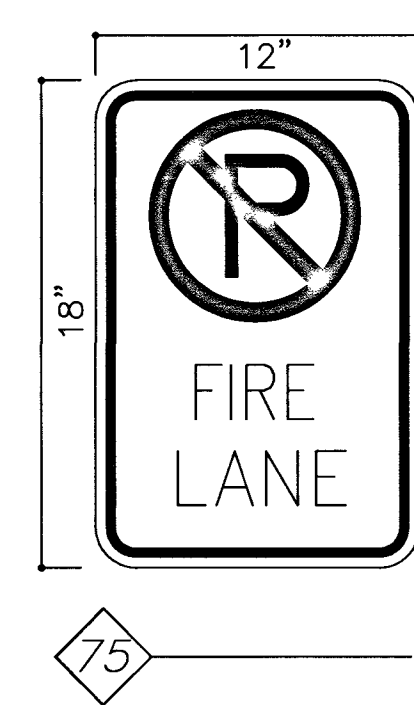

[Signature]
CITY OF LAS VEGAS FIRE DEPT. 7/5/10 DATE

DIMENSIONS SHOWN ARE TO BACK OF CURB

LEGEND

- CL CENTERLINE
- R/W RIGHT-OF-WAY
- FG FINISH GRADE
- FL FLOW LINE
- EX EXISTING
- FF FINISH FLOOR
- TC TOP OF CURB
- PT POINT OF TANGENCY
- SVRZ SITE VISIBILITY RESTRICTION ZONE
- TRW TOP OF RETAINING WALL
- FTG TOP OF FOOTING
- BCR BEGIN CURVE RETURN
- DES DESIGN ELEVATION FROM PLANS
- PROJ PROJECTION
- RETAINING / SCREEN WALL
- DES DESIGN ELEVATION FROM AVAILABLE PLANS

1 inch = 20 ft.

BENCHMARK

CLARK CO. VERTICAL CONTROL V.2003 PT. "C10 25WS 1997" (NAVD 88), RIVET & ROUND ALUM. PLATE IN TC, NE COR. OF RAINBOW & SAHARA, NEAR THE PC OF RAINBOW. ELEV.=2,392.63 (US SURVEY FEET) = 729.274 (METERS) - INFORMATION PROVIDED BY COLLINS ENG. DATED 1/08/18.

ADD 2300.00 FEET TO ALL GRADES FOR TRUE MEAN SEA ELEVATION, EXCEPT FOR CONTOURS AND FINISH FLOOR ELEVATION

BASIS OF BEARING

S 02°39'07" E, BEING THE BEARING OF THE CENTERLINE OF RAINBOW & THE EAST LINE OF THE SE 1/4 OF THE SE 1/4 OF SEC. 3, T.21S., R.60E., M.D.M., CITY OF LAS VEGAS, CLARK CO., NV, AS SHOWN IN FILE 128 OF SURVEYS, PAGE 46.

GEOTECHNICAL REPORT

ALL GRADING SHALL CONFORM TO THE GEOTECHNICAL REPORT PREPARED BY McGETTIGAN CONSULTING, LLC, DATED 02/27/18, PROJECT NO. 1800701.

REFERENCE INFORMATION

APN 163-03-806-010
DEED 20160725:01560
PM FILE 123, PAGE 49

ZONING INFORMATION
GENERAL COMMERCIAL (C2)
PROJ-72340, SDR-72356, DS#4963, PMP#72875
WARD 1 - TARKANIAN

LEGAL DESCRIPTION
POR. GOVT LOTS 130, 131 & 132 WITHIN SE1/4 SE1/4 SEC. 3, T.21S., R.60E., CITY OF LAS VEGAS, CLARK CO. NV.-ROS FILE 128, PAGE 46, #20030226:1042

FLOOD ZONE
UNSHADED ZONE "X", COMMUNITY MAP 32003 C 02165 D, DATED 11/16/2011
AN AREA DETERMINED TO BE OUTSIDE OF THE 0.2% ANNUAL CHANCE FLOOD PLAIN

CLARK CO., NEVADA

BMW OF LAS VEGAS

TRAFFIC/HORIZONTAL CONTROL PLAN 03

CITY OF LAS VEGAS

DATE: 3/2018

DRAFTER: JC

DESIGNER: SCD

CHECKED: SCD

PROJECT NO. 701326.00

PROFESSIONAL ENGINEER - STATE OF NEVADA

SAM C. DUNNAM




EXP. 12-31-18

CIVIL


C3.03

SHEET 9 OF 20

CLV # L18-00533

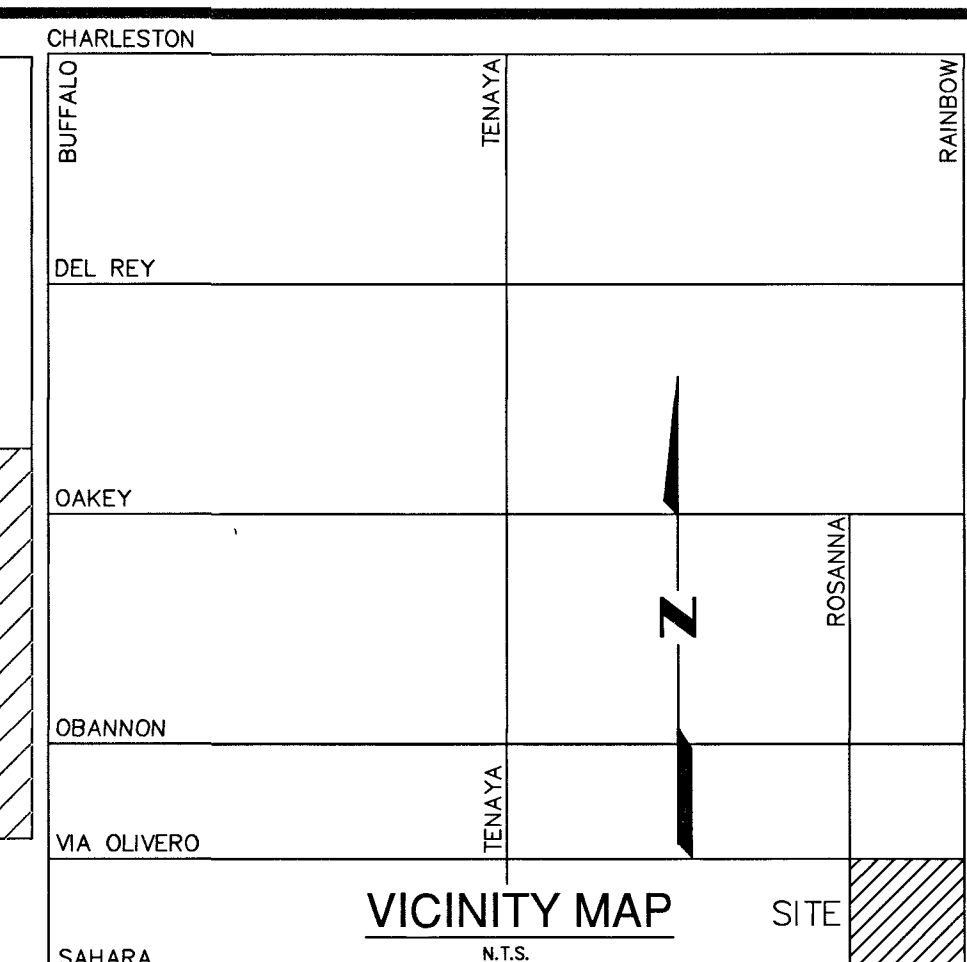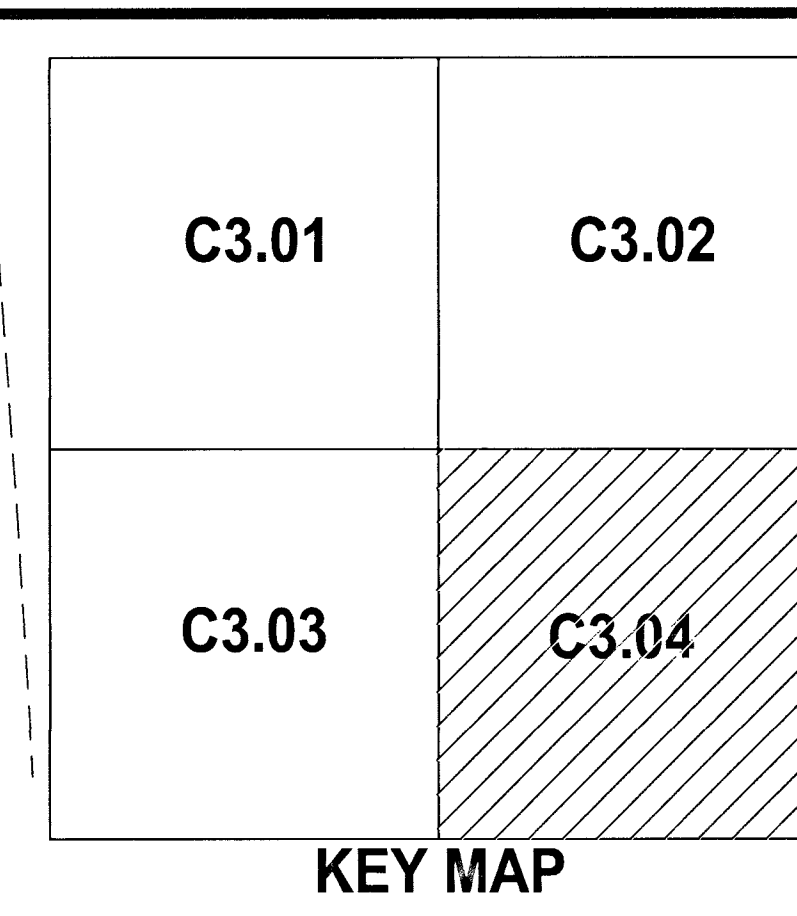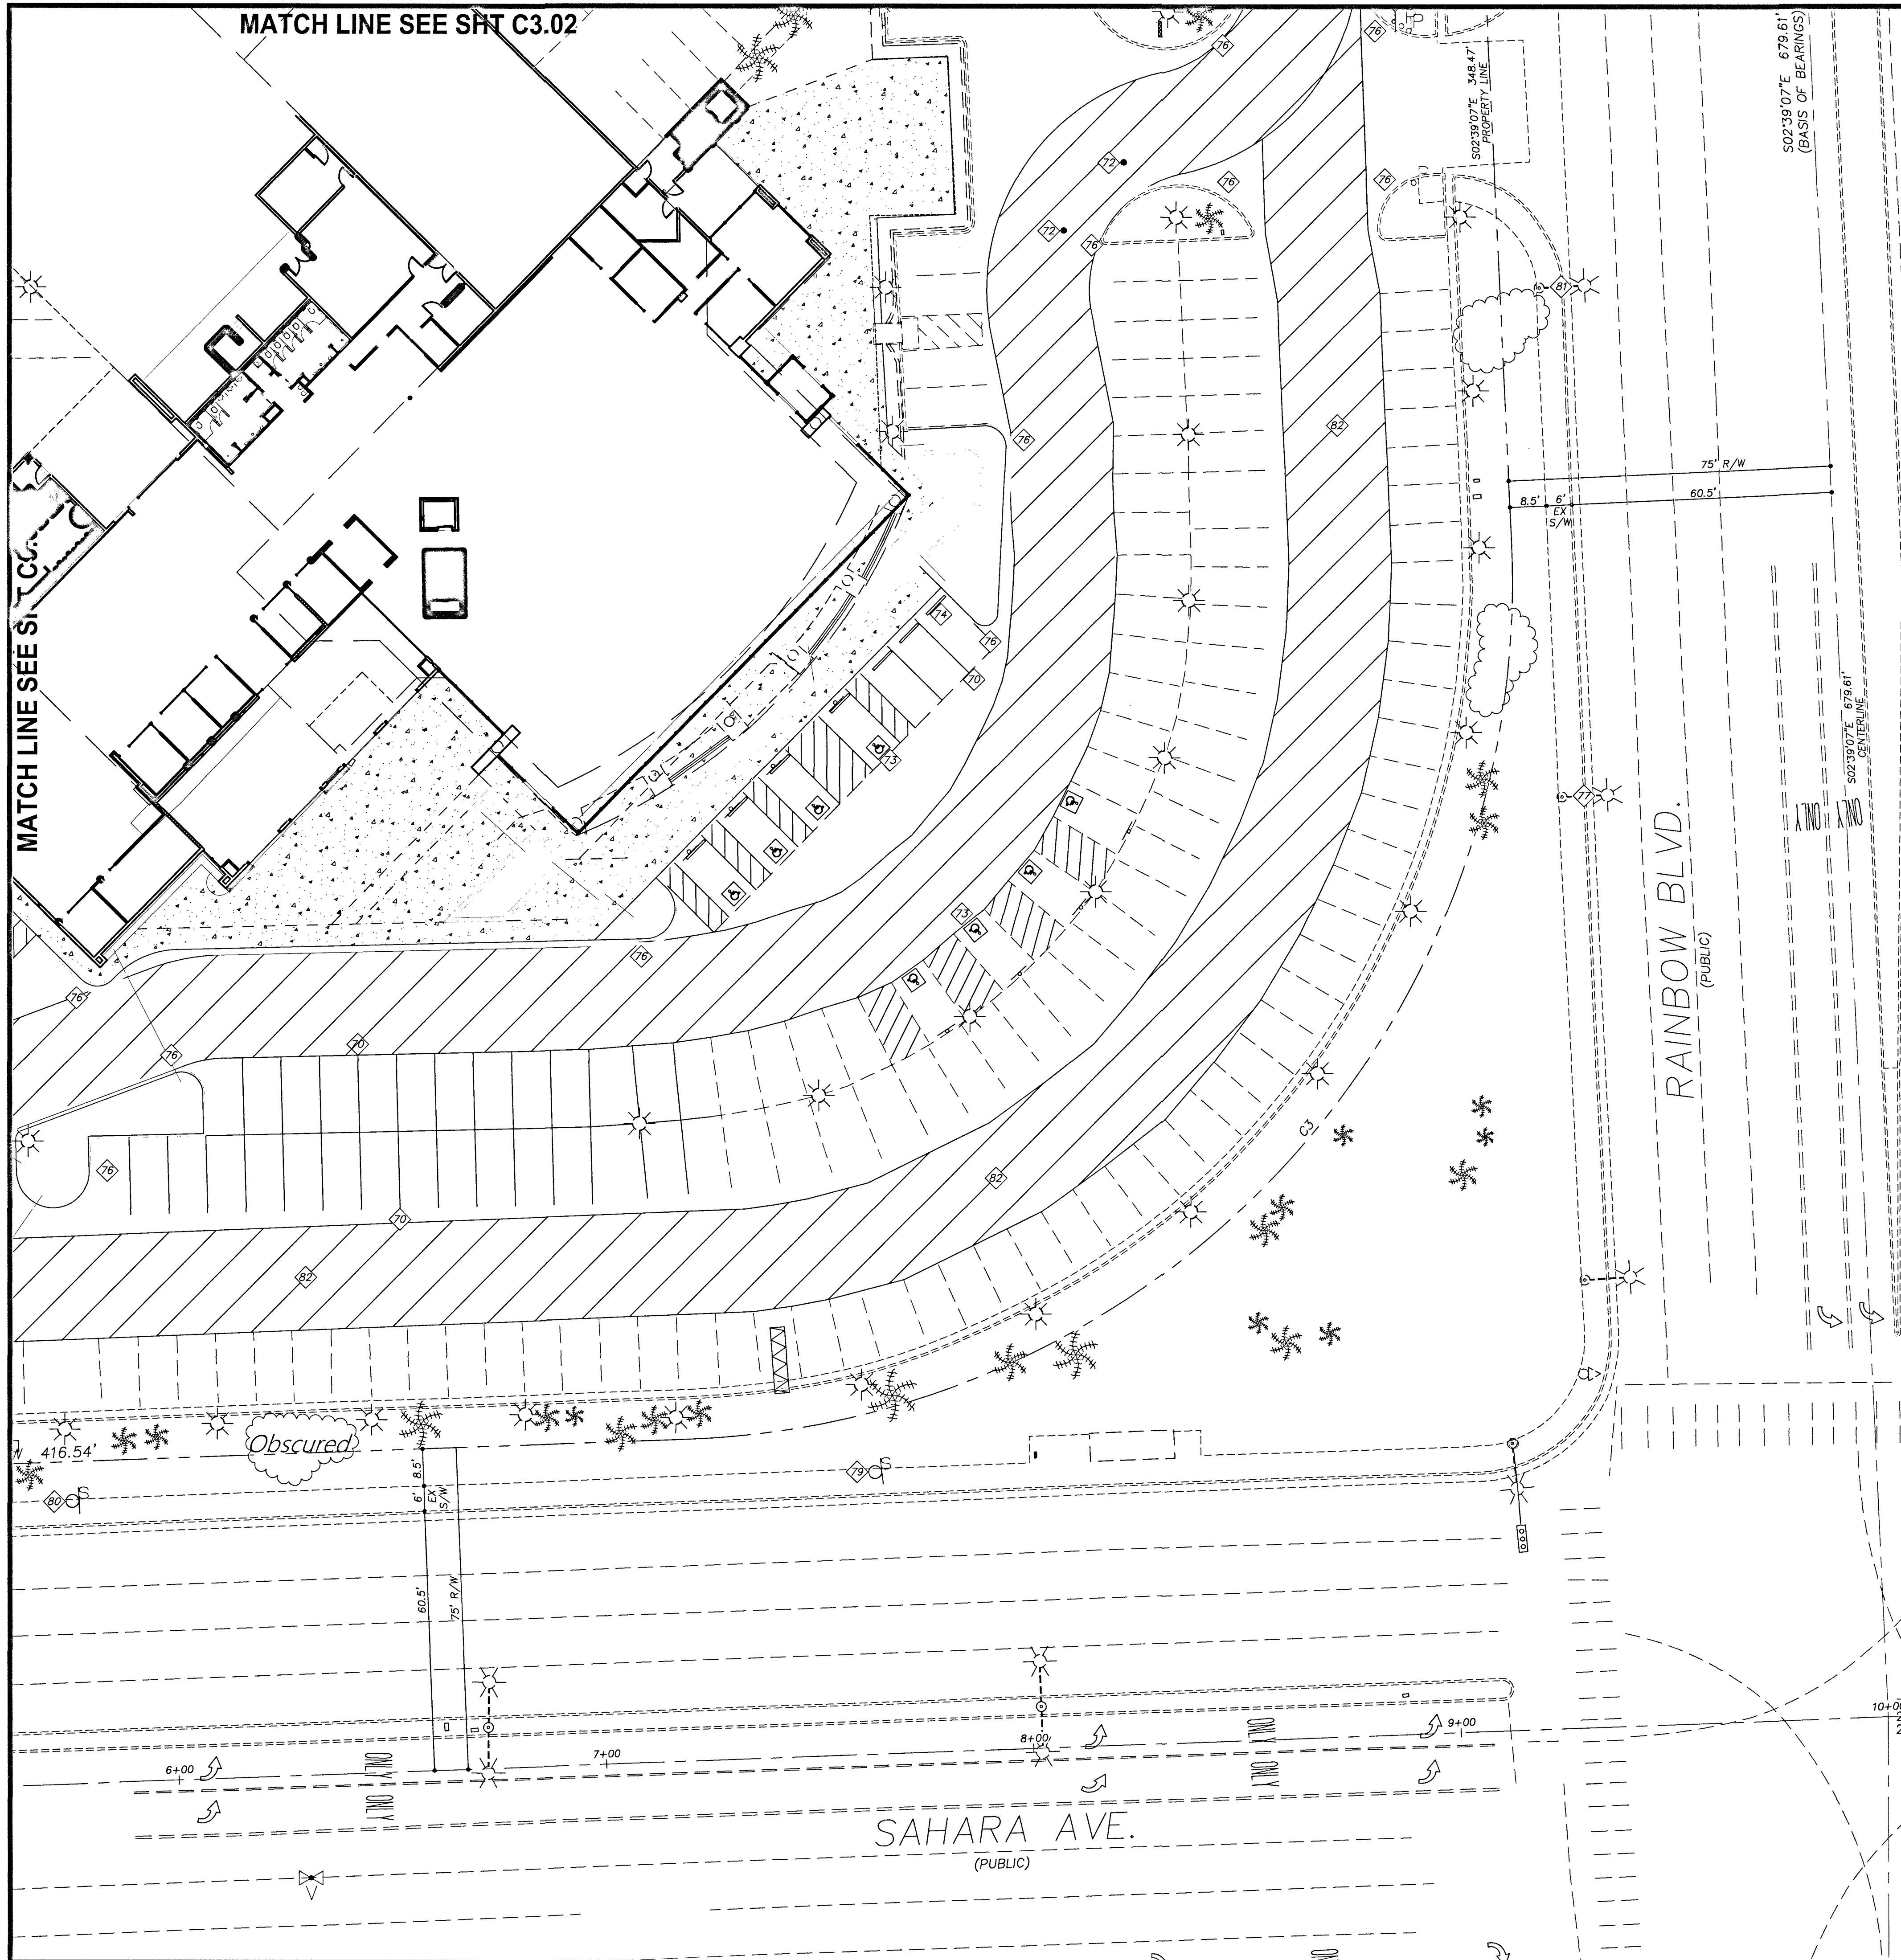

TRAFFIC NOTES	
NO.	ITEM
70	INSTALL 4" WIDE WHITE PAINTED SOLID PARKING LINE
71	INSTALL 4" WIDE WHITE PAINTED DIAGONAL SOLID LINE @ 36" ON CENTER
72	NOT USED
73	CONSTRUCT HANDICAP ACCESSIBLE PARKING SPACE PER DETAIL #73 SHEET C5.02
74	INSTALL PRE-CAST CONCRETE BUMPER BLOCK PER STD DWG #238 (OR SIMILAR)
75	INSTALL "NO PARKING-FIRE LANE" SIGN PER STD DWG #249.1
76	PAINT CURB RED & STENCIL IN WHITE PAINT "NO PARKING-FIRE LANE" @ 50" ON CENTER
77	EX R7-1ap SIGN
78	EX R1-1 & D-1 SIGNS
79	EX R2-1 (45) SIGN
80	EX M5-6 SIGN
81	EX I-8 LIBRARY SIGN
82	FIRE TRUCK ROUTE - 24' WIDE - 52' / 28' RADII (TYP.)

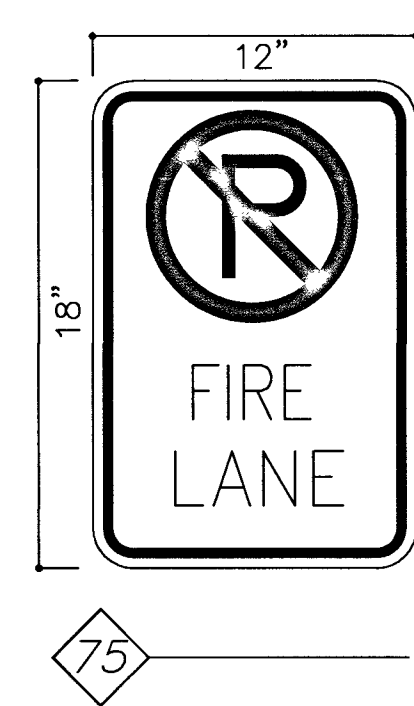

CITY OF LAS VEGAS FIRE DEPT. DATE

DIMENSIONS SHOWN ARE TO BACK OF CURB

DETAIL Z SHOWN ON SHEET #47

LEGEND

- CL CENTERLINE
- R/W RIGHT-OF-WAY
- FG FINISH GRADE
- FL FLOW LINE
- EX EXISTING
- FF FINISH FLOOR
- TC TOP OF CURB
- PT POINT OF TANGENCY
- SVRZ SITE VISIBILITY RESTRICTION ZONE
- TRW TOP OF RETAINING WALL
- FTG TOP OF FOOTING
- BCR NATURAL GROUND CONTOUR
- des BEGIN CURVE RETURN
- PROJ DESIGN ELEVATION FROM PLANS
- RETAINING / SCREEN WALL
- des DESIGN ELEVATION FROM AVAILABLE PLANS

1 inch = 20 ft.

BENCHMARK

CLARK CO. VERTICAL CONTROL V.2003 PT. "7C10 25WS 1997" (NAVD 88), RIVET & ROUND ALUM. PLATE IN TC, NE COR. OF RAINBOW & SAHARA, NEAR THE PC OF RAINBOW. ELEV.=2,392.63 (US SURVEY FEET) = 729.274 (METERS) - INFORMATION PROVIDED BY COLLINS ENG. DATED 1/08/18.

ADD 2300.00 FEET TO ALL GRADES FOR TRUE MEAN SEA ELEVATION, EXCEPT FOR CONTOURS AND FINISH FLOOR ELEVATION

BASIS OF BEARING

S 02°39'07" E, BEING THE BEARING OF THE CENTERLINE OF RAINBOW & THE EAST LINE OF THE SE 1/4 OF THE SE 1/4 OF SEC. 3, T.21S., R.60E., M.D.M., CITY OF LAS VEGAS, CLARK CO., NV, AS SHOWN IN FILE 128 OF SURVEYS, PAGE 46.

GEOTECHNICAL REPORT

ALL GRADING SHALL CONFORM TO THE GEOTECHNICAL REPORT PREPARED BY McGETTIGAN CONSULTING, LLC, DATED 02/27/18, PROJECT NO. 1800701.

REFERENCE INFORMATION

APN 163-03-806-010
DEED 20160725-01560
FM FILE 123, PAGE 49

ZONING INFORMATION
GENERAL COMMERCIAL (C2)
PROJ-72340, SDR-72366, DS#4963, PMP#72875
WARD 1 - TARKANIAN

LEGAL DESCRIPTION
POR. GOVT LOTS 130, 131 & 132 WITHIN SE1/4 SE1/4 SEC. 3, T.21S., R.60E., CITY OF LAS VEGAS, CLARK CO. NV.-ROS FILE 128, PAGE 46, #20030226:1042

FLOOD ZONE
UNSHADED ZONE "X", COMMUNITY MAP 32003 C 02165 D, DATED 11/16/2011
AN AREA DETERMINED TO BE OUTSIDE OF THE 0.2% ANNUAL CHANCE FLOOD PLAIN

CLARK CO., NEVADA

BMW OF LAS VEGAS

TRAFFIC/HORIZONTAL CONTROL PLAN 04

CITY OF LAS VEGAS

DATE: 3/2018

DRAFTER: JC

DESIGNER: SCD

CHECKED: SCD

 
PROJECT NO. 701326.00




PROFESSIONAL ENGINEER - STATE OF NEVADA
SAM C. DUNHAM
EXP. 12-31-18
CIVIL
107V7427

C3.04

SHEET 10 OF 20

CLV # L18-00533

[illegible]

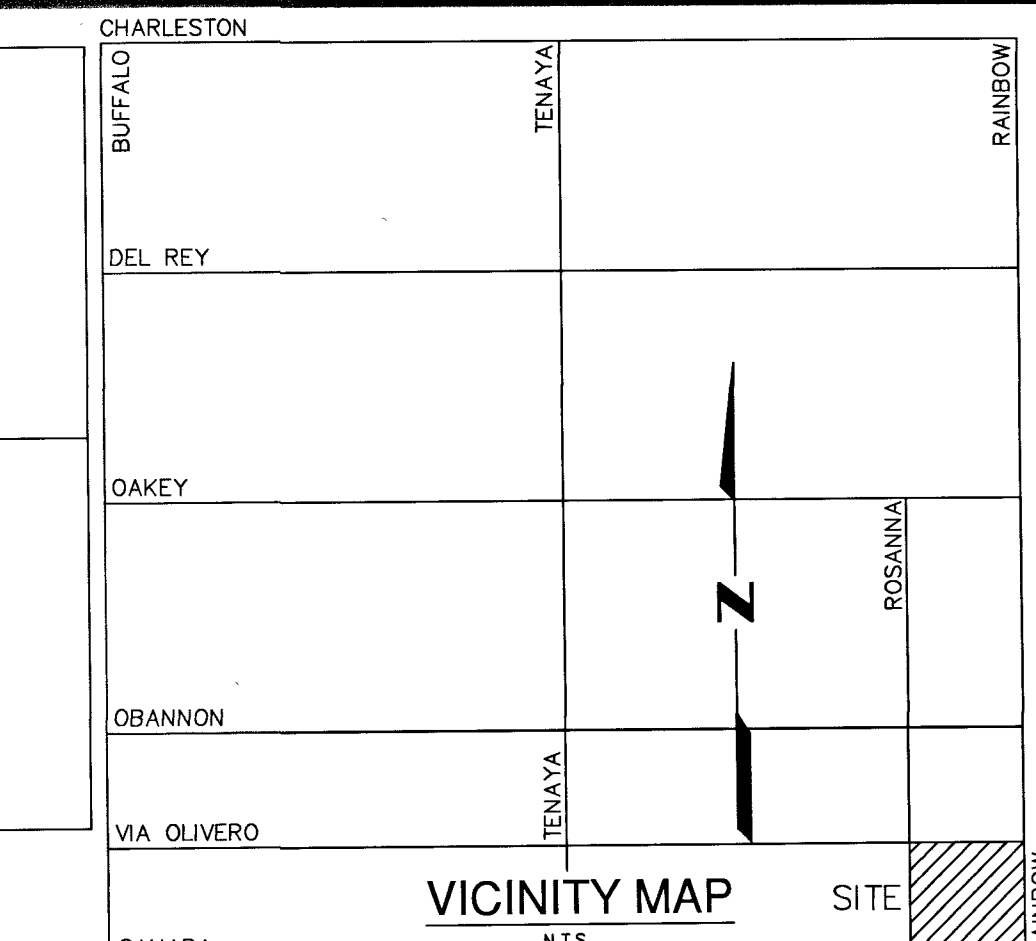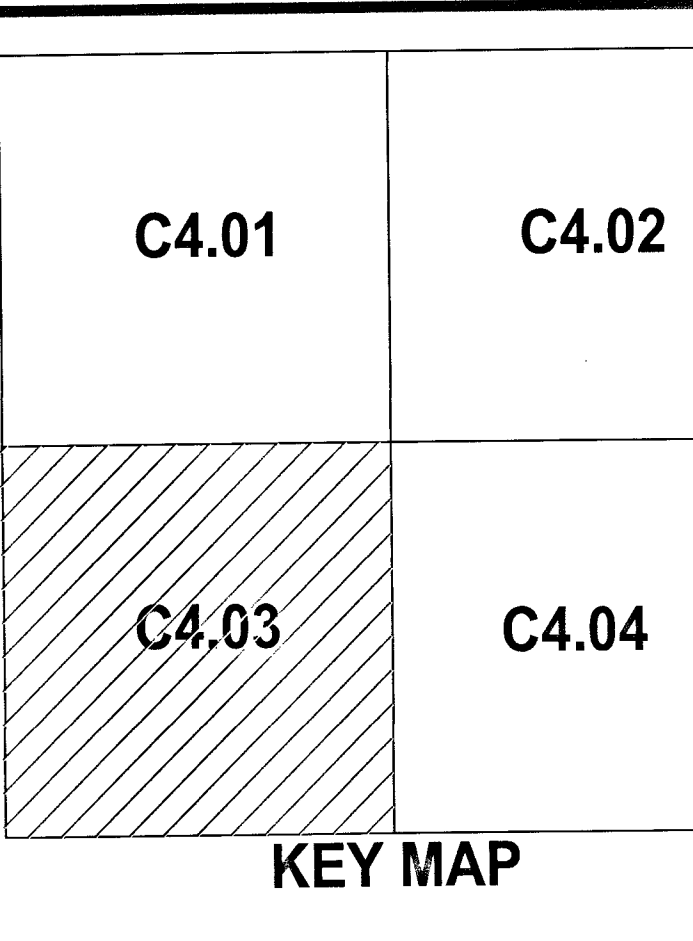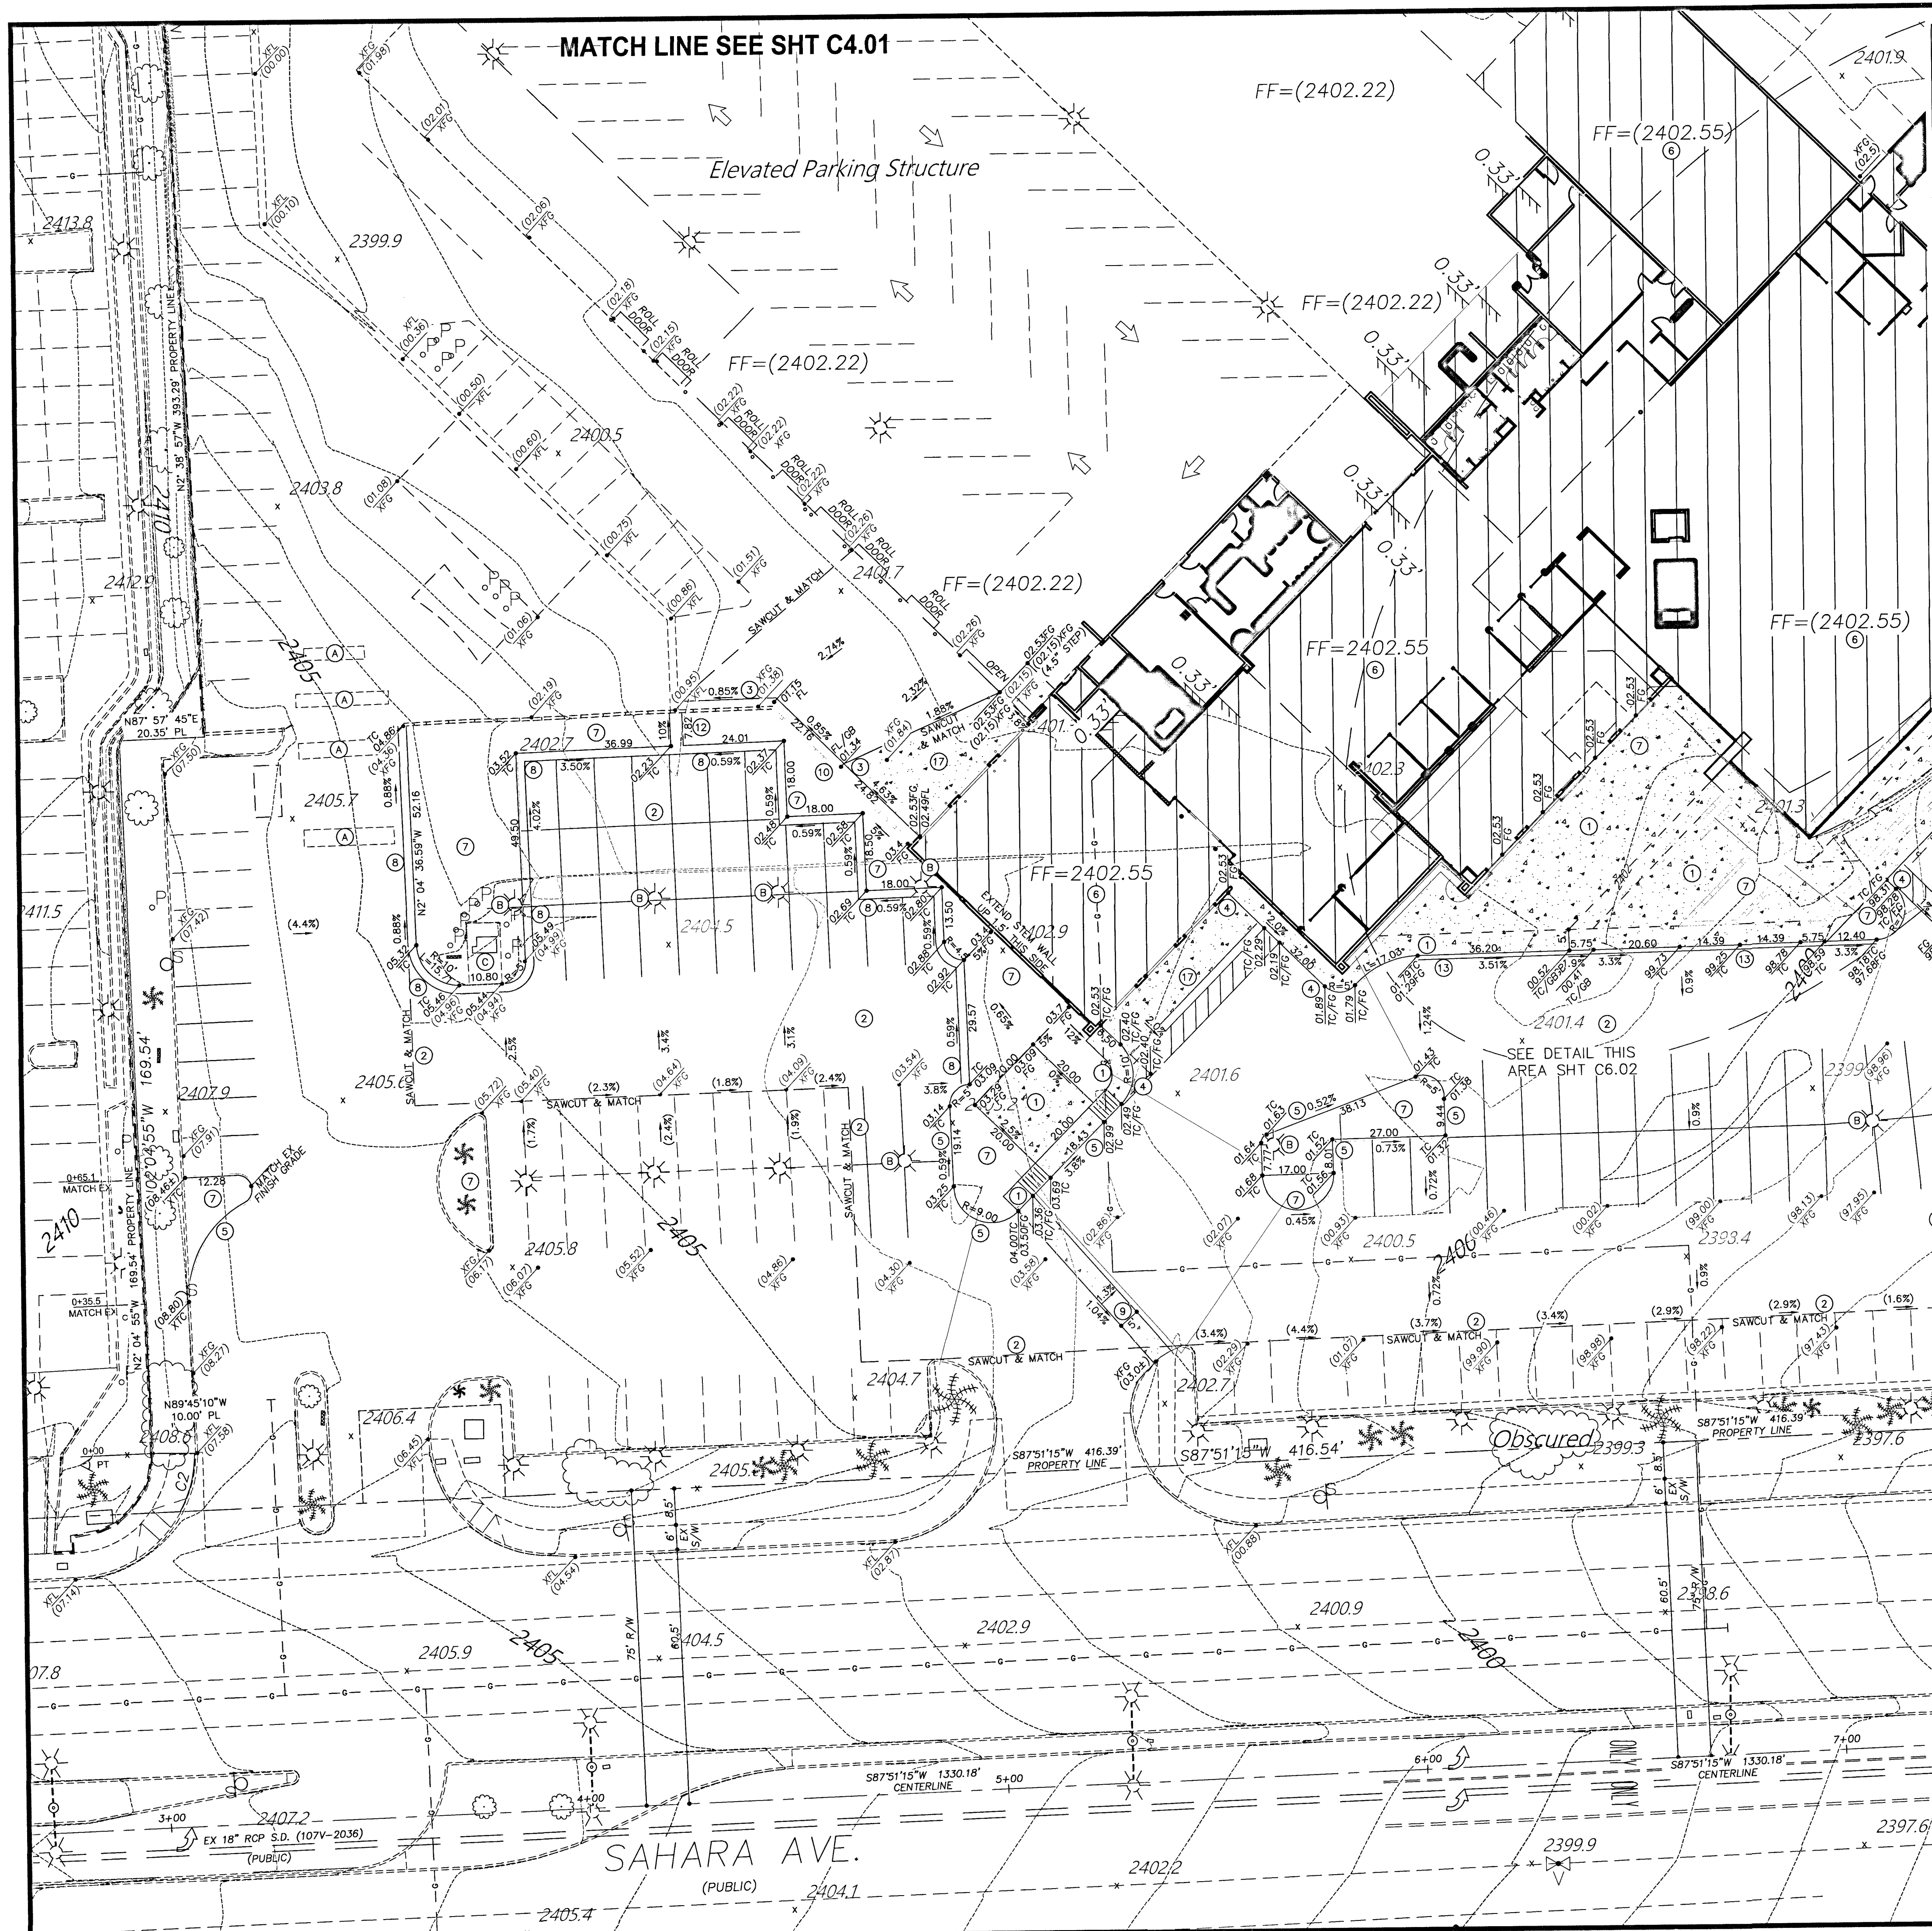

- CONSTRUCTION NOTES**
- CONSTRUCT CONCRETE SIDEWALK PER DETAIL #1, SHT C6.02-SEE FINISH PLAN PER ARCHITECTS PLANS & DETAILS
 - CONSTRUCT AC PAVEMENT PER DETAIL #2, SHT C6.02
 - CONSTRUCT 24" CONCRETE VALLEY GUTTER PER DETAIL #3, SHT C6.02
 - CONSTRUCT "A" TYPE CURB-0" FACE PER STD. DWG. #219
 - CONSTRUCT "A" TYPE CURB-6" FACE PER STD. DWG. #219
 - ROUGH GRADE PAD ELEV. IS ASSUMED TO BE 12" BELOW FINISH FLOOR ELEV. VERIFY W/ STRUCTURAL PLANS PRIOR TO ANY CONSTRUCTION.
 - PLANTER AREA
 - CONSTRUCT "L" TYPE CURB PER STD. DWG. #216
 - NOT USED
 - CONSTRUCT RETAINING WALL PER DETAIL #10 SHT C6.01
RETAINING WALL CALCS & DETAILS BY OTHERS
 - CONSTRUCT HANDICAP PARKING STALL PER DETAIL #11, SHT C6.01
 - DRAIN-THRU PER DETAIL #12 SHT C6.01
 - NDOT TYPE "3" CURB PER NDOT STD DWG #R-5.1.1 - 6" RISE
 - NOT USED
 - PROVIDE HANDRAILS PER ARCHITECTURAL DETAILS
 - 2% GRADE ALLOWED PER SOILS REPORT-SECTION: GRADING & DRAINAGE
 - CONSTRUCT CONCRETE PAVEMENT PER DETAIL #17, SHT C6.01
 - CAST IN PLACE WALL-SEE ARCHITECTURAL DETAILS
- (A) PROTECT EX LOOP DETECTORS IN PLACE
(B) PROTECT EX AREA LIGHT & CONCRETE BASE IN PLACE
(C) PROTECT EX ELECTRICAL TRANSFORMER IN PLACE

I CERTIFY THAT THIS GRADING PLAN IS IN CONFORMANCE WITH THE APPROVED DRAINAGE (#054963) ON FILE WITH THE CITY OF LAS VEGAS FOR THIS PROJECT.

SAM C. DUNNAM, P.E. No. 7886 DATE: 3/2018

BENCHMARK

CLARK CO. VERTICAL CONTROL V.2003 PT. "7C10 25WS 1997" (NAVD 88), RIVET & ROUND ALUM. PLATE IN TC, NE COR. OF RAINBOW & SAHARA, NEAR THE PC OF RAINBOW. ELEV.=2392.63 (US SURVEY FEET) = 729.274 (METERS) - INFORMATION PROVIDED BY COLLINS ENG. DATED 1/08/18.

ADD 2300.00 FEET TO ALL GRADES FOR TRUE MEAN SEA ELEVATION, EXCEPT FOR CONTOURS AND FINISH FLOOR ELEVATION

BASIS OF BEARING

S 02°39'07" E, BEING THE BEARING OF THE CENTERLINE OF RAINBOW & THE EAST LINE OF THE SE 1/4 OF THE SE 1/4 OF SEC. 3, T.21S., R.60E., M.D.M., CITY OF LAS VEGAS, CLARK CO., NV, AS SHOWN IN FILE 128 OF SURVEYS, PAGE 46.

GEOTECHNICAL REPORT

ALL GRADING SHALL CONFORM TO THE GEOTECHNICAL REPORT PREPARED BY McGETTIGAN CONSULTING, LLC, DATED 02/27/18, PROJECT NO. 1800701.

REFERENCE INFORMATION


APN 163-03-806-010
DEED 20160725-01560
PM FILE 123, PAGE 49

ZONING INFORMATION
GENERAL COMMERCIAL (C2)
PROJ-72340, SDR-72366, DS#4963, PMP#72875
WARD 1 - TARKANIAN

LEGAL DESCRIPTION
POR. GOVT LOTS 130, 131 & 132 WITHIN SE1/4 SE1/4 SEC. 3, T.21S., R.60E., CITY OF LAS VEGAS, CLARK CO., NV--R05 FILE 128, PAGE 46, #20030226-1042

FLOOD ZONE
UNSHADED ZONE "X", COMMUNITY MAP 32003 C 02165 D, DATED 11/16/2011
AN AREA DETERMINED TO BE OUTSIDE OF THE 0.2% ANNUAL CHANCE FLOOD PLAIN

MATCH LINE SEE SHT C4.04

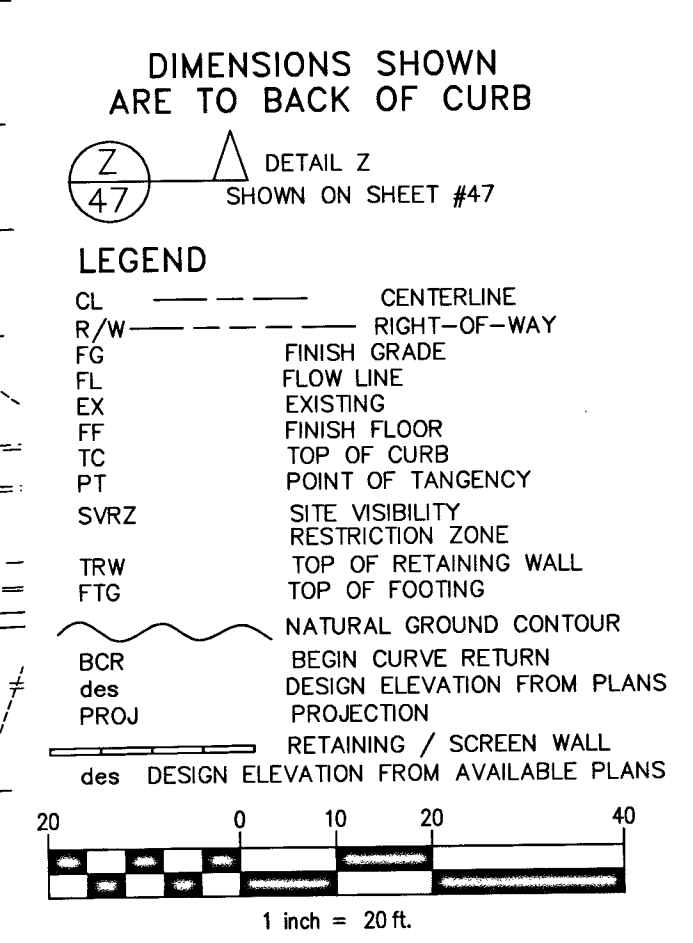

CLARK CO., NEVADA

BMW OF LAS VEGAS

GRADING PLAN 03

CITY OF LAS VEGAS

DATE: 3/2018

DRAFTER: JC

DESIGNER: SCD

CHECKED: SCD

PROJECT NO. 701326.00




PROFESSIONAL ENGINEER - STATE OF NEVADA

SAM C. DUNNAM
EXP. 12-31-18
No. 7886

C4.03

SHEET 13 OF 20

CLV # L18-00533

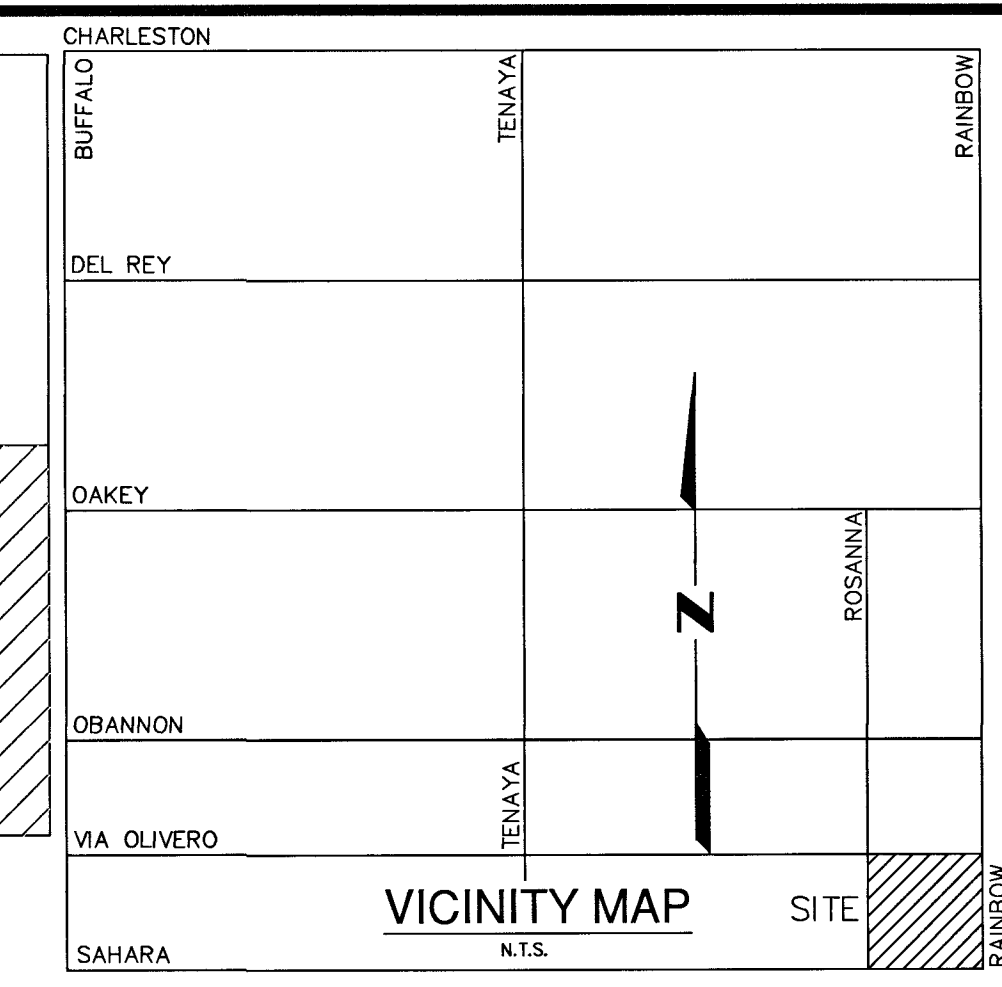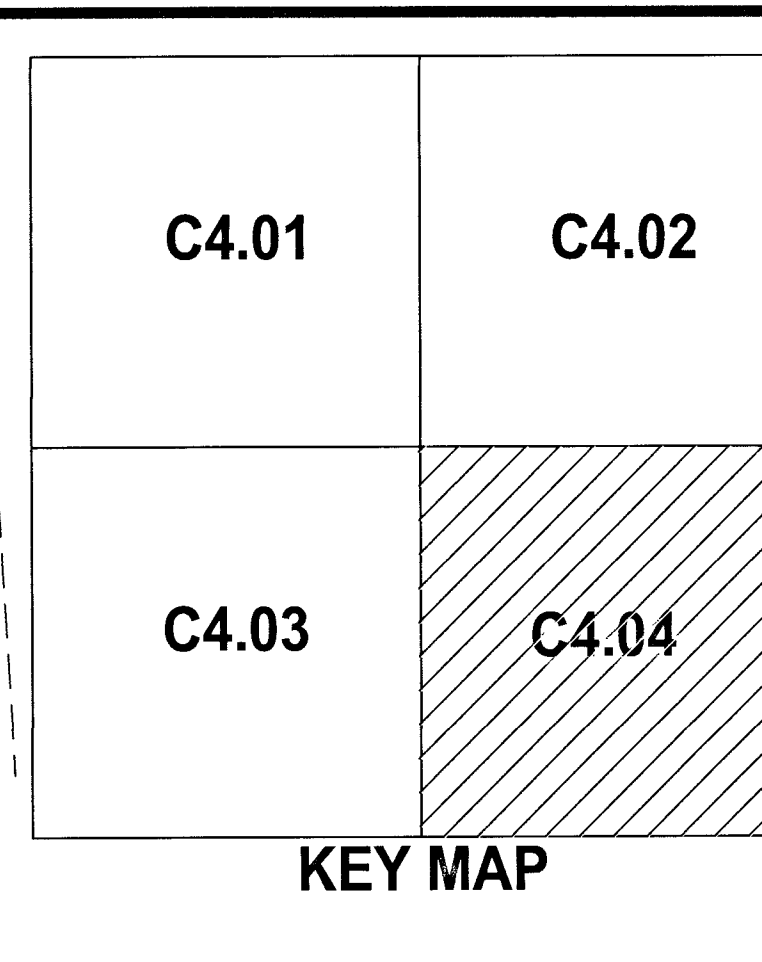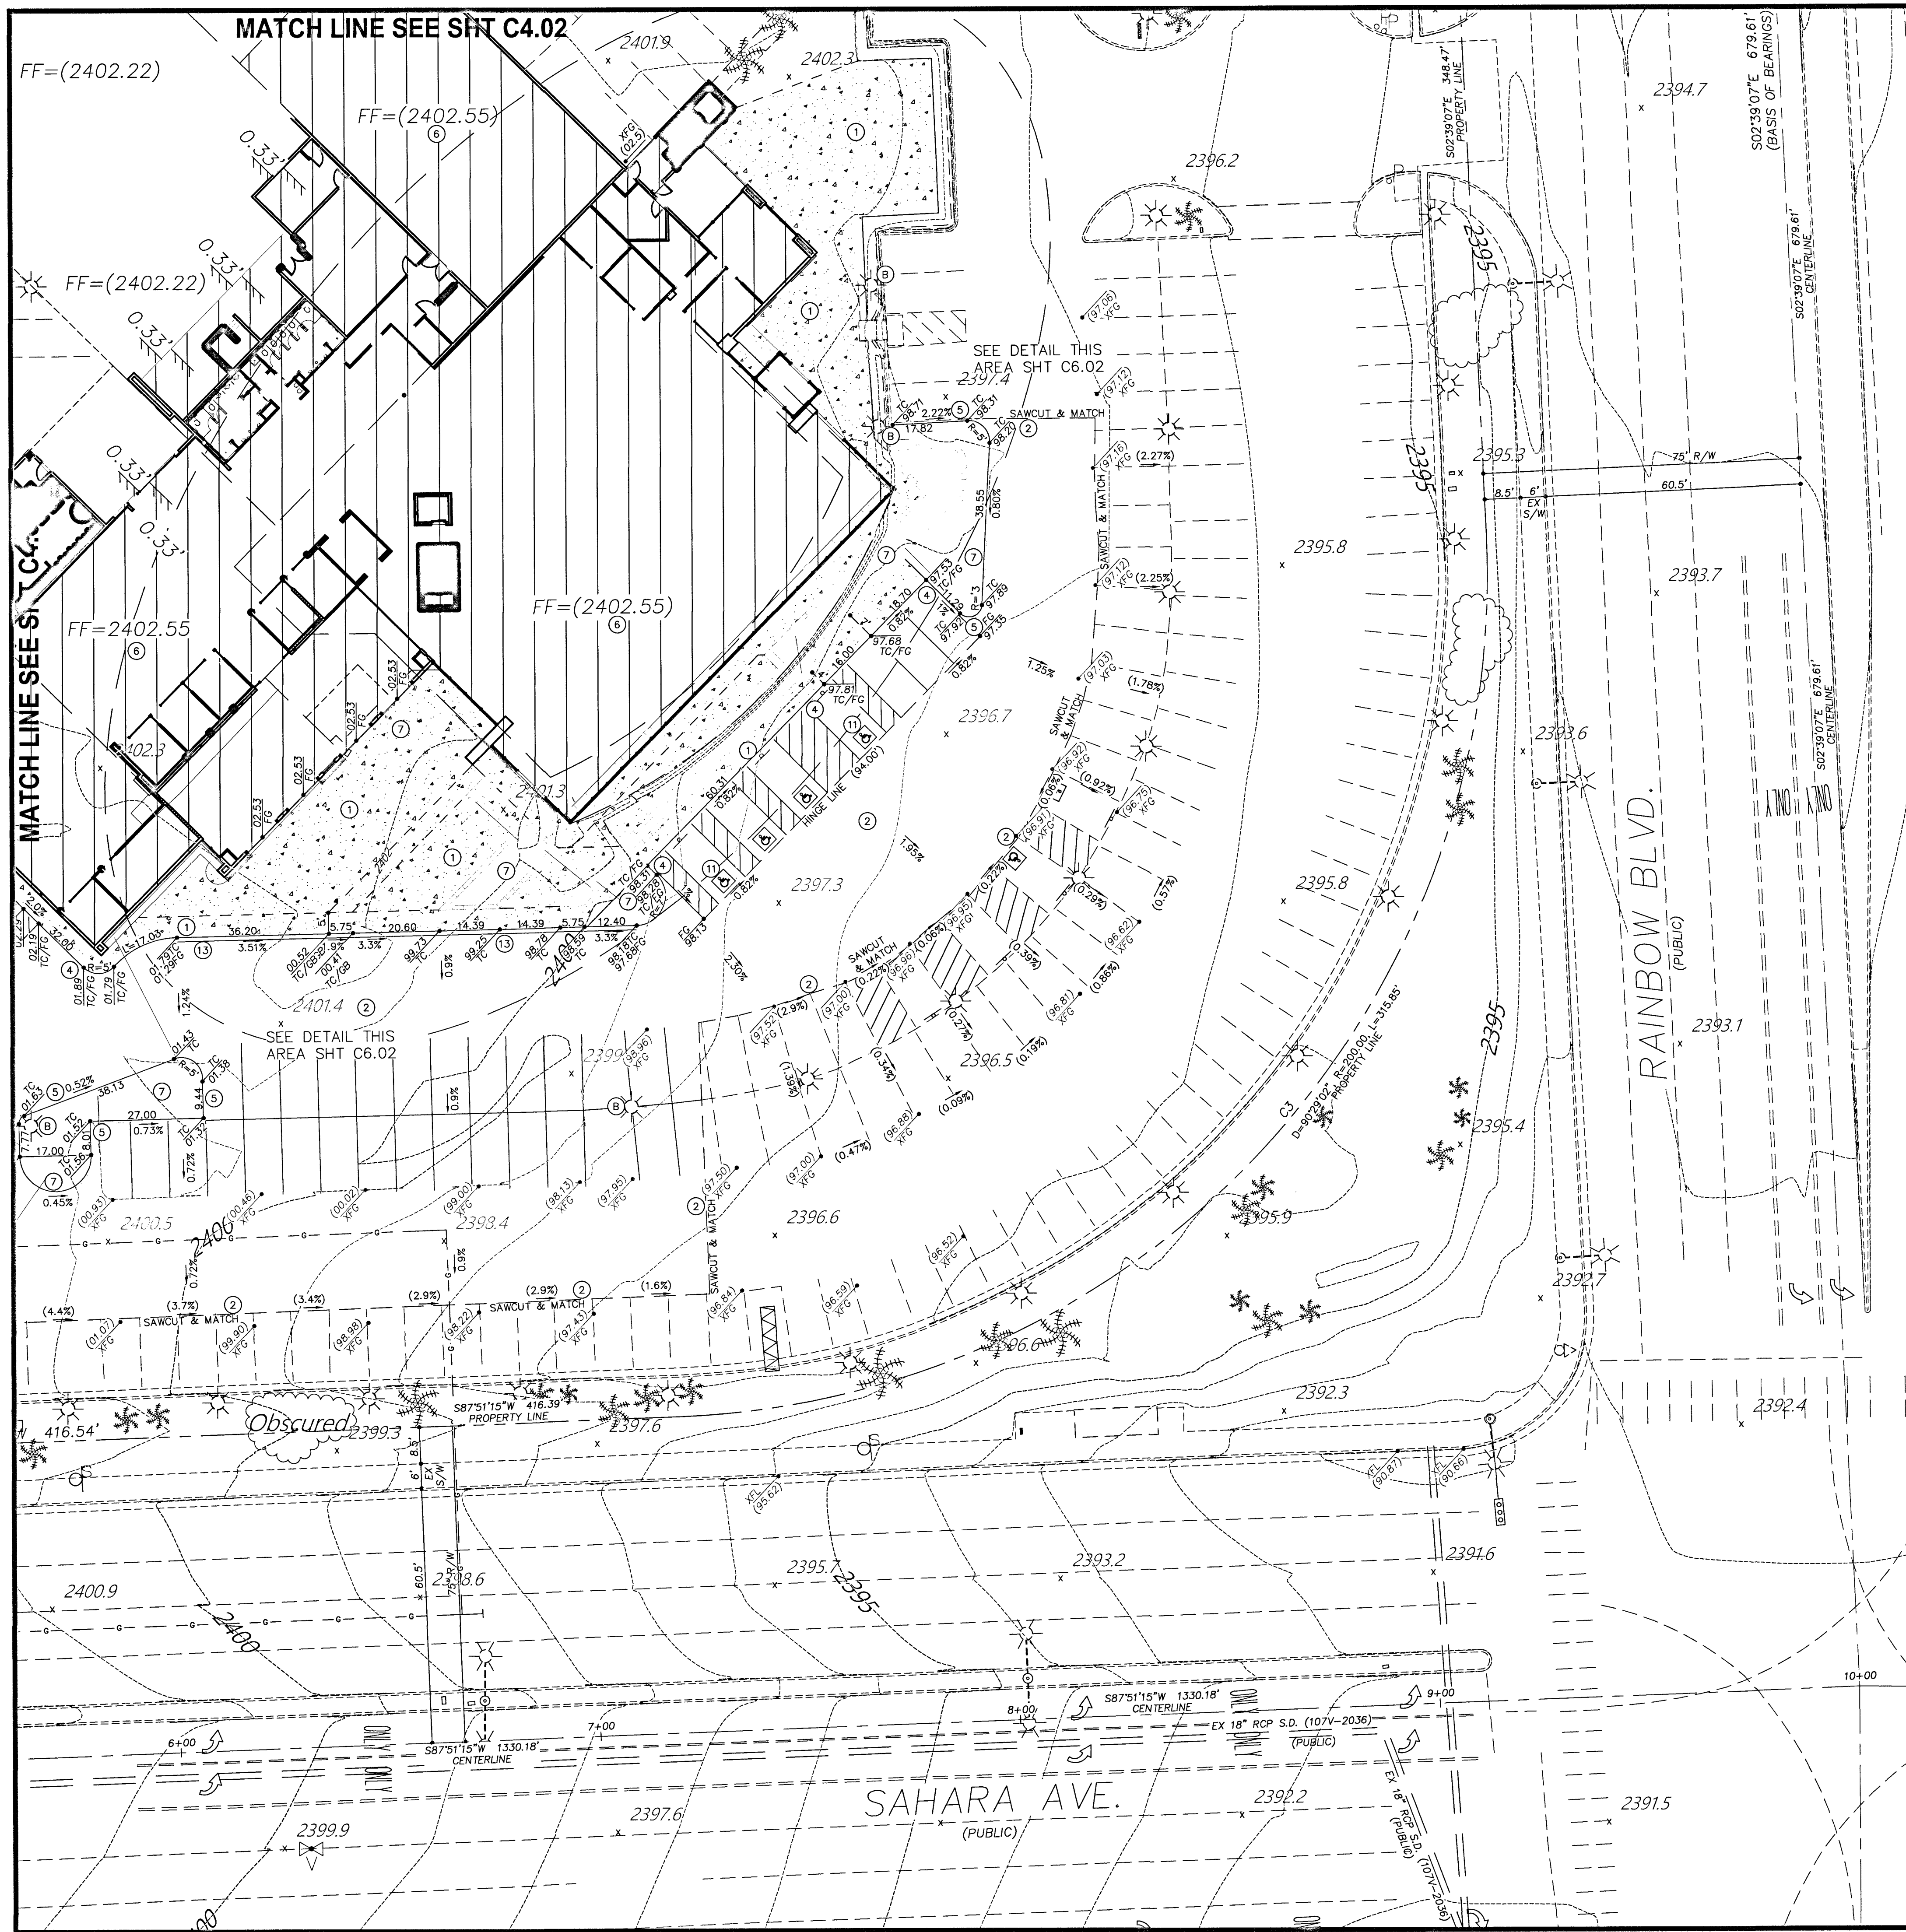

- CONSTRUCTION NOTES**
- 1. CONSTRUCT CONCRETE SIDEWALK PER DETAIL #1, SHT C6.02-SEE FINISH PLAN PER ARCHITECT'S PLANS & DETAILS
 - 2. CONSTRUCT AC PAVEMENT PER DETAIL #2, SHT C6.02
 - 3. CONSTRUCT 24" CONCRETE VALLEY GUTTER PER DETAIL #3, SHT C6.02
 - 4. CONSTRUCT "A" TYPE CURB-0" FACE PER STD. DWG. #219
 - 5. CONSTRUCT "A" TYPE CURB-6" FACE PER STD. DWG. #219
 - 6. ROUGH GRADE PAD ELEV. IS ASSUMED TO BE 12" BELOW FINISH FLOOR ELEV. VERIFY W/ STRUCTURAL PLANS PRIOR TO ANY CONSTRUCTION.
 - 7. PLANTER AREA
 - 8. CONSTRUCT "L" TYPE CURB PER STD. DWG. #216
 - 9. NOT USED
 - 10. CONSTRUCT RETAINING WALL PER DETAIL #10 SHT C6.01
 - 11. RETAINING WALL CALCS & DETAILS BY OTHERS
 - 12. CONSTRUCT HANDICAP PARKING STALL PER DETAIL #11, SHT C6.01
 - 13. DRAIN-THRU PER DETAIL #12 SHT C6.01
 - 14. NDOT TYPE "3" CURB PER NDOT STD DWG #R-5.1.1 - 6" RISE
 - 15. NOT USED
 - 16. PROVIDE HANDRAILS PER ARCHITECTURAL DETAILS
 - 17. 2% GRADE ALLOWED PER SOILS REPORT-SECTION: GRADING & DRAINAGE
 - 18. CONSTRUCT CONCRETE PAVEMENT PER DETAIL #17, SHT C6.01
 - 19. CAST IN PLACE WALL-SEE ARCHITECTURAL DETAILS
- (A) PROTECT EX LOOP DETECTORS IN PLACE
(B) PROTECT EX AREA LIGHT & CONCRETE BASE IN PLACE
(C) PROTECT EX ELECTRICAL TRANSFORMER IN PLACE

I CERTIFY THAT THIS GRADING PLAN IS IN CONFORMANCE WITH THE APPROVED DRAINAGE (#054963) ON FILE WITH THE CITY OF LAS VEGAS FOR THIS PROJECT.

SAM C. DUNHAM, P.E. No. 7886 DATE

BENCHMARK

CLARK CO. VERTICAL CONTROL V.2003 PT. "7C10 25WS 1997" (NAVD 88), RIVET & ROUND ALUM. PLATE IN TC, NE COR. OF RAINBOW & SAHARA, NEAR THE PC OF RAINBOW. ELEV.=2,392.63 (US SURVEY FEET) = 729.274 (METERS) - INFORMATION PROVIDED BY COLLINS ENG. DATED 1/08/18.

ADD 2300.00 FEET TO ALL GRADES FOR TRUE MEAN SEA ELEVATION, EXCEPT FOR CONTOURS AND FINISH FLOOR ELEVATION

BASIS OF BEARING

S 02°39'07" E, BEING THE BEARING OF THE CENTERLINE OF RAINBOW & THE EAST LINE OF THE SE 1/4 OF THE SE 1/4 OF SEC. 3, T.21S., R.60E., M.D.M., CITY OF LAS VEGAS, CLARK CO., NV, AS SHOWN IN FILE 128 OF SURVEYS, PAGE 46.

GEOTECHNICAL REPORT

ALL GRADING SHALL CONFORM TO THE GEOTECHNICAL REPORT PREPARED BY MCGITTIGAN CONSULTING, LLC, DATED 02/27/18, PROJECT NO. 1800701.


REFERENCE INFORMATION

APN 163-03-806-010
DEED 20160725-01560
PM FILE 123, PAGE 49

ZONING INFORMATION
GENERAL COMMERCIAL (C2)
PROJ-72340, SDR-72366, DS#4963, PMP#7875
WARD 1 - TARKANIAN

LEGAL DESCRIPTION
POR. GOVT LOTS 130, 131 & 132 WITHIN SE1/4 SEC. 3, T.21S., R.60E., CITY OF LAS VEGAS, CLARK CO. NV-ROS FILE 128, PAGE 46, #20030226-1042

FLOOD ZONE
UNSHADED ZONE "X", COMMUNITY MAP 32003 C 02165 D, DATED 11/16/2011
AN AREA DETERMINED TO BE OUTSIDE OF THE 0.2% ANNUAL CHANCE FLOOD PLAIN

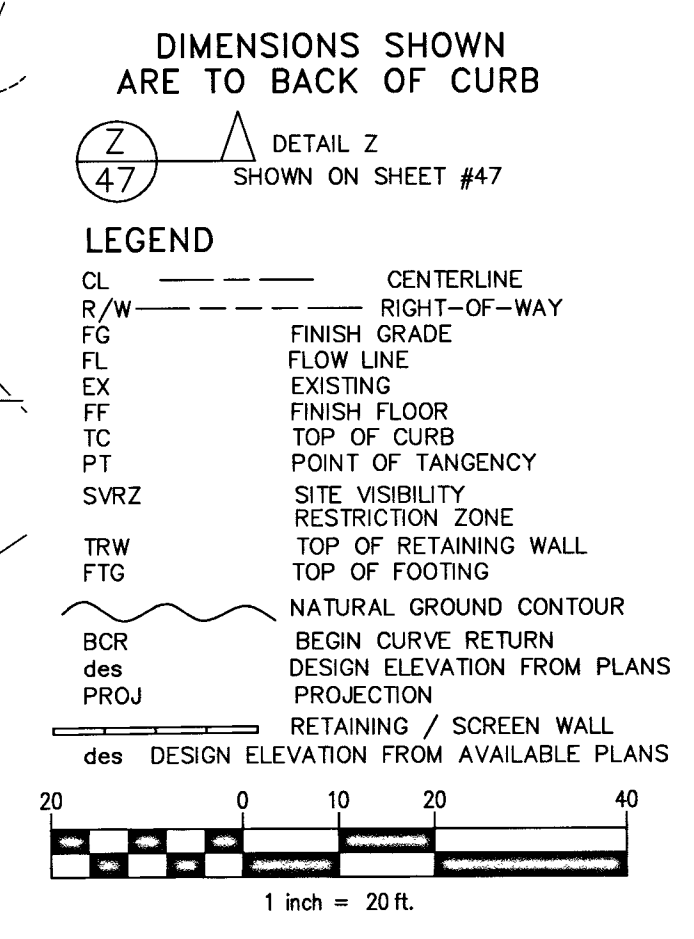

CLARK CO., NEVADA

BMW OF LAS VEGAS

GRADING PLAN 04

CITY OF LAS VEGAS




DATE: 3/2018
DRAFTER: JC
DESIGNER: SCJ
CHECKED: SCJ

PROJECT NO. 701326.00

C4.04

SHEET 14 OF 20
CLV # L18-00533

TY-LIN INTERNATIONAL
4031 DEAN MARTIN DR.
LAS VEGAS, NV 89103
P: 702-822-7100
F: 702-822-7105
WWW.TY-LIN.COM

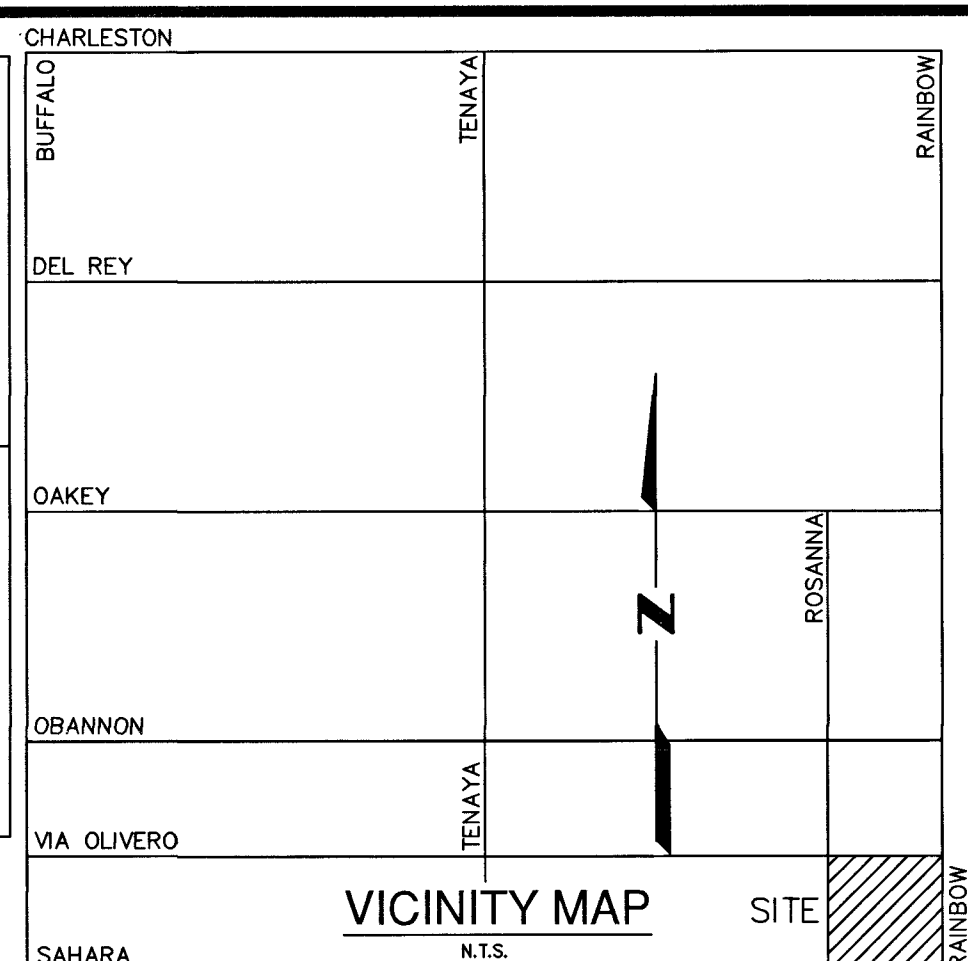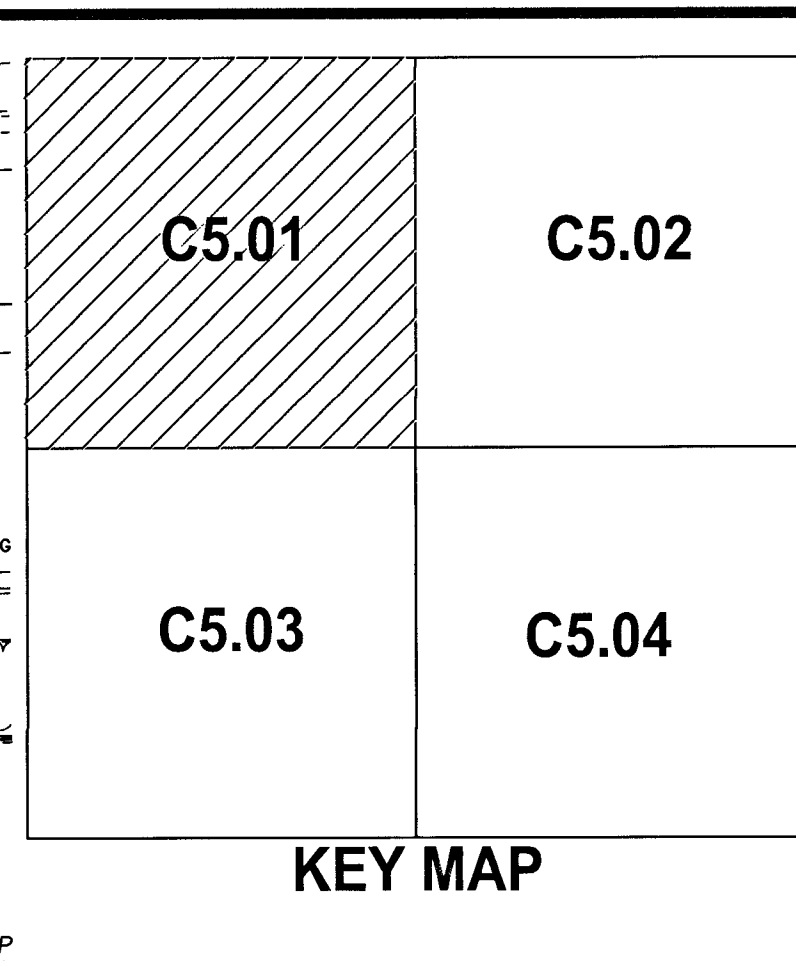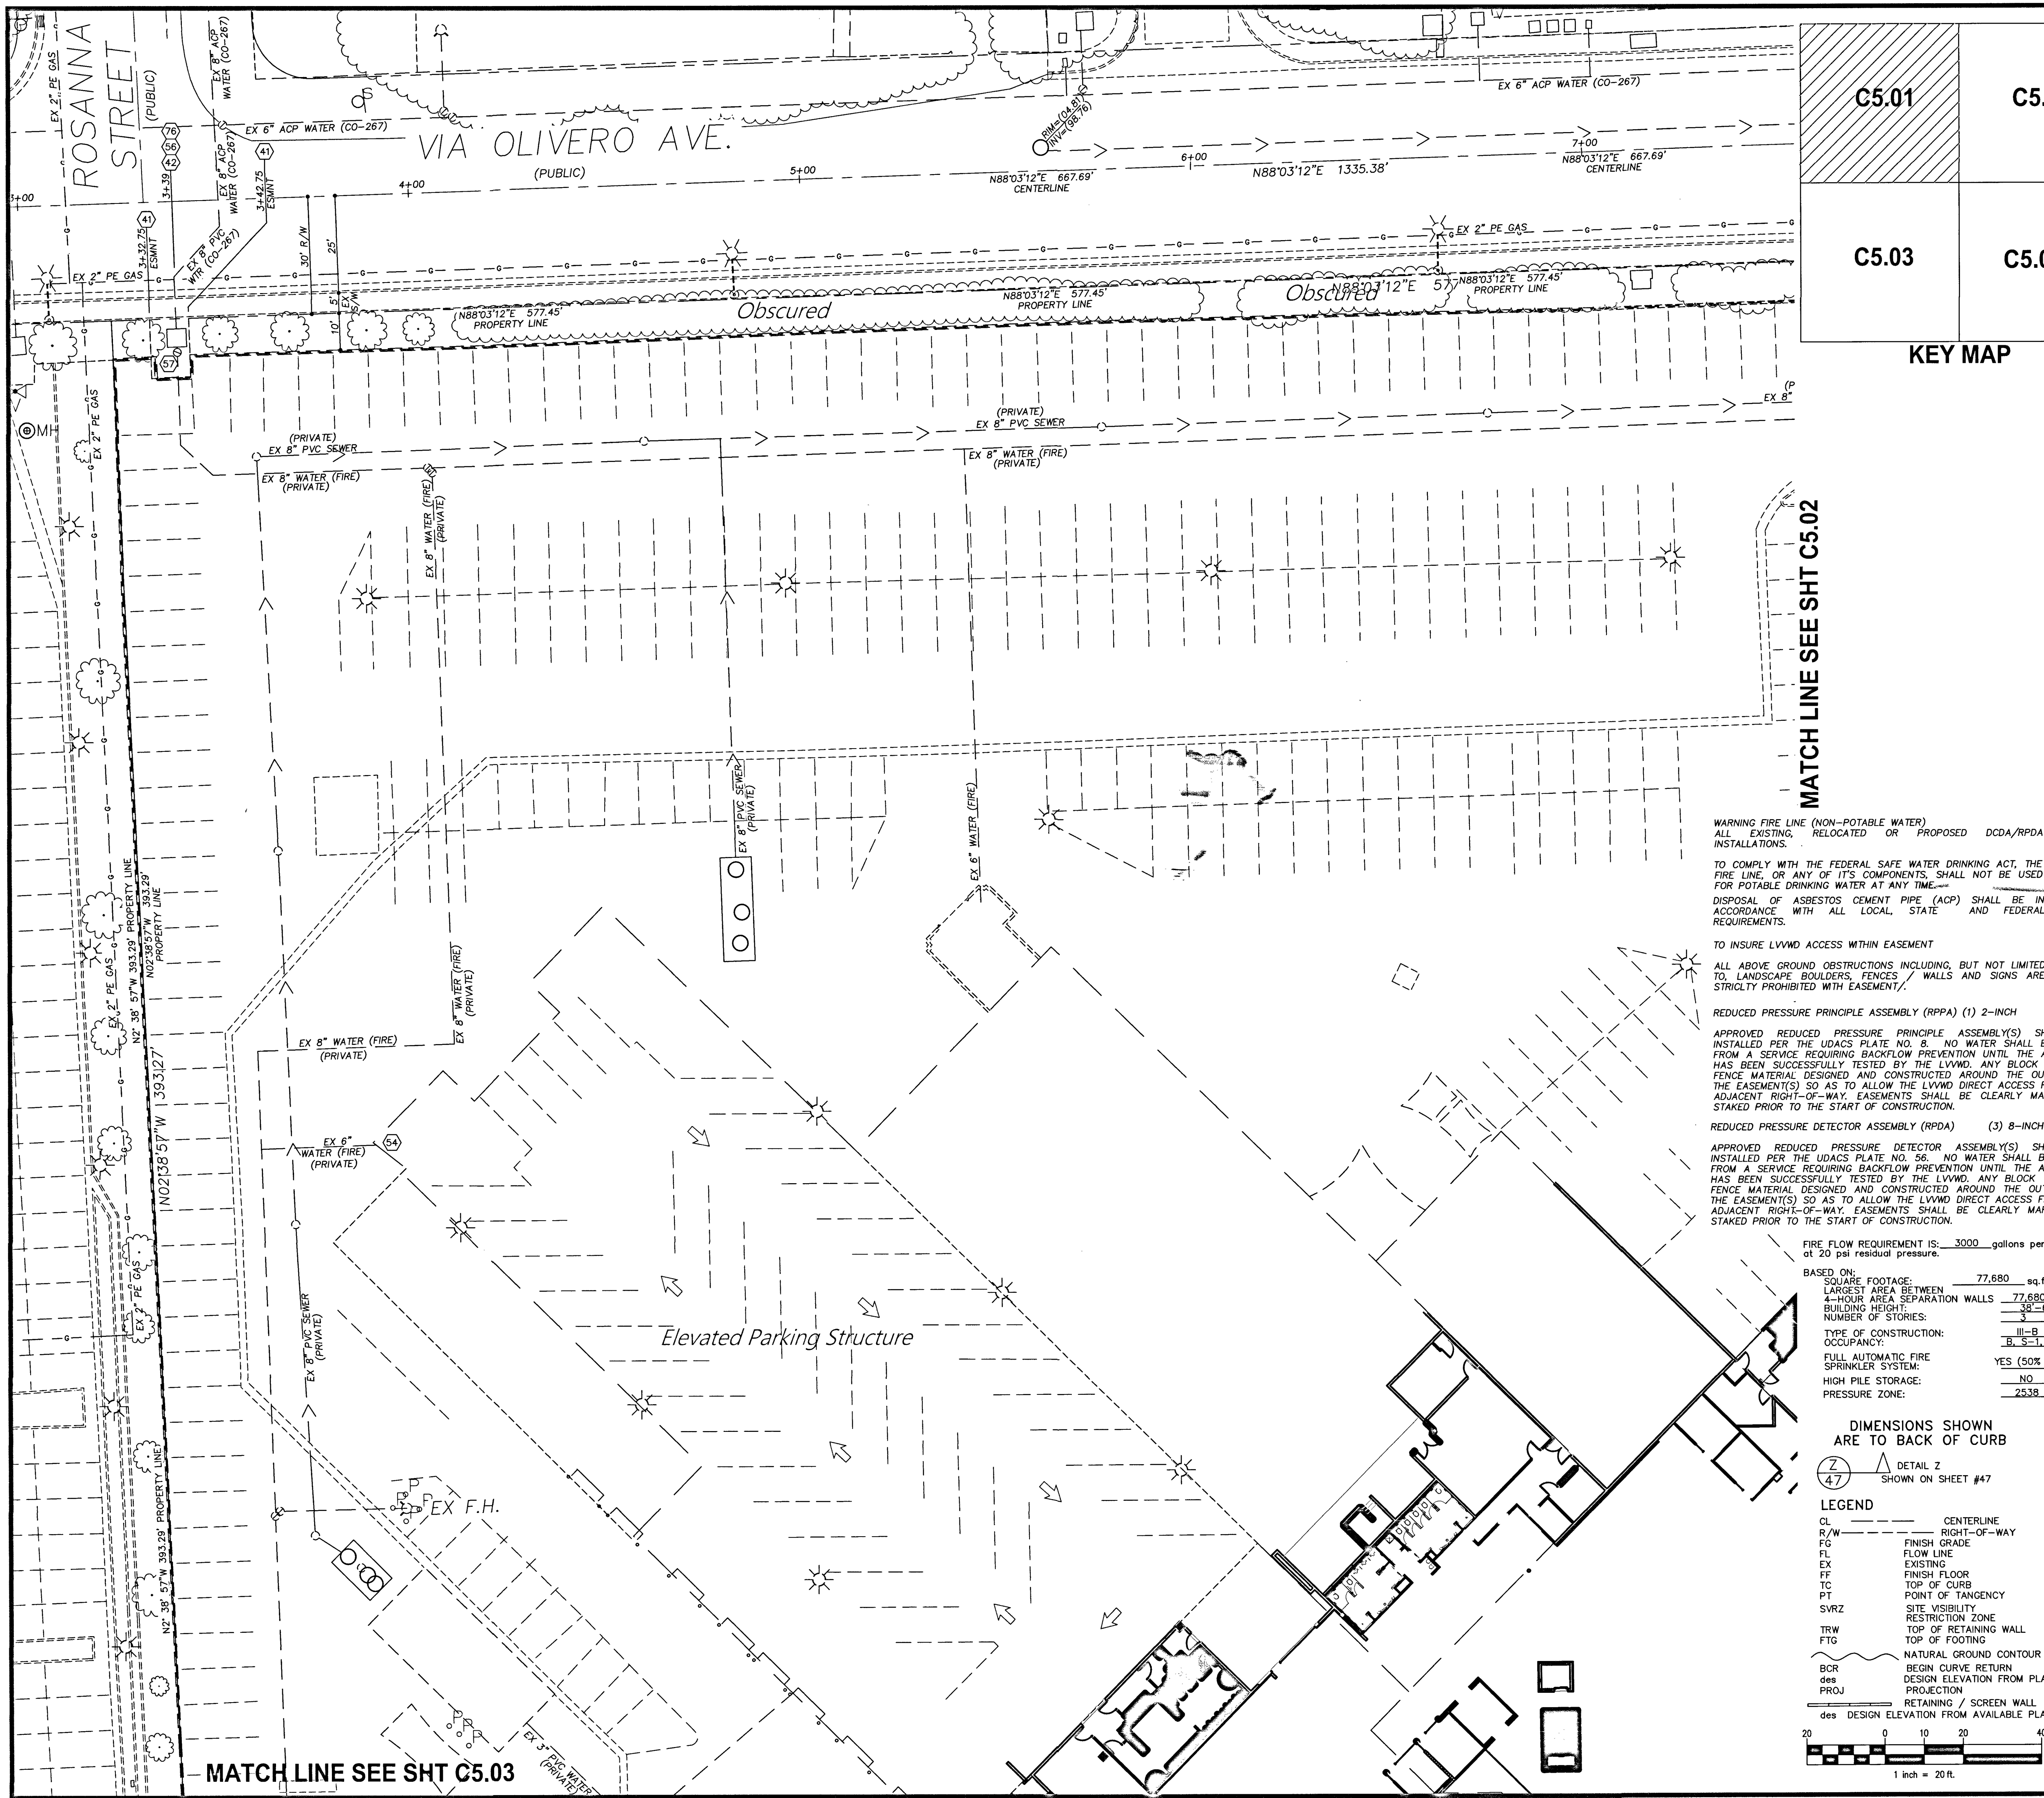

NO	WATER & UTILITY NOTES		
40	35' 55' LVWVD EASEMENT PER DOCUMENT 19941110:0001219	59	INSTALL 6" x 6" STAINLESS STEEL TAPPING SLEEVE & 6" TAPPING VALVE PER UDACS PLATES 30, 34 & 39
41	10' x 15' LVWVD EASEMENT PER DOCUMENT 19941110:0001220	60	NOT USED
42	EX 8" DODA - WILKINS SERIAL #0589523 - ACCOUNT #583051	61	INSTALL 8" TEE & 8" GATE VALVE PER UDACS PLATES #31 & #39
43	EX 8" DODA - AMES SERIAL #026357 - ACCOUNT #583050	62	INSTALL 45° BEND PER UDACS PLATE #31 - SIZE PER PLAN
44	EX 2" WATER METER & RPPA - ACCOUNT #583049	63	INSTALL 8" x 6" REDUCER PER UDACS PLATES #30
45	CUT IN 8" 90° BEND W/ 8" GATE VALVE PER UDACS PLATES #31 & #39	64	INSTALL 6" TRANSITION COUPLING PER UDACS PLATES #30
46	INSTALL PVC WATER MAIN W/TRENCH BACKFILL PER UDACS PLATE #17 - LENGTH PER PLAN	65	REMOVE & REPLACE EX "L" CURB & SIDEWALK PER STD DWG'S #216 & #254
47	INSTALL 8" x 6" TEE & 6" GATE VALVE PER UDACS PLATE #31 & #39. CONNECT TO EX. 6" PVC FIRE HYDRANT LATERAL	66	INSTALL 8" RPPA PER UDACS PLATES #56 & 8" GATE VALVE PER UDACS PLATE #30 & #39
48	REMOVE EX. PVC WATER MAIN (OMIT NEAR AREA LIGHT IF REQUIRED)	67	INSTALL 90° BEND PER UDACS PLATE #31 - SIZE PER PLAN
49	INSTALL 6" DUCTILE IRON PIPE SLEEVE - LENGTH PER PLAN	68	INSTALL 8" x 6" STAINLESS STEEL TAPPING SLEEVE & 6" TAPPING VALVE PER UDACS PLATES 30, 34 & 39
50	CONNECT TO EX" PVC WATER	69	AC PAVEMENT PATCH PER STD DWG #500.1
51	3" PVC 90° BEND	70	INSTALL 8" x 2" SERVICE SADDLE, 2" COPPER (CU) LATERAL & 2" WATER METER PER UDACS PLATE #4
52	3" PVC 45° BEND	71	BRASS WATER LINE REQUIRED BETWEEN METER & RPPA PER UDACS PLATE #4
53	3" x 3" PVC TEE	72	INSTALL 2" RPPA PER UDACS PLATE #9 W/CURB STOP PER DETAIL #72, SHT C6.01
54	EX BUILDING MOUNTED FIRE DEPT. CONNECTION (FDC)	73	CONNECT TO EX. 3" PVC WATER LINE
55	INSTALL 2" BALL ANGLE METER STOP & TAIL PIECE IN METER BOX PER UDACS PLATE 4 - NO WATER METER (PRIVATE)	74	4" SCH 40 PVC BLANK CONDUIT FOR IRRIGATION USE-LENGTH PER PLAN
56	REMOVE EX DODA & INSTALL 8" RPPA W/ NEW VALVE SETTER PER UDACS PLATE #56. REQUIRES NEW CONCRETE PAD & PIPING	75	RELOCATE EX F.H. TO 4.0 B/C AS SHOWN PER UDACS PLATE #40 & DETAIL #70, SHT C6.01 - REMOVE EX PVC WATER BEYOND F.H.
57	CUT IN 8" GATE VALVE PER UDACS PLATES #30 & #39	76	CONTRACTORS OPTION: KEEP EX VALVE SETTER & INSTALL LVWVD APPROVED 8" RPPA ON EX ASSEMBLY PER UDACS PLATE #56
58	15'(W) x 20' LVWVD EASEMENT PER DOCUMENT 20180908:0001221	77	34'(W) x 22' LVWVD EASEMENT PER DOCUMENT 2018

ALL BE
BE TAKEN
ASSEMBLY
SIDE OF

WARNING FIRE LINE (NON-POTABLE WATER)
ALL EXISTING, RELOCATED OR PROPOSED DCDA/RPPA INSTALLATIONS.

TO COMPLY WITH THE FEDERAL SAFE WATER DRINKING ACT, THE FIRE LINE, OR ANY OF ITS COMPONENTS, SHALL NOT BE USED FOR POTABLE DRINKING WATER AT ANY TIME.

DISPOSAL OF ASBESTOS CEMENT PIPE (ACP) SHALL BE IN ACCORDANCE WITH ALL LOCAL, STATE AND FEDERAL REQUIREMENTS.

TO INSURE LVWD ACCESS WITHIN EASEMENT

ALL ABOVE GROUND OBSTRUCTIONS INCLUDING, BUT NOT LIMITED TO, LANDSCAPE BOULDERS, FENCES / WALLS AND SIGNS ARE STRICTLY PROHIBITED WITH EASEMENT/.

REDUCED PRESSURE PRINCIPLE ASSEMBLY (RPPA) (1) 2-INCH

APPROVED REDUCED PRESSURE PRINCIPLE ASSEMBLY(S) SHALL BE INSTALLED PER THE UDACS PLATE NO. 8. NO WATER SHALL BE TAKEN FROM A SERVICE REQUIRING BACKFLOW PREVENTION UNTIL THE ASSEMBLY HAS BEEN SUCCESSFULLY TESTED BY THE LVWD. ANY BLOCK WALL OR FENCE MATERIAL DESIGNED AND CONSTRUCTED AROUND THE OUTSIDE OF THE EASEMENT(S) SO AS TO ALLOW THE LVWD DIRECT ACCESS FROM THE ADJACENT RIGHT-OF-WAY. EASEMENTS SHALL BE CLEARLY MARKED OR STAKED PRIOR TO THE START OF CONSTRUCTION.

REDUCED PRESSURE DETECTOR ASSEMBLY (RPDA) (3) 8-INCH

APPROVED REDUCED PRESSURE DETECTOR ASSEMBLY(S) SHALL BE INSTALLED PER THE UDACS PLATE NO. 56. NO WATER SHALL BE TAKEN FROM A SERVICE REQUIRING BACKFLOW PREVENTION UNTIL THE ASSEMBLY HAS BEEN SUCCESSFULLY TESTED BY THE LVWD. ANY BLOCK WALL OR FENCE MATERIAL DESIGNED AND CONSTRUCTED AROUND THE OUTSIDE OF THE EASEMENT(S) SO AS TO ALLOW THE LVWD DIRECT ACCESS FROM THE ADJACENT RIGHT-OF-WAY. EASEMENTS SHALL BE CLEARLY MARKED OR STAKED PRIOR TO THE START OF CONSTRUCTION.

FIRE FLOW REQUIREMENT IS: 3000 gallons per minute at 20 psi residual pressure.

BASED ON:

SQUARE FOOTAGE:	77,680 sq.ft.
LARGEST AREA BETWEEN 4-HOUR AREA SEPARATION WALLS:	77,680 sq.ft.
BUILDING HEIGHT:	3
NUMBER OF STORIES:	3
TYPE OF CONSTRUCTION:	III-B
OCCUPANCY:	B-S-1, S-2
FULL AUTOMATIC FIRE SPRINKLER SYSTEM:	YES (50% REDUCTION)
HIGH PILE STORAGE:	NO
PRESSURE ZONE:	2538

DIMENSIONS SHOWN ARE TO BACK OF CURB

LEGEND

CL	CENTERLINE
R/W	RIGHT-OF-WAY
FG	FINISH GRADE
FL	FLOW LINE
EX	EXISTING
FF	FINISH FLOOR
TC	TOP OF CURB
PT	POINT OF TANGENCY
SVRZ	SITE VISIBILITY RESTRICTION ZONE
TRW	TOP OF RETAINING WALL
FTG	TOP OF FOOTING
BCR	NATURAL GROUND CONTOUR
des	DESIGN ELEVATION FROM PLANS
PROJ	PROJECTION
des	DESIGN ELEVATION FROM AVAILABLE PLANS

1 inch = 20 ft.

CITY OF LAS VEGAS FIRE DEPT.

8/20/18

DATE

SOUTHWEST GAS CORPORATION

DATE

APPROVED FOR CONSTRUCTION

DATE

CLARK CO. VERTICAL CONTROL V.2003 PT. "7C10 25WS 1997" (NAVD 88), RIVET & ROUND ALUM. PLATE IN TC, NE COR. OF RAINBOW & SAHARA, NEAR THE PC OF RAINBOW. ELEV.=2,392.63 (US SURVEY FEET) = 729.274 (METERS) - INFORMATION PROVIDED BY COLLINS ENG. DATED 1/08/18.

ADD 2300.00 FEET TO ALL GRADES FOR TRUE MEAN SEA ELEVATION, EXCEPT FOR CONTOURS AND FINISH FLOOR ELEVATION

BENCHMARK

BASIS OF BEARING

S 02°39'07" E, BEING THE BEARING OF THE CENTERLINE OF RAINBOW & THE EAST LINE OF THE SE 1/4 OF THE SE 1/4 OF SEC. 3, T.21S., R.60E., M.D.M., CITY OF LAS VEGAS, CLARK CO., NV, AS SHOWN IN FILE 128 OF SURVEYS, PAGE 46.

GEOTECHNICAL REPORT

ALL GRADING SHALL CONFORM TO THE GEOTECHNICAL REPORT PREPARED BY McGETTING CONSULTING, LLC, DATED 02/27/18, PROJECT NO. 1800701.

REFERENCE INFORMATION

APN 163-03-806-010
DEED 20160725:01560
PM FILE 123, PAGE 49

ZONING INFORMATION
GENERAL COMMERCIAL (C2)
PROJ-72340, SDR-72366, DS#4963, PMP#72875
WARD 1 - TARKANIAN

LEGAL DESCRIPTION
POR. GOVT LOTS 130, 131 & 132 WITHIN SE1/4 SE1/4 SEC. 3, T.21S., R.60E., CITY OF LAS VEGAS, CLARK CO., NV.-ROS FILE 128, PAGE 46, #20030228-1042

FLOOD ZONE
UNSHADED ZONE "X", COMMUNITY MAP 32003 C 02165 D, DATED 11/16/2011
AN AREA DETERMINED TO BE OUTSIDE OF THE 0.2% ANNUAL CHANCE FLOOD PLAN

107V7427

CLARK CO., NEVADA

DATE

BY

DESCRIPTION

NO.

TRAILIN INTERNATIONAL

4031 DEAN MARTIN DR.
LAS VEGAS, NV 89103
P: 702-522-7100
F: 702-522-7105
WWW.TI.COM

BMW OF LAS VEGAS

UTILITY PLAN 01

CITY OF LAS VEGAS

DATE: 3/2018

DRAFTER: JC

DESIGNER: SCD

CHECKED: SCD

PROJECT NO. 701326.00

PROFESSIONAL ENGINEER STATE OF NEVADA

SAM C. DUNNAN

EXP. 12-31-18

CIVIL


107V7427

C5.01

SHEET 15 OF 20

CLV # L18-00533

PROJ# 126375-A QS-163-03-SE

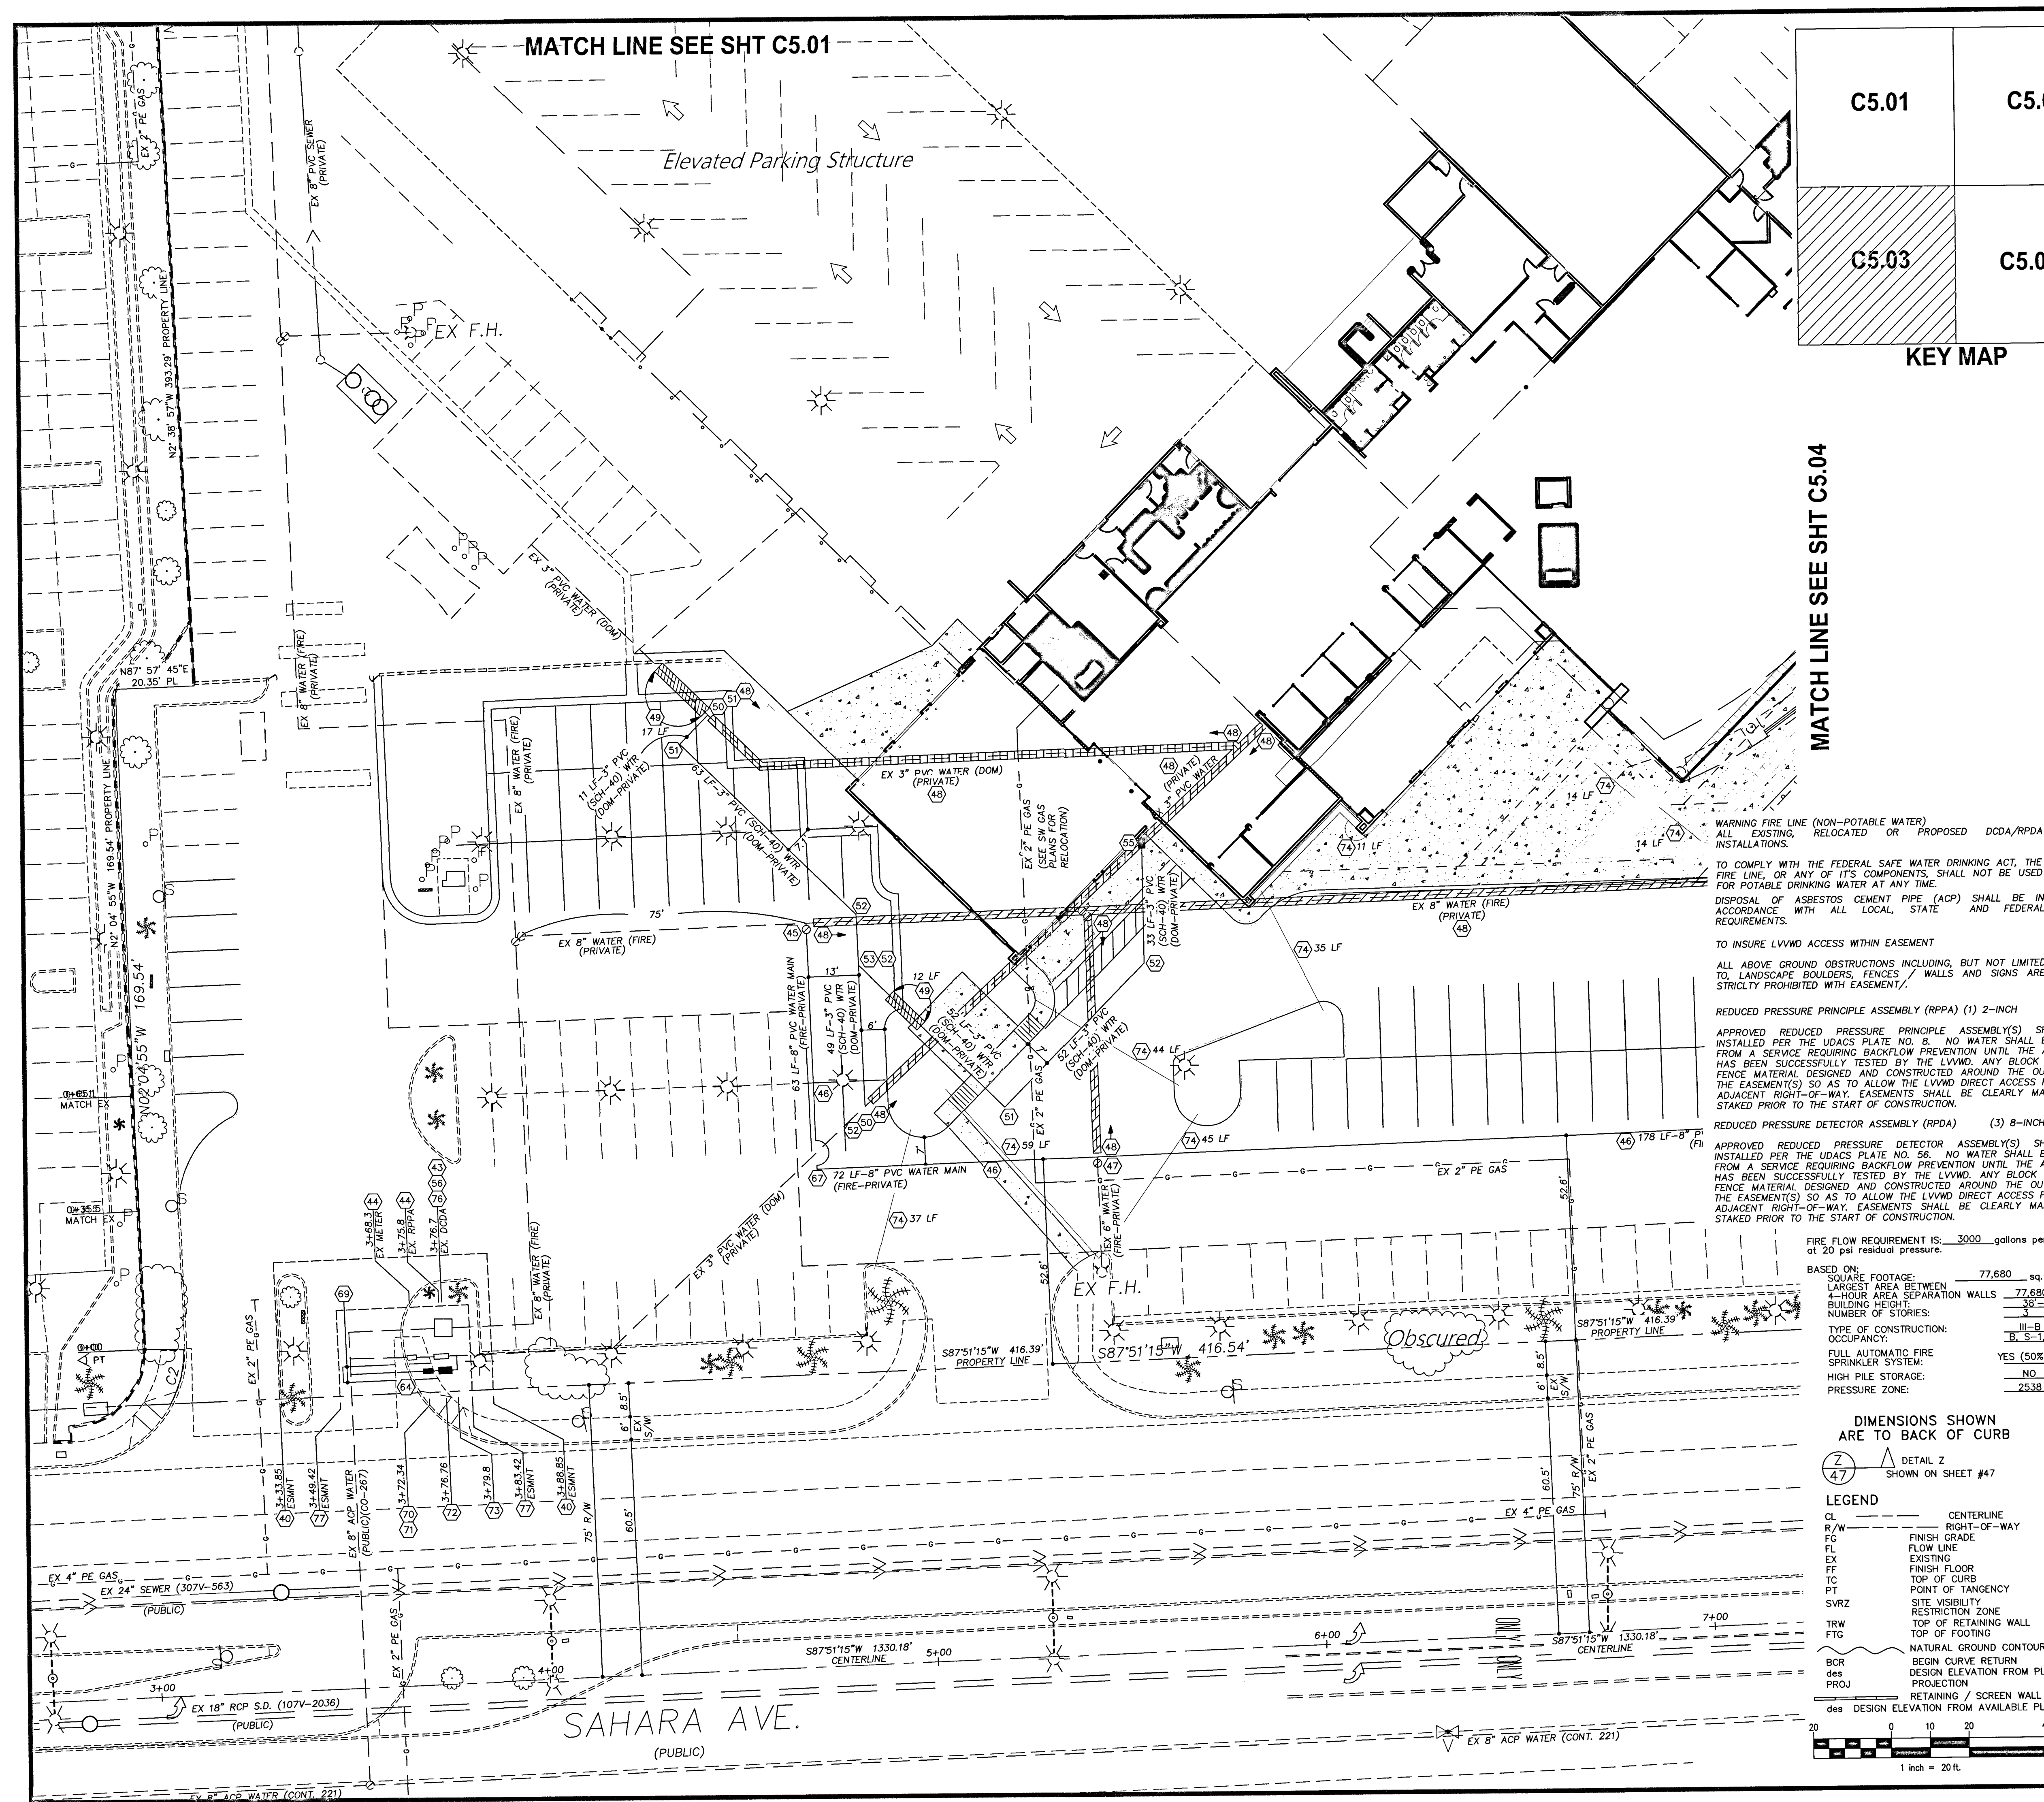

MATCH LINE SEE SHT C5.04


MATCH LINE SEE SHT C5.01

Elevated Parking Structure

SAHARA AVE.
(PUBLIC)

WARNING FIRE LINE (NON-POTABLE WATER)
ALL EXISTING, RELOCATED OR PROPOSED DCDA/RPDA
INSTALLATIONS.
TO COMPLY WITH THE FEDERAL SAFE WATER DRINKING ACT, THE
FIRE LINE, OR ANY OF ITS COMPONENTS, SHALL NOT BE USED
FOR POTABLE DRINKING WATER AT ANY TIME.
DISPOSAL OF ASBESTOS CEMENT PIPE (ACP) SHALL BE IN
ACCORDANCE WITH ALL LOCAL, STATE AND FEDERAL
REQUIREMENTS.
TO INSURE LVVMD ACCESS WITHIN EASEMENT
ALL ABOVE GROUND OBSTRUCTIONS INCLUDING, BUT NOT LIMITED
TO, LANDSCAPE BOLLARDS, FENCES / WALLS AND SIGNS ARE
STRICTLY PROHIBITED WITHIN EASEMENT.
REDUCED PRESSURE PRINCIPLE ASSEMBLY (RPDA) (1) 2-INCH
APPROVED REDUCED PRESSURE PRINCIPLE ASSEMBLY(S) SHALL BE
INSTALLED PER THE UDACS PLATE NO. 8. NO WATER SHALL BE TAKEN
FROM A SERVICE REQUIRING BACKFLOW PREVENTION UNTIL THE ASSEMBLY
HAS BEEN SUCCESSFULLY TESTED BY THE LVVMD. ANY BLOCK WALL OR
FENCE MATERIAL DESIGNED AND CONSTRUCTED AROUND THE OUTSIDE OF
THE EASEMENT(S) SO AS TO ALLOW THE LVVMD DIRECT ACCESS FROM THE
ADJACENT RIGHT-OF-WAY. EASEMENTS SHALL BE CLEARLY MARKED OR
STAKED PRIOR TO THE START OF CONSTRUCTION.
REDUCED PRESSURE DETECTOR ASSEMBLY (RPDA) (3) 8-INCH
APPROVED REDUCED PRESSURE DETECTOR ASSEMBLY(S) SHALL BE
INSTALLED PER THE UDACS PLATE NO. 56. NO WATER SHALL BE TAKEN
FROM A SERVICE REQUIRING BACKFLOW PREVENTION UNTIL THE ASSEMBLY
HAS BEEN SUCCESSFULLY TESTED BY THE LVVMD. ANY BLOCK WALL OR
FENCE MATERIAL DESIGNED AND CONSTRUCTED AROUND THE OUTSIDE OF
THE EASEMENT(S) SO AS TO ALLOW THE LVVMD DIRECT ACCESS FROM THE
ADJACENT RIGHT-OF-WAY. EASEMENTS SHALL BE CLEARLY MARKED OR
STAKED PRIOR TO THE START OF CONSTRUCTION.
FIRE FLOW REQUIREMENT IS: 3000 gallons per minute
at 0.1 psi residual pressure.
BASED ON:
SQUARE FOOTAGE: 77,680 sq. ft.
LARGEST AREA BETWEEN
SEPARATION WALLS: 77,680 sq. ft.
BUILDING HEIGHT: 38'-6"
NUMBER OF STORIES: 3
TYPE OF CONSTRUCTION: III-B
OCCUPANCY: B.S.-1, S-2
FULL AUTOMATIC FIRE
SPRINKLER SYSTEM: YES (50% REDUCTION)
HIGH PILE STORAGE: NO
PRESSURE ZONE: 2538
DIMENSIONS SHOWN
ARE TO BACK OF CURB
LEGEND
CL CENTERLINE
R/W RIGHT-OF-WAY
FG FINISH GRADE
EX EXISTING
FF FINISH FLOOR
TC TOP OF CURB
PT POINT OF TANGENCY
SVRZ SITE VISIBILITY
RESTRICTION ZONE
TRW TOP OF RETAINING WALL
FTG TOP OF FOOTING
NATURAL GROUND CONTOUR
BCR BEGIN CURVE RETURN
DESIGN ELEVATION FROM PLANS
PROJ PROJECTION
RETAINING / SCREEN WALL
des DESIGN ELEVATION FROM AVAILABLE PLANS
1 inch = 20 ft.

APPROVED FOR CONSTRUCTION
LAS VEGAS VALLEY WATER DISTRICT ENGINEERING SERVICES
PROJECT NO. 126375 FIRST APPROVED DATE: 8/21/18
LVVMD APPROVED FIRE FLOW: TOTAL = 3000 GPM / ONSITE = 3000 GPM
BENCHMARK
CLARK CO. VERTICAL CONTROL V.2003 PT. "7C10 2SWS 1997" (NAVD 88),
RIVET & ROUND ALUM. PLATE IN TO: NE COR. OF RAINBOW & SAHARA,
NEAR THE PG OF RAINBOW. ELEV = 2,392.63 (US SURVEY FEET) = 729.274
(METERS) - INFORMATION PROVIDED BY COLLINS ENG. DATED 1/08/18.
ADD 2300.00 FEET TO ALL GRADES FOR TRUE MEAN SEA ELEVATION, EXCEPT FOR
CONTOURS AND FINISH FLOOR ELEVATION
BASIS OF BEARING
S 02°39'07" E, BEING THE BEARING OF THE CENTERLINE OF RAINBOW & THE
EAST LINE OF THE SE 1/4 OF THE SE 1/4 OF SEC. 3, T.21S., R.60E.,
M.D.M., CITY OF LAS VEGAS, CLARK CO., NV, AS SHOWN IN FILE 128 OF
SURVEYS, PAGE 46.
GEOTECHNICAL REPORT
ALL GRADING SHALL CONFORM TO THE GEOTECHNICAL REPORT PREPARED BY MCGEETIGAN
CONSULTING, LLC, DATED 02/27/18, PROJECT NO. 1800701.
REFERENCE INFORMATION
APN 163-03-806-010
DEED 20160725-01560
PM FILE 123, PAGE 49
ZONING INFORMATION
GENERAL COMMERCIAL (C2)
PROJ-72340, SDR-72366, DS#4963, PMP#72875
WARD 1 - TARKANIAN
LEGAL DESCRIPTION
PLOT: GOVT LOTS 130, 131 & 132 WITHIN SE1/4 SE1/4 SEC. 3, T.21S., R.60E.,
CITY OF LAS VEGAS, CLARK CO. NV-RS FILE 128, PAGE 46, #20030226-1142
FLOOD ZONE
UNSHADED ZONE "X", COMMUNITY MAP 32003 C 02165 D, DATED 11/16/2011
AN AREA DETERMINED TO BE OUTSIDE OF THE 0.2% ANNUAL CHANCE FLOOD PLAIN

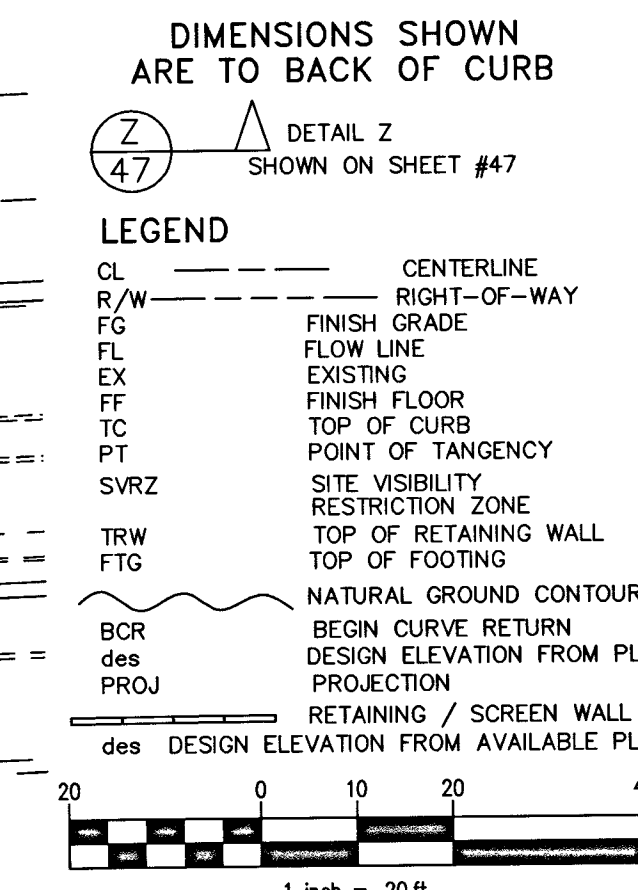

NO	WATER & UTILITY NOTES	NO	WATER & UTILITY NOTES
40	35'x 55' LVVMD EASEMENT PER DOCUMENT 19941110-0001219	59	INSTALL 6" 6" STAINLESS STEEL TAPPING SLEEVE & 6" TAPPING VALVE PER UDACS PLATES 30, 34 & 39
41	10'x 15' LVVMD EASEMENT PER DOCUMENT 19941110-0001220	60	NOT USED
42	EX 8" DCDA - WILKINS SERIAL #0589523 - ACCOUNT #583051	61	INSTALL 8" TEE & 8" GATE VALVE PER UDACS PLATES #31 & #39
43	EX 8" DCDA - AMES SERIAL #0226357 - ACCOUNT #583050	62	INSTALL 45° BEND PER UDACS PLATE #31 - SIZE PER PLAN
44	EX 2" WATER METER & RPDA - ACCOUNT #583049	63	INSTALL 8"x 6" REDUCER PER UDACS PLATES #30
45	CUT IN 8" 90° BEND W/ 8" GATE VALVE PER UDACS PLATES #31 & #39	64	INSTALL 6" TRANSITION COUPLING PER UDACS PLATES #30
46	INSTALL PVC WATER MAIN W/TRENCH BACKFILL PER UDACS PLATE #17 - LENGTH PER PLAN	65	REMOVE & REPLACE EX "L" CURB & SIDEWALK PER STD DWG'S #216 & #254
47	INSTALL 8"x 6" TEE & 6" GATE VALVE PER UDACS PLATE #31 & #39. CONNECT TO EX. 6" PVC FTRE HYDRANT LATERAL	66	INSTALL 8" RPDA PER UDACS PLATES #56 & 8" GATE VALVE PER UDACS PLATE #30 & #39
48	REMOVE EX. PVC WATER MAIN (OMIT NEAR AREA LIGHT IF REQUIRED)	67	INSTALL 90° BEND PER UDACS PLATE #31 - SIZE PER PLAN
49	INSTALL 6" DUCTILE IRON PIPE SLEEVE - LENGTH PER PLAN	68	INSTALL 8"x 6" STAINLESS STEEL TAPPING SLEEVE & 6" TAPPING VALVE PER UDACS PLATES 30, 34 & 39
50	CONNECT TO EX" PVC WATER	69	AC PAVEMENT PATCH PER STD DWG #500.1
51	3" PVC 90° BEND	70	INSTALL 8"x 2" SERVICE SADDLE, 2" COPPER (CJ) LATERAL & 2" WATER METER PER UDACS PLATE #4
52	3" PVC 45° BEND	71	BRASS WATER LINE REQUIRED BETWEEN METER & RPDA PER UDACS PLATE #4
53	3"x 3" PVC TEE	72	INSTALL 2" RPDA PER UDACS PLATE #3 W/CURB STOP PER DETAIL #72, SHT C6.01
54	EX BUILDING MOUNTED FIRE DEPT. CONNECTION (FDC)	73	CONNECT TO EX. 3" PVC WATER LINE
55	INSTALL 2" BALL ANGLE METER STOP & TAIL PIECE IN METER BOX PER UDACS PLATE #4 - NO WATER METER (PRIVATE)	74	4" SCH 40 PVC BLANK CONDUIT FOR IRRIGATION USE-LENGTH PER PLAN
56	REMOVE EX DCDA & INSTALL 8" RPDA W/ NEW VALVE SETTER PER UDACS PLATE #56. REQUIRES NEW CONCRETE PAD & PIPING	75	RELOCATE EX F.H. TO 4.0 B/C AS SHOWN PER UDACS PLATE #40 & DETAIL #70, SHT C6.01 - REMOVE EX PVC WATER BEYOND F.H.
57	CUT IN 8" GATE VALVE PER UDACS PLATES #30 & #39	76	CONTRACTORS OPTION: KEEP EX VALVE SETTER & INSTALL LVVMD APPROVED 8" RPDA ON EX ASSEMBLY PER UDACS PLATE #56
58	15'W x 20' LVVMD EASEMENT PER DOCUMENT 20180808-0001221	77	34'(W) x 22' LVVMD EASEMENT PER DOCUMENT 2018

APPROVED FOR CONSTRUCTION
CITY OF LAS VEGAS FIRE DEPT.
SOUTHWEST GAS CORPORATION
DATE: 8/20/18

APPROVED FOR CONSTRUCTION
LAS VEGAS VALLEY WATER DISTRICT ENGINEERING SERVICES
PROJECT NO. 126375 FIRST APPROVED DATE: 8/21/18
LVVMD APPROVED FIRE FLOW: TOTAL = 3000 GPM / ONSITE = 3000 GPM

BENCHMARK
CLARK CO. VERTICAL CONTROL V.2003 PT. "7C10 2SWS 1997" (NAVD 88),
RIVET & ROUND ALUM. PLATE IN TO: NE COR. OF RAINBOW & SAHARA,
NEAR THE PG OF RAINBOW. ELEV = 2,392.63 (US SURVEY FEET) = 729.274
(METERS) - INFORMATION PROVIDED BY COLLINS ENG. DATED 1/08/18.
ADD 2300.00 FEET TO ALL GRADES FOR TRUE MEAN SEA ELEVATION, EXCEPT FOR
CONTOURS AND FINISH FLOOR ELEVATION

BASIS OF BEARING
S 02°39'07" E, BEING THE BEARING OF THE CENTERLINE OF RAINBOW & THE
EAST LINE OF THE SE 1/4 OF THE SE 1/4 OF SEC. 3, T.21S., R.60E.,
M.D.M., CITY OF LAS VEGAS, CLARK CO., NV, AS SHOWN IN FILE 128 OF
SURVEYS, PAGE 46.

GEOTECHNICAL REPORT
ALL GRADING SHALL CONFORM TO THE GEOTECHNICAL REPORT PREPARED BY MCGEETIGAN
CONSULTING, LLC, DATED 02/27/18, PROJECT NO. 1800701.

REFERENCE INFORMATION
APN 163-03-806-010
DEED 20160725-01560
PM FILE 123, PAGE 49
ZONING INFORMATION
GENERAL COMMERCIAL (C2)
PROJ-72340, SDR-72366, DS#4963, PMP#72875
WARD 1 - TARKANIAN
LEGAL DESCRIPTION
PLOT: GOVT LOTS 130, 131 & 132 WITHIN SE1/4 SE1/4 SEC. 3, T.21S., R.60E.,
CITY OF LAS VEGAS, CLARK CO. NV-RS FILE 128, PAGE 46, #20030226-1142
FLOOD ZONE
UNSHADED ZONE "X", COMMUNITY MAP 32003 C 02165 D, DATED 11/16/2011
AN AREA DETERMINED TO BE OUTSIDE OF THE 0.2% ANNUAL CHANCE FLOOD PLAIN

10747427
C5.03
SHEET 17 OF 20
CLV # L18-00533

CLARK CO. NEVADA

DATE: 3/2018

DRAFTER: JC

DESIGNER: SCD

CHECKED: SCD

PROJECT NO. 701326.00

PROJ: 126375-A QS: 163-03-SE

UTILITY PLAN 03

BMW OF LAS VEGAS

CLV # L18-00533



PROFESSIONAL ENGINEER

SAM C. DUNHAM

EXP. 12-31-18

CIVIL

No. 126375

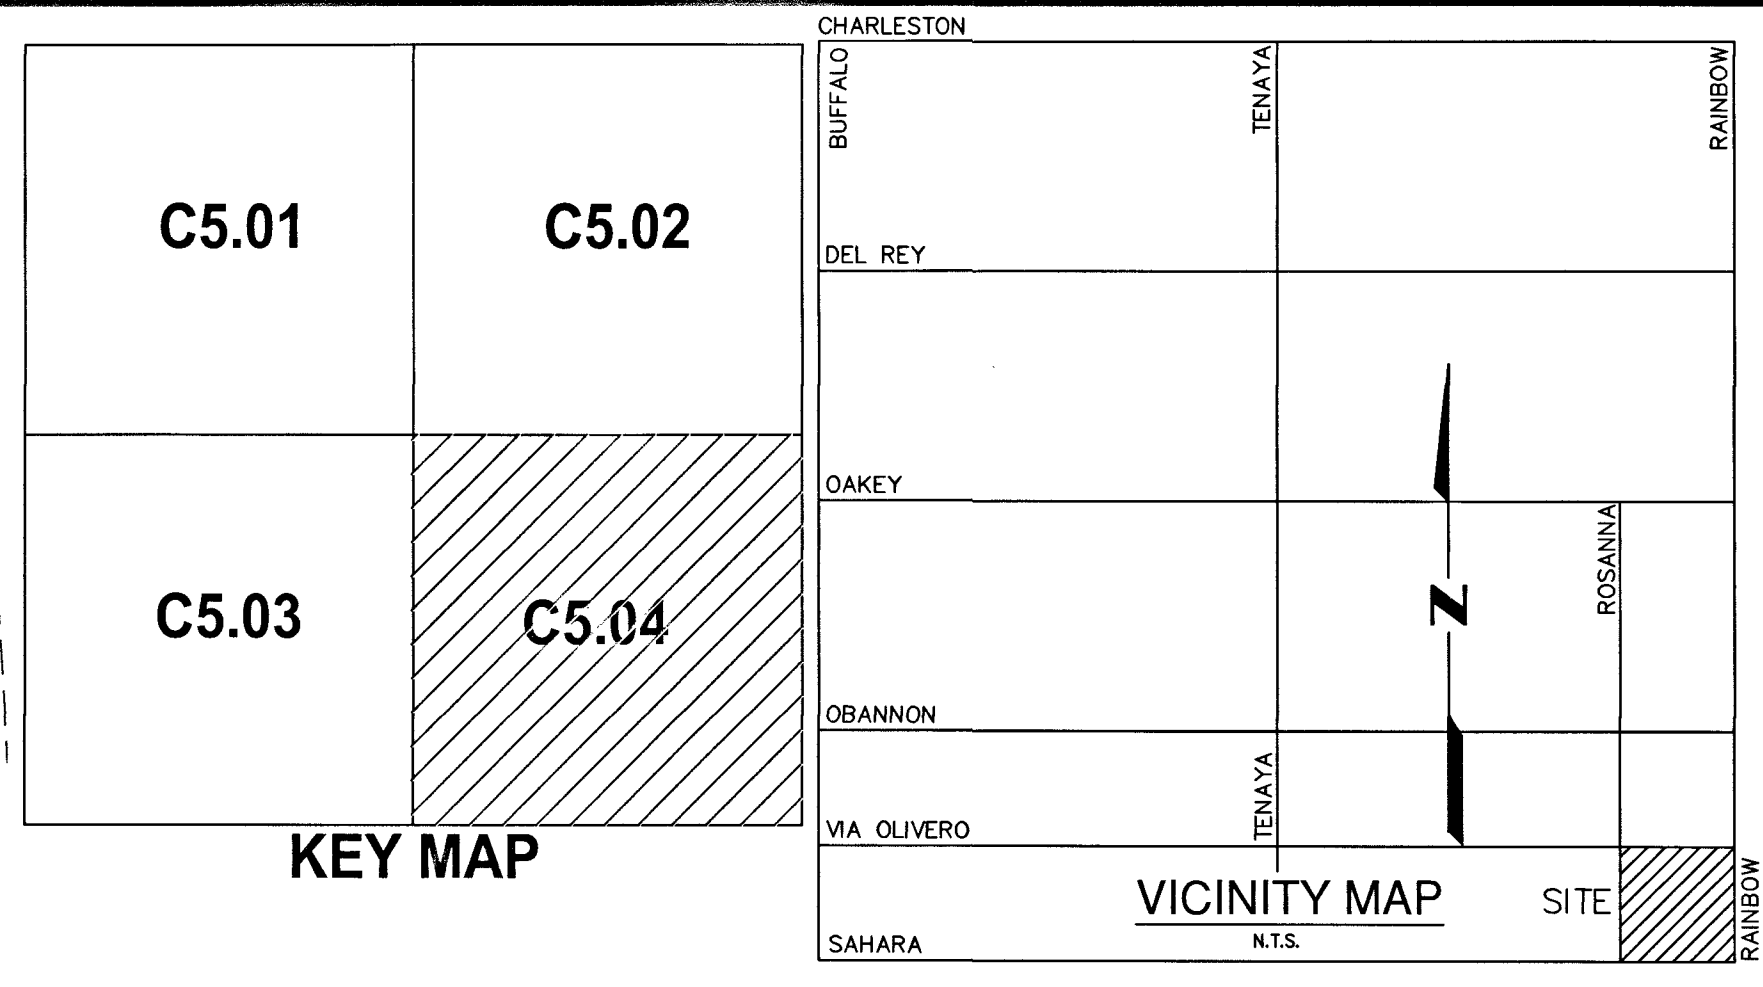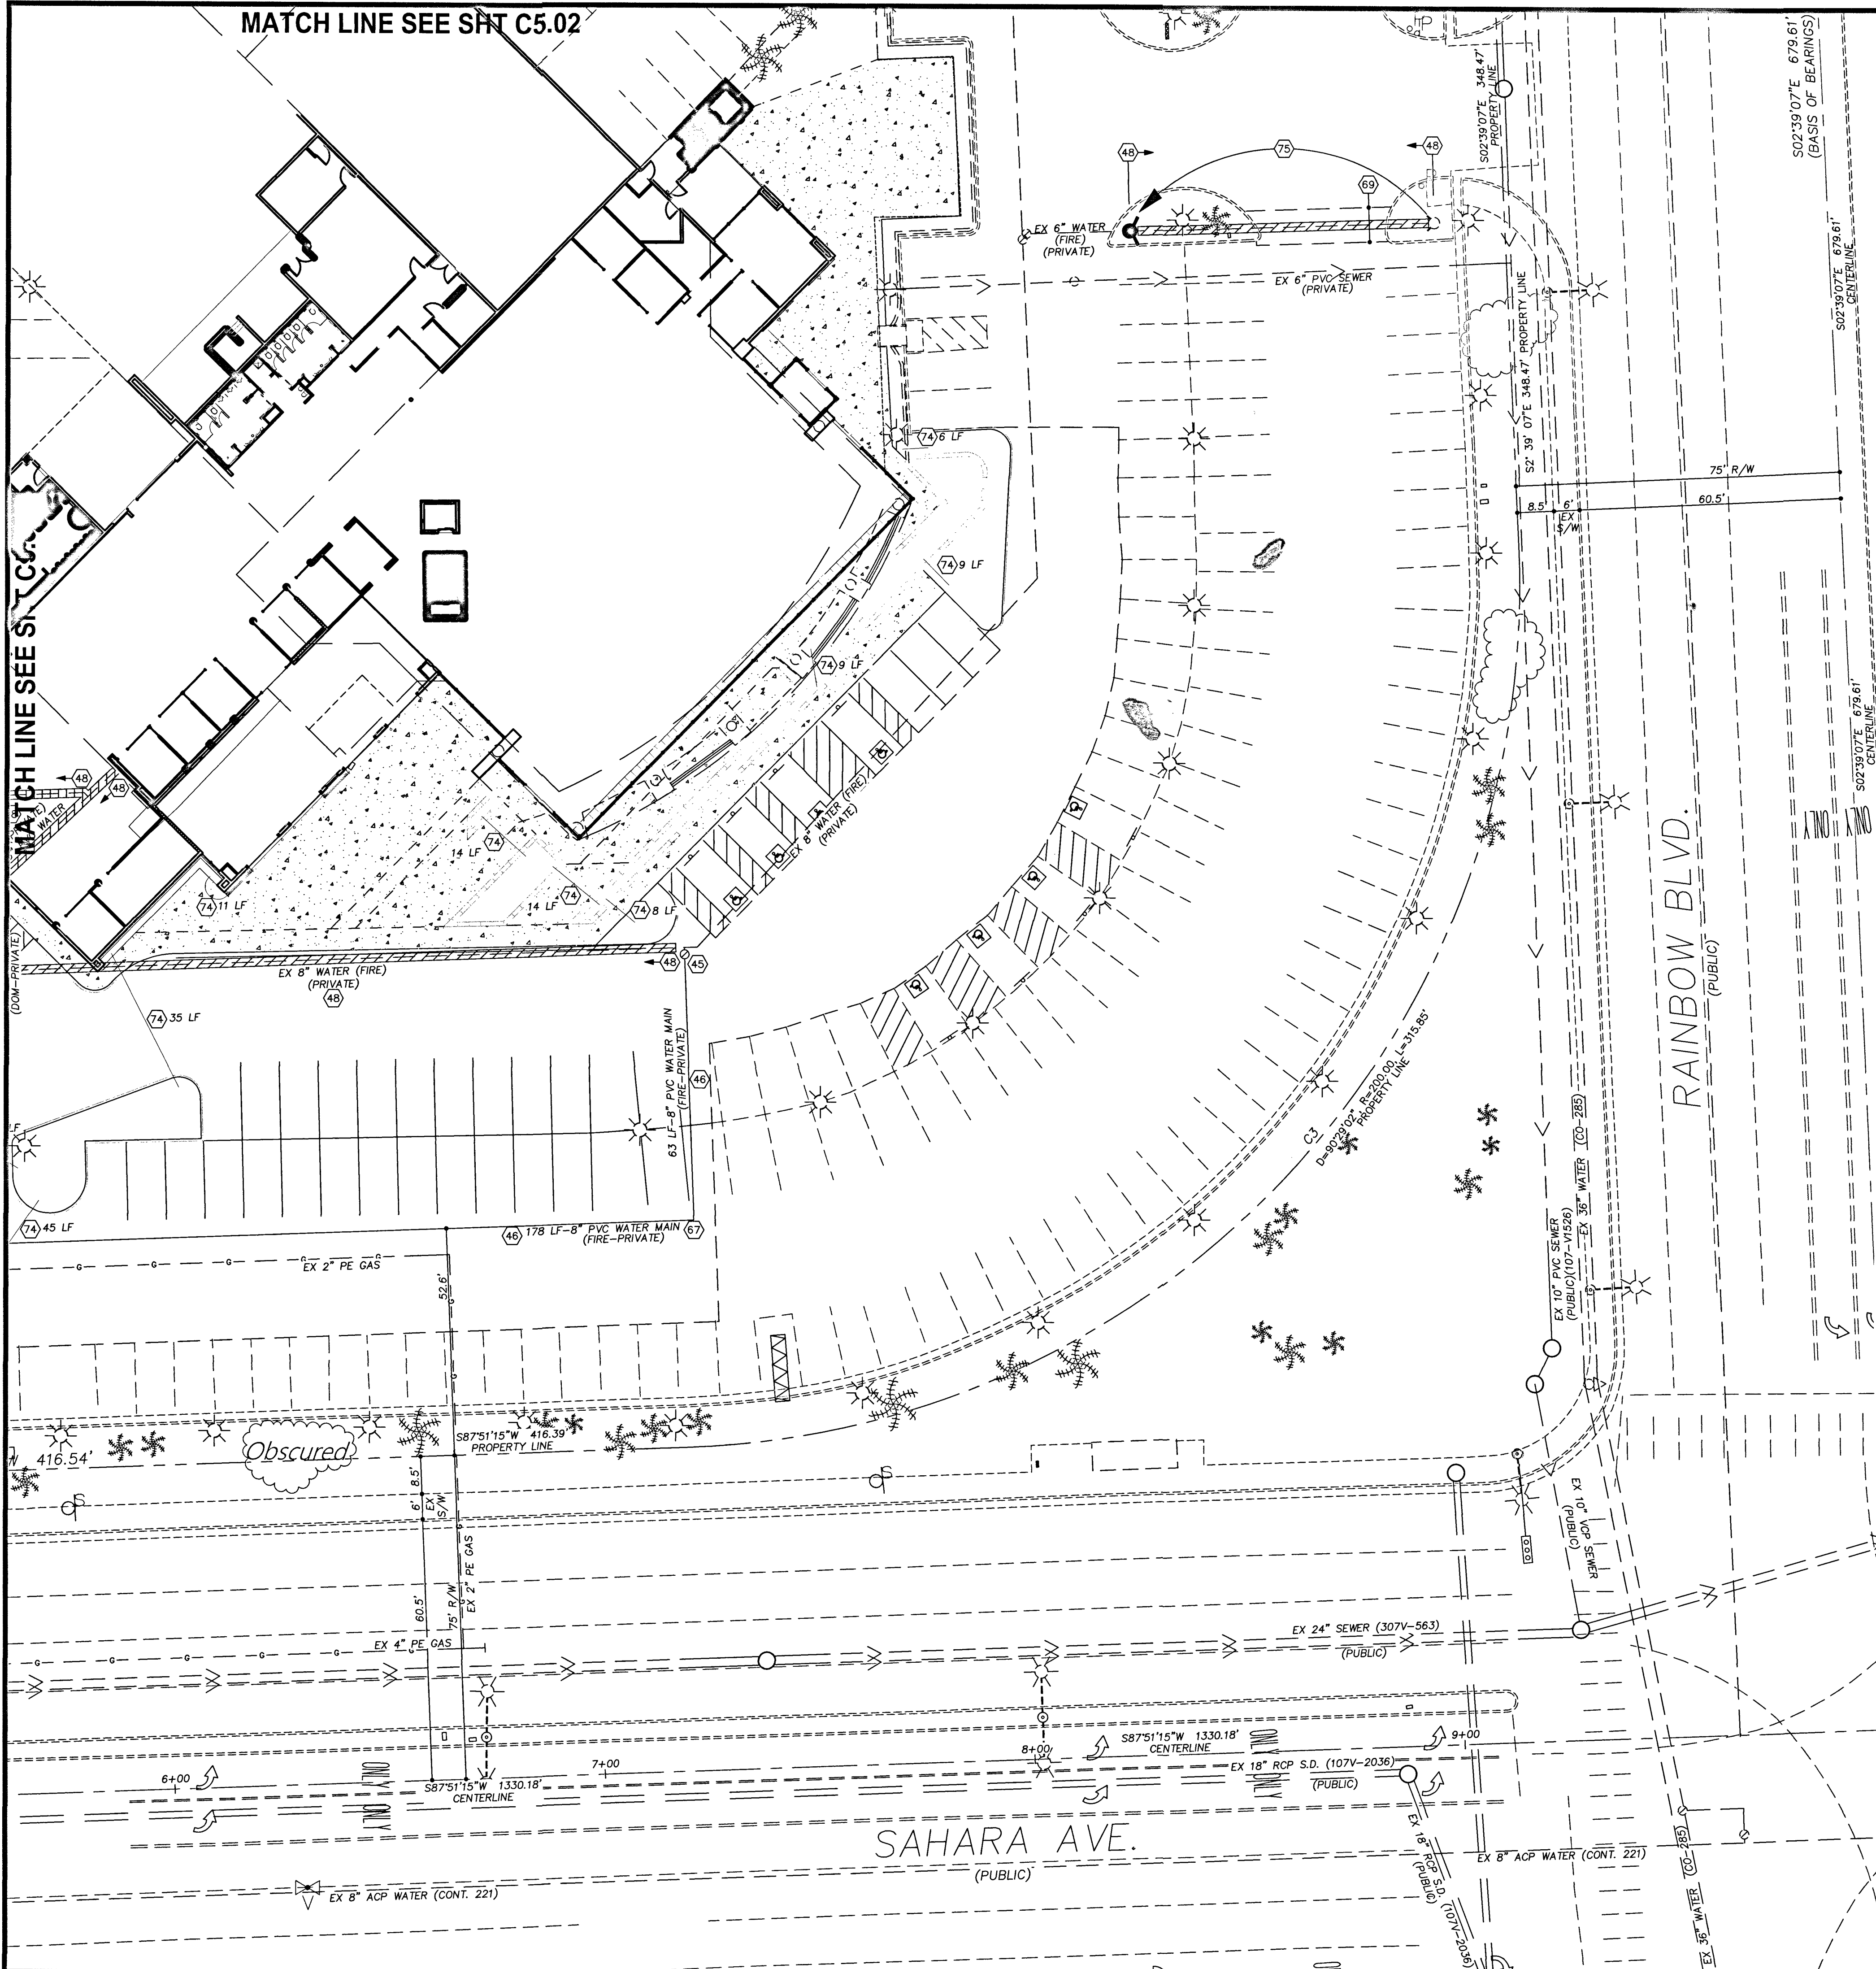


NO. WATER & UTILITY NOTES	
(40) 35'x 55' LVWD EASEMENT PER DOCUMENT 19941110:0001219	(59) INSTALL 6"x 6" STAINLESS STEEL TAPPING SLEEVE & 6" TAPPING VALVE PER UDACS PLATES 30, 34 & 39
(41) 10'x 15' LVWD EASEMENT PER DOCUMENT 19941110:0001220	(60) NOT USED
(42) EX 8" DCDA - WILKINS SERIAL #058923 - ACCOUNT #583051	(61) INSTALL 8" TEE & 8" GATE VALVE PER PER UDACS PLATES #31 & #39
(43) EX 8" DCDA - AMES SERIAL #026357 - ACCOUNT #583050	(62) INSTALL 45° BEND PER UDACS PLATE #31 - SIZE PER PLAN
(44) EX 2" WATER METER & RPPA - ACCOUNT #583049	(63) INSTALL 8"x 6" REDUCER PER UDACS PLATES #30
(45) CUT IN 8" 90° BEND W/ 8" GATE VALVE PER UDACS PLATES #31 & #39	(64) INSTALL 6" TRANSITION COUPLING PER UDACS PLATES #30
(46) INSTALL PVC WATER MAIN W/TRENCH BACKFILL PER UDACS PLATE #17 - LENGTH PER PLAN	(65) REMOVE & REPLACE EX "L" CURB & SIDEWALK PER STD DWG'S #216 & #254
(47) INSTALL 8"x 6" TEE & 6" GATE VALVE PER UDACS PLATE #31 & #39. CONNECT TO EX. 6" PVC FIRE HYDRANT LATERAL	(66) INSTALL 8" RPPA PER UDACS PLATES #30 & #39
(48) REMOVE EX PVC WATER MAIN (OMIT NEAR AREA LIGHT IF REQUIRED)	(67) INSTALL 90° BEND PER UDACS PLATE #31 - SIZE PER PLAN
(49) INSTALL 6" DUCTILE IRON PIPE SLEEVE - LENGTH PER PLAN	(68) INSTALL 8"x 6" STAINLESS STEEL TAPPING SLEEVE & 6" TAPPING VALVE PER UDACS PLATES 30, 34 & 39
(50) CONNECT TO EX" PVC WATER	(69) AC PAVEMENT PATCH PER STD DWG #500.1
(51) 3" PVC 90° BEND	(70) INSTALL 8"x 2" SERVICE SADDLE, 2" COPPER (CU) LATERAL & 2" WATER METER PER UDACS PLATE #4
(52) 3"x 3" PVC TEE	(71) BRASS WATER LINE REQUIRED BETWEEN WATER & RPPA PER UDACS PLATE #4
(53) EX BUILDING MOUNTED FIRE DEPT. CONNECTION (FDC)	(72) INSTALL 2" RPPA PER UDACS PLATE #8 W/CURB STOP PER DETAIL #72, SHT C6.01
(54) INSTALL 2" BALL ANGLE METER STOP & TAIL PIECE IN METER BOX PER UDACS PLATE #4 - NO WATER METER (PRIVATE)	(73) CONNECT TO EX. 3" PVC WATER LINE
(55) REMOVE EX DCDA & INSTALL 8" RPPA W/ NEW VALVE SETTER PER UDACS PLATE #56. REQUIRES NEW CONCRETE PAD & PIPING	(74) 4" SCH 40 PVC BLANK CONDUIT FOR IRRIGATION USE-LENGTH PER PLAN
(56) CUT IN 8" GATE VALVE PER UDACS PLATES #30 & #39	(75) RELOCATE EX F.H. TO 4.0 B/C AS SHOWN PER UDACS PLATE #40 & DETAIL #70, SHT C6.01 - REMOVE EX PVC WATER BEYOND F.H.
(57) 15'(W) x 20' LVWD EASEMENT PER DOCUMENT 20180808:0001221	(76) CONTRACTORS OPTION: KEEP EX VALVE SETTER & INSTALL LVWD APPROVED 8" RPPA ON EX ASSEMBLY PER UDACS PLATE #56
(58)	(77) 34'(W) x 22' LVWD EASEMENT PER DOCUMENT 2018

WARNING FIRE LINE (NON-POTABLE WATER)
ALL EXISTING, RELOCATED OR PROPOSED DCDA/RPPA INSTALLATIONS.
TO COMPLY WITH THE FEDERAL SAFE WATER DRINKING ACT, THE FIRE LINE, OR ANY OF ITS COMPONENTS, SHALL NOT BE USED FOR POTABLE DRINKING WATER AT ANY TIME.
DISPOSAL OF ASBESTOS CEMENT PIPE (ACP) SHALL BE IN ACCORDANCE WITH ALL LOCAL, STATE AND FEDERAL REQUIREMENTS.
TO INSURE LVWD ACCESS WITHIN EASEMENT
ALL ABOVE GROUND OBSTRUCTIONS INCLUDING, BUT NOT LIMITED TO, LANDSCAPE BOULDERS, FENCES, WALLS AND SIGNS ARE STRICTLY PROHIBITED WITH EASEMENT.

REDUCED PRESSURE PRINCIPLE ASSEMBLY (RPPA) (1) 2-INCH
APPROVED REDUCED PRESSURE PRINCIPLE ASSEMBLY(S) SHALL BE INSTALLED PER THE UDACS PLATE NO. 56. NO WATER SHALL BE TAKEN FROM A SERVICE REQUIRING BACKFLOW PREVENTION UNTIL THE ASSEMBLY HAS BEEN SUCCESSFULLY TESTED BY THE LVWD. ANY BLOCK WALL OR FENCE MATERIAL DESIGNED AND CONSTRUCTED AROUND THE OUTSIDE OF THE EASEMENT(S) SO AS TO ALLOW THE LVWD DIRECT ACCESS FROM THE ADJACENT RIGHT-OF-WAY. EASEMENTS SHALL BE CLEARLY MARKED OR STAKED PRIOR TO THE START OF CONSTRUCTION.
REDUCED PRESSURE DETECTOR ASSEMBLY (RPDA) (3) 8-INCH
APPROVED REDUCED PRESSURE DETECTOR ASSEMBLY(S) SHALL BE INSTALLED PER THE UDACS PLATE NO. 56. NO WATER SHALL BE TAKEN FROM A SERVICE REQUIRING BACKFLOW PREVENTION UNTIL THE ASSEMBLY HAS BEEN SUCCESSFULLY TESTED BY THE LVWD. ANY BLOCK WALL OR FENCE MATERIAL DESIGNED AND CONSTRUCTED AROUND THE OUTSIDE OF THE EASEMENT(S) SO AS TO ALLOW THE LVWD DIRECT ACCESS FROM THE ADJACENT RIGHT-OF-WAY. EASEMENTS SHALL BE CLEARLY MARKED OR STAKED PRIOR TO THE START OF CONSTRUCTION.

FIRE FLOW REQUIREMENT IS: 3000 gallons per minute at 20 psi residual pressure.
BASED ON:
SQUARE FOOTAGE: 77,680 sq.ft.
LARGEST AREA BETWEEN 4-HOUR AREA SEPARATION WALLS: 77,680 sq.ft.
BUILDING HEIGHT: 38'-6"
NUMBER OF STORIES: 3
TYPE OF CONSTRUCTION: III-B
OCCUPANCY: B, S-1, S-2
FULL AUTOMATIC FIRE SPRINKLER SYSTEM: YES (50% REDUCTION)
HIGH PILE STORAGE: NO
PRESSURE ZONE: 2538

DIMENSIONS SHOWN ARE TO BACK OF CURB
DETAIL Z
SHOWN ON SHEET #47

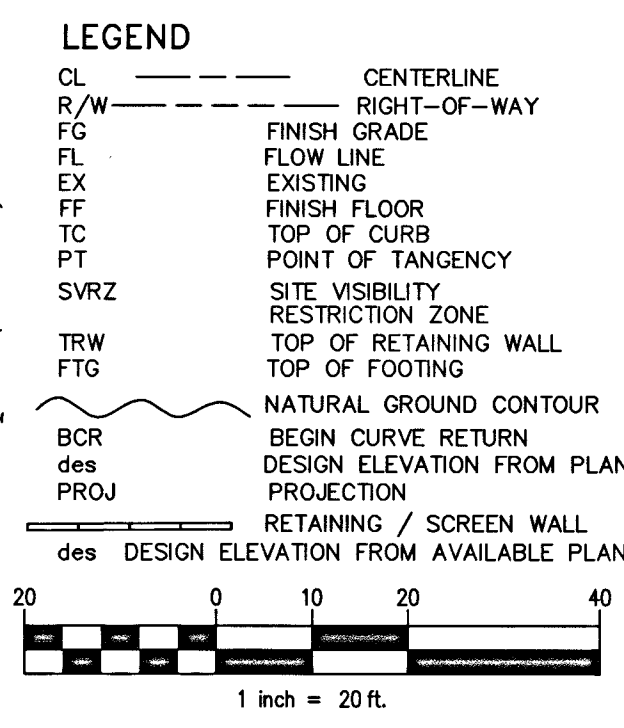

APPROVED FOR CONSTRUCTION
CITY OF LAS VEGAS FIRE DEPT.
DATE: 8/21/18
APPROVED DATE: 8/21/18
PROJECT NO. 126375
LVWD APPROVED FIRE FLOW: TOTAL = 3000 GPM / ONSITE = 3000 GPM
BENCHMARK
CLARK CO. VERTICAL CONTROL V.2003 PT. "7C10 2SW5 1997" (NAVD 88), RIVET & ROUND ALUM. PLATE IN TC, NE COR. OF RAINBOW & SAHARA, NEAR THE PC OF RAINBOW. ELEV.=2,392.63 (US SURVEY FEET) = 729.274 (METERS) - INFORMATION PROVIDED BY COLLINS ENG. DATED 1/08/18.
ADD 2300.00 FEET TO ALL GRADES FOR TRUE MEAN SEA ELEVATION, EXCEPT FOR CONTOURS AND FINISH FLOOR ELEVATION
BASIS OF BEARING
S 02°39'07" E, BEING THE BEARING OF THE CENTERLINE OF RAINBOW & THE EAST LINE OF THE SE 1/4 OF THE SE 1/4 OF SEC. 3, T.21S., R.60E., M.D.M., CITY OF LAS VEGAS, CLARK CO., NV, AS SHOWN IN FILE 128 OF SURVEYS, PAGE 46.
GEOTECHNICAL REPORT
ALL GRADING SHALL CONFORM TO THE GEOTECHNICAL REPORT PREPARED BY MCGITTIGAN CONSULTING, LLC, DATED 02/27/18, PROJECT NO. 1800701.
REFERENCE INFORMATION
APN 163-03-806-010
DEED 20160725:01560
PM FILE 123, PAGE 49
ZONING INFORMATION
GENERAL COMMERCIAL (C2)
PROJ-72340, SDR-72356, DS#4963, PMP#72875
WARD 1 - TARKANIAN
LEGAL DESCRIPTION
POR. GOVT LOTS 130, 131 & 132 WITHIN SE1/4 SE1/4 SEC. 3, T.21S., R.60E., CITY OF LAS VEGAS, CLARK CO. NV.-ROS FILE 128, PAGE 46, #20030226:1042
FLOOD ZONE
UNSHADED ZONE "X", COMMUNITY MAP 32003 C 02165 D, DATED 11/16/2011
AN AREA DETERMINED TO BE OUTSIDE OF THE 0.2% ANNUAL CHANCE FLOOD PLAIN

CLARK CO. NEVADA

BMW OF LAS VEGAS

UTILITY PLAN 04

DATE: 3/2018

DRAFTER: JC

DESIGNER: SCD

CHECKED: SCD

PROJECT NO. 701326.00

PROFESSIONAL ENGINEER

SAM C. DUINAM

EXP. 12-31-18

CLARK CO. NV





107V7427

C5.04

SHEET 18 OF 20


CLV # L18-00533

PROJ#: 126375-A QS: 163-03-SE

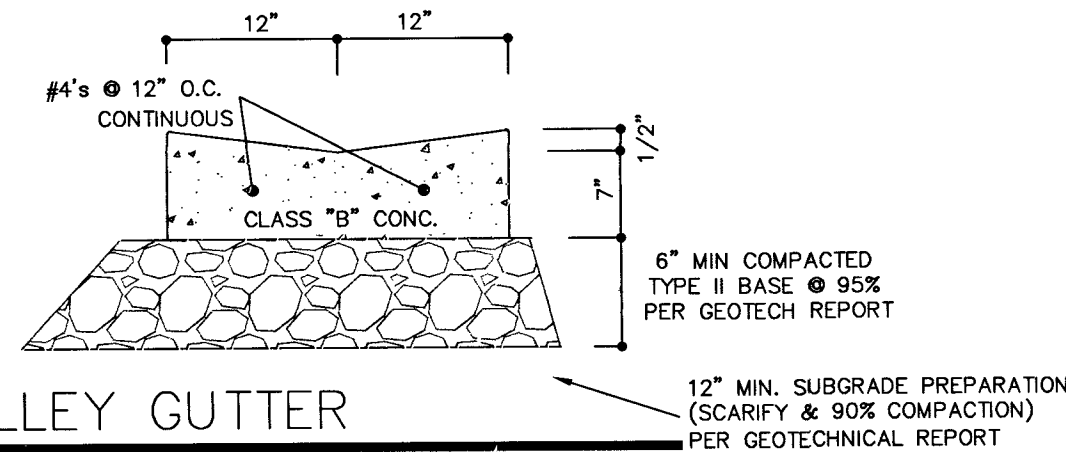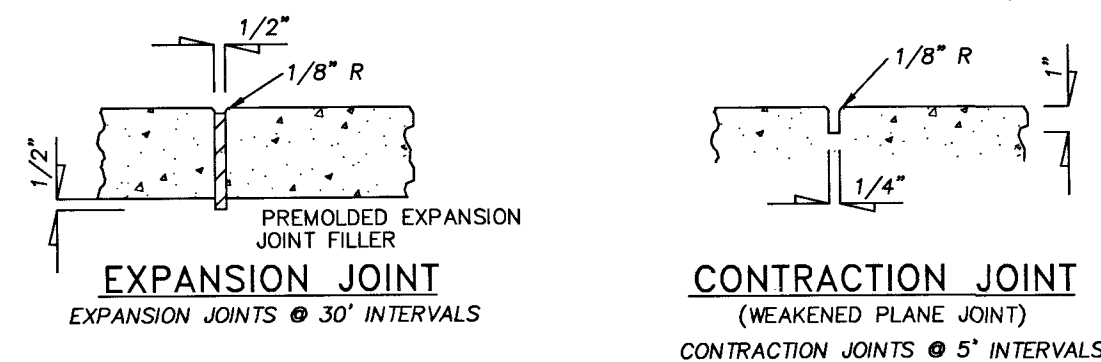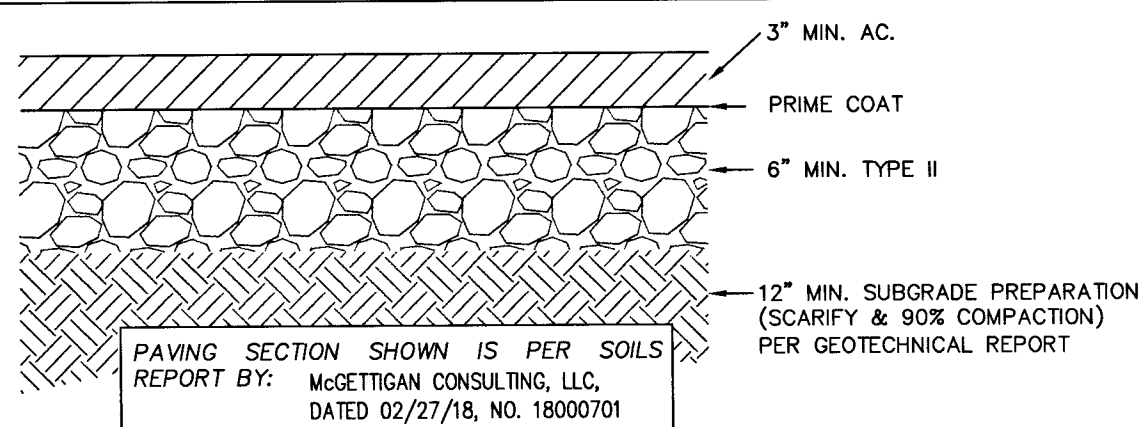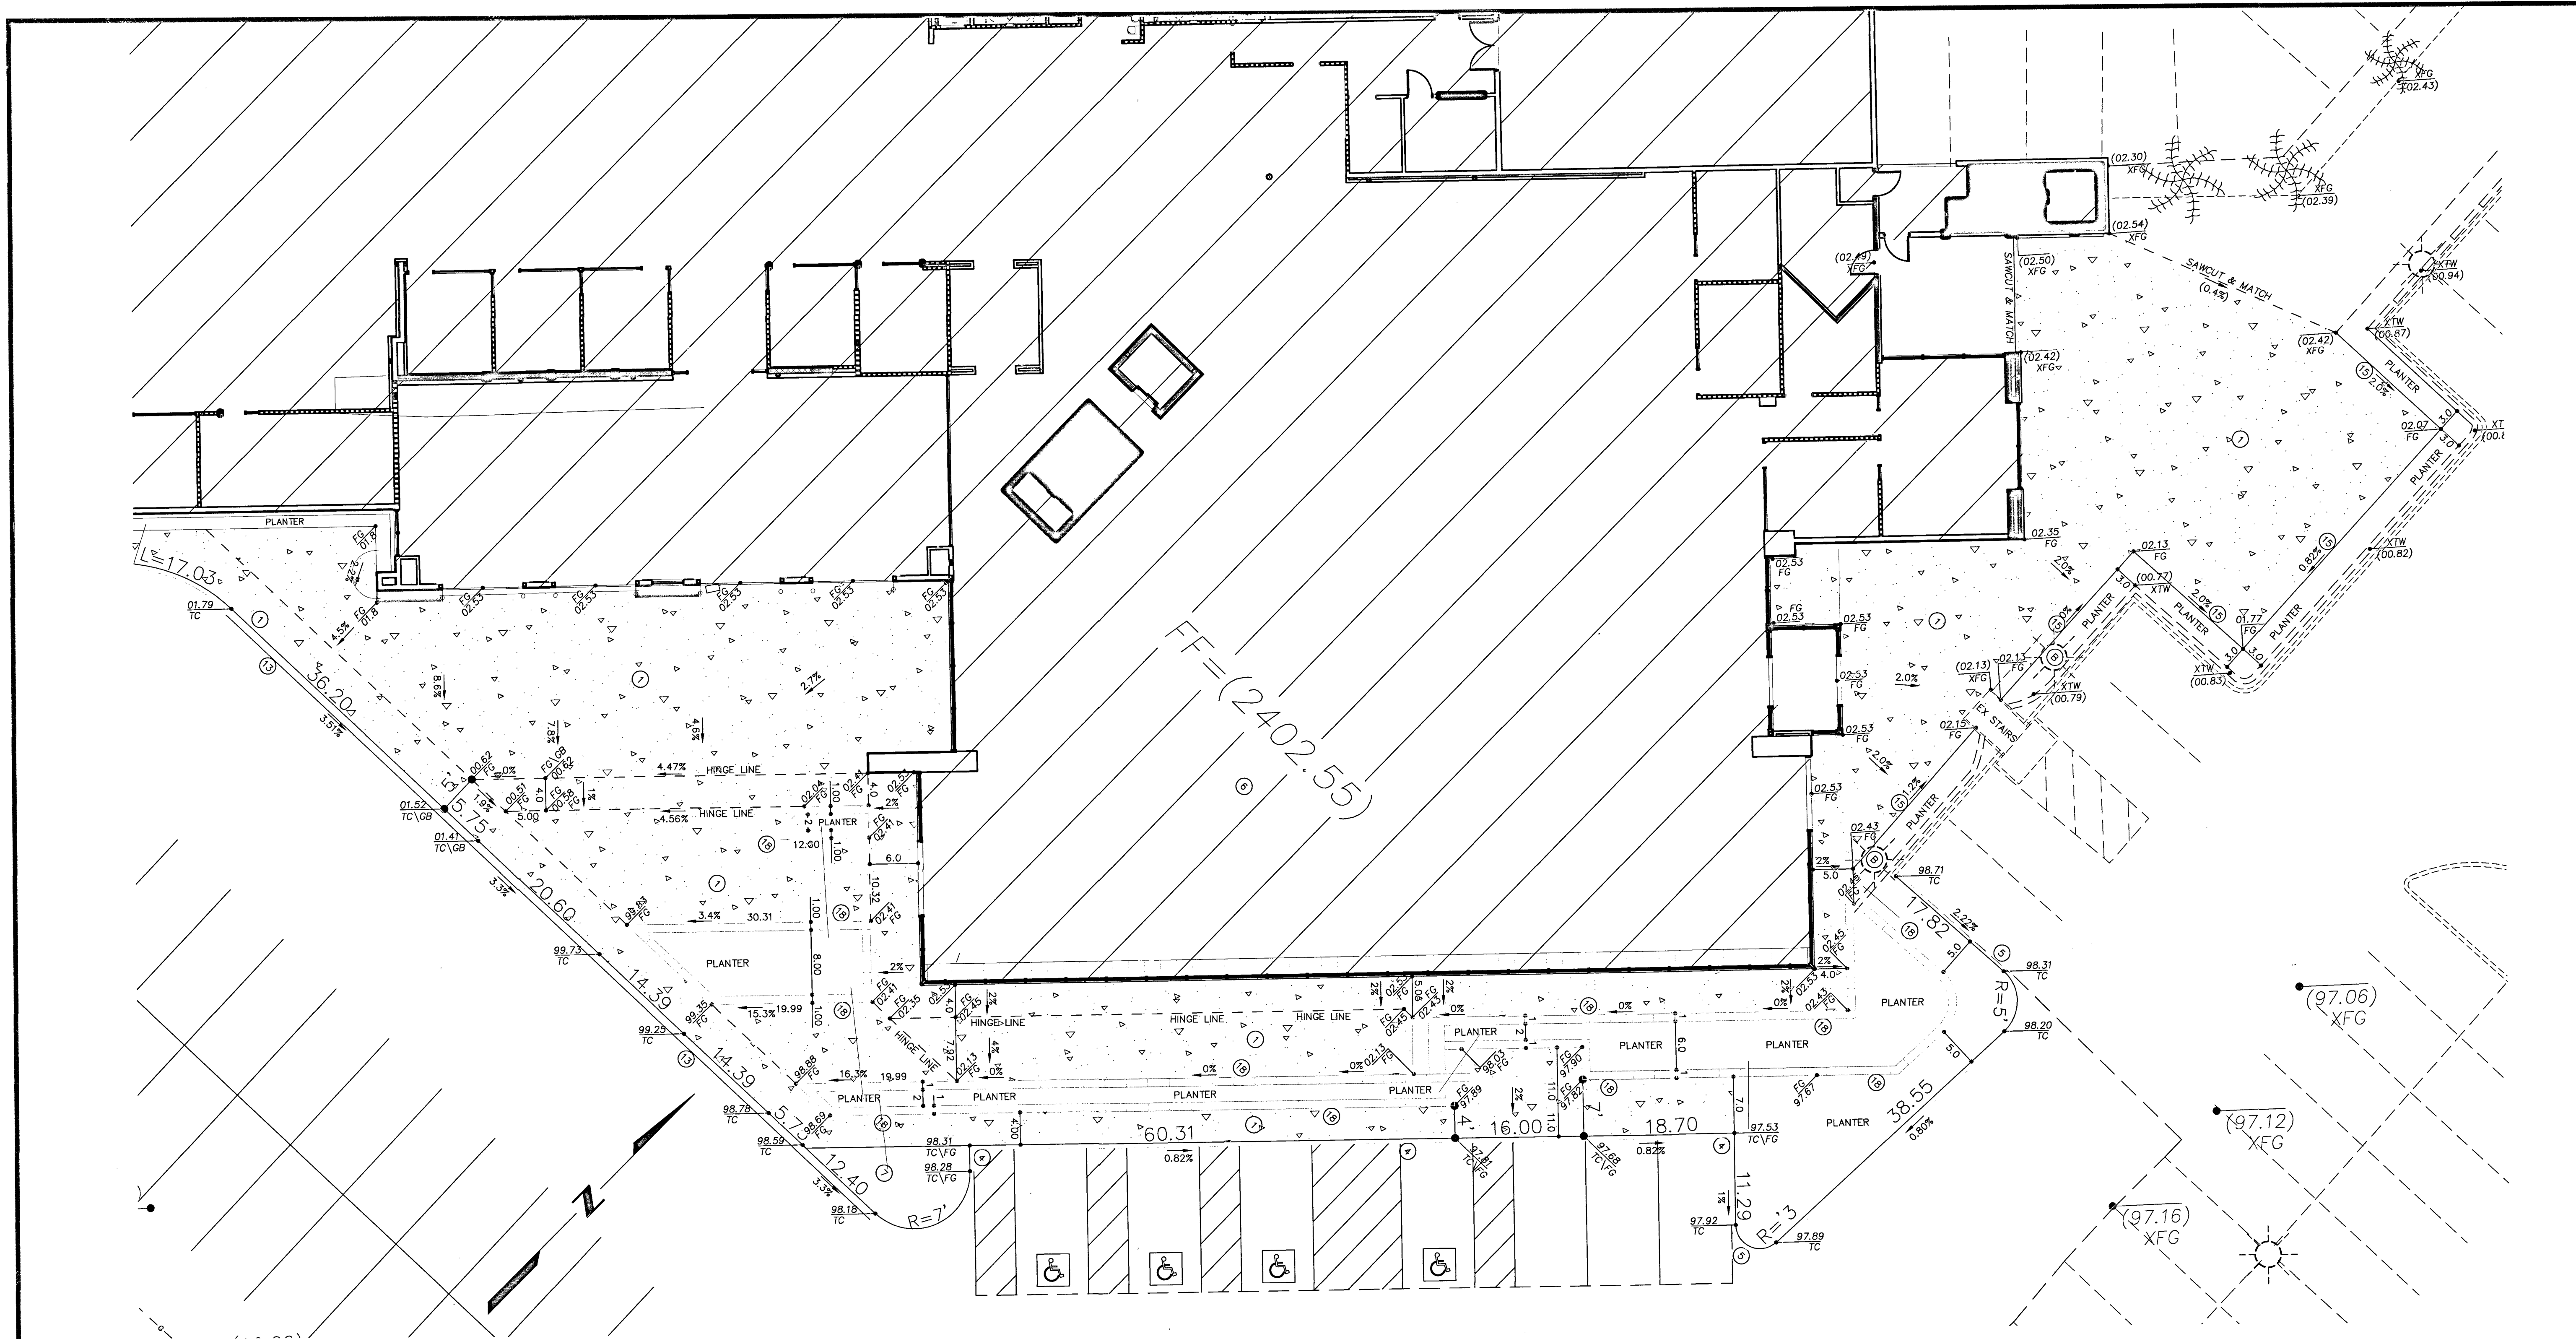

- CONSTRUCTION NOTES**
1. CONSTRUCT CONCRETE SIDEWALK PER DETAIL #1, SHT C6.02-SEE FINISH PLAN PER ARCHITECTS PLANS & DETAILS
 2. CONSTRUCT AC PAVEMENT PER DETAIL #2, SHT C6.02
 3. CONSTRUCT 24" CONCRETE VALLEY GUTTER PER DETAIL #3, SHT C6.02
 4. CONSTRUCT "A" TYPE CURB-0" FACE PER STD. DWG. #219
 5. CONSTRUCT "A" TYPE CURB-6" FACE PER STD. DWG. #219
 6. ROUGH GRADE PAD ELEV. IS ASSUMED TO BE 12" BELOW FINISH FLOOR ELEV. VERIFY w/ STRUCTURAL PLANS PRIOR TO ANY CONSTRUCTION.
 7. PLANTER AREA
 8. CONSTRUCT "L" TYPE CURB PER STD. DWG. #216
 9. NOT USED
 10. CONSTRUCT RETAINING WALL PER DETAIL #10 SHT C6.01 RETAINING WALL CALCS & DETAILS BY OTHERS
 11. CONSTRUCT HANDICAP PARKING STALL PER DETAIL #11, SHT C6.01
 12. DRAIN-THRU PER DETAIL #12 SHT C6.01
 13. NDOT TYPE "3" CURB PER NDOT STD DWG #R-5.1.1 - 6" RISE
 14. NOT USED
 15. PROVIDE HANDRAILS PER ARCHITECTURAL DETAILS
 16. 2% GRADE ALLOWED PER SOILS REPORT-SECTION: GRADING & DRAINAGE
 17. CONSTRUCT CONCRETE PAVEMENT PER DETAIL #17, SHT C6.01
 18. CAST IN PLACE WALL-SEE ARCHITECTURAL DETAILS

- | | |
|-----|--|
| (A) | PROTECT EX LOOP DETECTORS IN PLACE |
| (B) | PROTECT EX AREA LIGHT & CONCRETE BASE IN PLACE |
| (C) | PROTECT EX ELECTRICAL TRANSFORMER IN PLACE |

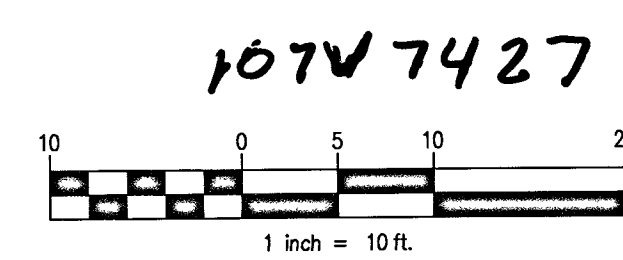

NO.	DATE	BY	APP.
	12/12/17	SCD	
DESCRIPTION			
7. REVISE SW GAS PLAN			

TYLIN INTERNATIONAL
4031 DEAN MARTIN DR.
LAS VEGAS, NV 89103
P: 702-522-7100
F: 702-522-7105
WWW.TYLIN.COM

CITY OF LAS VEGAS
CLARK CO, NEVADA

BMW OF LAS VEGAS

DETAIL / SECTION SHEET 2

DATE: 3/2018
DRAFTER: JC
DESIGNER: SCD
CHECKED: SCD
PROJECT NO.
701326.00

SAM C. DUNHAM
PROFESSIONAL ENGINEER
EXP. 12-31-17
CIVIL
#4788

C6.02
SHEET 20 OF 20
CLV # L18-00533