
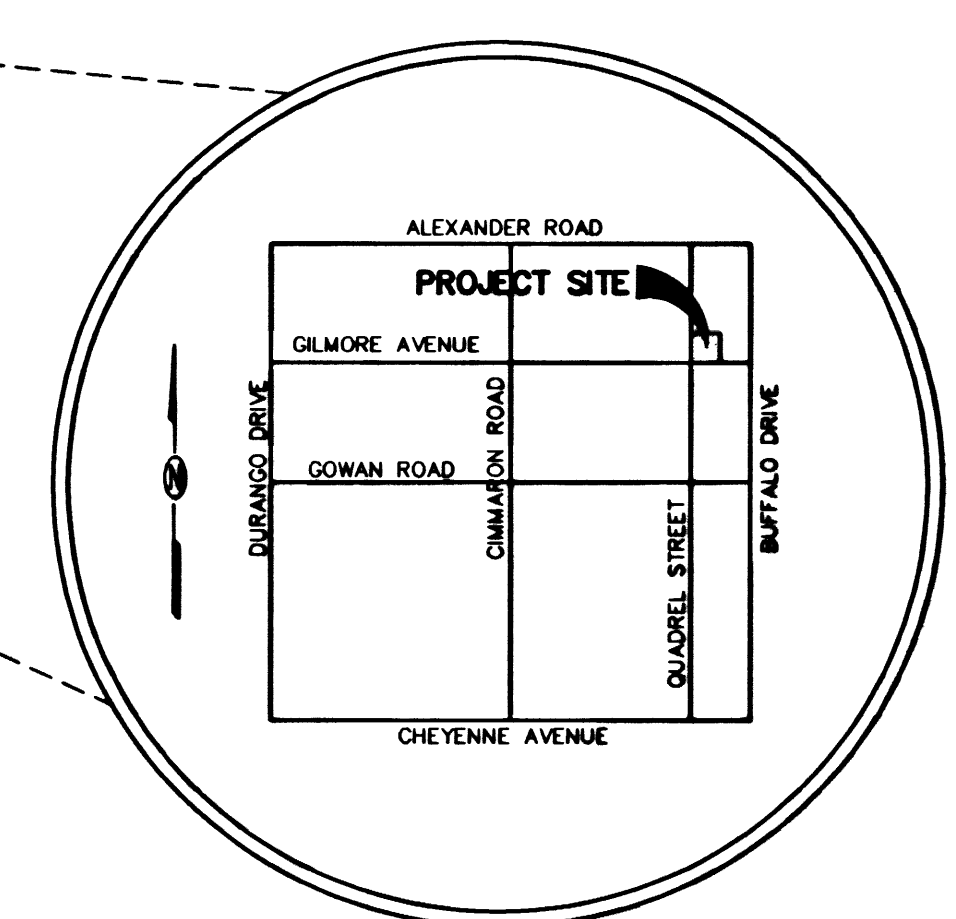
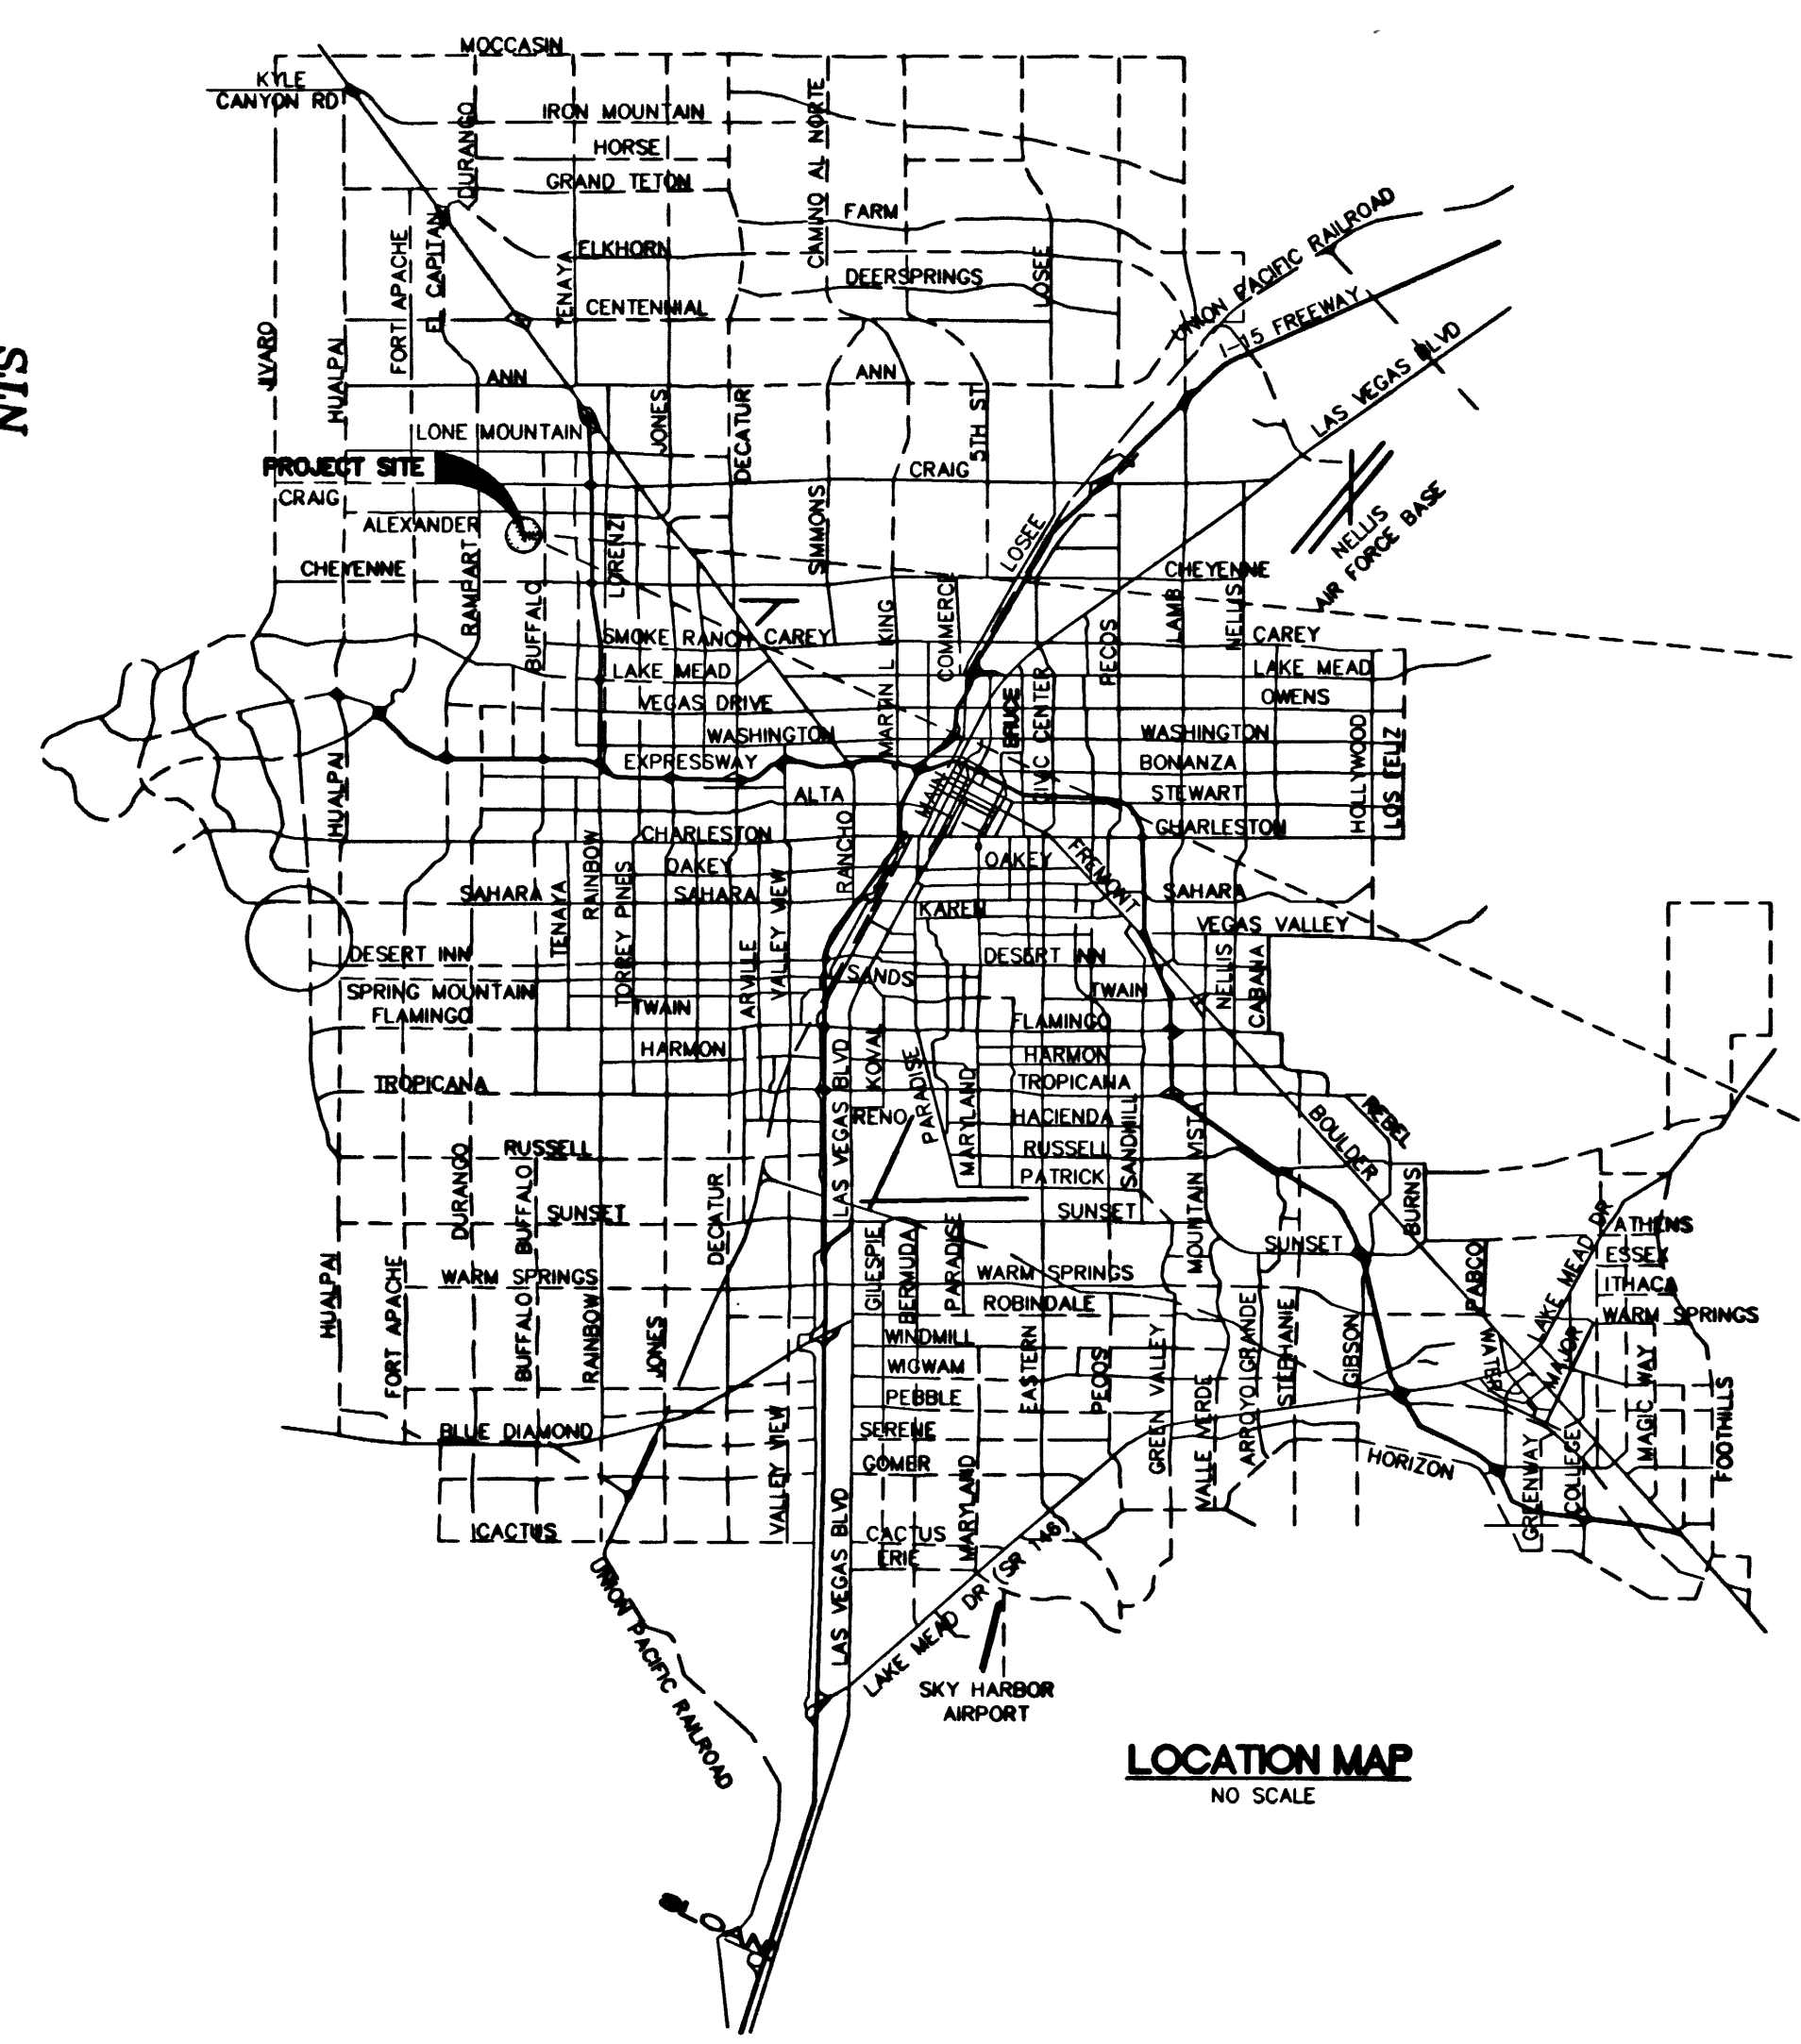


IMPROVEMENT PLANS
OF
SAINT GEORGE
EPISCOPAL CHURCH
FOR
EDWIN BOWES

CITY OF LAS VEGAS
CLARK COUNTY, NEVADA
APN 138-09-501-040

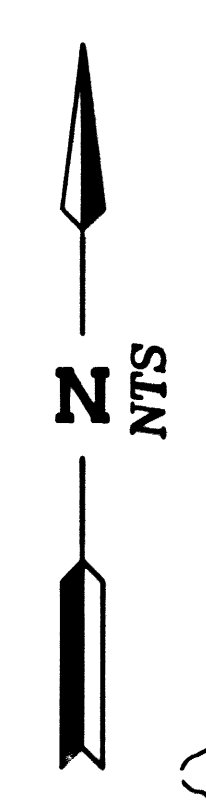

VICINITY MAP
SECTION 9, TOWNSHIP 20 SOUTH, RANGE 60 EAST
NO SCALE

APPROVALS

LAS VEGAS VALLEY WATER DISTRICT (SHTS: C1, C2 & D1) DATE

Benton Marshall 11-1-00
SOUTHWEST GAS CORPORATION DATE

Richard M. Horal 11-1-00
SPRINT DATE

Janita Rodriguez 11-1-00
NEVADA POWER COMPANY - LAS VEGAS DISTRICT DATE

Charles K. Kowalski (For Phase I only) 12-14-2010
CITY OF LAS VEGAS FIRE MARSHAL
DATE
and Occupants need to be sprinkled due to lack of access

Charles K. Kowalski 12-14-2010
CHARLES K. KOWALSKI JR., PE # 4784
CITY ENGINEER DATE

INDEX OF SHEETS

- 1 SHEET C1 --- COVER SHEET AND VICINITY MAP
- 2 SHEET C2 --- GENERAL NOTES & QUANTITIES
- 3 SHEET H1 --- HORIZONTAL CONTROL PLAN
- 4 SHEET G1 --- GRADING PLAN
- 5 SHEET U1 --- UTILITY PLAN
- 6 SHEET P1 --- PLAN & PROFILE (GILMORE AVENUE)
- 7 SHEET P2 --- PLAN & PROFILE (QUADREL STREET)
- 8 SHEET T1 --- TRAFFIC AND STREET LIGHTING PLAN
- 9 SHEET D1 --- DETAIL SHEET

NOTICE!

EXISTING UTILITIES ARE SHOWN ON PLANS FOR THE CONVENIENCE OF THE CONTRACTOR ONLY. THE CONTRACTOR IS RESPONSIBLE FOR THE PROTECTION OF ALL UTILITIES. THE ENGINEER BEARS NO RESPONSIBILITY FOR UTILITIES NOT SHOWN OR SHOWN INCORRECTLY.

Call BEFORE YOU Dig

1-800-227-2600
UNDERGROUND SERVICE (USA)

AVOID CUTTING UNDERGROUND UTILITIES. IT'S COSTLY.

EDWIN BOWES PO BOX 35578 LAS VEGAS, NEVADA 89133 PHONE (702) 647-8740 FAX (702) 645-0387	ENGINEERING COMPANY 50 So. Jones #202, Las Vegas, NV, 89107 Telephone: (702) 877-1300
COVER SHEET & VICINITY MAP	SHEET 1 OF 9 SHEETS DRAWING NO. 107-V-3372
SANCT GEORGE EPISCOPAL CHURCH	REVISION REV DATE BY