



- NOTES:**
- ① SEE MUSCO LIGHTING PLAN FOR EXACT POLE AND LIGHTING LOCATIONS AND LAYOUT ON SOCCER FIELD.
 - ② SEE ONELINE FOR FEEDER AND CONDUIT SIZES.
 - ③ MOUNT F18 FIXTURES TO BE MOUNTED ON SPORT POLE AT A MAXIMUM OF 20' A.F.G. REFER TO THE SPORT LIGHTING MANUFACTURER FOR BALLAST BOX HEIGHT PRIOR TO INSTALLATION.

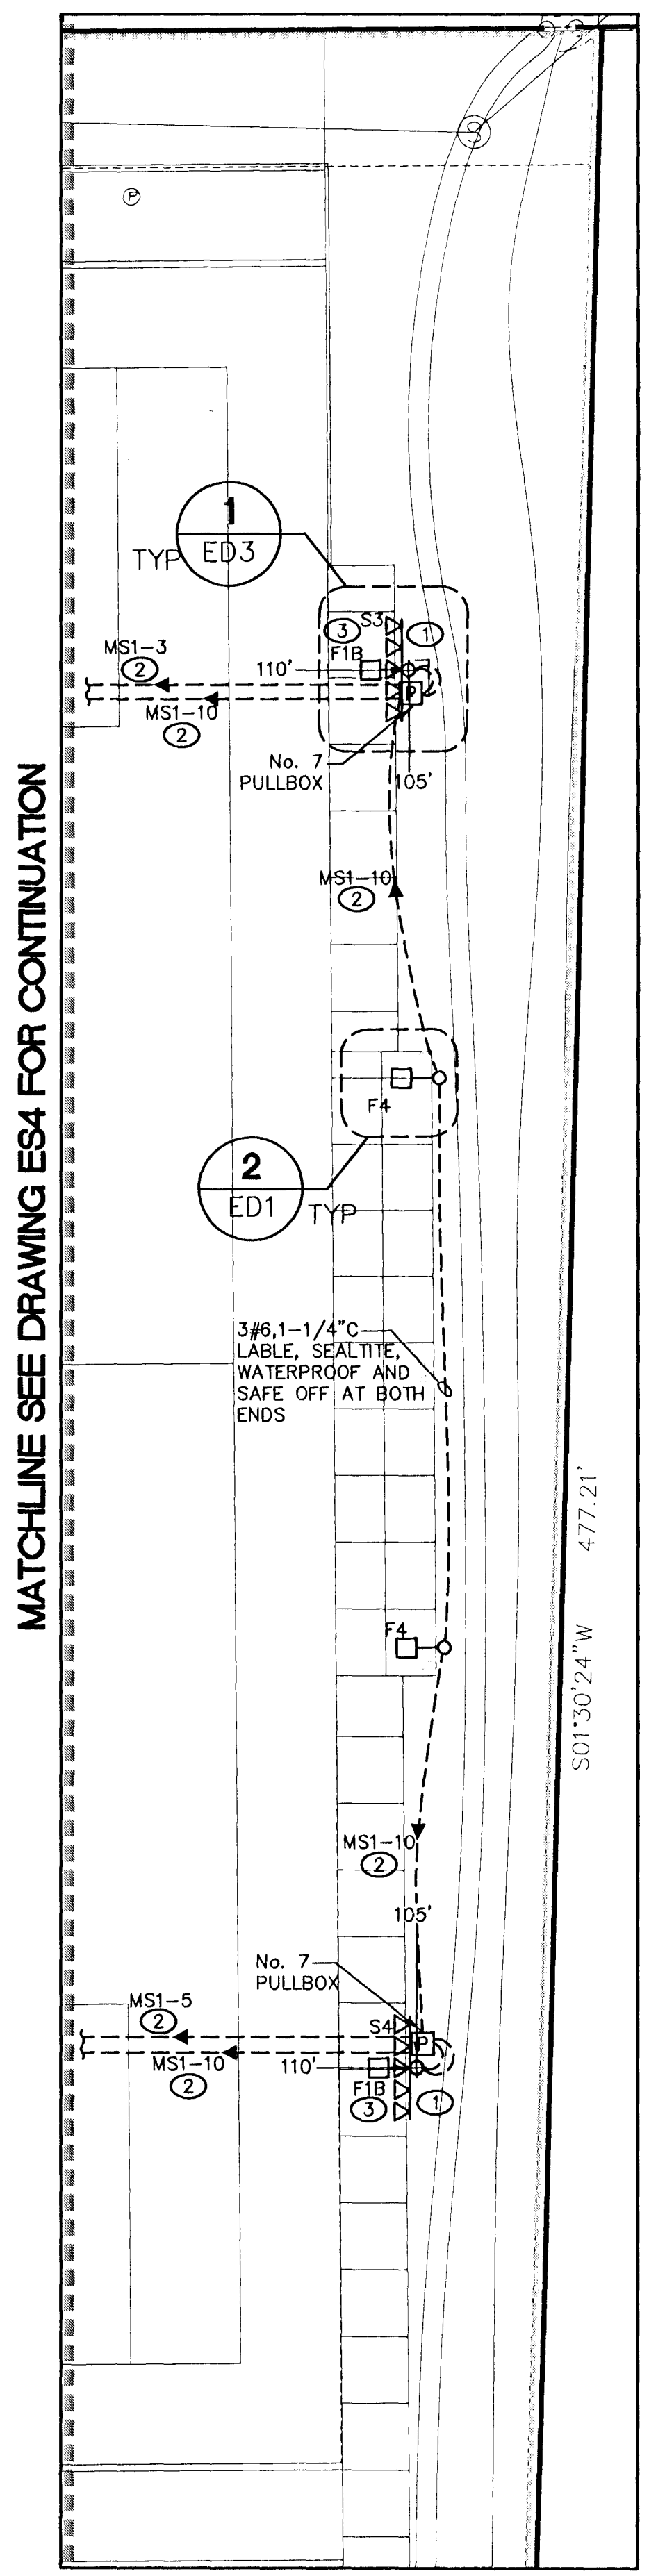

MATCHLINE SEE DRAWING ES4 FOR CONTINUATION


S01°30'24"W 477.21'

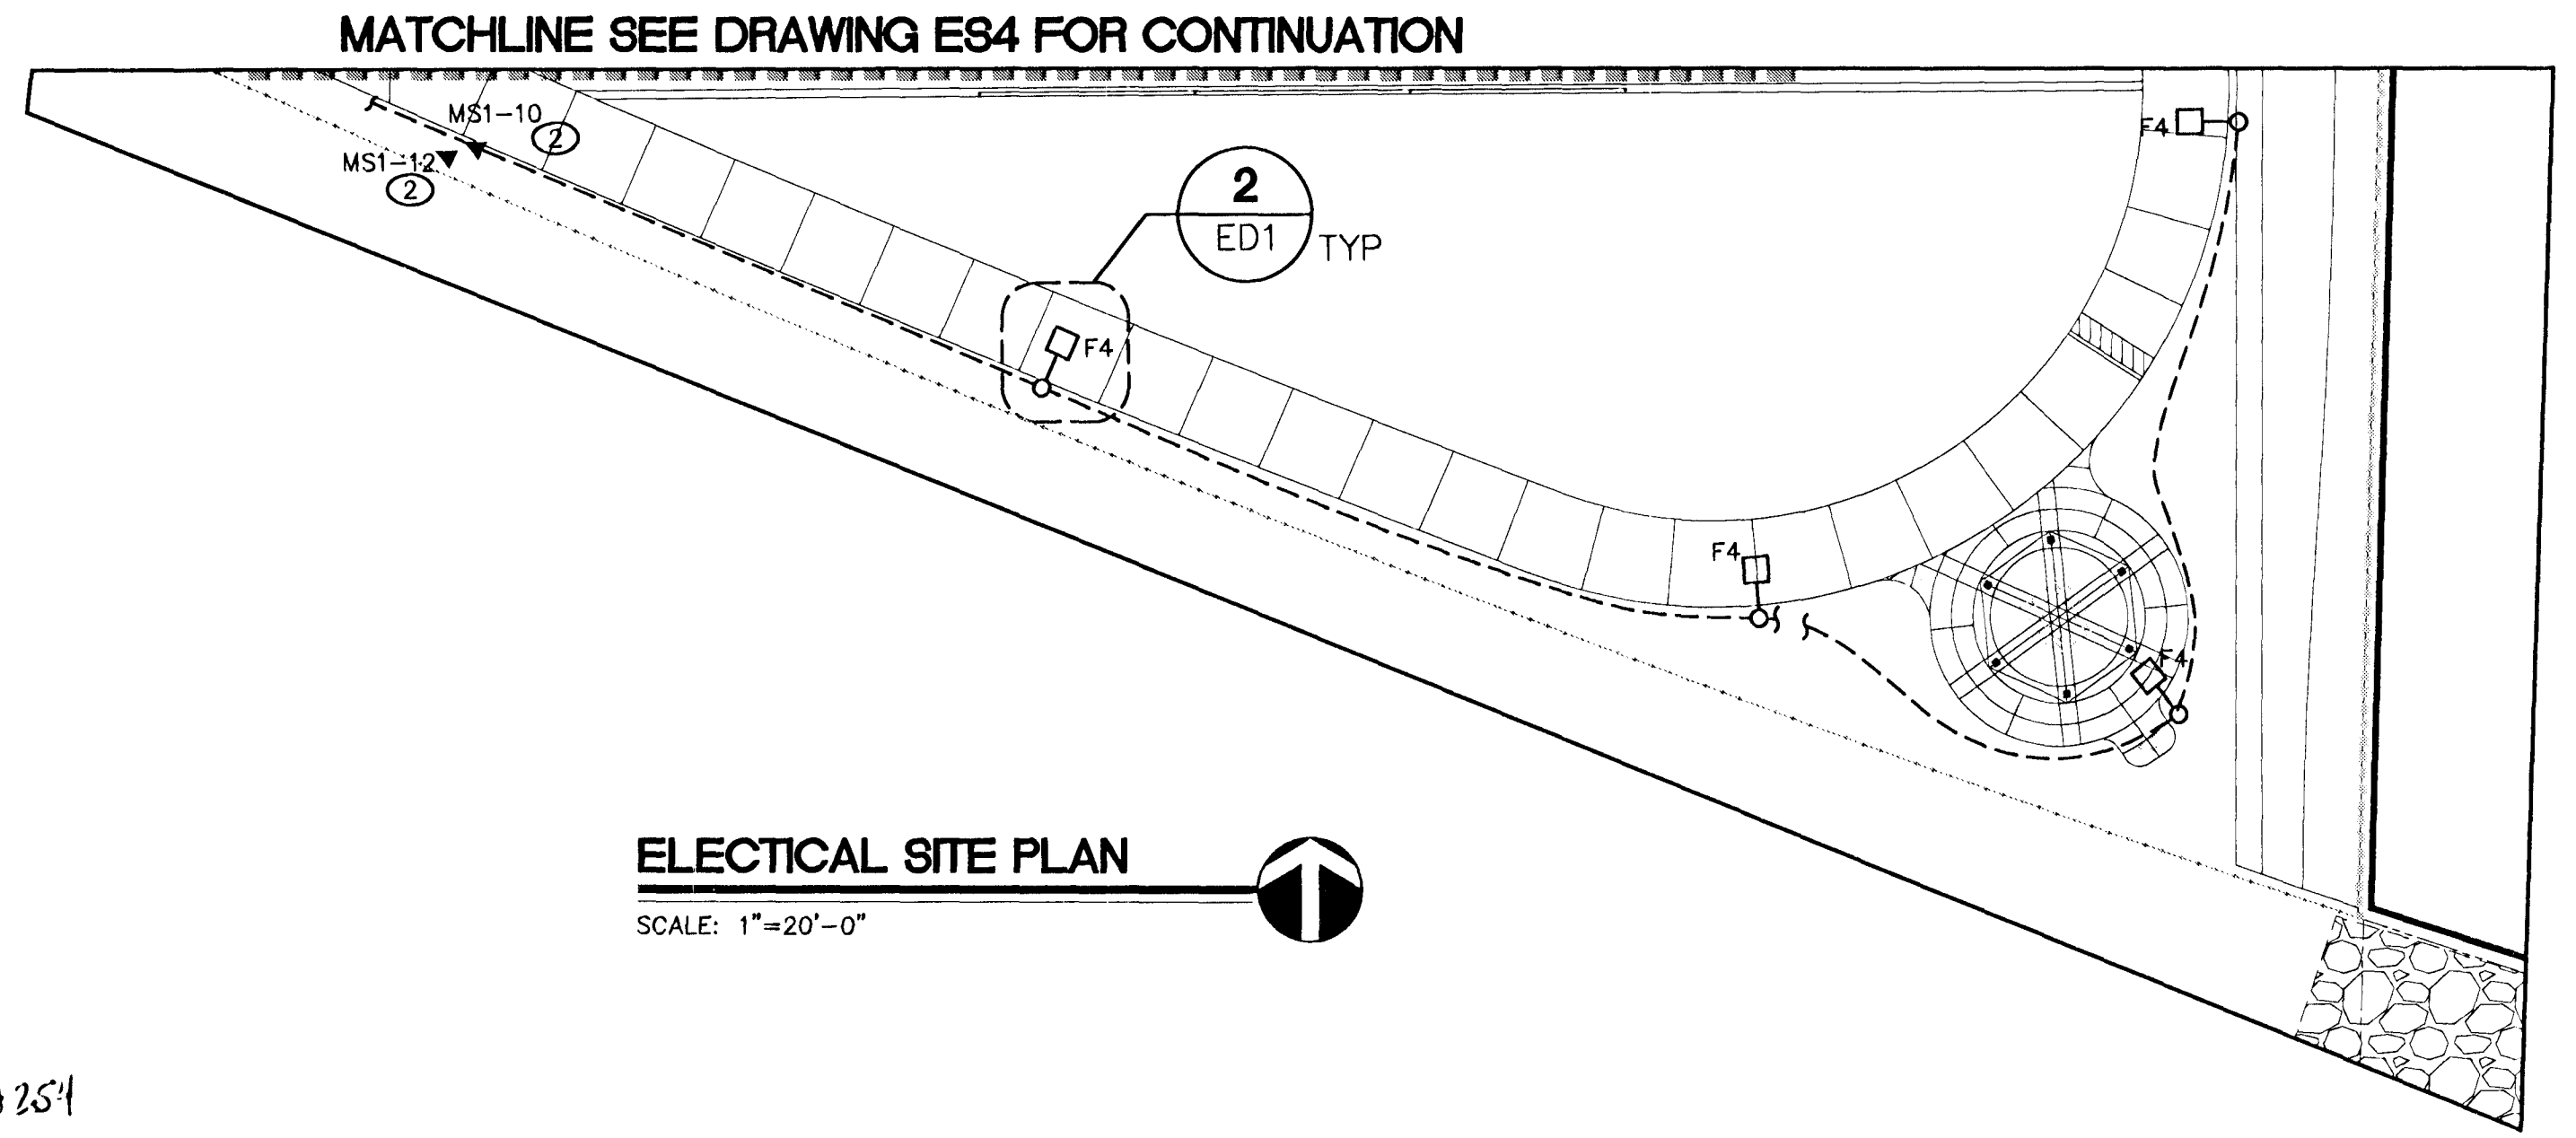


MATCHLINE SEE DRAWING ES4 FOR CONTINUATION

ELECTICAL SITE PLAN
SCALE: 1"=20'-0"

- GENERAL NOTES:**
- 1. ALL PULLBOXES WILL BE NO. 3 1/2 UNLESS NOTED OTHERWISE. GROUNDING PER NEC 250 SEE DETAIL 8/ED1 FOR FURTHER INFORMATION.
 - 2. REFER TO CIVIL DRAWINGS FOR EXACT LOCATION OF POLES.

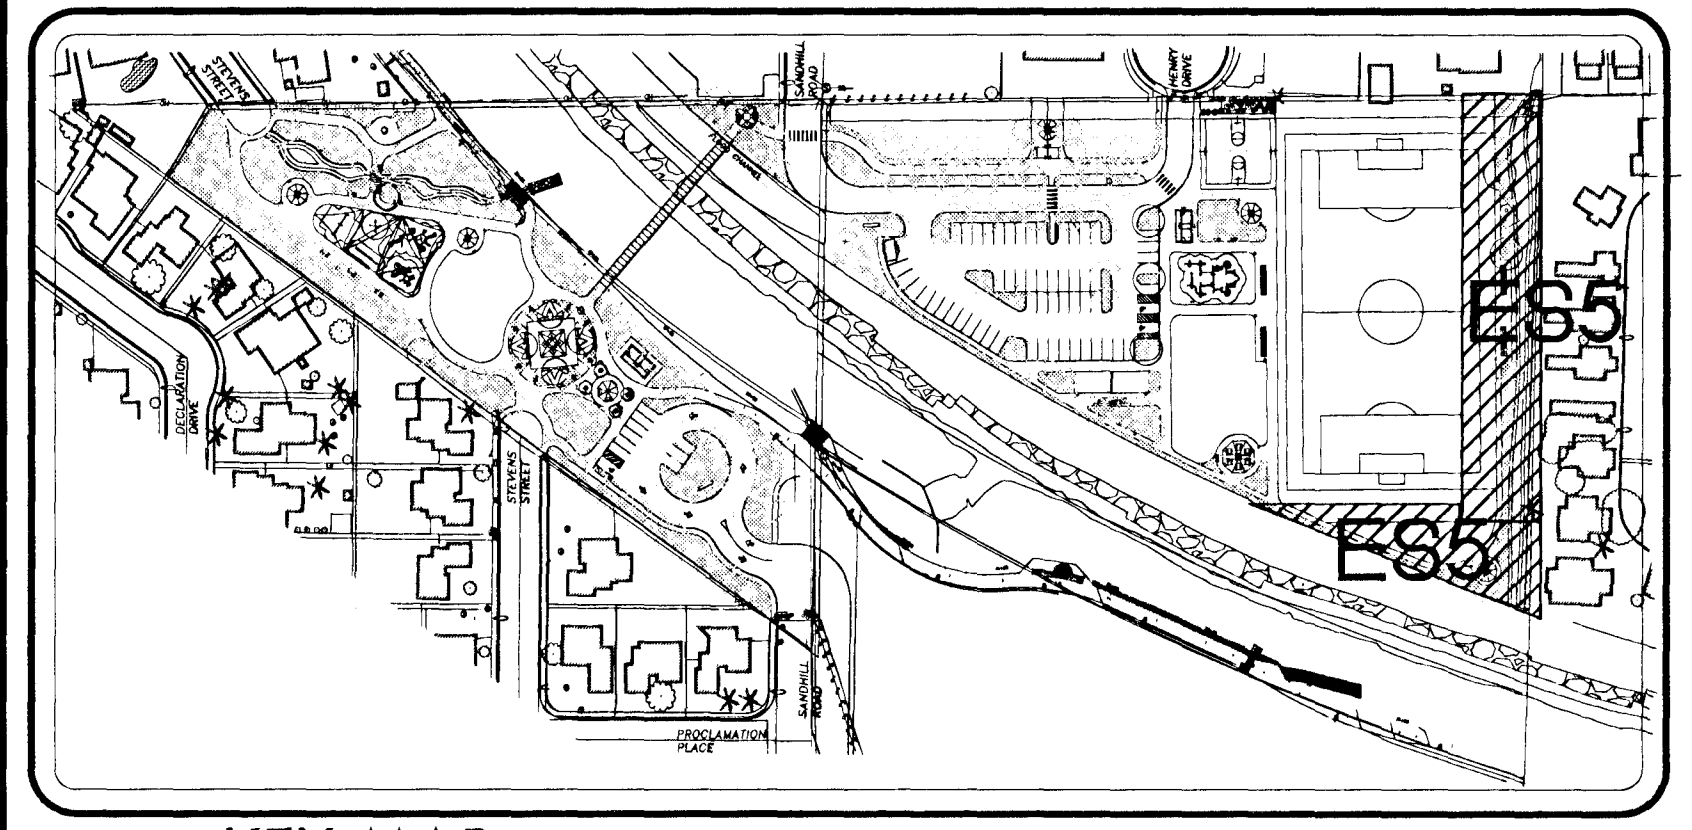

THESE RECORD DOCUMENTS HAVE BEEN PREPARED BASED ON INFORMATION PROVIDED BY OTHERS. THE DESIGN PROFESSIONAL HAS NOT VERIFIED THE ACCURACY AND/OR COMPLETENESS OF THIS INFORMATION AND SHALL NOT BE RESPONSIBLE FOR ANY ERRORS OR OMISSIONS WHICH MAY BE INCORPORATED HEREIN AS A RESULT.

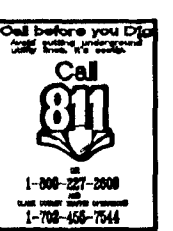

REVISIONS	CONSULTANT
<p>SANDHILL OWENS PARK & TRAILHEAD LAS VEGAS, NEVADA</p> <p>ELECTRICAL SITE PLAN</p>	
DRAWN	DATE
	12/7/2009
FILE	SCALE
	1"=20'
DRAWN	DATE
	12/7/2009
DRAWN	SCALE
	1"=20'
DRAWN	DATE
	12/7/2009
DRAWN	SCALE
	1"=20'
DRAWN	