


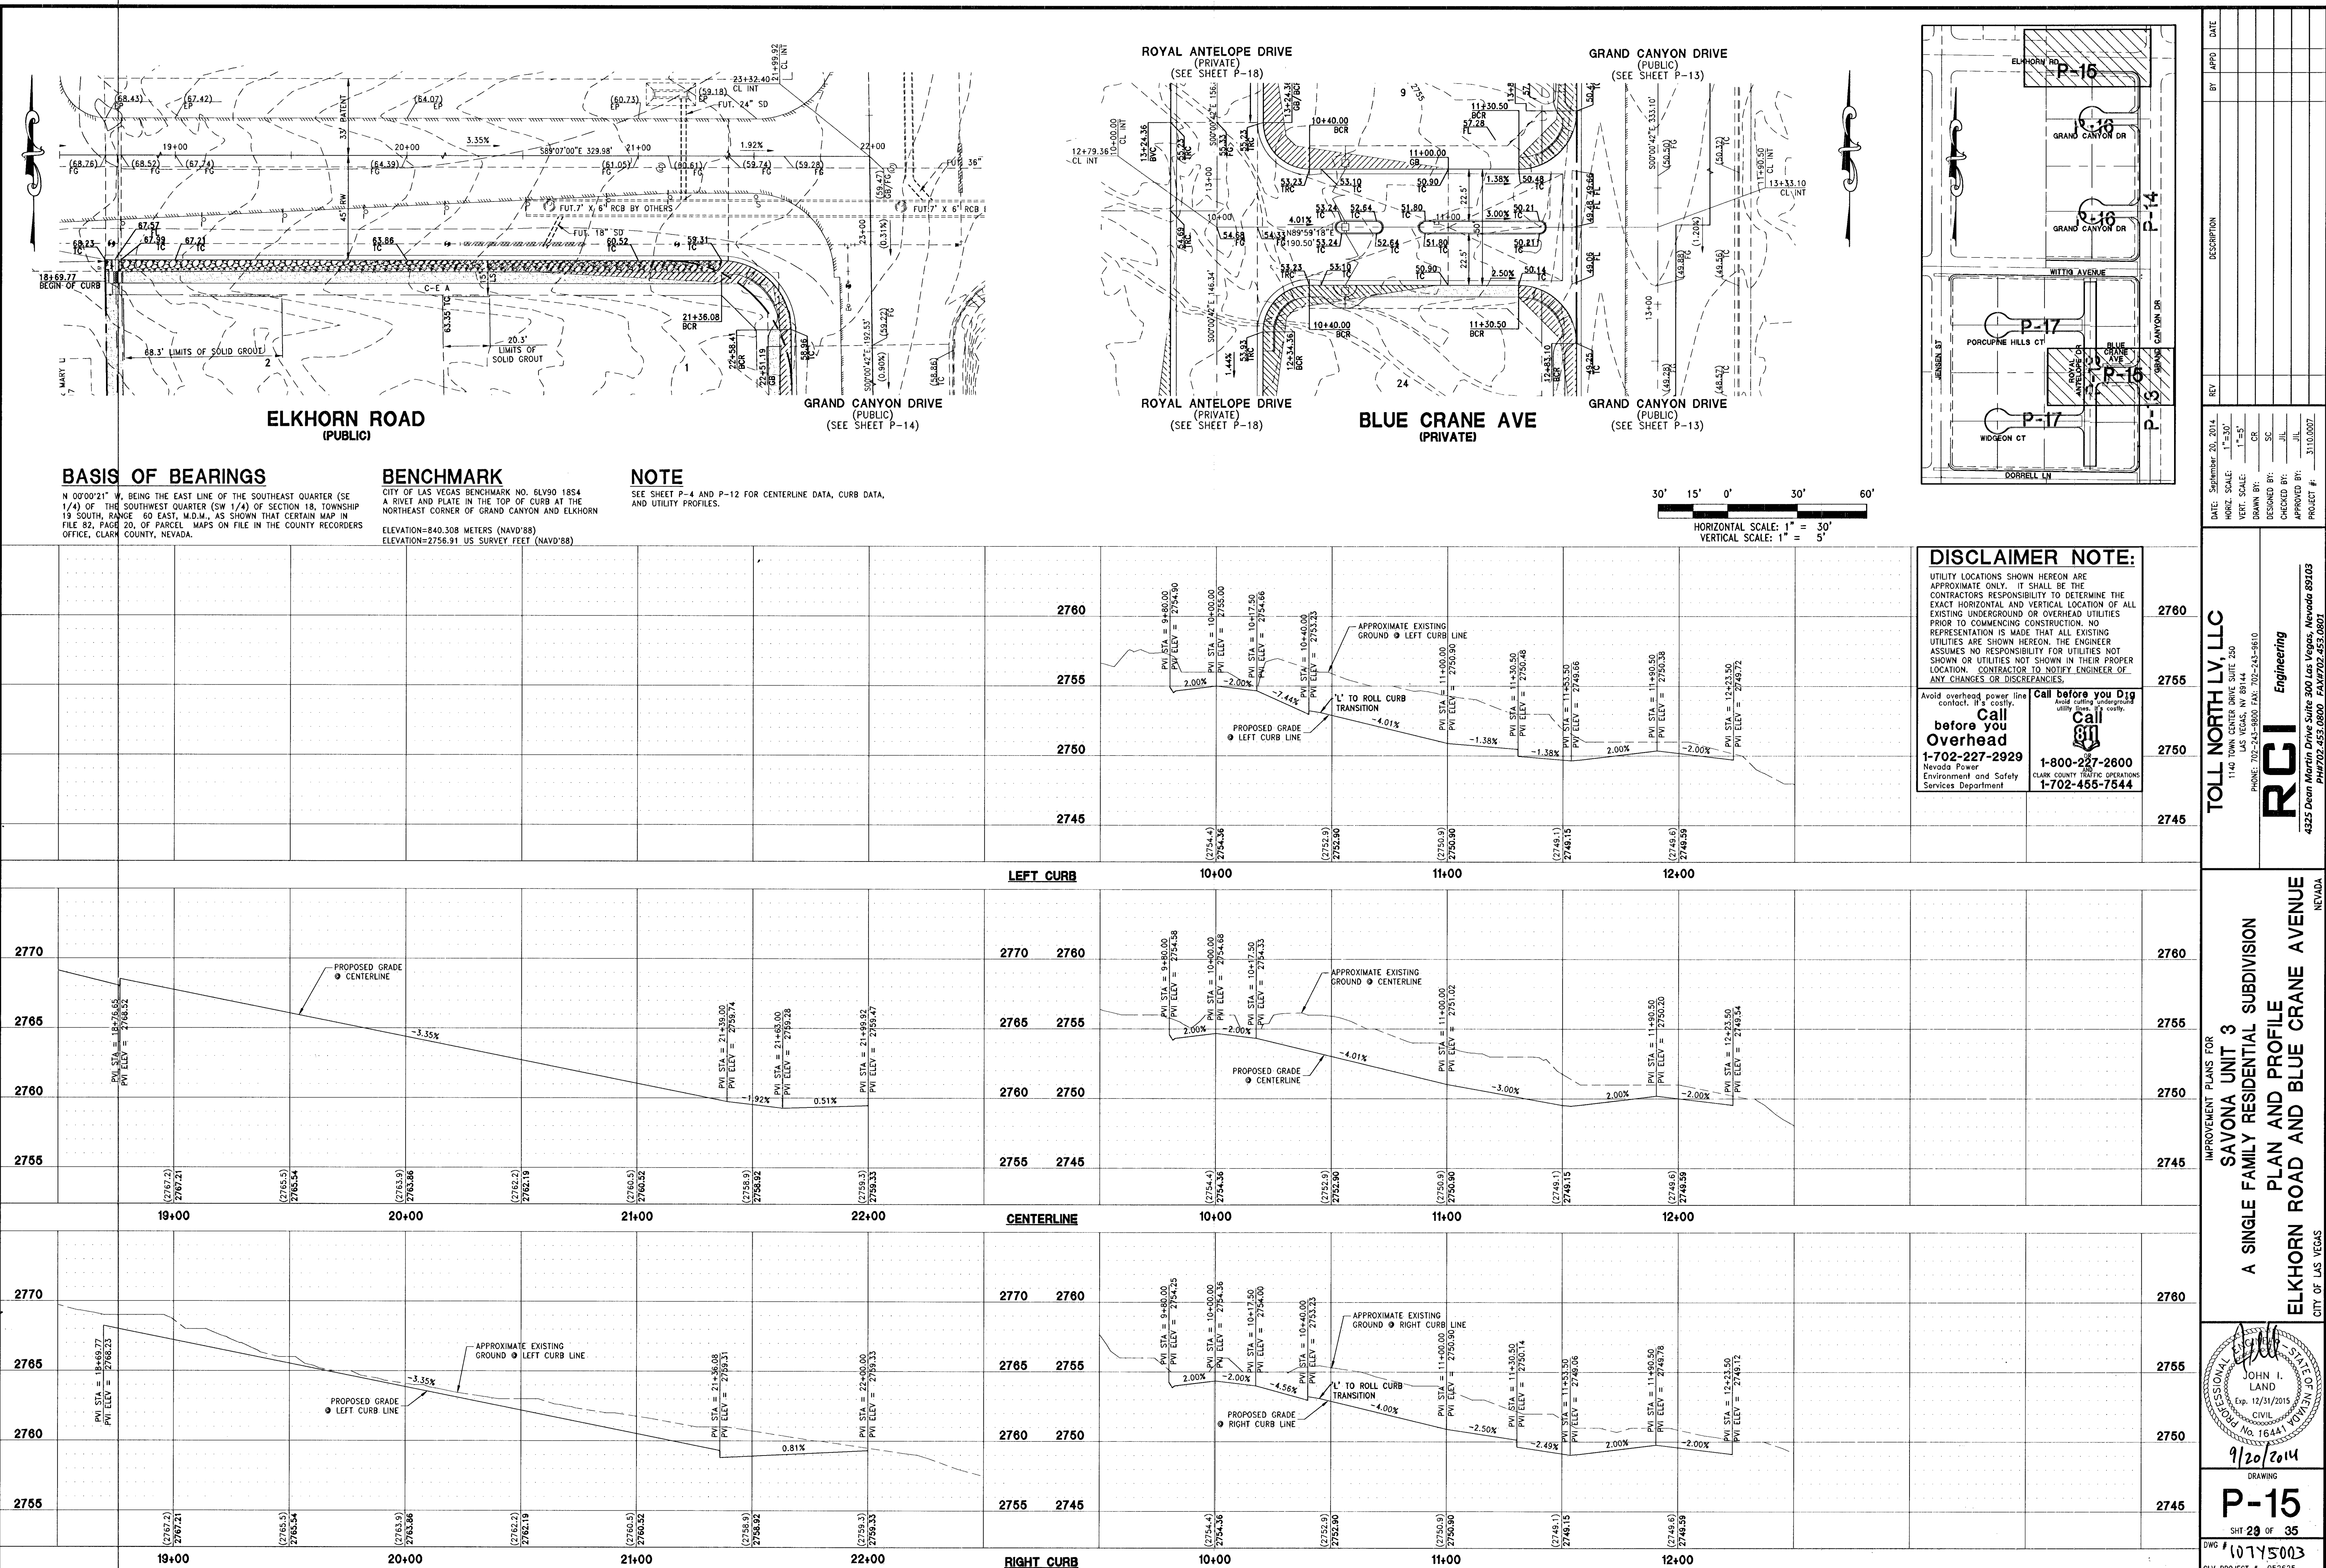

DISCLAIMER NOTE:
UTILITY LOCATIONS SHOWN HEREON ARE APPROXIMATE ONLY. IT SHALL BE THE CONTRACTOR'S RESPONSIBILITY TO DETERMINE THE EXACT HORIZONTAL AND VERTICAL LOCATION OF ALL EXISTING UNDERGROUND OR OVERHEAD UTILITIES PRIOR TO COMMENCING CONSTRUCTION. NO REPRESENTATION IS MADE THAT ALL EXISTING UTILITIES ARE SHOWN HEREON. THE ENGINEER ASSUMES NO RESPONSIBILITY FOR UTILITIES NOT SHOWN OR UTILITIES NOT SHOWN IN THEIR PROPER LOCATION. CONTRACTOR TO NOTIFY ENGINEER OF ANY CHANGES OR DISCREPANCIES.

Avoid overhead power line contact, it's costly.
Call before you Overhead
1-702-227-2929
Nevada Power
Environment and Safety
Services Department

Avoid cutting underground utility lines, it's costly.
Call before you Dig
1-800-227-2600
CLARK COUNTY TRAFFIC OPERATIONS
1-702-455-7544

DATE: September 20, 2014	REV	DESCRIPTION	BY	APPD	DATE
HORIZ. SCALE: 1"=30'					
VERT. SCALE: 1"=5'					
DRAWN BY: CR					
DESIGNED BY: SC					
CHECKED BY: JIL					
APPROVED BY: JIL					
PROJECT #:					

TOLL NORTH LV, LLC
1140 IOWA CENTER DRIVE, SUITE 250
PHOENIX, AZ 85016
PHONE: 702-243-8800 FAX: 702-243-8610

RCI Engineering
4325 Dean Martin Drive Suite 300 Las Vegas, Nevada 89103
PH: 702.453.0800 FAX: 702.453.0801

IMPROVEMENT PLANS FOR
SAVONA UNIT 3
A SINGLE FAMILY RESIDENTIAL SUBDIVISION
PLAN AND PROFILE
ELKHORN ROAD AND BLUE CRANE AVENUE
CITY OF LAS VEGAS
NEVADA

JOHN I. LAND
PROFESSIONAL ENGINEER
Exp. 12/31/2015
CIVIL
No. 16441
9/20/2014
DRAWING
P-15
SHT 29 OF 35
CLV PROJECT # 052625