

STORMWATER RUNOFF MANAGEMENT

(REQUIRED FOR ALL SITES GREATER THAN 1 ACRE (43,560 SQ.FT.))

1. THE OWNER, SITE DEVELOPER, CONTRACTOR AND/OR THEIR AUTHORIZED AGENTS SHALL EACH DAY REMOVE ALL SEDIMENT, MUD, CONSTRUCTION DEBRIS, OR OTHER POTENTIAL POLLUTANTS THAT MAY HAVE BEEN DISCHARGED TO, OR ACCUMULATE IN, THE PUBLIC RIGHTS OF WAYS OF CLARK COUNTY AS A RESULT OF CONSTRUCTION ACTIVITIES ASSOCIATED WITH THIS SITE DEVELOPMENT OR CONSTRUCTION PROJECT. SUCH MATERIALS SHALL BE PREVENTED FROM ENTERING THE STORM SEWER SYSTEM.
2. ADDITIONAL CONSTRUCTION SITE DISCHARGE BEST MANAGEMENT PRACTICES MAY BE REQUIRED OF THE OWNER AND HIS OR HER AGENTS DUE TO UNFOUNDED EROSION PROBLEMS OR IF THE SUBMITTED PLAN DOES NOT MEET THE PERFORMANCE STANDARDS SPECIFIED IN TITLE 24.40 AND THE LAS VEGAS VALLEY CONSTRUCTION SITE BEST MANAGEMENT PRACTICES MANUAL.
3. TEMPORARY OR PERMANENT STABILIZATION PRACTICES WILL BE INSTALLED ON DISTURBED AREAS AS SOON AS PRACTICABLE AND NO LATER THAN 14 DAYS AFTER THE CONSTRUCTION ACTIVITY IN THAT PORTION OF THE SITE HAS TEMPORARILY OR PERMANENTLY CEASED. SOME EXCEPTIONS MAY APPLY. REFER TO NEVADA STORMWATER GENERAL PERMIT FOR CONSTRUCTION ACTIVITY NVRI00000, SECTION III.A.5.
4. AT A MINIMUM, THE CONTRACTOR OR HIS AGENT SHALL INSPECT ALL DISTURBED AREAS, AREAS USED FOR STORAGE OF MATERIALS AND EQUIPMENT THAT ARE EXPOSED TO PRECIPITATION, VEHICLE ENTRANCE AND EXIT LOCATIONS AND ALL BMPs WEEKLY, AND WITHIN 24 HOURS AFTER ANY ACTUAL RAIN EVENT OF 0.5 INCHES OR MORE. THE CONTRACTOR OR HIS AGENT SHALL UPDATE OR MODIFY THE STORMWATER POLLUTION PREVENTION PLAN AS NECESSARY. SOME EXCEPTIONS TO WEEKLY INSPECTIONS MAY APPLY, SUCH AS SUSPENSION OF LAND DISTURBANCE ACTIVITIES. REFER TO NEVADA STORMWATER GENERAL PERMIT FOR CONSTRUCTION ACTIVITY NVRI00000, SECTION III.A.12.
5. ACCUMULATED SEDIMENT IN BMPs SHALL BE REMOVED WITHIN SEVEN DAYS AFTER A STORMWATER RUNOFF EVENT OR PRIOR TO THE NEXT ANTICIPATED STORM EVENT, WHICHEVER IS EARLIER. SEDIMENT MUST BE REMOVED WHEN BMP DESIGN CAPACITY HAS BEEN REDUCED BY 50 PERCENT OR MORE.

LEGAL DESCRIPTION

ALL OF GOVERNMENT LOTS 1, 2, 3, 4, 5, 6, 7, 8, 9, 10, 11, 12, 13, 14, 15 AND 16 OF SECTION 12, TOWNSHIP 19 SOUTH, RANGE 38 EAST, W.D.M., CITY OF LAS VEGAS, CLARK COUNTY NEVADA.

BENCHMARK

USDA BRASS CAP ON AN IRON PIPE, 140' SOUTHWEST OF TELEPHONE POLE #269941, SOUTHWEST CORNER OF THE U.S. 95/KYLE CANYON TURNOFF.

ELEVATION = 2817.62 FEET, 858.813 METERS
N.A.D. 83
PER THE CLARK COUNTY VERTICAL CONTROL LAST REVISED 2003

BASIS OF BEARINGS

SOUTH 00°22'12" WEST, BEING THE BEARING OF THE WEST LINE OF THE NORTHWEST QUARTER (NW1/4) OF SECTION 8, TOWNSHIP 19 SOUTH, RANGE 38 EAST, W.D.M., CITY OF LAS VEGAS, CLARK COUNTY, NEVADA, AS SHOWN BY MAP THEREOF IN FILE 151, PAGE 14 OF SURVEYS IN THE CLARK COUNTY RECORDER'S OFFICE, NEVADA.

2.2 CITY OF LAS VEGAS SEWER NOTES

1. ALL CONSTRUCTION AND MATERIALS SHALL BE IN ACCORDANCE WITH THE LATEST EDITION OF THE DESIGN AND CONSTRUCTION STANDARDS FOR WASTEWATER COLLECTION SYSTEMS AND THE UNIFORM STANDARD SPECIFICATIONS FOR PUBLIC WORKS' CONSTRUCTION OFF-SITE IMPROVEMENTS, CLARK COUNTY AREA, NEVADA, AS AMENDED. IT WILL BE THE RESPONSIBILITY OF THE CONTRACTOR TO BE AWARE OF THE CONTENTS OF THE ABOVE SPECIFICATIONS.
2. IT SHALL BE THE CONTRACTOR'S RESPONSIBILITY TO PERFORM CONSTRUCTION AS PER PLANS, ANY ADDITIONS, DELETIONS, OR CHANGES SHALL FIRST MEET WITH THE APPROVAL OF THE CITY ENGINEER.
3. CHISEL "S" OR "G" IN CURBS WHERE SEWER OR GAS LATERALS PASS UNDER THE CURB.
4. POLYVINYL (PVC) SEWER PIPE SHALL MEET ASTM D-3034 SDR 35 SPECIFICATIONS, INSTALLED WITH SAND BEDDING AND BACKFILL OF TYPE II AGGREGATE BASE.
5. ALL MANHOLES PAVED IN STREETS EIGHTY (80') FOOT R/W AND LARGER SHALL HAVE CONCRETE COLLARS. STREETS LESS THAN EIGHTY (80') FOOT R/W WILL REQUIRE RETROFIT IF PAVING DOES NOT CONFORM TO CITY STANDARDS AT THE MANHOLE.
6. TEE SADDLES SHALL BE USED TO CONNECT SEWER LATERALS TO EXISTING MAIN LINES UP TO TWELVE (12") INCH (12") DIAMETER, CONNECTIONS TO FIFTEEN INCH (15") OR LARGER MAINS SHALL REQUIRE SPECIAL PROCEDURES. IN LINE "Y" 'S SHALL BE USED ON LINES TWELVE INCHES (12") OR ABOVE.
7. WATER MAINS SHALL BE PROTECTED IN ACCORDANCE WITH LVVMD STANDARDS WHENEVER A SEWER MAIN CROSSES OVER A WATER MAIN OR THE SEWER IS LESS THAN EIGHTEEN INCH (18") UNDER A WATER MAIN.
8. ALL CONTRACTORS INSTALLING SEWER MAINS THAT WILL BE UNDER THE JURISDICTION OF THE CITY OF LAS VEGAS MUST BE STATE OF NEVADA CLASS "A" CONTRACTORS.
9. THE CITY OF LAS VEGAS WILL NOT ACCEPT ANY SEWER MAINS WHICH HAVE A VERTICAL DEFLECTION OF MORE THAN ONE TENTH (0.1) OF A FOOT FROM THE APPROVED CONSTRUCTION PLANS AT ANY LOCATION. SEWER MAINS FOUND TO EXCEED THIS TOLERANCE WILL HAVE TO BE REPAIRED OR REMOVED OR REDUCED TO THE SATISFACTION OF THE CITY ENGINEER PRIOR TO ACCEPTANCE BY THE CITY OF LAS VEGAS.
10. INSTALLATION OF CURVED SEWER REQUIRES THE USE OF C-900 PIPE WHICH ALLOWS FOR PIPE DEFLECTION AT THE JOINTS.

LAS VEGAS VALLEY WATER DISTRICT (LVVWD) STANDARD NOTES

LVVMD PROJECT # 125227 (REVISED 01/09/2017)

1. NO WORK SHALL BEGIN UNTIL THE WATER PLANS HAVE BEEN APPROVED FOR CONSTRUCTION BY THE LVVMD. FOLLOWING WATER PLAN APPROVAL, NOTICE SHALL BE GIVEN TO THE LVVMD COMMUNICATION SUPPORT CENTER (258-7171) TWO (2) WORKING DAYS PRIOR TO THE START OF CONSTRUCTION. FOR FUTURE INSPECTIONS, NOTICE MUST BE GIVEN BY 2:00 P.M. THE BUSINESS DAY PRIOR TO THE REQUESTED LVVMD INSPECTION. WHEN REQUESTING INSPECTIONS, PLEASE REFER TO THE PROJECT # IDENTIFIED ABOVE.
2. ALL WORK SHALL CONFORM TO LVVMD STANDARD PLANS, DRAWINGS, AND SPECIFICATIONS, AND TO THE 2010 EDITION OF THE UNIFORM STANDARD SPECIFICATIONS FOR POTABLE WATER SYSTEMS (UDSAS). THE LATEST EDITION OF UDSAS SHALL SUPERSEDE ANY CONFLICTS CONTAINED IN THE APPROVED DRAWINGS AND/OR SPECIFICATIONS.
3. ALL WORK, EXCEPT AS MODIFIED BY THESE PLANS OR BY NOTE 2 ABOVE, SHALL BE DONE IN ACCORDANCE WITH THE MOST RECENT DRAFT OR EDITION OF THE UNIFORM STANDARD SPECIFICATIONS FOR PUBLIC WORKS CONSTRUCTION OFFSITE IMPROVEMENT, CLARK COUNTY AREA.
4. A SINGLE PIPE MATERIAL SHALL BE USED THROUGHOUT THE PROJECT UNLESS OTHERWISE APPROVED BY THE LVVMD.
5. ALL SERVICE LATERALS TWO (2) INCHES IN DIAMETER AND SMALLER SHALL BE TYPE K COPPER TUBING WITH LVVMD APPROVED SERVICE SADDLES.
6. ALL WATER METER BOXES SHALL BE LOCATED OUTSIDE OF DRIVEWAY AREAS.
7. ALL VALVES SHALL BE LOCATED OUTSIDE OF DRIVEWAYS, VALLEY AND CURB GUTTERS.
8. ALL WATER AND STORM DRAIN OR SANITARY SEWER CROSSEINGS SHALL CONFORM TO SECTION 2.22 OF THE 2010 EDITION OF THE UDSAS.
9. ALL WATER FACILITIES SHALL BE FILLED, DISINFECTED, PRESSURE TESTED, FLUSHED, FILLED, AND AN ACCEPTABLE WATER SAMPLE OBTAINED, PRIOR TO CONNECTION TO THE LVVMD DISTRIBUTION SYSTEM.
10. THE CONTRACTOR MUST OBTAIN ALL METERS TWO (2) INCHES AND SMALLER FROM LVVMD CENTRAL STORES. TELEPHONE 258-3152 OR 258-3602, TWO (2) WORKING DAYS PRIOR TO METER PICKUP.
11. ANY INTERRUPTION OF SERVICE MUST BE PERFORMED IN ACCORDANCE WITH UDSAS SECTION 3.14.01, AND APPROVED BY THE LVVMD INSPECTION DIVISION PRIOR TO SHUTDOWN. PROPER WRITTEN NOTIFICATION MUST BE GIVEN TO ALL AFFECTED CUSTOMERS.
12. ALL WATER FACILITY CONSTRUCTION MATERIALS USED MUST BE AS LISTED ON THE LVVMD PRE-APPROVED MATERIALS AND MANUFACTURER'S LISTING FOR NEW FACILITIES. LATEST REVISION, OR SPECIFICALLY APPROVED ON THESE PLANS.
13. TELEPHONE "CALL BEFORE YOU DIG" AT "811" OR 1-800-227-2600.
14. THE INSTALLATION OF LAS VEGAS VALLEY WATER DISTRICT (LVVMD) MUNICIPAL WATER FACILITIES WITHIN ALL STREETS IS ASSUMED TO BE IN COMPLIANCE WITH THE UNIFORM STANDARDS, INCLUDING THE PLACEMENT OF ASPHALT PAVING STREET SURFACES. ANY REPAIR WORK DONE BY THE LVVMD TO THE MUNICIPAL WATER FACILITIES WILL INCLUDE THE PLACEMENT OF AN APPROPRIATELY SIZED ASPHALT REPAIR PATCH ON THE STREET SURFACE.

ANY DECORATIVE PAVING SURFACE WITHIN THE STREET IS THE RESPONSIBILITY OF THE OWNER'S ASSOCIATION, OR THE INDIVIDUAL PROPERTY OWNERS IF NO OWNER'S ASSOCIATION IS IN EXISTENCE, OR THE AGENCY HAVING JURISDICTION. DECORATIVE SURFACE MATERIALS PLACED WITHIN THE TEN FOOT EASEMENT ADJUTING A PUBLIC OR PRIVATE STREET, IF DISTURBED BY THE LVVMD DURING THE REPAIR OR OPERATION OF ITS FACILITIES, WILL BE REPLACED BY LVVMD WITH AN APPROPRIATELY SIZED PLAIN FINISH CONCRETE PATCH. THE LVVMD WILL NOT RESTORE, AND WILL NOT BE RESPONSIBLE FOR THE RESTORATION OF, ANY DECORATIVE PAVING SURFACE WITHIN THE STREET. THE LVVMD WILL NOT ATTEMPT TO MATCH COLOR OR FINISH OF ANY ADJACENT MATERIALS.

15. NO LEAD COMPLIANCE NOTE:
TO COMPLY WITH THE FEDERAL SAFE DRINKING WATER ACT, ALL WATER WORKS BRASS PRODUCTS PROPOSED TO BE RELOCATED OR INSTALLED AS NEW MUST BE INSTALLED WITH THE LEAD FREE APPROVED PRODUCT. THE OLD LEADED PRODUCT MAY NOT BE USED.

GRADING NOTES

1. INDICATED GRADES OTHER THAN T.C., F.G. & GUTTER F.L. ARE ROUGH GRADES.
2. THE ROUGH GRADING PLANS SHALL BE ON THE JOB SITE AT ALL TIMES. THE ROUGH GRADING SHALL BE FINISHED IN CONFORMANCE WITH THE LINES AND GRADES SHOWN ON THE PLANS. THE GRADING QUANTITIES ARE BASED ON THE ELEVATION AND DETAILS SHOWN ON THE PLANS. ANY DEVIATIONS FROM THE PLANS WILL RESULT IN QUANTITY CHANGES.
3. CARE SHALL BE EXERCISED IN GRADING CORNER LOTS.
4. ROUGH PAD ELEVATIONS SHALL BE GRADED TO WITHIN 0.1' OF THE PAD ELEVATIONS SHOWN ON THE PLANS. WHEN GRADING IS COMPLETE PER THE PLANS, THE CONTRACTOR SHALL NOTIFY THE ENGINEER SO THAT THE CAN BE INSPECTED. AT THAT TIME THE ENGINEER SHALL ALSO DECIDE IF ANY ADDITIONAL DITCHES OR BERMS ARE REQUIRED. THE CONTRACTOR IS REQUESTED NOT TO REMOVE ANY OF HIS ROUGH GRADING EQUIPMENT UNTIL HE RECEIVES GRADING APPROVAL FROM THE ENGINEER.
5. SOILS REPORT PREPARED BY GEOTECH, INC., PROJECT NO. 13245-LV, DATED DECEMBER 5, 2016.
6. EARTHWORK QUANTITIES (RAW):
- CUT = 30,666 CUBIC YARDS
- FILL = 43,578 CUBIC YARDS

A) THE ABOVE QUANTITIES DO NOT REFLECT LOSSES DUE TO SUBSIDENCE OR SHRINKAGE.
B) THE ABOVE QUANTITIES DO REFLECT USING NATIVE MATERIAL IN LIEU OF TYPE I GRAVEL BASE MATERIAL FOR STREET SECTIONS.
C) THE ABOVE QUANTITIES DO NOT REFLECT ANY EARTHWORK WHICH MAY BE REQUIRED BY THE ENGINEER TO CONSTRUCT ADDITIONAL PROTECTIVE DITCHES OR BERMS NOT SHOWN ON THESE DRAWINGS.

CITY OF LAS VEGAS FIRE AND RESCUE GENERAL NOTES

1. ALL WORK SHALL BE DONE IN STRICT ACCORDANCE WITH THE LAS VEGAS FIRE AND RESCUE ADOPTED FIRE CODE ORDINANCE # 8325, FOR HYDRANT SPECIFICATIONS, AND HYDRANT INSTALLATION SPECIFICATIONS.
2. ONLY FIRE HYDRANTS THAT ARE ON THE LAS VEGAS VALLEY WATER DISTRICTS - **APPROVED PRODUCTS LIST** ARE ALLOWED TO BE INSTALLED.
3. A PERMIT IS REQUIRED FROM LAS VEGAS FIRE AND RESCUE FOR ALL INSTALLATION OF ON-SITE WATER LINES AND FIRE HYDRANTS. THE PERMIT AND CONTRACTORS MATERIAL TEST CERTIFICATE FOR UNDERGROUND PIPING FORM SHALL BE OBTAINED FROM THE FIRE PROTECTION ENGINEER BEFORE COMMENCEMENT OF WORK. [FC 105.7.12]
4. ON ANY RESIDENTIAL OR COMMERCIAL INSTALLATIONS, FIRE HYDRANTS SHALL BE INSTALLED AND FIRE APPARATUS ACCESS ROADS SHALL BE MAINTAINED BEFORE COMMENCEMENT OF ANY COMBUSTIBLE CONSTRUCTION. ALL FIRE HYDRANTS SHALL BE IN GOOD WORKING ORDER AND SHALL BE CAPABLE OF DELIVERING THE REQUIRED FIRE FLOW. [FC 310, 3312]
5. TO IDENTIFY THE FIRE HYDRANT LOCATIONS, THE CONTRACTOR SHALL PLACE A BLUE REFLECTIVE MARKER AT THE CENTER LINE OF THE STREET ADJACENT TO THE FIRE HYDRANTS. [FC 507.5.7.3]
6. ALL UNDERGROUND INSPECTIONS, PRESSURE AND FLUSH VERIFICATIONS OF ALL FIRE HYDRANTS AND FIRE LINES, SHALL BE CONDUCTED BEFORE COVERING THE LINES. CENTER LOADING IS ACCEPTABLE FOR THE HYDRO TESTS WITH PRIOR FIRE PREVENTION APPROVAL. [FC 106.3]
7. ALL ON-SITE UNDERGROUND WATER MAINS AND MATERIALS SHALL BE U.L. LISTED, A.W.W.A APPROVED AND SHALL BE RATED FOR THE APPROPRIATE WORKING PRESSURE. [FC 507.2.1, NFPA 24]
8. PAINTING OF CURBS, FIRE HYDRANTS, PADS, PROTECTION OF FIRE HYDRANTS FROM PHYSICAL DAMAGE, AND ALL OTHER WORK NECESSARY PER PLANS SHALL BE COMPLETED BEFORE APPROVAL BY LAS VEGAS FIRE AND RESCUE, FIRE PREVENTION DIVISION. [FC 507]
9. PRIVATE HYDRANTS SHALL BE PAINTED RED. [FC 507.5.7.1]
10. PRIOR TO THE FINAL OCCUPANCY, A FIRE FLOW TEST SHALL BE WITNESSED BY LAS VEGAS FIRE AND RESCUE, FIRE PREVENTION DIVISION TO VERIFY AVAILABILITY OF THE REQUIRED FIRE FLOW. [FC 507]
11. FIRE HYDRANT SPACING SHALL BE AS FOLLOWS: [FC C102]
- RESIDENTIAL - 500 FT UNSPRINKLERED; 600 FT SPRINKLERED.
- COMMERCIAL - 300 FT UNSPRINKLERED; 400 FT SPRINKLERED.
12. WHERE NEW WATER MAINS ARE EXTENDED ALONG STREETS OR NEW STREETS ARE INSTALLED WHERE FIRE HYDRANTS ARE NOT NEEDED FOR PROTECTION OF THE STRUCTURES, FIRE HYDRANTS SHALL BE INSTALLED AT A MAXIMUM OF 1,000 FOOT SPACING, TO PROVIDE FOR TRANSPORTATION HAZARDS, WHERE STREETS ARE PROVIDED WITH MEDIAN DIVIDERS OR HAVE FOUR (4) OR MORE TRAFFIC LANES AND HAVE A TRAFFIC COUNT OF MORE THAN 30,000 PER DAY. HYDRANTS ARE REQUIRED ON EACH SIDE OF THE STREET SPACED AT 500 FT ON AN ALTERNATING BASIS. [FC C102.8]
13. NO FIRE HYDRANTS SHALL BE LOCATED WITHIN THE RADIIUS OF A CURB-DE-SAC OR WITHIN 20 FEET OF THE PERIMETER OF THE RADIIUS OF THE CUL-DE-SAC.
14. NO FIRE HYDRANTS SHALL BE LOCATED WITHIN 6 FT OF ANY CURB RETURN, DRIVEWAY, POWER POLE, STREETLIGHT OR ANY OTHER OBSTRUCTION. [FC C102.12]
15. A MAXIMUM DISTANCE FROM A FIRE HYDRANT TO A ONE-TWO FAMILY DWELLING SHALL NOT EXCEED 300 FT, AS MEASURED BY AN APPROVED ROUTE. [FC C102.4]
16. THE MAXIMUM DISTANCE FROM A FIRE HYDRANT TO A FIRE DEPARTMENT CONNECTION (FDC) SHALL NOT EXCEED 100 FT, AS MEASURED BY AN APPROVED ROUTE. [FC C102.7]
17. THE MAXIMUM DISTANCE FROM A HYDRANT TO THE END OF A DEAD-END STREET SHALL NOT EXCEED 200 FT. [FC C102.6]
18. TWO (2) SOURCES OF SUPPLY ARE REQUIRED WHENEVER THERE ARE 4 OR MORE FIRE HYDRANTS/SPRINKLER HEADS ARE INSTALLED ON A SINGLE SYSTEM. SECTIONAL CONTROL VALVES SHALL BE INSTALLED SO THAT NO MORE THAN 2 FIRE HYDRANTS CAN BE OUT OF SERVICE DUE TO A BREAK IN A WATER MAIN. [FC C104]
19. ALL FIRE APPARATUS ACCESS ROADS SHALL BE PAVED TO PROVIDE ALL WEATHER DRIVING CAPABILITIES, AND SHALL BE DESIGNED AND MAINTAINED TO SUPPORT THE IMPOSED LOADS OF THE FIRE APPARATUS. [FC 503.2.3]
20. THE GRADIENT FOR THE FIRE APPARATUS ACCESS ROADS SHALL NOT EXCEED 12% ANGLES OF APPROACH AND ANGLES OF DEPARTURE SHALL NOT EXCEED 6% FOR 25 FEET PRIOR TO OR AFTER THE GRADE CHANGE. ADJACENT TO THE STRUCTURES GRADIENT SHALL NOT EXCEED 6%. [FC 503.2.7, 503.2.8]
21. THE TURNING RADIIUS OF THE FIRE APPARATUS ACCESS ROADS SHALL BE NO LESS THAN 52 FEET OUTSIDE AND 28 FEET INSIDE TURNING RADIIUS. [FC 503.2.4]
22. VERTICAL CLEARANCE OF ALL FIRE APPARATUS ACCESS ROADS SHALL NOT BE LESS THAN 13 FT 6 IN. [FC 503.2.1]
23. FIRE DEPARTMENT ACCESS ROADS SHALL HAVE A MINIMUM UNOBSTRUCTED WIDTH OF NOT LESS THAN 40 FT. FLOW LINE TO FLOW LINE WITH PARALLEL PARKING PERMITTED ON BOTH SIDES. NOT LESS THAN 32 FT MIN. FLOW LINE TO FLOW LINE, WHERE PARKING IS PERMITTED ONLY ON ONE SIDE OF THE FIRE APPARATUS ACCESS ROAD. NOT LESS THAN 24 FT MIN. FLOW LINE TO FLOW LINE, WHERE NO PARKING IS PERMITTED ON EITHER SIDE. FIRE LANES THROUGH PARKING LOTS SHALL BE NOT LESS THAN 24 FT. [FC 503.2.1.1]
24. A FIRE APPARATUS ACCESS ROAD SHALL BE REQUIRED WHEN ANY PORTION OF AN EXTERIOR WALL OF THE FIRST STORY IS LOCATED MORE THAN 150 FT FROM A FIRE DEPARTMENT VEHICLE ACCESS. THE DISTANCE COULD BE INCREASED TO 250 FT IF THE BUILDING IS SPRINKLERED. [FC 503.1.1]
25. APPROVED SECONDARY FIRE APPARATUS ACCESS SHALL BE PROVIDED FOR 100 OR MORE DWELLING UNITS (ROADS) WITH DEAD-ENDS OR WITH A SINGLE POINT OF ACCESS IN EXCESS OF 600 FT. COMMERCIAL AND INDUSTRIAL DEVELOPMENTS WHERE BUILDINGS EXCEED 2 STORES OR 30 FEET IN HEIGHT, OR EXCEEDING 62,000 SQUARE FEET IN AREA. [FC 503.1.2]
26. ALL DEAD-END FIRE APPARATUS ROADS AND/OR FIRE LANES, PUBLIC OR PRIVATE, IN EXCESS OF 150 FT IN LENGTH SHALL BE PROVIDED WITH AN APPROVED TURN AROUND HAVING A MINIMUM DIAMETER OF 81 FT. [FC 503.2.5]
27. ALL FIRE APPARATUS ACCESS ROADS SHALL BE MARKED BY PLACING APPROVED SIGNS AT THE START OF THE DESIGNATED FIRE LANE. ONE SIGN AT THE END OF THE FIRE LANE AND WITH SIGNS AT INTERVALS OF 100 FEET ALONG THE DESIGNATED FIRE LANES. SIGNS TO BE PLACED ON BOTH SIDES OF AN ACCESS ROADWAY IF NEEDED TO PREVENT PARKING ON EITHER SIDE. SIGNS TO BE INSTALLED NO HIGHER THAN 10 FEET OR LESS THAN 6 FEET FROM THE ROADWAY LEVEL. THE CURB ALONG OR ON THE PAVEMENT OR CEMENT (IF NO CURB IS PROVIDED) SHALL BE PAINTED WITH A RED WEATHER RESISTANT PAINT IN ADDITION TO THE SIGNS. [FC 503.3]
28. ELECTRICALLY CONTROLLED ACCESS GATES SHALL BE PROVIDED WITH AN APPROVED EMERGENCY VEHICLE DETECTOR/RECEIVER SYSTEM. SAID SYSTEM SHALL BE INSTALLED IN ACCORDANCE WITH THE FC 503.6 AND FC APPENDIX M.

2.5 CITY OF LAS VEGAS GRADING NOTES

1. IN THE EVENT THAT ANY UNFORESEEN CONDITIONS NOT COVERED BY THESE NOTES ARE ENCOUNTERED DURING GRADING OPERATIONS, THE OWNER/ENGINEER SHALL BE IMMEDIATELY NOTIFIED FOR DIRECTION.
2. IT SHALL BE THE RESPONSIBILITY OF THE CONTRACTOR TO PERFORM ALL NECESSARY CUTS AND FILLS WITHIN THE LIMITS OF THIS PROJECT AND THE RELATED OFF-SITE WORK, SO AS TO GENERATE THE DESIRED SUBGRADE, FINISH GRADES AND SLOPES SHOWN.
3. THE CONTRACTOR SHALL TAKE FULL RESPONSIBILITY FOR ALL EXCAVATION. ADEQUATE SHORING SHALL BE DESIGNED AND PROVIDED BY THE CONTRACTOR TO PREVENT UNDERMINING OF ANY ADJACENT FEATURES OR FACILITIES AND/OR CAVING OF THE EXCAVATION.
4. THE CONTRACTOR IS WARNED THAT AN EARTHWORK BALANCE WAS NOT NECESSARILY THE INTENT OF THIS PROJECT. ANY ADDITIONAL MATERIAL REQUIRED OR LEFTOVER MATERIAL FOLLOWING EARTHWORK OPERATIONS BECOMES THE RESPONSIBILITY OF THE CONTRACTOR.
5. THE GRADING CONTRACTOR IS RESPONSIBLE TO COORDINATE WITH THE OWNER TO PROVIDE FOR THE REQUIREMENTS OF THE PROJECT STORM WATER POLLUTION PREVENTION PLAN (SWPPP) AND ASSOCIATED PERMIT.
6. CONTRACTOR SHALL GRADE TO THE LINES AND ELEVATIONS SHOWN ON THE PLANS WITHIN THE FOLLOWING HORIZONTAL AND VERTICAL TOLERANCES AND DEGREES OF COMPACTION, IN THE AREAS INDICATED:

	HORIZONTAL	VERTICAL COMPACTION	
A. PAVEMENT AREA SUBGRADE	0.1"	+0.0' TO -0.1'	SEE SOILS REPORT
B. ENGINEERED FILL	0.5"	+0.1' TO -0.1'	SEE SOILS REPORT

COMPACTION TESTING WILL BE PERFORMED BY THE OWNER OR HIS REPRESENTATIVE.
7. ALL CUT AND FILL SLOPES SHALL BE PROTECTED UNTIL EFFECTIVE EROSION CONTROL HAS BEEN ESTABLISHED.
8. THE USE OF POTABLE WATER WITHOUT A SPECIAL PERMIT FOR BUILDING OR CONSTRUCTION PURPOSES INCLUDING CONSOLIDATION OF BACKFILL OR DUST CONTROL IS PROHIBITED. THE CONTRACTOR SHALL OBTAIN ALL NECESSARY PERMITS FOR CONSTRUCTION WATER.
9. THE CONTRACTOR SHALL MAINTAIN THE STREETS, SIDEWALKS AND ALL OTHER PUBLIC RIGHT-OF-WAY IN A CLEAN, SAFE AND USABLE CONDITION. ON OR OFF OF SOIL, ROCK OR CONSTRUCTION DEBRIS SHALL BE PROHIBITED FROM THE PUBLICLY OWNED PROPERTY DURING CONSTRUCTION AND UPON COMPLETION OF THE PROJECT. ALL ADJACENT PROPERTY, PRIVATE OR PUBLIC SHALL BE MAINTAINED IN A CLEAN, SAFE AND USABLE CONDITION.
10. IN THE EVENT THAT ANY TEMPORARY CONSTRUCTION ITEM IS REQUIRED THAT IS NOT SHOWN ON THESE DRAWINGS, THE OWNER AGREES TO PROVIDE AND INSTALL SUCH ITEM AT HIS OWN EXPENSE AND AT THE DIRECTION OF THE CITY ENGINEER. TEMPORARY CONSTRUCTION INCLUDES DITCHES, BERMS, ROAD SIGNS AND BARRICADES, ETC.

2.1 CITY OF LAS VEGAS GENERAL NOTES

1. ALL CONSTRUCTION AND MATERIALS SHALL BE IN ACCORDANCE WITH THE "UNIFORM STANDARD SPECIFICATIONS FOR PUBLIC WORKS CONSTRUCTION OFF-SITE IMPROVEMENTS, CLARK COUNTY AREA NEVADA", LATEST ISSUE, THE "UNIFORM STANDARD DRAWINGS FOR PUBLIC WORKS CONSTRUCTION, CLARK COUNTY AREA NEVADA", LATEST REVISED EDITION; THE "SUMMERLIN IMPROVEMENT STANDARDS" FOR WORK IN THE SUMMERLIN AREA, AND OTHER APPLICABLE APPROVED STANDARDS ISSUED BY THE CONTROLLING AGENCY, THE UNIFORM BUILDING CODE, AND ALL LOCAL CITY CODES AND ORDINANCES APPLICABLE, EXCEPT AS NOTED ON THIS SHEET AS "DEVIATIONS FROM STANDARDS".
2. THE EXISTENCE AND LOCATION OF ANY OVERHEAD OR UNDERGROUND UTILITY LINES, PIPES, OR STRUCTURES SHOWN ON THESE PLANS ARE OBTAINED BY A RESEARCH OF THE AVAILABLE RECORDS, EXISTING UTILITIES AS SHOWN FROM CIVIL PLANS LIBRARY ARE APPROXIMATE AND FOR RECORD PURPOSES. EXISTING UTILITIES ARE LOCATED ON PLANS ONLY FOR THE CONVENIENCE OF THE CONTRACTOR. EXISTING UTILITY SERVICE LATERALS MAY NOT BE SHOWN ON THE PLANS. THE CONTRACTOR SHALL, AT HIS OWN EXPENSE, LOCATE ALL UNDERGROUND AND OVERHEAD INTERFERENCES WHICH MAY AFFECT HIS OPERATION DURING CONSTRUCTION AND SHALL TAKE ALL NECESSARY PRECAUTIONS TO AVOID DAMAGE TO SAME. THE CONTRACTOR SHALL USE EXTREME CAUTION WHEN WORKING NEAR OVERHEAD UTILITIES SO AS TO SAFELY PROTECT ALL PERSONNEL AND EQUIPMENT, AND SHALL BE RESPONSIBLE FOR ALL COST AND LIABILITY IN CONNECTION THEREWITH.
3. THE CONTRACTOR SHALL TAKE ALL PRECAUTIONARY MEASURES NECESSARY TO PROTECT EXISTING UTILITY LINES, STRUCTURES AND STREET IMPROVEMENTS WHICH ARE TO REMAIN IN PLACE, FROM DAMAGE, AND ALL SUCH IMPROVEMENTS OR STRUCTURES DAMAGED BY THE CONTRACTOR'S OPERATIONS SHALL BE REPAIRED OR REPLACED SATISFACTORY TO THE CITY ENGINEER AND OWNING UTILITY COMPANY AT THE EXPENSE OF THE CONTRACTOR.
4. ALL CONSTRUCTION SHALL BE AS SHOWN ON THESE PLANS, ANY REVISIONS SHALL HAVE THE PRIOR WRITTEN APPROVAL OF THE CITY ENGINEER.
5. TYPE V CEMENT SHALL BE USED IN ALL OFF-SITE CONCRETE WORK. CONCRETE TO BE 3000 P.S.I. MINIMUM @ 28 DAYS. MIX DESIGNS TO BE APPROVED BY THE CITY, PRIOR TO THE USE ON THE PROJECT.
6. PERMITS ARE REQUIRED FOR ANY WORK IN THE PUBLIC RIGHT-OF-WAY. THE CONTRACTOR SHALL SECURE ALL PERMITS AND INSPECTIONS REQUIRED FOR THIS CONSTRUCTION.
7. EXPANSION JOINTS REQUIRED, MAXIMUM EVERY 300' IN EXTENDED-TYPE CURB.
8. AC PAVEMENT TO BE ONE-HALF INCH (1/2") ABOVE UP OF ALL GUTTERS AFTER COMPACTION, EXCEPT AT SIDEWALK RAMPS AND CROSS GUTTERS.
9. CURB AND GUTTER FOUND TO BE UNACCEPTABLE TO THE CITY OF LAS VEGAS SHALL BE REMOVED AND REPLACED PER STANDARD DRAWING 216.
10. SIDEWALK RAMPS SHALL BE CONSTRUCTED IN EACH QUADRANT OF AN INTERSECTION PER STANDARD DRAWING 235. EXACT LOCATION OF RAMPS MAY BE ADJUSTED IN THE FIELD BY A CITY INSPECTOR.
11. CONTRACTOR SHALL PROVIDE ALL NECESSARY HORIZONTAL AND VERTICAL TRANSITIONS BETWEEN NEW CONSTRUCTION AND EXISTING SURFACES TO PROVIDE FOR PROPER DRAINAGE AND FOR INSURE EGRESS TO NEW CONSTRUCTION. THE EXTENT OF THE TRANSITIONS TO BE AS SHOWN ON PLANS.
12. ALL GRADING WORK SHALL CONFORM TO THE SOILS REPORT AS PREPARED BY ADD GEO. REPORT #ADD FIELD, ADD FIELD APPROVED BY THE CITY ENGINEER, AND AS SHOWN ON THESE PLANS.
13. EXACT LOCATION OF ALL SAWCUT LINES MAY BE ADJUSTED OR DETERMINED IN THE FIELD BY A CITY INSPECTOR. EXISTING PAVEMENT CONSTRUCTION IS NOT CLEARLY SHOWN, OR EXISTING PAVEMENT CONSTRUCTION REQUIRES RELOCATION.
14. THE CONTRACTOR SHALL TAKE ALL PRECAUTIONS NECESSARY TO PROTECT EXISTING PERMANENT SURVEY MONUMENTS. ANY MONUMENTS DISTURBED SHALL BE REPLACED AND ADJUSTED PER AVAILABLE RECORDS IN ACCORDANCE WITH N.E.S. STATUTE NO. 625.380 & CITY OF LAS VEGAS TITLE 18, APPENDIX D.
15. UTILITY COMPANY METER BOXES, MANHOLE LIDS, VALVE COVERS, ETC., SHALL BE LOCATED OUT OF DRIVEWAYS, DRIVEWAY APRONS, FLOWLINES, AND CROSS GUTTERS UNLESS WRITTEN APPROVAL IS GRANTED BY THE UTILITY COMPANY AND THE CITY ENGINEER.
16. WALL NOTES:
16. ALL WALLS, NEW OR EXISTING, ARE ONLY SHOWN ON CIVIL PLANS FOR THE PURPOSE OF REVIEWING GRADING RELATIONSHIPS, FLOOD CONTROL, AND SIGHT DISTANCE AT INTERSECTIONS. NEW WALLS REQUIRE A SEPARATE PERMIT AND INSPECTION BY THE BUILDING DEPARTMENT.
17. ASPHALT MIX DESIGN MUST BE SUBMITTED AND APPROVED BY THE CITY ENGINEER PRIOR TO THE PLACEMENT OF ASPHALT WITHIN CITY RIGHT OF WAY.
18. CONTRACTOR SHALL ADJUST ALL NEW AND EXISTING LINES, VALVE BOXES, MANHOLE RIMS, AND SEWER CLEAN OUTS, ETC. TO FINISH GRADE AS APPLICABLE WHETHER OR NOT THEY ARE SHOWN ON THE PLANS.
19. MATERIALS, HANDLING AND PLACEMENT OF PORTLAND CEMENT CONCRETE SHALL BE IN ACCORDANCE WITH APPLICABLE SECTIONS OF NDOT OR THE CLARK COUNTY AREA SPECIFICATIONS (AS APPLICABLE) AND THE PLANS AND DETAILS SHOWN HEREON.
20. WHEN INSTALLING UNDERGROUND FACILITIES THAT REQUIRE UNDERGROUND LOCATING DEVICES SUCH AS MARKER BALLS, LOCATING RIBBON, ETC., THE CONTRACTOR SHALL PROVIDE WRITTEN DOCUMENTATION TO OFFSITE INSPECTION AND TESTING CERTIFYING THAT ALL DEVICES HAVE BEEN PLACED AND VERIFIED TO BE IN GOOD WORKING CONDITION PRIOR TO THE CONSTRUCTION OF ANY ROAD BASE.
21. SANITARY SEWER AND STORM DRAIN FINAL LOCATION MAP(S) SHALL BE PROVIDED TO THE CITY AND APPROVED PRIOR TO ACCEPTANCE OF FACILITY VIDEO INSPECTION. THE MAP(S) SHALL INCLUDE THE HORIZONTAL AND VERTICAL (INVERT) LOCATION OF PUBLIC SEWER MANHOLES, STORM DRAIN MANHOLES AND TRANSITION STRUCTURES, STORM DRAIN LATERALS AT THE CONNECTION TO THE STORM DRAIN MAIN AND AT THE CONNECTION TO A DROP INLET, THE CONNECTION OF SEWER SERVICE LATERALS TO THE SEWER MAIN AND WHERE THE SEWER SERVICE LATERALS EXIT THE PUBLIC RIGHT-OF-WAY, AND STORM DRAIN MAIN ALIGNMENT, INCLUDING DETECTION POINTS. THE LOCATION SHALL BE DESCRIBED BY COORDINATES WHICH SHALL BE BASED ON THE OFFICIAL HORIZONTAL AND VERTICAL CONTROL NETWORKS OF THE CITY OF LAS VEGAS. FINAL LOCATION MAPS MUST BE SEALED AND CERTIFIED BY A NEVADA PROFESSIONAL LAND SURVEYOR TO HAVE POSITIONAL CERTANTIES OF 40.09 METERS (40.3 FEET) HORIZONTALLY AND VERTICALLY. A SEPARATE ELECTRONIC COMMA DELIMITED FILE FOR THE SANITARY SEWER AND STORM DRAIN COORDINATES SHALL ALSO ACCOMPANY THE SANITARY SEWER AND STORM DRAIN FINAL LOCATION MAP(S).
22. CCTV VIDEO INSPECTION IS REQUIRED FOR ALL SEWER AND STORM DRAINS. THE CCTV VIDEO INSPECTIONS NEED TO BE PERFORMED PER THE DESIGN AND CONSTRUCTION STANDARDS FOR WASTEWATER COLLECTION SYSTEMS LATEST ADDITION.
23. A SEPARATE BORING PERMIT IS REQUIRED FOR ALL BORING ACTIVITIES.

UTILITY LOCATION NOTE TO CONTRACTOR

EXISTING UTILITY LOCATIONS SHOWN HEREIN ARE APPROXIMATE ONLY. IT SHALL BE THE CONTRACTOR'S RESPONSIBILITY TO DETERMINE THE EXACT VERTICAL AND HORIZONTAL LOCATION OF ALL EXISTING UNDERGROUND UTILITIES PRIOR TO COMMENCING CONSTRUCTION. NO REPRESENTATION IS MADE THAT ALL EXISTING UTILITIES ARE SHOWN HEREON. THE ENGINEER ASSUMES NO RESPONSIBILITY FOR UTILITIES NOT SHOWN OR UTILITIES NOT SHOWN IN THEIR PROPER LOCATIONS. CALL BEFORE YOU DIG: 1 (800) 227-2600

DEVIATIONS FROM STANDARDS


NONE

2.3 CITY OF LAS VEGAS TRAFFIC NOTES

1. ALL CONSTRUCTION SIGNING, BARRICADING, AND TRAFFIC DELINEATION SHALL CONFORM TO THE "MANUAL ON UNIFORM TRAFFIC CONTROL DEVICES", LATEST EDITION.
2. THE STREET SIGN CONTRACTOR SHALL OBTAIN STREET NAMES AND BLOCK NUMBERING FROM THE PLANNING DEPARTMENT PRIOR TO CONSTRUCTION.
3. BEFORE ANY WORK IS STARTED IN THE RIGHT-OF-WAY, THE CONTRACTOR SHALL INSTALL ALL ADVANCE WARNING SIGNS FOR THE CONSTRUCTION ZONE. THE CONTRACTOR SHALL INSTALL TEMPORARY STOP SIGNS AT ALL NEW STREET ENCROACHMENTS INTO EXISTING CITY STREETS WHERE WARRANTED IMMEDIATELY AFTER FIRST GRADING WORK IS ACCOMPLISHED, AND SHALL MAINTAIN SAID SIGNS UNTIL PERMANENT SIGNS ARE INSTALLED.
4. WHEN A DESIGNATED "SAFE ROUTE TO SCHOOL" IS ENCROACHED UPON BY A CONSTRUCTION WORK ZONE AND PUBLIC WORKS STOP DEVICES A NEED FOR STUDENTS TO BE ASSISTED IN THE SAFE CROSSING THROUGH THAT WORK ZONE, THE CONTRACTOR SHALL BE REQUIRED TO PROVIDE A QUALIFIED "CROSSING GUARD", THE GUARD SHALL BE PRESENT FOR THE FULL DURATION OF TIME THAT CHILDREN ARE LIKELY TO BE PRESENT.
5. IF THE IMPROVEMENTS NECESSITATE THE OBLITERATION, TEMPORARY OBSTRUCTION, TEMPORARY REMOVAL OR RELOCATION OF ANY EXISTING TRAFFIC PAVEMENT MARKING, SUCH PAVEMENT MARKING SHALL BE RESTORED OR REPLACED WITH LIKE MATERIALS TO THE SATISFACTION OF THE CITY ENGINEER.
6. THE CONTRACTOR SHALL BE RESPONSIBLE FOR PROVIDING AND INSTALLING ALL PERMANENT SIGNS SHOWN ON THE PLANS. ALL NEW TRAFFIC SIGNS SHALL BE FABRICATED WITH DIAMOND GRADE VP CLASS 6 REFLECTIVE SHEETING OR APPROVED EQUAL. ALL NEW TRAFFIC SIGNS, EXCEPT STREET NAME AND SCHOOL SPEED LIMIT SIGNS, SHALL HAVE 3M SERIES 1160 OR APPROVED EQUIVALENT ANTI-GRAFFITI PROTECTIVE OVERLAY FILM. SCHOOL ZONE SIGNS SHALL HAVE 3M SERIES 1150 ANTI-GRAFFITI PROTECTIVE OVERLAY FILM. STREET NAME SIGNS SHALL CONFORM IN THEIR ENTIRETY TO CURRENT CITY STANDARDS. ALL OTHER SIGNS SHALL BE STANDARD SIZE UNLESS OTHERWISE SPECIFIED ON THE PLANS. ALL SIGN POSTS SHALL BE INSTALLED IN ACCORDANCE WITH THE CURRENT CITY STANDARDS.
7. WHEN A PROPOSED STREET LIGHT STANDARD IS LOCATED WITHIN FIVE (5) FEET OF ANY PROPOSED SIGN SHOWN ON THE PLANS, THE SIGN PLANS TO BE MOUNTED ON A SIGNPOST THAT SHALL BE MOUNTED ON THE STREET LIGHT STANDARD AND THE SIGNPOST SHALL BE ELIMINATED.
8. ALL PERMANENT TRAFFIC CONTROL DEVICES CALLED FOR HEREON SHALL BE IN PLACE AND IN FINAL POSITION PRIOR TO ALLOWING ANY PUBLIC TRAFFIC ONTO THE PORTIONS OF THE ROAD(S) BEING IMPROVED HERE UNDER, REGARDLESS OF THE STATUS OF COMPLETION OF PAVING OR OTHER OFF-SITE IMPROVEMENTS CALLED FOR BY THESE PLANS.
9. STREET SIGNS AND STOP SIGNS SHALL BE INSTALLED PER CITY STANDARD SPECIFICATIONS FOR PLACEMENT OF STREET NAME SIGNS.
10. THE CONTRACTOR SHALL PROVIDE ALL NECESSARY TRAFFIC CONTROL DEVICES AND FLAGGERS TO INSURE THE SAFETY OF THE PUBLIC IN OR AROUND THE WORK AREA. THE CONTRACTOR SHALL PROVIDE TRAFFIC CONTROL TECHNICIAN OR WORK ZONE SAFETY SPECIALIST SET UP, MAINTAIN AND/OR REMOVE ALL TRAFFIC CONTROL DEVICES IN THE CITY OF LAS VEGAS RIGHT OF WAY.
11. WORK IN PUBLIC STREETS, ONCE BEGUN, SHALL BE EXPEDITED TO COMPLETION SO AS TO PROVIDE MINIMUM INCONVENIENCE TO ADJACENT PROPERTY OWNERS AND TO THE TRAVELING PUBLIC.
12. THE CONTRACTOR SHALL BE RESPONSIBLE FOR NOTIFYING CITIZENS AREA TRANSIT (C.A.T.) IF THE CONSTRUCTION INTERRUPTS OR RELOCATES A BUS STOP OR HAS AN ADVERSE EFFECT ON BUS SERVICE ON THAT STREET TO ARRANGE FOR TEMPORARY RELOCATION OF STOP.
13. GUARDS SHALL BE OBTAINED BY CONTACTING THE METROPOLITAN POLICE DEPARTMENT SPECIAL EVENTS UNIT (PHONE # 828-3442) WHO WILL PROVIDE OFFICERS PROPERLY TRAINED IN TRAFFIC CONTROL FEES FOR THE USE OF THESE OFFICERS SHALL BE SET BY METRO AND WILL BE PAID BY THE CONTRACTOR. THE CONTRACTOR IS RESPONSIBLE FOR ALL ARRANGEMENTS WITH METRO.
14. ANY WORK WITHIN 300' OF A SIGNALIZED INTERSECTION WILL BE NIGHT WORK, UNLESS OTHERWISE DIRECTED BY THE CITY OF LAS VEGAS TRAFFIC ENGINEER.
15. THE CONTRACTOR SHALL CONTACT THE TRAFFIC ENGINEERING DIVISION (TRANSPORTATION SECTION) THROUGH THE PROJECT'S OFFSITE INSPECTOR PRIOR TO INITIATING PAVING TO RECEIVE DIRECTION FOR ANY PERMANENT OR TEMPORARY MODIFICATIONS TO THE APPROVED DRAWINGS REGARDING FINAL PAVEMENT TRANSITIONS, MARKINGS AND SIGNING THAT ARE REQUIRED TO MATCH ADJACENT ROADWAY SEGMENTS. THE CONTRACTOR SHALL PROVIDE A DRAWING FOR APPROVAL BY THE TRAFFIC ENGINEERING DIVISION DEPICTING ANY ADJUSTMENTS TO THE FINAL PAVEMENT MARKINGS AND SIGNING, WHICH MAY INCLUDE ADDING OR MODIFYING PAVEMENT MARKINGS AND TRAFFIC CONTROL SIGNS SUCH THAT ADEQUATE TRANSITIONS AND LANE TERMINATIONS BETWEEN ADJACENT ROADWAY SEGMENTS ARE CONSTRUCTED.

2.4 CITY OF LAS VEGAS STREETLIGHT NOTES

1. ALL STREET LIGHTING INSTALLATIONS SHALL BE IN ACCORDANCE WITH THE STREET LIGHTING PLANS, THE "UNIFORM STANDARD SPECIFICATIONS FOR PUBLIC WORKS CONSTRUCTION OFF-SITE IMPROVEMENTS, CLARK COUNTY AREA, NEVADA", LATEST REVISION, AND THE "UNIFORM STANDARD DRAWINGS FOR PUBLIC WORKS CONSTRUCTION OFF-SITE IMPROVEMENTS, CLARK COUNTY AREA, NEVADA", LATEST REVISION, AND ANY ADOPTED SPECIAL AREA STANDARDS.
2. NO DEVIATION OF STREET LIGHT, PULL BOX, CONDUITS (ETC.) LOCATIONS SHALL BE PERMITTED WITHOUT WRITTEN APPROVAL OF TRAFFIC ENGINEERING AND THE CITY ENGINEER.
3. ALL EXISTING STREET LIGHTING SHALL REMAIN OPERATIONAL DURING CONSTRUCTION.
4. ALL STREET LIGHTING CONDUITS SHALL HAVE AT LEAST ONE GREEN #10 THW WIRE INSTALLED, AS TRACER WIRE. WHEN "EMPTY" CONDUIT IS COMPLETELY INSTALLED FROM PRE TO POST, IT SHALL HAVE MINIMUM OF 2 #4 AND 1 #10 THW WIRE WITH THE ENDS TAPED OR "SAFE OFF" PRIOR TO FINAL INSPECTION.
5. ANY STRUCTURE SUCH AS BLOCK WALLS, CHAIN LINK FENCES, RETAINING WALLS, ETC., SHALL LEAVE A MINIMUM CLEARANCE IN ACCORDANCE WITH THE USDO NO. 320A.
6. AS-BUILT DRAWINGS SHALL BE SUPPLIED TO THE CITY PRIOR TO ANY PRE-FINAL INSPECTION. THE ASBUILT DRAWING NEEDS TO BE STAMPED AS-NV AND SIGNED BY THE PREPARED.
7. SERVICE POINT SHALL BE COORDINATED WITH NV ENERGY COMPANY, AND WHEREVER POSSIBLE, BE LOCATED NEAR THE CENTER OF THE CIRCUIT. SERVICE POINTS SHALL BE SHOWN ON THE CIVIL PLANS.
8. IT SHALL BE ASSURED THAT IN THE ABSENCE OF AN EXISTING, WORKABLE CIRCUIT TO ATTACH TO, ALL INSTALLATIONS SHALL REQUIRE A NEW SERVICE FOR OPERATION OF THE CIRCUIT.
9. WHEREVER THERE IS AN OVERHEAD UTILITY THAT MAY CONFLICT WITH THE INSTALLATION OF STREET LIGHTING CIRCUITS AND/OR POLES, THESE CONFLICTS MUST BE RESOLVED BEFORE THE DEVELOPER AND THE UTILITIES INVOLVED, AT NO EXPENSE TO THE CITY OF LAS VEGAS, BEFORE STREETLIGHT BASES ARE INSTALLED.
10. THE CONTRACTOR SHALL FURNISH COMPLETE SERVICE TO TRANSFORMERS AND CONTROL SYSTEMS IF REQUIRED ON PLANS.
11. THE DEVELOPER/OWNER WILL BE REQUIRED TO SUPPLY POWER TO ALL NEW PUBLIC STREET LIGHTS INSTALLED UNDER THIS DESIGN PRIOR TO BOND RELEASE OR PROJECT COMPLETION. THE DEVELOPER/OWNER WILL BE RESPONSIBLE FOR ALL ITEMS ASSOCIATED WITH THE INSTALLATION, CONSTRUCTION, ENERGIZING, MAINTENANCE AND OPERATIONAL COST OF SAID STREET LIGHTS PRIOR TO PROJECT COMPLETION. REFER TO THE PLAN FOR ANY NEW SERVICE REQUIREMENTS. THE TRANSFER OF OWNERSHIP FROM THE DEVELOPER/OWNER TO THE CITY OF LAS VEGAS FOR ALL NEW PUBLIC STREET LIGHTS AND/OR SERVICE/S INSTALLED UNDER THIS PLAN DESIGN WILL BE IN CONJUNCTION WITH THE PROJECT COMPLETION. COORDINATE ALL MAINTENANCE AND OPERATIONAL TRANSFERS WITH THE CITY OF LAS VEGAS TRAFFIC ENGINEERING DEPARTMENT (TED) AT (702) 229-6331.

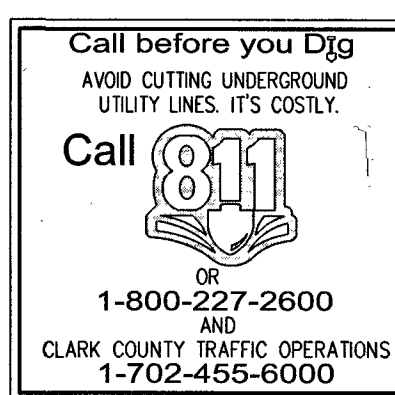

ABBREVIATIONS			
AC	ASPHALTIC CONCRETE OR ACRE	FUT	FUTURE
AGG	AGGREGATE BASE	GRD	GRADE OR GROUND
APN	ASSESSORS PARCEL NUMBER	GB	GRADE BREAK OR GRADE CHANGE
APPROX OR ~	APPROXIMATE	GV	GATE VALVE
AVE	AVENUE	HDP	HIGH DENSITY POLYETHYLENE
AT	AT	HOA	HOME OWNERS ASSOCIATION
BC	BEGN CURVE OR BACK OF CURB	HORZ	HORIZONTAL
BOR	BEGINNING OF CURB RETURN	HP	HIGH POINT
BHW	BOTTOM OF HEADWALL	HWL	HIGH WATER LEVEL
BLDG	BUILDING	HOWL OR HW	HEADWALL
BLVD	BULEVARD	HYD	HYDRAULIC OR HYDRANT
BM	BENCHMARK	ID	INSIDE DIAMETER
BVC	BEGN VERTICAL CURVE	IN	INCH
BWV	BACK WATER VALVE	INT	INTERSECTION
CC	CLARK COUNTY	INV	INVERT ELEVATION
CCAUSD	CLARK COUNTY AREA UNIFORM STANDARD DRAWINGS	IP	IRON PIPE
CCPW	CLARK COUNTY PUBLIC WORKS	IRRG	IRRIGATION
CORFCD	CLARK COUNTY REGIONAL FLOOD DISTRICT	LF	LINEAR FEET
CORWD	CLARK COUNTY WATER RECLAMATION DISTRICT	LP	LOW POINT
CE	COMMON ELEMENT	LT OR L	LEFT
CL/C/LC	CENTERLINE	LVWD	LAS VEGAS VALLEY WATER DISTRICT
CLR	CLEAR OR CLEARANCE	LWL	LOW WATER LEVEL
CLSM	CONTROLLED LOW STRENGTH MATERIAL	MAX	MAXIMUM
CML&C	CEMENT MORTAR LINED AND COATED	MECH	MECHANICAL
CNU	CONCRETE MASONRY UNIT	MH	MANHOLE
CONC	CONCRETE	MIN	MINIMUM
CT	COURT	MISC	MISCELLANEOUS
CY OR CU YD	CUBIC YARD	MUE	MUNICIPAL UTILITY EASEMENT
DWCS	DESIGN AND CONSTRUCTION FOR WASTEWATER COLLECTION SYSTEMS	NDOT	NEVADA DEPARTMENT OF TRANSPORTATION
DET	DETAIL	NPC	NEVADA POWER COMPANY
DI	DUCTILE IRON OR DRAIN INLET	NTS	NOT TO SCALE
DIA	DIAMETER	NUE	NONEXCLUSIVE UTILITY EASEMENT
DP	DUCTILE IRON PIPE	OC	ON CENTER
DR	DRIVE	OD	OUTSIDE DIAMETER OR OVERALL DIMENSION
DWG(S)	DRAWING	OFF	OFFSET
DWT	DRIVEWAY	ORIG	ORIGINAL
EA	EACH	PAE	PUBLIC OR PEDESTRIAN ACCESS EASEMENT
ECR	END CURB RETURN	PB	PULL BOX
EG	EXISTING GROUND	PC	POINT OF CURVE
EL	ELEVATION	PCC	POINT OF COMPOUND CURVE
ESMT	EASEMENT	PCE	POINT OF CURVATURE
EP	EDGE OF PAVEMENT	PDE	POINT OF BEGINNING
EVC	END VERTICAL CURVE	PDE	POINT OF ENDING
EX OR EXIST	EXISTING	PDR	PRELIMINARY
FC	FACE OF CURB	PRV	PRESSURE REDUCING VALVE
FF	FINISHED FLOOR	PUE	PUBLIC UTILITY EASEMENT
FG	FINISHED GRADE	PT	POINT OF TANGENT OR POINT
FGL	FINISHED GRADE, HIGH SIDE	PVC	POLYVINYL CHLORIDE
FH	FINISHED GRADE, LOW SIDE	PVI	POINT OF VERTICAL INTERSECTION
FL	FIRE HYDRANT		
FL	FLOWLINE		
FT	FEET OR FOOT		

SPECIAL NOTE

IN THE EVENT THAT ANY TEMPORARY CONSTRUCTION ITEM IS REQUIRED WHICH IS NOT SHOWN ON THESE DRAWINGS, THE OWNER AGREES TO PROVIDE AND INSTALL SUCH ITEM AT HIS OWN EXPENSE AND AT THE DIRECTION OF THE CLARK COUNTY DEPT. OF PUBLIC WORKS. TEMPORARY CONSTRUCTION ITEMS INCLUDE: PAVEMENT TRANSITIONS, PROTECTIVE DITCHES AND BERMS, ROAD SIGNS AND BARRICADES, ETC.

NOTICE TO CONTRACTOR

-QUANTITIES SHOWN ARE ESTIMATES ONLY AND ARE INTENDED TO ILLUSTRATE SCOPE OF WORK. THE CONTRACTOR SHALL BE RESPONSIBLE FOR VERIFYING THE EXACT QUANTITIES INVOLVED.

-EXISTING UTILITY LOCATIONS SHOWN HEREIN ARE APPROXIMATE ONLY. IT SHALL BE THE CONTRACTOR'S RESPONSIBILITY TO DETERMINE THE EXACT VERTICAL AND HORIZONTAL LOCATION OF ALL EXISTING UNDERGROUND UTILITIES PRIOR TO COMMENCING CONSTRUCTION. NO REPRESENTATION IS MADE THAT ALL EXISTING UTILITIES ARE SHOWN HEREON. THE ENGINEER ASSUMES NO RESPONSIBILITY FOR UTILITIES NOT SHOWN OR UTILITIES NOT SHOWN IN THEIR PROPER LOCATIONS. CALL BEFORE YOU DIG. (800) 227-2600

LEGEND

EXISTING	PROPOSED	DESCRIPTION
		5' CONTOUR
		1' CONTOUR
		STRIPING
		SEWER MANHOLE
		CURB AND GUTTER
		SANITARY SEWER PIPE AND FLOW ARROW
		WATER PIPE
		WATER GATE VALVE
		FIRE HYDRANT
		WATER BLOW-OFF
		WATER LATERAL W/ METER
		SANITARY SEWER LATERAL
		STREETLIGHT
		EDGE OF PAVEMENT
		TRAFFIC SIGN
		PAD ELEVATION
		FINISHED FLOOR ELEVATION
		ELEVATION
		RETAINING WALL
		STORM DRAIN W/ MANHOLE
		EXISTING GAS GATE VALVE
		EXISTING UNKNOWN MANHOLE
		EXISTING GAS, SIZE PER PLAN
		EXISTING POWER POLE
		EXISTING TRAFFIC SIGNAL
		EXISTING WALL
		WATER PIPE FITTING
		WATER POINT OF CONNECTION
		SEWER POINT OF CONNECTION
		DAYLIGHT LINE
		STREET CENTERLINE
		RIGHT-OF-WAY
		MATCHLINE
		BOUNDARY LINE
		PHASE LINE
		PROPERTY LINE
		FLOWLINE
		SAWCUT
		CUT/FILL TRANSITION LINE
		SIDEWALK
		EX STRIPING TO BE OBLITERATED
		GRADE BREAK LINE
		REFLECTIVE RAISED PAVEMENT MARKERS
		BACK WATER VALVE
		WROUGHT IRON FENCE
		PONY WALL
		DECORATIVE PERIMETER WALL
		DECORATIVE PERIMETER RETAINING WALL
		PROPOSED CURB AND GUTTER WITH RIGHT-OF-WAY AT BACK OF CURB
		EXISTING CURB AND GUTTER WITH RIGHT-OF-WAY AT BACK OF CURB
		FUTURE CURB AND GUTTER WITH RIGHT-OF-WAY AT BACK OF CURB

QUANTITIES

	PRIVATE	PUBLIC
DRAINAGE		
1. 48" TYPE I STORM DRAIN MANHOLE	EA	2
2. 48" TYPE II STORM DRAIN MANHOLE	EA	4
3. 12" NOS SQUARE DRAIN (OR APPROVED EQUAL) PER DETAILS ON SHEET D-3	EA	3
4. JENSON PRECAST DRAIN INLET PER DETAILS ON SHEET D-3	EA	2
5. 12" PVC STORM DRAIN	EA	144
6. 18" PVC STORM DRAIN	LF	504
7. 24" PVC STORM DRAIN	LF	21
8. 36" RCP CLASS IV STORM DRAIN	LF	381
9. RIPRAP D50=8", THK=16"	SF	1650
10. SIDEWALK UNDER DRAIN PER CCAUSD #236	EA	1
11. 60" TYPE III STORM DRAIN MANHOLE	EA	1
12. 6" WIDE ZURN SIDEWALK TRENCH DRAIN	EA	1
13. 2'-FT WIDE CONCRETE FLUME	LF	12
SEWER SYSTEM		
1. 6" PVC SEWER PIPE (PRIVATE)	LF	321
2. 8" PVC SEWER PIPE (PRIVATE)	LF	2
3. SEWER CLEANOUT, SIZE PER PLAN, PER DCSWCS DWG NO. SD-26 (PRIVATE)	EA	4
4. GREASE INTERCEPTOR, PER PLUMBING PLANS	EA	1
5. 6" X 6" WYE SEWER CONNECTION PER SD-22 & SD-23 (PRIVATE)	EA	1
6.		
7.		
WATER SYSTEM		
1. FIRE HYDRANT ASSEMBLY W/6" GATE VALVE PER UDACS PLATE NO. 40	EA	4
2. 3" PVC WATER PIPE (CLASS 150)	LF	87
3. 6" PVC WATER PIPE (CLASS 150)	LF	104
4. 8" PVC WATER PIPE (CLASS 150)	LF	1265
5. 10" PVC WATER PIPE (CLASS 150)	LF	86
6. 6" GATE VALVE WITH VALVE BOX PER UDACS PLATE NO. 30 & 39	EA	4
7. 8" GATE VALVE WITH VALVE BOX PER UDACS PLATE NO. 30 & 39	EA	5
8. 8" 45 DEGREE BEND PER UDACS PLATE NO. 31	EA	6
9. 3" CAP AND 2" BLOW-OFF ASSEMBLY W/CAP PER UDACS PLATE NO. 36	EA	1
10. 6" CAP AND 2" BLOW-OFF ASSEMBLY W/CAP PER UDACS PLATE NO. 36	EA	2
11. 8" RPPA PER UDACS PLATE NO. 56	EA	2
12. 3" X 3" TEE PER UDACS PLATE NO. 31	EA	1
13. 8" X 8" TEE PER UDACS PLATE NO. 31	EA	1
14. 8" X 8" TEE PER UDACS PLATE NO. 31	EA	5
15. 10" X 6" TEE PER UDACS PLATE NO. 31	EA	1
16. 8" X 8" TAPPING TEE AND SLEEVE WITH 8" TAPPING VALVE	EA	1
17. 10" X 6" REDUCER PER UDACS PLATE NO. 30	EA	1
18. 8" X 6" REDUCER PER UDACS PLATE NO. 30	EA	1
19. 2" 90 DEGREE BEND PER UDACS PLATE NO. 31	EA	2
20. 3" 90 DEGREE BEND PER UDACS PLATE NO. 31	EA	4
21. 6" 90 DEGREE BEND PER UDACS PLATE NO. 31	EA	2
22. 8" 90 DEGREE BEND PER UDACS PLATE NO. 31	EA	5
23. 8" 22.5 DEGREE BEND PER UDACS PLATE NO. 31	EA	1
24. 8" 5 DEGREE BEND PER UDACS PLATE NO. 31	EA	1
25. 1" COPPER SERVICE W/ 1" RPPA PER UDACS PLATE NO. 4 & 8	EA	1
26. 2" COPPER SERVICE W/ 2" METER & 2" RPPA PER UDACS PLATE NO. 3 & 8	EA	2
STREET IMPROVEMENTS		
1. 2" A.C. PAVEMENT W/ 4" TYPE II OVER 6" TYPE I AGGREGATE BASE	SY	125,393
2. TYPE "L" CURB & GUTTER PER CCAUSD DWG NO. 216	LF	581
3. TYPE "A" CURB PER DETAIL C ON SHEET D-2	LF	4,289
4. "DEPRESSED" CURB PER DETAIL D ON SHEET D-2	LF	261
5. CUSTOM 6" CURB	LF	413
6. CUSTOM 12" CURB	LF	1052
7. CONCRETE SIDEWALK W/4" TYPE II AGGREGATE BASE	SF	8,760
8. CONCRETE VALLEY GUTTER	SF	490
TRAFFIC SIGNALS		
1. 36" X 30" STOP SIGN WITH POST (R4-4)	EA	1
2. 9" STREET NAME SIGN (D-3, BROWN W/ WHITE LETTERS)	EA	2
3. BLUE COLORED REFLECTIVE RAISED PAVEMENT MARKER	EA	4
4. 12" X 18" RESERVED PARKING SIGN WITH POST (R7-8)	EA	3
5. FIRE & RESCUE SIGNAGE PER CLV ORDINANCE #6325	EA	4
6.		
7.		
8.		
DRY UTILITIES		
1. 100W H.P.S. LUMINAIRE STREET LIGHT W/DECORATIVE POLE	EA	1
2. 1-1/4" PVC STREET LIGHT CONDUIT WITH (2) #4 AND (1) #8 CONDUCTORS	LF	1
3. NO. 3-1/2 PULL BOX W/METAL COVER	EA	1
4. 150 AMP SERVICE PEDESTAL (RR)	EA	1
5. 200 AMP SERVICE PEDESTAL (STLT)	EA	1
6.		

APPROVED FOR CONSTRUCTION

 LAS VEGAS VALLEY WATER DISTRICT ENGINEERING SERVICE
 PROJECT No. 125227 FIRST APPROVED DATE: 11/14/17
 LVWD APPROVED FIRE FLOW 2,875 GPM AT 20 PSI RESIDUAL

FAST
 Call before you dig
 UnderGround
 1-702-432-5300
 FREEWAY & ARTERIAL SYSTEM
 OF TRANSPORTATION (F.A.S.T.)

AVOID HITTING UNDERGROUND TRAFFIC SIGNAL SYSTEMS AND STREET LIGHT SYSTEM CONDUITS. IT'S COSTLY.
 Call before you dig
 UnderGround
 1-702-455-6000
 CLARK COUNTY TRAFFIC OPERATIONS AND
 1-702-432-5300
 (FREEWAY AND ARTERIAL SYSTEM OF TRANSPORTATION)

Call before you dig
 AVOID CUTTING UNDERGROUND UTILITY LINES. IT'S COSTLY.
 Call 811
 OR
 1-800-227-2600
 AND
 CLARK COUNTY TRAFFIC OPERATIONS
 1-702-455-6000

SLATER HANIFAN GROUP
 CONSULTING ENGINEERS & PLANNERS
 5740 S. ARVILLE STREET #216, LAS VEGAS, NV 89118
 PHONE (702) 284-5390 FAX (702) 284-5399

ETHOS THREE ARCHITECTURE
 SKYE CANYON SOMERSET ACADEMY
 GENERAL NOTES AND QUANTITIES

NO.	DESCRIPTION	DATE	BY	APP.	DATE
1					
2					
3					
4					
5					
6					
7					
8					
9					
10					
11					
12					
13					
14					
15					
16					
17					
18					
19					
20					
21					
22					
23					
24					
25					
26					
27					
28					
29					
30					

CITY OF LAS VEGAS


DATE: 11/01/17
 DRAFTER: DNP
 DESIGNER: BCC
 CHECKED: STS
 PROJECT NO.
ETA1601-000

PROFESSIONAL ENGINEER - STATE OF NEVADA

 JERRY S. HANAN
 CIVIL
 No. 14167

C-3
 SHEET 3 OF 15
 HANSEN NO. 68370
 DWG NO. 715-196

PROJ.#125227 AGR116208 QS:126-12-SW

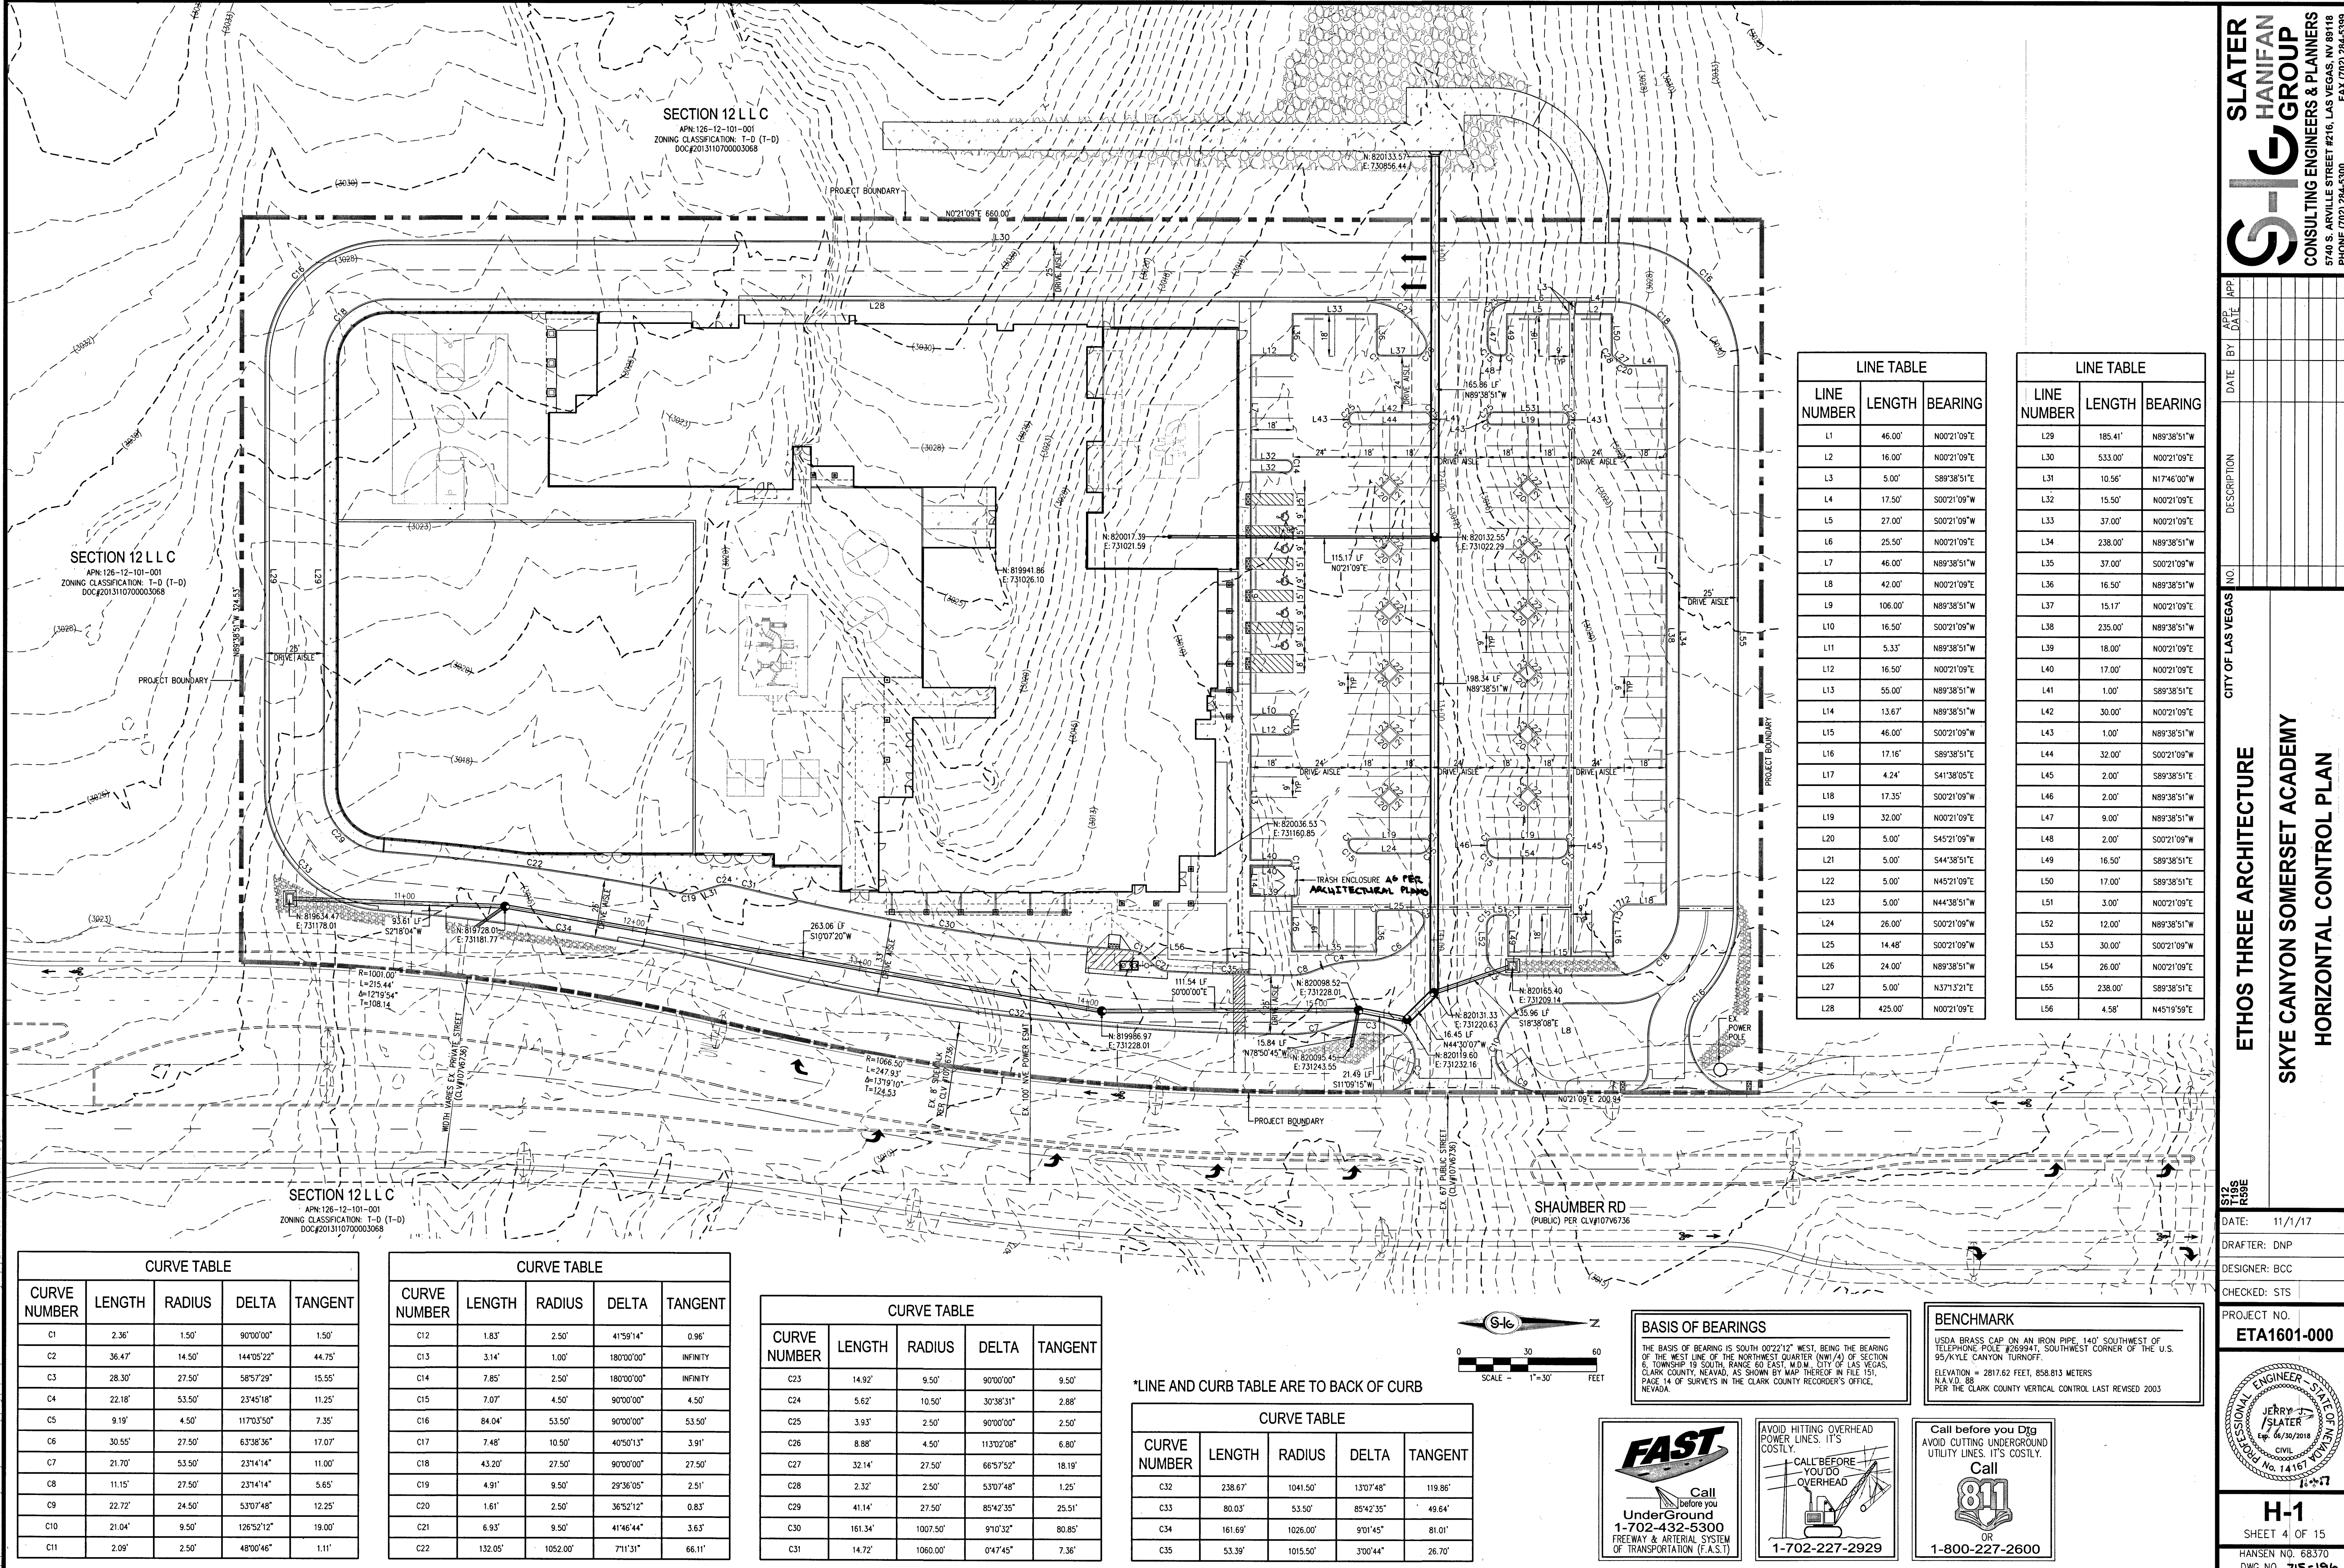

SECTION 12 L L C
APN: 126-12-101-001
ZONING CLASSIFICATION: T-D (T-D)
DOC#201311070003068

SECTION 12 L L C
APN: 126-12-101-001
ZONING CLASSIFICATION: T-D (T-D)
DOC#201311070003068

SECTION 12 L L C
APN: 126-12-101-001
ZONING CLASSIFICATION: T-D (T-D)
DOC#201311070003068

CURVE TABLE				
CURVE NUMBER	LENGTH	RADIUS	DELTA	TANGENT
C1	2.36'	1.50'	90°00'00"	1.50'
C2	36.47'	14.50'	144°05'22"	44.75'
C3	28.30'	27.50'	58°57'29"	15.55'
C4	22.18'	53.50'	23°45'18"	11.25'
C5	9.19'	4.50'	117°03'50"	7.35'
C6	30.55'	27.50'	63°38'36"	17.07'
C7	21.70'	53.50'	23°14'14"	11.00'
C8	11.15'	27.50'	23°14'14"	5.65'
C9	22.72'	24.50'	53°07'48"	12.25'
C10	21.04'	9.50'	126°52'12"	19.00'
C11	2.09'	2.50'	48°00'46"	1.11'

CURVE TABLE				
CURVE NUMBER	LENGTH	RADIUS	DELTA	TANGENT
C12	1.83'	2.50'	41°59'14"	0.96'
C13	3.14'	1.00'	180°00'00"	INFINITY
C14	7.85'	2.50'	180°00'00"	INFINITY
C15	7.07'	4.50'	90°00'00"	4.50'
C16	84.04'	53.50'	90°00'00"	53.50'
C17	7.48'	10.50'	40°50'13"	3.91'
C18	43.20'	27.50'	90°00'00"	27.50'
C19	4.91'	9.50'	29°36'05"	2.51'
C20	1.61'	2.50'	36°52'12"	0.83'
C21	6.93'	9.50'	41°46'44"	3.63'
C22	132.05'	1052.00'	7°11'31"	66.11'

CURVE TABLE				
CURVE NUMBER	LENGTH	RADIUS	DELTA	TANGENT
C23	14.92'	9.50'	90°00'00"	9.50'
C24	5.62'	10.50'	30°38'31"	2.88'
C25	3.93'	2.50'	90°00'00"	2.50'
C26	8.88'	4.50'	113°02'08"	6.80'
C27	32.14'	27.50'	66°57'52"	18.19'
C28	2.32'	2.50'	53°07'48"	1.25'
C29	41.14'	27.50'	85°42'35"	25.51'
C30	161.34'	1007.50'	9°10'32"	80.85'
C31	14.72'	1060.00'	0°47'45"	7.36'

*LINE AND CURB TABLE ARE TO BACK OF CURB

CURVE TABLE				
CURVE NUMBER	LENGTH	RADIUS	DELTA	TANGENT
C32	238.67'	1041.50'	13°07'48"	119.86'
C33	80.03'	53.50'	85°42'35"	49.64'
C34	161.69'	1026.00'	9°01'45"	81.01'
C35	53.39'	1015.50'	3°00'44"	26.70'

LINE TABLE		
LINE NUMBER	LENGTH	BEARING
L1	46.00'	N00°21'09"E
L2	16.00'	N00°21'09"E
L3	5.00'	S89°38'51"W
L4	17.50'	S00°21'09"W
L5	27.00'	S00°21'09"W
L6	25.50'	N00°21'09"E
L7	46.00'	N89°38'51"W
L8	42.00'	N00°21'09"E
L9	106.00'	N89°38'51"W
L10	16.50'	S00°21'09"W
L11	5.33'	S89°38'51"W
L12	16.50'	N00°21'09"E
L13	55.00'	N89°38'51"W
L14	13.67'	N89°38'51"W
L15	46.00'	S00°21'09"W
L16	17.16'	S89°38'51"E
L17	4.24'	S41°38'05"E
L18	17.35'	S00°21'09"W
L19	32.00'	N00°21'09"E
L20	5.00'	S45°21'09"W
L21	5.00'	S44°38'51"E
L22	5.00'	N45°21'09"E
L23	5.00'	N44°38'51"W
L24	26.00'	S00°21'09"W
L25	14.48'	S00°21'09"W
L26	24.00'	N89°38'51"W
L27	5.00'	N37°13'21"E
L28	425.00'	N00°21'09"E


LINE TABLE		
LINE NUMBER	LENGTH	BEARING
L29	185.41'	N89°38'51"W
L30	533.00'	N00°21'09"E
L31	10.56'	N17°46'00"W
L32	15.50'	N00°21'09"E
L33	37.00'	N00°21'09"E
L34	238.00'	N89°38'51"W
L35	37.00'	S00°21'09"W
L36	16.50'	N89°38'51"W
L37	15.17'	N00°21'09"E
L38	235.00'	N89°38'51"W
L39	18.00'	N00°21'09"E
L40	17.00'	N00°21'09"E
L41	1.00'	S89°38'51"E
L42	30.00'	N00°21'09"E
L43	1.00'	N89°38'51"W
L44	32.00'	S00°21'09"W
L45	2.00'	S89°38'51"E
L46	2.00'	N89°38'51"W
L47	9.00'	N89°38'51"W
L48	2.00'	S00°21'09"W
L49	16.50'	S89°38'51"E
L50	17.00'	S89°38'51"E
L51	3.00'	N00°21'09"E
L52	12.00'	N89°38'51"W
L53	30.00'	S00°21'09"W
L54	26.00'	N00°21'09"E
L55	238.00'	S89°38'51"E
L56	4.58'	N45°19'59"E


DATE	BY	APP.	DATE

CITY OF LAS VEGAS

ETHOS THREE ARCHITECTURE
SKYE CANYON SOMERSET ACADEMY
HORIZONTAL CONTROL PLAN

DATE: 11/1/17
DRAFTER: DNP
DESIGNER: BCC
CHECKED: STS
PROJECT NO.
ETA1601-000

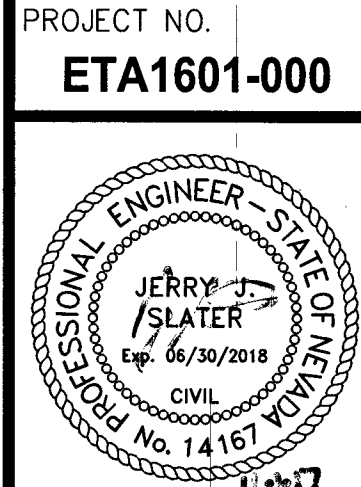

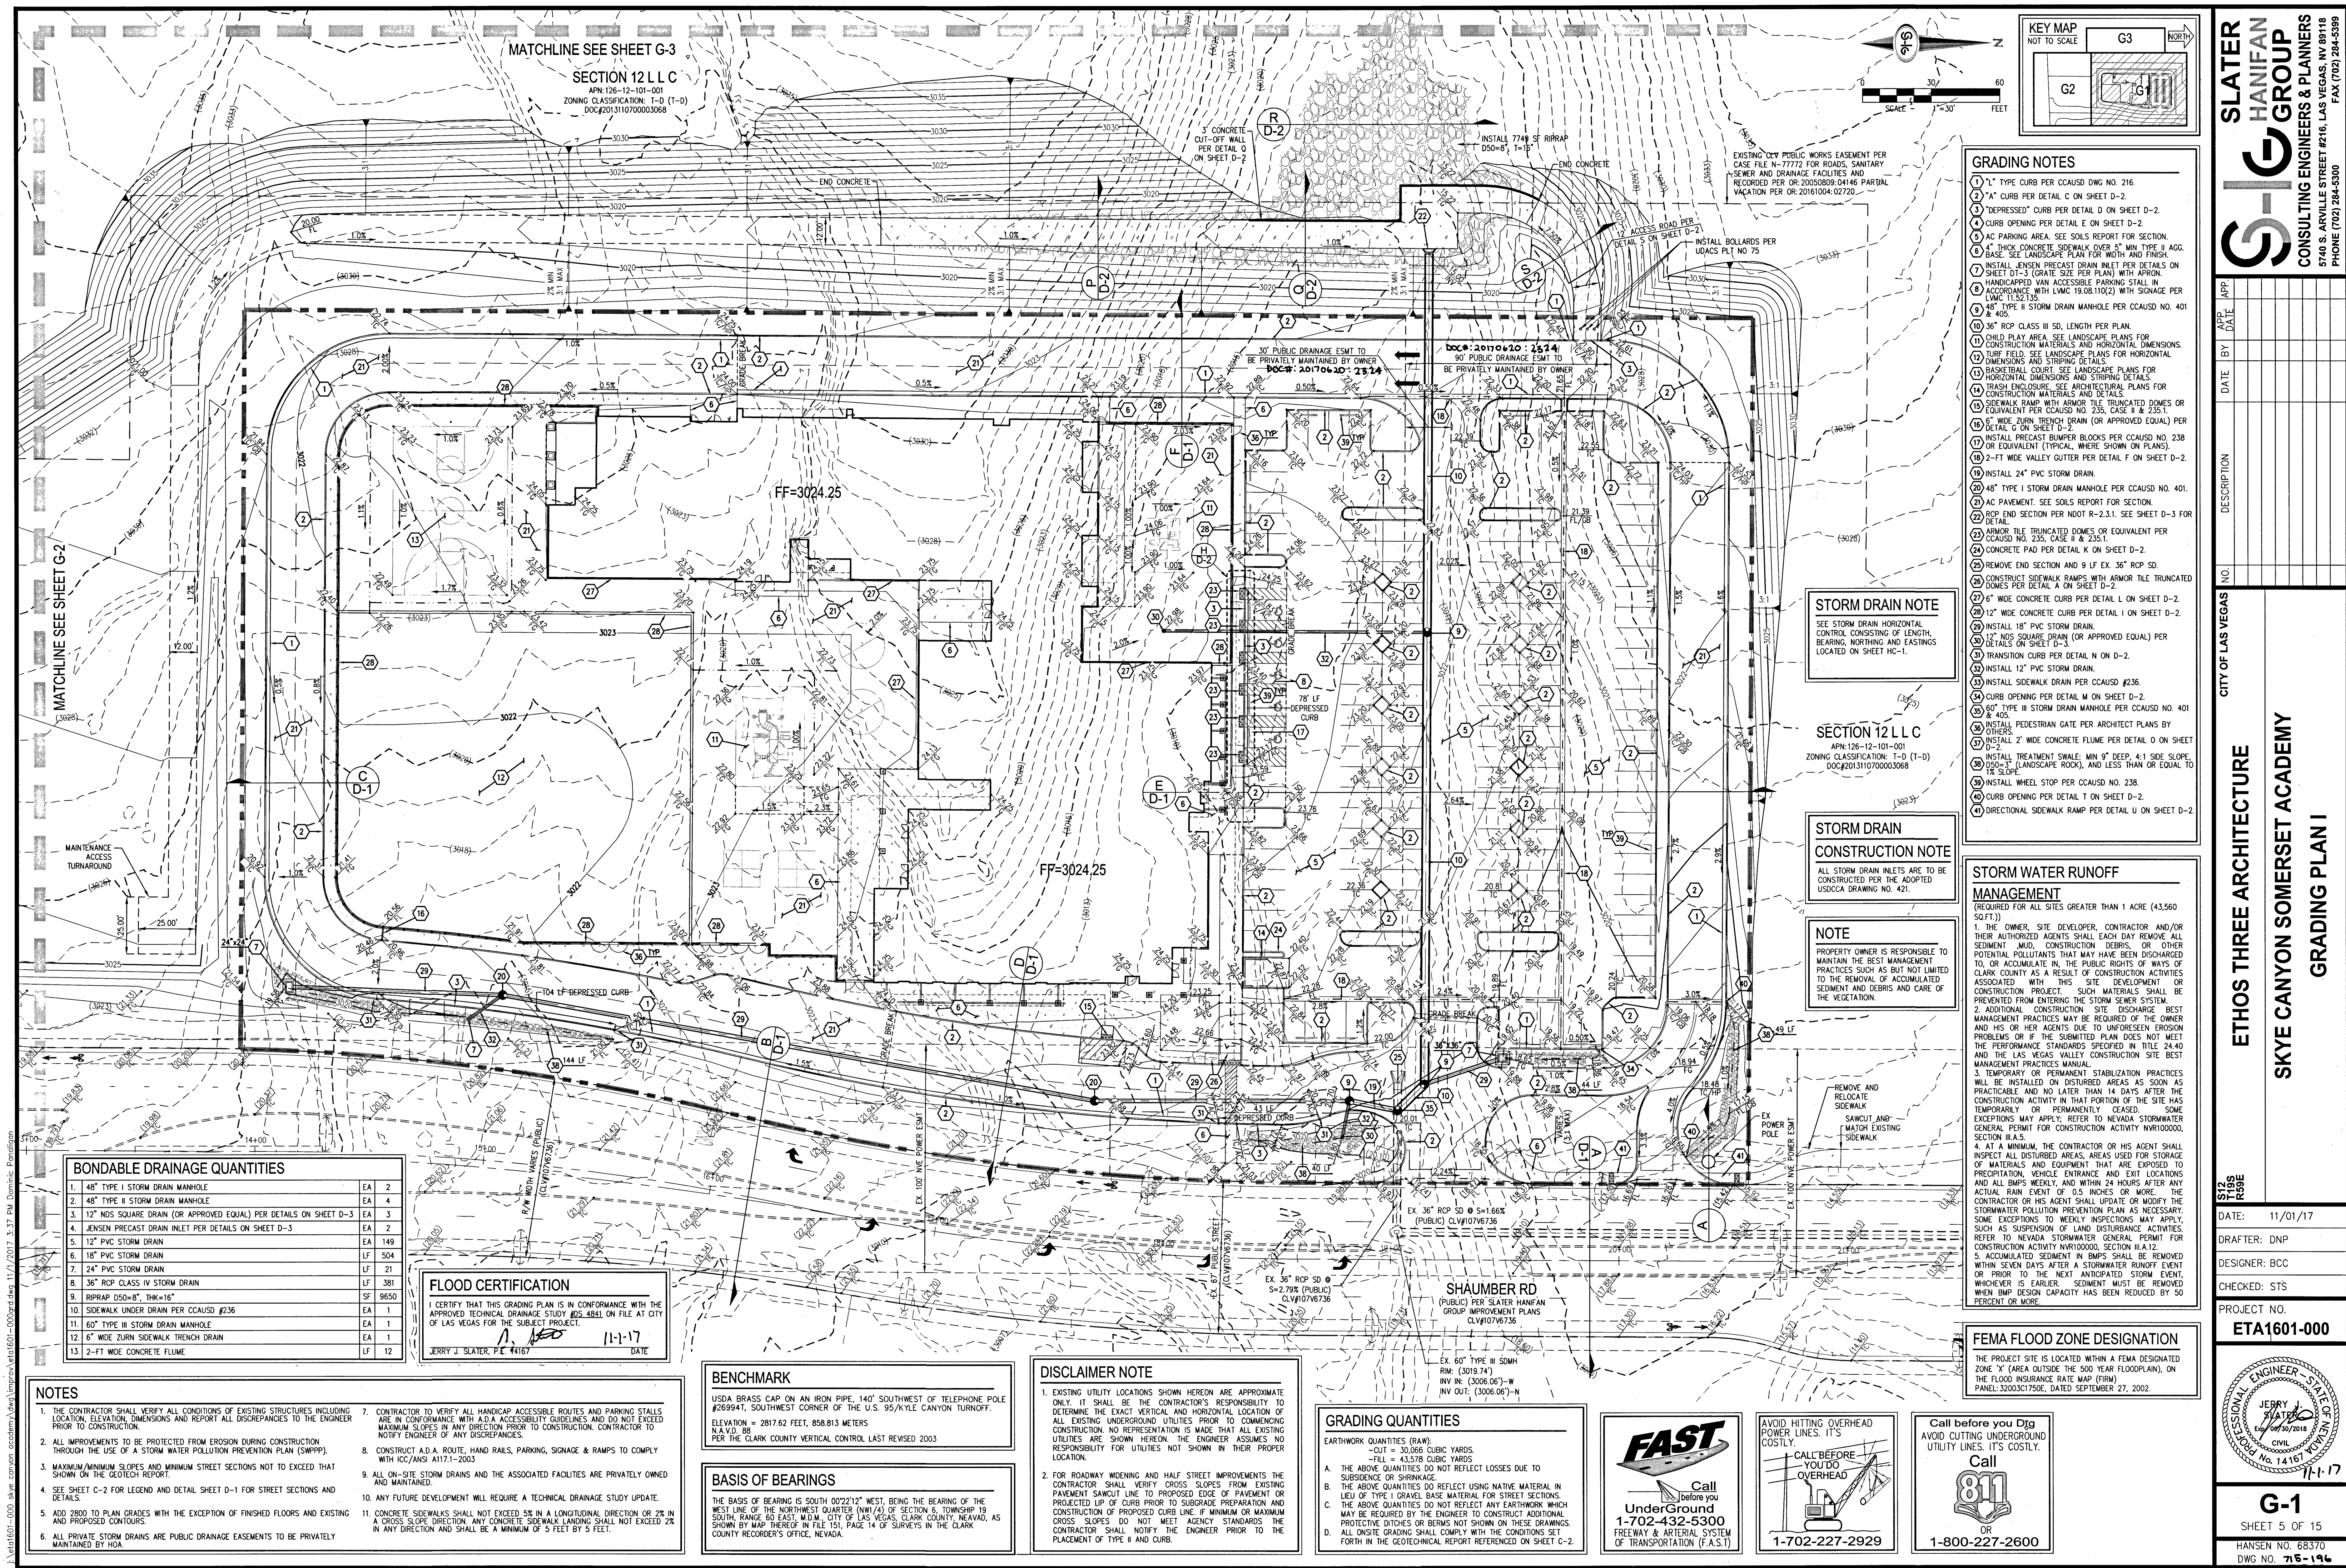

SECTION 12 L L C
APN: 126-12-101-001
ZONING CLASSIFICATION: T-D (T-D)
DOC#201311070003068

MATCHLINE SEE SHEET G-3

KEY MAP
NOT TO SCALE
G2 G3

SCALE
1" = 30'
0 30 60 FEET

GRADING NOTES

1. "L" TYPE CURB PER CCAUSD DWG NO. 216.
2. "A" CURB PER DETAIL C ON SHEET D-2.
3. "DEPRESSED" CURB PER DETAIL D ON SHEET D-2.
4. CURB OPENING PER DETAIL E ON SHEET D-2.
5. AC PARKING AREA. SEE SOILS REPORT FOR SECTION.
6. 4" THICK CONCRETE SIDEWALK OVER 5" MIN TYPE II AGG. BASE. SEE LANDSCAPE PLAN FOR WIDTH AND FINISH.
7. INSTALL JENSEN PRECAST DRAIN INLET PER DETAILS ON SHEET D-1-3 (GRATE SIZE PER PLAN) WITH APRON. HANDICAPPED VAN ACCESSIBLE PARKING SHALL BE IN ACCORDANCE WITH LVMC 19.08.11(2) WITH SIGNAGE PER LVMC 11.52.135.
8. 48" TYPE II STORM DRAIN MANHOLE PER CCAUSD NO. 401 & 405.
9. 36" RCP CLASS III SD, LENGTH PER PLAN.
10. CHILD PLAY AREA. SEE LANDSCAPE PLANS FOR CONSTRUCTION MATERIALS AND HORIZONTAL DIMENSIONS.
11. TURF FIELD. SEE LANDSCAPE PLANS FOR HORIZONTAL DIMENSIONS AND STRIPING DETAILS.
12. BASKETBALL COURT. SEE LANDSCAPE PLANS FOR HORIZONTAL DIMENSIONS AND STRIPING DETAILS.
13. TRASH ENCLOSURE. SEE ARCHITECTURAL PLANS FOR CONSTRUCTION MATERIALS AND DETAILS.
14. SIDEWALK RAMP WITH ARMOR TILE TRUNCATED DOMES OR EQUIVALENT PER CCAUSD NO. 235, CASE II & 235.1.
15. 6" WIDE ZURN TRENCH DRAIN (OR APPROVED EQUAL) PER DETAIL G ON SHEET D-2.
16. INSTALL PRECAST BLUMER BLOCKS PER CCAUSD NO. 238 OR EQUIVALENT (TYPICAL, WHERE SHOWN ON PLANS).
17. 2'-FT WIDE VALLEY CUTTER PER DETAIL F ON SHEET D-2.
18. INSTALL 24" PVC STORM DRAIN.
19. 48" TYPE I STORM DRAIN MANHOLE PER CCAUSD NO. 401.
20. AC PAVEMENT. SEE SOILS REPORT FOR SECTION.
21. 20' END SECTION PER NOTD R-2.3.1. SEE SHEET D-3 FOR DETAIL.
22. ARMOR TILE TRUNCATED DOMES OR EQUIVALENT PER CCAUSD NO. 235, CASE II & 235.1.
23. CONCRETE PAD PER DETAIL K ON SHEET D-2.
24. REMOVE END SECTION AND 9 LF EX. 36" RCP SD.
25. CONSTRUCT SIDEWALK RAMP WITH ARMOR TILE TRUNCATED DOMES PER DETAIL A ON SHEET D-2.
26. 6" WIDE CONCRETE CURB PER DETAIL L ON SHEET D-2.
27. 12" WIDE CONCRETE CURB PER DETAIL I ON SHEET D-2.
28. INSTALL 18" PVC STORM DRAIN.
29. 12" NOS SQUARE DRAIN (OR APPROVED EQUAL) PER DETAILS ON SHEET D-3.
30. TRANSITION CURB PER DETAIL N ON D-2.
31. INSTALL 12" PVC STORM DRAIN.
32. INSTALL SIDEWALK DRAIN PER CCAUSD #236.
33. CURB OPENING PER DETAIL M ON SHEET D-2.
34. 60" TYPE III STORM DRAIN MANHOLE PER CCAUSD NO. 401 & 405.
35. INSTALL PEDESTRIAN GATE PER ARCHITECT PLANS BY OTHERS.
36. INSTALL 2" WIDE CONCRETE FLUME PER DETAIL O ON SHEET D-2.
37. INSTALL TREATMENT SWALE: MIN 9" DEEP, 4:1 SIDE SLOPE, 120'-3" (LANDSCAPE ROCK), AND LESS THAN OR EQUAL TO 5' SLOPE.
38. INSTALL WHEEL STOP PER CCAUSD NO. 238.
39. CURB OPENING PER DETAIL T ON SHEET D-2.
40. DIRECTIONAL SIDEWALK RAMP PER DETAIL U ON SHEET D-2.

STORM DRAIN NOTE
SEE STORM DRAIN HORIZONTAL CONTROL CONSISTING OF LENGTH, BEARING, NORTHING AND EASTINGS LOCATED ON SHEET HC-1.

SECTION 12 L L C
APN: 126-12-101-001
ZONING CLASSIFICATION: T-D (T-D)
DOC#201311070003068

STORM DRAIN CONSTRUCTION NOTE
ALL STORM DRAIN INLETS ARE TO BE CONSTRUCTED PER THE ADOPTED USDOCA DRAWING NO. 421.

NOTE
PROPERTY OWNER IS RESPONSIBLE TO MAINTAIN THE BEST MANAGEMENT PRACTICES SUCH AS BUT NOT LIMITED TO THE REMOVAL OF ACCUMULATED SEDIMENT AND DEBRIS AND CARE OF THE VEGETATION.

STORM WATER RUNOFF MANAGEMENT
(REQUIRED FOR ALL SITES GREATER THAN 1 ACRE (43,560 SQ. FT.))

1. THE OWNER, SITE DEVELOPER, CONTRACTOR AND/OR THEIR AUTHORIZED AGENTS SHALL EACH DAY REMOVE ALL SEDIMENT, MUD, CONSTRUCTION DEBRIS, OR OTHER POTENTIAL POLLUTANTS THAT MAY HAVE BEEN DISCHARGED TO, OR ACCUMULATED IN, THE PUBLIC RIGHTS OF WAY OF CLARK COUNTY AS A RESULT OF CONSTRUCTION ACTIVITIES ASSOCIATED WITH THIS SITE DEVELOPMENT PROJECT. SUCH MATERIALS SHALL BE PREVENTED FROM ENTERING THE STORM SEWER SYSTEM.
2. ADDITIONAL CONSTRUCTION SITE DISCHARGE BEST MANAGEMENT PRACTICES MAY BE REQUIRED OF THE OWNER AND HIS OR HER AGENTS DUE TO UNFORSEEN EROSION PROBLEMS OR IF THE SUBMITTED PLAN DOES NOT MEET THE PERFORMANCE STANDARDS SPECIFIED IN TITLE 24.40 AND THE LAS VEGAS VALLEY CONSTRUCTION SITE BEST MANAGEMENT PRACTICES MANUAL.
3. TEMPORARY OR PERMANENT STABILIZATION PRACTICES WILL BE INSTALLED ON DISTURBED AREAS AS SOON AS PRACTICABLE AND NO LATER THAN 14 DAYS AFTER THE CONSTRUCTION ACTIVITY IN THAT PORTION OF THE SITE HAS TEMPORARILY OR PERMANENTLY CEASED. SOME EXCEPTIONS MAY APPLY. REFER TO NEVADA STORMWATER GENERAL PERMIT FOR CONSTRUCTION ACTIVITY NV100000, SECTION II.A.5.
4. AT A MINIMUM, THE CONTRACTOR OR HIS AGENT SHALL INSPECT ALL DISTURBED AREAS, AREAS USED FOR STORAGE OF MATERIALS AND EQUIPMENT THAT ARE EXPOSED TO PRECIPITATION, VEHICLE ENTRANCE, AND EXIT LOCATIONS AND ALL BMPs WEEKLY AND WITHIN 24 HOURS AFTER ANY ACTUAL RAIN EVENT OF 0.5 INCHES OR MORE. THE CONTRACTOR OR HIS AGENT SHALL UPDATE OR MODIFY THE STORMWATER POLLUTION PREVENTION PLAN AS NECESSARY. SOME EXCEPTIONS TO WEEKLY INSPECTIONS MAY APPLY, SUCH AS SUSPENSION OF LAND DISTURBANCE ACTIVITIES. REFER TO NEVADA STORMWATER GENERAL PERMIT FOR CONSTRUCTION ACTIVITY NV100000, SECTION II.A.12.
5. ACCUMULATED SEDIMENT IN BMPs SHALL BE REMOVED WITHIN SEVEN DAYS AFTER A STORMWATER RUNOFF EVENT OR PRIOR TO THE NEXT ANTICIPATED STORM EVENT, WHICHEVER IS EARLIER. SEDIMENT MUST BE REMOVED WHEN BMP DESIGN CAPACITY HAS BEEN REDUCED BY 50 PERCENT OR MORE.

BONDABLE DRAINAGE QUANTITIES

ITEM	QUANTITY	UNIT
1. 48" TYPE I STORM DRAIN MANHOLE	EA	2
2. 48" TYPE II STORM DRAIN MANHOLE	EA	4
3. 12" NOS SQUARE DRAIN (OR APPROVED EQUAL) PER DETAILS ON SHEET D-3	EA	3
4. JENSEN PRECAST DRAIN INLET PER DETAILS ON SHEET D-3	EA	2
5. 12" PVC STORM DRAIN	EA	149
6. 18" PVC STORM DRAIN	LF	504
7. 24" PVC STORM DRAIN	LF	21
8. 36" RCP CLASS IV STORM DRAIN	LF	381
9. RIPRAP D50=8", THK=16"	SF	9650
10. SIDEWALK UNDER DRAIN PER CCAUSD #236	EA	1
11. 60" TYPE III STORM DRAIN MANHOLE	EA	1
12. 6" WIDE ZURN SIDEWALK TRENCH DRAIN	EA	1
13. 2'-FT WIDE CONCRETE FLUME	LF	12

FLOOD CERTIFICATION
I, JERRY J. SLATER, P.E. #4167, CERTIFY THAT THIS GRADING PLAN IS IN CONFORMANCE WITH THE APPROVED TECHNICAL DRAINAGE STUDY #25-3841 ON FILE AT CITY OF LAS VEGAS FOR THE SUBJECT PROJECT.
DATE: 11-1-17

NOTES

1. THE CONTRACTOR SHALL VERIFY ALL CONDITIONS OF EXISTING STRUCTURES INCLUDING LOCATION, ELEVATION, DIMENSIONS AND REPORT ALL DISCREPANCIES TO THE ENGINEER PRIOR TO CONSTRUCTION.
2. ALL IMPROVEMENTS TO BE PROTECTED FROM EROSION DURING CONSTRUCTION THROUGH THE USE OF A STORM WATER POLLUTION PREVENTION PLAN (SWPPP).
3. MAXIMUM/MINIMUM SLOPES AND MINIMUM STREET SECTIONS NOT TO EXCEED THAT SHOWN ON THE GEOTECH REPORT.
4. SEE SHEET C-2 FOR LEGEND AND DETAIL SHEET D-1 FOR STREET SECTIONS AND DETAILS.
5. ADD 2800 TO PLAN GRADES WITH THE EXCEPTION OF FINISHED FLOORS AND EXISTING AND PROPOSED CONTOURS.
6. ALL PRIVATE STORM DRAINS ARE PUBLIC DRAINAGE EASEMENTS TO BE PRIVATELY MAINTAINED BY HOA.
7. CONTRACTOR TO VERIFY ALL HANDICAP ACCESSIBLE ROUTES AND PARKING STALLS ARE IN CONFORMANCE WITH A.D.A. ACCESSIBILITY GUIDELINES AND DO NOT EXCEED MAXIMUM SLOPES IN ANY DIRECTION PRIOR TO CONSTRUCTION. CONTRACTOR TO NOTIFY ENGINEER OF ANY DISCREPANCIES.
8. CONSTRUCT A.D.A. ROUTE, HAND RAILS, PARKING, SIGNAGE & RAMPS TO COMPLY WITH ICC/ANSI A117.1-2003.
9. ALL ON-SITE STORM DRAINS AND THE ASSOCIATED FACILITIES ARE PRIVATELY OWNED AND MAINTAINED.
10. ANY FUTURE DEVELOPMENT WILL REQUIRE A TECHNICAL DRAINAGE STUDY UPDATE.
11. CONCRETE SIDEWALKS SHALL NOT EXCEED 5% IN A LONGITUDINAL DIRECTION OR 2% IN A CROSS SLOPE DIRECTION. ANY CONCRETE SIDEWALK LANDINGS SHALL NOT EXCEED 2% IN ANY DIRECTION AND SHALL BE A MINIMUM OF 5 FEET BY 5 FEET.

BENCHMARK
USDA BRASS CAP ON AN IRON PIPE, 140' SOUTHWEST OF TELEPHONE POLE #26994T, SOUTHWEST CORNER OF THE U.S. 95/KYLE CANYON TURNOFF.
ELEVATION = 2817.62 FEET, 858.813 METERS
N.A.S.D. 88
FOR THE CLARK COUNTY VERTICAL CONTROL LAST REVISED 2003.

BASIS OF BEARINGS
THE BASIS OF BEARING IS SOUTH 00°22'12" WEST, BEING THE BEARING OF THE WEST LINE OF THE NORTHWEST QUARTER (NW1/4) OF SECTION 6, TOWNSHIP 19 SOUTH, RANGE 60 EAST, M.D.M. CITY OF LAS VEGAS, CLARK COUNTY, NEVADA, AS SHOWN BY MAP THEREOF IN FILE 151, PAGE 14 OF SURVEYS IN THE CLARK COUNTY RECORDER'S OFFICE, NEVADA.

DISCLAIMER NOTE

1. EXISTING UTILITY LOCATIONS SHOWN HEREON ARE APPROXIMATE ONLY. IT SHALL BE THE CONTRACTOR'S RESPONSIBILITY TO DETERMINE THE EXACT VERTICAL AND HORIZONTAL LOCATION OF ALL EXISTING UNDERGROUND UTILITIES PRIOR TO COMMENCING CONSTRUCTION. NO REPRESENTATION IS MADE THAT ALL EXISTING UTILITIES ARE SHOWN HEREON. THE ENGINEER ASSUMES NO RESPONSIBILITY FOR UTILITIES NOT SHOWN IN THEIR PROPER LOCATION.
2. FOR ROADWAY WIDENING AND HALF STREET IMPROVEMENTS THE CONTRACTOR SHALL VERIFY CROSS SLOPES FROM EXISTING PAVEMENT SAWCUT LINE TO PROPOSED ELEVATION OF PROPOSED CURB PRIOR TO SUBGRADE PREPARATION AND CONSTRUCTION OF PROPOSED CURB LINE. IF MINIMUM OR MAXIMUM CROSS SLOPES DO NOT MEET AGENCY STANDARDS THE CONTRACTOR SHALL NOTIFY THE ENGINEER PRIOR TO THE PLACEMENT OF TYPE II AND CURB.

GRADING QUANTITIES
EARTHWORK QUANTITIES (RAW):
- CUT = 30,086 CUBIC YARDS
- FILL = 43,578 CUBIC YARDS
THE ABOVE QUANTITIES DO NOT REFLECT LOSSES DUE TO SUBSIDENCE OR SHRINKAGE.
THE ABOVE QUANTITIES DO REFLECT USING NATIVE MATERIAL IN LIEU OF TYPE I GRAVEL BASE MATERIAL FOR STREET SECTIONS.
THE ABOVE QUANTITIES DO NOT REFLECT ANY EARTHWORK WHICH MAY BE REQUIRED BY THE ENGINEER TO CONSTRUCT ADDITIONAL PROTECTIVE DITCHES OR BERMS NOT SHOWN ON THESE DRAWINGS.
ALL ON-SITE GRADING SHALL COMPLY WITH THE CONDITIONS SET FORTH IN THE GEOTECHNICAL REPORT REFERENCED ON SHEET C-2.




FAST
Call before you Dig
Underground
1-702-432-5300
FIREWAY & MATERIAL SYSTEM OF TRANSPORTATION (F.A.S.T.)

AVOID HITTING OVERHEAD POWER LINES. IT'S COSTLY.
CALL BEFORE YOU DIG
1-702-227-2929

Call before you Dig
AVOID CUTTING UNDERGROUND UTILITY LINES. IT'S COSTLY.
Call 811
OR
1-800-227-2600

SHAUMBER RD
(PUBLIC) PER SLATER HANFAN GROUP IMPROVEMENT PLANS
CLV#1076736
EX 36" RCP SD @ S=1.65% (PUBLIC) CLV#1076736
EX 60" TYPE III SD MH
RM: (3019.74')
INV IN: (3006.06')-W
INV OUT: (3006.06')-N

FEMA FLOOD ZONE DESIGNATION
THE PROJECT SITE IS LOCATED WITHIN A FEMA DESIGNATED ZONE "X" (AREA OUTSIDE THE 500 YEAR FLOODPLAIN), ON THE FLOOD INSURANCE RATE MAP (FIRM) PANEL: 33003C1750E, DATED SEPTEMBER 27, 2002.

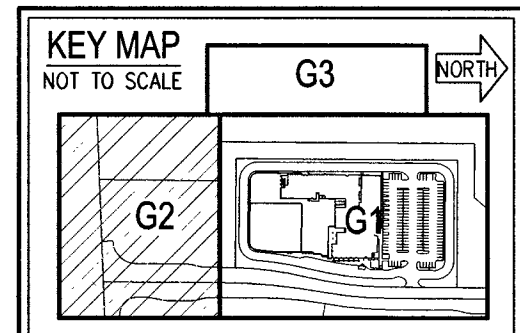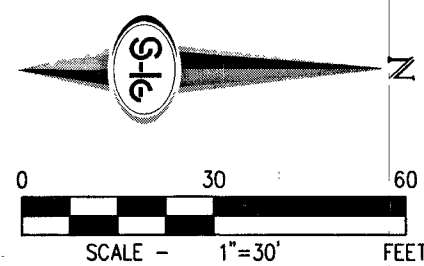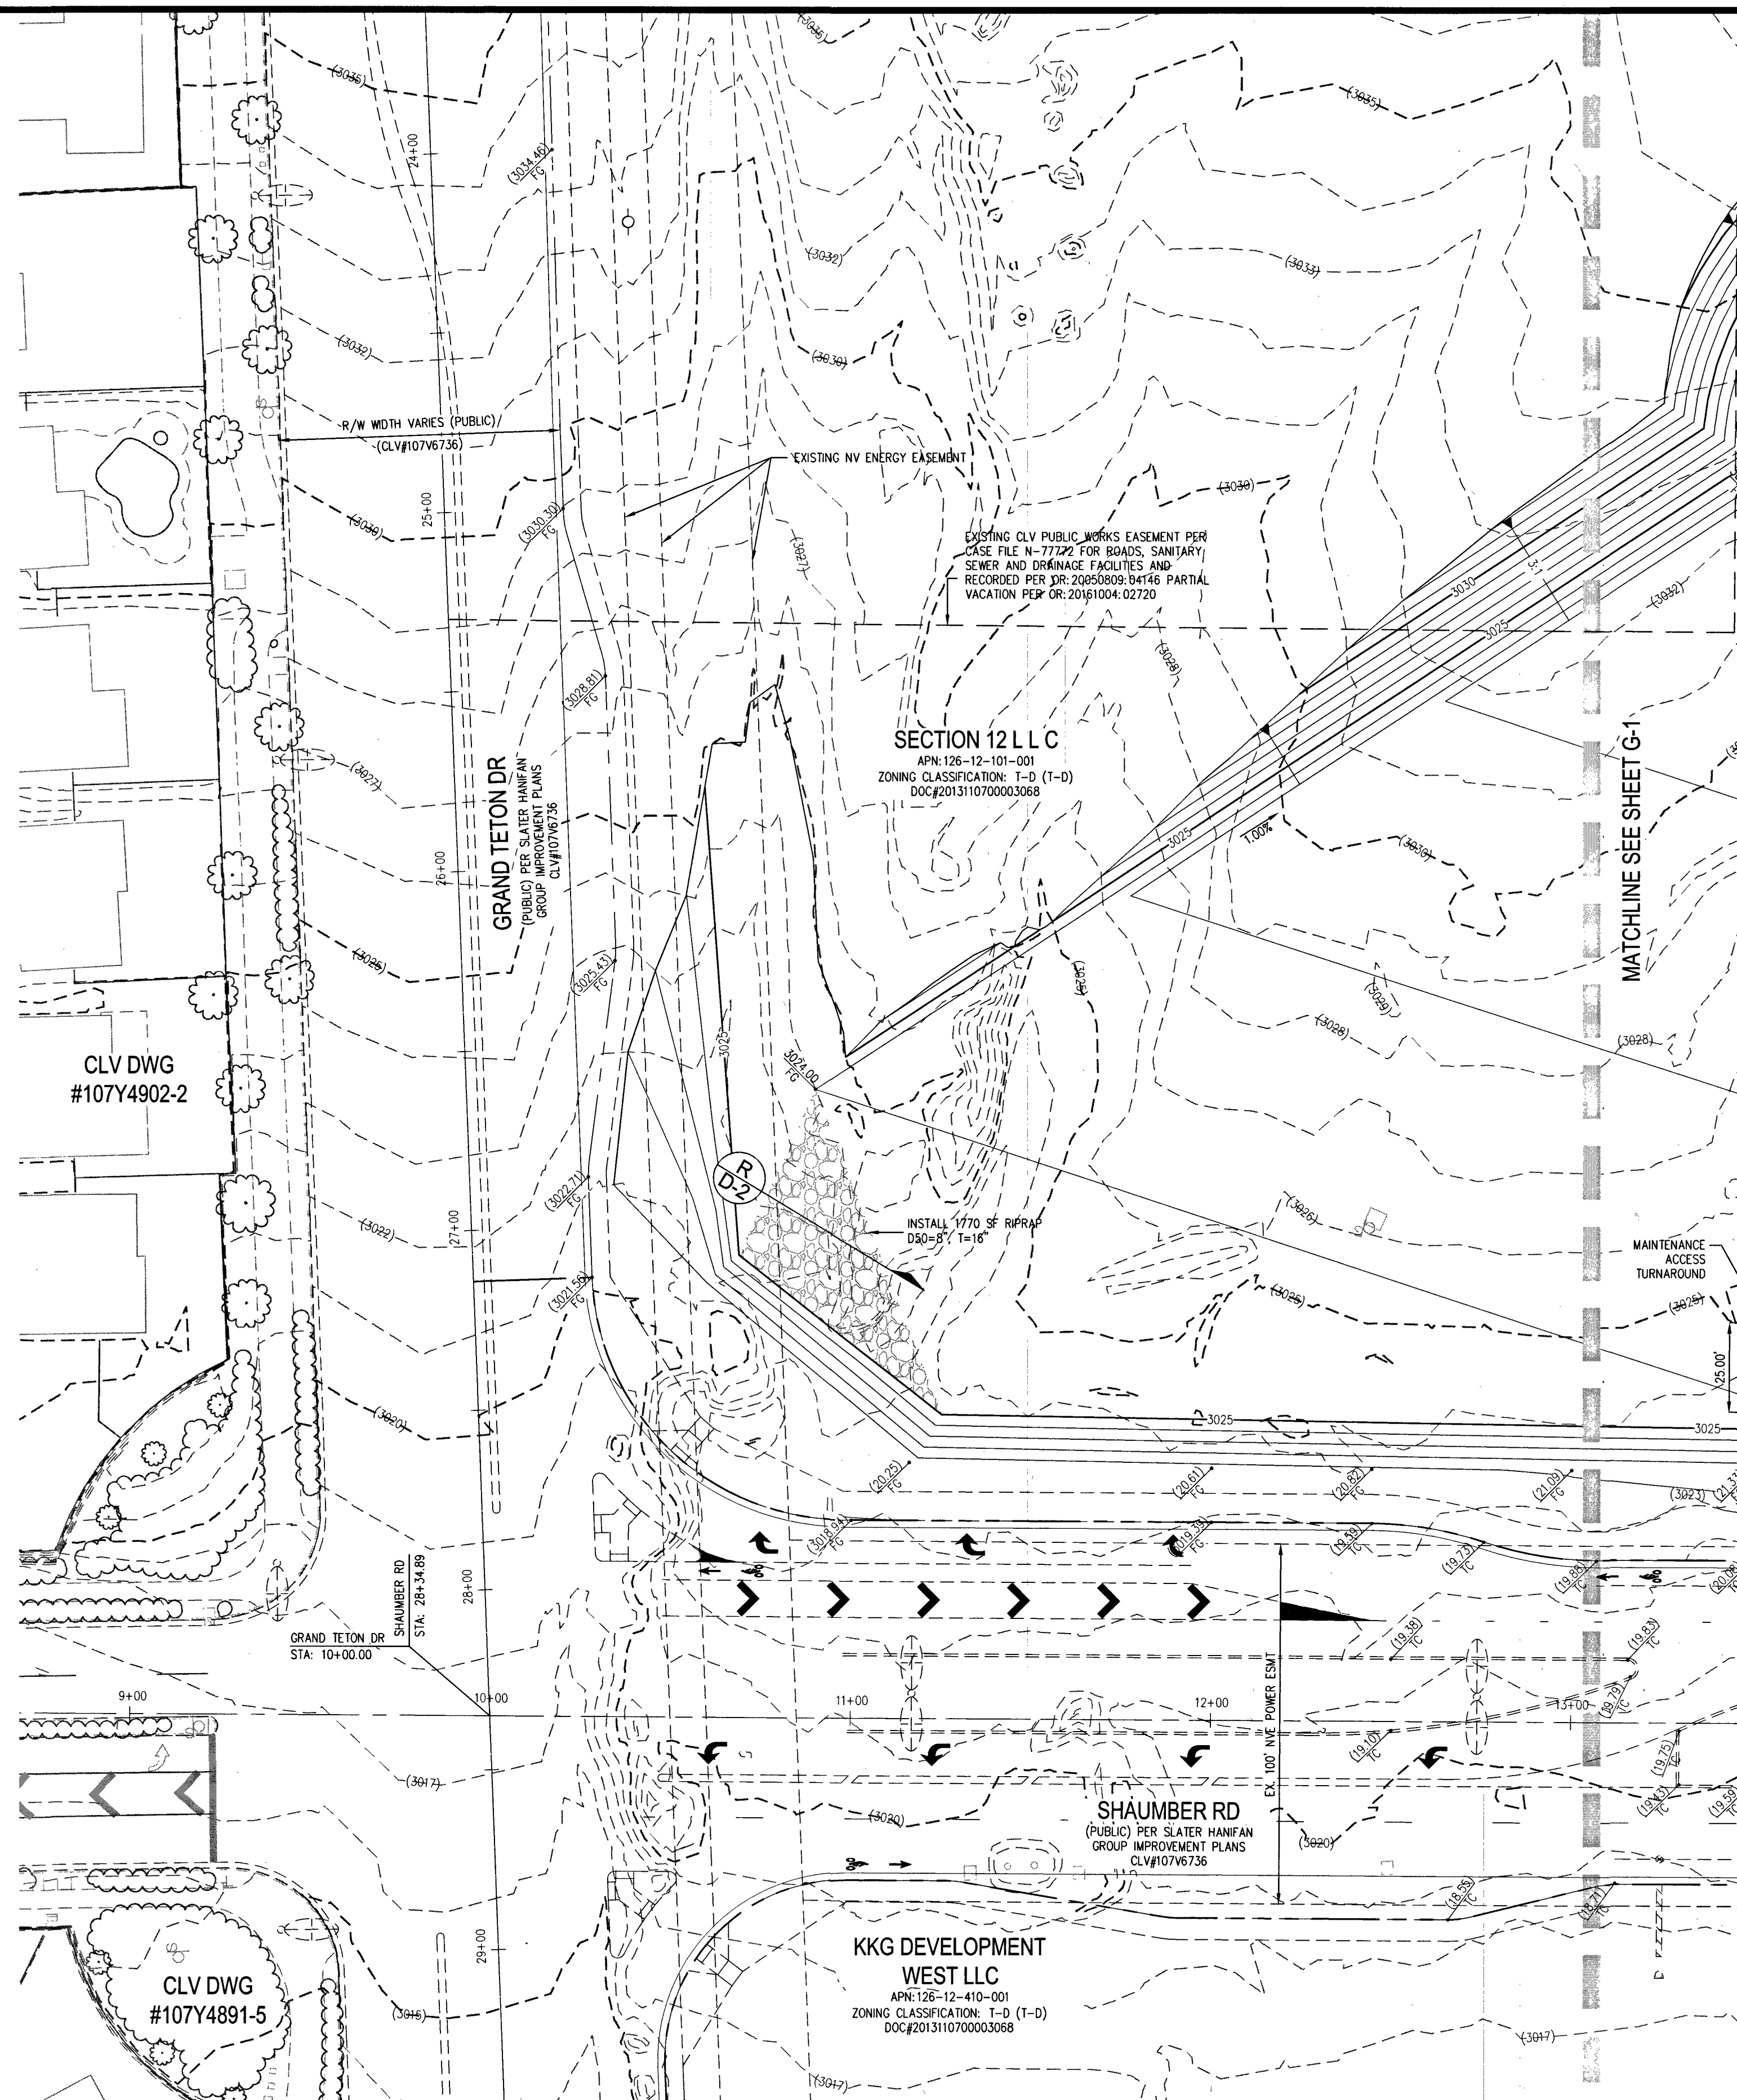

GRADING NOTES

1. "L" TYPE CURB PER CCAUSD DWG NO. 216.
2. "A" CURB PER DETAIL C ON SHEET D-2.
3. "DEPRESSED" CURB PER DETAIL D ON SHEET D-2.
4. CURB OPENING PER DETAIL E ON SHEET D-2.
5. AC PARKING AREA. SEE SOILS REPORT FOR SECTION.
6. 4" THICK CONCRETE SIDEWALK OVER 5" MIN TYPE II AGG. BASE. SEE LANDSCAPE PLAN FOR WIDTH AND FINISH.
7. INSTALL JENSEN PRECAST DRAIN INLET PER DETAILS ON SHEET D-1-3 (GRATE SIZE PER PLAN) WITH APRON.
8. HANDICAPPED VAN ACCESSIBLE PARKING STALL IN ACCORDANCE WITH LWC 18.08.110(2) WITH SIGNAGE PER LWC 11.52.135.
9. 48" TYPE II STORM DRAIN MANHOLE PER CCAUSD NO. 401 & 403.
10. 36" RCP CLASS III SD, LENGTH PER PLAN.
11. CHILD PLAY AREA. SEE LANDSCAPE PLANS FOR CONSTRUCTION MATERIALS AND HORIZONTAL DIMENSIONS.
12. TURF FIELD. SEE LANDSCAPE PLANS FOR HORIZONTAL DIMENSIONS AND STRIPING DETAILS.
13. BASKETBALL COURT. SEE LANDSCAPE PLANS FOR HORIZONTAL DIMENSIONS AND STRIPING DETAILS.
14. TRASH ENCLOSURE. SEE ARCHITECTURAL PLANS FOR CONSTRUCTION MATERIALS AND DETAILS.
15. SIDEWALK RAMP WITH ARMOR TILE TRUNCATED DOMES OR EQUIVALENT PER CCAUSD NO. 235, CASE II & 235.1.
16. 6" WIDE ZURN TRENCH DRAIN (OR APPROVED EQUAL) PER DETAIL C ON SHEET D-2.
17. INSTALL PRECAST BUMPER BLOCKS PER CCAUSD NO. 238 OR EQUIVALENT (TYPICAL WHERE SHOWN ON PLANS).
18. 2-FT WIDE VALLEY GUTTER PER DETAIL F ON SHEET D-2.
19. INSTALL 24" PVC STORM DRAIN.
20. 48" TYPE I STORM DRAIN MANHOLE PER CCAUSD NO. 401.
21. AC PAVEMENT. SEE SOILS REPORT FOR SECTION.
22. RCP END SECTION PER DETAIL R-2.3.1. SEE SHEET D-3 FOR DETAIL.
23. ARMOR TILE TRUNCATED DOMES OR EQUIVALENT PER CCAUSD NO. 235, CASE II & 235.1.
24. CONCRETE PAD PER DETAIL K ON SHEET D-2.
25. REMOVE END SECTION AND 9 LF EX. 36" RCP SD.
26. CONSTRUCT SIDEWALK RAMPS WITH ARMOR TILE TRUNCATED DOMES PER DETAIL A ON SHEET D-2.
27. 6" WIDE CONCRETE CURB PER DETAIL L ON SHEET D-2.
28. 12" WIDE CONCRETE CURB PER DETAIL I ON SHEET D-2.
29. INSTALL 18" PVC STORM DRAIN.
30. 12" NDS SQUARE DRAIN (OR APPROVED EQUAL) PER DETAILS ON SHEET D-3.
31. TRANSITION CURB PER DETAIL N ON D-2.
32. INSTALL 12" PVC STORM DRAIN.
33. INSTALL SIDEWALK DRAIN PER CCAUSD #236.
34. CURB OPENING PER DETAIL M ON SHEET D-2.
35. 60" TYPE III STORM DRAIN MANHOLE PER CCAUSD NO. 401 & 403.
36. INSTALL PEDESTRIAN GATE PER ARCHITECT PLANS BY OTHERS.
37. INSTALL 2" WIDE CONCRETE FLUME PER DETAIL O ON SHEET D-2.
38. INSTALL TREATMENT SHALE: MIN 9" DEEP, 4:1 SIDE SLOPE, D50=3 (LANDSCAPE ROCK), AND LESS THAN OR EQUAL TO 1/2 SLOPE.
39. INSTALL WHEEL STOP PER CCAUSD NO. 238.
40. CURB OPENING PER DETAIL T ON SHEET D-2.
41. DIRECTIONAL SIDEWALK RAMP PER DETAIL U ON SHEET D-2.

STORM DRAIN CONSTRUCTION NOTE

ALL STORM DRAIN INLETS ARE TO BE CONSTRUCTED PER THE ADOPTED USDOCA DRAWING NO. 421.

NOTE

PROPERTY OWNER IS RESPONSIBLE TO MAINTAIN THE BEST MANAGEMENT PRACTICES SUCH AS BUT NOT LIMITED TO THE REMOVAL OF ACCUMULATED SEDIMENT AND DEBRIS AND CARE OF THE VEGETATION.

FLOOD CERTIFICATION

I CERTIFY THAT THIS GRADING PLAN IS IN CONFORMANCE WITH THE APPROVED TECHNICAL DRAINAGE STUDY (DGS 4841) ON FILE AT CITY OF LAS VEGAS FOR THE SUBJECT PROJECT.

JERRY SLATER, P.E. 14167 DATE 11-1-17

BONDABLE DRAINAGE QUANTITIES

1. 48" TYPE I STORM DRAIN MANHOLE	EA	2
2. 48" TYPE II STORM DRAIN MANHOLE	EA	4
3. 12" NDS SQUARE DRAIN (OR APPROVED EQUAL) PER DETAILS ON SHEET D-3	EA	2
4. JENSEN PRECAST DRAIN INLET PER DETAILS ON SHEET D-3	EA	2
5. 12" PVC STORM DRAIN	EA	131
6. 18" PVC STORM DRAIN	LF	504
7. 24" PVC STORM DRAIN	LF	21
8. 36" RCP CLASS IV STORM DRAIN	LF	381
9. RIPRAP D50=8", THK=16"	SF	9650
10. SIDEWALK UNDER DRAIN PER CCAUSD #236	EA	1
11. 60" TYPE III STORM DRAIN MANHOLE	EA	1
12. 6" WIDE ZURN SIDEWALK TRENCH DRAIN	EA	1
13. 2-FT WIDE CONCRETE FLUME	LF	12

GRADING QUANTITIES

- EARTHWORK QUANTITIES (RAW):
- CUT = 30,066 CUBIC YARDS
 - FILL = 43,578 CUBIC YARDS
- A. THE ABOVE QUANTITIES DO NOT REFLECT LOSSES DUE TO SUBSIDENCE OR SHRINKAGE.
- B. THE ABOVE QUANTITIES DO REFLECT USING NATIVE MATERIAL IN LIEU OF TYPE I GRAVEL BASE MATERIAL FOR STREET SECTIONS.
- C. THE ABOVE QUANTITIES DO NOT REFLECT ANY EARTHWORK WHICH MAY BE REQUIRED BY THE ENGINEER TO CONSTRUCT ADDITIONAL PROTECTIVE DITCHES OR BERMS NOT SHOWN ON THESE DRAWINGS.
- D. ALL ON-SITE GRADING SHALL COMPLY WITH THE CONDITIONS SET FORTH IN THE GEOTECHNICAL REPORT REFERENCED ON SHEET C-2.

BENCHMARK

USDA BRASS CAP ON AN IRON PIPE, 140' SOUTHWEST OF TELEPHONE POLE #269941, SOUTHWEST CORNER OF THE U.S. 95/KYLE CANYON TURNOFF. ELEVATION = 2817.62 FEET, 858.813 METERS N.A. VD, 88 PER THE CLARK COUNTY VERTICAL CONTROL, LAST REVISED 2003.

BASIS OF BEARINGS



THE BASIS OF BEARING IS SOUTH 00°22'12" WEST, BEING THE BEARING OF THE WEST LINE OF THE NORTHWEST QUARTER (NW/4) OF SECTION 6, TOWNSHIP 19 SOUTH, RANGE 60 EAST, 114th E. OF LAS VEGAS, CLARK COUNTY, NEVADA, AS SHOWN BY MAP THEREOF IN FILE 151, PAGE 14 OF SURVEYS IN THE CLARK COUNTY RECORDER'S OFFICE, NEVADA.

DISCLAIMER NOTE

1. EXISTING UTILITY LOCATIONS SHOWN HEREON ARE APPROXIMATE ONLY. IT SHALL BE THE CONTRACTOR'S RESPONSIBILITY TO DETERMINE THE EXACT VERTICAL AND HORIZONTAL LOCATION OF ALL EXISTING UNDERGROUND UTILITIES PRIOR TO COMMENCING CONSTRUCTION. NO REPRESENTATION IS MADE THAT ALL EXISTING UTILITIES ARE SHOWN HEREON. THE ENGINEER ASSUMES NO RESPONSIBILITY FOR UTILITIES NOT SHOWN IN THEIR PROPER LOCATION.
2. FOR ROADWAY WIDENING AND HALF STREET IMPROVEMENTS THE CONTRACTOR SHALL VERIFY CROSS SLOPES FROM EXISTING PAVEMENT SCAOUT LINE TO PROPOSED EDGE OF PAVEMENT OR PROJECTED LIP OF CURB PRIOR TO SUBGRADE PREPARATION AND CONSTRUCTION OF PROPOSED CURB LINE. IF MINIMUM OR MAXIMUM CROSS SLOPES DO NOT MEET AGENCY STANDARDS THE CONTRACTOR SHALL NOTIFY THE ENGINEER PRIOR TO THE PLACEMENT OF TYPE II AND CURB.

NOTES

1. THE CONTRACTOR SHALL VERIFY ALL CONDITIONS OF EXISTING STRUCTURES INCLUDING LOCATION, ELEVATION, DIMENSIONS AND REPORT ALL DISCREPANCIES TO THE ENGINEER PRIOR TO CONSTRUCTION.
2. ALL IMPROVEMENTS TO BE PROTECTED FROM EROSION DURING CONSTRUCTION THROUGH THE USE OF A STORM WATER POLLUTION PREVENTION PLAN (SWPPP).
3. MAXIMUM/MINIMUM SLOPES AND MINIMUM STREET SECTIONS NOT TO EXCEED THAT SHOWN ON THE GEOTECH REPORT.
4. SEE SHEET C-2 FOR LEGEND AND DETAIL SHEET D-1 FOR STREET SECTIONS AND DETAILS.
5. ADD 2800 TO PLAN GRADES WITH THE EXCEPTION OF FINISHED FLOORS AND EXISTING AND PROPOSED CONTOURS.
6. ALL PRIVATE STORM DRAINS ARE PUBLIC DRAINAGE EASEMENTS TO BE PRIVATELY MAINTAINED BY HOA.
7. CONTRACTOR TO VERIFY ALL HANDICAP ACCESSIBLE ROUTES AND PARKING STALLS ARE IN CONFORMANCE WITH A.D.A. ACCESSIBILITY GUIDELINES AND DO NOT EXCEED MAXIMUM SLOPES IN ANY DIRECTION PRIOR TO CONSTRUCTION. CONTRACTOR TO NOTIFY ENGINEER OF ANY DISCREPANCIES.
8. CONSTRUCT A.D.A. ROUTE, HAND RAILS, PARKING, SIGNAGE & RAMPS TO COMPLY WITH ICC/ANSI A117.1-2003.
9. ALL ON-SITE STORM DRAINS AND THE ASSOCIATED FACILITIES ARE PRIVATELY OWNED AND MAINTAINED.
10. ANY FUTURE DEVELOPMENT WILL REQUIRE A TECHNICAL DRAINAGE STUDY UPDATE.
11. CONCRETE SIDEWALKS SHALL NOT EXCEED 5% IN A LONGITUDINAL DIRECTION OR 2% IN A CROSS SLOPE DIRECTION. ANY CONCRETE SIDEWALK LANDING SHALL NOT EXCEED 2% IN ANY DIRECTION AND SHALL BE A MINIMUM OF 5 FEET BY 5 FEET.

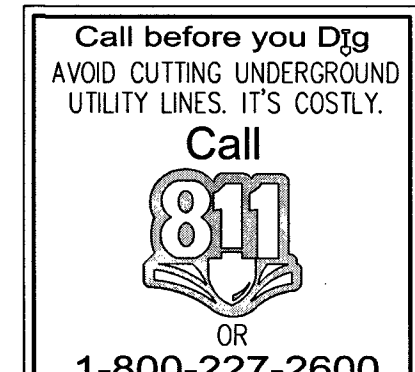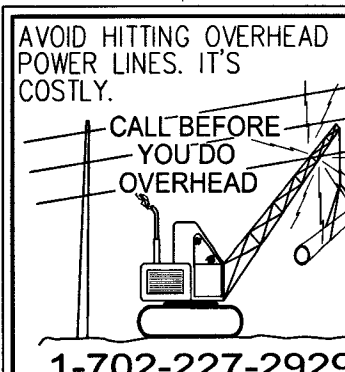

FEMA FLOOD ZONE DESIGNATION

THE PROJECT SITE IS LOCATED WITHIN A FEMA DESIGNATED ZONE 'X' (AREA OUTSIDE THE 500 YEAR FLOODPLAIN), ON THE FLOOD INSURANCE RATE MAP (FIRM) PANEL: 3200301750E, DATED SEPTEMBER 27, 2002.



SLATER HANIFAN GROUP
CONSULTING ENGINEERS & PLANNERS
5740 S. ARVILLE STREET #216, LAS VEGAS, NV 89118
PHONE (702) 284-5300
FAX (702) 284-5399

ETHOS THREE ARCHITECTURE
SKYE CANYON SOMERSET ACADEMY
GRADING PLAN II

G-2
SHEET 6 OF 15
HANSEN NO. 68370
DWG NO. 715-196

DATE: 11/01/17
DRAFTER: DNP
DESIGNER: BCC
CHECKED: STS
PROJECT NO. ETA1601-000

JERRY SLATER
P.E.
14167
11-1-17

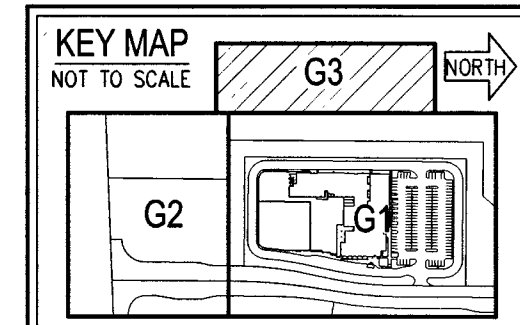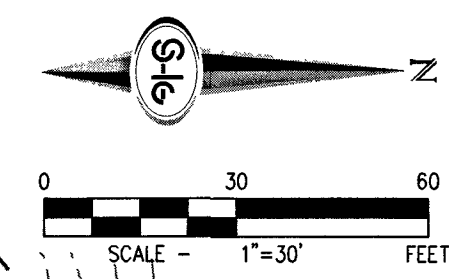

- 1 "L" TYPE CURB PER CAUSD DWG NO. 216.
- 2 "K" CURB PER DETAIL C ON SHEET D-2.
- 3 "DEPRESSED" CURB PER DETAIL D ON SHEET D-2.
- 4 CURB OPENING PER DETAIL E ON SHEET D-2.
- 5 AC PARKING AREA. SEE SOLS REPORT FOR SECTION.
6 TWICK DRIVE. SEE LANDSCAPE PLANS FOR DETAIL.
7 "W" TYPE CURB PER DETAIL F ON SHEET D-2.
8 BASE. SEE LANDSCAPE PLAN FOR WIDTH AND FINISH.
- 9 INSTALL JENSEN PRECAST DRAIN INLET PER DETAILS ON
10 SHEET D-2. (GRADE 2.35' MINUS 1' MINUS TYPE II AGG.
11 HANDICAPPED VAN ACCESSIBLE PARKING STALL IN
12 ACCORDANCE WITH LWC 19.08.11(2) WITH SIGNAGE PER
13 48".
14 TYPE II STORM DRAIN MANHOLE PER CAUSD NO. 401
15 & 405.
- 16 36" RCP CLASS III SO, LENGTH PER PLAN.
- 17 SHOW PLAY AREA. SEE LANDSCAPE PLANS FOR
18 CONSTRUCTION MATERIALS AND HORIZONTAL DIMENSIONS.
19 TURF FIELD. SEE LANDSCAPE PLANS FOR HORIZONTAL
20 DIMENSIONS AND STRIPING.
- 21 BASKETBALL COURT. SEE LANDSCAPE PLANS FOR
22 HORIZONTAL DIMENSIONS AND STRIPING DETAILS.
- 23 FLASH EROSION CONTROL. SEE LANDSCAPE PLANS FOR
24 CONSTRUCTION MATERIALS AND DETAILS.
- 25 SIDEWALK. SEE DETAIL FOR ARMOR LITE TRUNCATED DOMES OR
26 1" MIN. GRANITE. SEE DETAIL C ON SHEET D-2 & 235.1.
- 27 6" WIDE ZURN TRENCH DRAIN (OR APPROVED EQUAL) PER
28 SHEET D-2.
- 29 INSTALL PRECAST BUMPER BLOCKS PER CAUSD NO. 238
30 OR EQUIVALENT (TYPICAL, WHERE SHOWN ON PLANS).
- 31 2"-FT WIDE VALLEY GUTTER PER DETAIL F ON SHEET D-2.
- 32 INSTALL 24" PVC STORM DRAIN.
- 33 48" TYPE I STORM DRAIN MANHOLE PER CAUSD NO. 401.
- 34 AC PAVEMENT. SEE SOLS REPORT FOR SECTION.
- 35 RCP END SECTION PER NDOT R-2.3.1. SEE SHEET D-3 FOR
36 DETAIL.
- 37 CONCRETE PAD PER DETAIL K ON SHEET D-2.
- 38 REMOVE END SECTION AND 9 LF EX. 36" RCP SD.
- 39 CONSTRUCT SIDEWALK RAMPS WITH ARMOR LITE TRUNCATED
40 DOMES PER DETAIL A ON SHEET D-2.
- 41 6" WIDE CONCRETE CURB PER DETAIL L ON SHEET D-2.
- 42 12" WIDE CONCRETE CURB PER DETAIL I ON SHEET D-2.
- 43 INSTALL 18" PVC STORM DRAIN.
- 44 18" NOS SIDE DRAIN (OR APPROVED EQUAL) ON
45 DETAILS ON SHEET D-2.
- 46 TRANSITION CURB PER DETAIL N ON D-2.
- 47 INSTALL 12" PVC STORM DRAIN.
- 48 INSTALL SIDEWALK RAMP PER CAUSD #236.
- 49 CURB OPENING PER DETAIL M ON SHEET D-2.
- 50 60" TYPE II STORM DRAIN MANHOLE PER CAUSD NO. 401
51 & 405.
- 52 18" PEDESTRIAN CATCH PER ARCHITECT PLANS BY
53 OTHERS.
- 54 INSTALL 2' WIDE CONCRETE FLOUSE PER DETAIL O ON SHEET
55 D-2.
- 56 INSTALL TREATMENT SWALE: 10" DEEP, 4' SIDE SLOPE,
57 12" WIDE (LANDSCAPE ROCKS), AND LESS THAN OR EQUAL TO
58 1% SLOPE.
- 59 INSTALL WHEEL STOP PER CAUSD NO. 238.
- 60 CURB OPENING PER DETAIL P ON SHEET D-2.
- 61 DIRECTIONAL SIDEWALK RAMP PER DETAIL U ON SHEET D-2.

MANAGEMENT

(REQUIRED FOR ALL SITES GREATER THAN 1 ACRE (43,600 SQ. FT.))

1. THE OWNER, SITE DEVELOPER, CONTRACTOR AND/OR THEIR AUTHORIZED AGENTS SHALL EACH DAY REMOVE ALL SEDIMENT AND CONSTRUCTION DEBRIS, OR OTHER POTENTIAL POLLUTANTS THAT MAY HAVE BEEN EXPOSED TO, ACCUMULATE IN THE PUBLIC RIGHTS OF WAYS OF CLARK COUNTY AS A RESULT OF CONSTRUCTION ACTIVITIES ASSOCIATED WITH THIS SITE DEVELOPMENT OR CONSTRUCTION PROJECT. SUCH MATERIALS SHALL BE PREVENTED FROM ENTERING THE STORM SEWER SYSTEM.
2. ADDITIONAL CONSTRUCTION SITE DISCHARGE BEST MANAGEMENT PRACTICES MAY BE REQUIRED OF THE OWNER AND/OR CONTRACTOR TO ADDRESS ANY EROSION PROBLEMS OR IF THE SUBMITTED PLAN DOES NOT MEET THE PERFORMANCE STANDARDS SPECIFIED IN TITLE 24.40 AND THE LAS VEGAS VALLEY CONSTRUCTION SITE BEST MANAGEMENT PRACTICES.
3. TEMPORARY OR PERMANENT STABILIZATION PRACTICES WILL BE INSTALLED ON DISTURBED AREAS AS SOON AS POSSIBLE AND NOT LATER THAN 15 DAYS AFTER THE CONSTRUCTION ACTIVITY IN THAT PORTION OF THE SITE HAS TEMPORARILY OR PERMANENTLY CEASED. SOME EXCEPTIONS MAY APPLY; REFER TO NEVADA STORMWATER GENERAL PERMIT FOR CONSTRUCTION ACTIVITY NW000000, SECTION II.A.5.
4. AT A MINIMUM, THE CONTRACTOR OR HIS AGENT SHALL INSPECT ALL DISTURBED AREAS, AREAS USED FOR STORAGE OF MATERIALS, AND AREAS USED FOR EROSION CONTROL, PRECIPITATION, VEHICLE ENTRANCE AND EXIT LOCATIONS AND ALL BMPs WEEKLY, AND WITHIN 24 HOURS AFTER ANY ACTUAL RAIN EVENT OF .05 INCHES OR MORE. THE CONTRACTOR OR HIS AGENT SHALL REPORT ANY VIOLATION OF THE STORMWATER POLLUTION PREVENTION PLAN AS NECESSARY. SOME EXCEPTIONS TO WEEKLY INSPECTIONS MAY APPLY. REFER TO NEVADA STORMWATER GENERAL PERMIT FOR CONSTRUCTION ACTIVITY NW000000, SECTION II.A.12.
5. ACCUMULATED SEDIMENT IN BMPs SHALL BE REMOVED WHEN LAS VEGAS COUNTY HAS BEEN ADVISED OF THE EVENT OR PRIOR TO THE NEXT ANTICIPATED STORM EVENT, WHICHEVER IS EARLIER. SEDIMENT MUST BE REMOVED WHEN BMP DESIGN CAPACITY HAS BEEN REDUCED BY 50 PERCENT.

THE PROJECT SITE IS LOCATED WITHIN A FEMA DESIGNATED ZONE 'X' (AREA OUTSIDE THE 500 YEAR FLOODPLAIN), ON THE FLOOD INSURANCE RATE MAP (FIRM) PANEL: 32003C1750E, DATED SEPTEMBER 27, 2002.

1. THE CONTRACTOR SHALL VERIFY ALL CONDITIONS OF EXISTING STRUCTURES INCLUDING LOCATION, ELEVATION, DIMENSIONS AND REPORT ALL DISCREPANCIES TO THE ENGINEER PRIOR TO CONSTRUCTION.
2. ALL IMPROVEMENTS TO BE PROTECTED FROM EROSION DURING CONSTRUCTION THROUGHOUT THE USE OF A STORM WATER POLLUTION PREVENTION PLAN (SWPPP).
3. MAXIMUM/MINIMUM SLOPES AND MINIMUM STREET SECTIONS NOT TO EXCEED THAT SHOWN ON THE GEOTECH REPORT.
4. SEE SHEET C-2 FOR LEGEND AND DETAIL SHEET D-1 FOR STREET SECTIONS AND DETAILS.
5. ADD 2800 TO PLAN GRADES WITH THE EXCEPTION OF FINISHED FLOORS AND EXISTING IMPROVED CONDITIONS.
6. ALL PRIVATE STORM DRAINS ARE PUBLIC DRAINAGE EASEMENTS TO BE PRIVATELY MAINTAINED BY HOA.
7. CONTRACTOR TO VERIFY ALL HANDICAP ACCESSIBLE ROADS AND PARKING STALLS ARE IN CONFORMANCE WITH A.D.A. ACCESSIBILITY GUIDELINES AND DO NOT EXCEED MAXIMUM SLOPES IN ANY DIRECTION PRIOR TO CONSTRUCTION. CONTRACTOR TO NOTIFY ENGINEER OF ANY DISCREPANCIES.
8. CONSTRUCT A.D.A. RAMP, HAND RAILS, PARKING, SIGNAGE & RAMPS TO COMPLY WITH ICC/ANSI A117.1-2003.
9. ALL ON-SITE STORM DRAINS AND THE ASSOCIATED FACILITIES ARE PRIVATELY OWNED AND MAINTAINED.
10. ANY FUTURE DEVELOPMENT WILL REQUIRE A TECHNICAL DRAINAGE STUDY UPDATE.
11. CONCRETE SIDEWALKS SHALL NOT EXCEED 5% IN A LONGITUDINAL DIRECTION OR 2% IN A CROSS SLOPE DIRECTION. ANY CONCRETE SIDEWALK LANDING SHALL NOT EXCEED 2% IN ANY DIRECTION SHALL BE A MINIMUM OF 5 FEET BY 5 FEET.

USDA BRASS CAP ON AN IRON PIPE, 140' SOUTHWEST OF TELEPHONE POLE
#26994T, SOUTHWEST CORNER OF THE U.S. 95/KYLE CANYON TURNOFF.
ELEVATION = 2817.62 FEET, 858.813 METERS
N.A.V.D. 88
PER THE CLARK COUNTY VERTICAL CONTROL LAST REVISED 2003

THE BASIS OF BEARING IS SOUTH 00°22'12" WEST, BEING THE BEARING OF THE WEST LINE OF THE NORTHWEST QUARTER (NW1/4) OF SECTION 6, TOWNSHIP 19 SOUTH, RANGE 60 EAST, M.D.M., CITY OF LAS VEGAS, CLARK COUNTY, NEVADA, AS SHOWN BY MAP THEREOF IN FILE 151, PAGE 14 OF SURVEYS IN THE CLARK COUNTY RECORDER'S OFFICE, NEVADA.

1. EXISTING UTILITY LOCATIONS SHOWN HEREON ARE APPROXIMATE ONLY. IT SHALL BE THE CONTRACTOR'S RESPONSIBILITY TO DETERMINE THE EXACT VERTICAL AND HORIZONTAL LOCATION OF ALL EXISTING UNDERGROUND UTILITIES PRIOR TO COMMENCING CONSTRUCTION. NO REPRESENTATION IS MADE THAT ALL EXISTING UTILITIES ARE SHOWN HEREON. THE ENGINEER ASSUMES NO RESPONSIBILITY FOR UTILITIES NOT SHOWN IN THEIR PROPER LOCATION.

2. FOR ROADWAY WIDENING AND HALF STREET IMPROVEMENTS THE CONTRACTOR SHALL VERIFY CROSS SLOPES FROM EXISTING PAVEMENT SAWCUT LINE TO PROPOSED EDGE OF PAVEMENT OR PROJECTED LIP OF CURB PRIOR TO SUBGRADE PREPARATION AND CONSTRUCTION OF PROPOSED CURB LINE. IF MINIMUM OR MAXIMUM CROSS SLOPES DO NOT MEET AGENCY STANDARDS THE CONTRACTOR SHALL NOTIFY THE ENGINEER PRIOR TO THE PLACEMENT OF TYPE II AND CURB.

ALL STORM DRAIN INLETS ARE TO BE
CONSTRUCTED PER THE ADOPTED
USDCCA DRAWING NO. 421.

PROPERTY OWNER IS RESPONSIBLE TO MAINTAIN THE BEST MANAGEMENT PRACTICES SUCH AS BUT NOT LIMITED TO THE REMOVAL OF ACCUMULATED SEDIMENT AND DEBRIS AND CARE OF THE VEGETATION

EARTHWORK QUANTITIES (RAW):
 -CUT = 30,066 CUBIC YARDS.
 -FILL = 43,578 CUBIC YARDS

- THE ABOVE QUANTITIES DO NOT REFLECT LOSSES DUE TO SUBSIDENCE OR SHRINKAGE.
- THE ABOVE QUANTITIES DO REFLECT USING NATIVE MATERIAL IN LIEU OF TYPE I GRAVEL BASE MATERIAL FOR STREET SECTIONS.
- THE ABOVE QUANTITIES DO NOT REFLECT ANY EARTHWORK WHICH MAY BE REQUIRED BY THE ENGINEER TO CONSTRUCT ADDITIONAL PROTECTIVE DITCHES OR BERMS NOT SHOWN ON THESE DRAWINGS.
- ALL ONSITE GRADING SHALL COMPLY WITH THE CONDITIONS SET FORTH IN THE GEOTECHNICAL REPORT REFERENCED ON SHEET C-2.

1	48" TYPE I STORM DRAIN MANHOLE	EA	2
2	48" TYPE I STORM DRAIN MANHOLE	EA	4
3	12" NDS SQUARE DRAIN (OR APPROVED EQUAL) PER DETAILS ON SHEET D-3	EA	2
4	JENSON PRECAST DRAIN INLET PER DETAILS ON SHEET D-3	EA	2
5	12" PVC STORM DRAIN	EA	131
6	18" PVC STORM DRAIN	LF	504
7	24" PVC STORM DRAIN	LF	21
8	36" RCP CLASS IV STORM DRAIN	LF	381
9	RIPRAP 50#-8", THK=16"	SF	96505
10	SIDEWALK UNDER DRAIN PER CCAIN #236	EA	1
11	60" TYPE III STORM DRAIN MANHOLE	EA	1
12	6" WIDE ZURN SIDEWALK TRENCH DRAIN	EA	1
13	2-FT WIDE CONCRETE FLUME	LF	12



Call before you Dig
AVOID CUTTING UNDERGROUND
UTILITY LINES. IT'S COSTLY.
Call

OR
1-800-227-2600

**SLATER
HANIFAN
G-E GROUP**
CONSULTING ENGINEERS & PLANNERS
S. ARVILLE STREET #216, LAS VEGAS, NV 89118
FAX (702) 284-5399
PHONE (702) 284-5300

[illegible]

CITY OF LAS VEGAS

ETHOS THREE ARCHITECTURE

SKYE CANYON SOMERSET ACADEMY

GRADING PLAN III


S12 T19S R59E	
DATE:	11/01/17

DRAFTER: DNP







DESIGNER: BCC

CHECKED: STS

PROJECT NO.
ETA1601-000

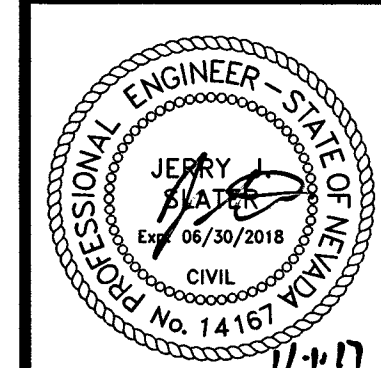

G-3
SHEET 7 OF 15
HANSEN NO. 68370
DWG NO. 715-196

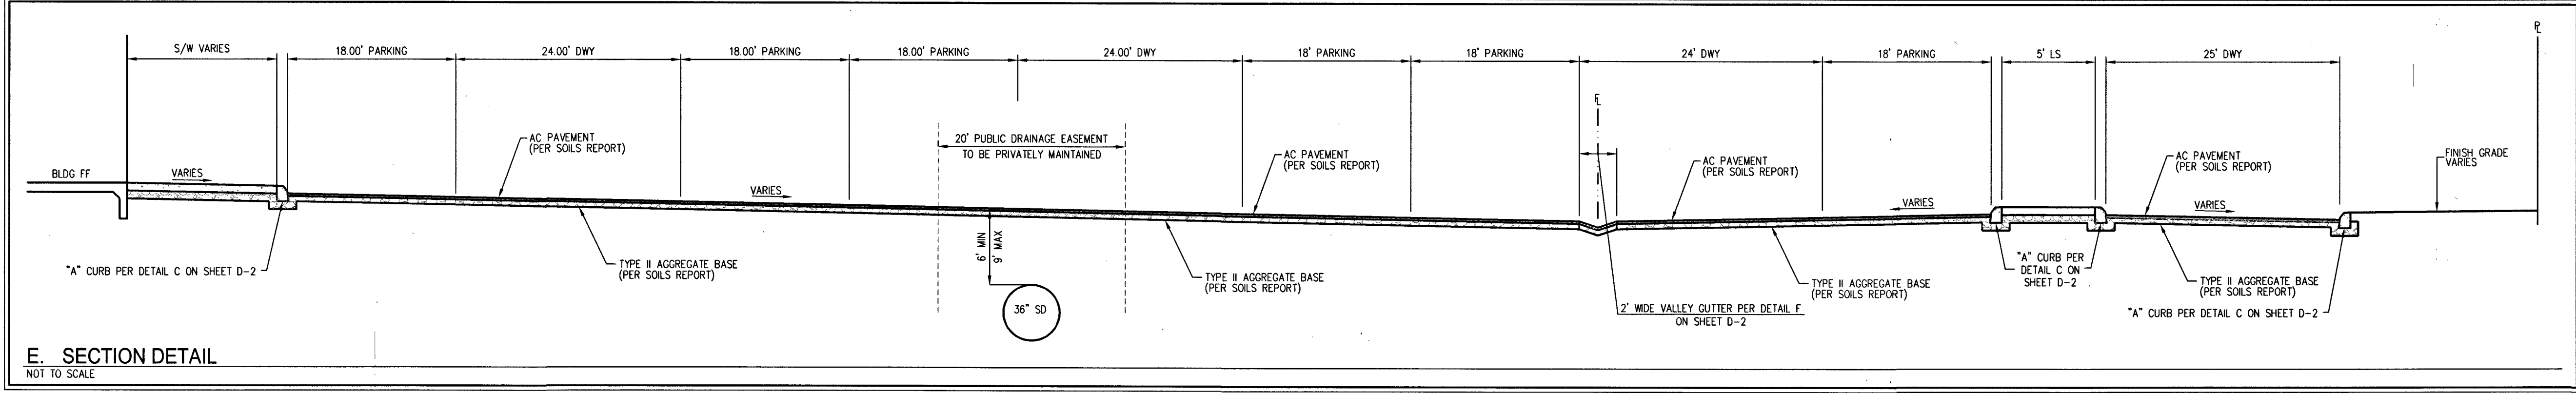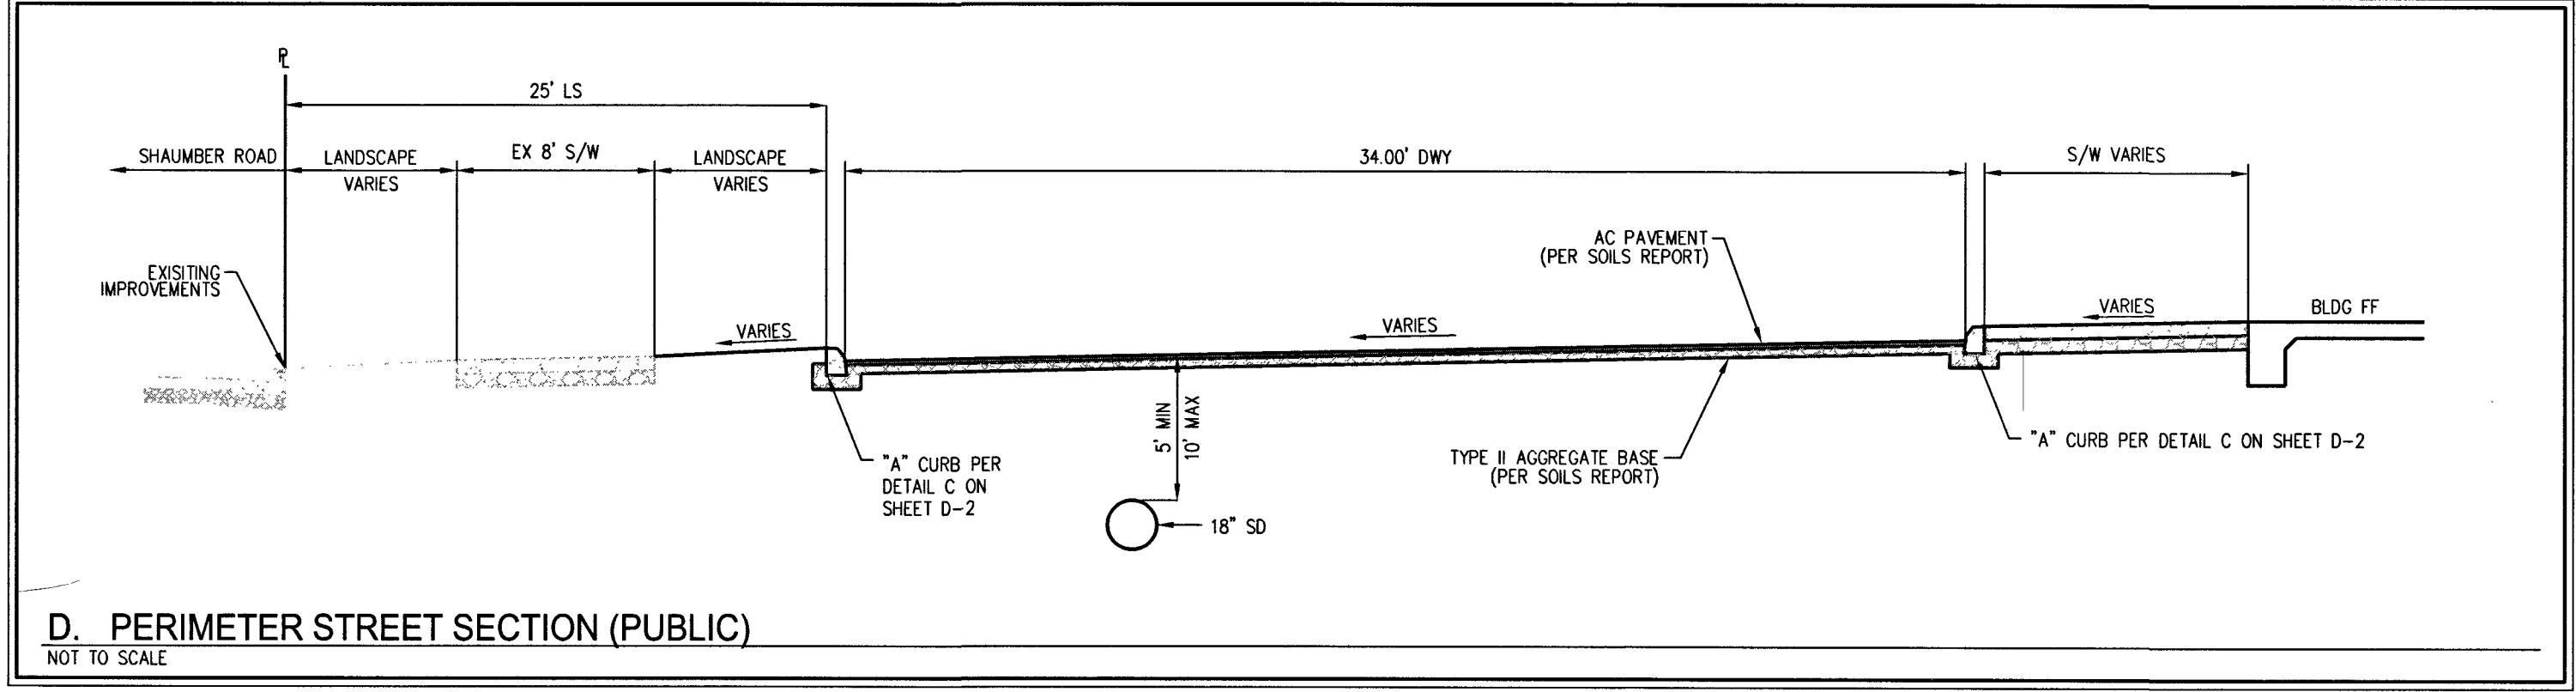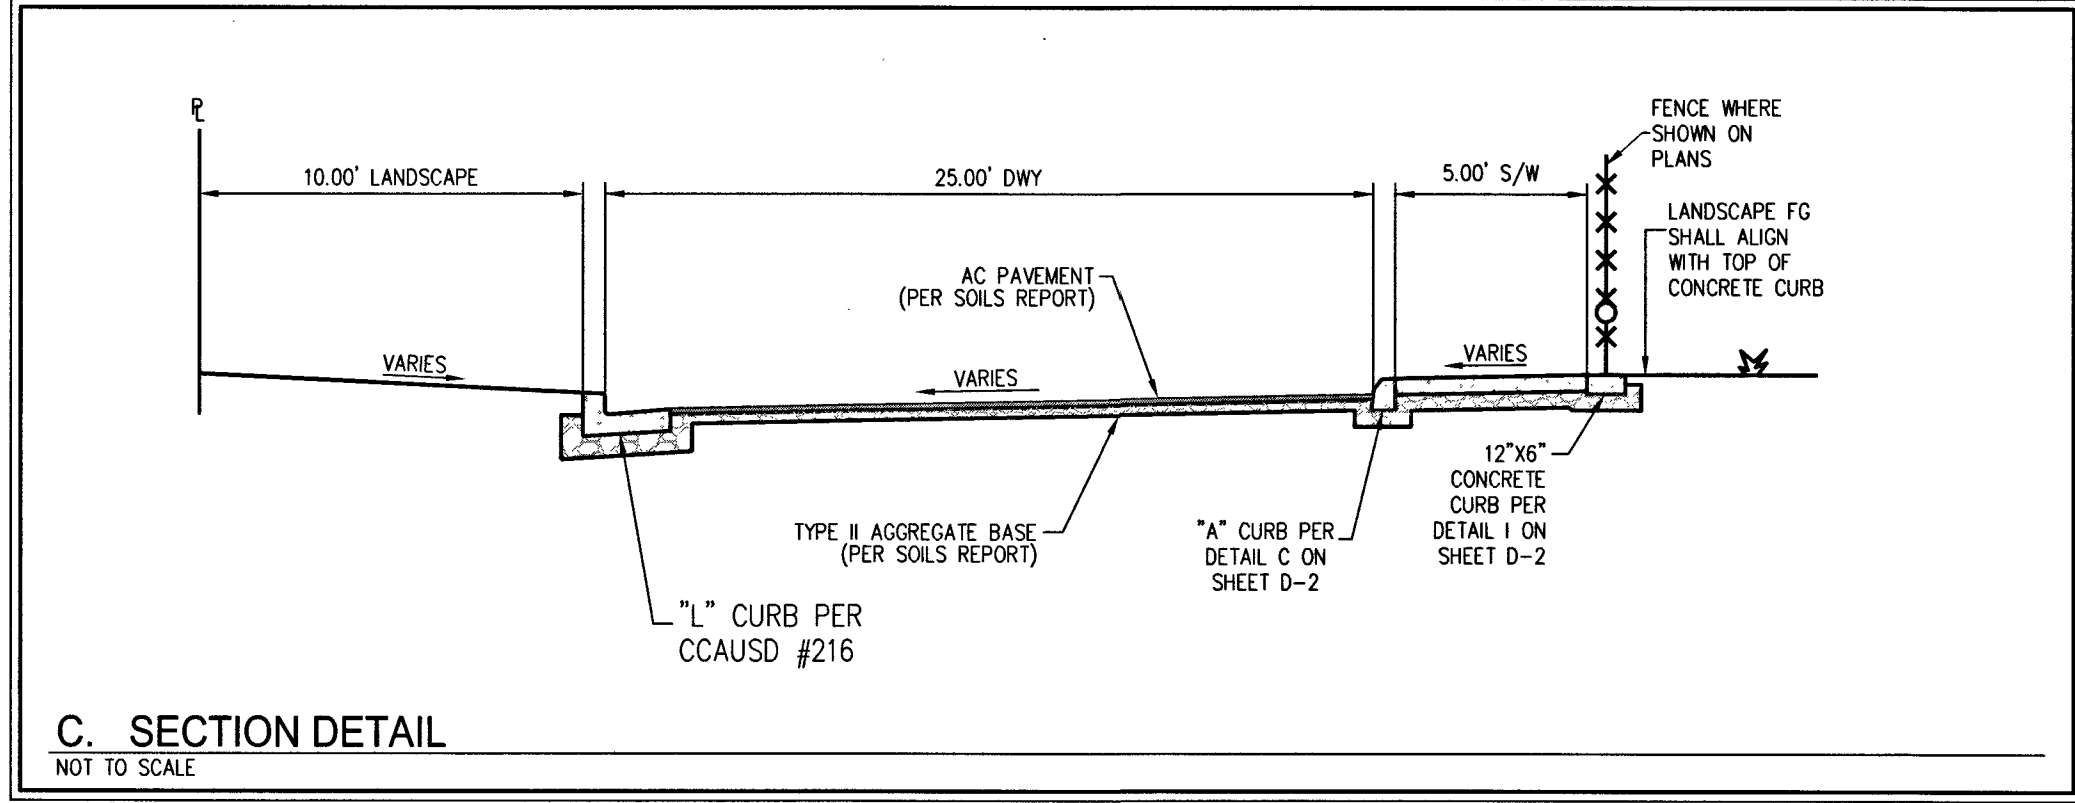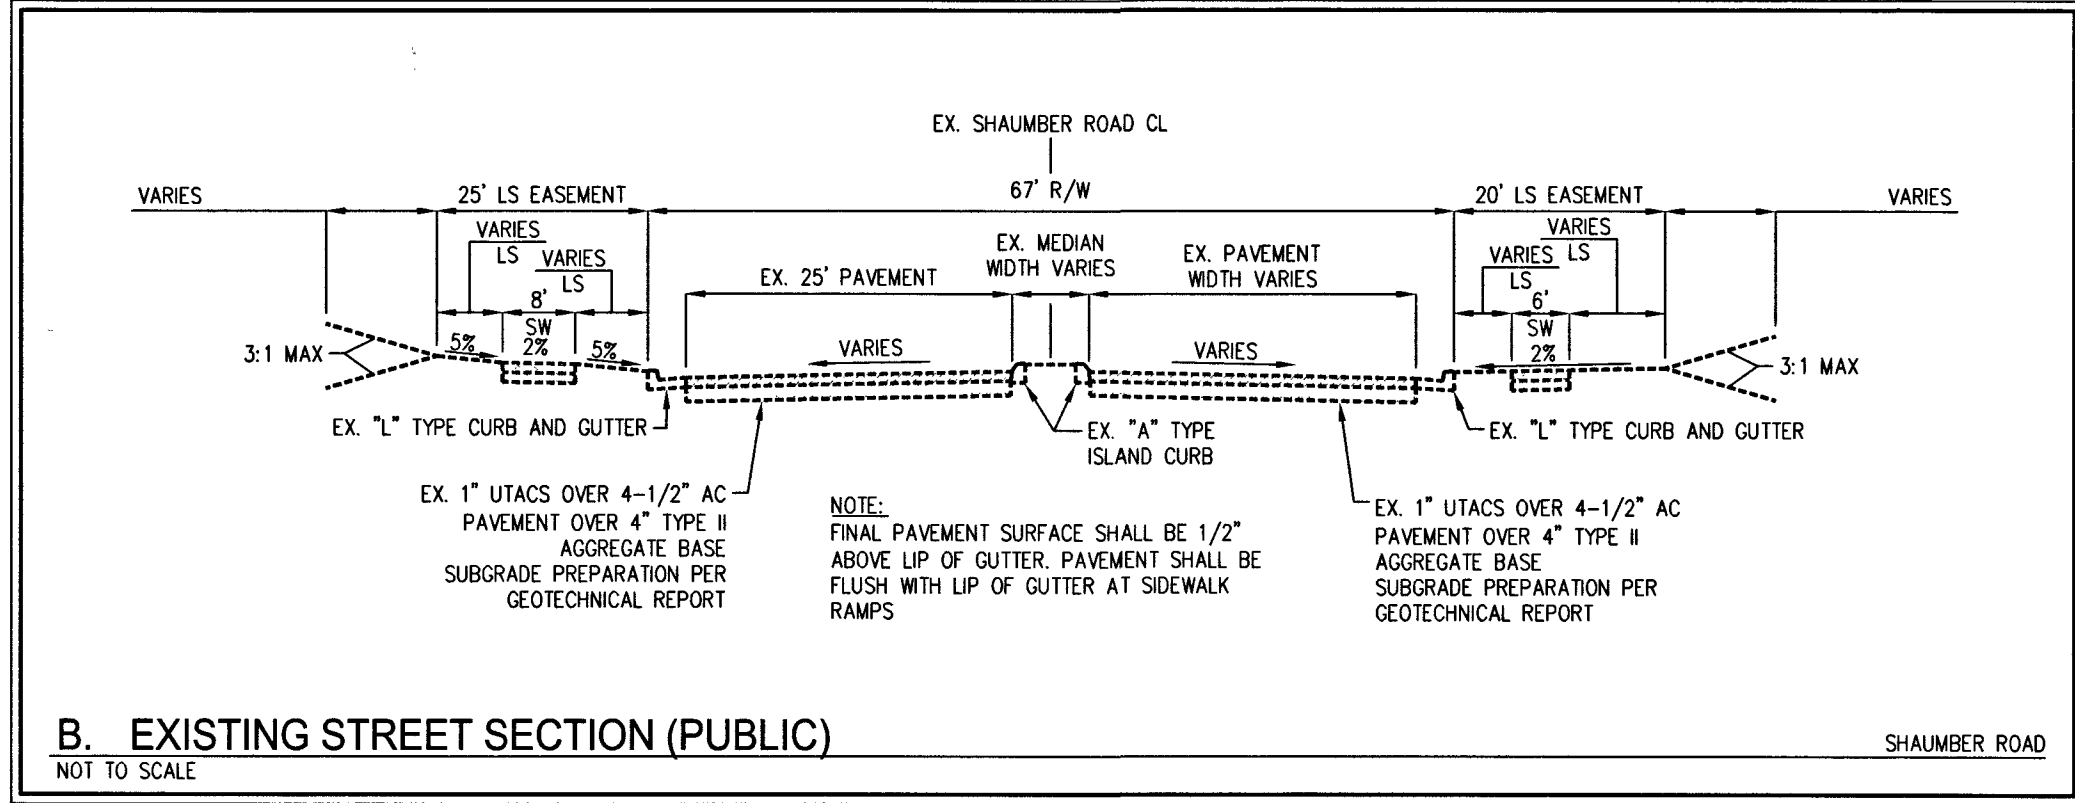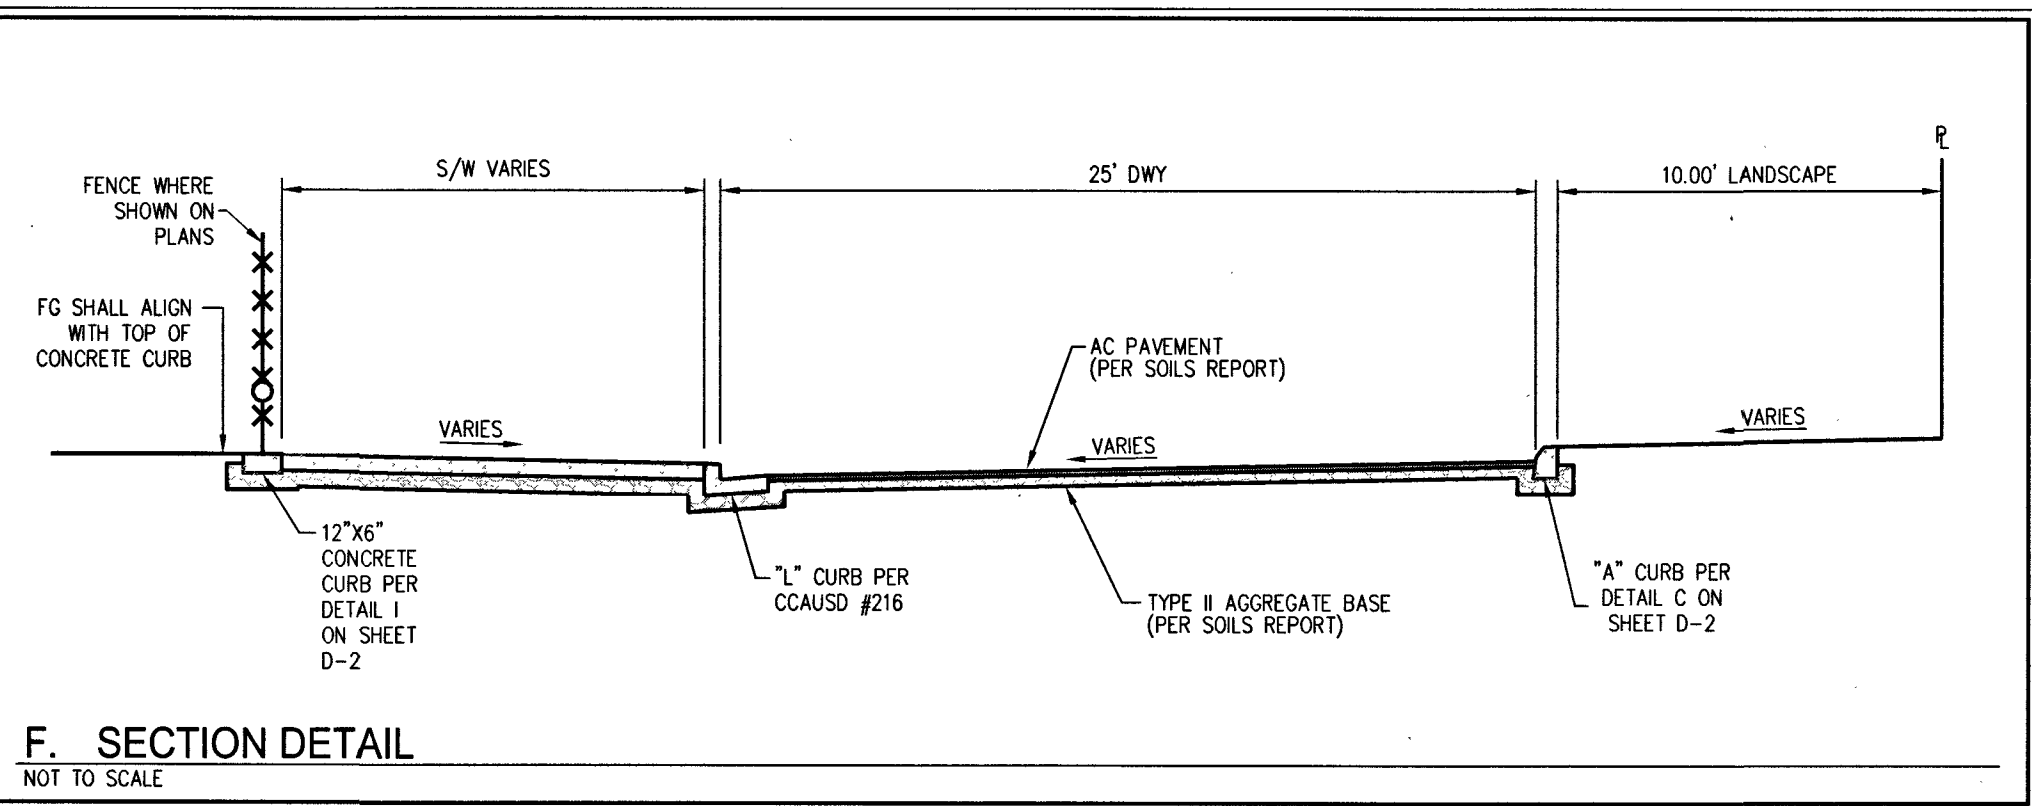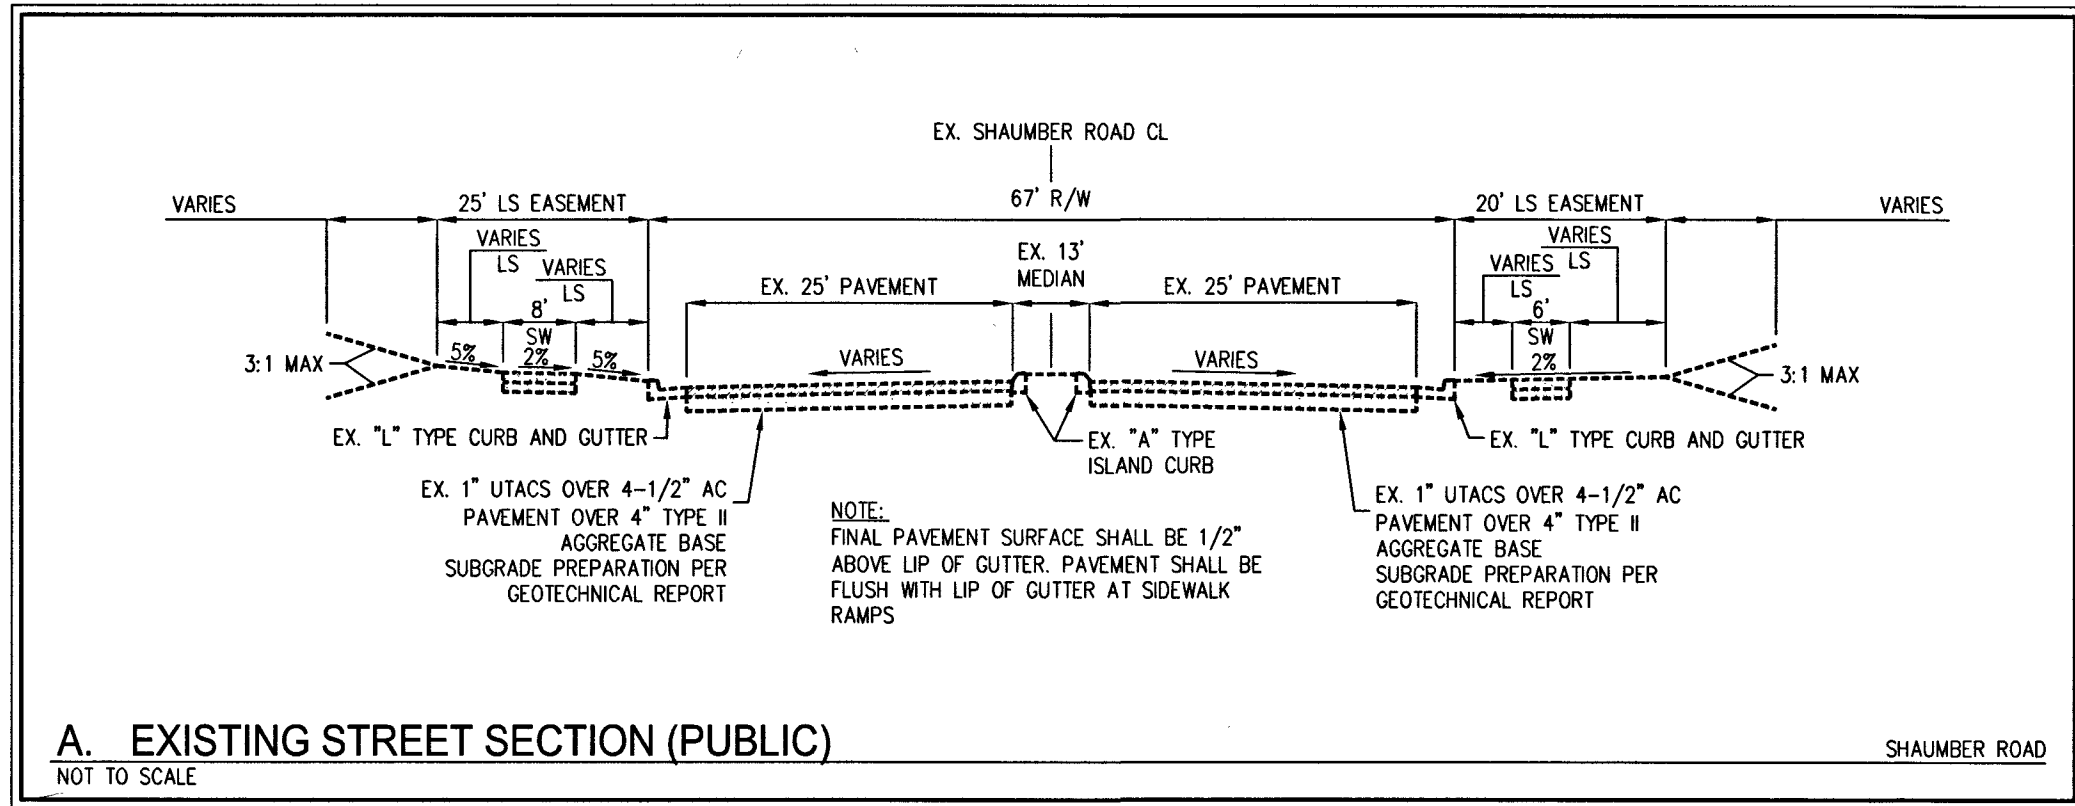

AVOID OVERHEAD POWER
LINE CONTACT. IT'S COSTLY.
**CALL
BEFORE YOU
OVERHEAD**
1-702-227-2929

Call before you Dig
Avoid cutting underground
utility lines. It's costly.
Call
811
OR
1-800-227-2600
AND
CLARK COUNTY TRAFFIC OPERATIONS
1-702-455-6000


AVOID HITTING UNDERGROUND
TRAFFIC SIGNAL SYSTEMS
AND STREET LIGHT SYSTEM
CONDUITS. IT'S COSTLY.
Call
UnderGround
1-702-455-6000
CLARK COUNTY TRAFFIC OPERATIONS
AND
1-702-432-5300
FREEWAY & ARTERIAL SYSTEM
OF TRANSPORTATION (F.A.S.T.)

**SLATER
HANIFAN
GROUP**
CONSULTING ENGINEERS & PLANNERS
5740 S. ARVILLE STREET #216, LAS VEGAS, NV 89118
PHONE (702) 284-5300 FAX (702) 284-5399


CITY OF LAS VEGAS
ETHOS THREE ARCHITECTURE
SKYE CANYON SOMERSET ACADEMY
DETAIL SHEET

DATE: 11/1/17
DRAFTER: DNP
DESIGNER: BCC
CHECKED: STS
PROJECT NO.
ETA1601-000


D-1
SHEET 8 OF 15
HANSEN NO. 68370
DWG NO. **715-196**

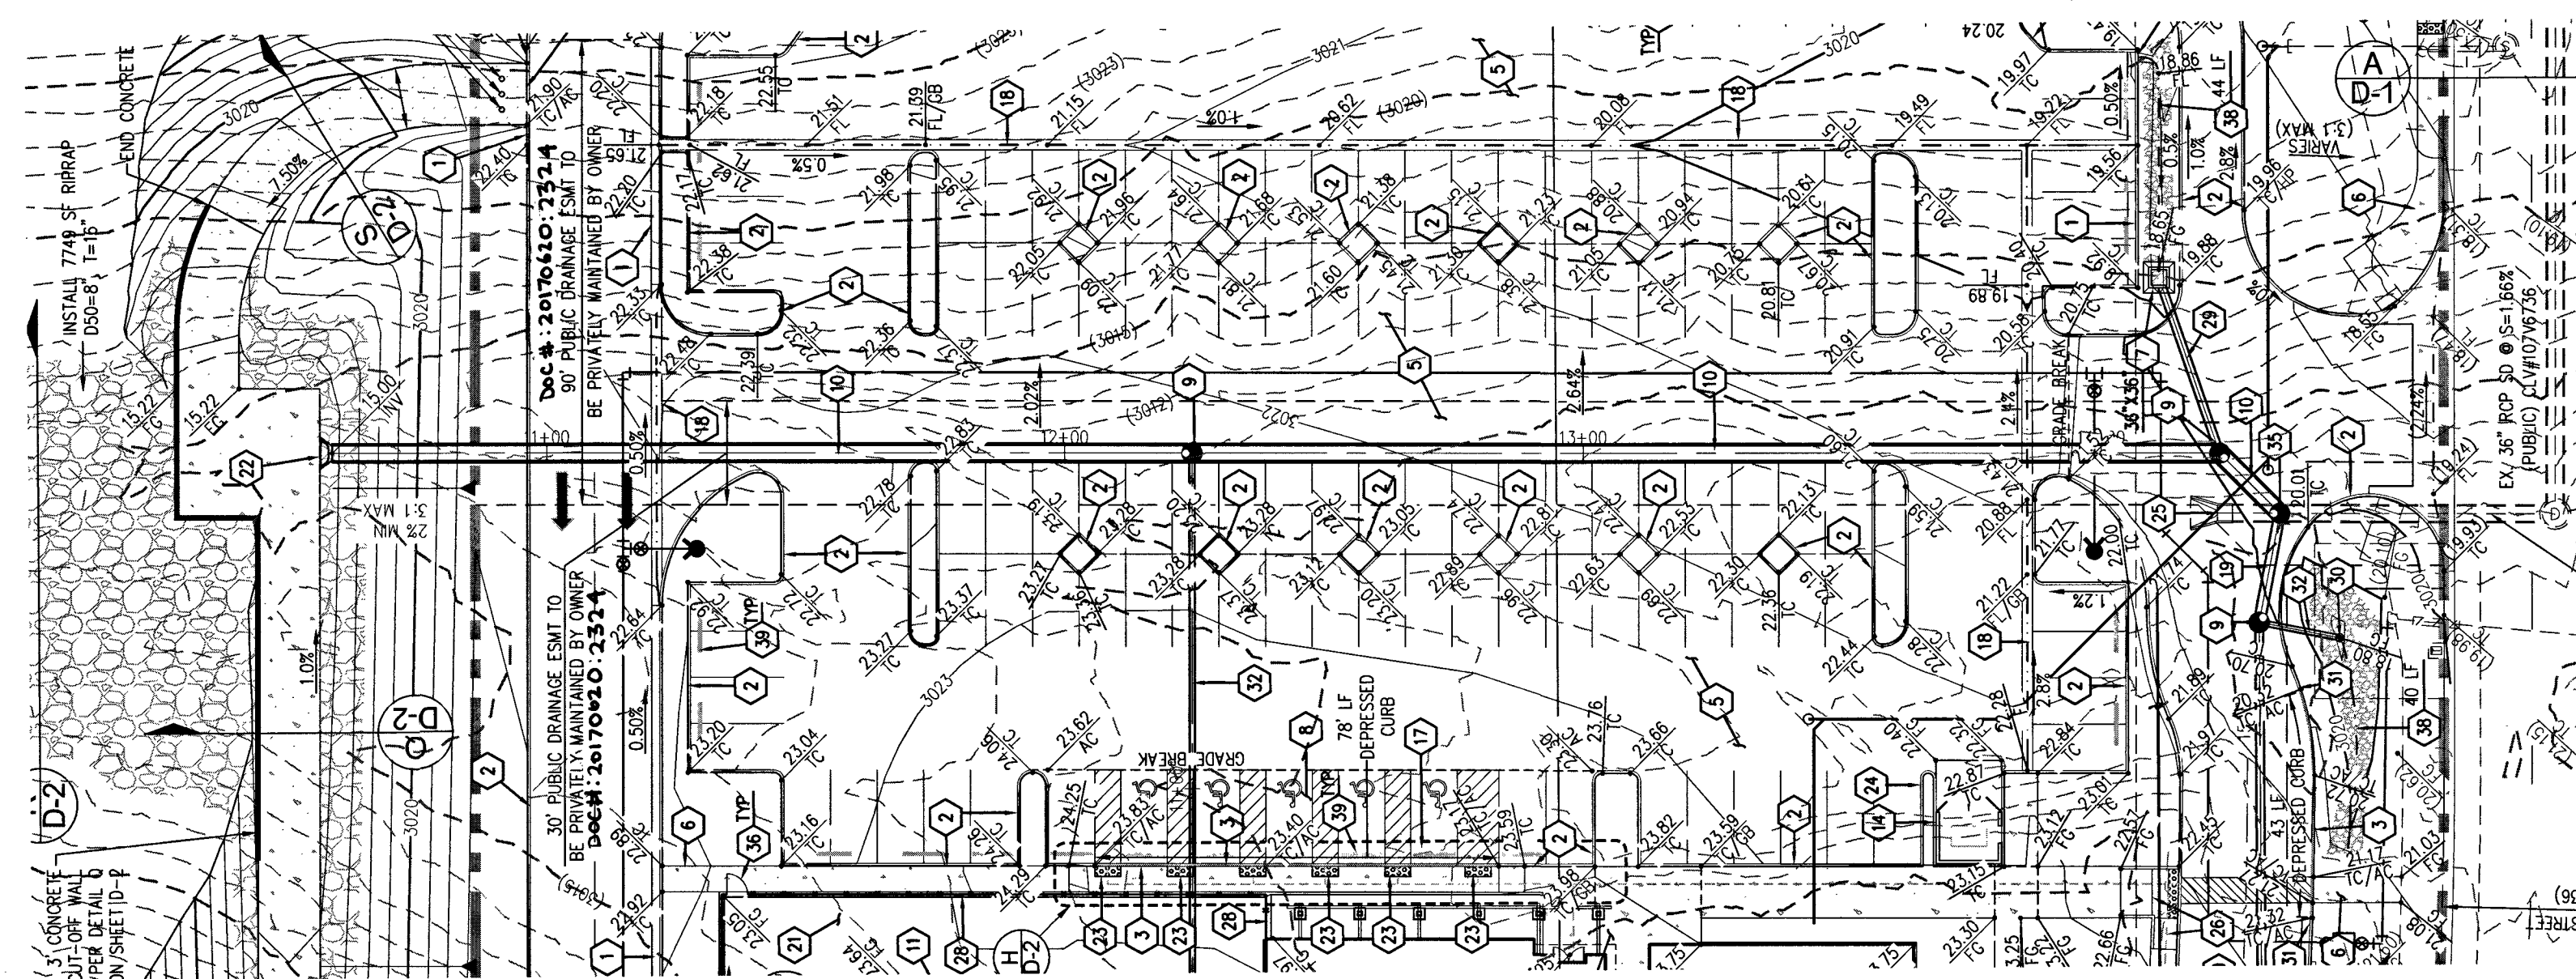

STORM DRAIN #1 - PLAN VIEW
(PRIVATE)

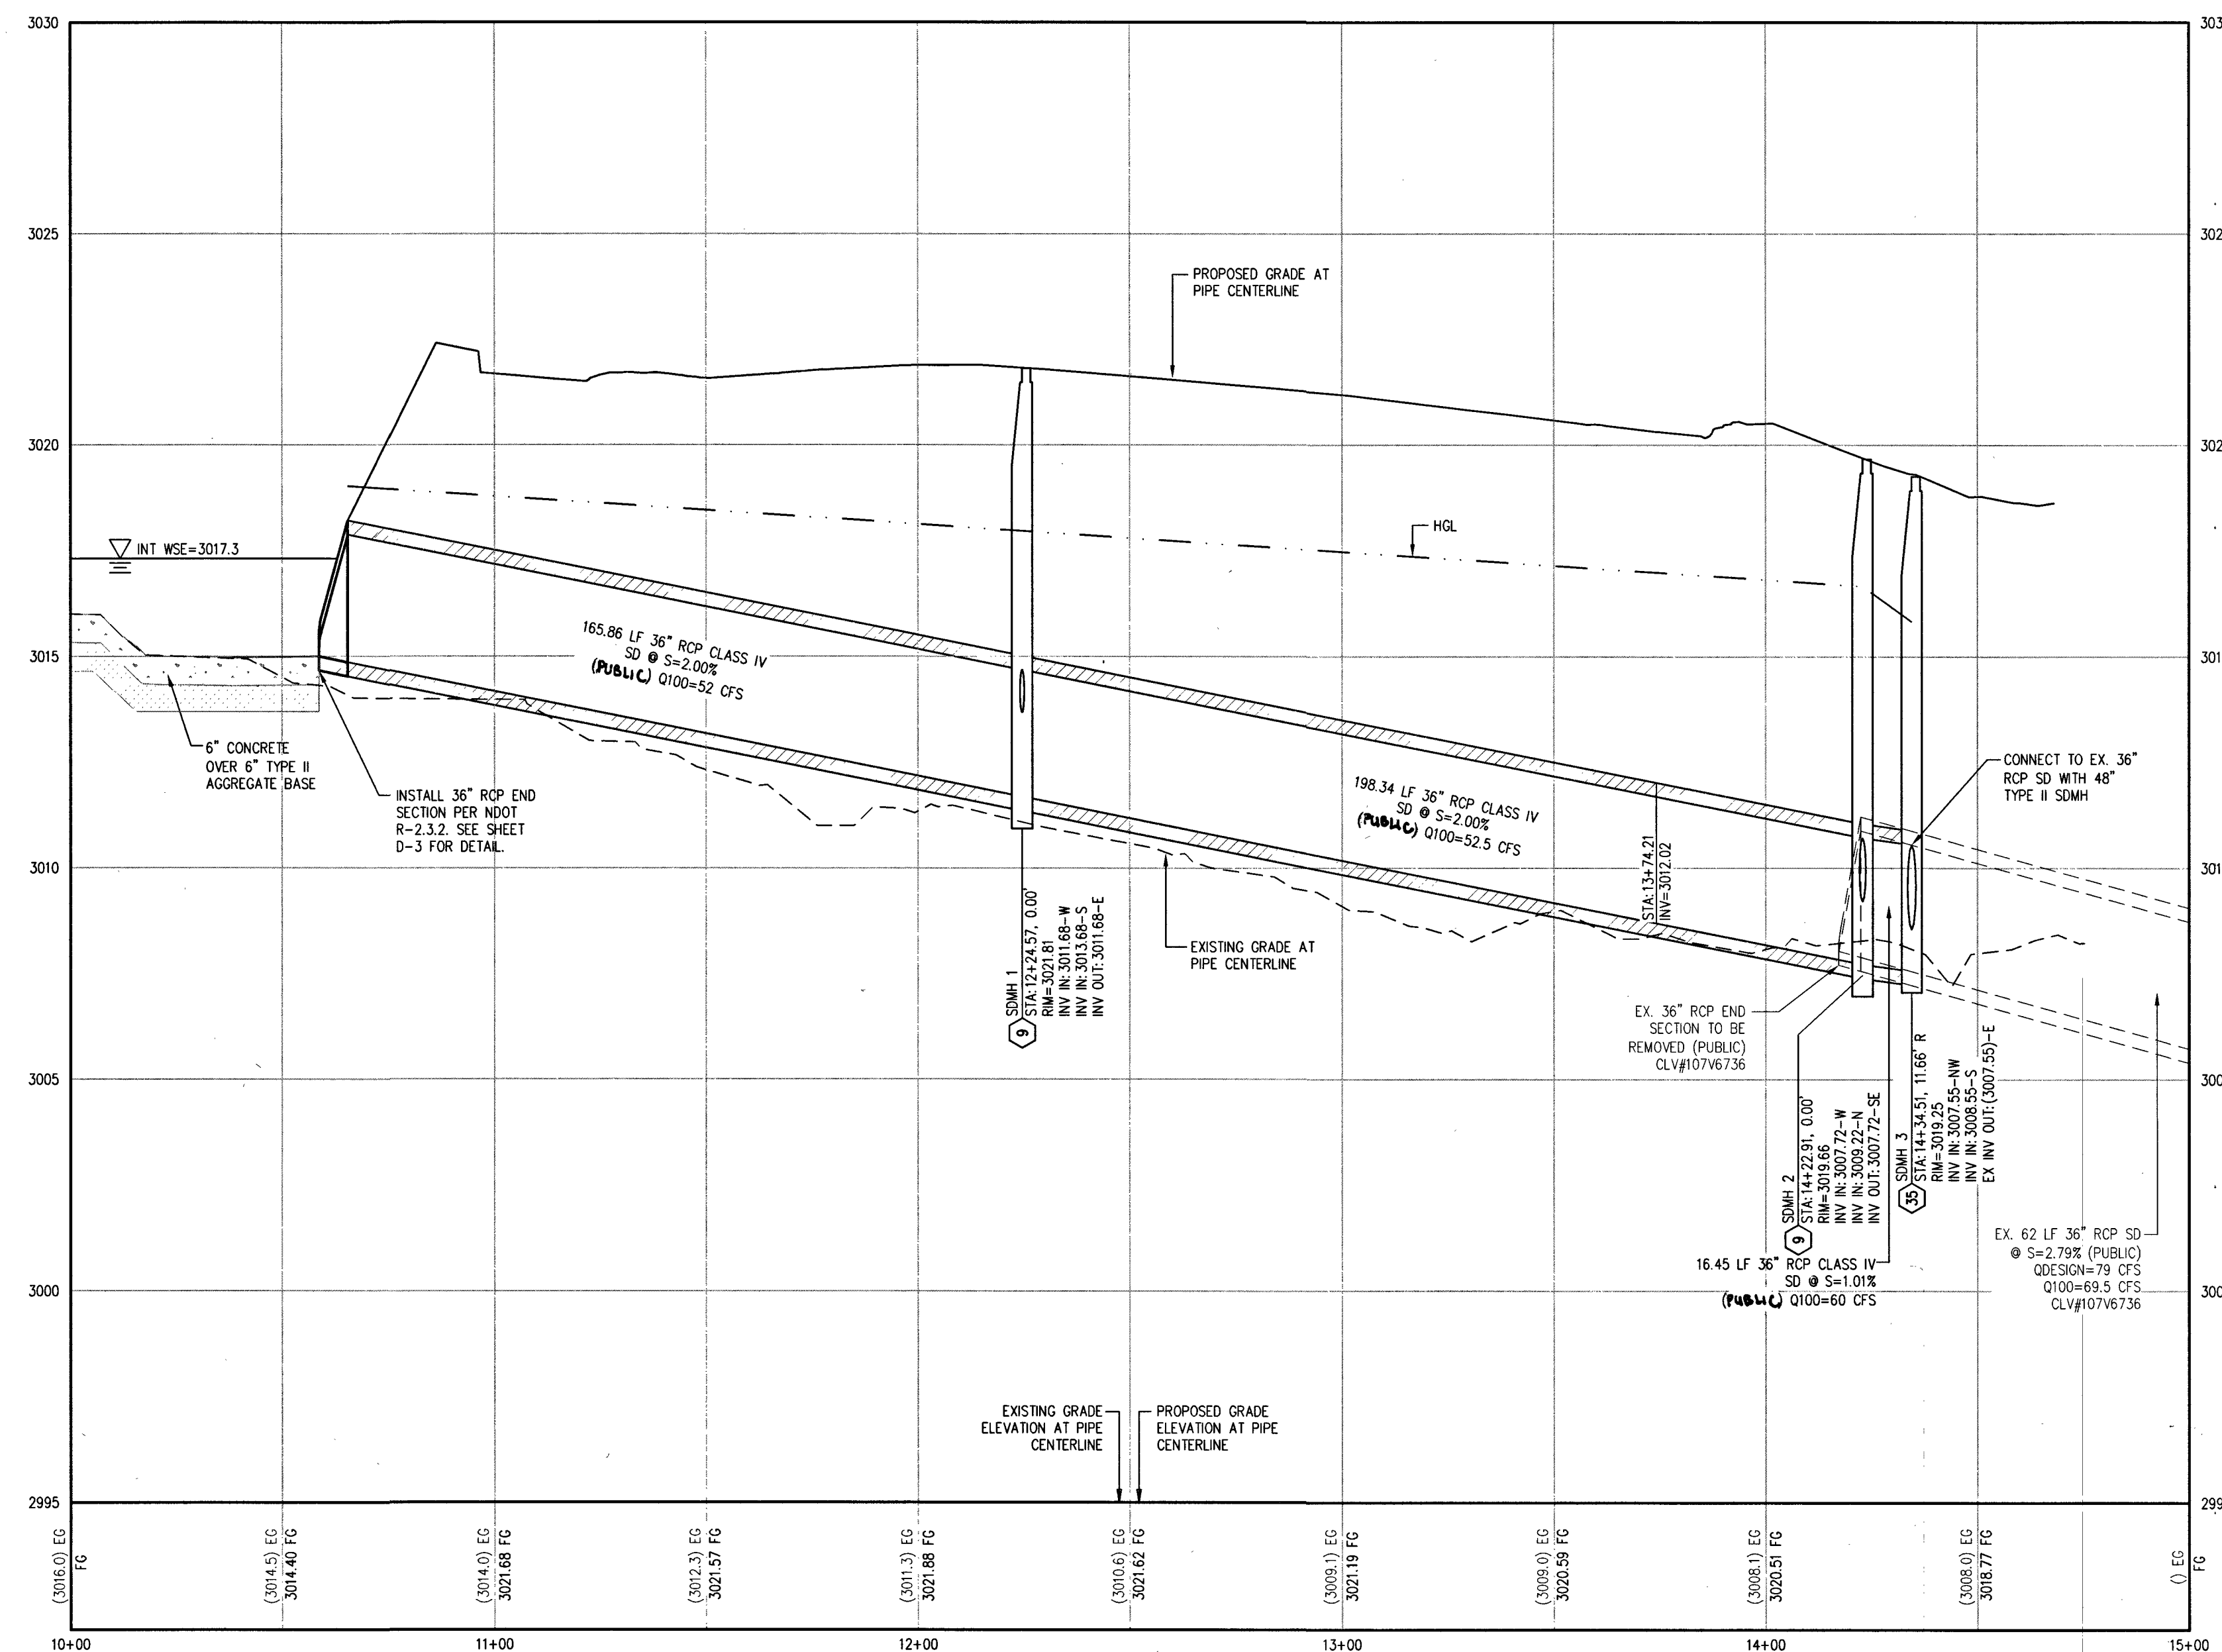

STORM DRAIN #1 - PROFILE VIEW
HORIZ: 1" = 30'
VERT: 1" = 5'

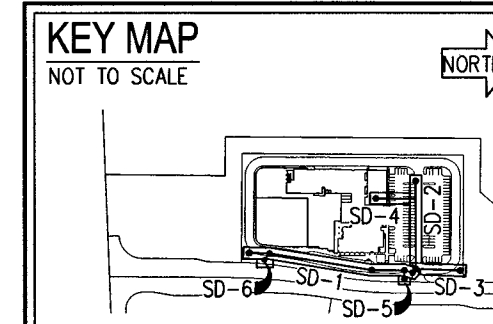

GRADING NOTES

1. "L" TYPE CURB PER CCAUSD DWG NO. 216.
2. "A" CURB PER DETAIL C ON SHEET D-2.
3. "DEPRESSED" CURB PER DETAIL D ON SHEET D-2.
4. CURB OPENING PER DETAIL E ON SHEET D-2.
5. AC PARKING AREA. SEE SOILS REPORT FOR SECTION.
6. 4" THICK CONCRETE SIDEWALK OVER 5" MIN TYPE II AGG. BASE. SEE LANDSCAPE PLAN FOR WIDTH AND FINISH.
7. INSTALL JENSEN PRECAST DRAIN INLET PER DETAILS ON SHEET DT-3 (GRATE SIZE PER PLAN) WITH APRON.
8. HANDICAPPED VAN ACCESSIBLE PARKING STALL IN ACCORDANCE WITH LMC 19.08.10(2) WITH SIGNAGE PER LMC 11.52.735.
9. 48" TYPE II STORM DRAIN MANHOLE PER CCAUSD NO. 401 & 405.
10. 36" RCP CLASS III SD, LENGTH PER PLAN.
11. CHILD PLAY AREA. SEE LANDSCAPE PLANS FOR CONSTRUCTION MATERIALS AND HORIZONTAL DIMENSIONS.
12. TURF FIELD. SEE LANDSCAPE PLANS FOR HORIZONTAL DIMENSIONS AND STRIPING DETAILS.
13. BASKETBALL COURT. SEE LANDSCAPE PLANS FOR HORIZONTAL DIMENSIONS AND STRIPING DETAILS.
14. TRASH ENCLOSURE. SEE ARCHITECTURAL PLANS FOR CONSTRUCTION MATERIALS AND DETAILS.
15. SIDEWALK RAMP WITH ARMOR TILE TRUNCATED DOMES OR EQUIVALENT PER CCAUSD NO. 235, CASE II & 235.1.
16. 6" WIDE ZURN TRENCH DRAIN (OR APPROVED EQUAL) PER DETAIL G ON SHEET D-2.
17. INSTALL PRECAST BUMPER BLOCKS PER CCAUSD NO. 238 OR EQUIVALENT (TYPICAL WHERE SHOWN ON PLANS).
18. 2'-FT WIDE VALLEY GUTTER PER DETAIL F ON SHEET D-2.
19. INSTALL 24" PVC STORM DRAIN.
20. 48" TYPE I STORM DRAIN MANHOLE PER CCAUSD NO. 401.
21. AC PAVEMENT. SEE SOILS REPORT FOR SECTION.
22. RCP END SECTION PER NDOT R-2.3.1. SEE SHEET D-3 FOR DETAIL.
23. ARMOR TILE TRUNCATED DOMES OR EQUIVALENT PER CCAUSD NO. 235, CASE II & 235.1.
24. CONCRETE PAD PER DETAIL K ON SHEET D-2.
25. REMOVE END SECTION AND 9 LF EX. 36" RCP SD.
26. CONSTRUCT SIDEWALK RAMPS WITH ARMOR TILE TRUNCATED DOMES PER DETAIL A ON SHEET D-2.
27. 6" WIDE CONCRETE CURB PER DETAIL L ON SHEET D-2.
28. 12" WIDE CONCRETE CURB PER DETAIL I ON SHEET D-2.
29. INSTALL 18" PVC STORM DRAIN.
30. 12" NOS SQUARE DRAIN (OR APPROVED EQUAL) PER DETAILS ON SHEET D-3.
31. TRANSITION CURB PER DETAIL N ON D-2.
32. INSTALL 12" PVC STORM DRAIN.
33. INSTALL SIDEWALK DRAIN PER CCAUSD #236.
34. CURB OPENING PER DETAIL M ON SHEET D-2.
35. 60" TYPE III STORM DRAIN MANHOLE PER CCAUSD NO. 401 & 405.
36. INSTALL PEDESTRIAN GATE PER ARCHITECT PLANS BY OTHERS.
37. INSTALL 2' WIDE CONCRETE FLUME PER DETAIL O ON SHEET D-2.
38. INSTALL TREATMENT SWALE: MIN 9" DEEP, 4:1 SIDE SLOPE, 150=1 (LANDSCAPE ROCK), AND LESS THAN OR EQUAL TO 18 SLOPE.
39. INSTALL WHEEL STOP PER CCAUSD NO. 238.
40. CURB OPENING PER DETAIL T ON SHEET D-2.
41. DIRECTIONAL SIDEWALK RAMP PER DETAIL U ON SHEET D-2.

STORM WATER RUNOFF

MANAGEMENT

(REQUIRED FOR ALL SITES GREATER THAN 1 ACRE (43,560 SQ.FT.))

1. THE OWNER, SITE DEVELOPER, CONTRACTOR AND/OR THEIR AUTHORIZED AGENTS SHALL EACH DAY REMOVE ALL SEDIMENT, MUD, CONSTRUCTION DEBRIS, OR OTHER POTENTIAL POLLUTANTS THAT MAY HAVE BEEN DISCHARGED TO, OR ACCUMULATE IN, THE PUBLIC RIGHTS OF WAYS OF CLARK COUNTY AS A RESULT OF CONSTRUCTION ACTIVITIES ASSOCIATED WITH THIS SITE DEVELOPMENT OR CONSTRUCTION PROJECT. SUCH MATERIALS SHALL BE PREVENTED FROM ENTERING THE STORM SEWER SYSTEM.

2. ADDITIONAL CONSTRUCTION SITE DISCHARGE BEST MANAGEMENT PRACTICES MAY BE REQUIRED OF THE OWNER AND HIS OR HER AGENTS DUE TO UNFORESEEN EROSION PROBLEMS OR IF THE SUBMITTED PLAN DOES NOT MEET THE PERFORMANCE STANDARDS SPECIFIED IN TITLE 24.40 AND THE LAS VEGAS VALLEY CONSTRUCTION SITE BEST MANAGEMENT PRACTICES MANUAL.



3. TEMPORARY OR PERMANENT STABILIZATION PRACTICES WILL BE INSTALLED ON DISTURBED AREAS AS SOON AS PRACTICABLE AND NO LATER THAN 14 DAYS AFTER THE CONSTRUCTION ACTIVITY IN THAT PORTION OF THE SITE HAS TEMPORARILY OR PERMANENTLY CEASED. SOME EXCEPTIONS MAY APPLY. REFER TO NEVADA STORMWATER GENERAL PERMIT FOR CONSTRUCTION ACTIVITY NV100000, SECTION III.A.5.

4. AT A MINIMUM, THE CONTRACTOR OR HIS AGENT SHALL INSPECT ALL DISTURBED AREAS, AREAS USED FOR STORAGE OF MATERIALS AND EQUIPMENT THAT ARE EXPOSED TO PRECIPITATION, VEHICLE ENTRANCE AND EXIT LOCATIONS AND ALL BMPs WEEKLY, AND WITHIN 24 HOURS AFTER ANY ACTUAL RAIN EVENT OF 0.5 INCHES OR MORE. THE CONTRACTOR OR HIS AGENT SHALL UPDATE OR MODIFY THE STORMWATER POLLUTION PREVENTION PLAN AS NECESSARY. SOME EXCEPTIONS MAY APPLY. REFER TO NEVADA STORMWATER GENERAL PERMIT FOR CONSTRUCTION ACTIVITY NV100000, SECTION III.A.12.

5. ACCUMULATED SEDIMENT IN BMPs SHALL BE REMOVED WITHIN SEVEN DAYS AFTER A STORMWATER RUNOFF EVENT OR PRIOR TO THE NEXT ANTICIPATED STORM EVENT, WHICHEVER IS EARLIER. SEDIMENT MUST BE REMOVED WHEN BMP DESIGN CAPACITY HAS BEEN REDUCED BY 50 PERCENT OR MORE.

FEMA FLOOD ZONE DESIGNATION


THE PROJECT SITE IS LOCATED WITHIN A FEMA DESIGNATED ZONE "X" (AREA OUTSIDE THE 500 YEAR FLOODPLAIN), ON THE FLOOD INSURANCE RATE MAP (FIRM) PANEL:32003C1750C, DATED: SEPTEMBER 27, 2002.

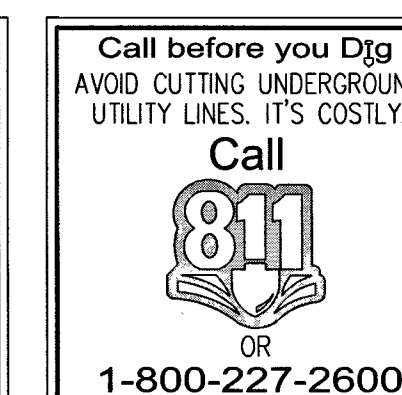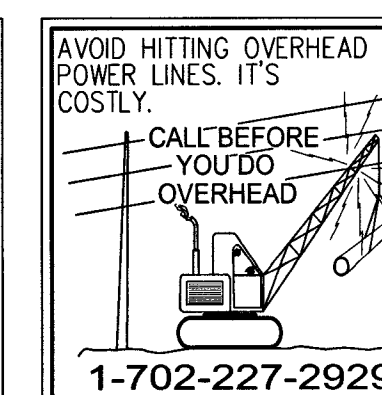


SLATER HANIFAN GROUP
CONSULTING ENGINEERS & PLANNERS
5740 S. ARVILLE STREET #216, LAS VEGAS, NV 89118
PHONE (702) 284-5399 FAX (702) 284-5399

ETHOS THREE ARCHITECTURE
SKYE CANYON SOMERSET ACADEMY
PLAN AND PROFILE


P-1
SHEET 11 OF 15
HANSER NO. 68370
DWG NO. 715-176

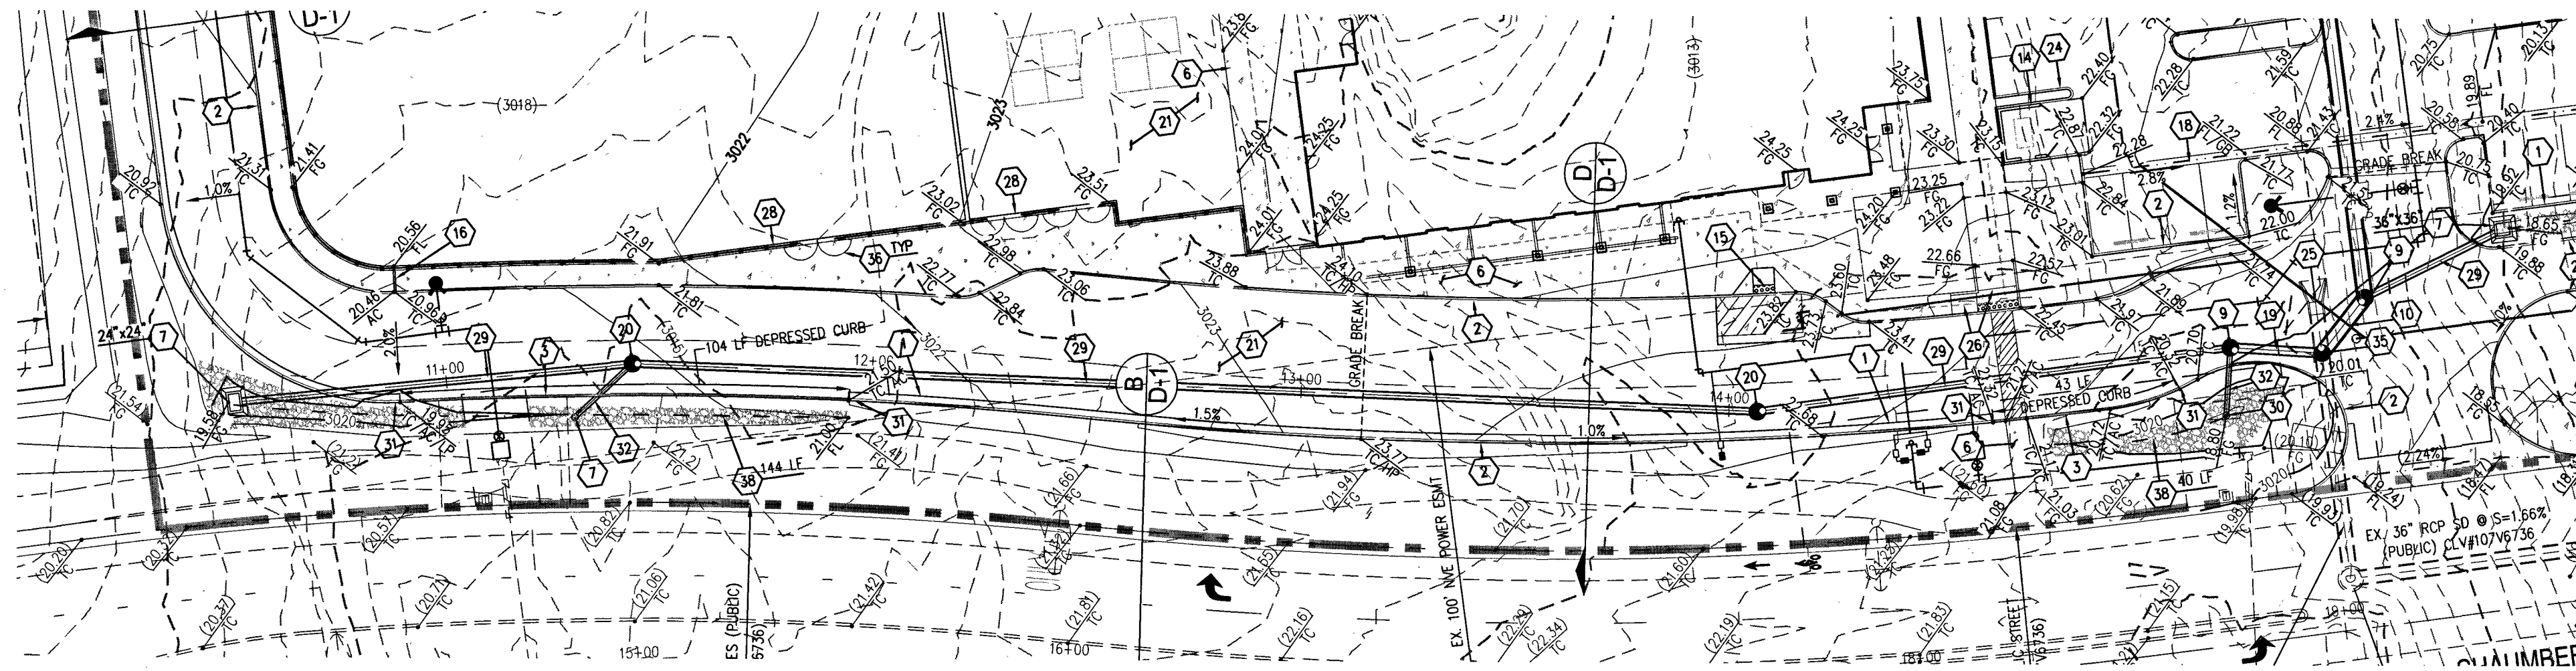

STORM DRAIN #2 - PLAN VIEW
(PRIVATE)

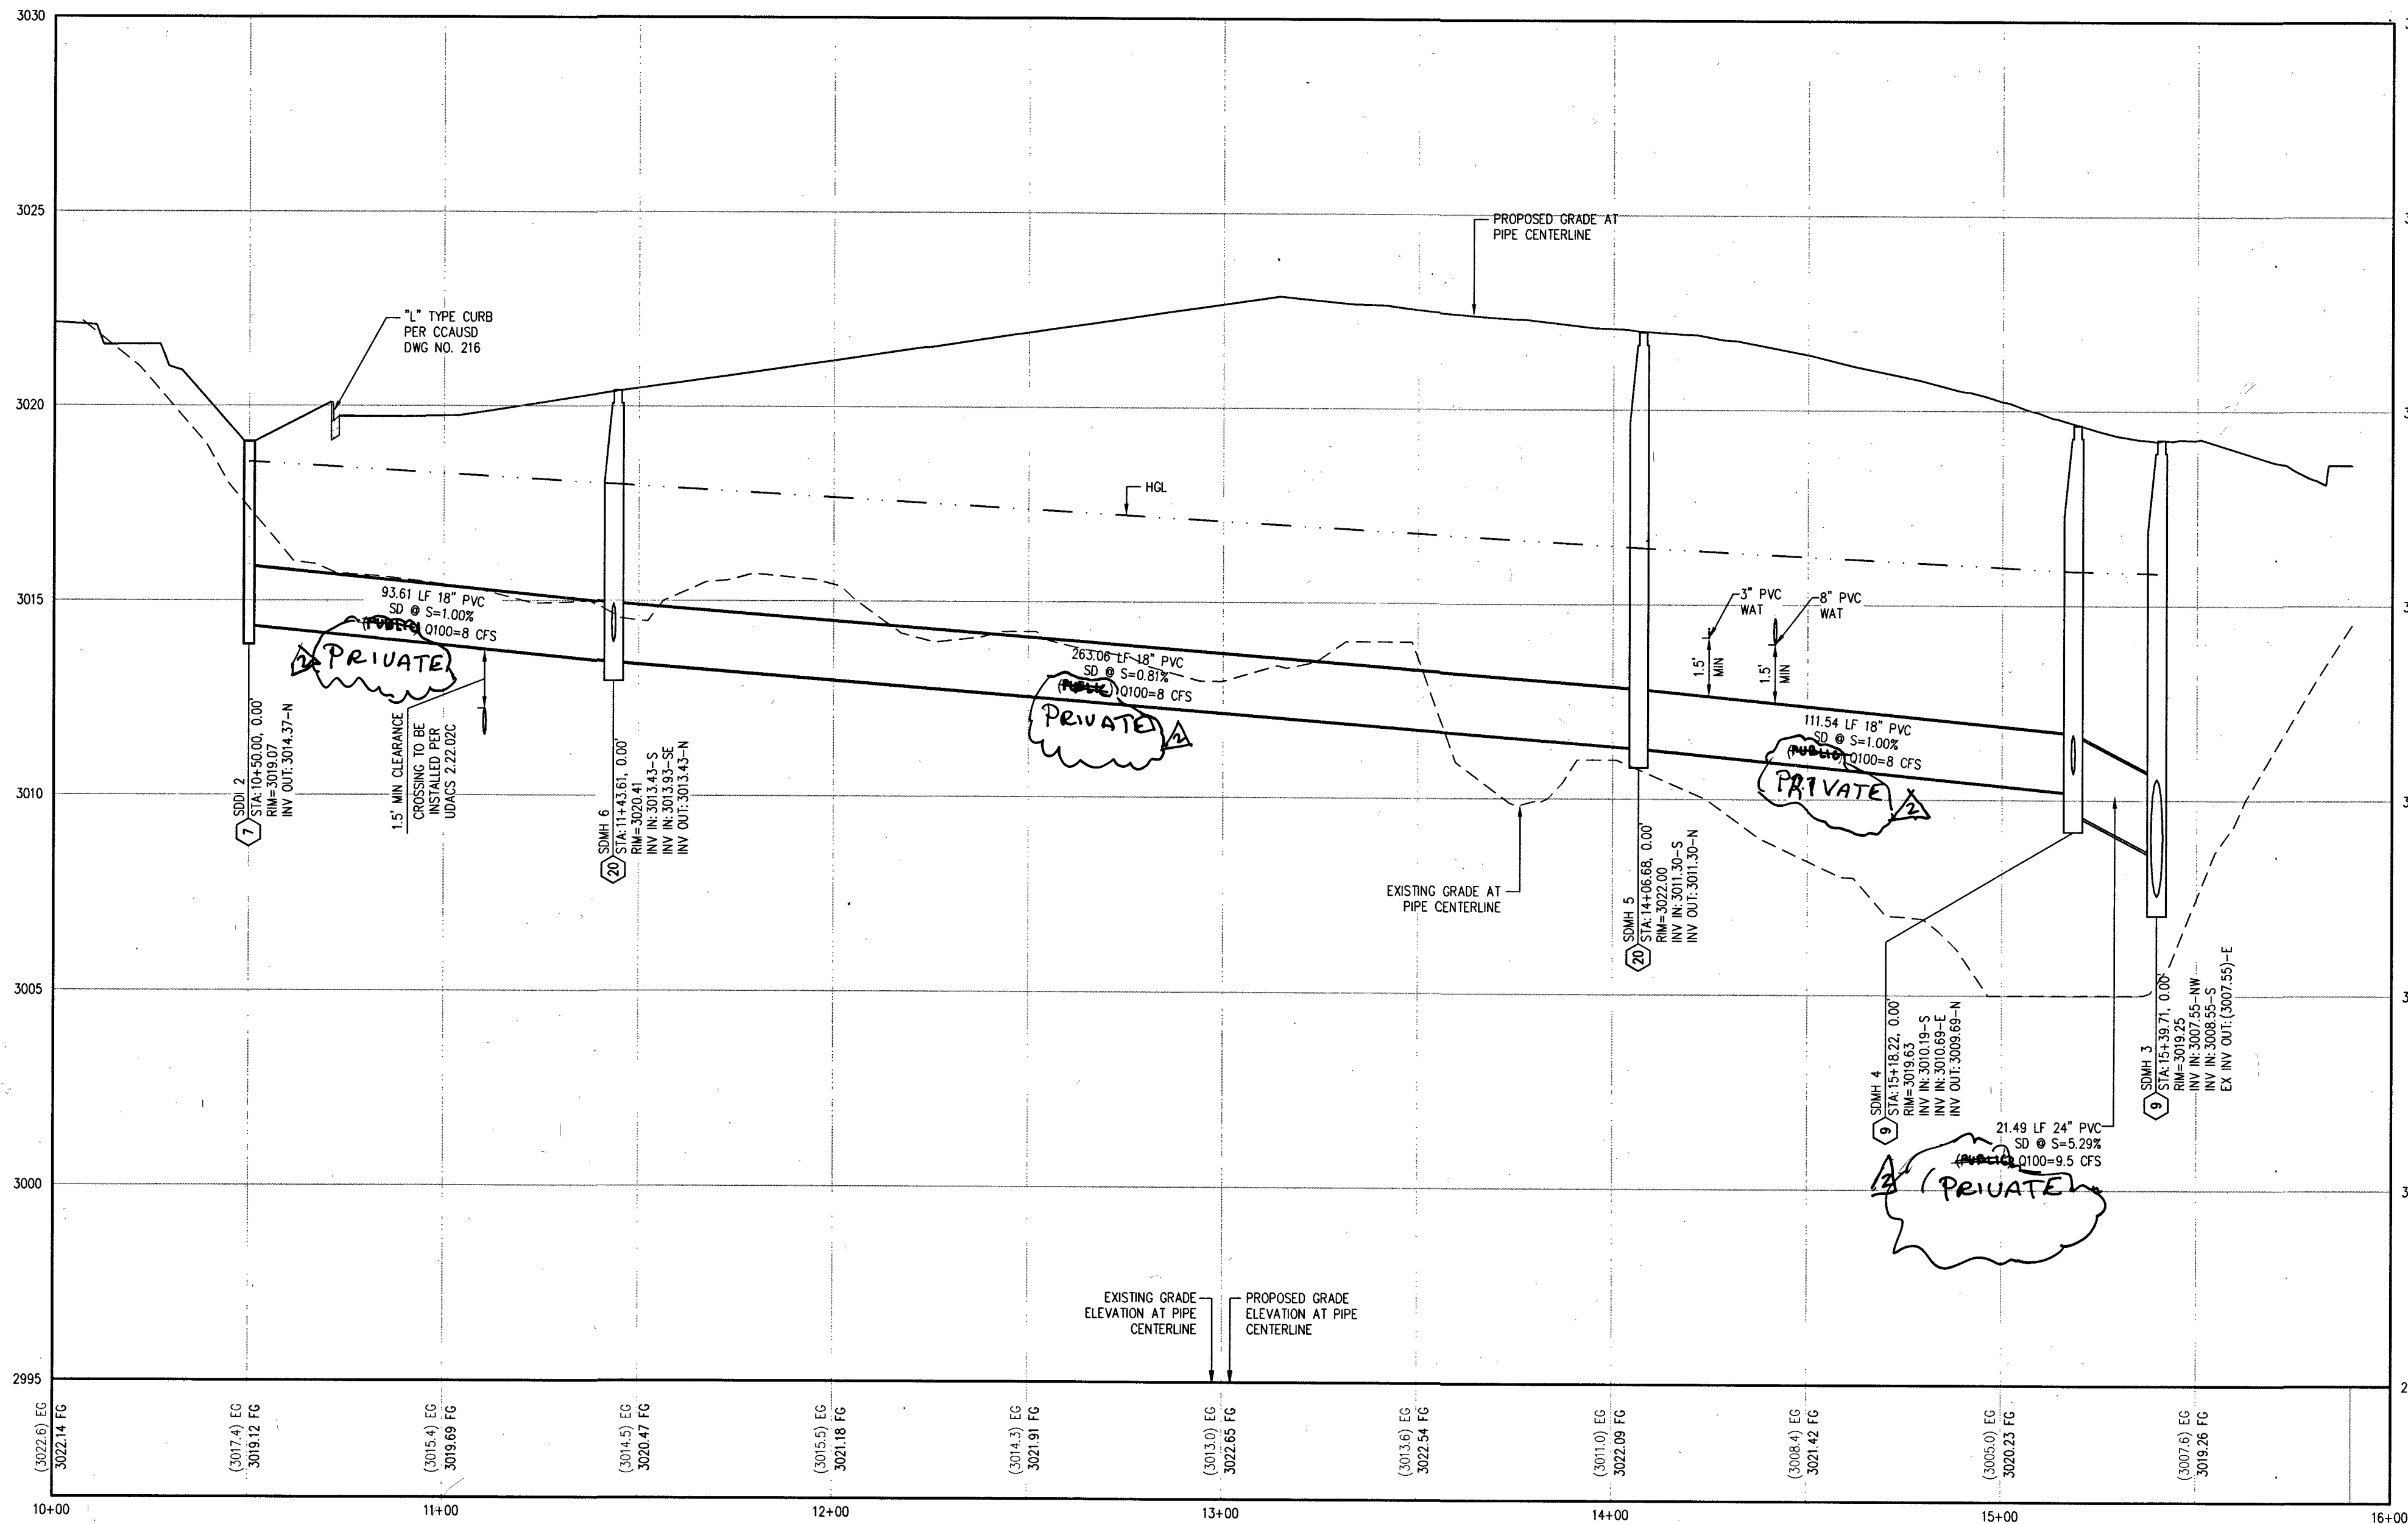

STORM DRAIN #2 - PROFILE VIEW
HORIZ: 1" = 30'
VERT: 1" = 3'

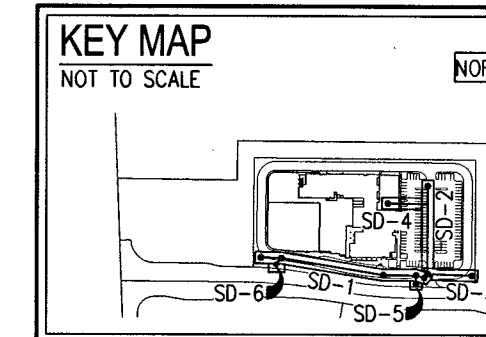

GRADING NOTES


1. "L" TYPE CURB PER CCAUSD DWG NO. 216.
2. "A" CURB PER DETAIL C ON SHEET D-2.
3. "DEPRESSED" CURB PER DETAIL D ON SHEET D-2.
4. CURB OPENING PER DETAIL E ON SHEET D-2.
5. AC PARKING AREA. SEE SOILS REPORT FOR SECTION.
6. 4" THICK CONCRETE SIDEWALK OVER 5" MIN TYPE II AGG. BASE. SEE LANDSCAPE PLAN FOR WIDTH AND FINISH.
7. INSTALL JENSEN PRECAST DRAIN INLET PER DETAILS ON SHEET D-3 (GRATE SIZE PER PLAN) WITH APPROX.
8. HANDICAPPED VAN ACCESSIBLE PARKING STALL IN ACCORDANCE WITH LVMC 19.08.110(2) WITH SIGNAGE PER LVMC 11.52.153.
9. 48" TYPE II STORM DRAIN MANHOLE PER CCAUSD NO. 401 & 405.
10. 36" RCP CLASS III SD, LENGTH PER PLAN.
11. CHILD PLAY AREA. SEE LANDSCAPE PLANS FOR CONSTRUCTION MATERIALS AND HORIZONTAL DIMENSIONS.
12. TURF FIELD. SEE LANDSCAPE PLANS FOR HORIZONTAL DIMENSIONS AND STRIPING DETAILS.
13. BASKETBALL COURT. SEE LANDSCAPE PLANS FOR HORIZONTAL DIMENSIONS AND STRIPING DETAILS.
14. TRASH ENCLOSURE. SEE ARCHITECTURAL PLANS FOR CONSTRUCTION MATERIALS AND DETAILS.
15. SIDEWALK RAMP WITH ARMOR TILE TRUNCATED DOMES OR EQUIVALENT PER CCAUSD NO. 235, CASE II & 235.1.
16. 6" WIDE JURN. TRENCH DRAIN (OR APPROVED EQUAL) PER DETAIL G ON SHEET D-2.
17. INSTALL PRECAST BUMPER BLOCKS PER CCAUSD NO. 238 OR EQUIVALENT (TYPICAL, WHERE SHOWN ON PLANS).
18. 2'-FT WIDE VALLEY GUTTER PER DETAIL F ON SHEET D-2.
19. INSTALL 24" PVC STORM DRAIN.
20. 48" TYPE I STORM DRAIN MANHOLE PER CCAUSD NO. 401.
21. AC PAVEMENT. SEE SOILS REPORT FOR SECTION.
22. RCP END SECTION PER NDOT R-2.3.1. SEE SHEET D-3 FOR DETAIL.
23. ARMOR TILE TRUNCATED DOMES OR EQUIVALENT PER CCAUSD NO. 235, CASE II & 235.1.
24. CONCRETE PAD PER DETAIL K ON SHEET D-2.
25. REMOVE END SECTION AND 9 LF EX. 36" RCP SD.
26. CONSTRUCT SIDEWALK RAMPS WITH ARMOR TILE TRUNCATED DOMES PER DETAIL A ON SHEET D-2.
27. 6" WIDE CONCRETE CURB PER DETAIL L ON SHEET D-2.
28. 12" WIDE CONCRETE CURB PER DETAIL I ON SHEET D-2.
29. INSTALL 18" PVC STORM DRAIN.
30. 12" NOS SQUARE DRAIN (OR APPROVED EQUAL) PER DETAILS ON SHEET D-3.
31. TRANSITION CURB PER DETAIL N ON D-2.
32. INSTALL 12" PVC STORM DRAIN.
33. INSTALL SIDEWALK DRAIN PER CCAUSD #236.
34. CURB OPENING PER DETAIL M ON SHEET D-2.
35. 30" TYPE III STORM DRAIN MANHOLE PER CCAUSD NO. 401 & 405.
36. INSTALL PEDESTRIAN GATE PER ARCHITECT PLANS BY OTHERS.
37. INSTALL 2' WIDE CONCRETE FLUME PER DETAIL O ON SHEET D-2.
38. INSTALL TREATMENT SWALE: MIN 9" DEEP, 4:1 SIDE SLOPE, 5' SPACING (LANDSCAPE ROCK), AND LESS THAN OR EQUAL TO 1% SLOPE.
39. INSTALL WHEEL STOP PER CCAUSD NO. 238.
40. CURB OPENING PER DETAIL T ON SHEET D-2.
41. DIRECTIONAL SIDEWALK RAMP PER DETAIL U ON SHEET D-2.

STORM WATER RUNOFF MANAGEMENT


- (REQUIRED FOR ALL SITES GREATER THAN 1 ACRE (43,560 SQ.FT.))
1. THE OWNER, SITE DEVELOPER, CONTRACTOR AND/OR THEIR AUTHORIZED AGENTS SHALL EACH DAY REMOVE ALL SEDIMENT, MUD, CONSTRUCTION DEBRIS, OR OTHER POTENTIAL POLLUTANTS THAT MAY HAVE BEEN DISCHARGED TO, OR ACCUMULATE IN, THE PUBLIC RIGHTS OF WAYS OF CLARK COUNTY AS A RESULT OF CONSTRUCTION ACTIVITIES ASSOCIATED WITH THIS SITE DEVELOPMENT OR CONSTRUCTION PROJECT. SUCH MATERIALS SHALL BE PREVENTED FROM ENTERING THE STORM SEWER SYSTEM.
 2. ADDITIONAL CONSTRUCTION SITE DISCHARGE BEST MANAGEMENT PRACTICES MAY BE REQUIRED OF THE OWNER AND HIS OR HER AGENTS DUE TO UNFORESEEN EROSION PROBLEMS OR IF THE SUBMITTED PLAN DOES NOT MEET THE PERFORMANCE STANDARDS SPECIFIED IN TITLE 24.40 AND THE LAS VEGAS VALLEY CONSTRUCTION SITE BEST MANAGEMENT PRACTICES MANUAL.
 3. TEMPORARY OR PERMANENT STABILIZATION PRACTICES WILL BE INSTALLED ON DISTURBED AREAS AS SOON AS PRACTICABLE AND NO LATER THAN 14 DAYS AFTER THE CONSTRUCTION ACTIVITY IN THAT PORTION OF THE SITE HAS TEMPORARILY OR PERMANENTLY CEASED. SOME EXCEPTIONS MAY APPLY; REFER TO NEVADA STORMWATER GENERAL PERMIT FOR CONSTRUCTION ACTIVITY NVRI00000, SECTION II.A.5.
 4. AT A MINIMUM, THE CONTRACTOR OR HIS AGENT SHALL INSPECT ALL DISTURBED AREAS, AREAS USED FOR STORAGE OF MATERIALS AND EQUIPMENT THAT ARE EXPOSED TO PRECIPITATION, VEHICLE ENTRANCE, AND EXIT LOCATIONS AND ALL BMPs WEEKLY, AND WITHIN 24 HOURS AFTER ANY ACTUAL RAIN EVENT OF 0.5 INCHES OR MORE. THE CONTRACTOR OR HIS AGENT SHALL UPDATE OR MODIFY THE STORMWATER POLLUTION PREVENTION PLAN AS NECESSARY. SOME EXCEPTIONS TO WEEKLY INSPECTIONS MAY APPLY, SUCH AS SUSPENSION OF LAND DISTURBANCE ACTIVITIES. REFER TO NEVADA STORMWATER GENERAL PERMIT FOR CONSTRUCTION ACTIVITY NVRI00000, SECTION II.A.12.
 5. ACCUMULATED SEDIMENT IN BMPs SHALL BE REMOVED WITHIN SEVEN DAYS AFTER A STORMWATER RUNOFF EVENT OR PRIOR TO THE NEXT ANTICIPATED STORM EVENT, WHICHEVER IS EARLIER. SEDIMENT MUST BE REMOVED WHEN BMP DESIGN CAPACITY HAS BEEN REDUCED BY 50 PERCENT OR MORE.


FEMA FLOOD ZONE DESIGNATION

THE PROJECT SITE IS LOCATED WITHIN A FEMA DESIGNATED ZONE "X" (AREA OUTSIDE THE 500 YEAR FLOODPLAIN), ON THE FLOOD INSURANCE RATE MAP (FIRM) PANEL: 32003C1750E, DATED SEPTEMBER 27, 2002.

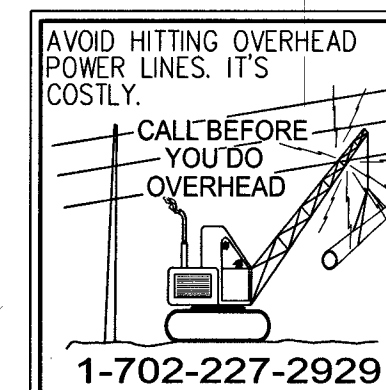


NO.	DESCRIPTION	DATE	BY	APP.
1	CLARKE S.D. TO PRIVATE	11/01/17		

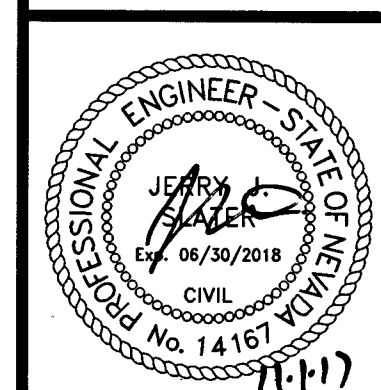


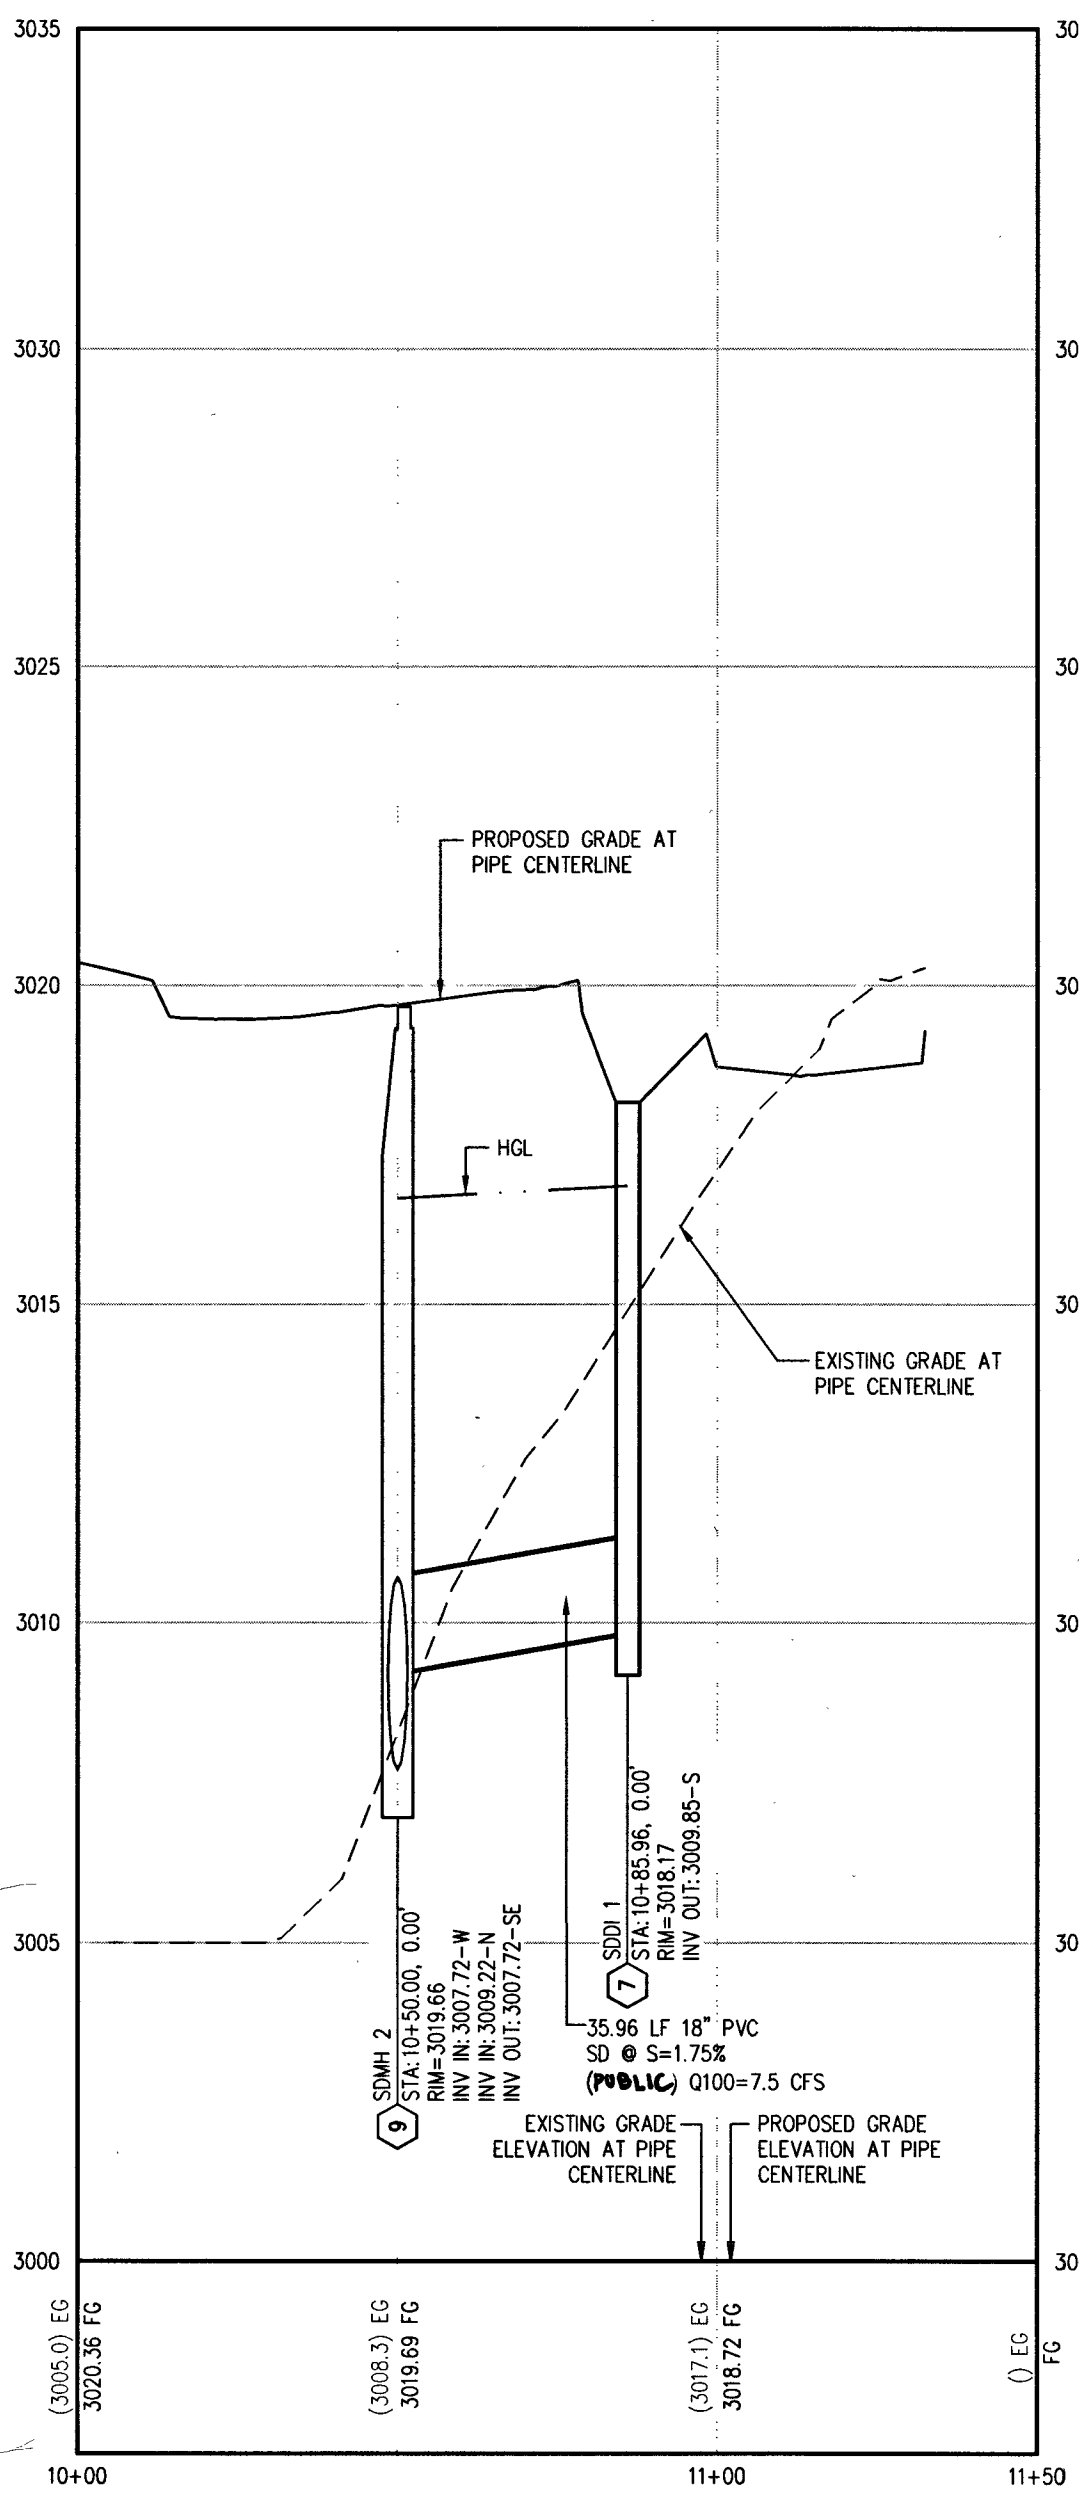


STORM DRAIN #3 - PROFILE VIEW
HORIZ: 1" = 30'
VERT: 1" = 3'

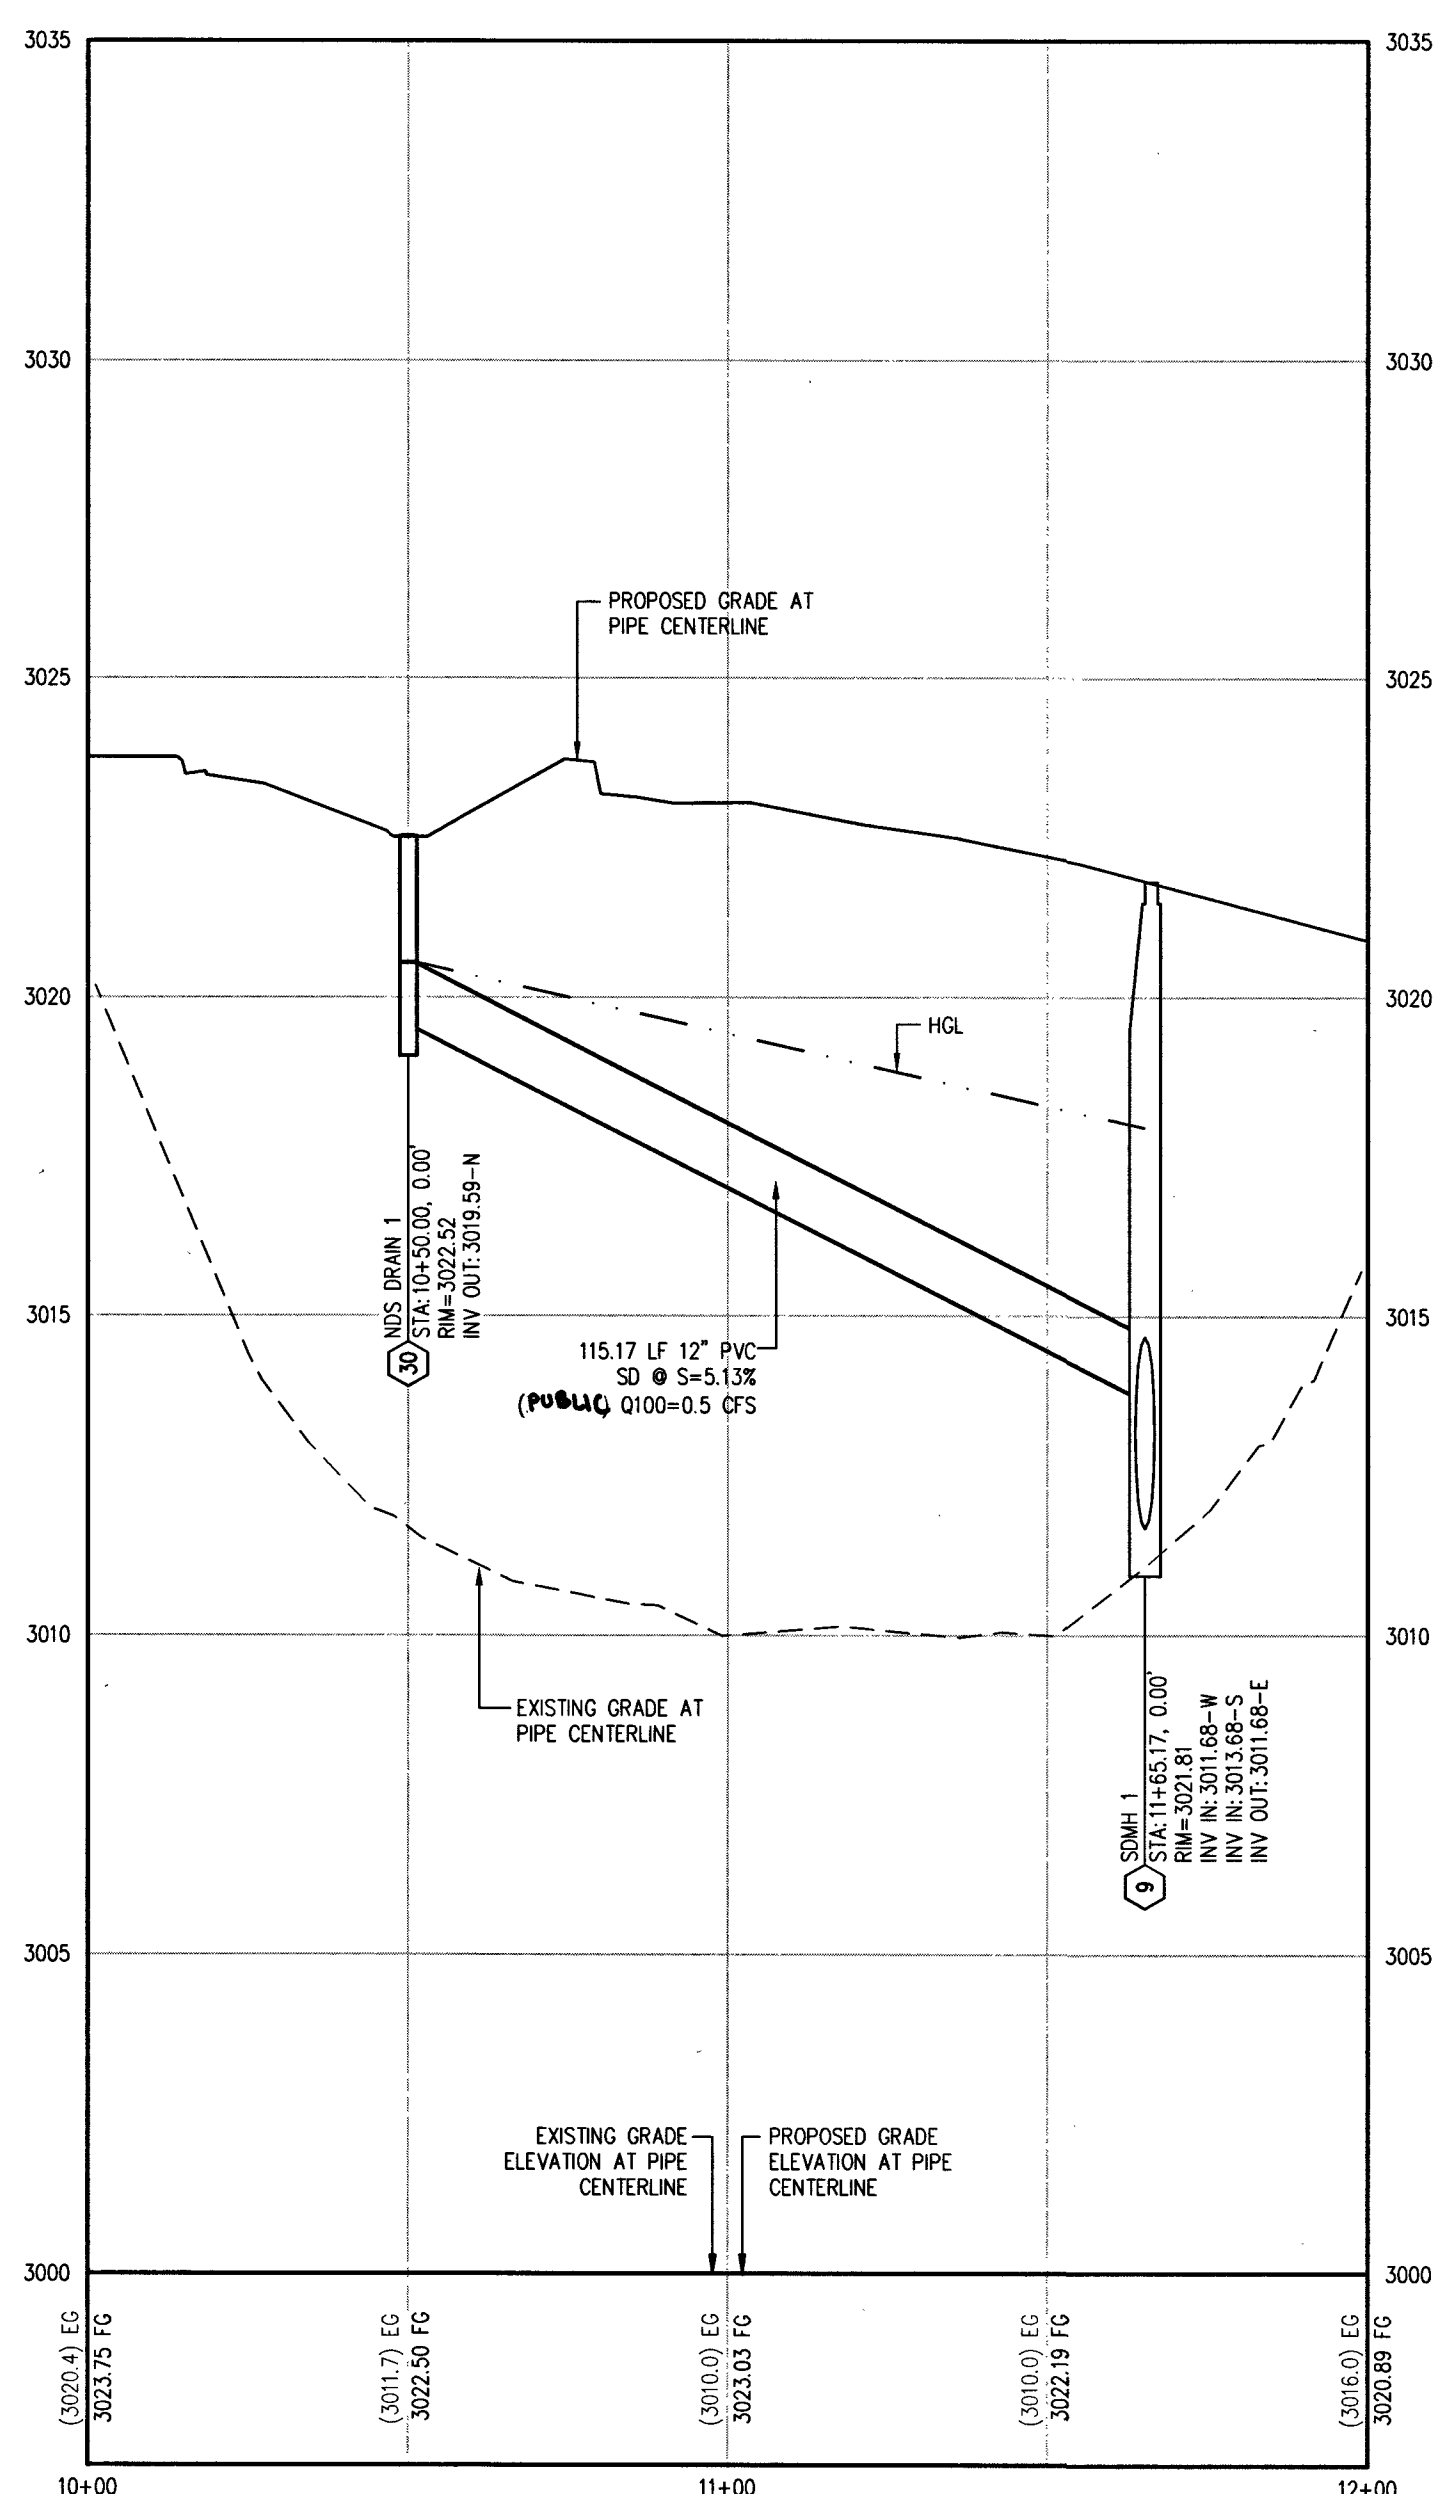

STORM DRAIN #4 - PROFILE VIEW
HORIZ: 1" = 30'
VERT: 1" = 3'

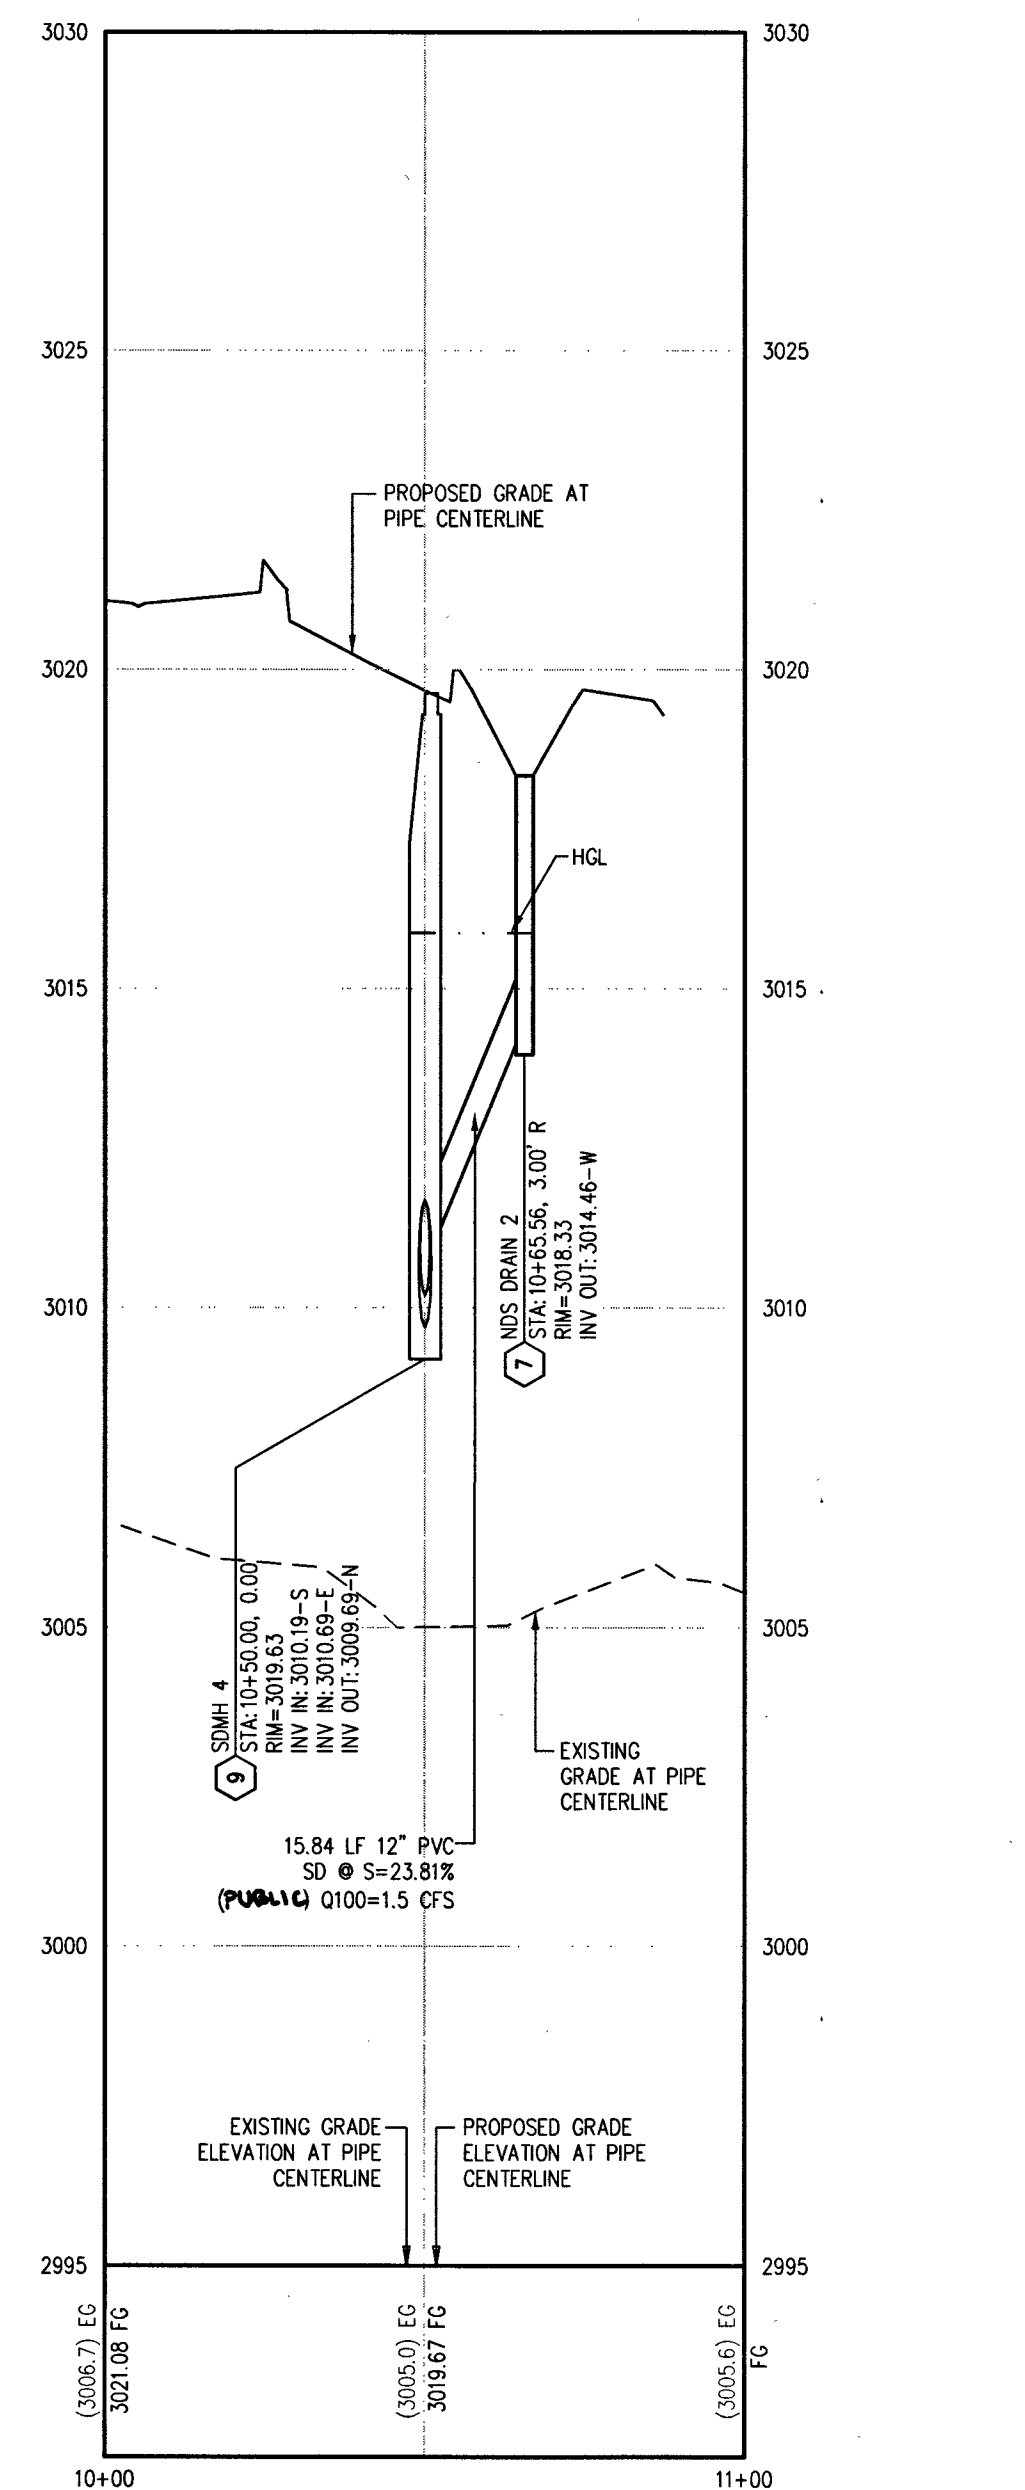

STORM DRAIN #5 - PROFILE VIEW
 HORIZ: 1" = 30'
 VERT: 1" = 3'

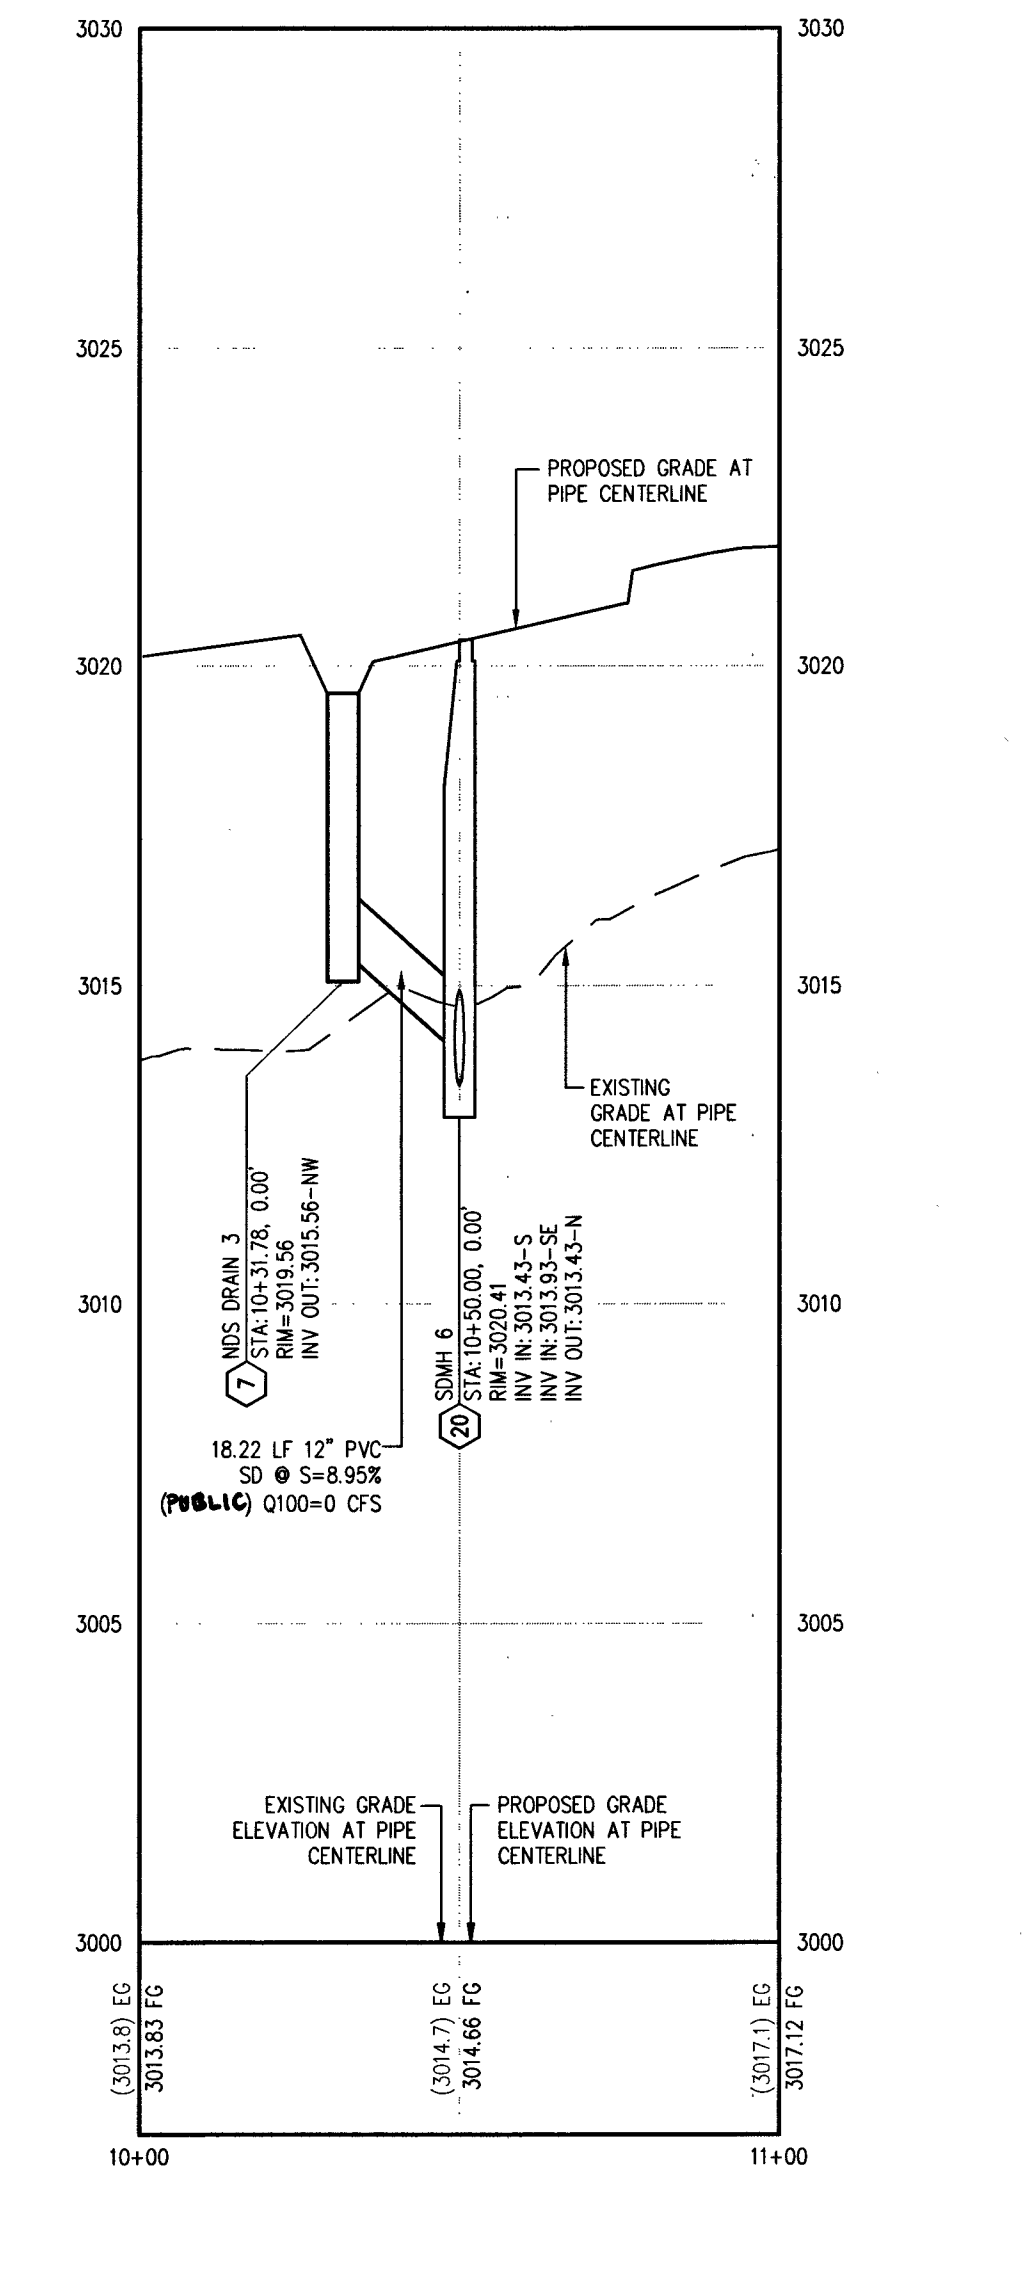

STORM DRAIN #6 - PROFILE VIEW
 HORIZ: 1" = 30'
 VERT: 1" = 3'



- 1 "1" TYPE CURB PER CAUSD DWG NO. 216.
- 2 "A" CURB PER DETAIL C ON SHEET D-2.
- 3 "DEPRESSED" CURB PER DETAIL D ON SHEET D-2.
- 4 CURB OPENING PER DETAIL E ON SHEET D-2.
- 5 AC PARKING AREA. SEE SOLS REPORT FOR SECTION.
- 6 CONCRETE SIDEWALK OVER 2" MIN TYPE II AGG. BASE. SEE LANDSCAPE PLAN FOR WIDTH AND FINISH.
- 7 INSTALL JENSEN PRECAST DRAIN INLET PER DETAILS ON SHEET D-2 (OR DETAIL C ON SHEET D-2) WITH APRON. HANDICAPPED VAN ACCESSIBLE PARKING STALL IN ACCORDANCE WITH LVMC 19.08.10(2) WITH SIGNAGE PER 19.03.
- 8 "E" TYPE II STORM DRAIN MANHOLE PER CAUSD NO. 401 & 405.
- 9 "F" RCP CLASS III SD, LENGTH PER PLAN.
- 10 "G" PLAY AREA. SEE LANDSCAPE PLANS FOR CONSTRUCTION MATERIALS AND HORIZONTAL DIMENSIONS.
- 11 TURF FIELD. SEE LANDSCAPE PLANS FOR HORIZONTAL DIMENSIONS AND STRIPING DETAILS.
- 12 BASKETBALL COURT. SEE LANDSCAPE PLANS FOR CONSTRUCTION MATERIALS AND DETAILS.
- 13 TRASH ENCLOSURE. SEE ARCHITECTURAL PLANS FOR CONSTRUCTION MATERIALS AND DETAILS.
- 14 "H" TYPE I STORM DRAIN MANHOLE PER CAUSD NO. 401 & 405.
- 15 EQUIVALENT PER CAUSD NO. 235, C&S 1 & 235.1.
- 16 "E" WIDE ZURN TRENCH DRAIN (OR APPROVED EQUIV) PER DETAIL C ON SHEET D-2.
- 17 INSTALL PRECAST BUMPER BLOCKS PER CAUSD NO. 238 OR EQUIVALENT (TYPICAL, WHERE SHOWN ON PLANS).
- 18 2'-FT WIDE VALLEY GUTTER PER DET C ON SHEET D-2.
- 19 INSTALL 24" PVC STORM DRAIN.
- 20 "E" TYPE I STORM DRAIN MANHOLE PER CAUSD NO. 401 & 405.
- 21 AC PAVEMENT. SEE SOLS REPORT FOR SECTION.
- 22 RCP END SECTION PER NDOT R-2.3.1. SEE SHEET D-3 FOR DETAIL.
- 23 "E" TYPE I TRUNCATED DOWMS OR EQUIVALENT PER CAUSD NO. 235, C&S 1 & 235.1.
- 24 CONCRETE PAD PER DETAIL K ON SHEET D-2.
- 25 REMOVE END SECTION AND 9 LF EX. 36" RCP SD.
- 26 CONSTRUCT SIDEWALK RAMPS WITH ARMOR THE TRUNCATED DOWMS PER DETAIL A ON SHEET D-2.
- 27 "E" WIDE CONCRETE CURB PER DETAIL L ON SHEET D-2.
- 28 12" WIDE CONCRETE CURB PER DETAIL I ON SHEET D-2.
- 29 INSTALL 18" PVC STORM DRAIN.
- 30 "H" TYPE I STORM DRAIN MANHOLE (OR APPROVED EQUIV) PER DETAIL C ON SHEET D-2.
- 31 TRANSITION CURB PER DETAIL N ON D-2.
- 32 INSTALL 12" PVC STORM DRAIN.
- 33 INSTALL SIDEWALK DRAIN PER CAUSD #236.
- 34 CURB OPENING PER DETAIL M ON SHEET D-2.
- 35 "E" TYPE II STORM DRAIN MANHOLE PER CAUSD NO. 401 & 405.
- 36 PEDESTRIAN GATE OVER ARCHITECT PLANS BY OTHERS.
- 37 INSTALL 2' WIDE TREATMENT FLUME PER DETAIL D ON SHEET D-2.
- 38 INSTALL TREATMENT SWALE: MIN 9" DEEP, 4:1 SIDE SLOPE, 15% (LANDSCAPE ROCK), AND LESS THAN OR EQUAL TO 15% SLOPE.
- 39 INSTALL WHEEL STOP PER CAUSD NO. 238.
- 40 CURB OPENING PER DETAIL T ON SHEET D-2.
- 41 DIRECTIONAL SIDEWALK RAMP PER DETAIL U ON SHEET D-2.

STORM WATER RUNOFF

MANAGEMENT

(REQUIRED FOR ALL SITES GREATER THAN 1 ACRE (43,560 SQ. FT.))

1. THE OWNER, SITE DEVELOPER, CONTRACTOR AND/OR THE AUTHORIZED AGENT SHALL, EACH DAY REMOVE ALL SEDIMENT, MUD, CONSTRUCTION DEBRIS, OR OTHER POTENTIAL POLLUTANTS THAT MAY HAVE BEEN DISCHARGED TO THE STORMWATER DRAINAGE SYSTEM. THE AGENT OF CLARK COUNTY AS A RESULT OF CONSTRUCTION ACTIVITIES ASSOCIATED WITH THIS SITE DEVELOPMENT OR CONSTRUCTION PROJECT. SUCH MATERIALS SHALL BE REMOVED FROM THE STORM DRAIN EXTERIOR TO THE SITE.
2. ADDITIONAL CONSTRUCTION SITE DISCHARGE, BEST MANAGEMENT PRACTICES MAY BE REQUIRED OF THE OWNER AND HIS OR HER AGENTS DUE TO UNFORESEEN EROSION OR OTHER ACTIVITY THAT MAY EXCEED THE DESIGN OR THE PERFORMANCE STANDARDS SPECIFIED IN TITLE 24.40 AND THE LAS VEGAS VALLEY CONSTRUCTION SITE BEST MANAGEMENT PRACTICES.
3. TEMPORARY OR PERMANENT STABILIZATION PRACTICES WILL BE INSTALLED ON DISTURBED AREAS AS SOON AS PRACTICABLE AND NO LATER THAN 14 DAYS AFTER THE COMPLETION OF THE ACTIVITY THAT CAUSED THE DISTURBANCE. TEMPORARILY OR PERMANENTLY CEASED. SOME EXCEPTIONS MAY APPLY; REFER TO NEVADA STATE GENERAL PERMIT FOR CONSTRUCTION ACTIVITY NVR100000, SECTION 11.2.
4. AT A MINIMUM, THE CONTRACTOR OR HIS AGENT SHALL INSPECT ALL DISTURBED AREAS, AREAS USED FOR STORAGE OF MATERIALS AND EQUIPMENT, TRUCK AND EQUIPMENT TO PRECIPITATION, VEHICLE ENTRANCE AND EXIT LOCATIONS AND ALL AREAS WEEKLY, AND WITHIN 24 HOURS AFTER ANY ACTUAL RAIN EVENT OF 0.5 INCHES OR MORE. THE CONTRACTOR OR HIS AGENT SHALL REPORT ANY VIOLATION TO THE STORMWATER POLLUTION PREVENTION PLAN AS NECESSARY. SOME EXCEPTIONS TO WEEKLY INSPECTIONS MAY APPLY, INCLUDING SUSPENSION OF INSPECTIONS DURING WINTER. REFER TO NEVADA STATE GENERAL PERMIT FOR CONSTRUCTION ACTIVITY NVR100000, SECTION 11.12.
5. ACCUMULATED SEDIMENT IN BMP'S SHALL BE REMOVED WITHIN 72 HOURS, 14 DAYS, 30 DAYS, OR 60 DAYS, AFTER AN EVENT OR PRIOR TO THE NEXT ANTICIPATED STORM EVENT, WHICHEVER IS EARLIER. SEDIMENT MUST BE REMOVED WITHIN THE DESIGN CAPACITY HAS BEEN REDUCED BY 50 PERCENT, OR MORE.

FEMA FLOOD ZONE DESIGNATION

THE PROJECT SITE IS LOCATED WITHIN A FEMA DESIGNATED
ZONE 'X' (AREA OUTSIDE THE 500 YEAR FLOODPLAIN), ON
THE FLOOD INSURANCE RATE MAP (FIRM)
PANEL: 32003C1750E, DATED SEPTEMBER 27, 2002.

FAST

 Call before you UnderGround

1-702-432-5300
FREeway & ARTERIAL SYSTEMS OF TRANSPORTATION (F.A.S.T.)

AVOID HITTING OVERHEAD
POWER LINES. IT'S
COSTLY.



CALL BEFORE
YOU DO
OVERHEAD

1-702-227-2929


Call before you Dig
AVOID CUTTING UNDERGROUND
UTILITY LINES. IT'S COSTLY.

Call

OR
1-800-227-2600

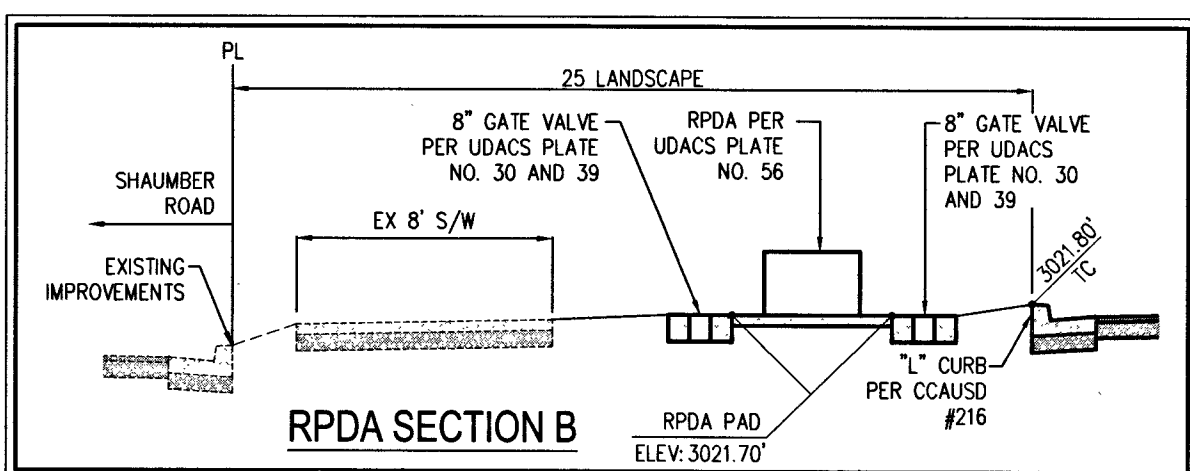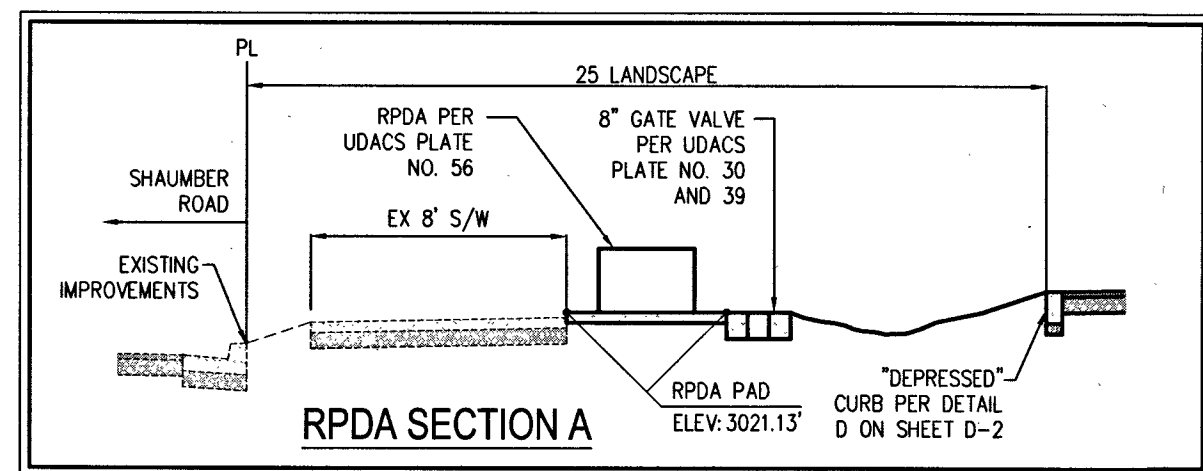

SECTION 12 L L C
 APN: 126-12-000-001
 ZONING CLASSIFICATION: T-D (T-D)
 DOC#2013110700003068

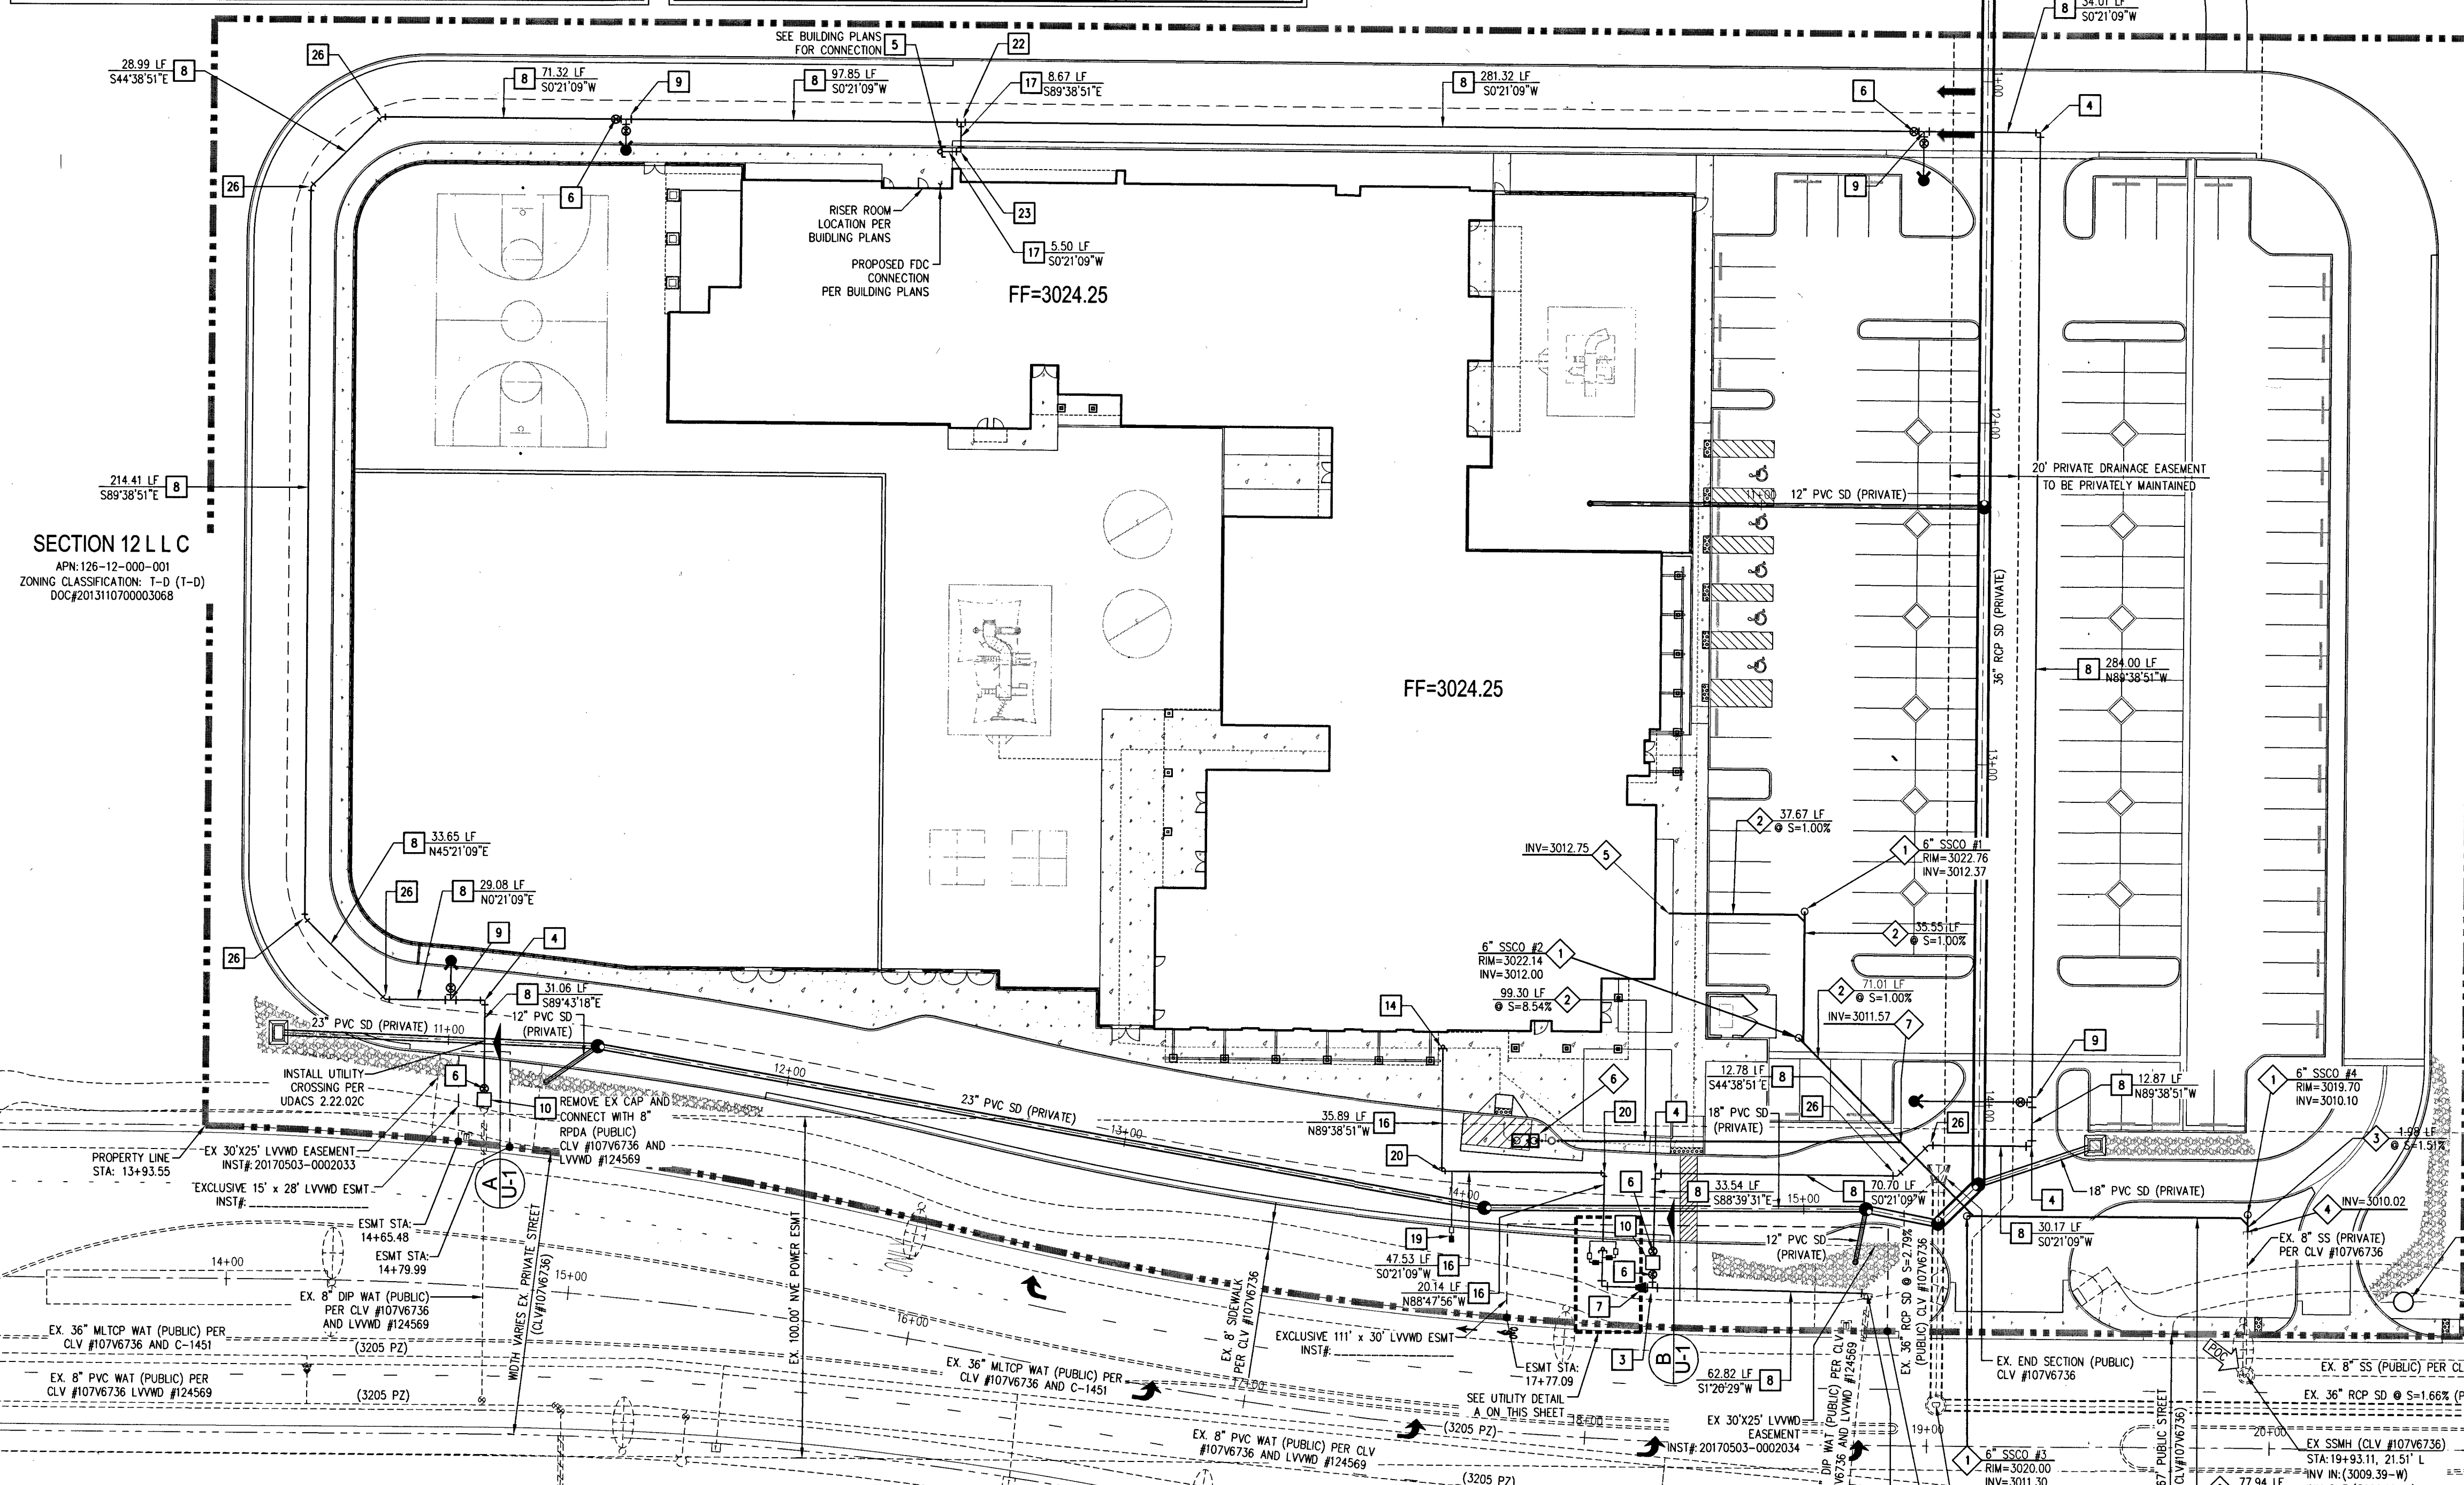


REDUCED PRESSURE PRINCIPLE ASSEMBLY (2) 2"
 APPROVED REDUCED PRESSURE PRINCIPLE ASSEMBLY(S) SHALL BE INSTALLED PER THE UDACS PLATE NO. 8. NO WATER SHALL BE TAKEN FROM A SERVICE REQUIRING BACKFLOW PREVENTION UNTIL THE REDUCED PRESSURE PRINCIPLE ASSEMBLY HAS BEEN SUCCESSFULLY TESTED BY THE LVWD. ANY BLOCK WALL OR OTHER FENCE MATERIAL SHALL BE DESIGNED AND CONSTRUCTED AROUND THE OUTSIDE OF THE EASEMENT(S) TO ALLOW THE DISTRICT DIRECT ACCESS FROM THE ADJACENT RIGHT-OF-WAY. EASEMENTS SHALL BE CLEARLY MARKED OR STAKED PRIOR TO THE START OF CONSTRUCTION.

REDUCED PRESSURE DETECTOR ASSEMBLY (2) 8"
 THE WATTS SERIES 909 REDUCED PRESSURE DETECTOR ASSEMBLY SHALL BE INSTALLED IN ACCORDANCE WITH THE UDACS PLATE NO. 56. NO WATER SHALL BE TAKEN FROM A SERVICE REQUIRING BACKFLOW PREVENTION UNTIL THE ASSEMBLY HAS BEEN SUCCESSFULLY TESTED BY LVWD. ANY BLOCK WALL OR OTHER FENCE MATERIAL SHALL BE DESIGNED AND CONSTRUCTED AROUND THE OUTSIDE OF THE EASEMENT(S) SO AS TO ALLOW LVWD DIRECT ACCESS FROM THE ADJACENT RIGHT-OF-WAY. EASEMENTS SHALL BE CLEARLY MARKED OR STAKED PRIOR TO THE START OF CONSTRUCTION.

SEWER CONNECTION NOTE
 ONE OR MORE SEGMENTS OF THE DOWNSIDE SEWER SYSTEM THAT WILL SERVE THIS PROJECT HAS NOT BEEN COMPLETED AND/OR ACCEPTED FOR MAINTENANCE BY THE CITY OF LAS VEGAS. ANY WORK DONE ON THIS PROJECT PRIOR TO THE COMPLETION AND/OR ACCEPTANCE OF THE DOWNSIDE SEWER SYSTEM(S) SHALL BE DONE AT THE DEVELOPER'S OWN RISK. THE CITY OF LAS VEGAS RESERVES THE RIGHT TO PREVENT THE PHYSICAL CONNECTION OF THIS PROJECT INTO THE DOWNSIDE SEWER SYSTEM UNTIL ALL SEGMENTS HAVE BEEN COMPLETED AND ACCEPTED FOR MAINTENANCE, OR UNTIL SUCH TIME AS THEY ARE DEMED AVAILABLE FOR SERVICE.

SECTION 12 L L C
 APN: 126-12-000-001
 ZONING CLASSIFICATION: T-D (T-D)
 DOC#2013110700003068

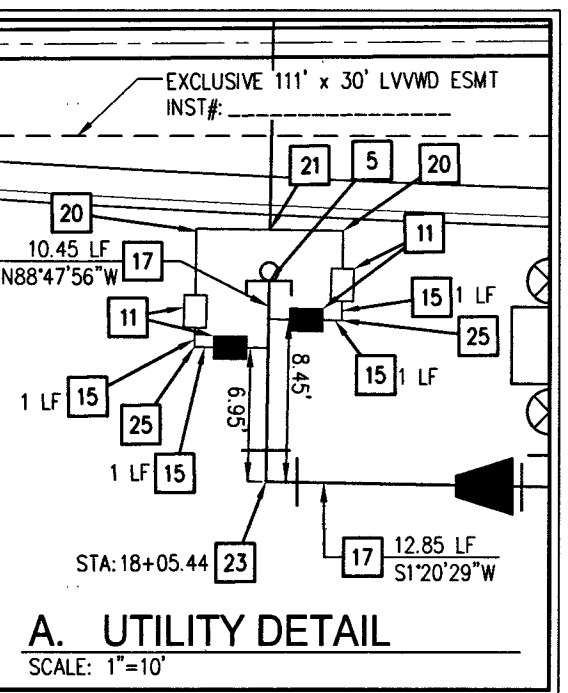

WATER NOTES

1. INSTALL 8" 5' BEND PER UDACS PLATE NO. 31
2. NOT USED
3. INSTALL 8" 8' TEE PER UDACS PLATE NO. 31
4. INSTALL 8" 90° BEND PER UDACS PLATE NO. 31
5. INSTALL 6" CAP PER UDACS PLATE NO. 31
6. INSTALL 8" GATE VALVE PER UDACS PLATE NO. 30 AND 39
7. INSTALL 8" 6" REDUCER PER UDACS PLATE NO. 30
8. INSTALL 8" PVC WATER PIPE
9. FIRE HYDRANT ASSEMBLY W/6" GATE VALVE PER UDACS PLATE NO. 40
10. INSTALL 8" WATTS SERIES 909 REDUCED PRESSURE DETECTOR ASSEMBLY
11. INSTALL 2" COPPER SERVICE WITH 2" METER AND 2" RPPA PER UDACS PLATE NO. 4 AND 8
12. NOT USED
13. NOT USED
14. INSTALL 3" CAP WITH BLOWOFF PER UDACS PLATE NO. 36
15. INSTALL 2" BRASS WATER PIPE
16. INSTALL 3" PVC WATER PIPE
17. INSTALL 6" PVC WATER PIPE
18. 10" GATE VALVE PER UDACS PLATE NO. 30 AND 39
19. INSTALL 1" COPPER SERVICE WITH 1" RPPA FOR LANDSCAPE IRRIGATION PER UDACS PLATE NO. 4 AND 8 (PRIVATE)
20. INSTALL 3" 90° BEND PER UDACS PLATE NO. 31
21. INSTALL 3" 3" 3" TEE PER UDACS PLATE NO. 31
22. INSTALL 8" 6" TEE PER UDACS PLATE NO. 31
23. INSTALL 6" 90° BEND PER UDACS PLATE NO. 31
24. INSTALL 6" GATE VALVE PER UDACS PLATE NO. 30 AND 39
25. INSTALL 2" BRASS 90° BEND
26. INSTALL 8" 45° BEND PER UDACS PLATE NO. 31
27. REMOVE EX CAP AND CONNECT WITH A 90° BEND PER UDACS PLATE #31

SEWER NOTES

1. INSTALL SANITARY SEWER CLEANOUT, SIZE PER PLAN, PER TRAFFIC RATED DCSWS DWG NO. SD-26
2. INSTALL 6" PVC SS PER DCSWS SD-15 AND SD-17
3. INSTALL 8" PVC SS PER DCSWS SD-15 AND SD-17
4. REMOVE PLUG & CONNECT TO EXISTING SANITARY SEWER
5. SEE ARCHITECTURAL PLANS FOR CONNECTION
6. GREASE INTERCEPTOR, PER PLUMBING PLANS
7. INSTALL 6"x6" WYE SEWER CONNECTION PER SD-22 & SD-23

SEE SHEET C-2 FOR LEGEND, ABBREVIATIONS AND QUANTITIES

APPROVED FOR CONSTRUCTION
 LAS VEGAS VALLEY WATER DISTRICT ENGINEERING SERVICES
 PROJECT NO. 126222
 FIRST APPROVED DATE: 11/11/17
 LVWD APPROVED FIRE FLOW 2,875 GPM AT 20 PSI RESIDUAL

APPROVAL
 LAS VEGAS FIRE AND RESCUE
 DATE: 11/8/17

BENCHMARK
 USDA BRASS CAP ON AN IRON PIPE, 140' SOUTHWEST OF TELEPHONE POLE #269941, SOUTHWEST CORNER OF THE U.S. 95/141E CANYON TURNOUT
 ELEVATION = 2817.62 FEET, 858.813 METERS
 N.A.V.D. 88
 PER THE CLARK COUNTY VERTICAL CONTROL LAST REVISED 2003

BASIS OF BEARINGS
 THE BASIS OF BEARING IS SOUTH 02°22'12" WEST, BEING THE BEARING OF THE WEST LINE OF THE NORTHWEST QUARTER (NW1/4) OF SECTION 6, TOWNSHIP 19 SOUTH, RANGE 60 EAST, N.M.D., CITY OF LAS VEGAS, CLARK COUNTY, NEVADA, AS SHOWN BY MAP THEREOF IN FILE 151, PAGE 14 OF SURVEYS IN THE CLARK COUNTY RECORDER'S OFFICE, NEVADA.

FIRE FLOW CALCULATIONS
 TOTAL FIRE FLOW 2,875 GPM AT 20 P.S.I. RESIDUAL
 ON SITE FIRE FLOW 2,875 GPM
 ON SITE SPRINKLER 1,500 GPM

USE/OCCUPANCY
 TYPE OF CONSTRUCTION (IBC)
 TYPE V-B
 SQUARE FOOTAGE
 47,365 SF
 LARGEST AREA BETWEEN 4 HOUR WALLS
 N/A
 BUILDING HEIGHT
 35'-2"
 NO OF STORES INCLUDING BASEMENT
 2
 FIRE SPRINKLER
 YES
 NO OF HYDRANTS INSTALLED
 4



FAST
 Call before you Dig
 UnderGround
 1-702-432-5300
 FREEMAN & ARTERIAL SYSTEM OF TRANSPORTATION (F.A.S.T.)

AVOID HITTING OVERHEAD POWER LINES. IT'S COSTLY.
 CALL BEFORE YOU DIG
 1-702-227-2929

Call before you Dig
 AVOID CUTTING UNDERGROUND UTILITY LINES. IT'S COSTLY.
 Call
 811
 OR
 1-800-227-2600

WATER NOTES

1. WATER MAIN JOINT DEFLECTION (PVC 3" - 24")
 PVC PIPE SHALL BE DEFLECTED AT THE JOINT ONLY. THE MAXIMUM ALLOWABLE DEFLECTION SHALL BE ONE (1) DEGREE PER JOINT WITH A MINIMUM RADIUS OF CURVATURE OF 1,150 FEET. PER UDACS 2.07.01 AND 2.07.02.
 FOR CHANGES IN DIRECTION EXCEEDING THE MAXIMUM ALLOWABLE JOINT DEFLECTION, FITTINGS SHALL BE USED.
2. ALL SEWER / STORM DRAINS CROSSING WATER LINES MUST CONFORM TO SECTION 2.22 OF THE UNIFORM DESIGN AND CONSTRUCTION STANDARDS FOR POTABLE WATER SYSTEMS (UDACS) FOR WATER AND STORM MAIN CROSSINGS AND CLEARANCES.
3. FITTINGS SHALL NOT FALL UNDER CURBS, GUTTERS OR SIDEWALKS.
4. INSTALL PIPELINE MARKER BALLS IN TRENCH ABOVE EACH HORIZONTAL ELBOW FITTING PER UDACS PLATE NO. 15.
5. THE LVWD CANNOT GUARANTEE A WATER TIGHT SHUTDOWN WHERE CONNECTIONS OR REPAIRS TO EXISTING FACILITIES ARE REQUIRED. THE CONTRACTOR SHALL ENSURE ALL LABOR AND EQUIPMENT IS AVAILABLE TO REMOVE FUGITIVE WATER THAT MAY IMPEDE CONSTRUCTION AT ALL TIMES. COORDINATION WITH INSPECTION DIVISION MUST TAKE PLACE PRIOR TO ANY TRIAL SHUTDOWN.
6. DISCLAIMER: EXISTING UTILITY LOCATIONS SHOWN HEREON ARE APPROXIMATE ONLY. IT SHALL BE THE CONTRACTOR'S RESPONSIBILITY TO DETERMINE THE EXACT VERTICAL AND HORIZONTAL LOCATION OF ALL EXISTING UNDERGROUND UTILITIES PRIOR TO COMMENCING CONSTRUCTION. NO REPRESENTATION IS MADE THAT ALL EXISTING UTILITIES ARE SHOWN HEREON. THE ENGINEER ASSUMES NO RESPONSIBILITY FOR UTILITIES NOT SHOWN IN THEIR PROPER LOCATION.
7. ALL ABOVE GROUND OBSTRUCTIONS INCLUDING BUT NOT LIMITED TO LANDSCAPE BOULDERS, FENCES/WALLS, AND SIGNS ARE STRICTLY PROHIBITED WITHIN EASEMENT.

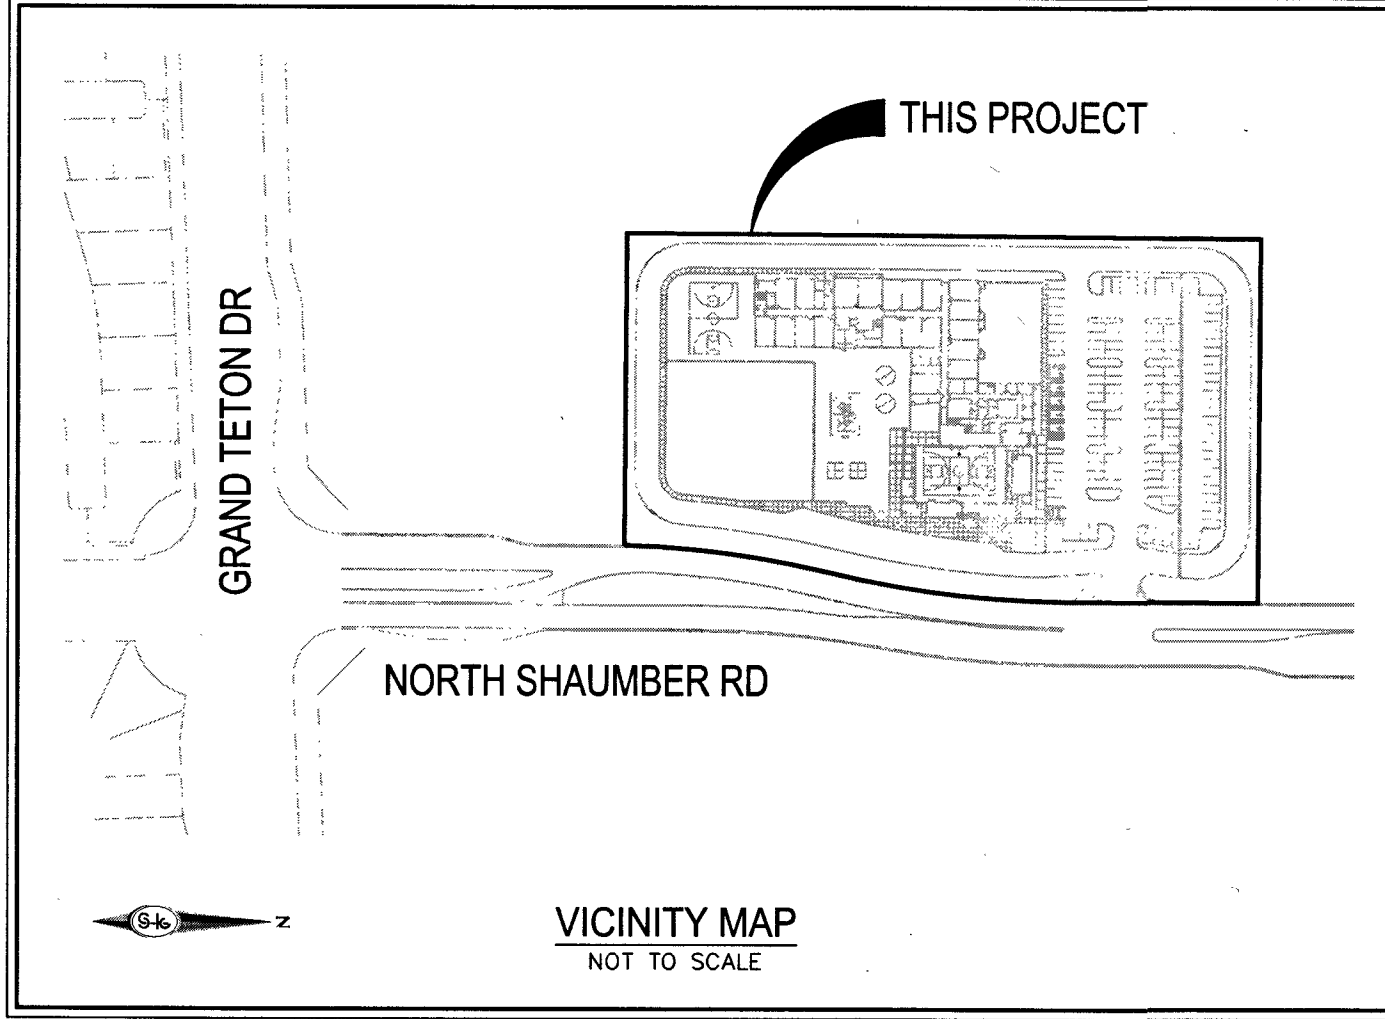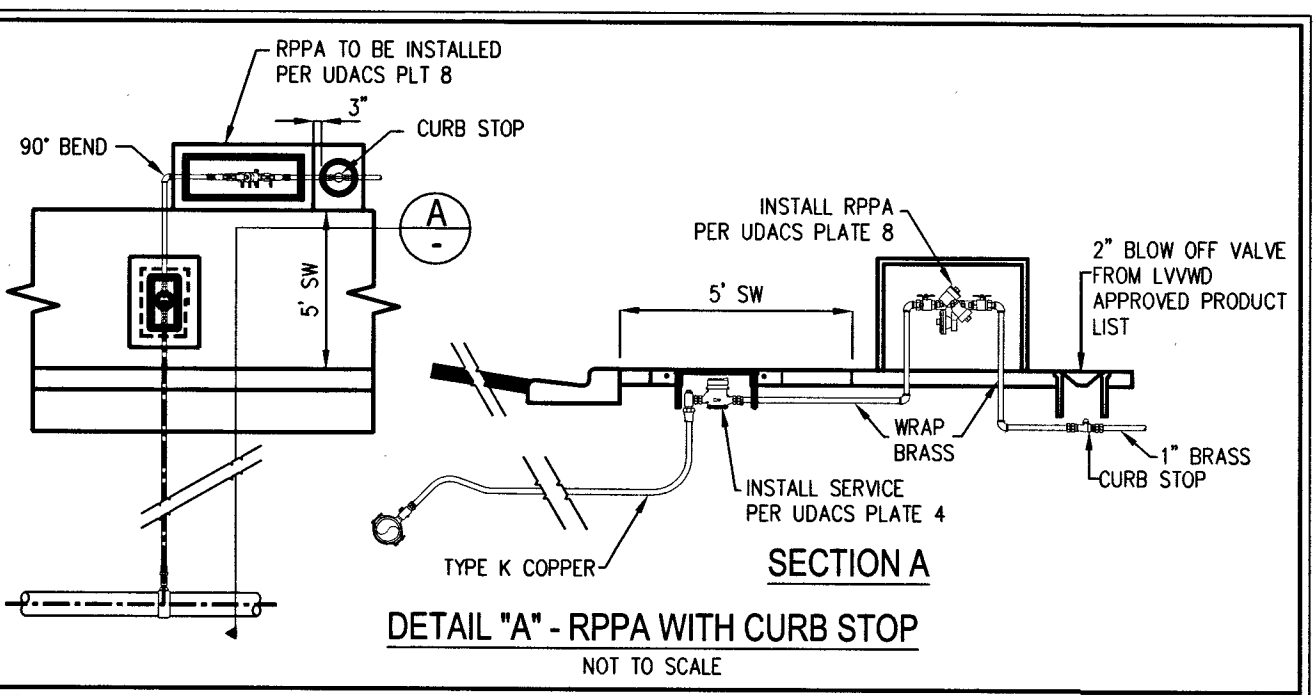

SLATER HANIFAN GROUP
CONSULTING ENGINEERS & PLANNERS
 5740 S. ARVILLE STREET #216, LAS VEGAS, NV 89118
 PHONE (702) 284-5390 FAX (702) 284-5390




ETHOS THREE ARCHITECTURE
SKYE CANYON SOMERSET ACADEMY
UTILITY PLAN

CITY OF LAS VEGAS

DATE: 11/1/17
 DRAFTER: DNP
 DESIGNER: BCC
 CHECKED: STS
 PROJECT NO. ETA1601-000

U-1
 SHEET 14 OF 15
 HANSEN NO. 68370
 DWG NO. 715-196

PROJ#126227 AGR116208 QS:126-12-SW

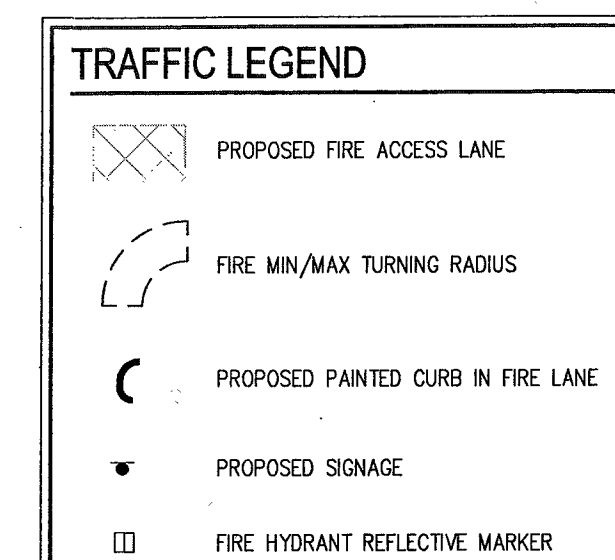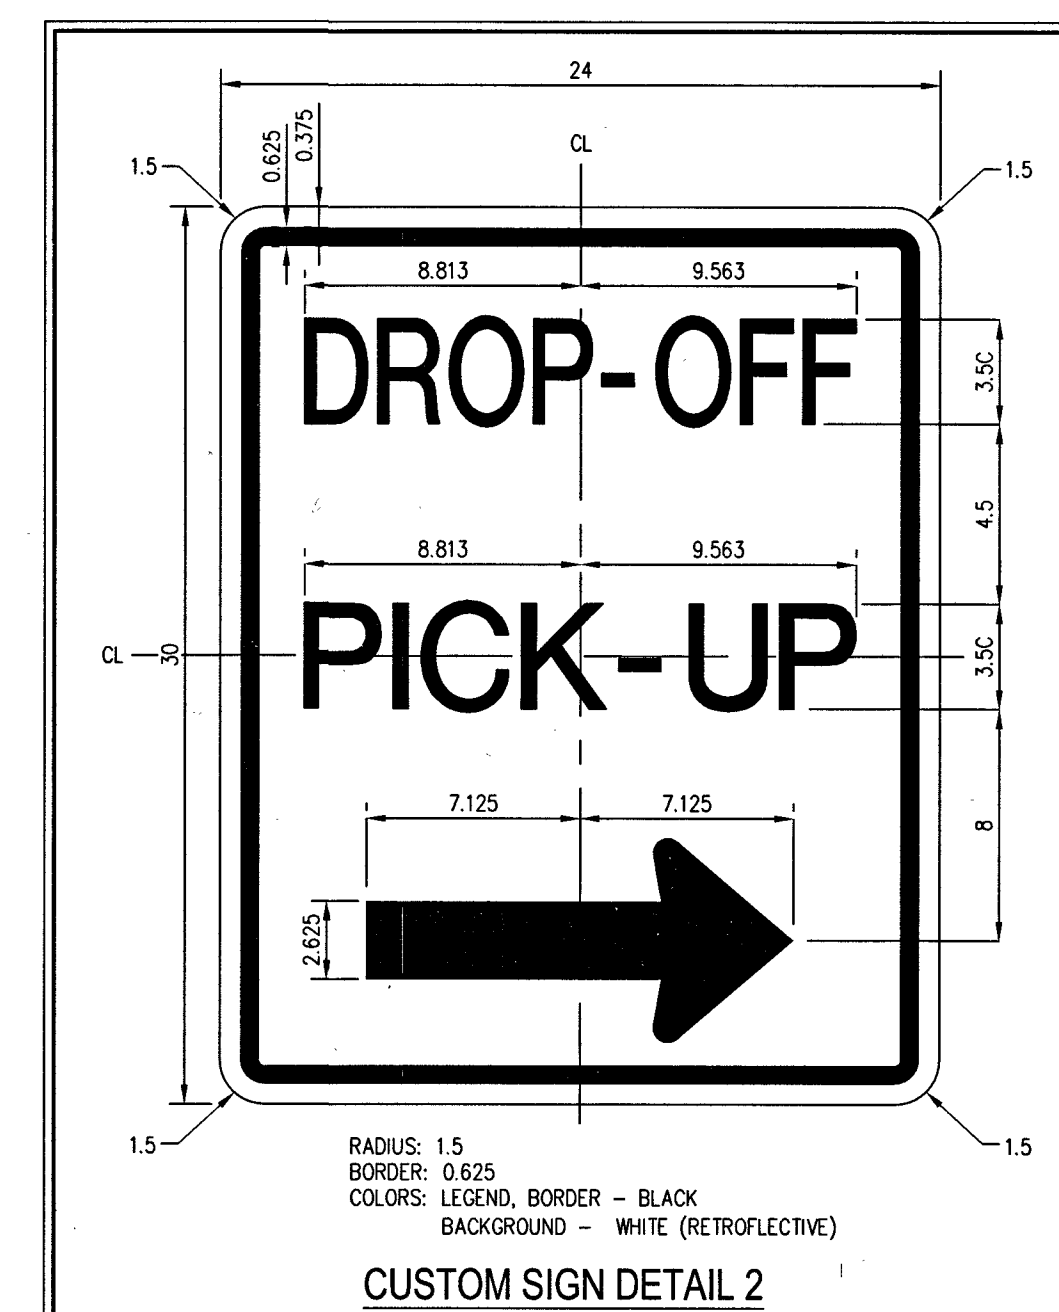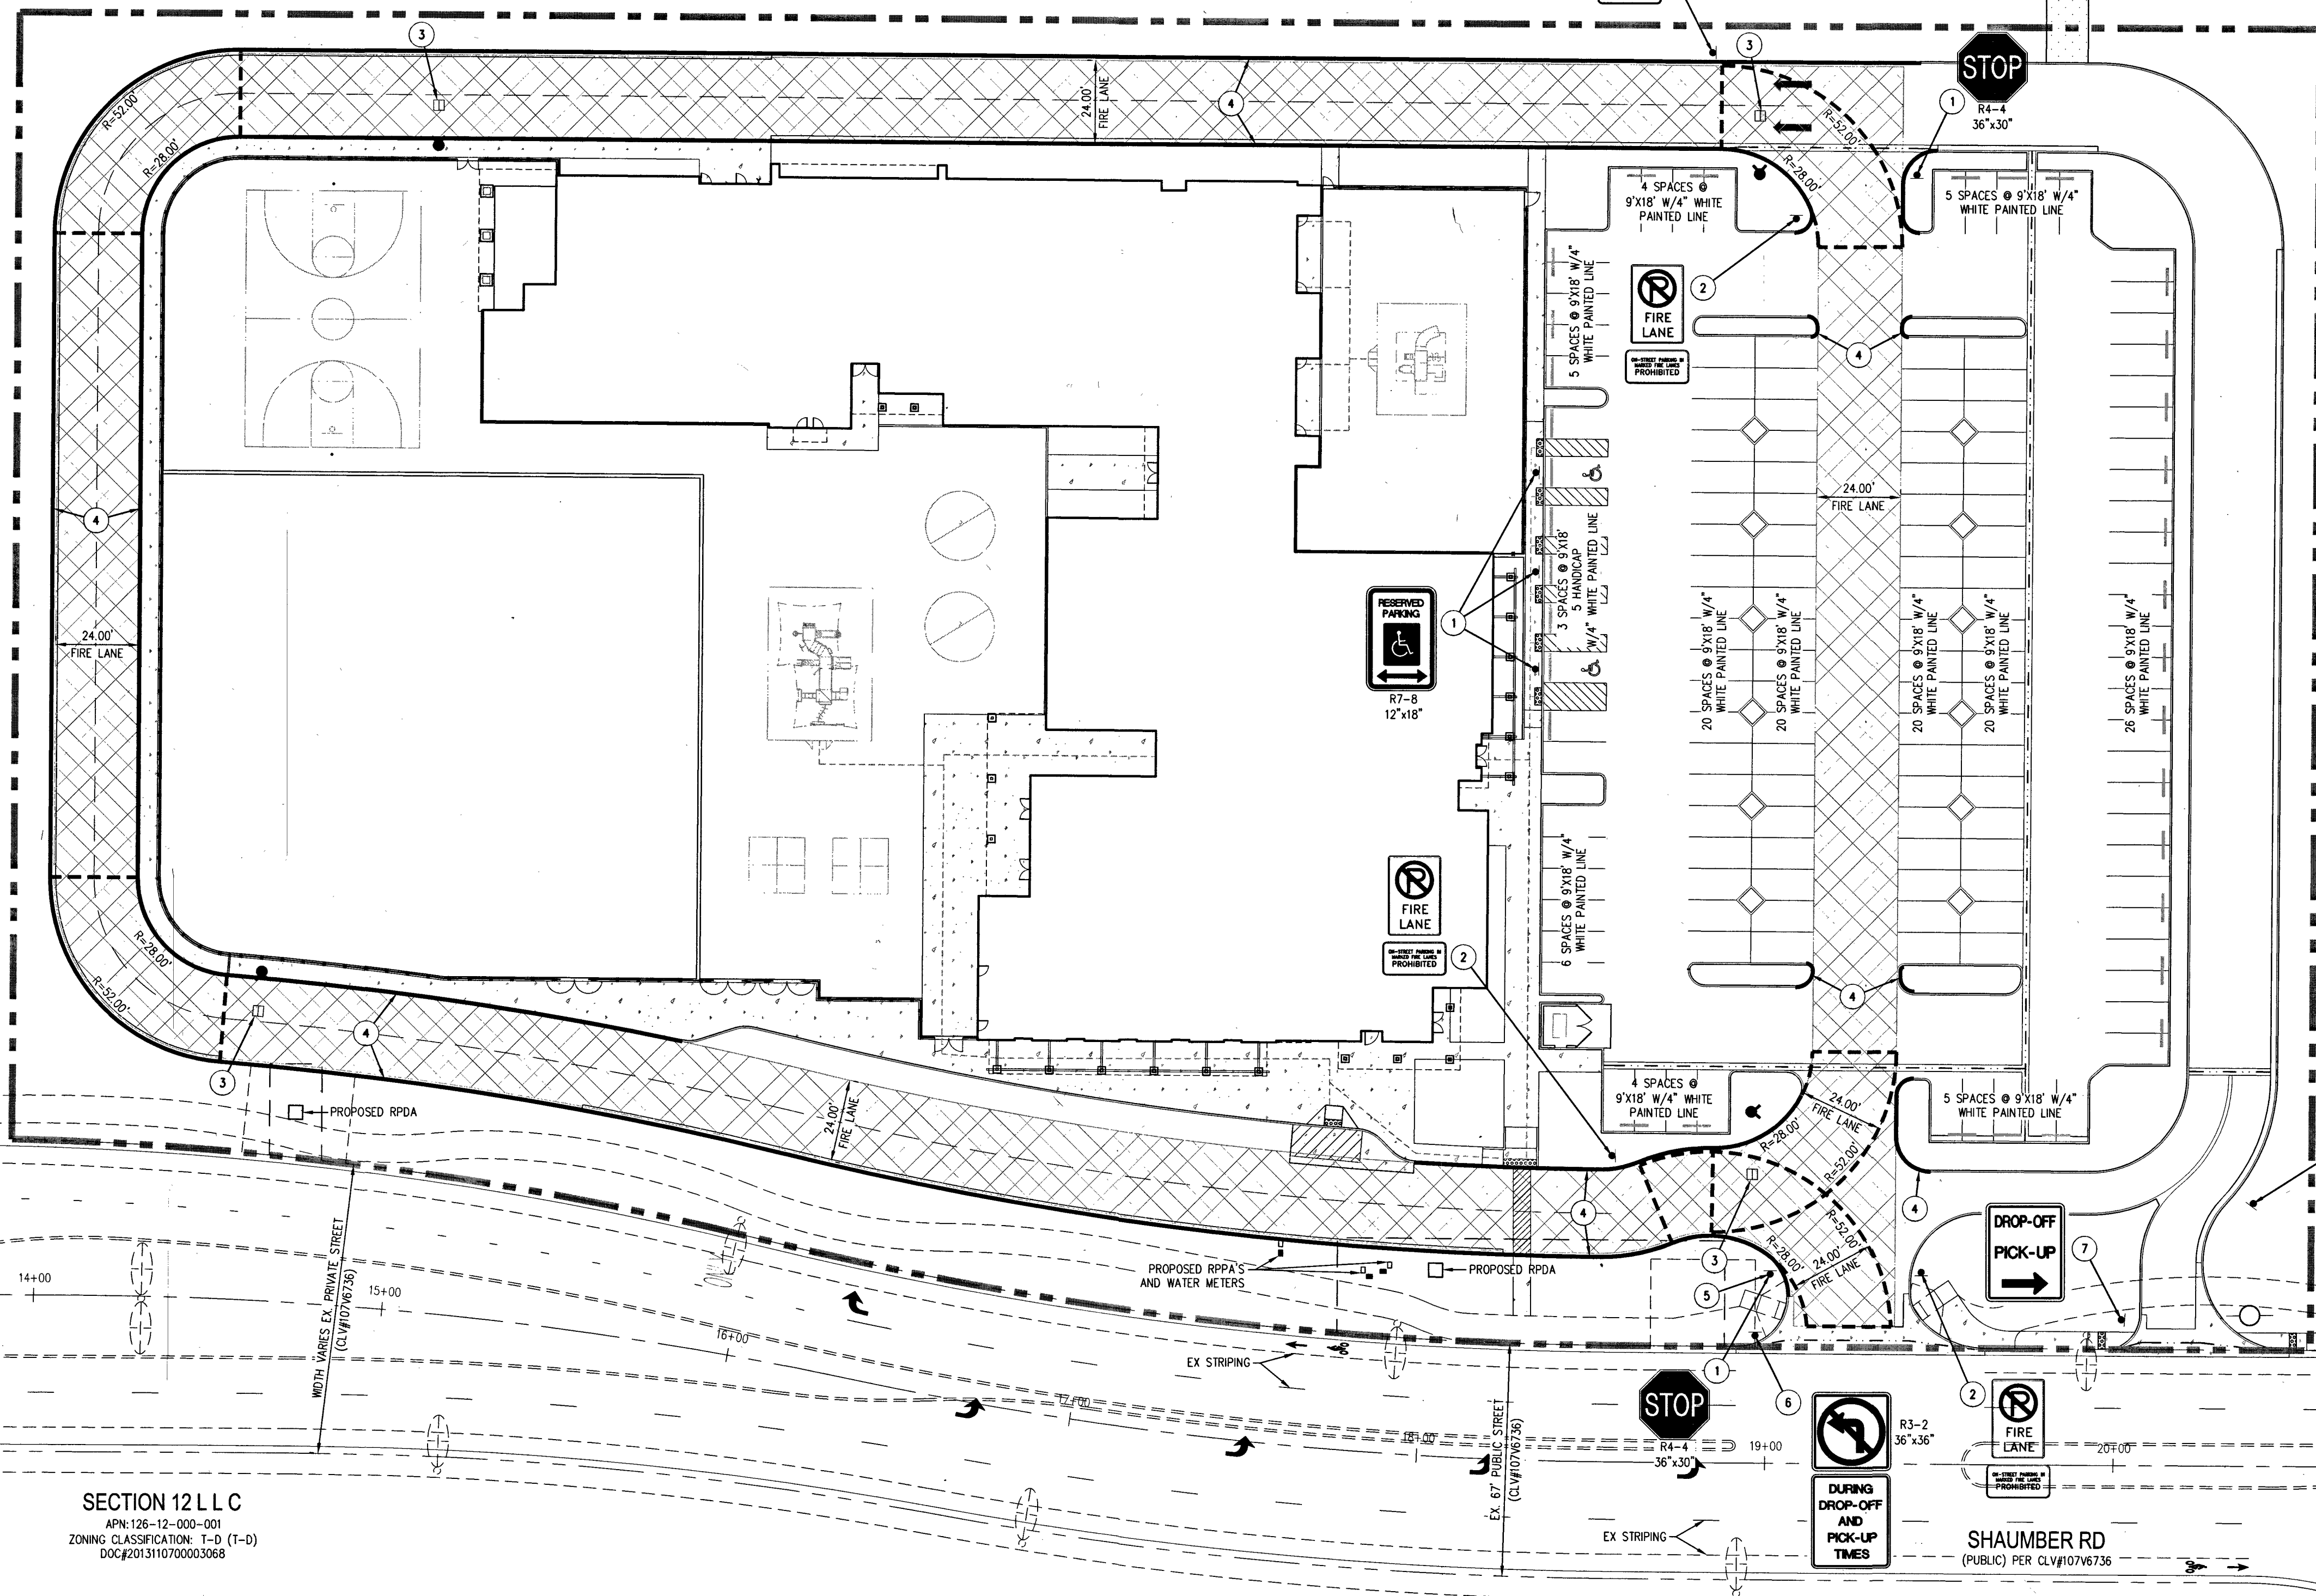

MATCHLINE: 13+50 SEE BELOW

MATCHLINE: 13+50 SEE ABOVE LEFT

MATCHLINE: 21+00 SEE ABOVE RIGHT

- 1 INSTALL NEW SIGN(S) (GROUND MOUNTED)
- 2 FIRE & RESCUE SIGNAGE AT ENTRY PER CLV ORDINANCE #6325
- 3 INSTALL FIRE HYDRANT MAKER PER CITY OF LAS VEGAS FIRE CODE
- 4 RED PAINTED CURB WITH "NO PARKING IN FIRE LANE" IN PAINTED WHITE LETTERS PER CLV ORDINANCE #6325
- 5 TWO 9" STREET NAME SIGNS (D-3, BROWN W WHITE LETTERS)
- 6 INSTALL "NO LEFT TURN SIGN" (R3-2) AND "DURING DROP-OFF AND PICK-UP TIMES" CUSTOM SIGN PER CUSTOM SIGN DETAIL 1 ON THIS SHEET
- 7 INSTALL CUSTOM "DROP-OFF AND PICK-UP" SIGN PER CUSTOM DETAIL 2 ON THIS SHEET

1. REPLACE ALL TRAFFIC CONTROL DEVICES (SIGNS AND/OR PAYMENT MARKINGS), UNDER CLARK COUNTY'S JURISDICTION, THAT ARE DISTURBED, DESTROYED, MOVED OR MODIFIED BY TRENCHING ACTIVITIES TO CLARK COUNTY'S SATISFACTION. ALL MATERIAL USED SHALL MEET CLARK COUNTY'S SPECIFICATIONS OR WILL BE AN APPROVED EQUIVALENT.
2. IN THE EVENT THAT THE TRAFFIC SIGNAL CONDUITS, LUGS, DETECTOR COILS OR ASSOCIATED EQUIPMENT ARE DAMAGED BY CONTRACTOR, THE CONTRACTOR WILL HIRE AN MSA LEVEL II ELECTRICAL CONTRACTOR TO MAKE REPAIRS PER UNIFORM SPECIFICATION NO. 623.6.01.02.
3. ALL SAWER/ STORM DRAIN CROSSING WATER LINES MUST STOP TO SECTION 2.22 OF THE UNIFORM DESIGN AND CONSTRUCTION STANDARDS FOR POTABLE WATER SYSTEMS (UDPCS) FOR WATER AND STORM MAIN CROSSINGS AND CLEARANCES.
4. THE CONTRACTOR IS TO VERIFY THE ACTUAL FIELD CONDITIONS OF ALL LOTS AND INSTALL SEWER CHECK VALVES AND MANHOLES AT THE LATEST EDITION OF THE UNIFORM PLUMBING CODE.
5. FITTINGS SHALL NOT FALL UNDER CURBS, GUTTERS OR SIDEWALK.

SPACES PROVIDED
A.D.A ACCESSIBLE PROVIDED

USDA BRASS CAP ON AN IRON PIPE, 140' SOUTHWEST C
TELEPHONE POLE #269941, SOUTHWEST CORNER OF THE
95/KYLE CANYON TURNOFF.

ELEVATION = 2817.62 FEET, 858.813 METERS
N.A.V.D. 88
PER THE CLARK COUNTY VERTICAL CONTROL LAST REVISED 200

THE BASIS OF BEARING IS SOUTH 00°22'12" WEST, BEING THE BEARING OF THE WEST LINE OF THE NORTHWEST QUARTER (NW1/4) OF SECTION 6, TOWNSHIP 19 SOUTH, RANGE 60 EAST, M.D.M., CITY OF LAS VEGAS, CLARK COUNTY, NEVADA, AS SHOWN BY MAP THEREOF IN FILE 151, PAGE 14 OF SURVEYS IN THE CLARK COUNTY RECORDER'S OFFICE, NEVADA.

R. J. Smith
LAS VEGAS FIRE AND RESCUE

FAST
Call before you
Underground
1-702-432-5300
FREWAY & ARTERIAL SYS
OF TRANSPORTATION (F.A.S.)

Call before you Dig
AVOID CUTTING UNDERGROUND
UTILITY LINES. IT'S COSTLY.
Call

OR
1-800-222-2600

[illegible]

ETHOS THREE ARCHITECTURE

SKYE CANYON SOMERSET ACADEMY

TRAFFIC PLAN

12
19S
59E

DATE: 11/01/17

DRAFTER: DNP

DESIGNER: BCC

CHECKED: STS

PROJECT NO.

ETA1601-000



T-1

SHEET: 15 OF 15

HANSEN NO. 68370

DWG NO. 713-140