
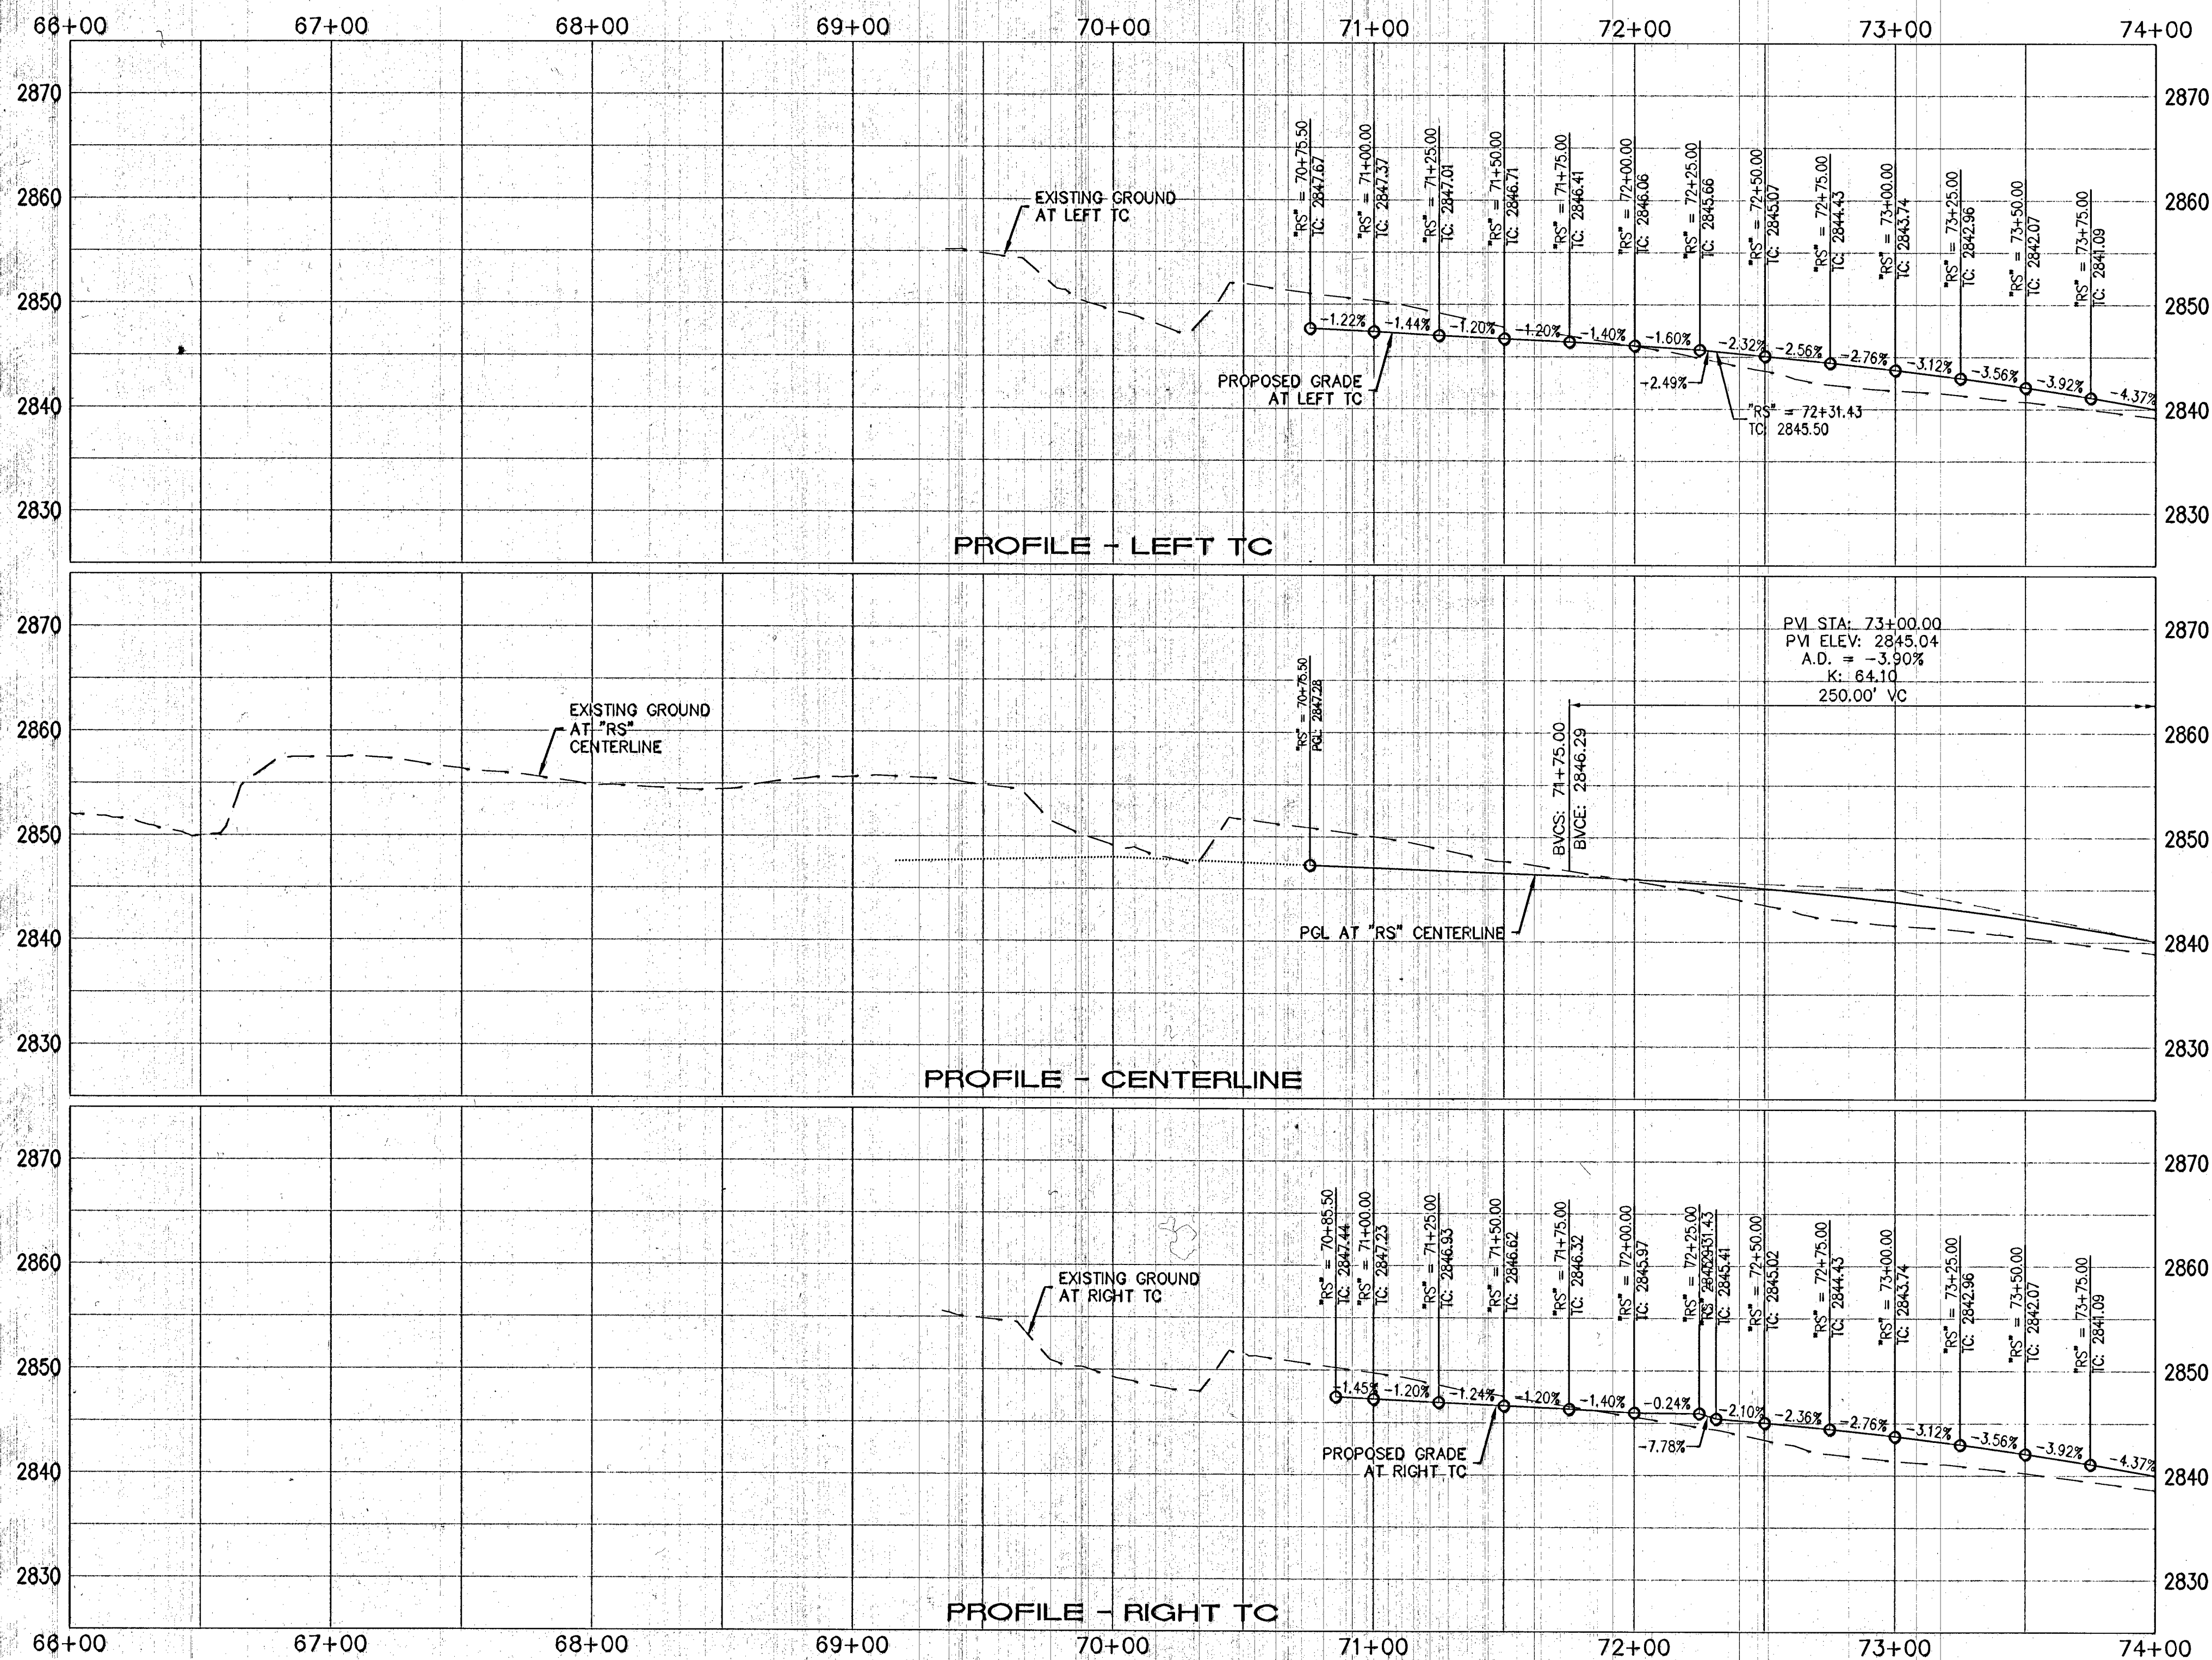


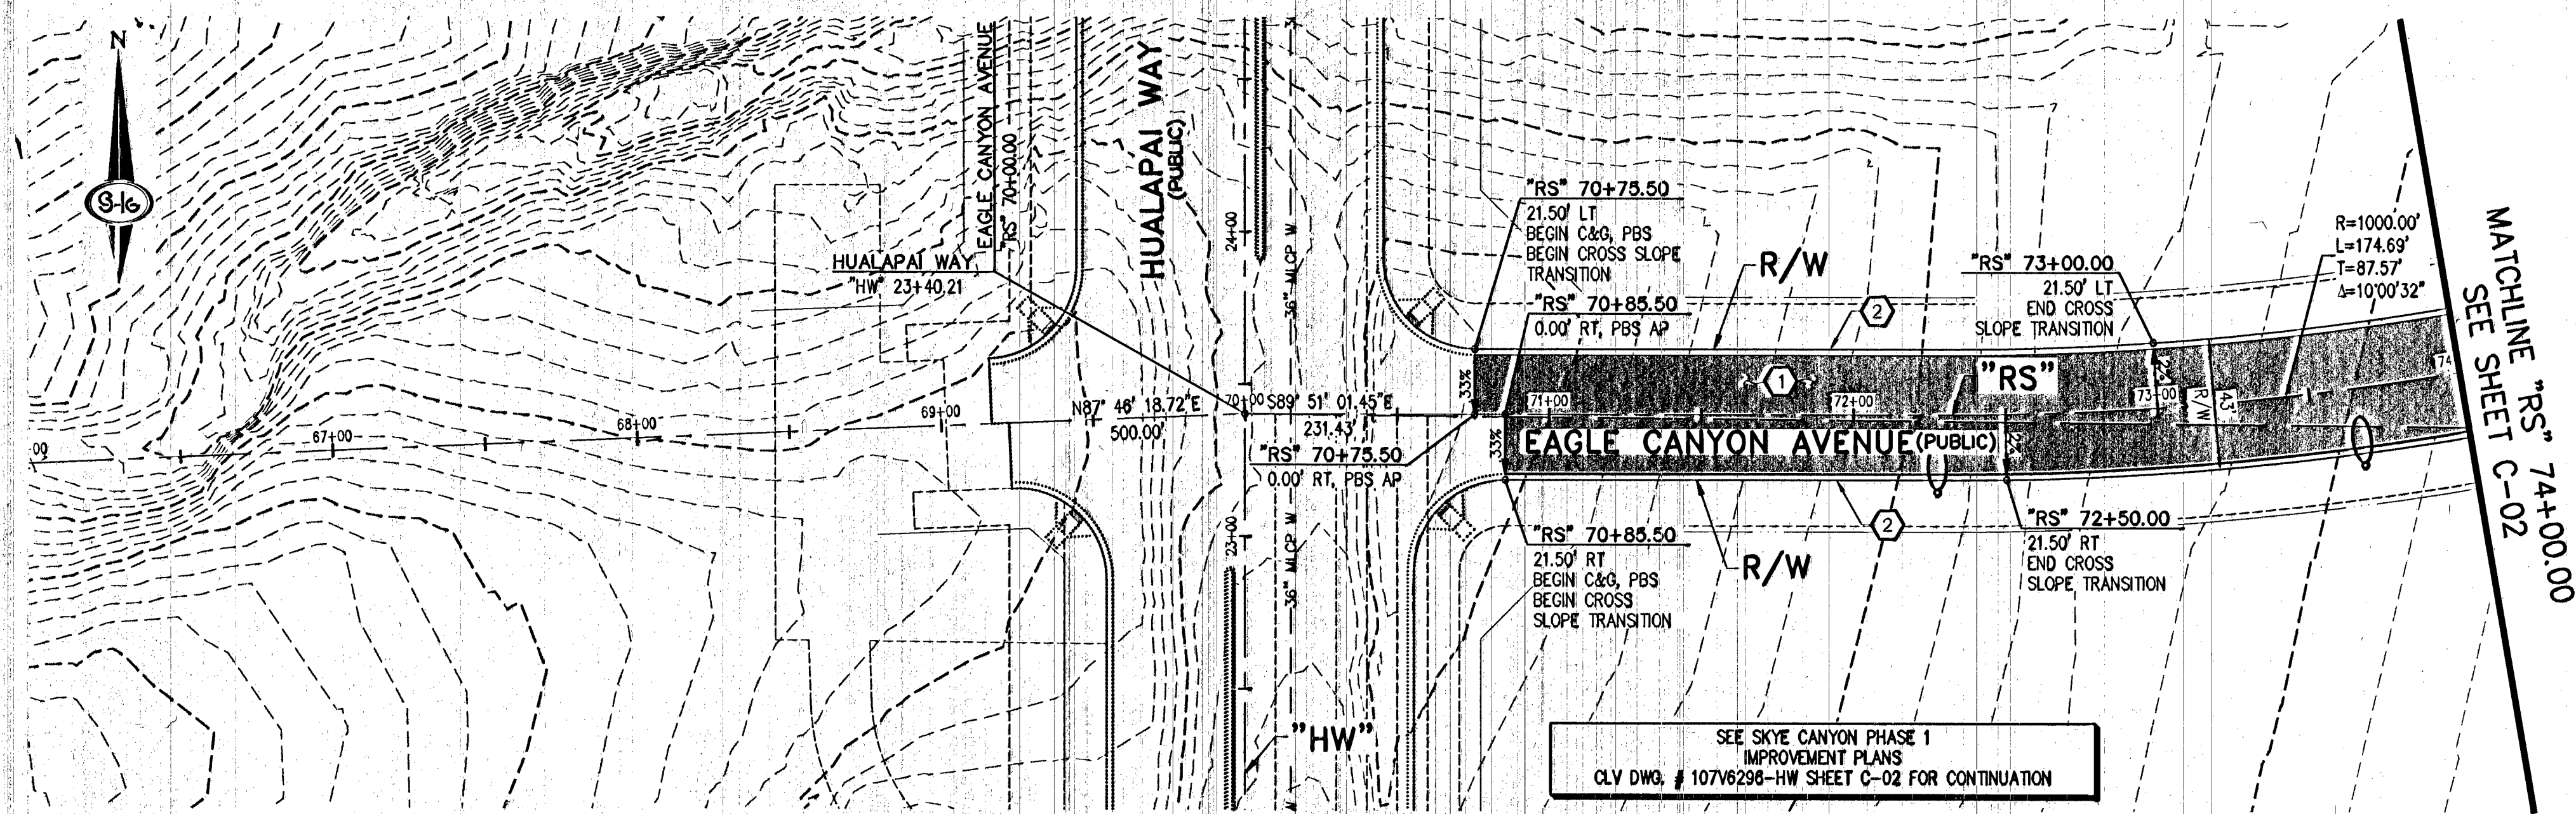

CONSTRUCTION NOTES

- CONSTRUCT 3" PBS OVER 4" TYPE II AGGREGATE BASE (SEE TY-SHEETS)
- CONSTRUCT "L" TYPE CURB AND GUTTER (USDCCA STD. DWG. NO. 216)
- CONSTRUCT CONCRETE CROSS GUTTER (USDCCA STD. DWG. NO. 228)
- CONSTRUCT SIDEWALK RAMP (CASE II) WITH TACTILE WARNING PANEL (USDCCA STD. DWG. NO. 235 AND DETAIL 1, SHEET C-08)

NOTES


- DIMENSIONS ARE TO BACK OF CURB, FACE OF CURB, OR FACE OF MEDIAN UNLESS OTHERWISE NOTED.
- SEE TY-SHEETS FOR TYPICAL SECTIONS.
- SEE SD-SHEETS FOR STORM DRAIN PLAN AND PROFILES.
- SEE UT-SHEETS FOR WATER AND SEWER PLAN AND PROFILES.
- SEE GR-SHEETS FOR OFFSITE GRADING.

LEGEND

3" PBS OVER 4" TYPE II AGGREGATE BASE

APPROVED FOR CONSTRUCTION

[Signature] 10/30/14
 LVWD ENGINEERING SERVICES MANAGER DATE
 PROJECT NO. 122933

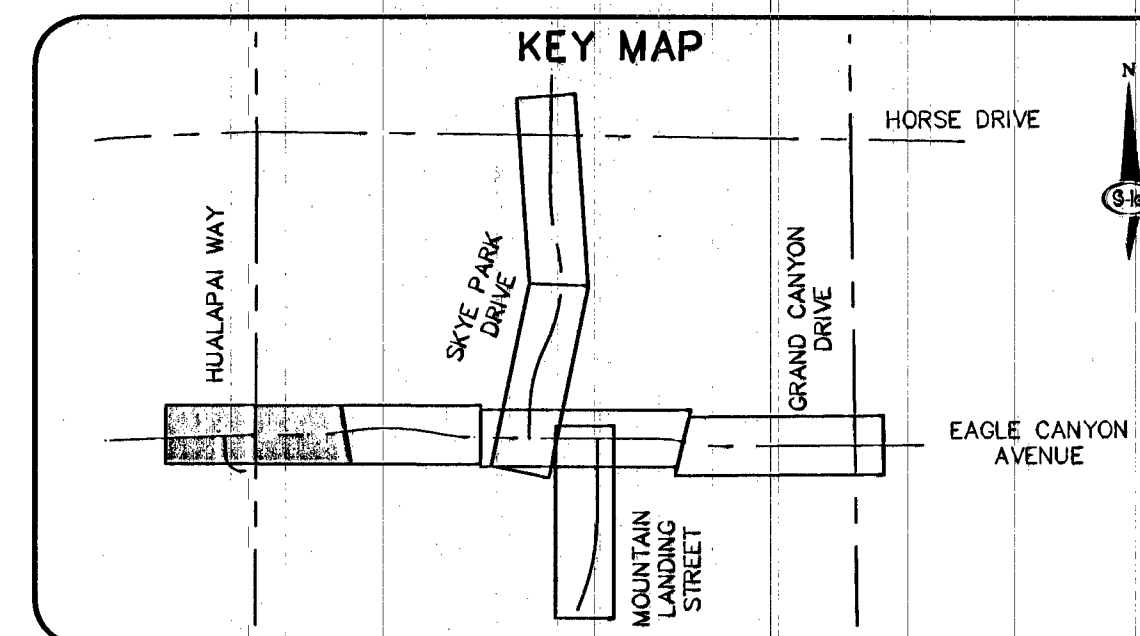

40 0 40 80
SCALE FEET

AVOID HITTING OVERHEAD POWER LINES. IF IN DOUBT, CALL BEFORE YOU DIG. 1-702-227-2929

FAST
Call before you dig. UnderGround. 1-702-432-5300

Call before you Dig. 1-800-227-2800

SLATER HANIFAN GROUP
 CONSULTING ENGINEERS & PLANNERS
 5740 S. ARVILLE STREET #216, LAS VEGAS, NV 89118
 PHONE (702) 284-5300 FAX (702) 284-5309

NINETY-FIVE MANAGEMENT LLC
SKYE CANYON PHASE 1
EAGLE CANYON AVENUE, SKYE PARK DRIVE & MOUNTAIN LANDING STREET
CONSTRUCTION PLAN - "RS" 66+00.00 TO "RS" 74+00.00

DATE: 9/17/14
 DRAFTER: SPC
 DESIGNER: DAM
 CHECKED: JSR
 PROJECT NO. OLY1401-001

C-01
 SHEET 5 OF 53
 DWG NO. 107V6296-PC
 HANSEN NO. 54673