


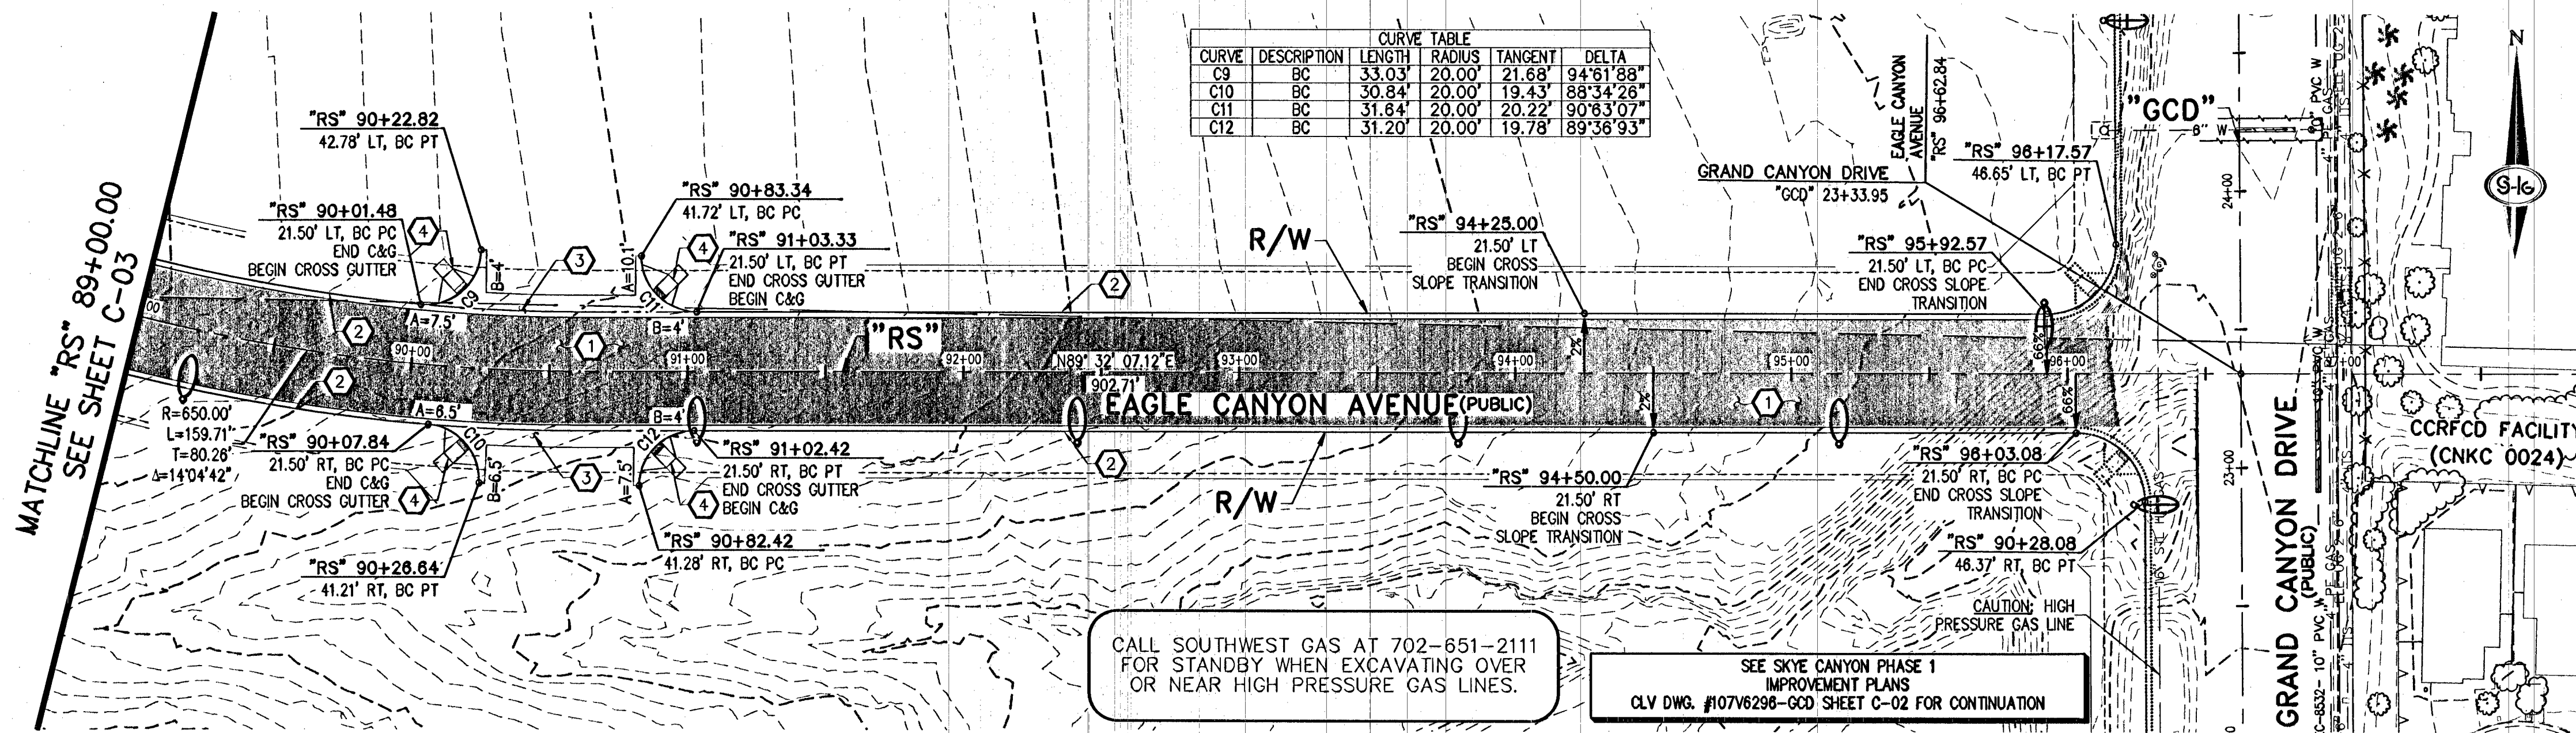

CALL SOUTHWEST GAS AT 702-651-2111 FOR STANDBY WHEN EXCAVATING OVER OR NEAR HIGH PRESSURE GAS LINES.

SEE SKYE CANYON PHASE 1 IMPROVEMENT PLANS
CLV DWG. #107V6296-GCD SHEET C-02 FOR CONTINUATION

CONSTRUCTION NOTES

- CONSTRUCT 3" PBS OVER 4" TYPE II AGGREGATE BASE (SEE TY-SHEETS)
- CONSTRUCT "L" TYPE CURB AND GUTTER (USDCCA STD. DWG. NO. 216)
- CONSTRUCT CONCRETE CROSS GUTTER (USDCCA STD. DWG. NO. 228)
- CONSTRUCT SIDEWALK RAMP (CASE II) WITH TACTILE WARNING PANEL (USDCCA STD. DWG. NO. 235 AND DETAIL 1, SHEET C-08)

NOTES

- DIMENSIONS ARE TO BACK OF CURB, FACE OF CURB, OR FACE OF MEDIAN UNLESS OTHERWISE NOTED.
- SEE TY-SHEETS FOR TYPICAL SECTIONS.
- SEE SD-SHEETS FOR STORM DRAIN PLAN AND PROFILES.
- SEE UT-SHEETS FOR WATER AND SEWER PLAN AND PROFILES.
- SEE GR-SHEETS FOR OFFSITE GRADING.



LEGEND

3" PBS OVER 4" TYPE II AGGREGATE BASE

APPROVED FOR CONSTRUCTION

Don Wade
LVMD ENGINEERING SERVICES MANAGER
PROJECT NO. 122933

10/30/14
DATE

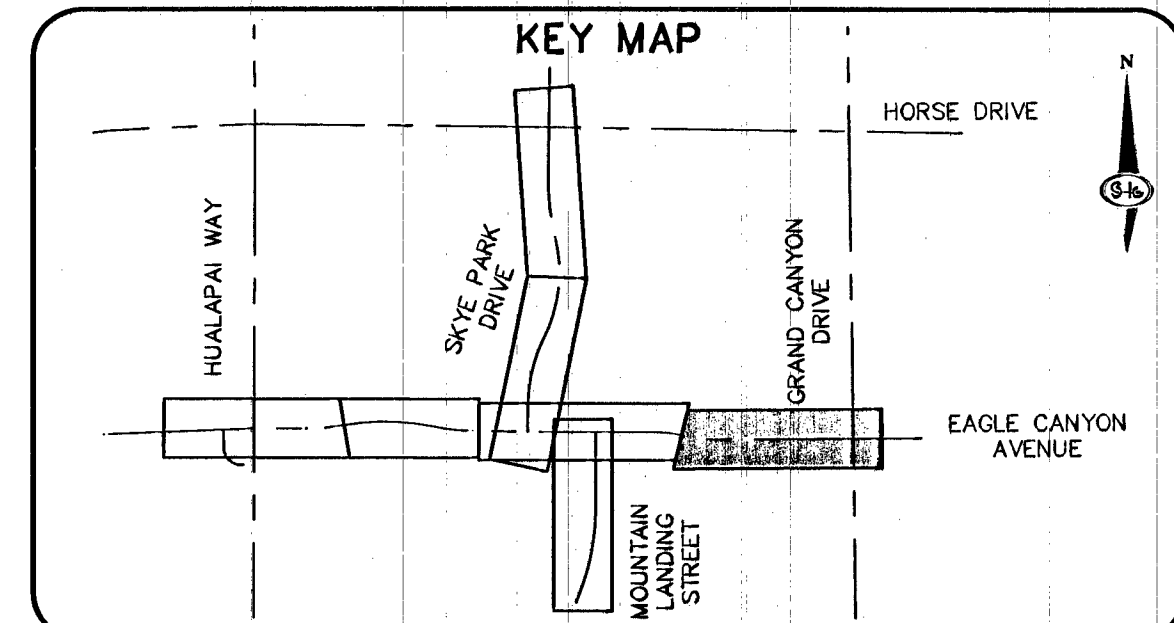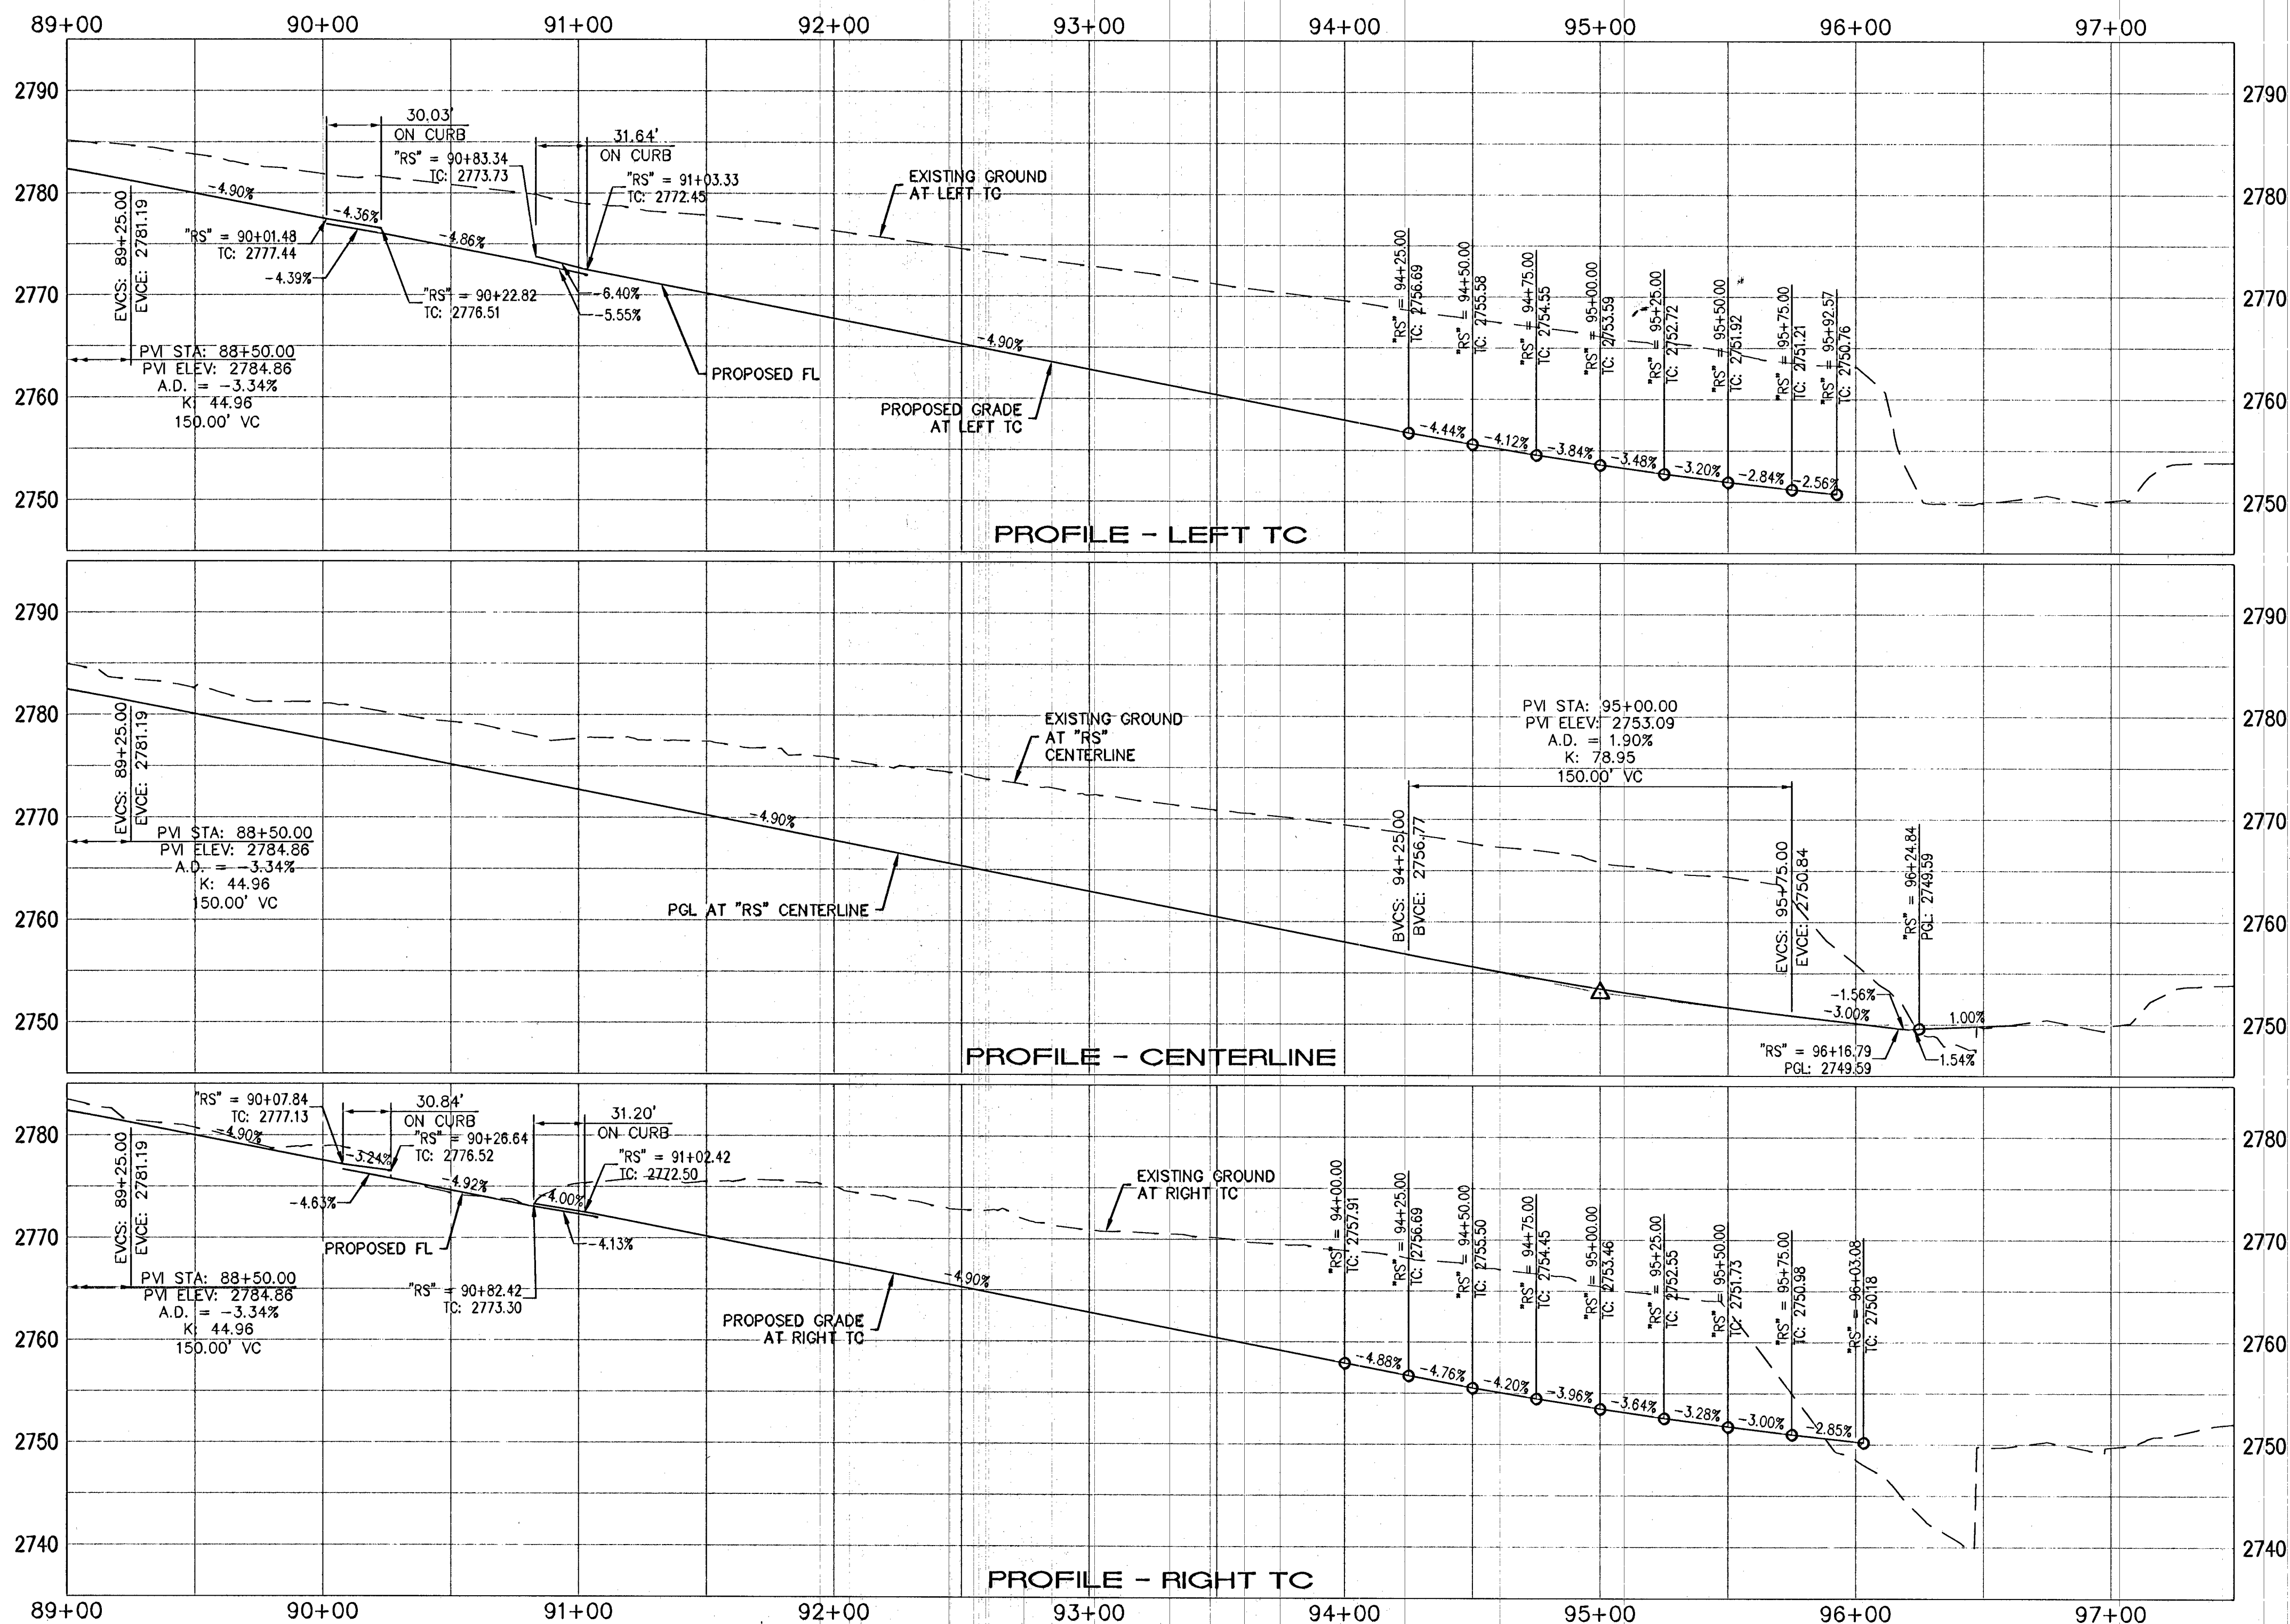

40 0 40 80
SCALE FEET

AVOID HITTING OVERHEAD POWER LINES WITH CRANE
CALL BEFORE YOU DO OVERHEAD

1-702-227-2929

FAST
Call before you dig
UnderGround.
1-702-432-5300
STREET AND UTILITY CONSTRUCTION

Call before you Dig
Call 811
1-800-227-3800

SLATER HANIFAN GROUP
CONSULTING ENGINEERS & PLANNERS
5740 S. ARVILLE STREET #216, LAS VEGAS, NV 89118
PHONE (702) 284-5390 FAX (702) 284-5399

NINETY-FIVE MANAGEMENT LLC
SKYE CANYON PHASE 1
EAGLE CANYON AVENUE, SKYE PARK DRIVE & MOUNTAIN LANDING STREET
CONSTRUCTION PLAN - "RS" 89+00.00 TO "RS" 97+00.00

DATE: 9/17/14
DRAFTER: SPC
DESIGNER: DAM
CHECKED: JSR
PROJECT NO.
OLY1401-001

C-04
SHEET 8 OF 53
DWG NO. 107V6296-PC
HANSEN NO. 54673