
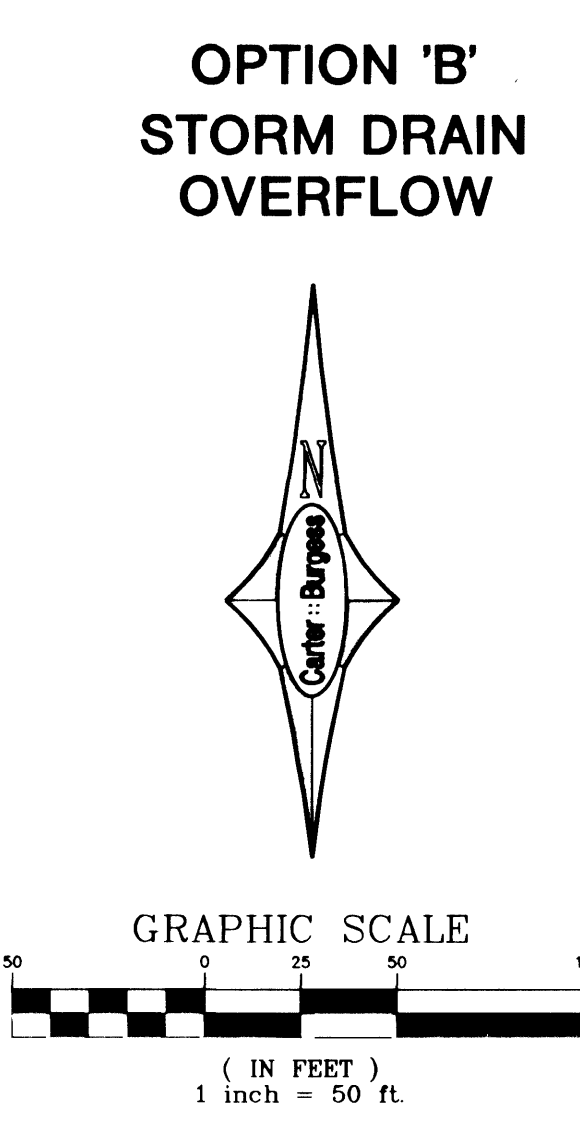
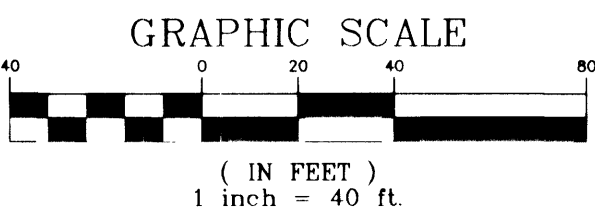
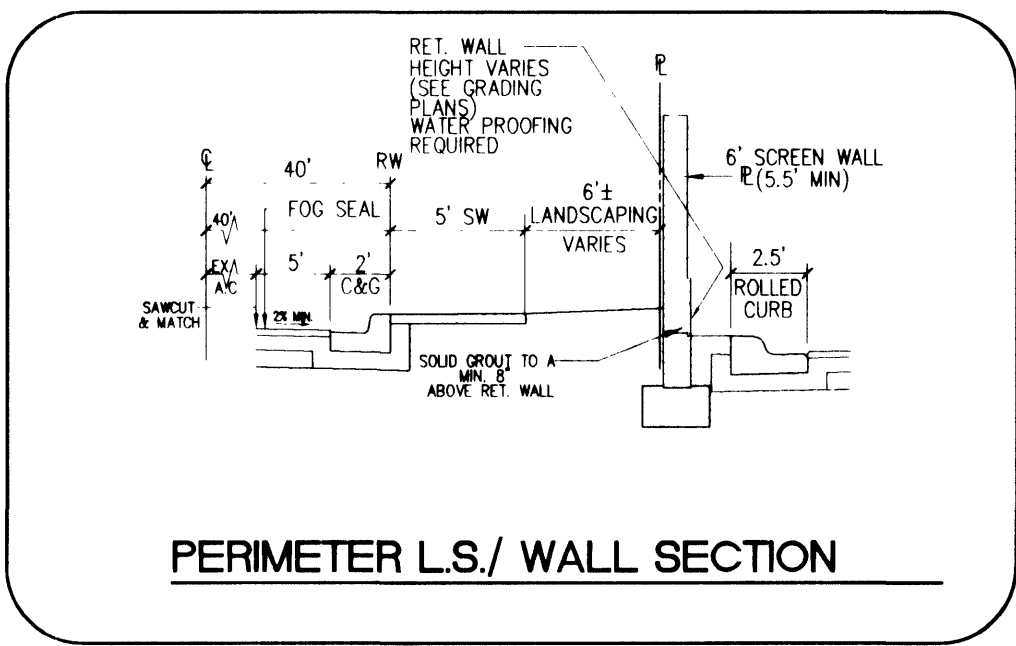


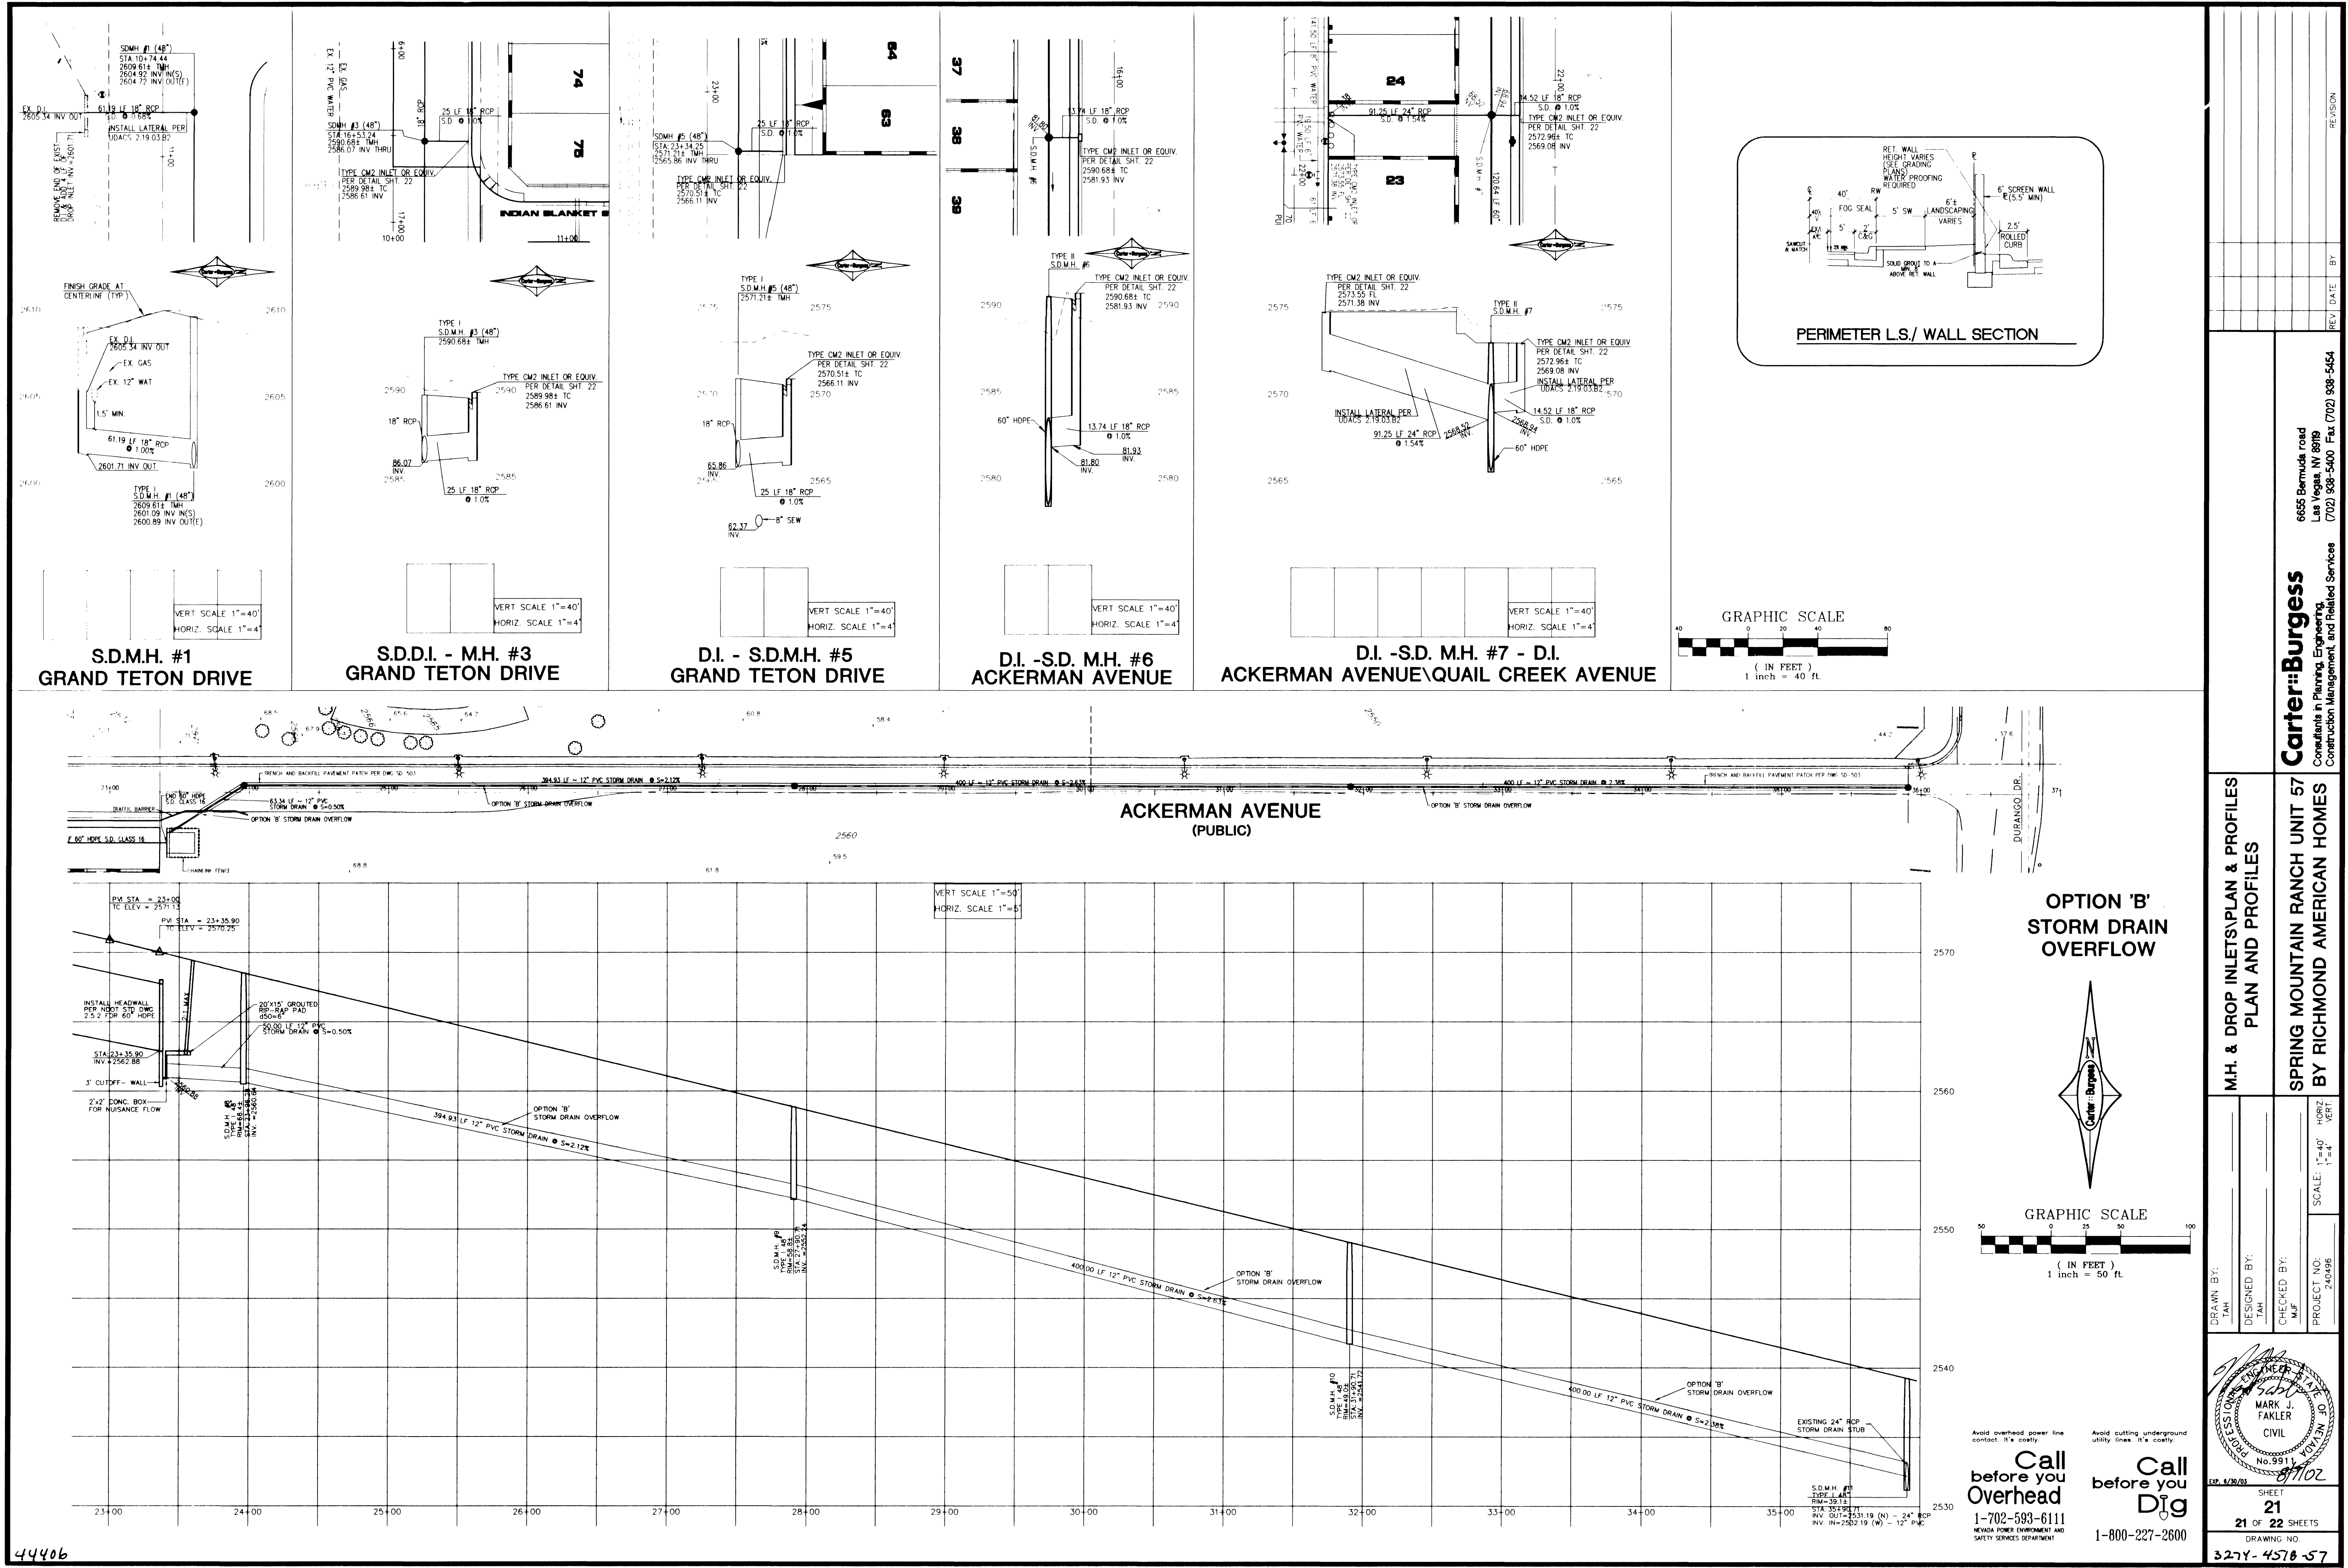

Call before you Overhead
1-702-593-6111
NEVADA POWER ENVIRONMENT AND SAFETY SERVICES DEPARTMENT

Call before you Dig
1-800-227-2600

6655 Bermuda Road Las Vegas, NV 89119 (702) 938-5400 Fax (702) 938-5454		Carter Burgess Consultants in Planning, Engineering, Construction Management, and Related Services		REV	DATE	BY
M.H. & DROP INLETS/PLAN & PROFILES		PLAN AND PROFILES				
DRAWN BY:		DESIGNED BY:		CHECKED BY:		
TAH		TAH		M.F.		
PROJECT NO:		SCALE:		SHEET		
240496		1"=40' HORIZ 1"=4' VERT		21 OF 22 SHEETS		
DRAWING NO:		3274-4578-57				