


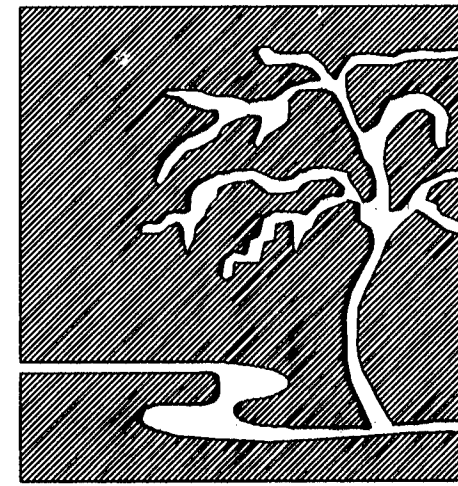

SPRINGS PRESERVE

CONTRACT NO. C1387

SPRINGS PRESERVE SOLAR HOUSE SITE INFRASTRUCTURE


APN: 139-31-602-003

309 SOUTH VALLEY VIEW BLVD.



LIST OF DRAWINGS

SHEET NO	DRAWING NO	DESCRIPTION
1	G1	COVER SHEET, LIST OF DRAWINGS, LOCATION MAP AND VICINITY MAP
2	G2	LVWD GENERAL NOTES, LEGEND
3	G3	CITY OF LAS VEGAS GENERAL NOTES I
4	G4	CITY OF LAS VEGAS GENERAL NOTES II
5	G5	ABBREVIATION LIST
6	SV1	HORIZONTAL CONTROL
7	D1	DEMOLITION PLAN
8	C1	SITE AND GRADING PLAN
9	C2	SITE YARD PIPING PLAN
10	CD1	SITE WORK DETAILS I
11	CD2	SITE WORK DETAILS II
12	CD3	SITE WORK DETAILS III
13	E1	ELECTRICAL ABBREVIATIONS, SYMBOLS, LEGEND AND GENERAL NOTES
14	E2	SINGLE LINE DIAGRAM
15	E3	SITE POWER PLAN
16	E4	SOLAR HOUSE AREA PLAN
17	ED1	ELECTRICAL DETAILS I
18	ED2	ELECTRICAL DETAILS II

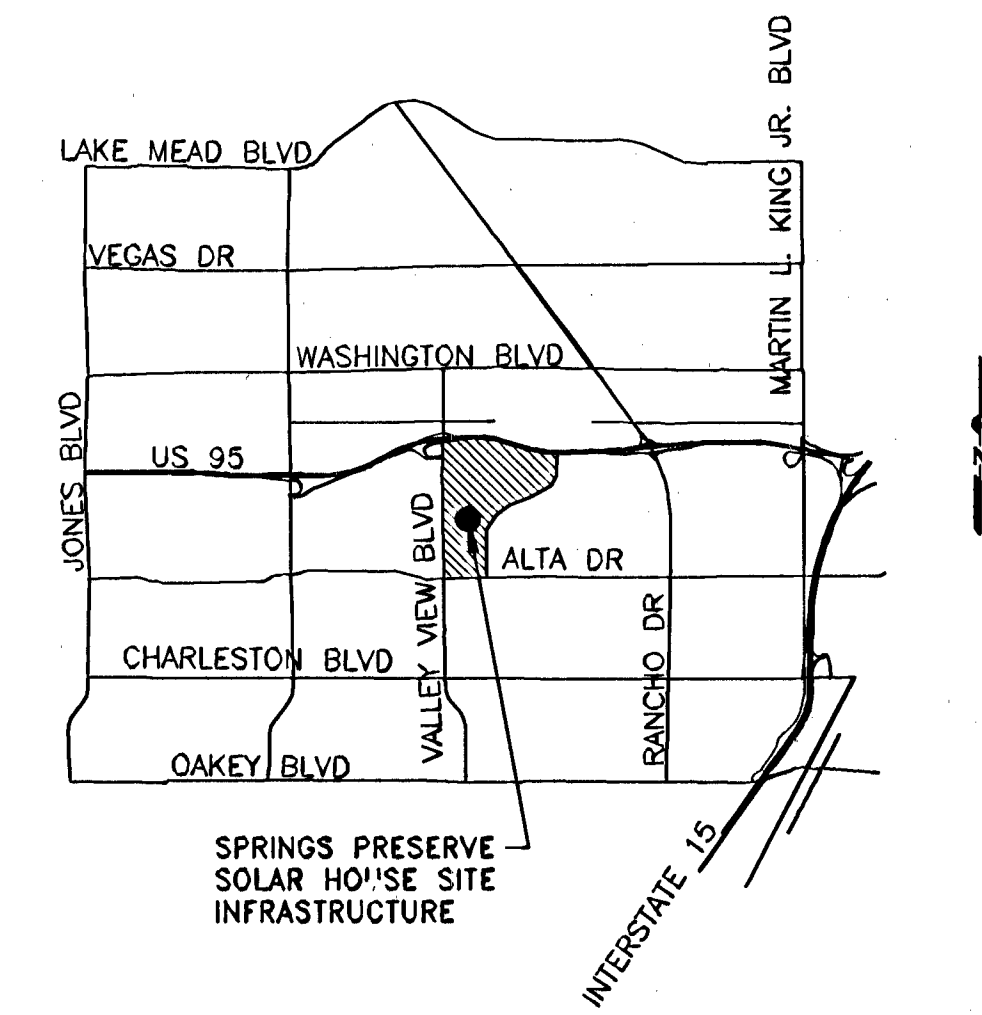

VICINITY MAP
NOT TO SCALE

LOCATION MAP
NOT TO SCALE

CAUTION TO CONTRACTOR:

THE CONTRACTOR SHALL BE RESPONSIBLE TO INVESTIGATE AND VERIFY THE ACTUAL LOCATION AND DEPTH OF ALL EXISTING UNDERGROUND FACILITIES AT LEAST 48 HOURS IN ADVANCE OF THE PERFORMANCE OF ANY WORK.

PROJECT BENCHMARK

DESCRIPTION:
CITY OF LAS VEGAS BENCHMARK - RIVET AND PLATE IN TOP OF CURB E SIDE TWIN LAKES DR. @ BONANZA RD.

ELEVATION:
648.869 METERS, 2,128.83 FEET (NAVD'88)

SOURCE:
BENCHMARK STATION 2LV01 29SWW6, "CITY OF LAS VEGAS VERTICAL CONTROL V.2008 ADJUSTMENT (UPDATE 5/24/2010)"

LOCATION:
T.20S R.61E S.29


BASIS OF BEARING

THE BASIS OF BEARINGS FOR THIS SURVEY IS NORTH 89°40'18" WEST BEING THE SOUTH LINE OF THE SOUTHEAST QUARTER OF THE NORTHEAST QUARTER OF SECTION 31 TOWNSHIP 20 SOUTH RANGE 61 EAST M.D.M.


ACCEPTED BY:

Shawn P. Mollus, PE, DIRECTOR OF LVWD ENGINEERING
DATE 12-18-13

CLV PERMIT SET ONLY

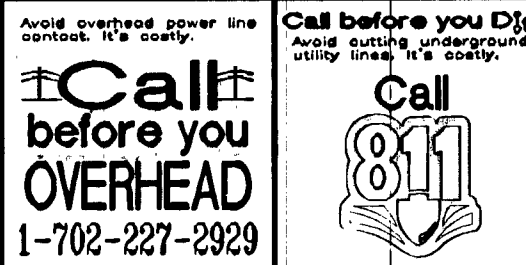

LAS VEGAS VALLEY
WATER DISTRICT
1001 S. VALLEY VIEW BOULEVARD
LAS VEGAS, NEVADA 89153
(702) 870-2011

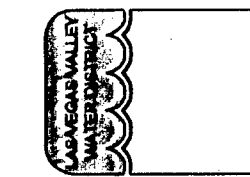


VERIFY SCALE
1/2" = 0' 1/2" = 1'
BAR REPRESENTS ONE AND ONE-HALF INCHES ON ORIGINAL

SPRINGS PRESERVE SOLAR HOUSE
SITE INFRASTRUCTURE

COVER SHEET, LIST OF DRAWINGS,
LOCATION MAP AND VICINITY MAP

SCALE
N.T.S.

DRAWN BY: TUAN M. NGUYEN
CHECKED BY: CHRISTOPHER M. LUQUETTE
RECOMMENDED BY: JOSEPH Y. LIN
ACCEPTED BY: PETER J. JAUCH
DATE 12-18-13

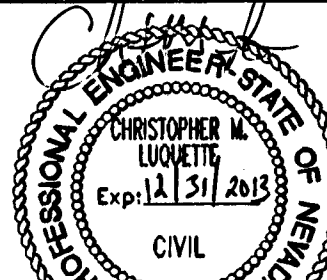

CONTRACT NUMBER
C1387

DRAWING NUMBER G1
SHEET 1 OF 18

H# 52213

CLV DWG # 565-495