


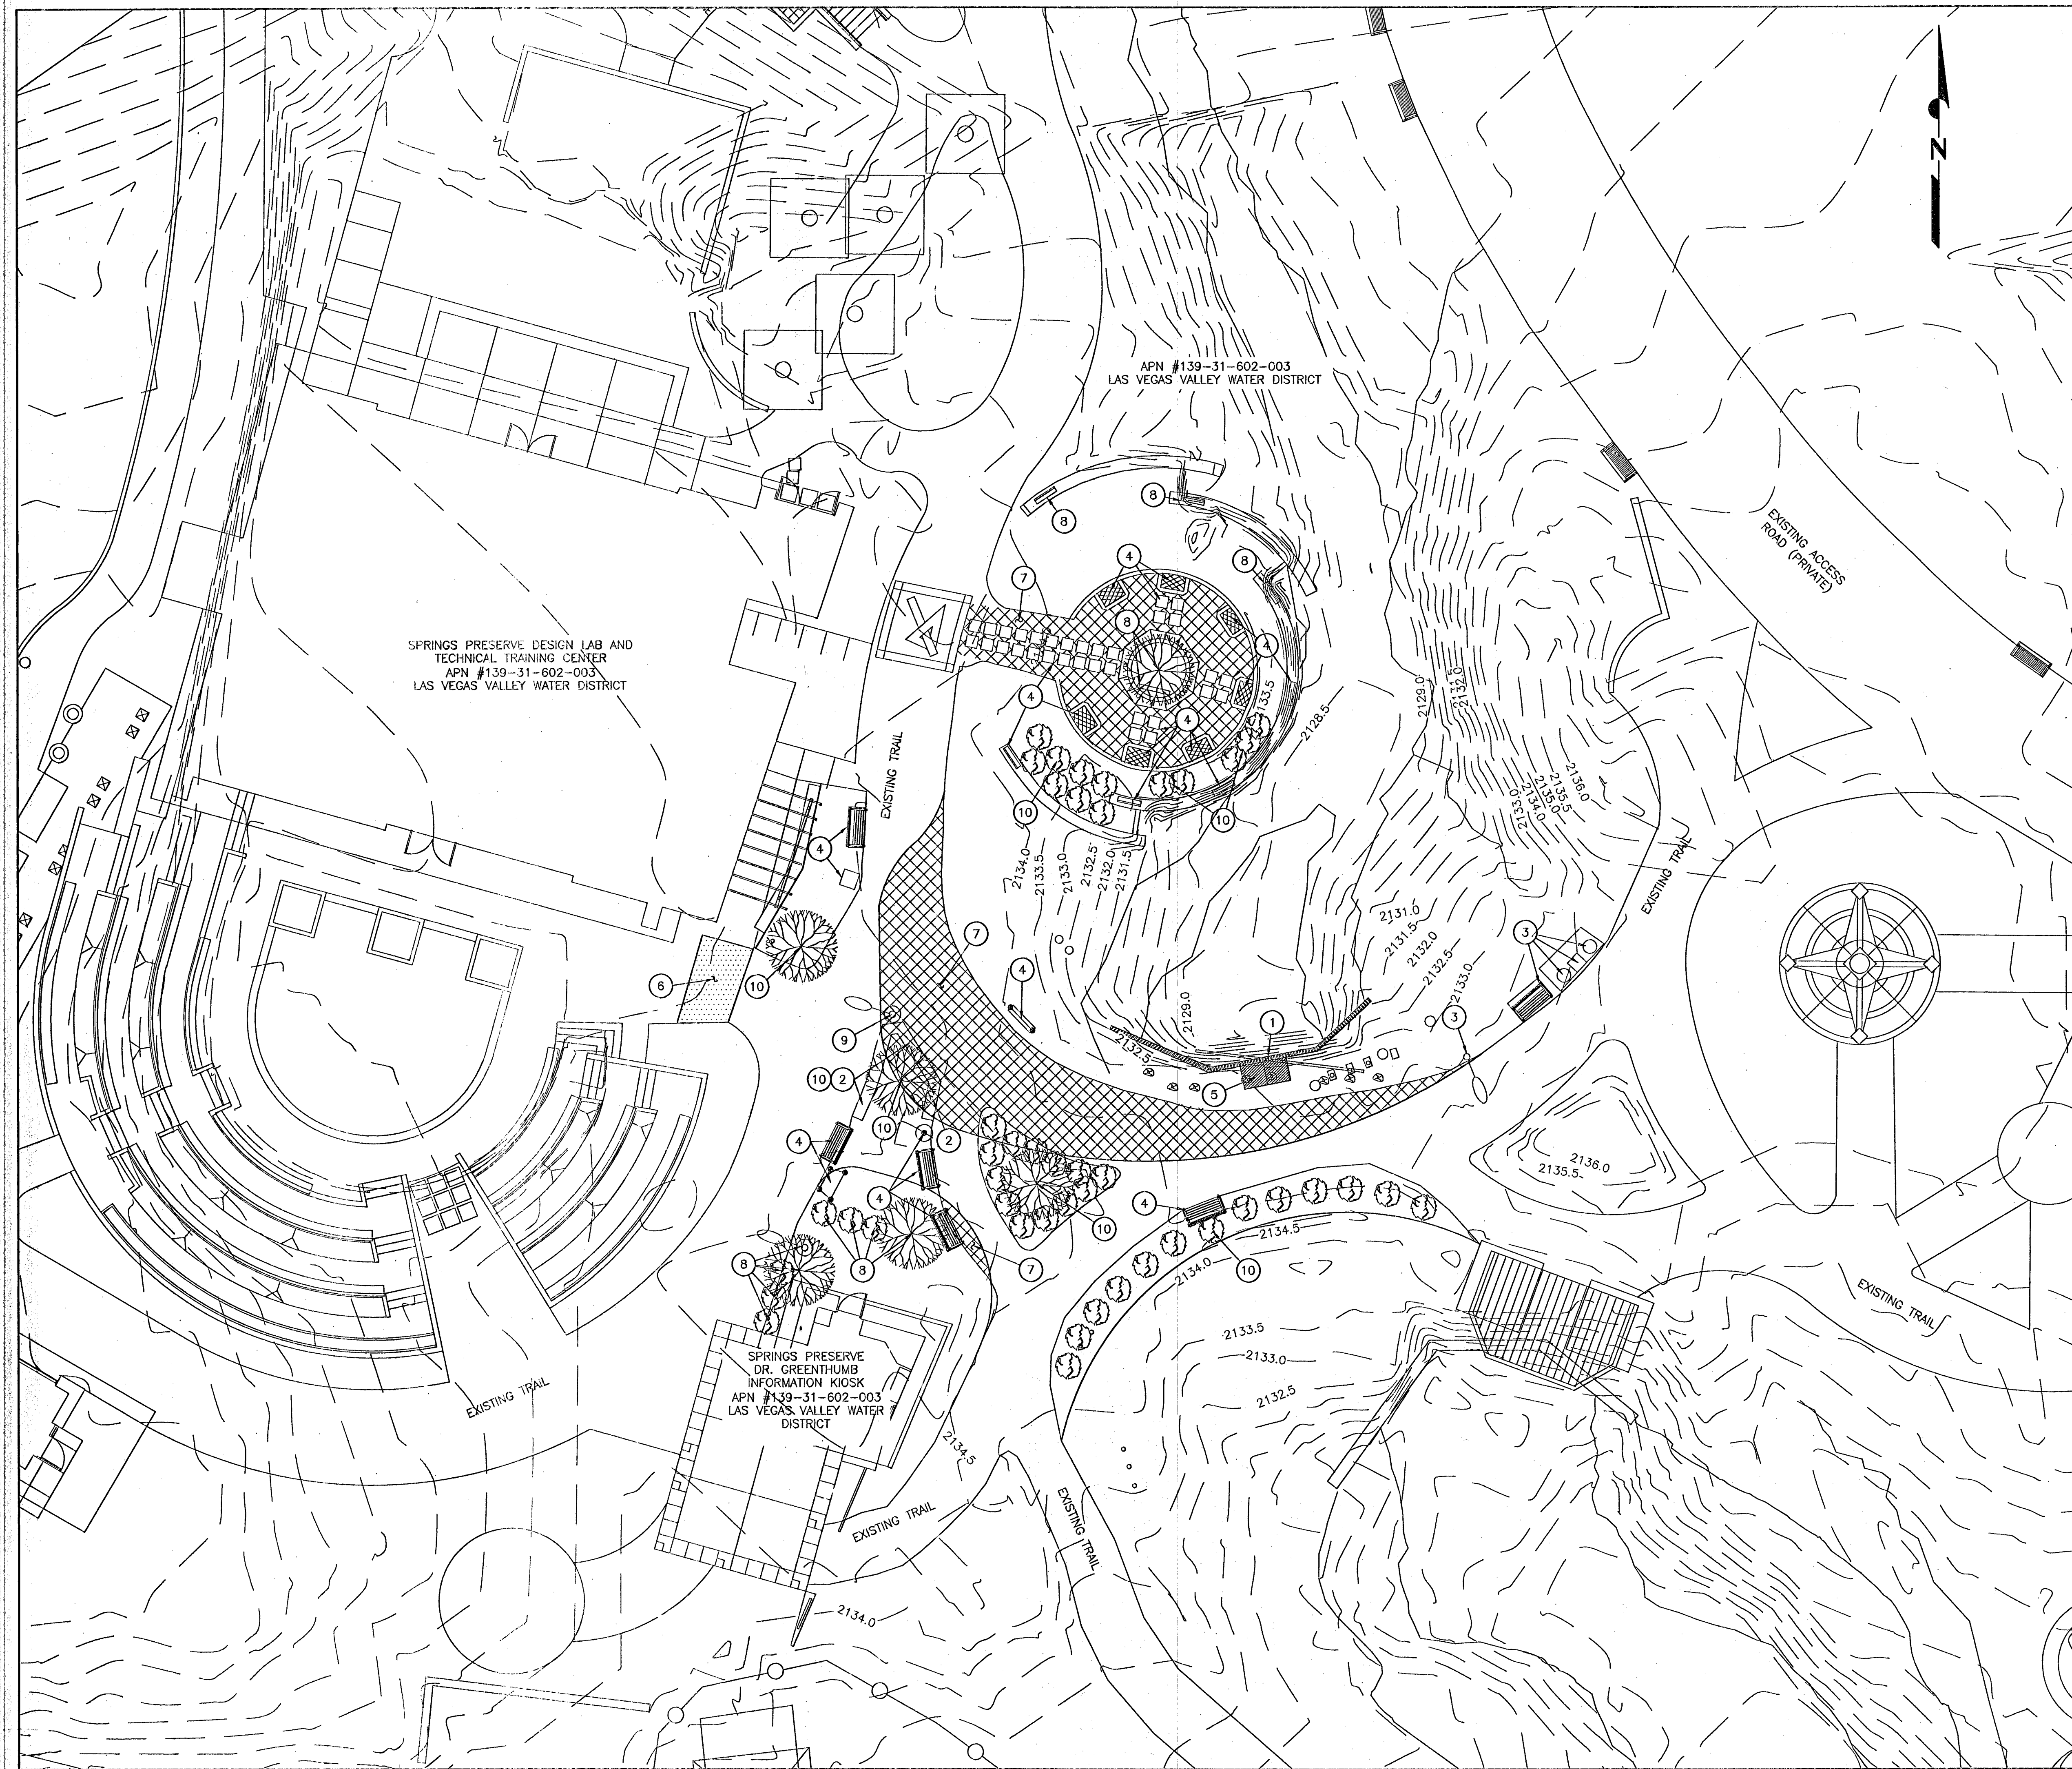


NOTES:

1. FOR YARD PIPING PLAN, SEE DWG. C2.
2. FOR HORIZONTAL CONTROL PLAN AND SITE BENCH MARK, SEE DWG. SV1.
3. ALL LANDSCAPING & IRRIGATION TO BE REMOVED BY LVSP PERSONNEL PRIOR TO CONTRACTOR PERFORMING ANY WORK IN THE PROJECT AREA.
4. ALL SIGNAGE TO BE REMOVED BY LVSP PERSONNEL PRIOR TO CONTRACTOR PERFORMING ANY WORK IN THE PROJECT AREA.
5. ALL LOW-VOLTAGE LIGHTING TO BE REMOVED BY LVSP PERSONNEL PRIOR TO CONTRACTOR PERFORMING ANY WORK IN THE PROJECT AREA.
6. ALL ONSITE STORM DRAINS AND THE ASSOCIATED FACILITIES ARE PRIVATELY MAINTAINED BY THE LAS VEGAS VALLEY WATER DISTRICT.

DEMOLITION NOTES

- 1 SAWCUT & REMOVE EXISTING RETAINING WALL AND HANDRAIL TO ELEV 2132.00 (MAX)
- 2 REMOVE AND DISPOSE OF CONCRETE WALL & DECORATIVE ROCK.
- 3 EXISTING BENCH, GARBAGE CANS, LIGHT POLE TO BE REMOVED AS NECESSARY AND REPLACED WITH EXISTING TO FACILITATE CONSTRUCTION.
- 4 EXISTING SIGNS, BENCHES, STEPPING STONES & MIRRORS TO BE REMOVED & RETURNED TO OWNER.
- 5 CAP EXISTING CULVERTS WITH 3/4" PLYWOOD THEN FILL WITH FLOWABLE FILL (2 x 36" x 36" LONG).
- 6 SAWCUT AT EXPANSION JOINT & REMOVE EXIST. 4" CONCRETE.
- 7 EXISTING 3" THICK DECOMPOSED GRANITE PATH TO BE REMOVED AND RETURNED TO OWNER. USE EXISTING DECOMPOSED GRANITE FOR NEW TRAIL INSTALLATIONS AS SHOWN ON GRADING PLAN.
- 8 PROTECT IN PLACE (TYP)
- 9 PROTECT IN PLACE OR REMOVE & REPLACE AS NECESSARY TO FACILITATE CONSTRUCTION.
- 10 COORDINATE WITH SPRINGS PRESERVE STAFF WITH THE REMOVAL OF EXISTING TREES AND SHRUBS.

LAS VEGAS VALLEY
WATER DISTRICT
1001 S. VALLEY VIEW BOULEVARD
LAS VEGAS, NEVADA 89153
(702) 870-3011

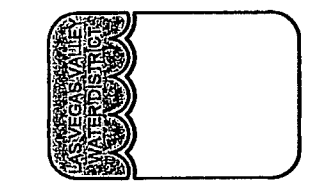

VERIFY SCALE

1/2 0 1/2

BAR REPRESENTS
ONE AND ONE-HALF
INCHES ON ORIGINAL

SPRINGS PRESERVE SOLAR HOUSE
SITE INFRASTRUCTURE

DEMOLITION PLAN

SCALE
1" = 10'



DRAWN BY: NGUYEN
TUNAN P.

CHECKED BY: CHRISTOPHER M. LUQUETTE

RECOMMENDED BY: JOSEPH Y. LIN
ACCEPTED BY: PETER J. JAUCH

DATE: 11/18/03

DATE: 12/03/03

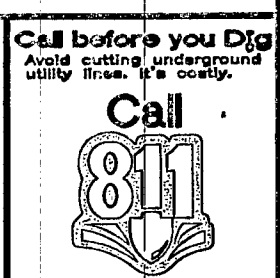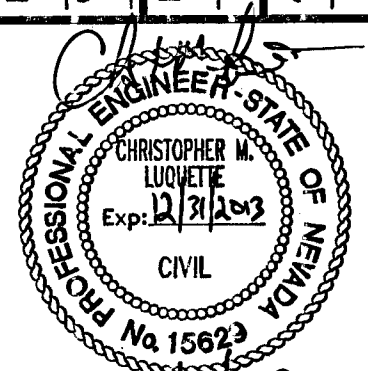

CONTRACT NUMBER

C1387

DRAWING NUMBER D1
SHEET 7 OF 18

H# 52013

CLV DWG # 565- 485