


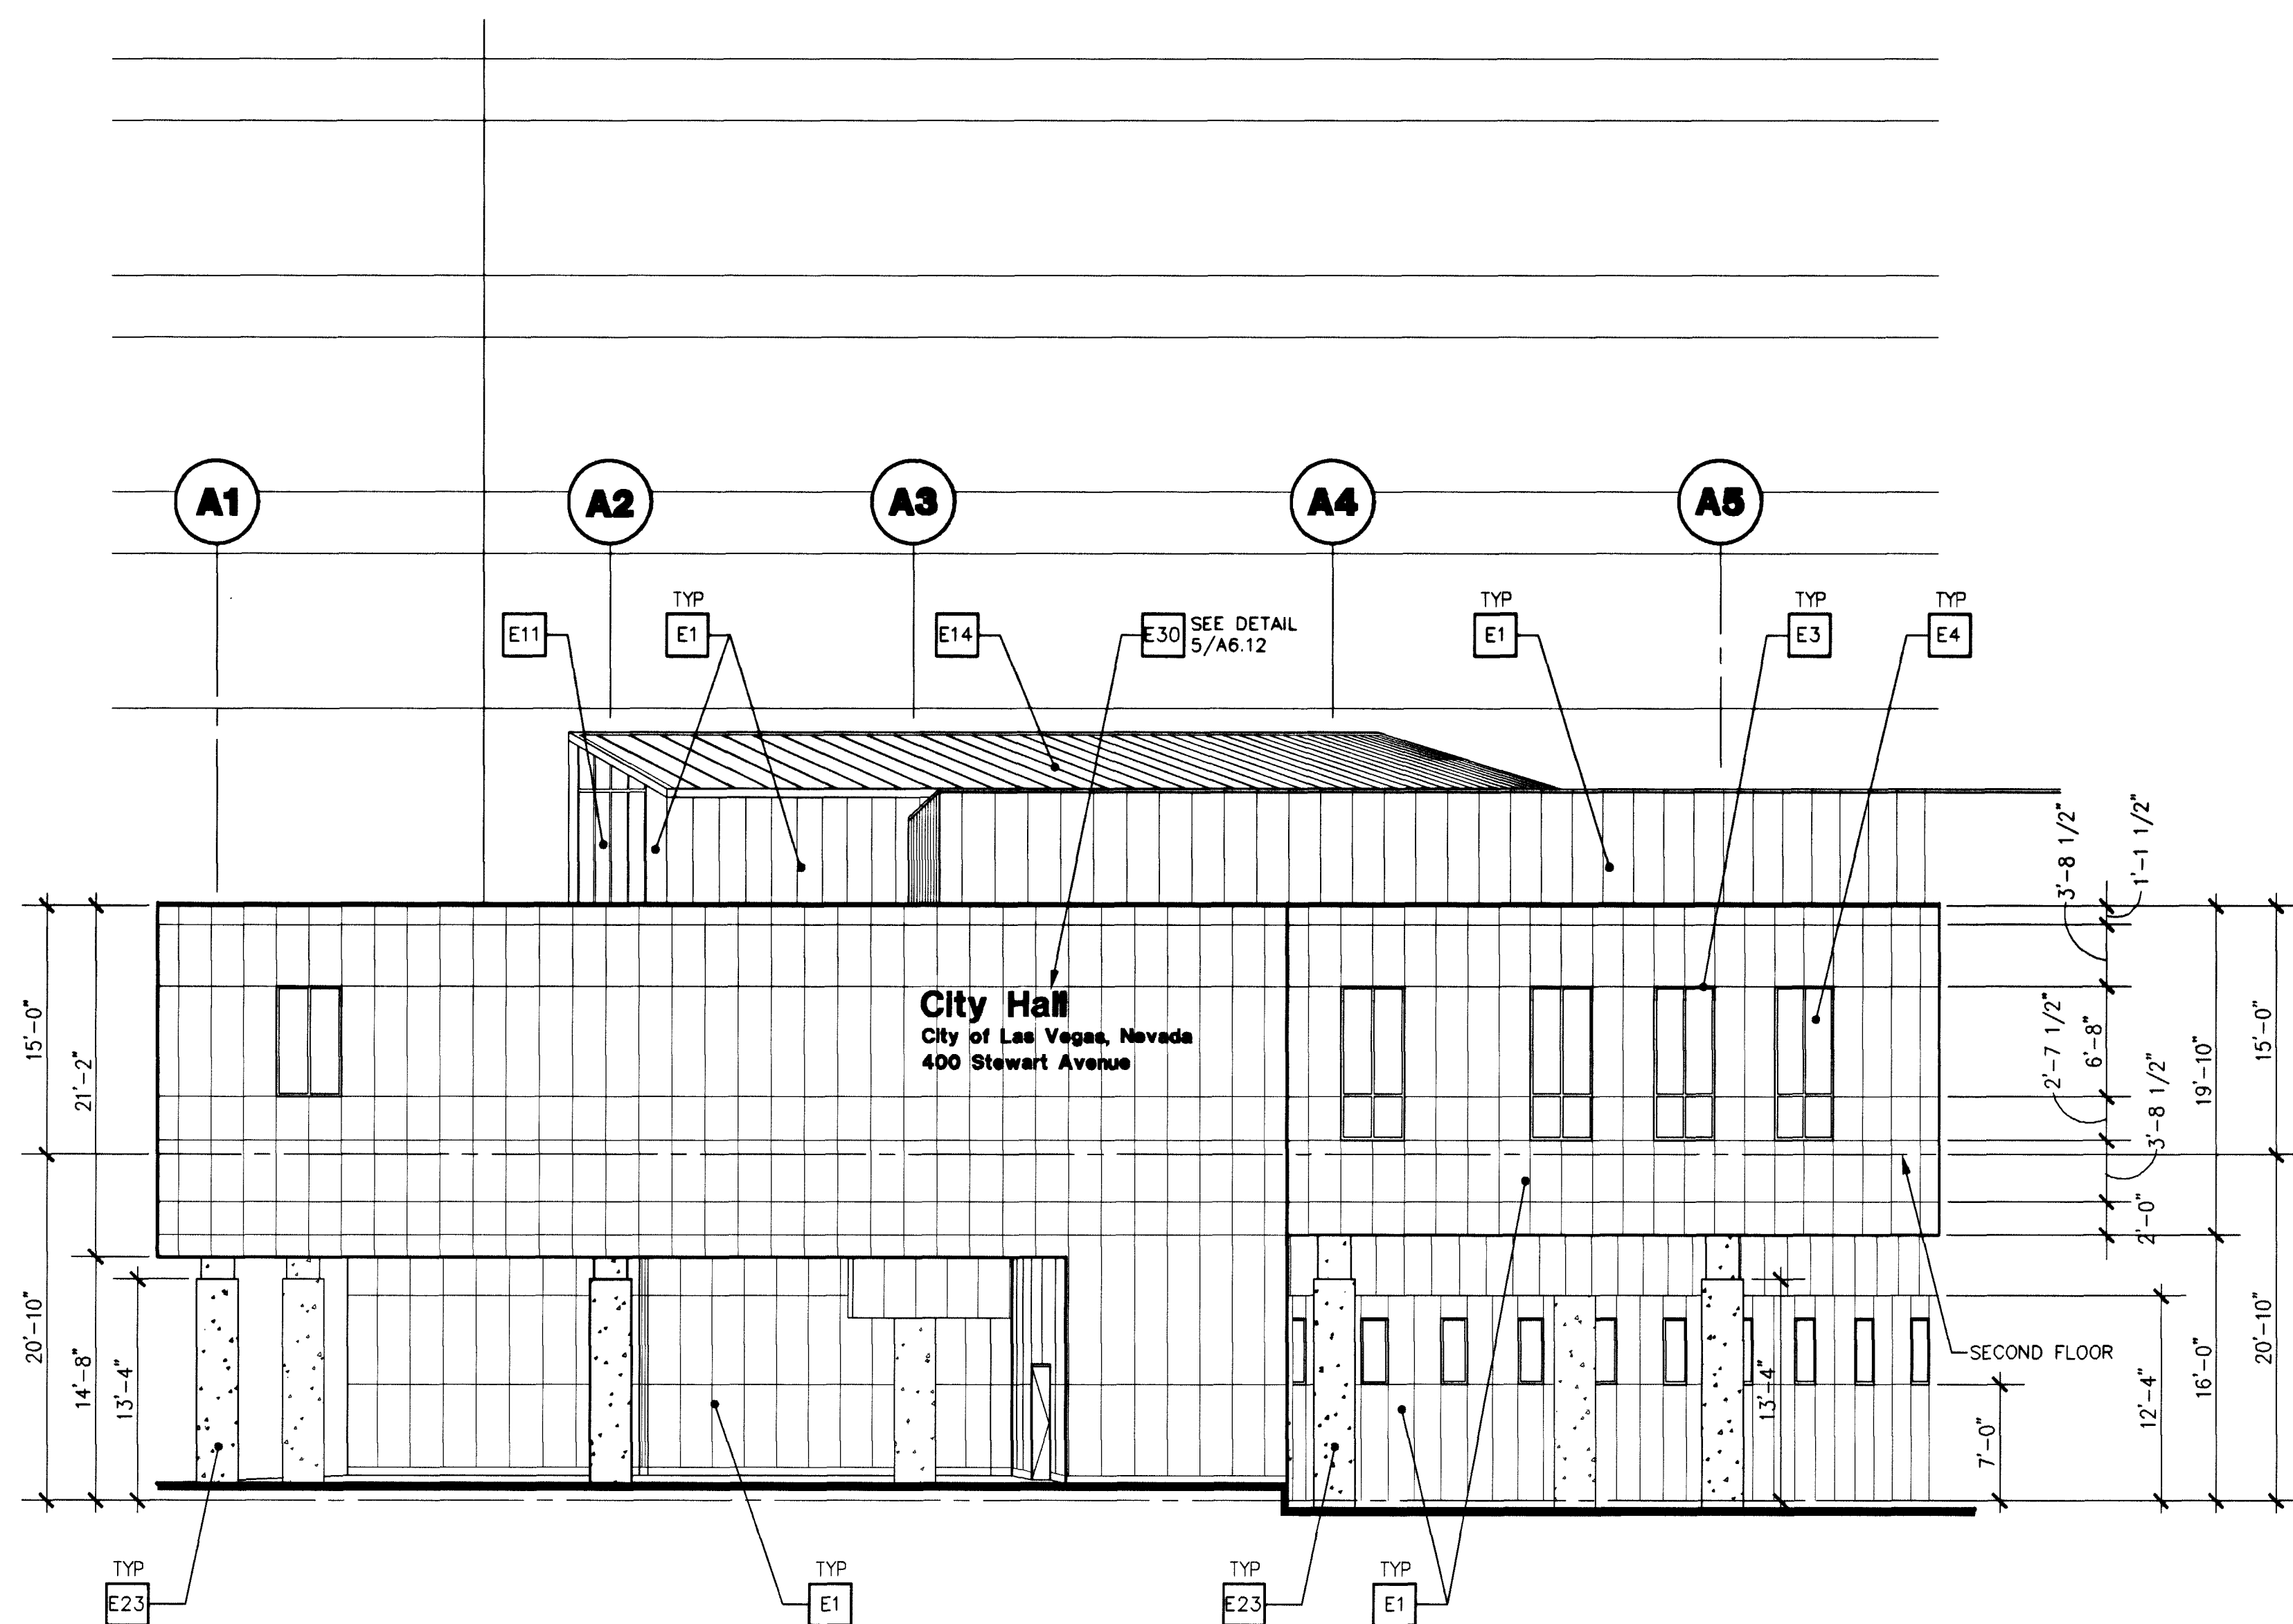


PARTIAL SOUTH ELEVATION

SCALE: 1/8" = 1'-0"

997AWELV

1
A6.12

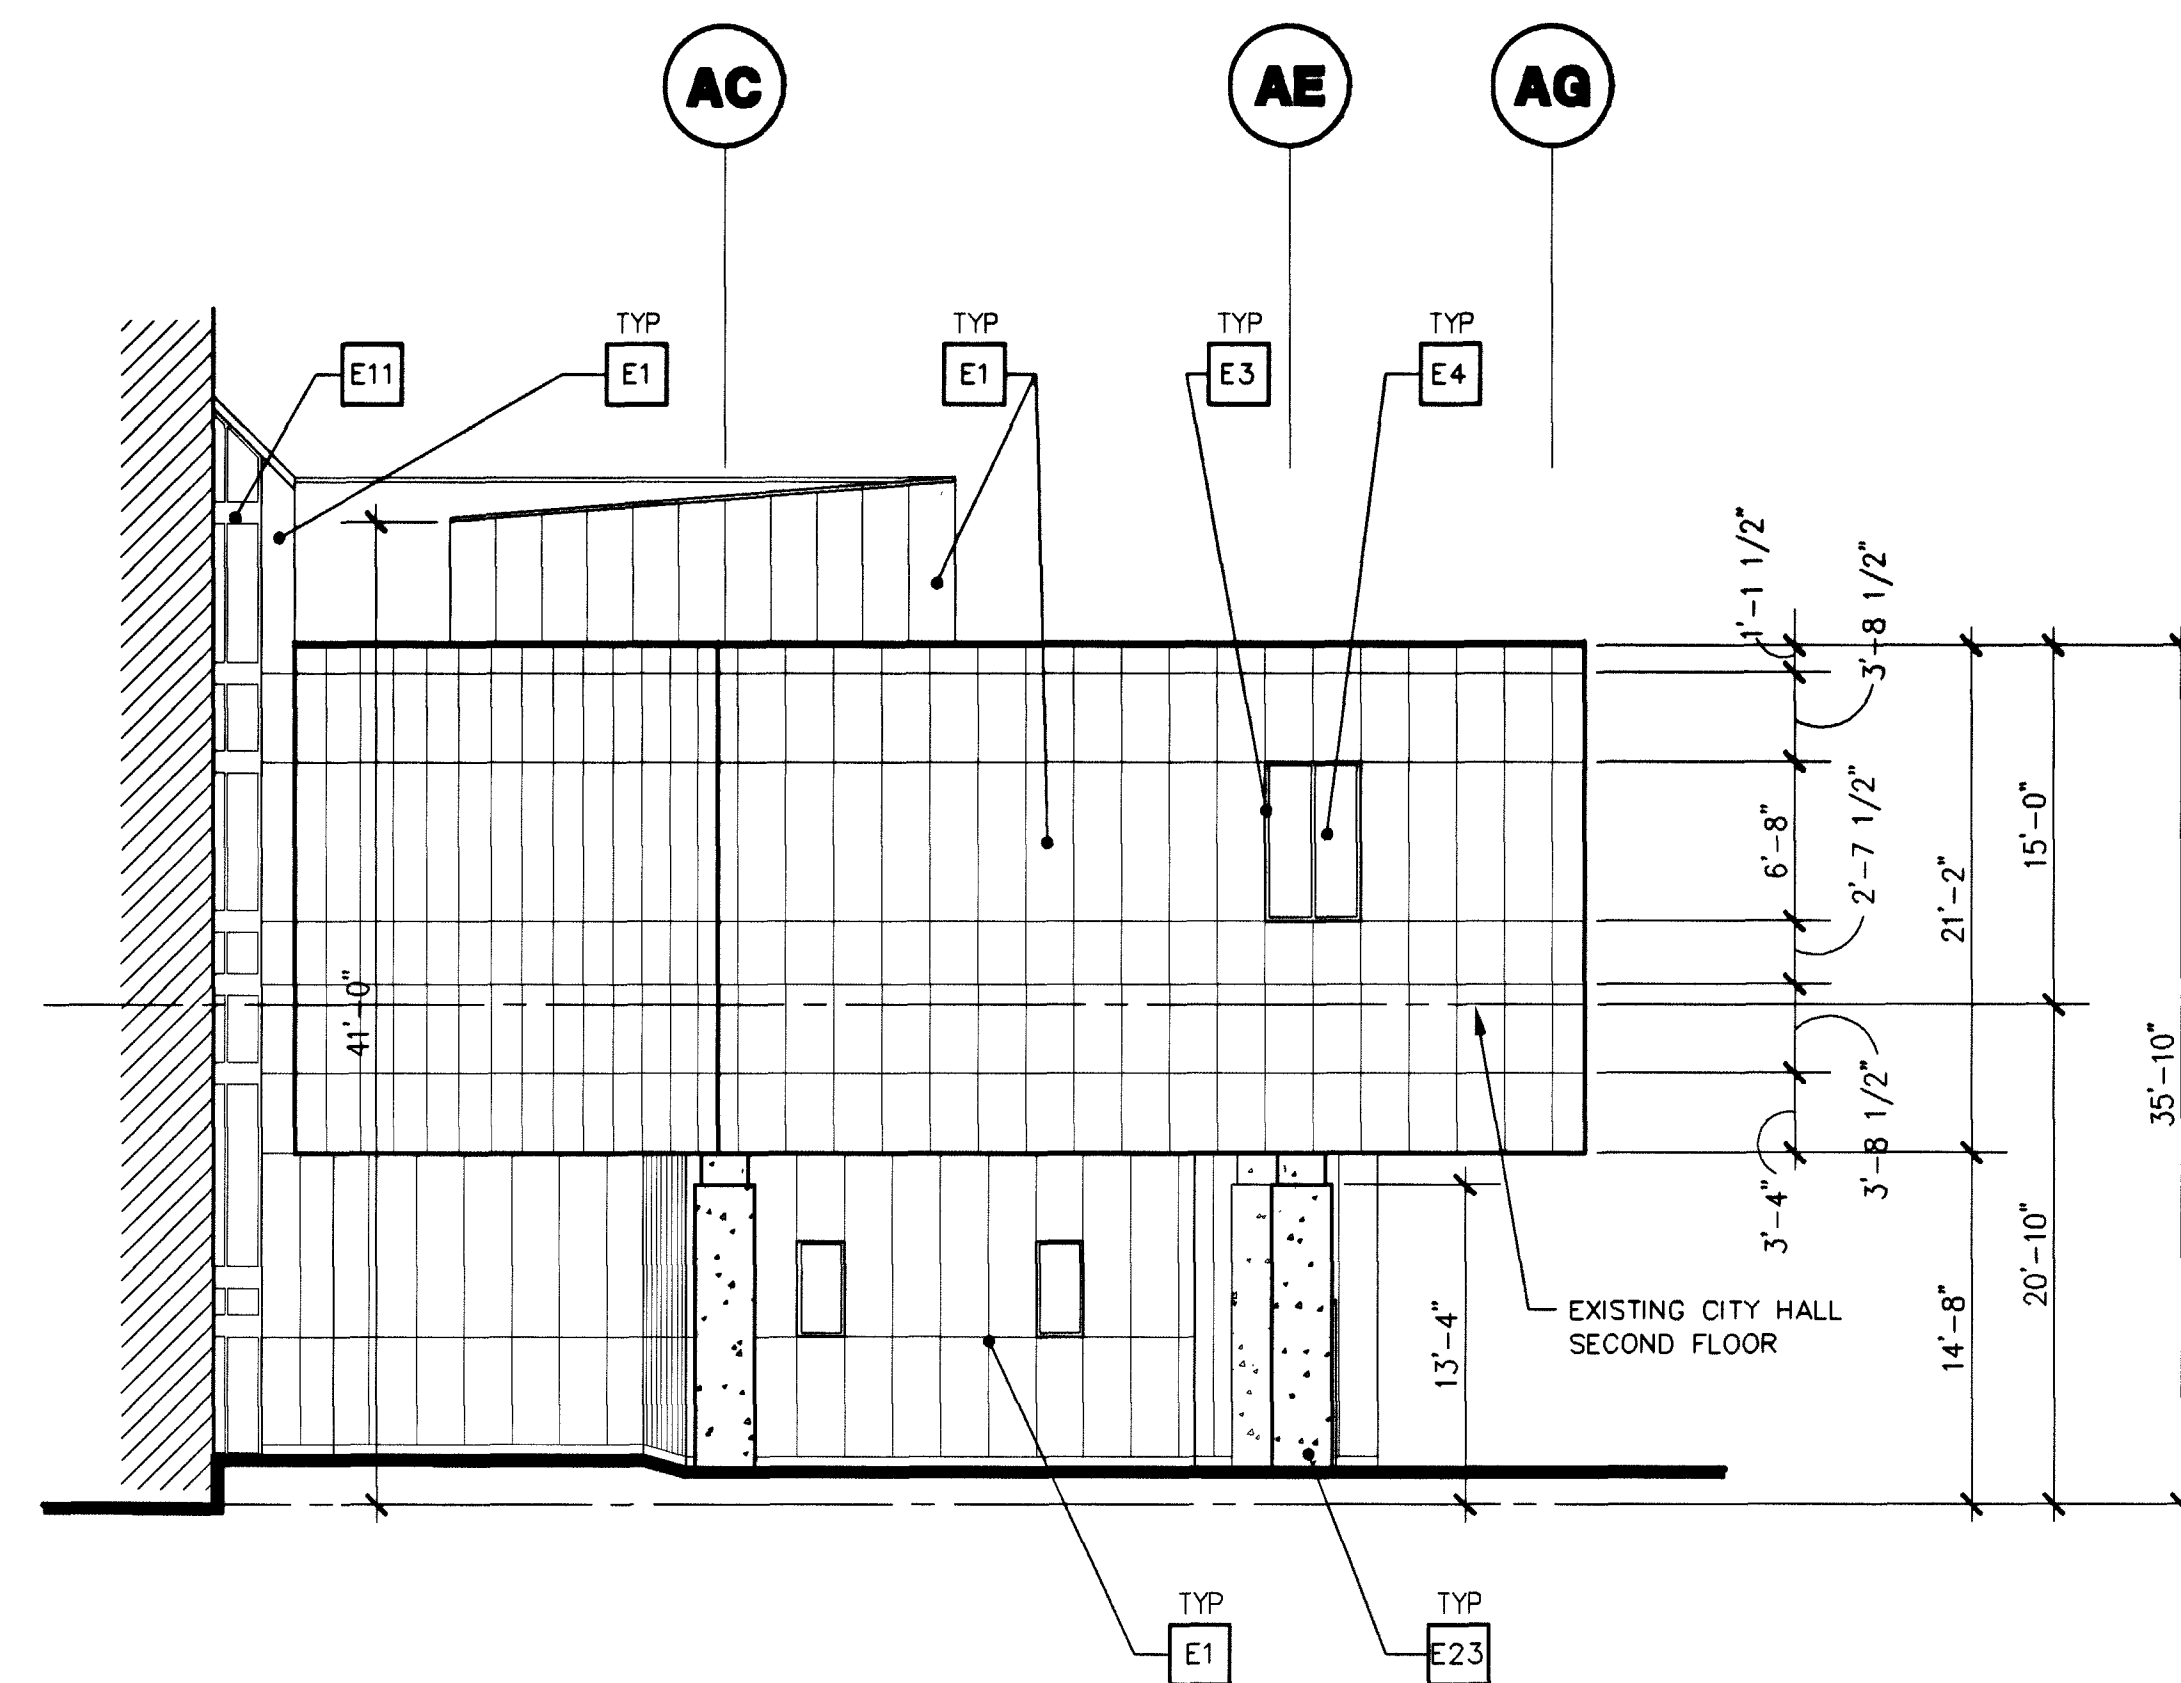


PARTIAL NORTH ELEVATION

SCALE: 1/8" = 1'-0"

997ANLV2

2
A6.12

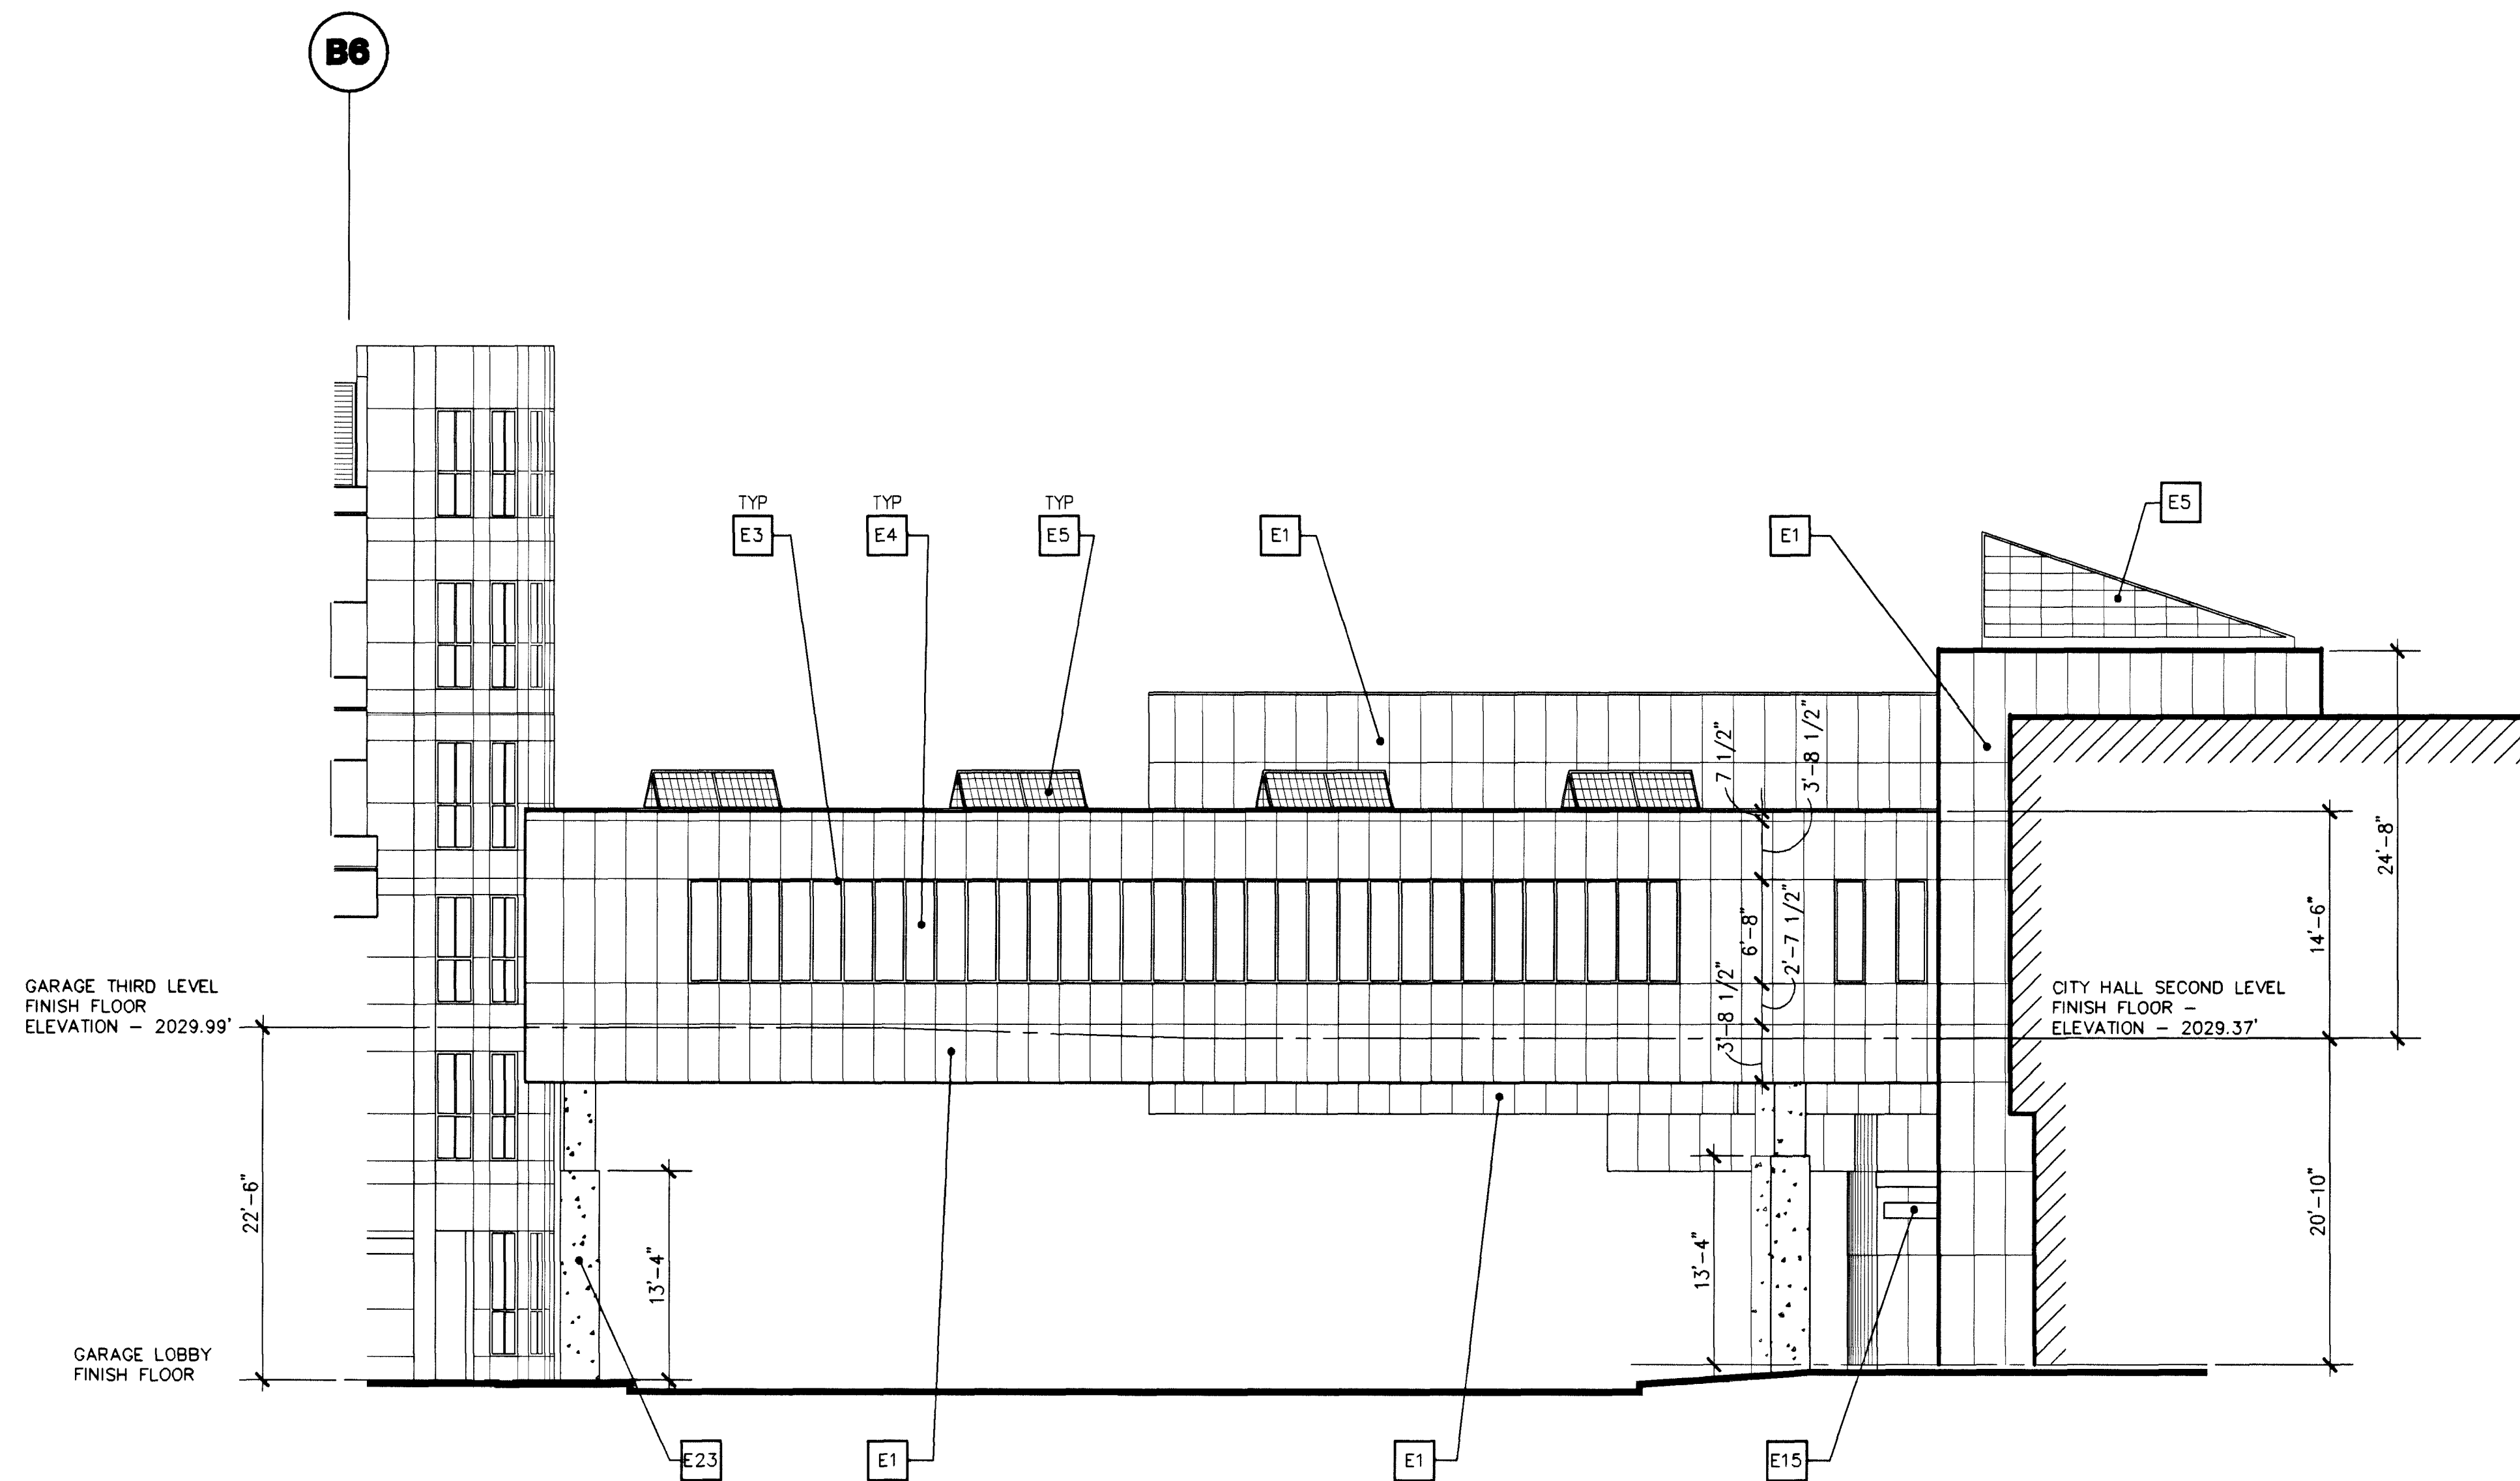

EAST ELEVATION - PEDESTRIAN WALKWAY

SCALE: 1/8" = 1'-0"

997AEELV

3
A6.12




SIGNAGE DETAIL

SCALE: 3/4" = 1'-0"

CHSIGN

5
A6.12

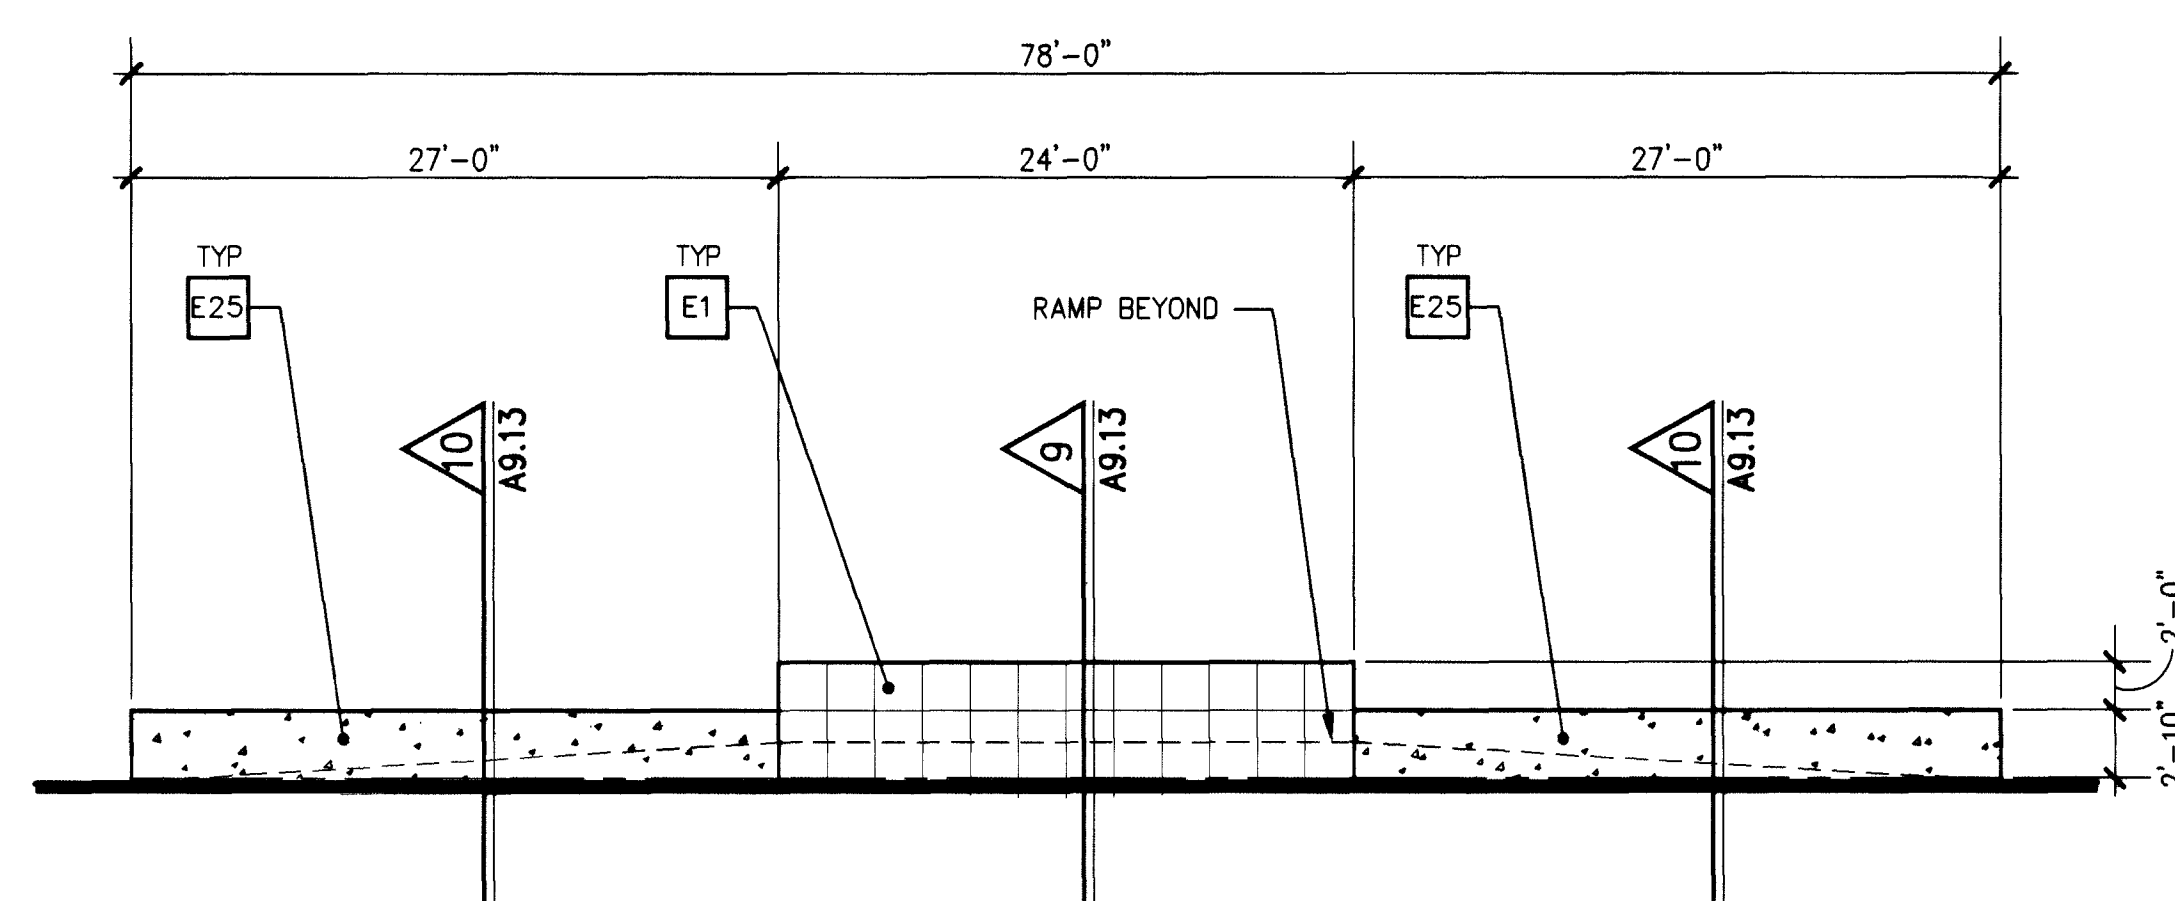

NORTH ELEVATION - DECORATIVE WALL

SCALE: 1/8" = 1'-0"

997APELT


4
A6.12

EXTERIOR FINISH		
E#	DESCRIPTION:	COLOR:
E1	NATURAL STONE (UNFILLED PORES) REINFORCED PANEL	
E2	8"-8"x16" SINGLE SCORE CMU MANUFACTURER: TRENDSTONE FINISH: HONED-FACE / SEALED	MARICOPA TAN NW
E3	ALUMINUM STOREFRONT FRAME MANUFACTURER: KAWNEER / SYSTEM 451	DARK BRONZE
E4	1" INSULATED GLASS MANUFACTURER: FPG	SOLARBAN 60 (3) BRONZE
E5	2 3/4" TRANSLUCENT INSULATED PANEL MANUFACTURER: SEE SPECIFICATIONS PATTERN: SHOU W/ WHITE FRAME	CRYSTAL
E6	PREMANUFACTURED METAL CAP FLASHING	TO MATCH ADJACENT SURFACE
E7	ROLL UP DOOR	FRAZEE 8870W FANLIGHT
E8	STEEL DOOR FRAME	FRAZEE 8870W FANLIGHT
E9	STEEL DOOR	FRAZEE 8870W FANLIGHT
E10	ALUMINUM DOOR FRAME	DARK BRONZE
E11	ALUMINUM CURTAINWALL MANUFACTURER: KAWNEER / SYSTEM 1600	DARK BRONZE
E12	ALUMINUM STOREFRONT FRAME MANUFACTURER: KAWNEER / SYSTEM 451 WITH NO GLAZING RECEIVER	DARK BRONZE
E13	8"-8"x16" SINGLE SCORE CMU MANUFACTURER: TRENDSTONE FINISH: HONED-FACE / SEALED	MW BONE
E14	ALUMINUM CURTAINWALL MANUFACTURER: KAWNEER / SYSTEM 1600SG	DARK BRONZE
E15	METAL SUN SCREEN	DARK BRONZE
E16	METAL LOUVER- SIZE AS INDICATED ON ELEVATION	FRAZEE 8870W FANLIGHT
E17	METAL LOUVER - SEE MECHANICAL PLANS	TO MATCH ADJACENT SURFACE
E18	PRE-CAST CONCRETE PANEL	EXPOSED AGGREGATE
E19	PRE-CAST CONCRETE PANEL AND COLUMN INTEGRAL COLOR	DAVIS COLORS #61205 5 LBS / 94 LBS GRAY CEMENT
E20	CABLE GUARDRAILS	FRAZEE 8242W NORTHERN PLAINS
E21	STANDPIPE	FRAZEE 8870W FANLIGHT
E22	CONCRETE SILL	
E23	CAST-IN-PLACE CONCRETE COLUMN COVER	EXPOSED AGGREGATE
E24	BUILDING DEDICATION PLAQUE - PROVIDED BY CITY OF LAS VEGAS - INSTALLED BY CONTRACTOR	
E25	CAST IN PLACE CONCRETE	
E26	EXTERIOR INSULATION FINISH SYSTEM	FRAZEE 8870W FANLIGHT
E27	SINGLE-PLY MEMBRANE ROOFING	BEIGE
E28	GALVANIZED METAL COLLECTION BOX AND DOWNSPOUT	PAINT TO MATCH CMU COLOR
E29	INSULATED SPANDREL PANEL	
E30	CAST ALUMINUM LETTERS	BRONZE
E31	DOWNSPOUT WITH METAL ESCUTCHEON PLATE	
E32	EXTERIOR INSULATION FINISH SYSTEM	FRAZEE 8242W NORTHERN PLAINS
E33	STEEL GUARDRAIL - PAINTED	FRAZEE 8242W NORTHERN PLAINS
E34	CHAIN LINK FENCE	GALVANIZED STEEL
E35	ILLUMINATED SIGN SEE DETAIL 8/9.34	
E36	SWITCHGEAR - SEE ELECTRICAL	
E37	RADIUSED 2x6 TUBE STEEL - PAINTED	DARK BRONZE
E38	EXISTING ADJACENT BUILDING TO REMAIN	

GENERAL NOTES:

1. STONE PANEL DIMENSIONS ARE BASED ON ORIGINAL CONSTRUCTION DOCUMENTS OF THE EXISTING CITY HALL. CONTRACTOR AND STONE PANEL MANUFACTURER ARE RESPONSIBLE TO FIELD VERIFY STONE PANEL DIMENSIONS PRIOR TO ANY FABRICATION.

KEY PLAN

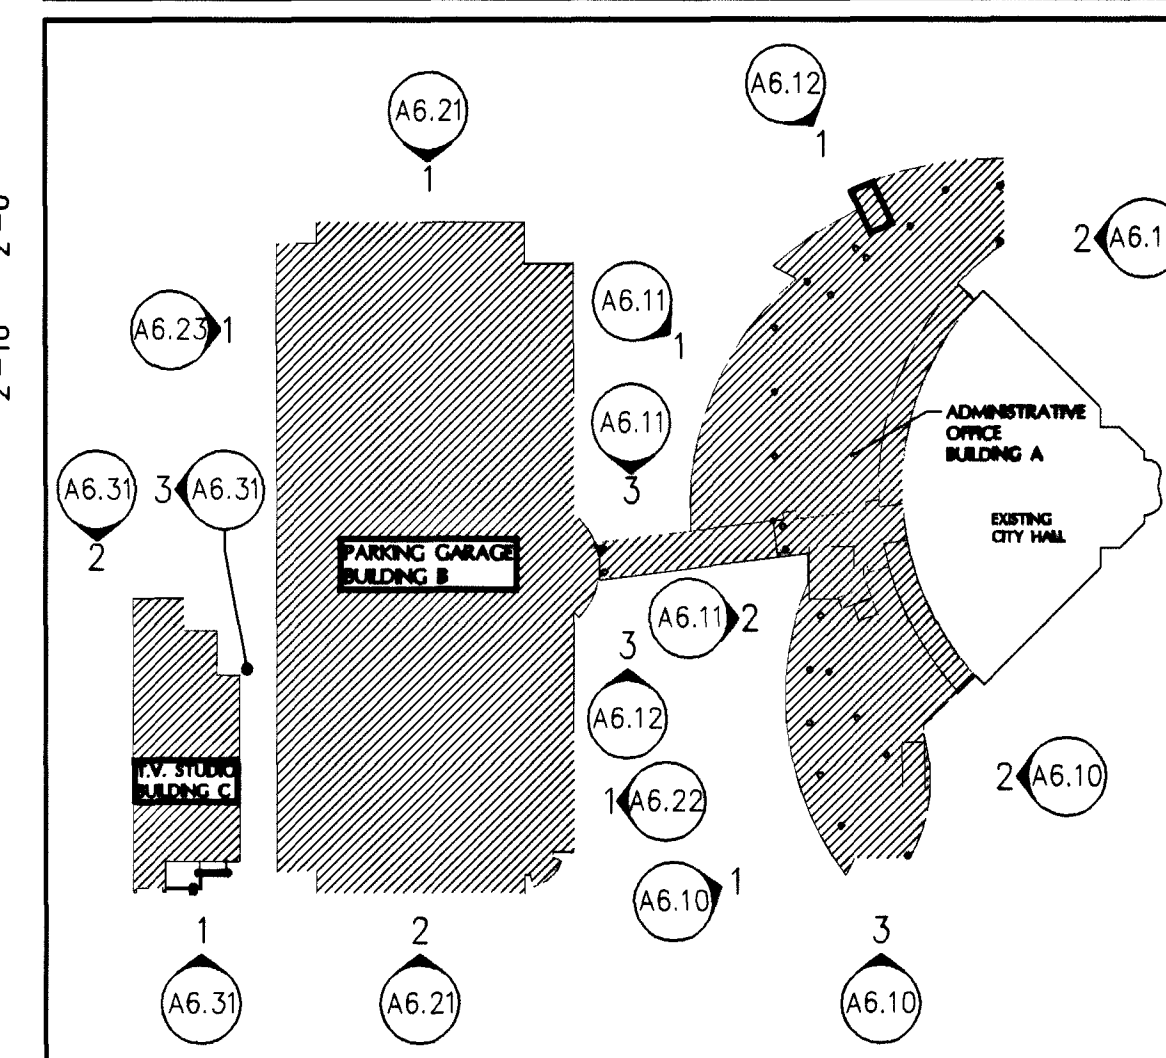

REVISIONS

RECORD DRAWINGS
DECEMBER 20, 2002

STEWART AVENUE
PARKING GARAGE



Nevada

Las Vegas,



4070 S. DECATUR BLVD. STE. B-5
LAS VEGAS, NEVADA 89103 USA
WWW.KGA-ARCHITECTS.COM
TELEPHONE 702.367.6900
FACSIMILE 702.367.3043

CONSULTANTS

CIVIL:
POCCOMBEY
DORIS DICKINSON
PHONE 702.381.9100

LANDSCAPE:
SOUTHWICK
and ASSOCIATES
PHONE 702.381.9100

STRUCTURAL:
DOROTHY PRINCE
ASSOCIATES
PHONE 702.381.9100

MECHANICAL / PLUMBING / ELECTRICAL:
BA
CONSULTING ENGINEERS
PHONE 702.381.9100

TECHNOLOGY CONSULTANT:
SHEN MULLIN
& WILKE, INC.
PHONE 482.000.0079

PARKING CONSULTANT:
INTERPARK
DESIGN
PHONE 702.381.9100

PROJECT:
STEWART AVENUE
PARKING GARAGE

107-V3338

CLIENTS:
EXTERIOR ELEVATIONS
BUILDING A

67

DATE:
AUGUST 23, 2000

JOB NO:
99997.00

SHEET:

A6.12