
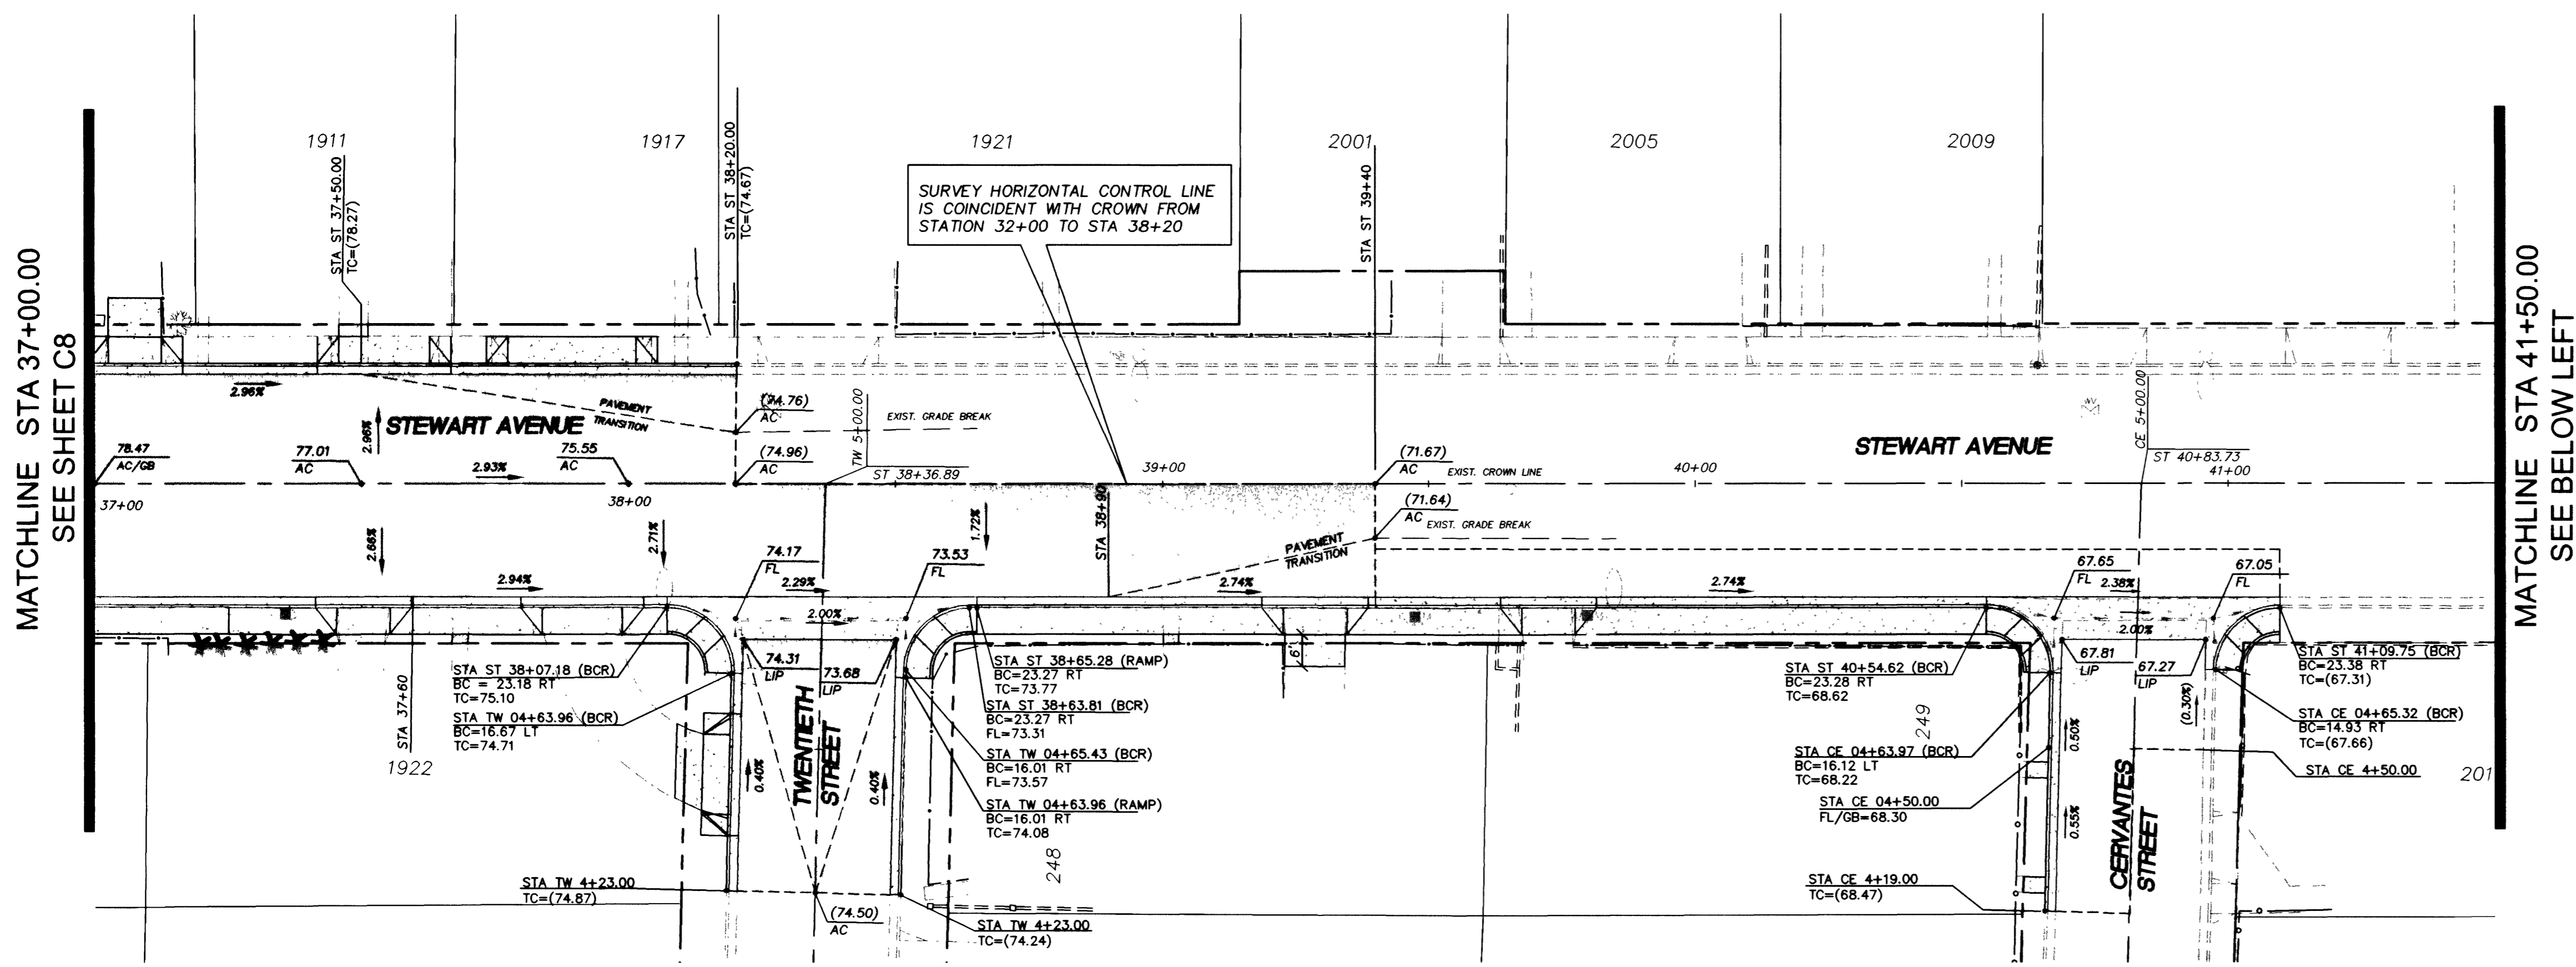
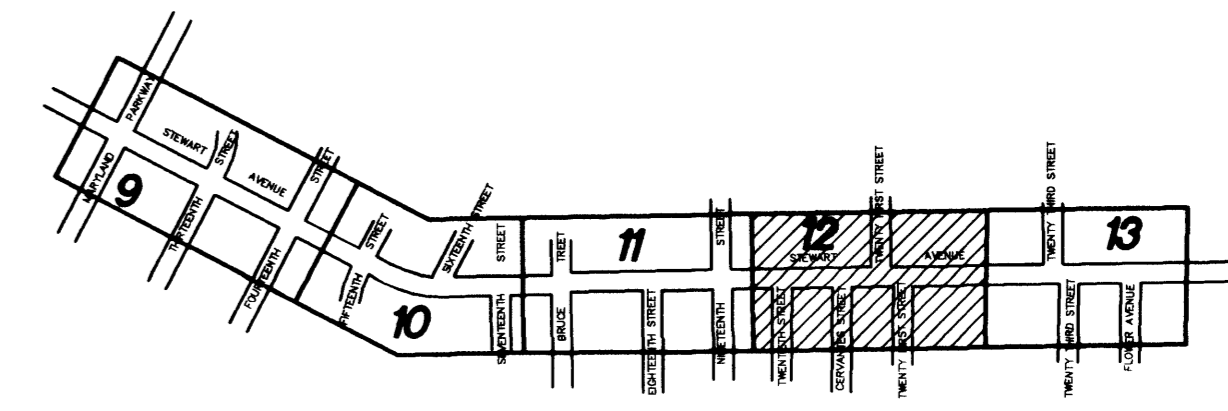


Avoid cutting underground utility lines. It's costly.  
**Call before you Dig.**  
 1-800-227-2600  
UNDERGROUND SERVICE ALERT (USA)

**SAFETY ALERT**  
**Call before you Overhead**  
 593-6111  
OVERHEAD SERVICE ALERT

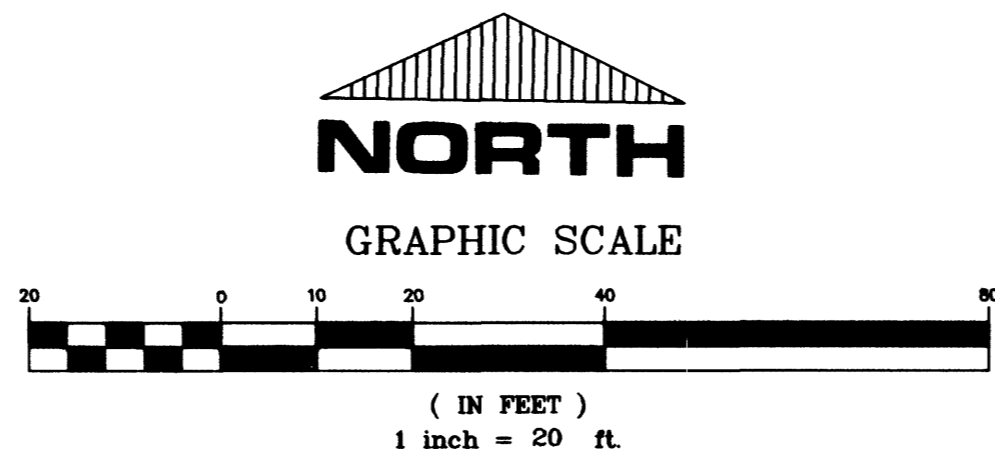


**HATCH LEGEND**

- REMOVE AND REPLACE FULL-DEPTH PAVEMENT SECTION
- NEW A.C. PATCH
- NEW CONCRETE CURB, GUTTER, SIDEWALK, FLATWORK, DRIVEWAY

**NOTES**


1. FINISH GRADE OF A.C. FOR THE ROADWAY CROWN SHOWN AT 50 FOOT STATIONS UNLESS NOTED OTHERWISE ON PLAN.

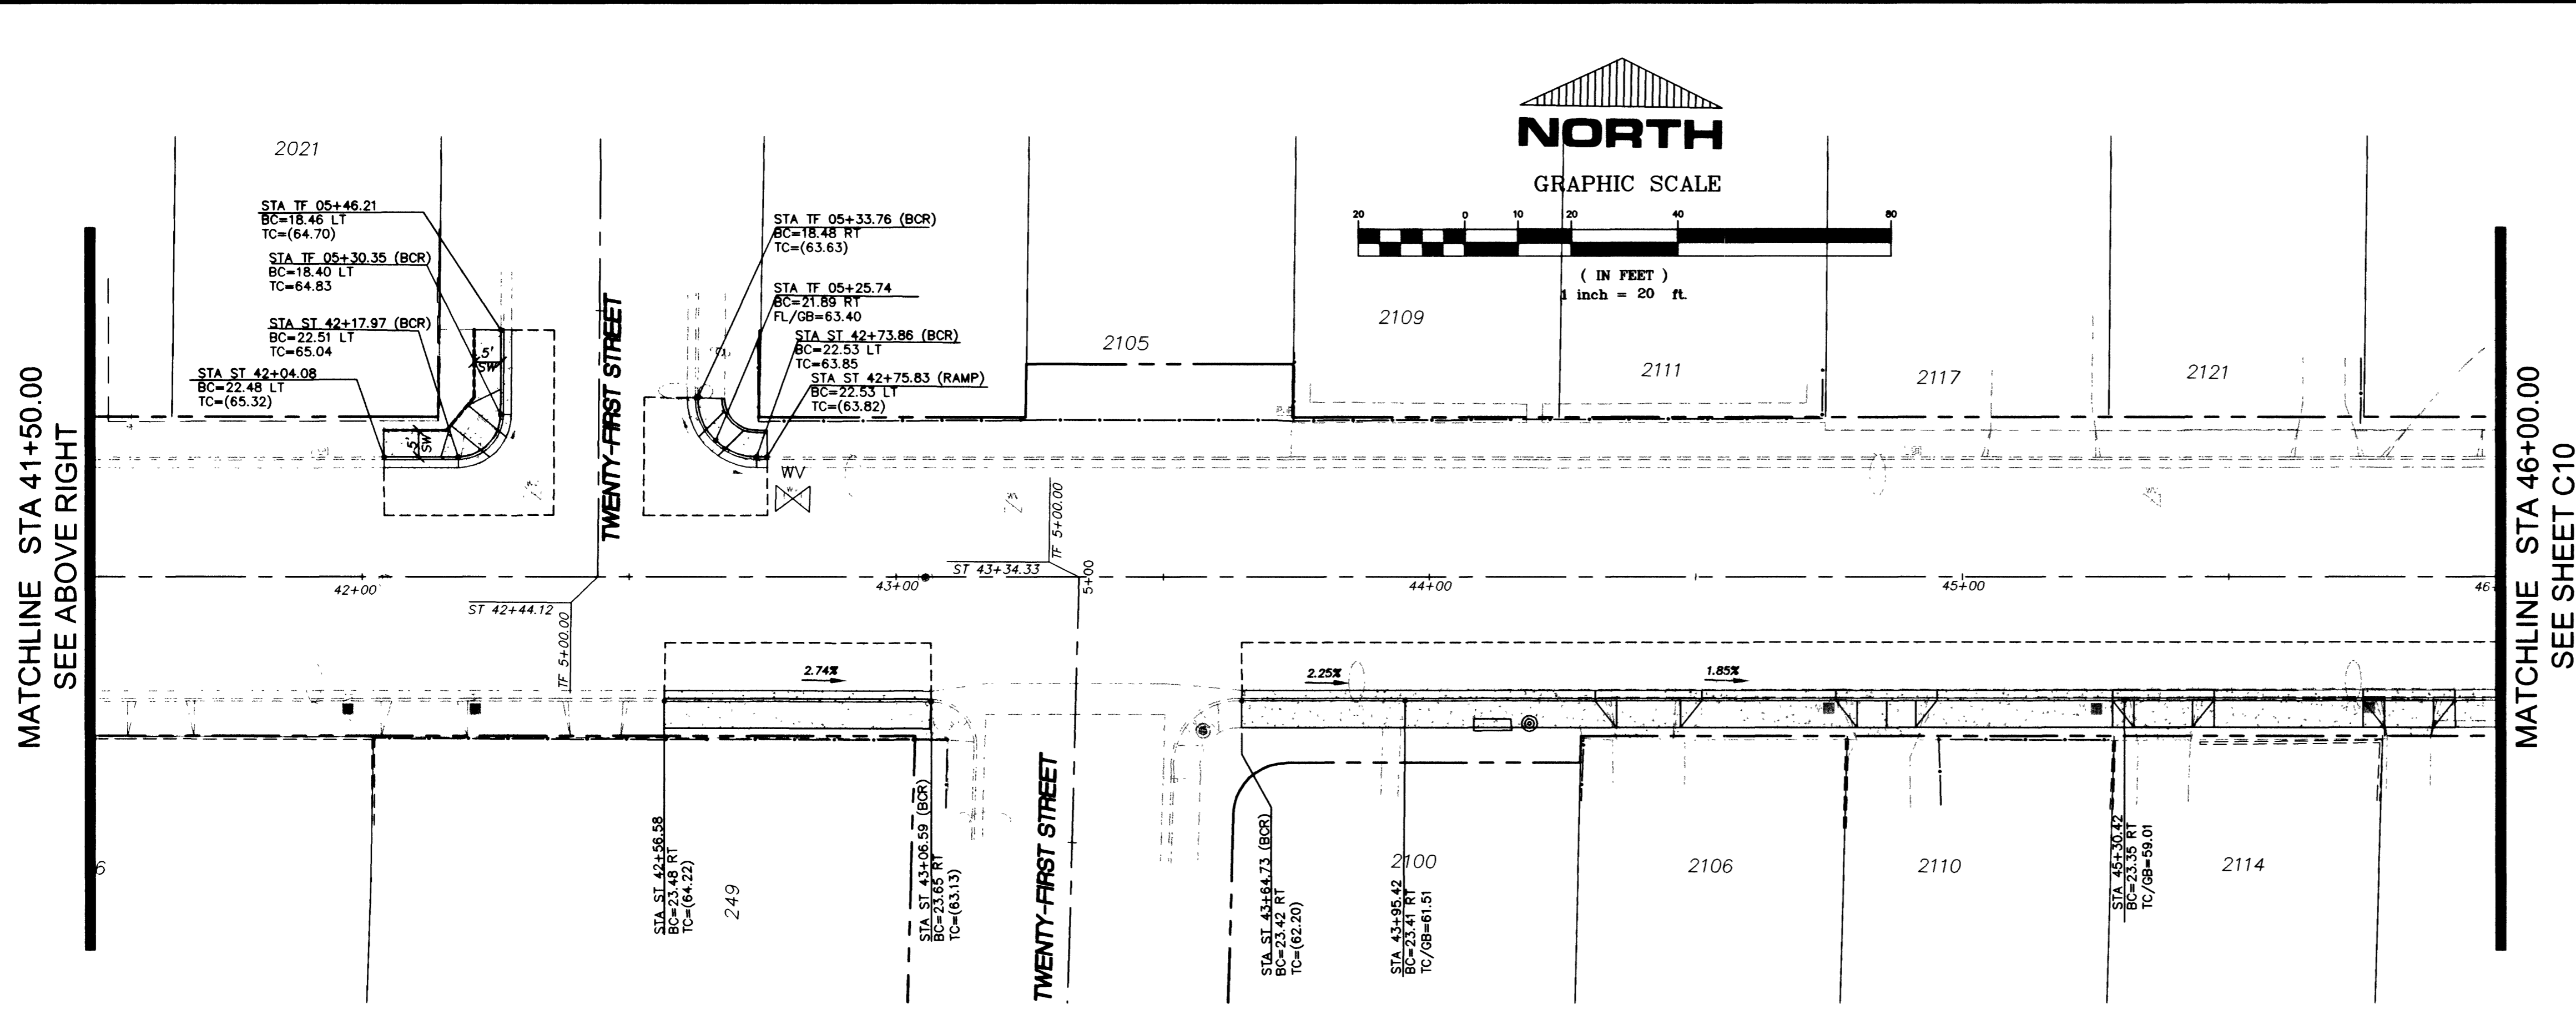

NO.	DATE	DESCRIPTION	APP'D

**DEPARTMENT OF PUBLIC WORKS**  
**ENGINEERING DESIGN SECTION**  
 CITY ENGINEER: CHARLES KALKOWSKI, JR., P.E.  
 PROJECT ENGINEER: JERRY L. TURNER, P.E.  
 DESIGNED BY: RC/ESM/JLT  
 CHECKED BY: JLT  
 HORIZONTAL SCALE: 1"=20'  
 VERTICAL SCALE: N/A  
 DATE: 10/10/01

**TITLE: STEWART AVENUE SIDEWALK INFILL**  
**MARYLAND PKWY TO FLOWER AVE**  
**SHEET: GRADING PLAN**  
**STA 37+00 TO 46+00**

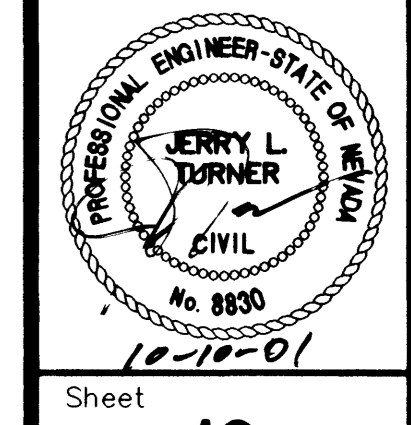

Sheet **12** of **15**  
 DRAWING NO. **107-V3463**