




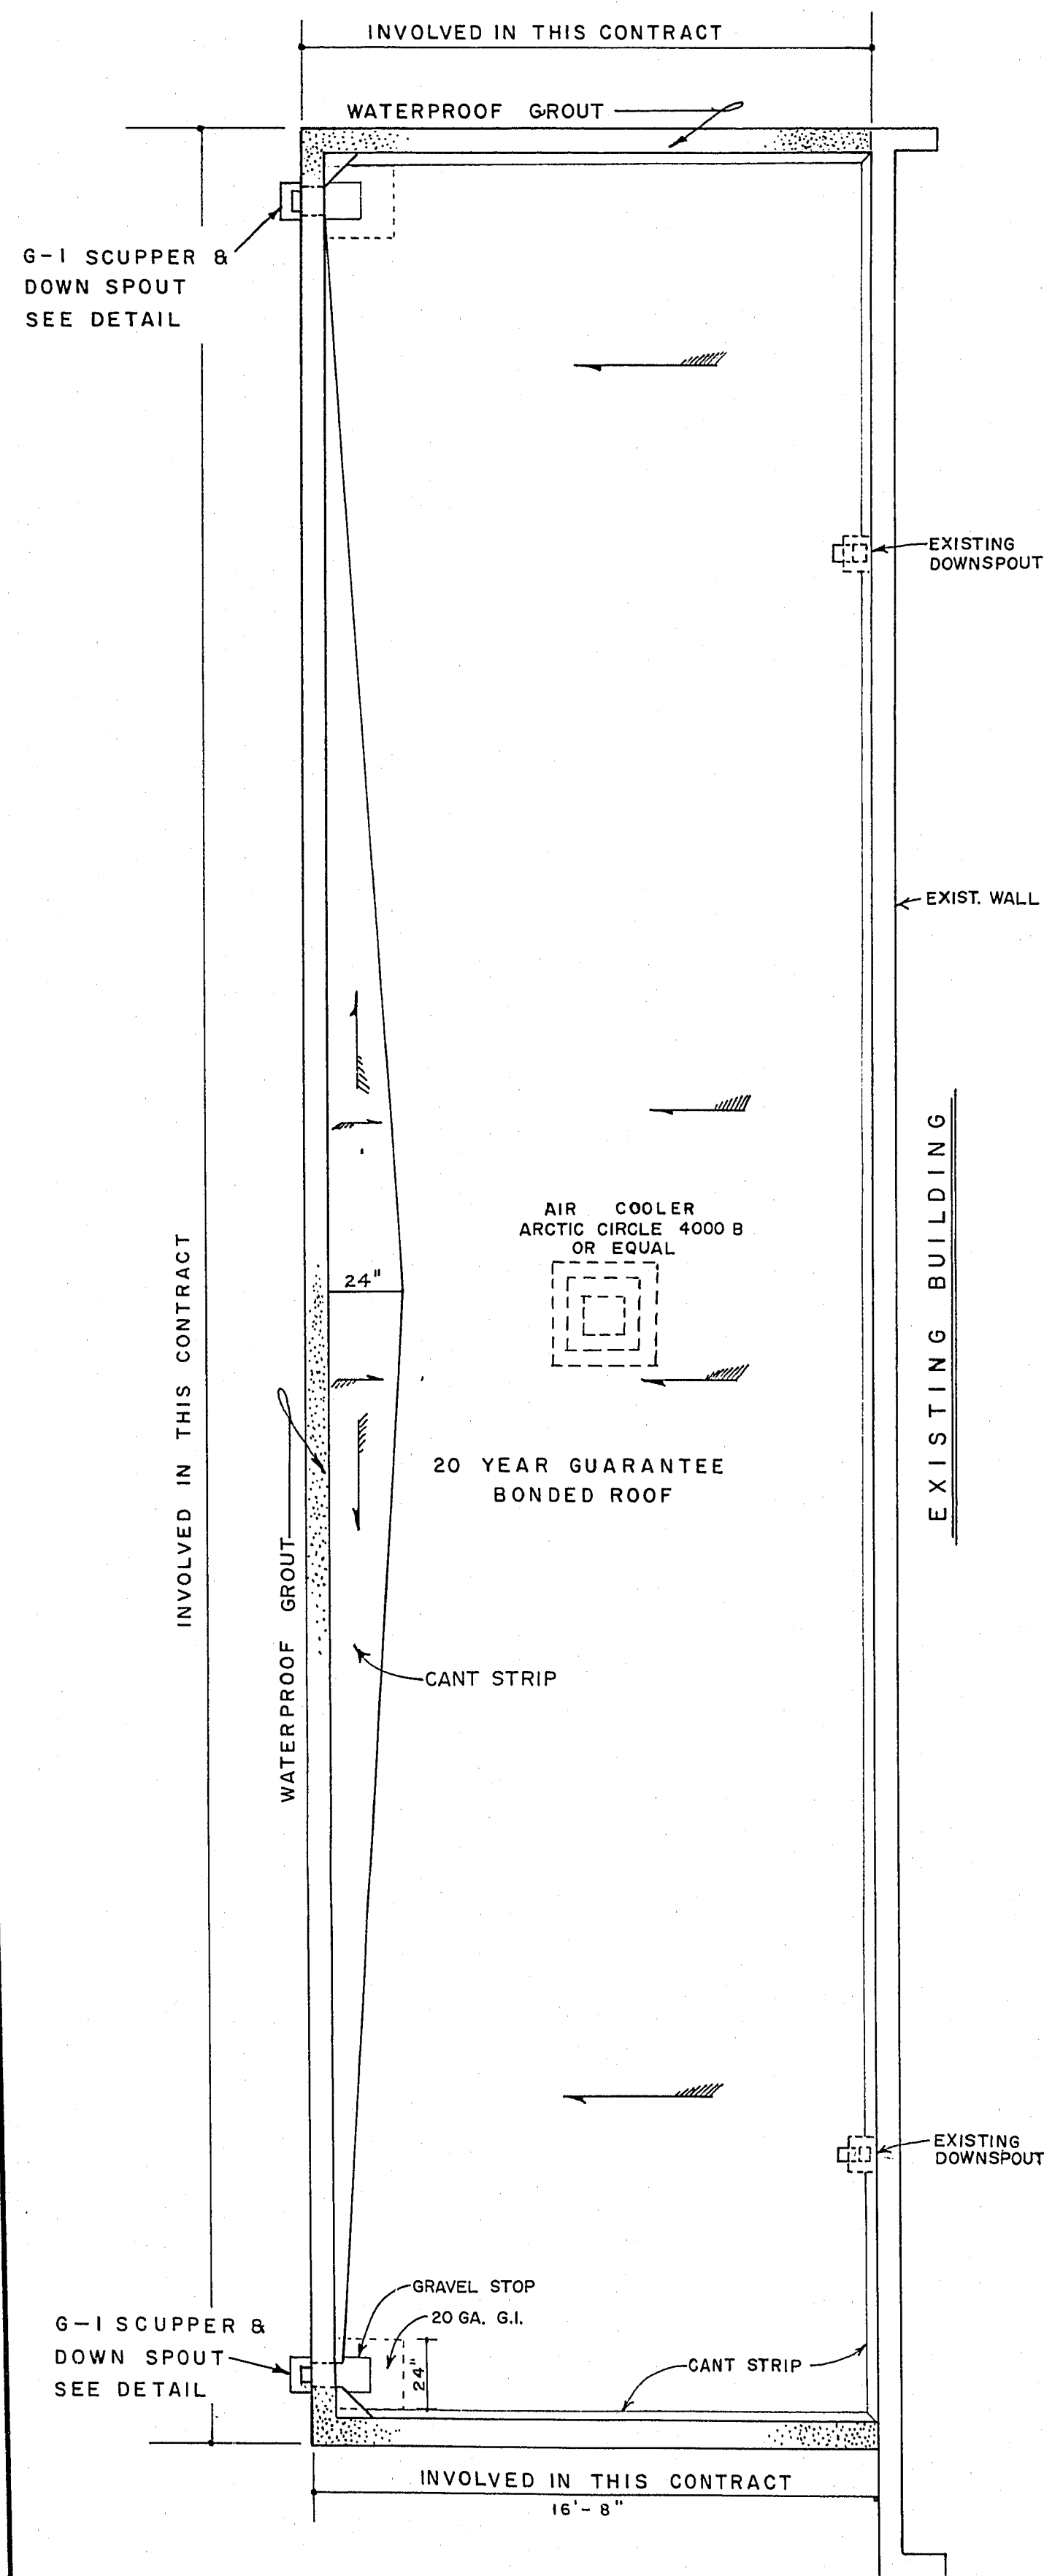



ROOF PLAN
SCALE: 1/4" = 1'-0"

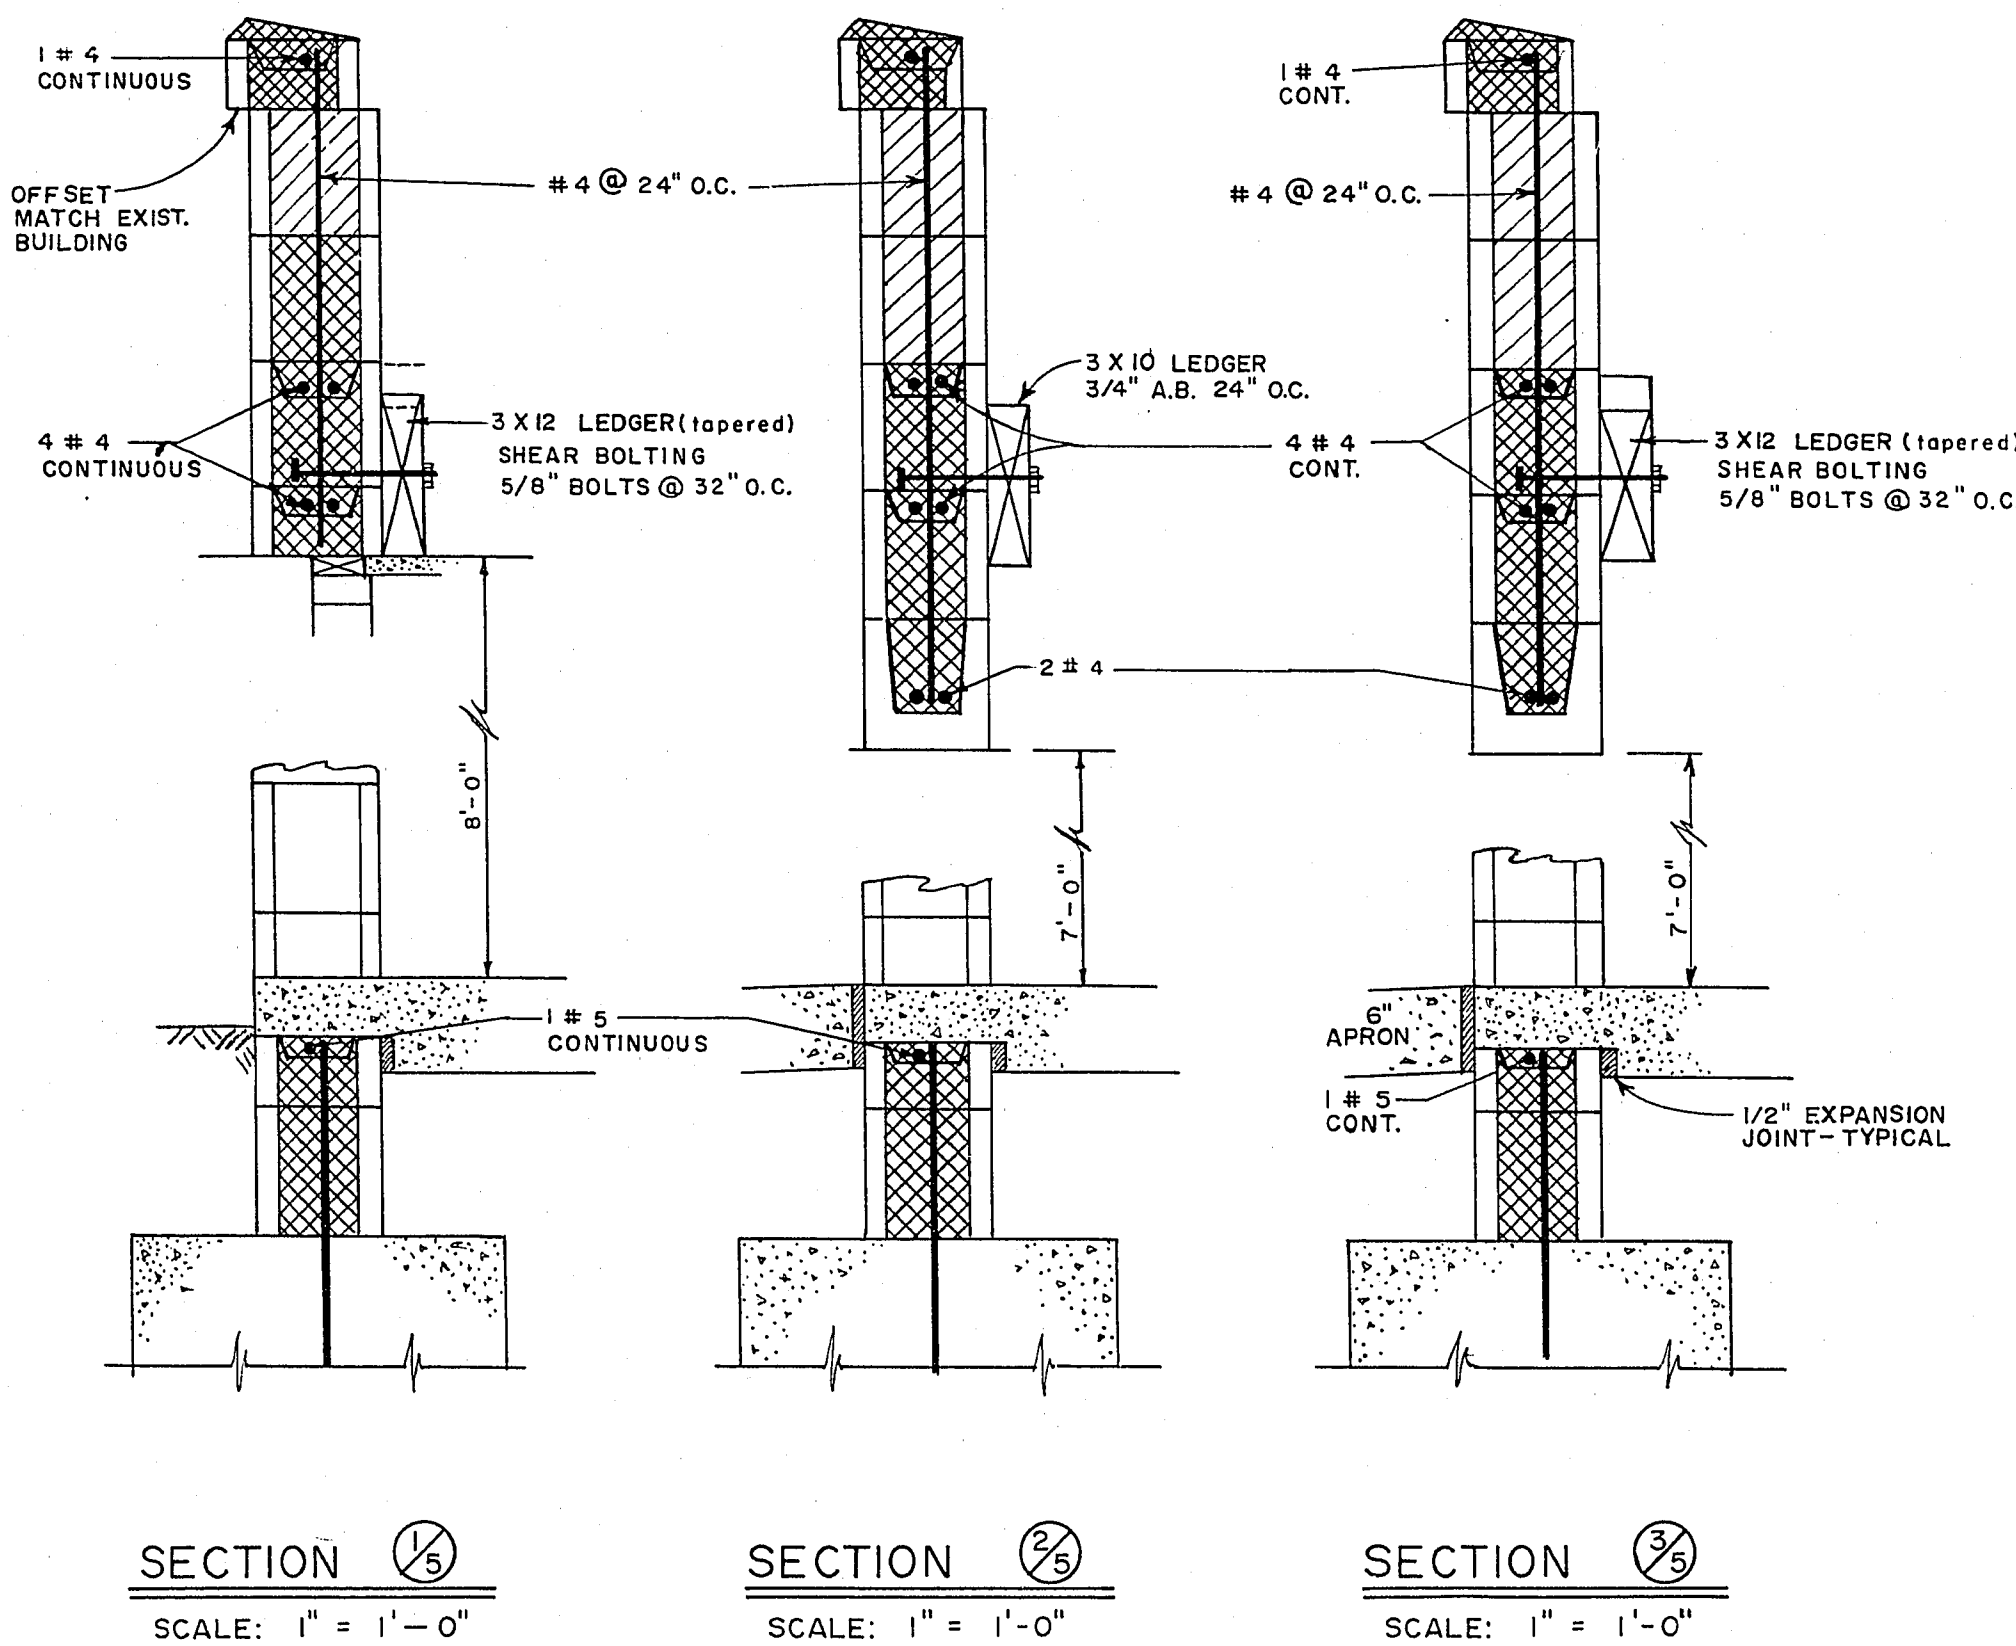

SCUPPER & DOWNSPOUT DETAIL
SCALE: 1" = 1'-0"

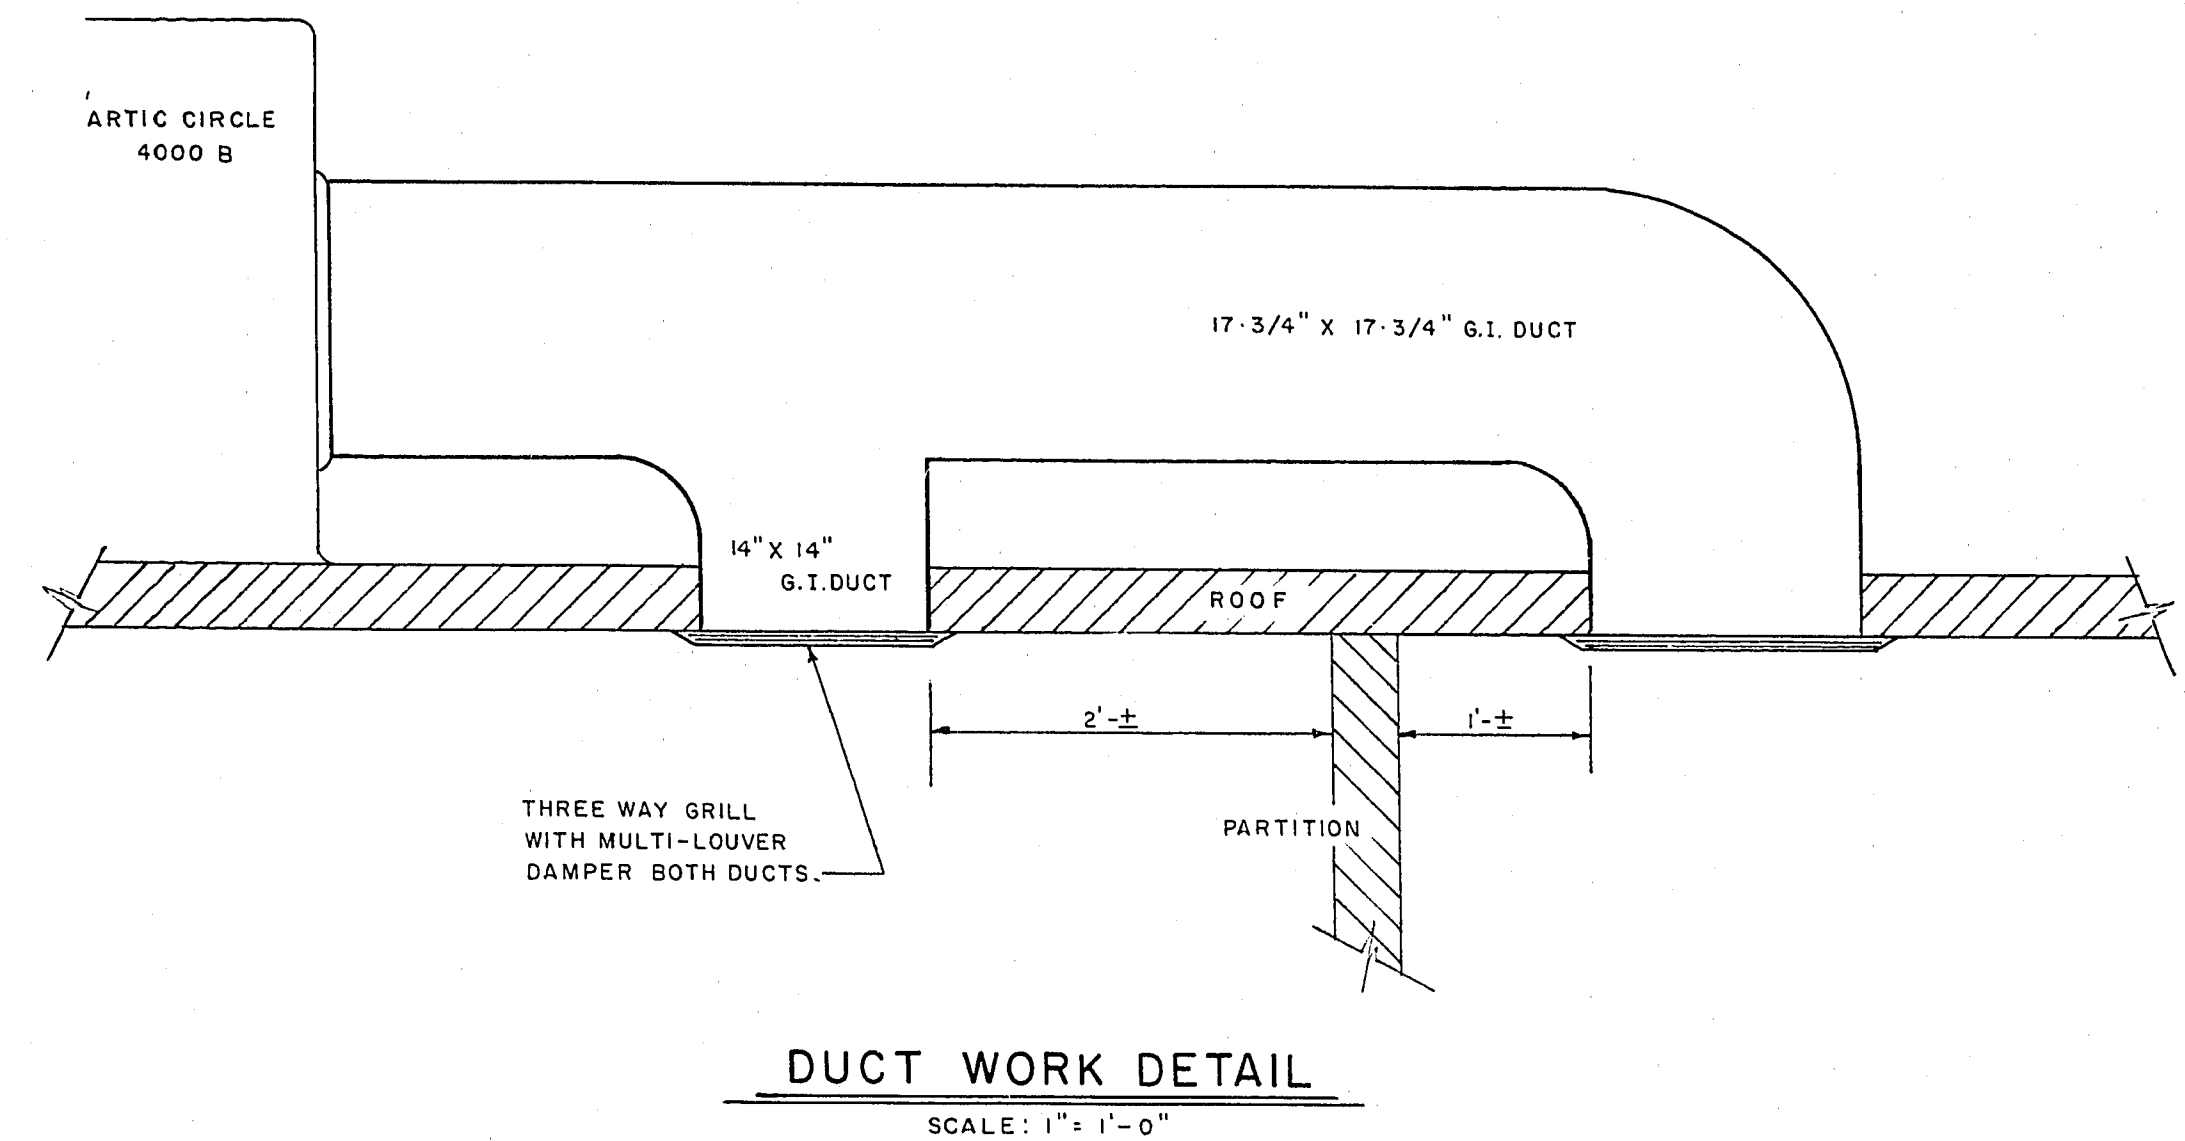

DUCT WORK DETAIL
SCALE: 1" = 1'-0"

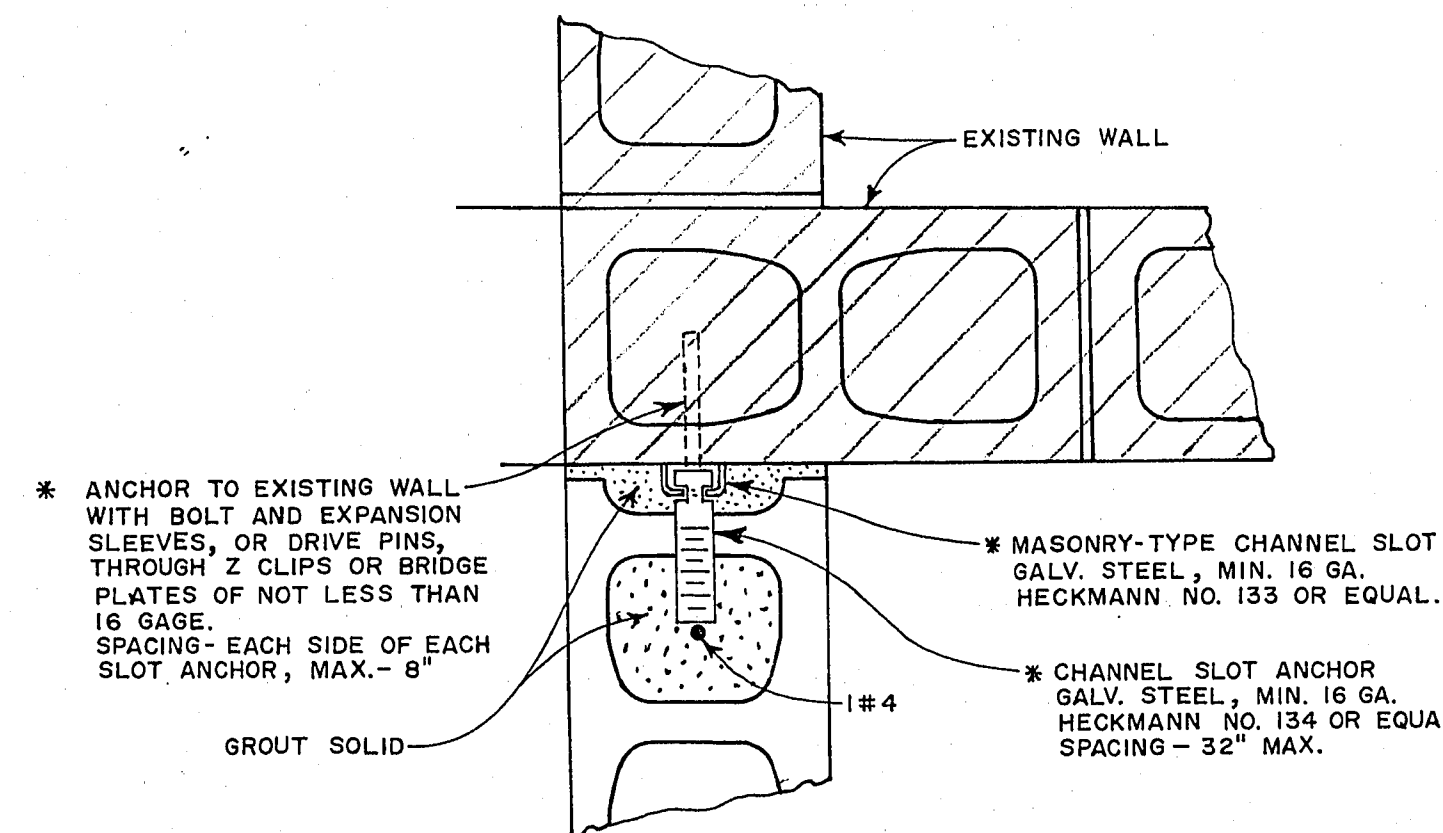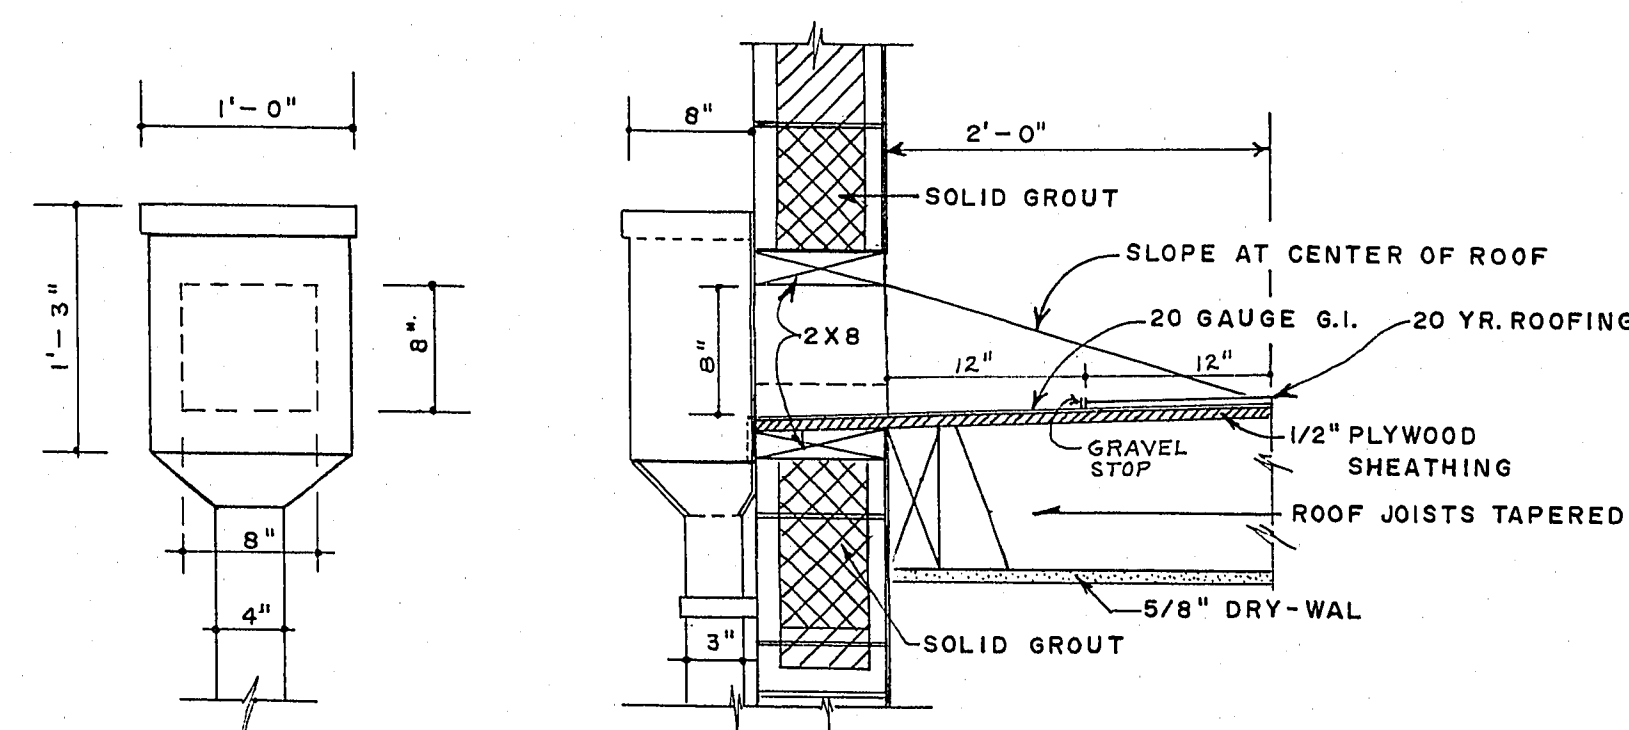

WALL TIE-IN DETAIL
SCALE: 2" = 1'-0"

I CERTIFY THAT THIS PLAN WAS PREPARED UNDER MY SUPERVISION.
Robert T. Whitney
ROBERT T. WHITNEY,
R.P.E. 1095
DATE 3-17-70

APPROVED		
RT	DIV	DATE
3	D.P.W.	5/5/70
2	SERV.	
1	FIELD	5-5-70
	TRAFF	
	UTIL	
	SUDD	
	SAD	
	ENGR.	

CONTRACT
DRAWING
SEP 4 1970

CONTRACT
DRAWING
MAY 1 1970

CITY OF LAS VEGAS NEVADA
DEPARTMENT OF PUBLIC WORKS
SERVICES DIVISION

STORAGE BLDG. ADDITION TO
LAS VEGAS FIRE TRAINING CENTER

APPROVALS		W.O. NO. 3027	F.B.K. NO.	DATE	DRAWING NO.
CHIEF J.D. MILLER - FIRE DEPT.	SC. (H) SHOWN	SC. (V)			
DATE <u>4-30-70</u>	DES. HARRY H. WHITELEY - A.I.A.				
	DR. L. HARPER - ELLISON			1-27-70	FILE NO.
	APPROVED BY DIRECTOR OF PUBLIC WORKS				513-26-E
CITY BUILDING DEPT.					SHEET 5 OF 9
DATE <u>4-30-70</u>					